



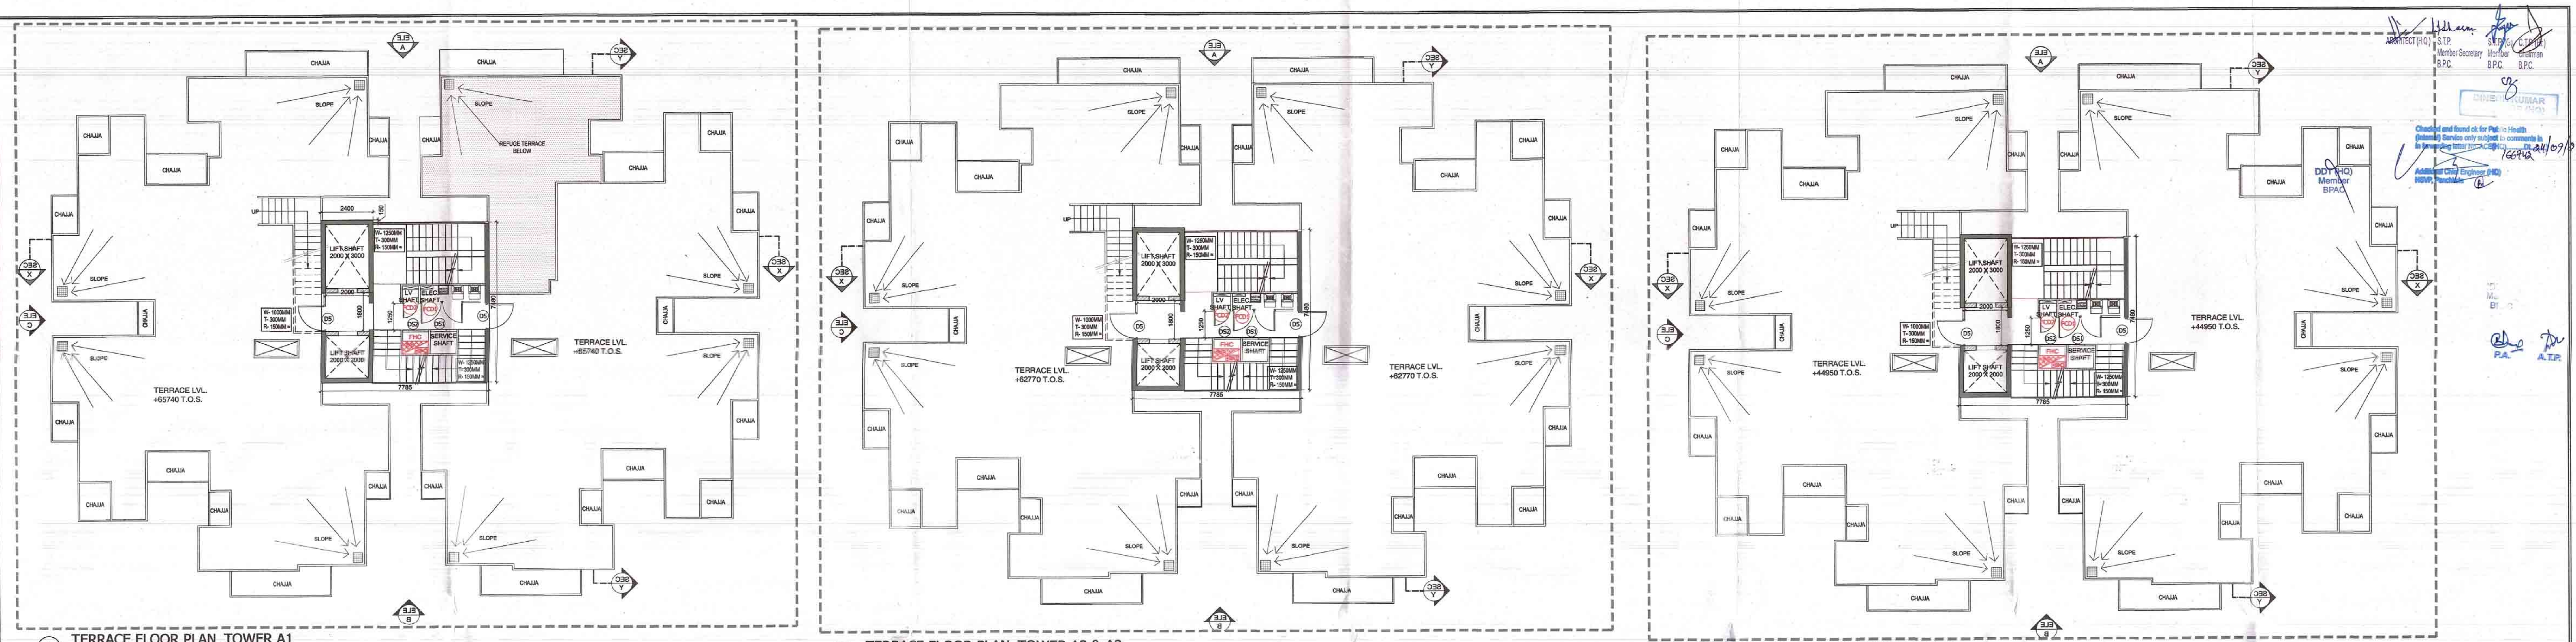


1 TERRACE FLOOR PLAN, TOWER A1
SCALE: 1:100

2 TERRACE FLOOR PLAN, TOWER A2 & A3
SCALE: 1:100


3 TERRACE FLOOR PLAN, TOWER A4-A10
SCALE: 1:100

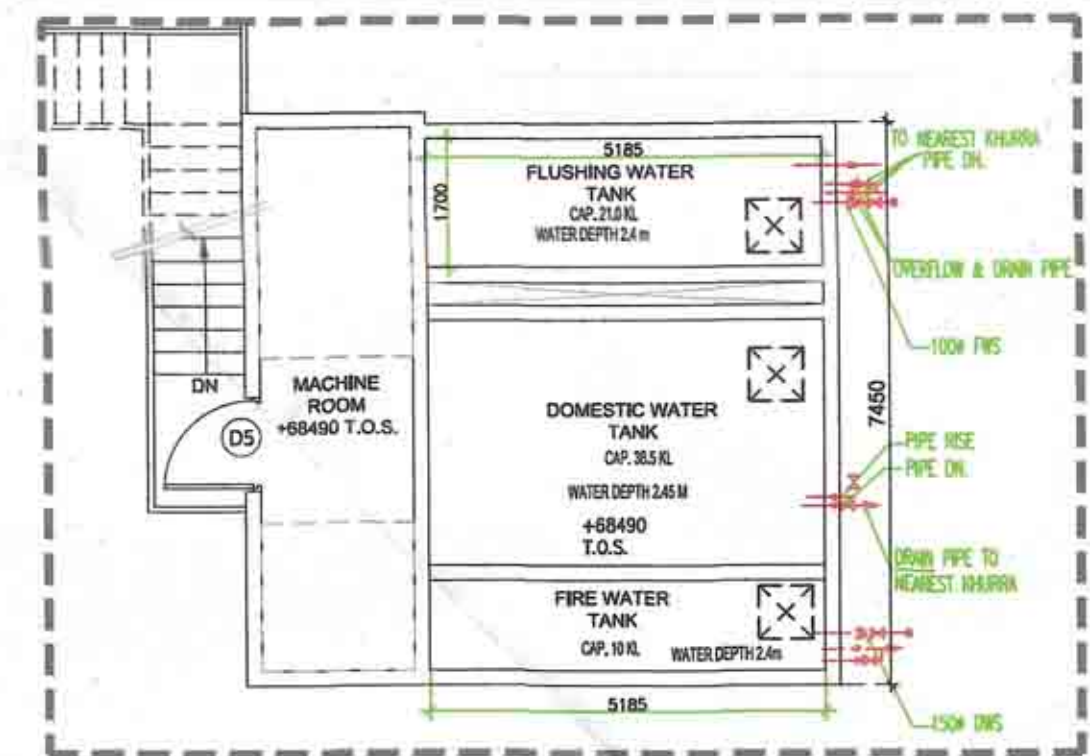


4 WATER TANK LVL. PLAN-TOWER A1
SCALE: 1:100

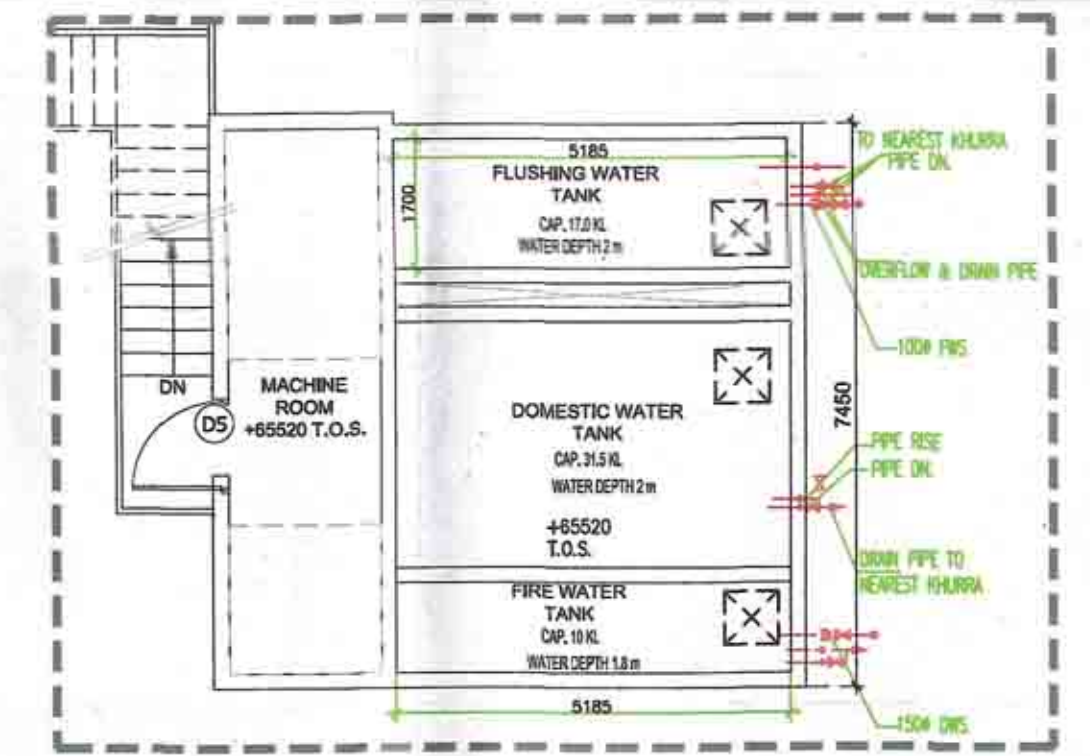


5 WATER TANK LVL. PLAN-TOWER A2&A3
SCALE: 1:100

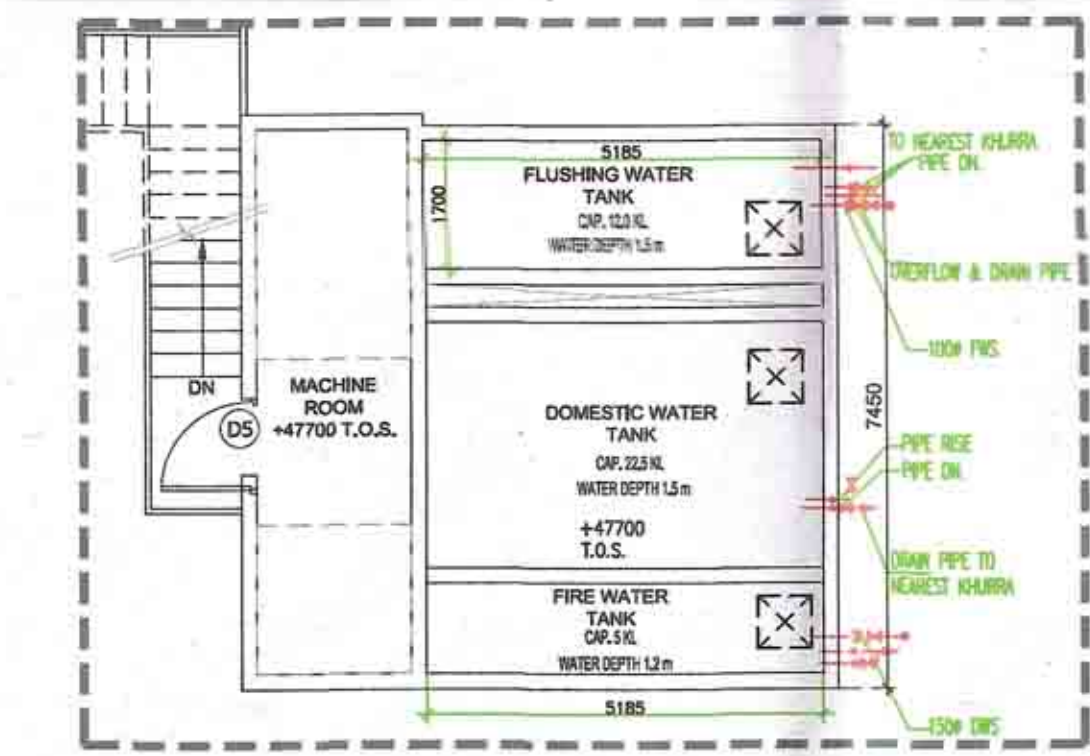


6 WATER TANK LVL. PLAN-TOWER TOWER A4-A10
SCALE: 1:100

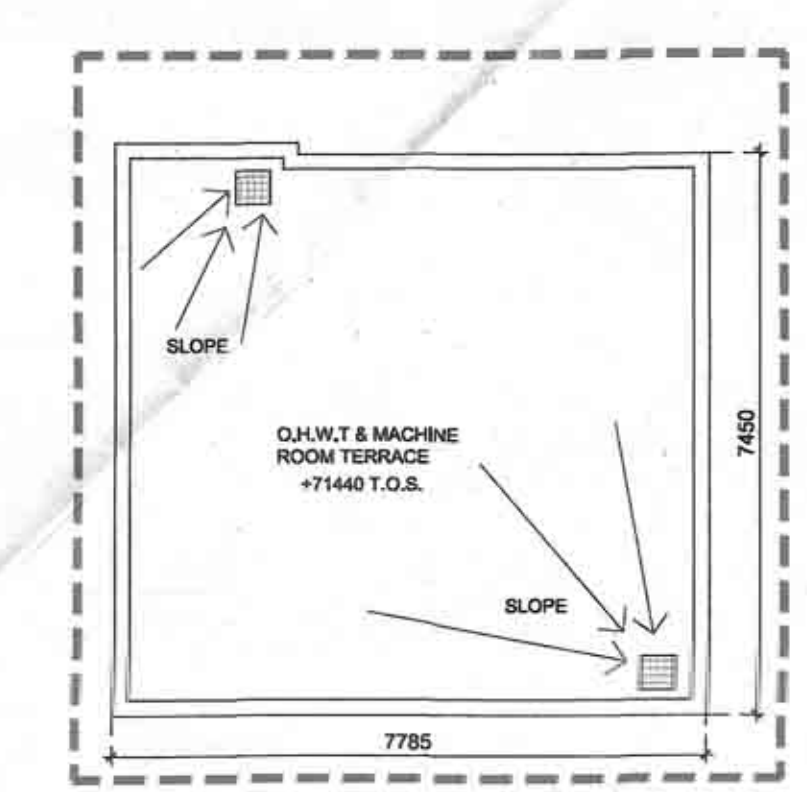


7 O.H.T. & M.R. TERRACE LVL. PLAN-TOWER A1
SCALE: 1:100

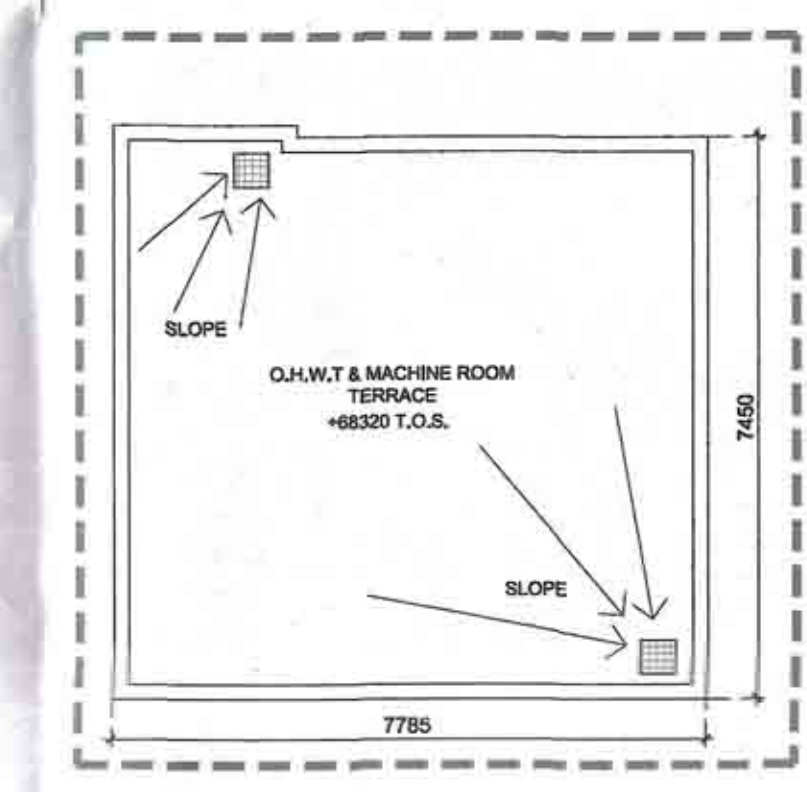


8 O.H.T. & M.R. TERRACE LVL. PLAN-TOWER A2&A3
SCALE: 1:100

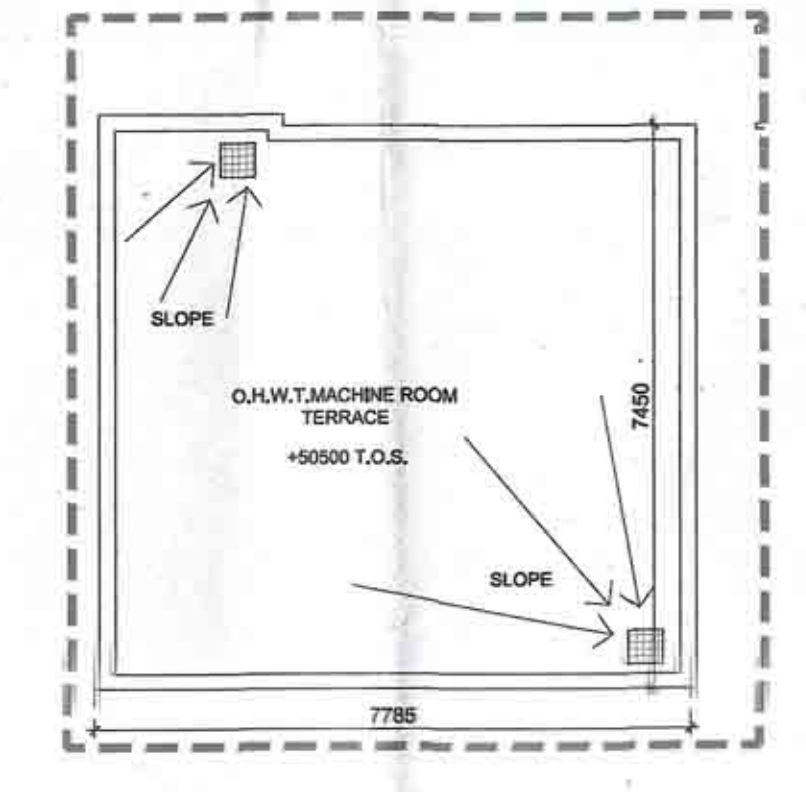


9 O.H.T. & M.R. TERRACE LVL. PLAN-TOWER TOWER A4-A10
SCALE: 1:100

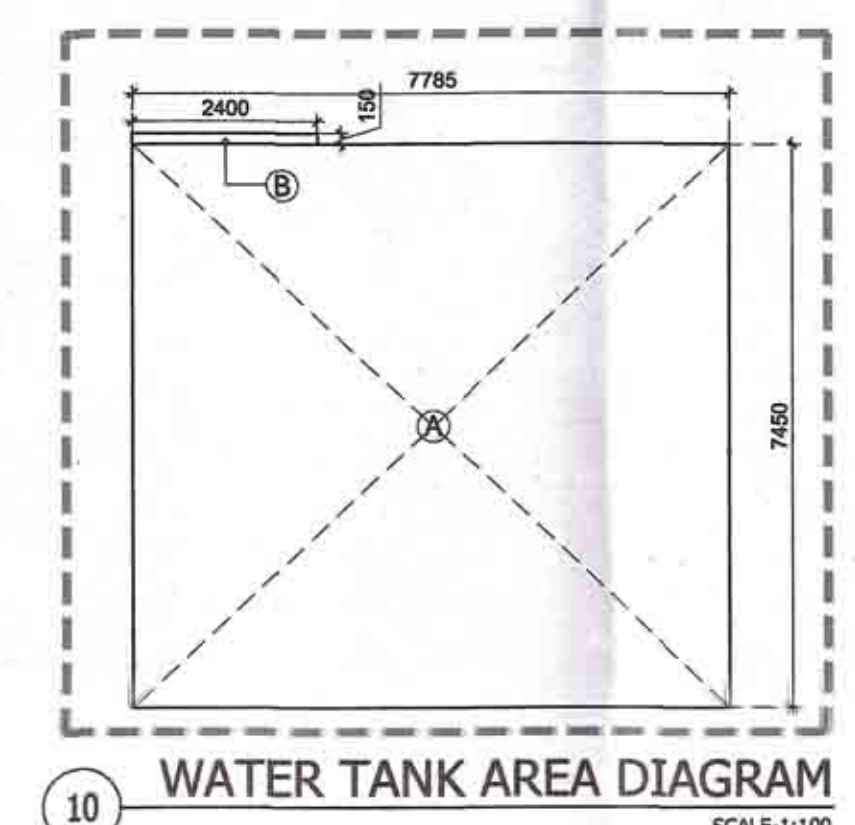

10 WATER TANK AREA DIAGRAM
SCALE: 1:100

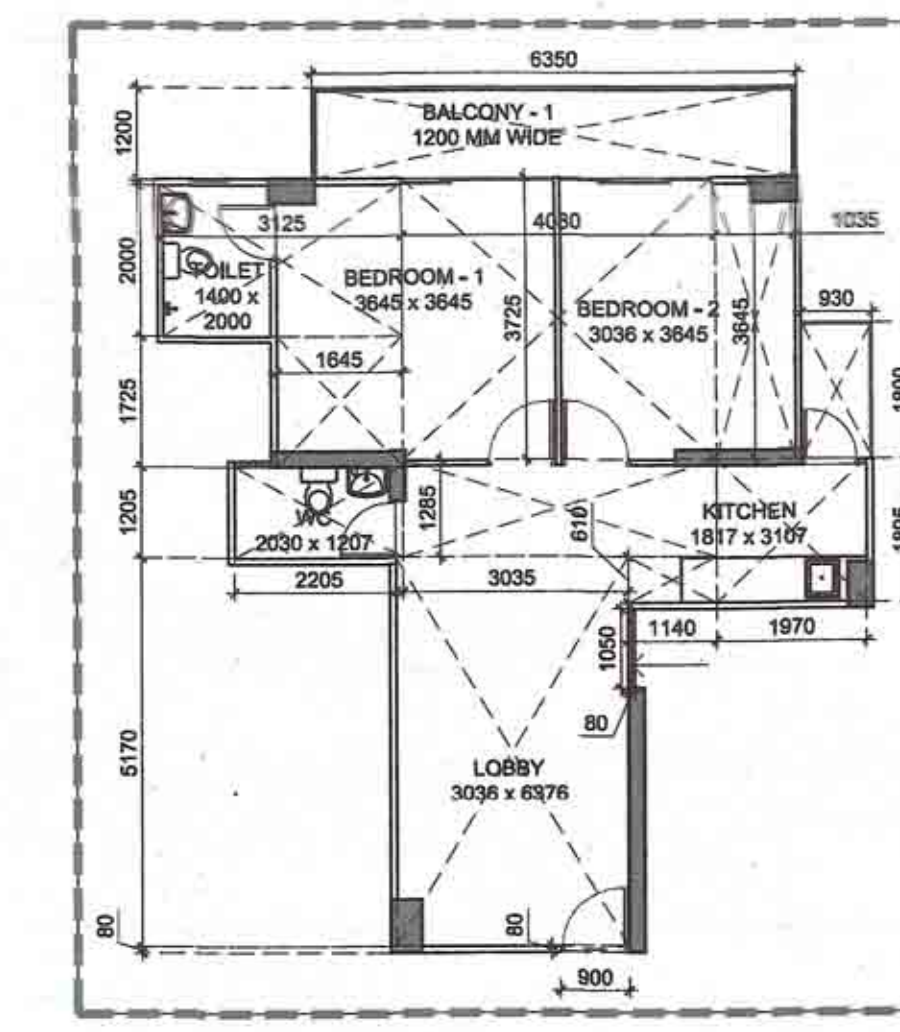

11 2BHK-TYPE 1
SCALE: 1:100

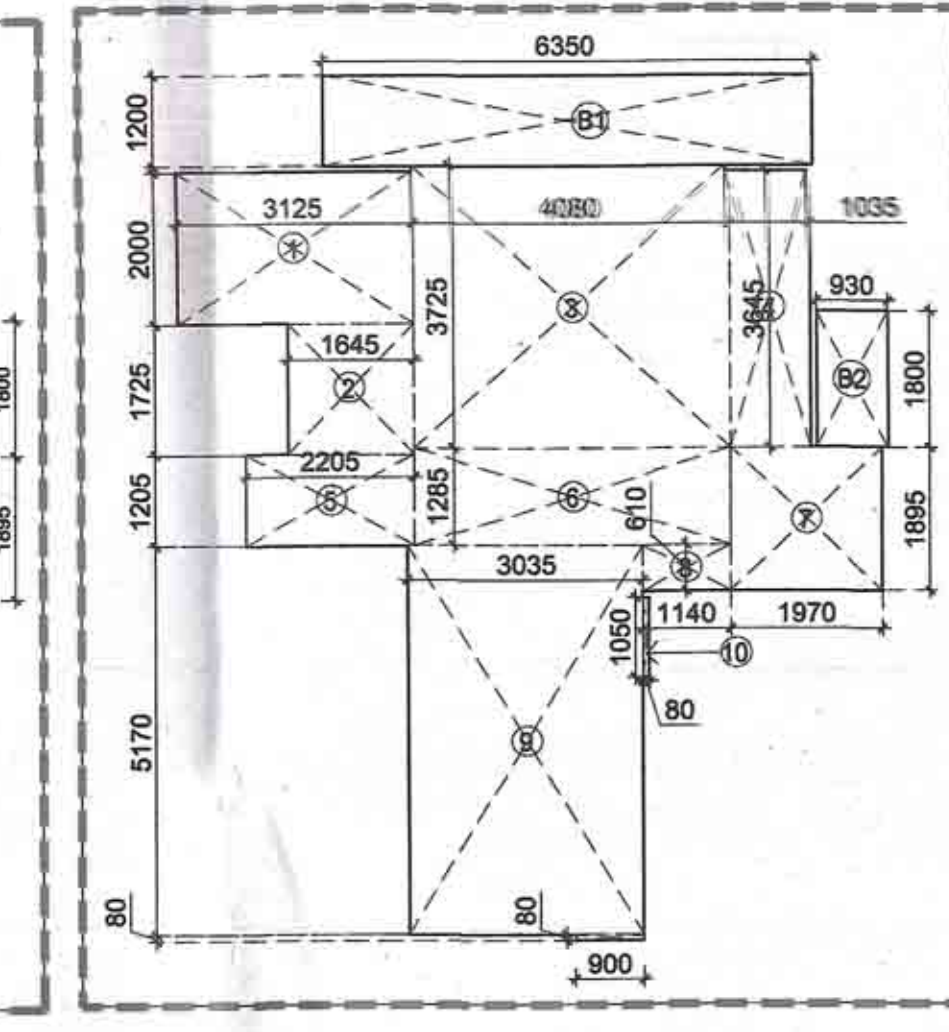

12 2BHK-TYPE 1-AREA DIAG.
SCALE: 1:100

CARPET AREA DETAIL (2BHK-TYPE 1)

NO.	DESCRIPTION	WIDTH (M)	LENGTH (M)	NOS.	AREA (SQ.M)
1	REC	3.125	2.000	1	6.250
2	REC	1.845	1.725	1	2.638
3	REC	4.080	3.725	1	15.198
4	REC	3.845	1.035	1	3.973
5	REC	1.205	2.205	1	2.657
6	REC	1.285	4.080	1	5.243
7	REC	1.970	1.895	1	3.733
8	REC	1.140	0.610	1	0.695
9	REC	3.035	5.170	1	15.691
10	REC	1.050	0.080	1	0.084
11	REC	0.900	0.080	1	0.072
TOTAL XX					58.23

DOOR & WINDOW SCHEDULE

DESCRIPTION	WIDTH	CLL	INTEL	HEIGHT	LOCATION
D1	900	00	2100	2100	BEDROOM
D2	750	00	2100	2100	TOILET
D3	750	00	2400	2400	BALCONY
D4	1250	00	2100	2200	LOBBY
D5	1250	00	2100	2200	TERRACE LOBBY
FD1	1000	00	2100	2100	ENTRY
FD2	1250	00	2100	2100	LOBBY
SD1	2000	100	2400	2300	BALCONY
SD2	1530	100	2400	2300	BALCONY
SD3	2510	100	2400	2300	BALCONY
SD4	1280	100	2400	2300	BALCONY
W1	1050	100	2400	2300	LOBBY
W2	1000	100	2400	2300	LOBBY
W3	800	450	2400	1950	BEDROOM
W4	750	100	2400	2300	LOBBY
W5	500	100	2400	2300	KITCHEN
W6	465	100	2400	2300	KITCHEN
W7	810	100	2400	2300	BEDROOM
V1	500	1200	2400	1200	TOILET
V2	480	1200	2400	1200	TOILET
DS1	750	450	2100	1650	SHAFT DOOR
DS2	1200	450	2100	1650	FHC SHAFT
FD1	2000	450	2100	1650	ELE. SHAFT
FD2	750	450	2100	1650	LV. SHAFT

PLUMBING LEGEND

1	110 OD SDR PVC SOIL & VENT PIPE
2	110 OD SDR PVC WASTE & VENT PIPE
3	90 OD UPVC ANTI-SIPHONAGE PIPE
4	110 OD UPVC RAIN WATER PIPE (FOR BALCONY)
5	110 OD UPVC RAIN WATER PIPE (FOR TERRACE)
6	50MM CDS RISER TO CHLT. FILING TANK
7	40MM PWS RISER TO CHLT. FILING TANK
8	DOMESTIC WATER SUPPLY ON TAKE PIPE
9	FLUSHING WATER SUPPLY ON TAKE PIPE

- NOTES:**
1. ALL LIFTS SHALL HAVE 100% POWER BACKUP.
 2. ALL ELECTRICAL INSTALLATIONS SHALL BE AS PER PROVISION OF NBC.
 3. FIRE FIGHTING/SAFETY PROVISIONS WILL BE AS PER RELEVANT NBC PROVISIONS.
 4. BUILDING STRUCTURE DESIGNED EARTHQUAKE RESISTANT.
 5. MAIN ENTRY & BOUNDARY WALL AS PER STANDARD DESIGN.

PROJECT
AFFORDABLE GROUP HOUSING COLONY ON LAND MEASURING 9.3629 Acres (License no.42 of 2021 dated 27.07.2021) IN SECTOR 102, GURUGRAM, HARYANA BEING DEVELOPED BY HABITAT TOWNSHIP PVT. LTD.

CLIENT
RUDRAKSHA REALTORS PVT. LTD. & OTHERS IN COLLABORATION WITH HABITAT TOWNSHIP PVT. LTD.

PRINCIPAL ARCHITECT



K-47, KAILASH COLONY, NEW DELHI-110048
PHONE NO.: 011-46556600

DRG. TITLE
TOWER A1-A10-TERRACE AND ABOVE. FL. PLANS & AREA DETAILS

OWNER'S SIGN

ARCHITECT'S SIGN

NORTH:

SCALE - AS MARKED

DATE:- 24.08.2021

SHEET NO.

06