
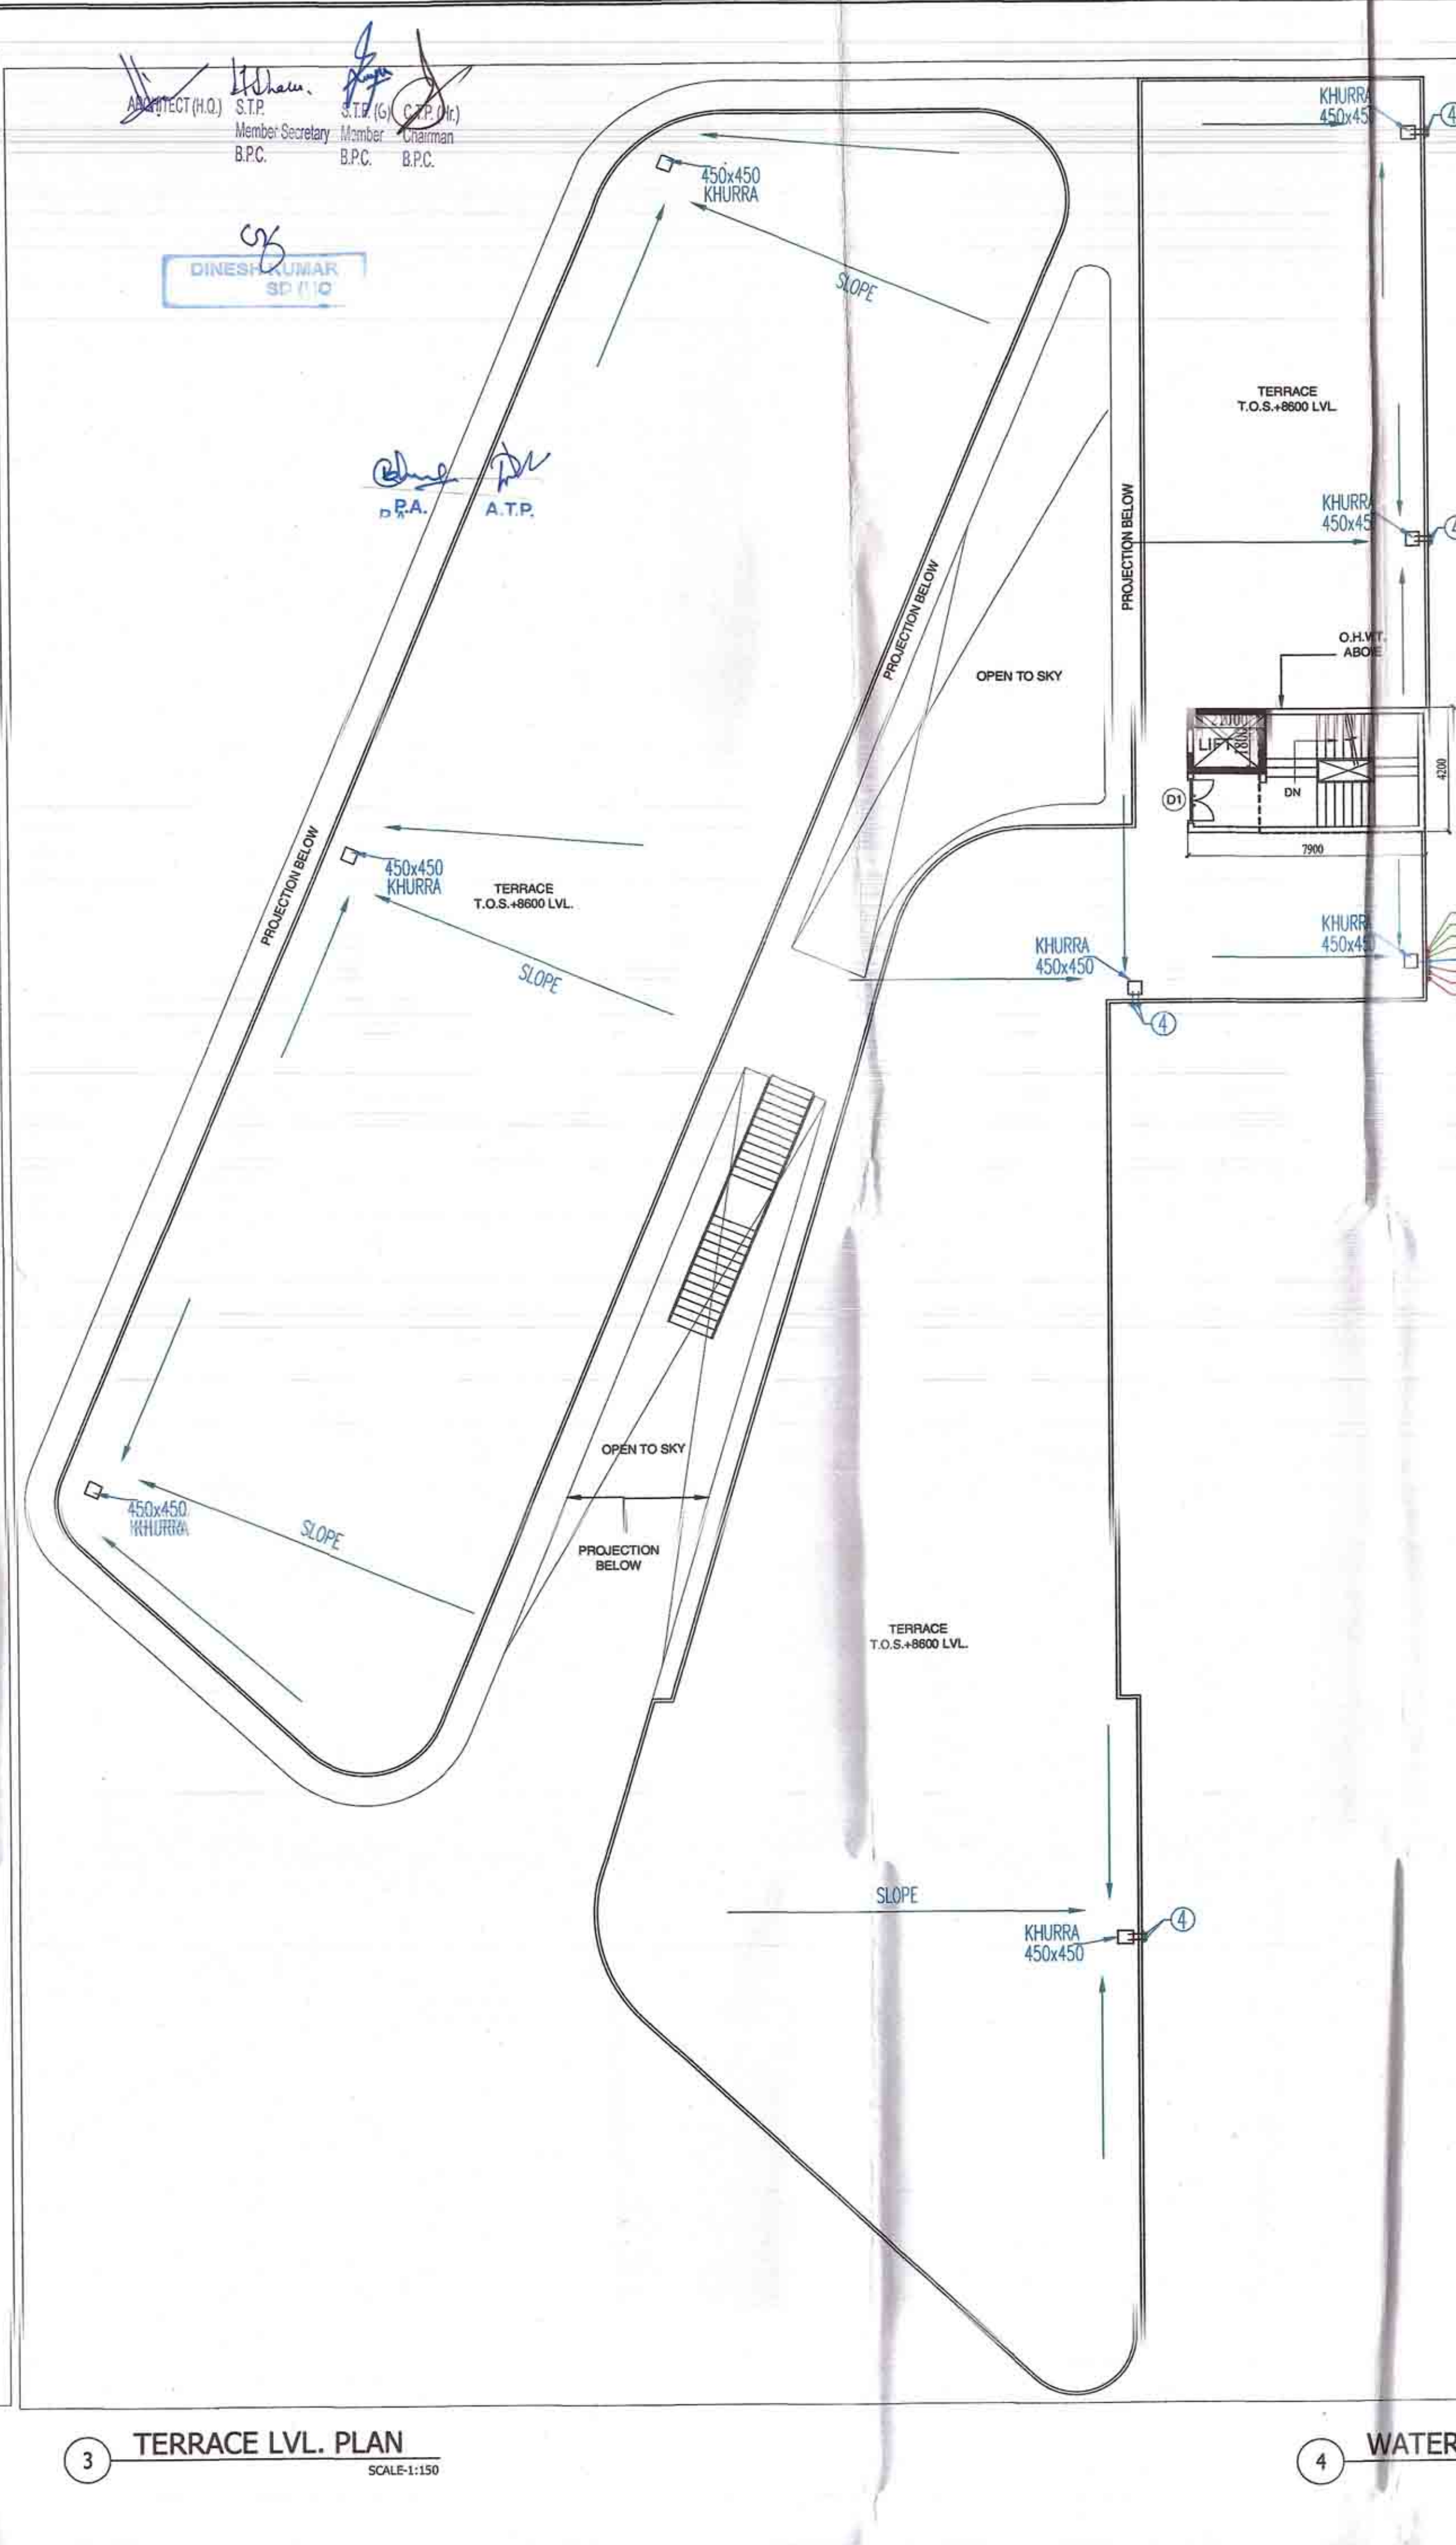
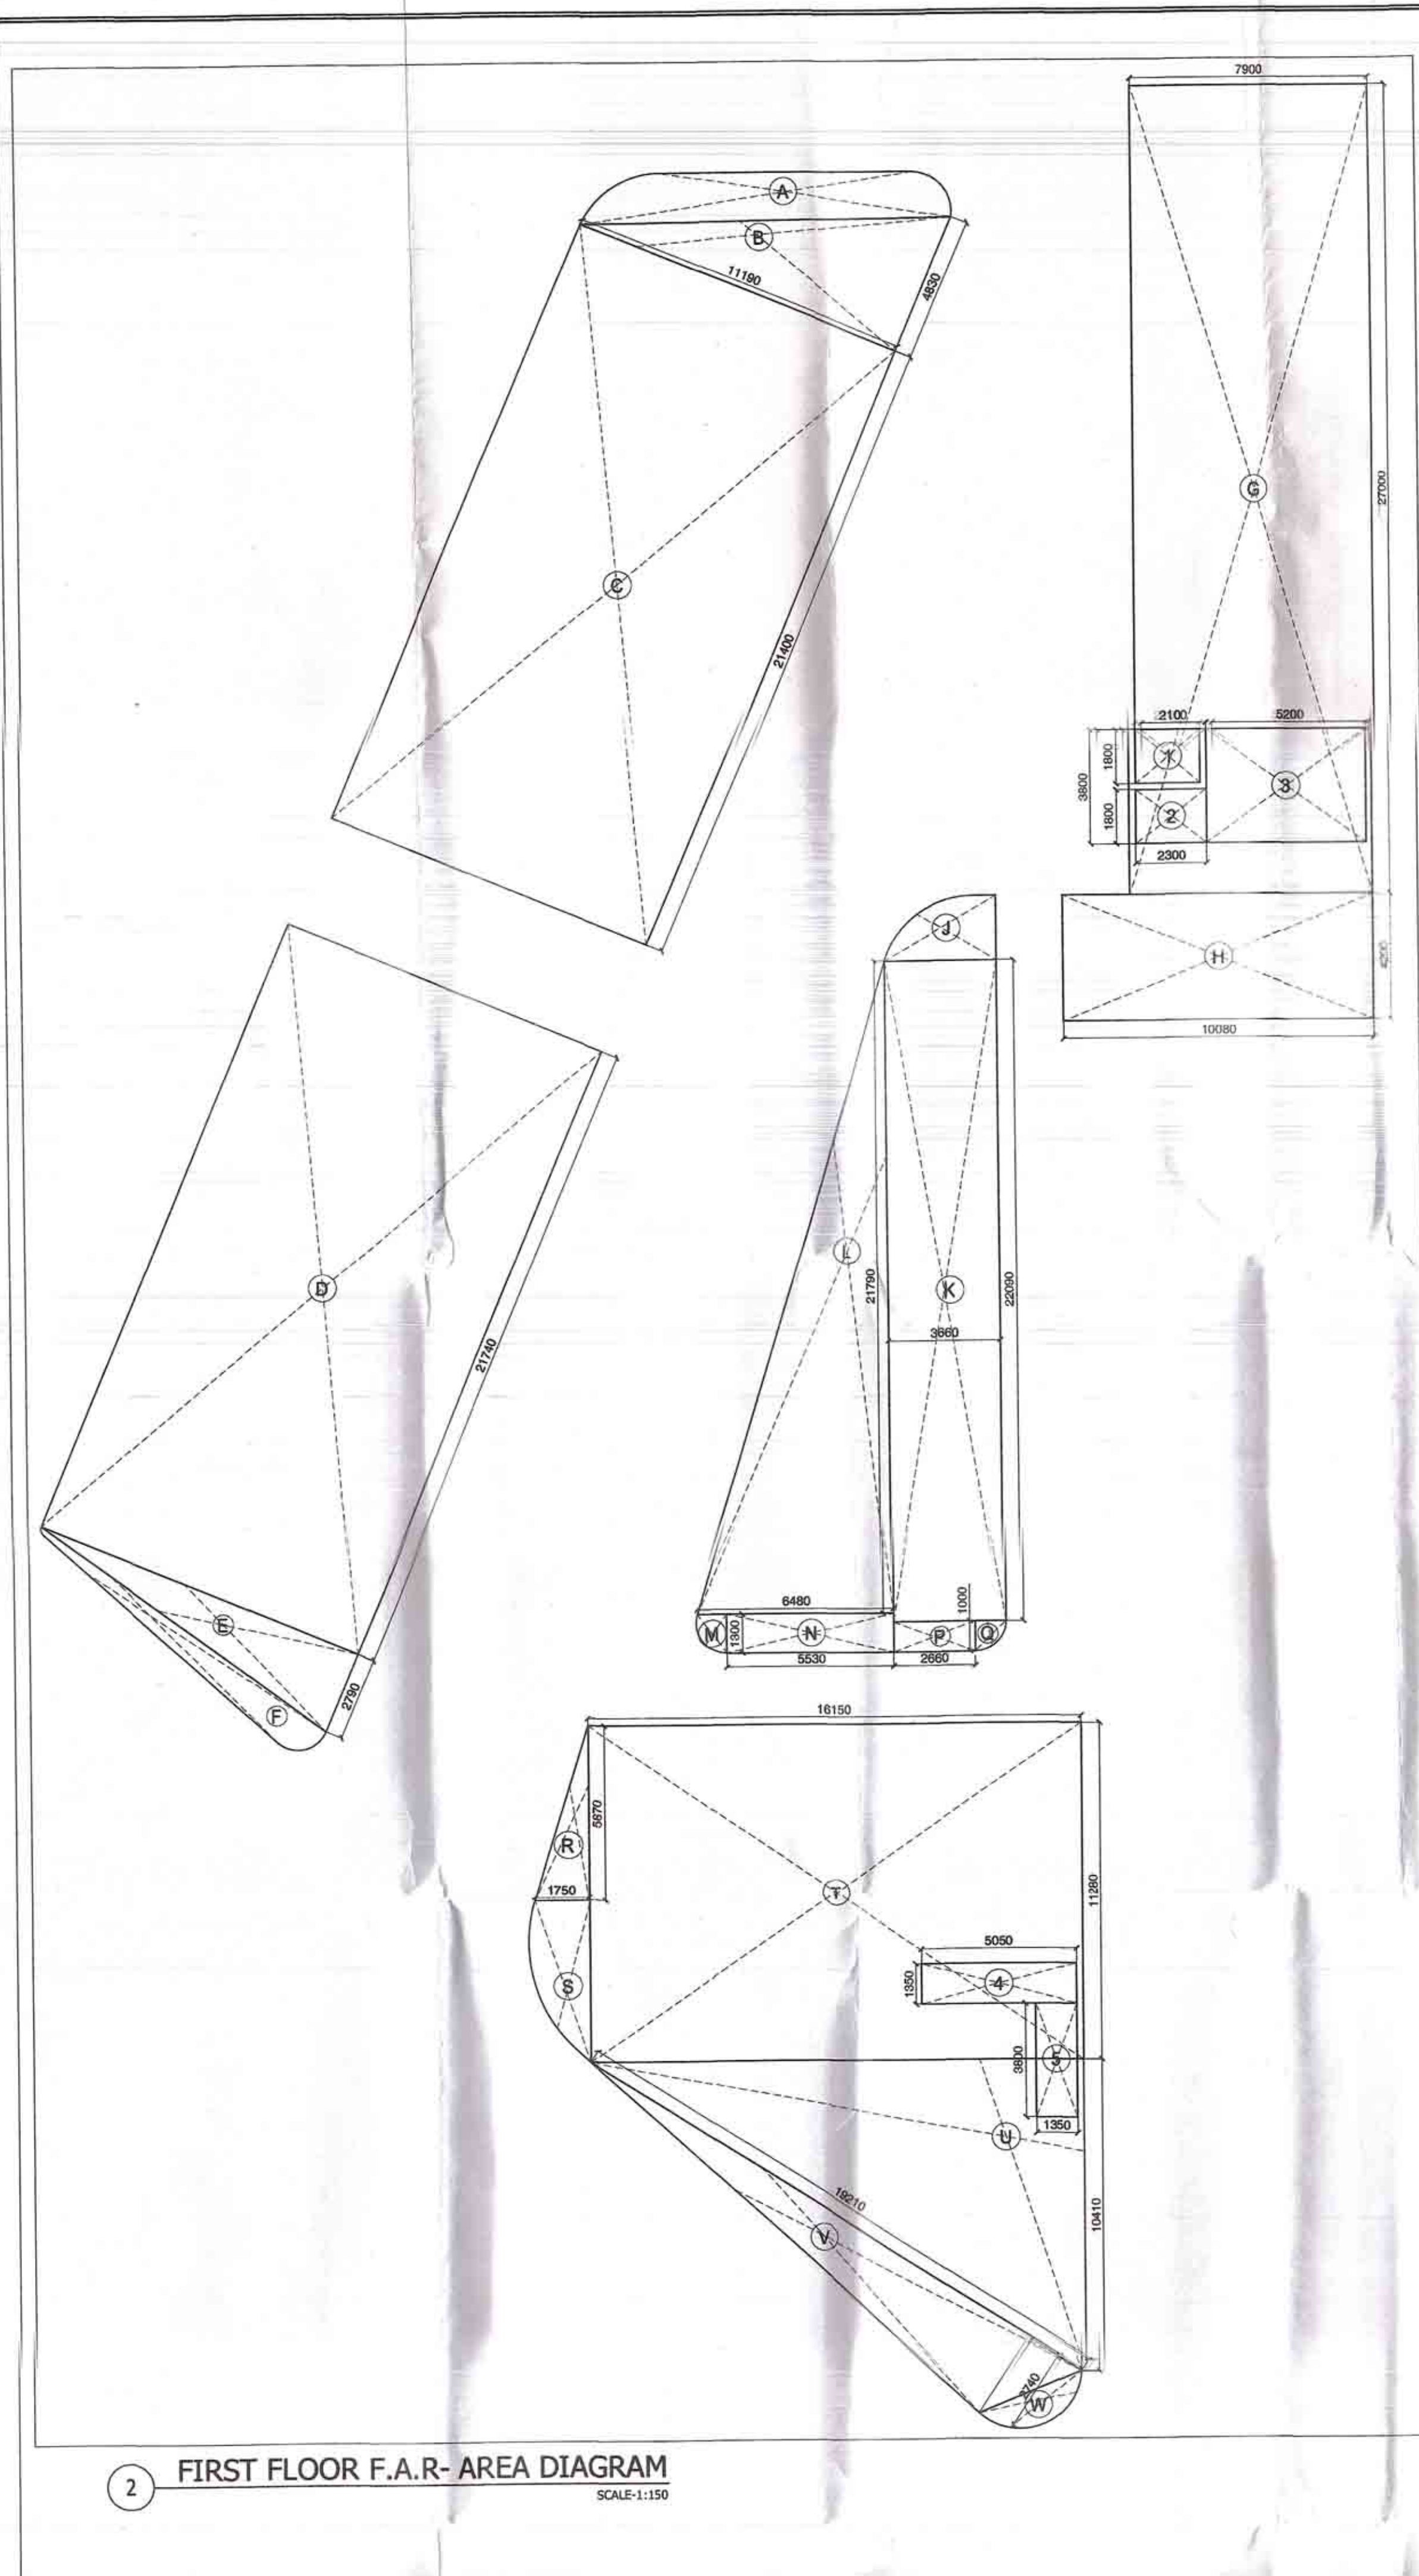


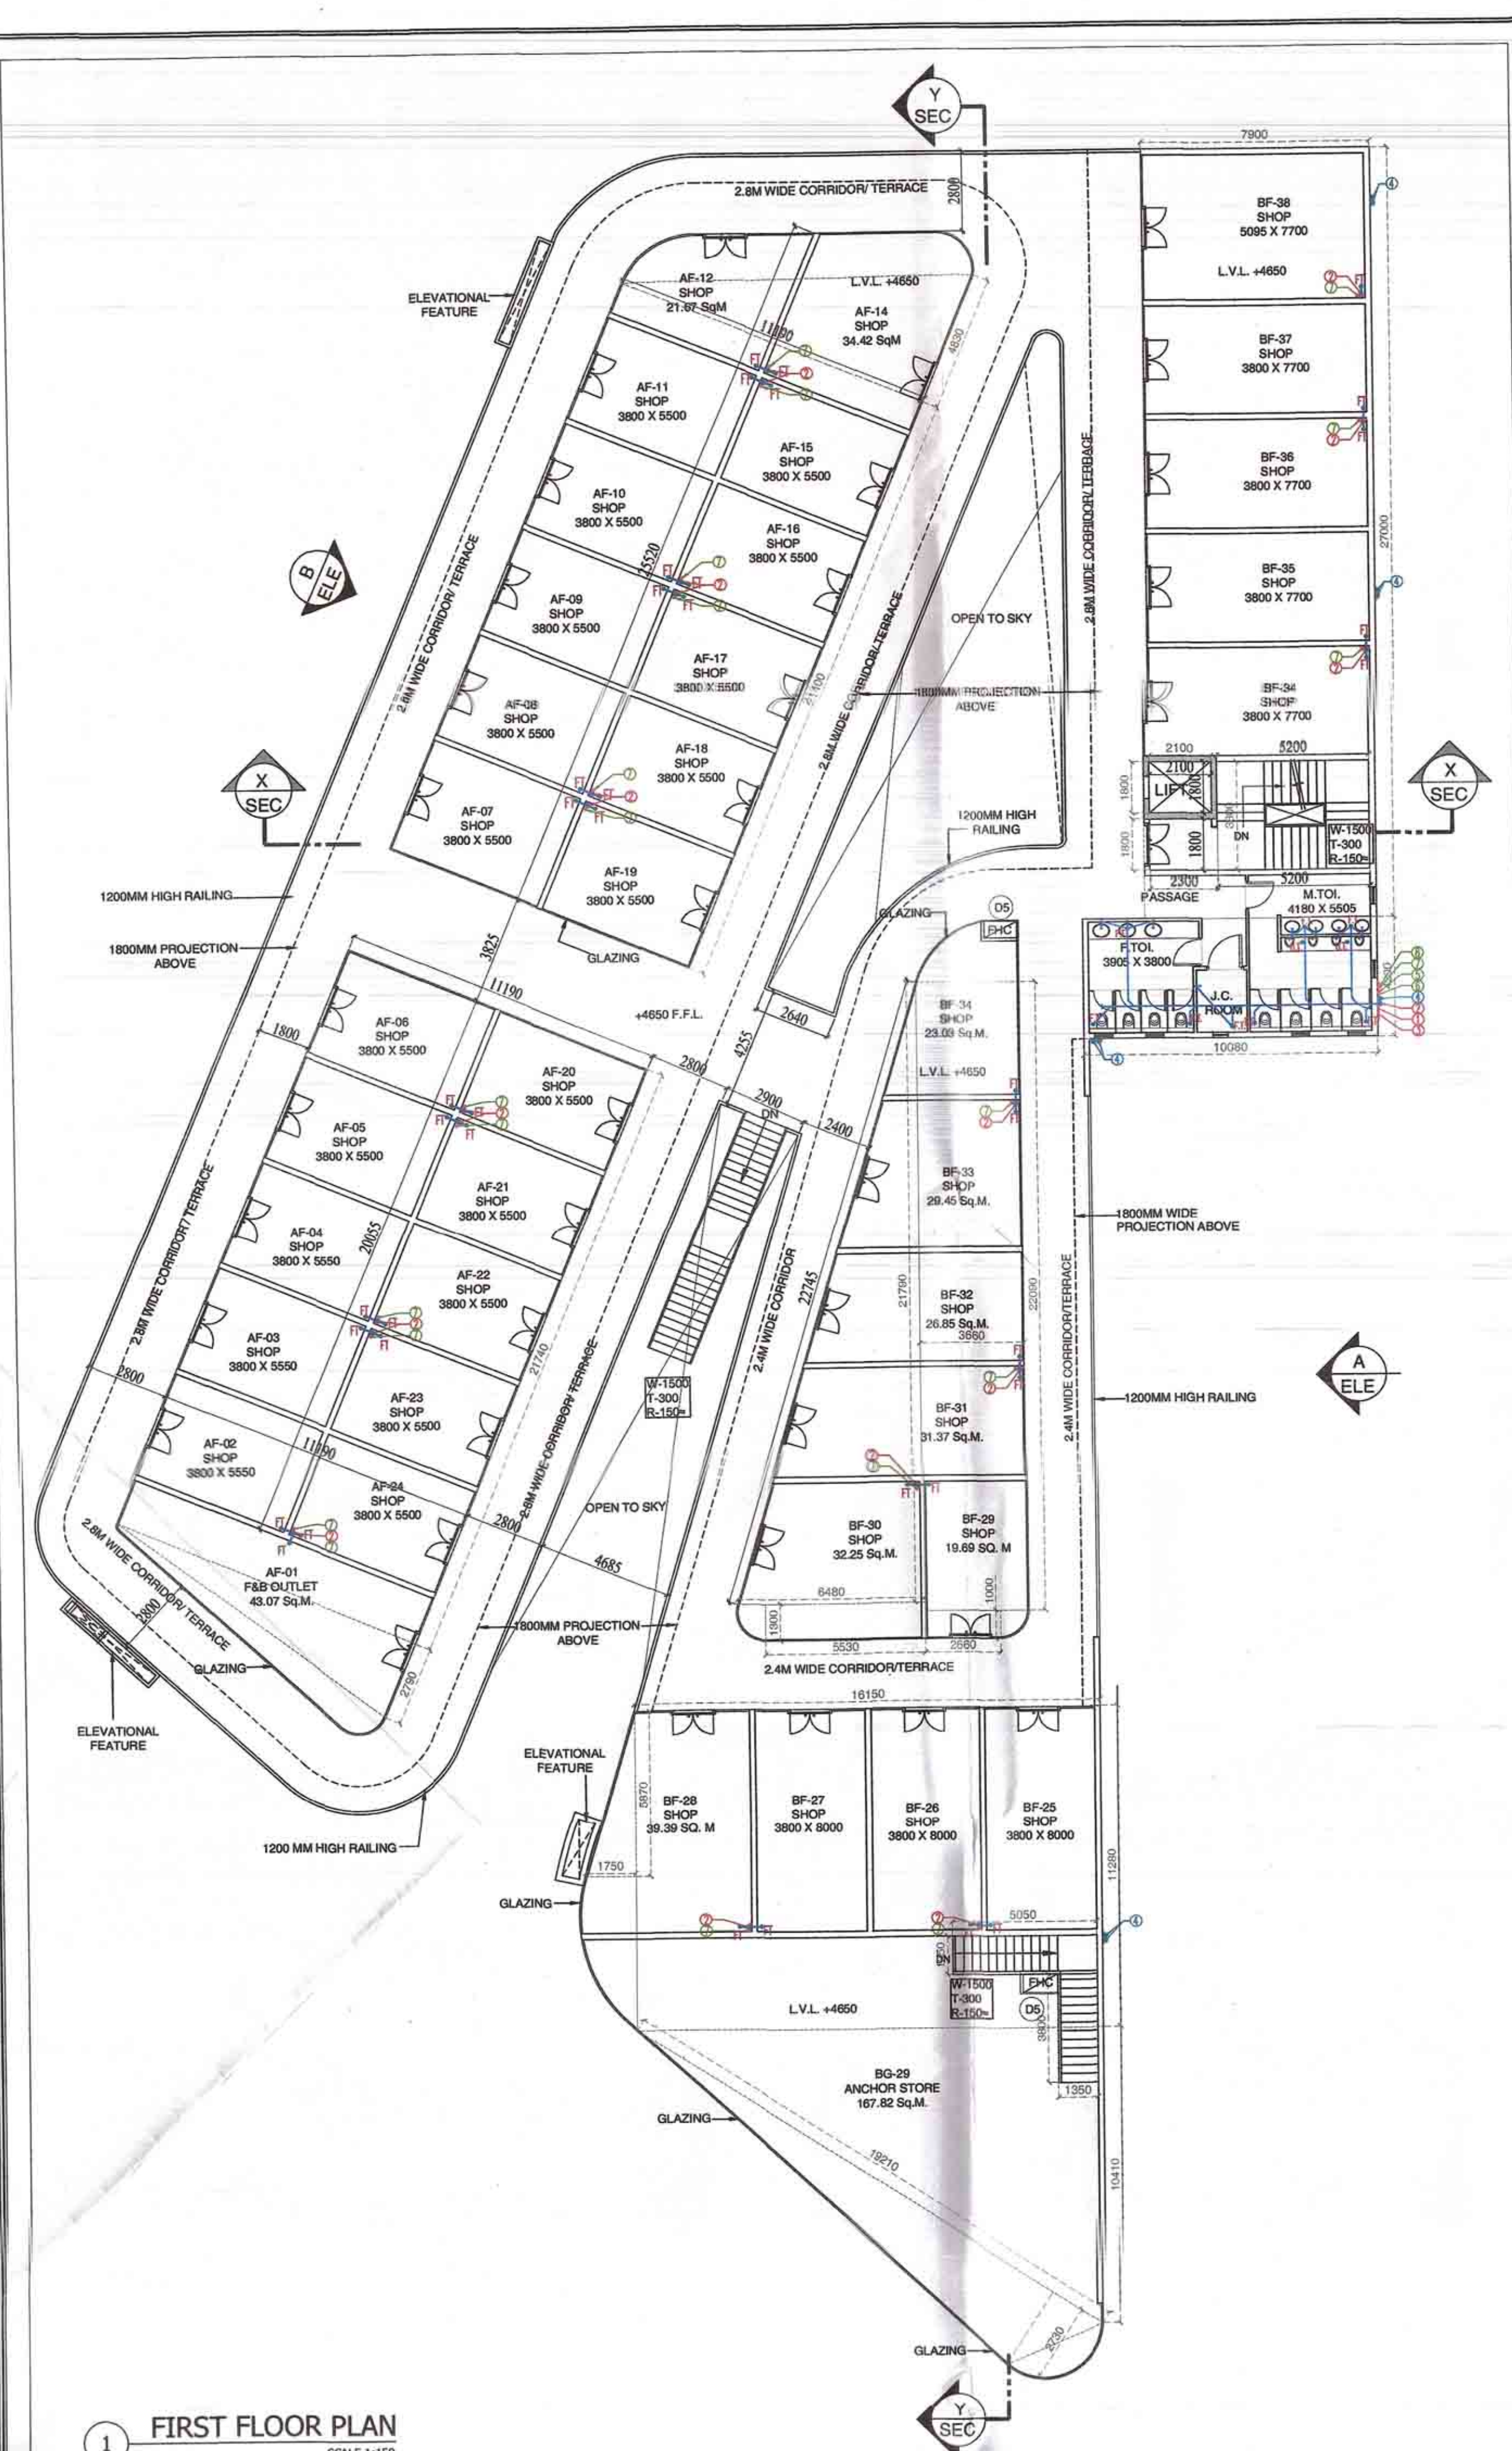

PLUMBING LEGEND:-

1	110 OD SRR PVC SOIL & VENT PIPE
2	110 OD SRR PVC WASTE & VENT PIPE
3	90 OD uPVC AIR-SPRING PIPE
4	180 OD uPVC RAIN WATER PIPE FOR TERRACE
5	32# CWS RISER TO O.H.T. FILLING TANK
6	25# FMS RISER TO O.H.T. FILLING TANK
7	DOMESTIC WATER SUPPLY ON THE PIPE
8	FLUSHING WATER SUPPLY ON THE PIPE

DOOR & WINDOW SCHEDULE

DESCRIPTION	WIDTH	ILL	UNTEL	HEIGHT
D1	1500	00	2100	2100
D2	1000	00	2100	2100
D3	1250	00	2100	2100
D4	750	00	2100	2100
D5	1200	00	2100	2100
D6	1500	00	2400	2400
D7	1200	00	2400	1200

FIRST FLOOR AREA DETAIL (F.A.R.)

TOTAL AREA	XX (ADDITION)	YY (SUBTRACTION)	TOTAL AREA
	1,288.250	39.628	1,248.622

DETAIL XX=

TYPE	ENVELOPE (ADDITION)	WIDTH	LENGTH	NOS.	AREA
A	POLYLINE			1	18.042
B	TRIANGLE	4.830	11.190	1	27.024
C	REC	21.400	11.190	1	239.468
D	REC	21.740	11.190	1	243.271
E	TRIANGLE	11.190	2.790	1	15.610
F	POLYLINE			1	8.509
G	REC	27.000	7.900	1	213.300
H	REC	10.050	4.200	1	42.335
I	POLYLINE			1	8.210
K	REC	22.080	3.660	1	80.849
L	TRIANGLE	21.790	6.480	1	70.800
M	POLYLINE			1	1.078
N	REC	1.300	5.530	1	7.189
P	REC	2.660	1.000	1	2.660
Q	POLYLINE			1	0.783
R	TRIANGLE	1.750	5.870	1	5.136
S	POLYLINE			1	8.054
T	REC	18.150	11.280	1	182.172
U	TRIANGLE	10.410	16.150	1	84.061
V	TRIANGLE	19.210	3.000	1	28.815
W	POLYLINE			1	3.045
TOTAL XX=					1288.250

DETAIL YY=

TYPE	ENVELOPE (SUBTRACTION)	WIDTH	LENGTH	NOS.	AREA
1	REC	1.800	2.100	1	3.780
2	REC	1.800	2.300	1	4.140
3	REC	5.200	3.800	1	19.760
4	REC	1.350	5.050	1	6.818
5	REC	3.800	1.350	1	5.130
TOTAL YY=					39.628

NOTES:

- ALL LIFTS SHALL HAVE 100% POWER BACKUP.
- ALL ELECTRICAL INSTALLATIONS SHALL BE AS PER PROVISION OF NBC.
- FIRE FIGHTING/SAFETY PROVISIONS WILL BE AS PER RELEVANT NBC PROVISIONS.
- BUILDING STRUCTURE DESIGNED EARTHQUAKE RESISTANT.
- MAIN ENTRY & BOUNDARY WALL AS PER STANDARD DESIGN.

PROJECT
PROPOSED BUILDING PLAN OF AFFORDABLE GROUP HOUSING COLONY ON LAND MEASURING 9.362 Acres (License no. 42 of 2023 dated 12/07/2023) IN SECTOR 102, GURUGRAM, HARYANA BEING DEVELOPED BY HABITAT TOWNSHIP PVT. LTD.

CLIENT
RUDRAKSHA REALTORS PVT. LTD. & OTHERS IN COLLABORATION WITH HABITAT TOWNSHIP PVT. LTD.

PRINCIPAL ARCHITECT
DESIGN FORUM INTERNATIONAL

K-47, KAILASH COLONY, NEW DELHI-110048
PHONE NO.: 011-46556600

DRG. TITLE
COMMERCIAL BUILDING TERRACE LVL PLANS, AREA DETAILS, ELEVATIONS & SECTIONS



OWNER'S SIGN

ARCHITECT'S SIGN
COONMEST S. CHAUHAN
R. Arch. (Hons.), M.C.A.
CAPS:18748

SCALE - AS MARKED

DATE-24.08.2021

SHEET NO.
11

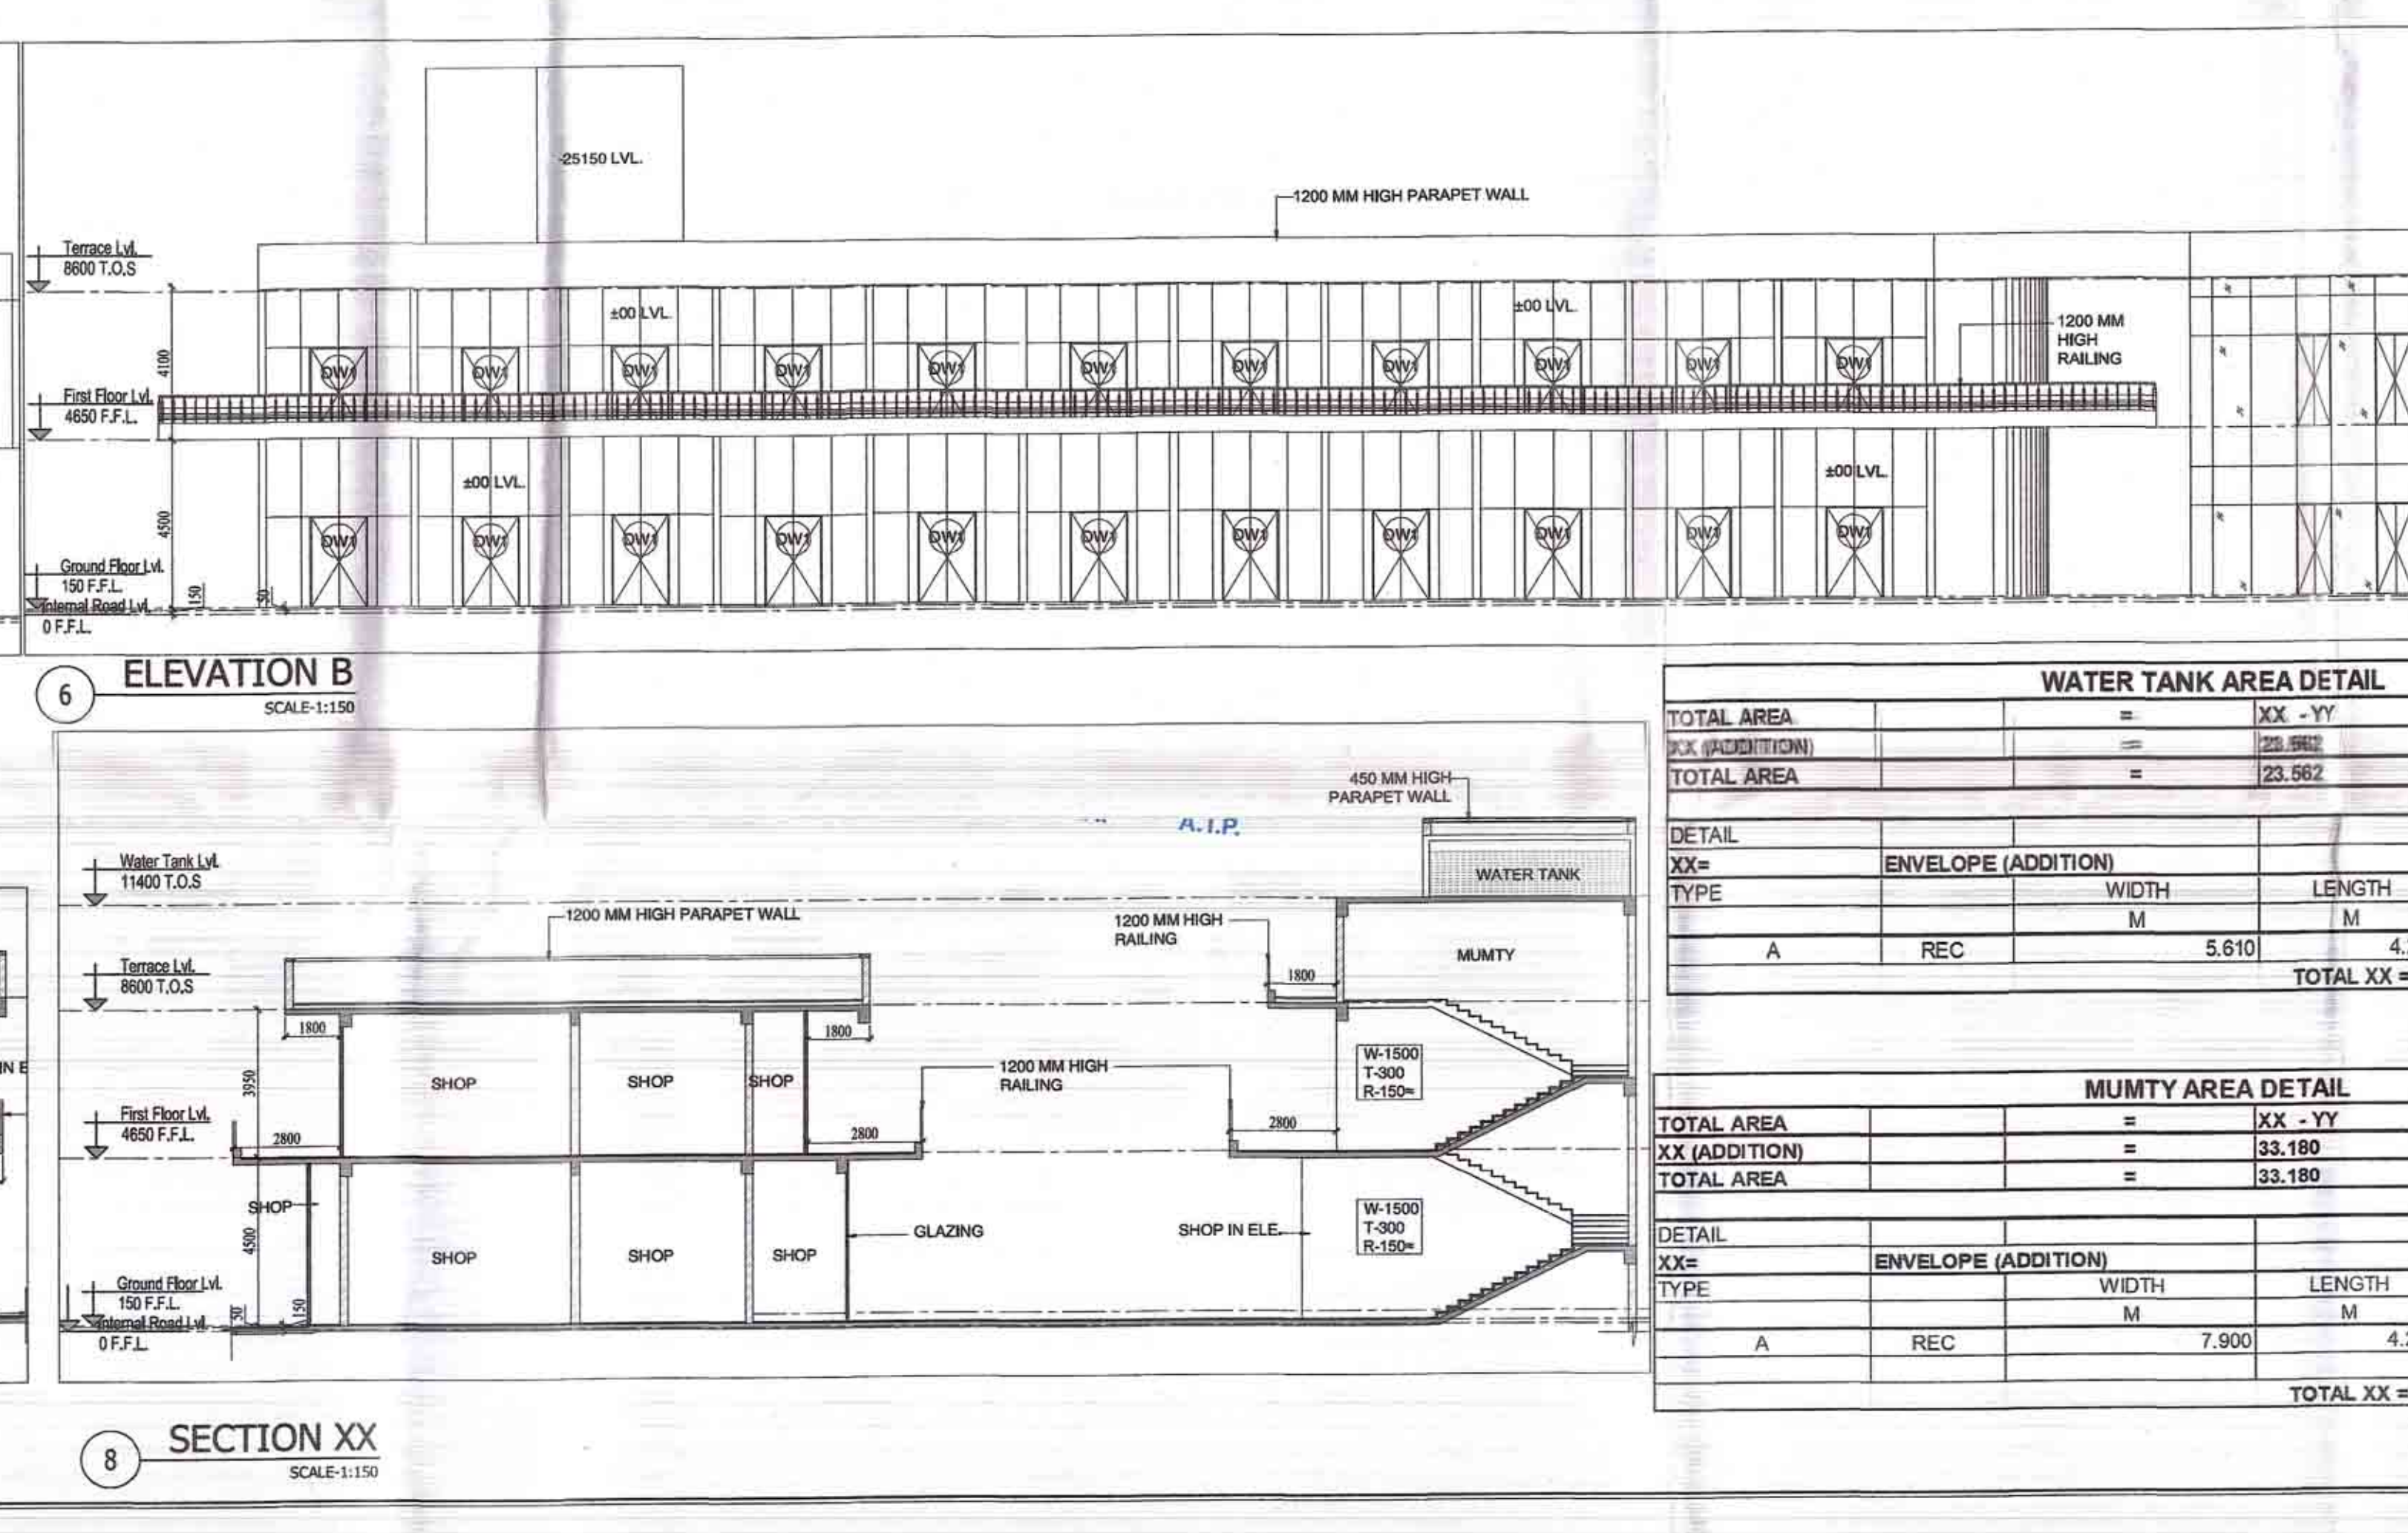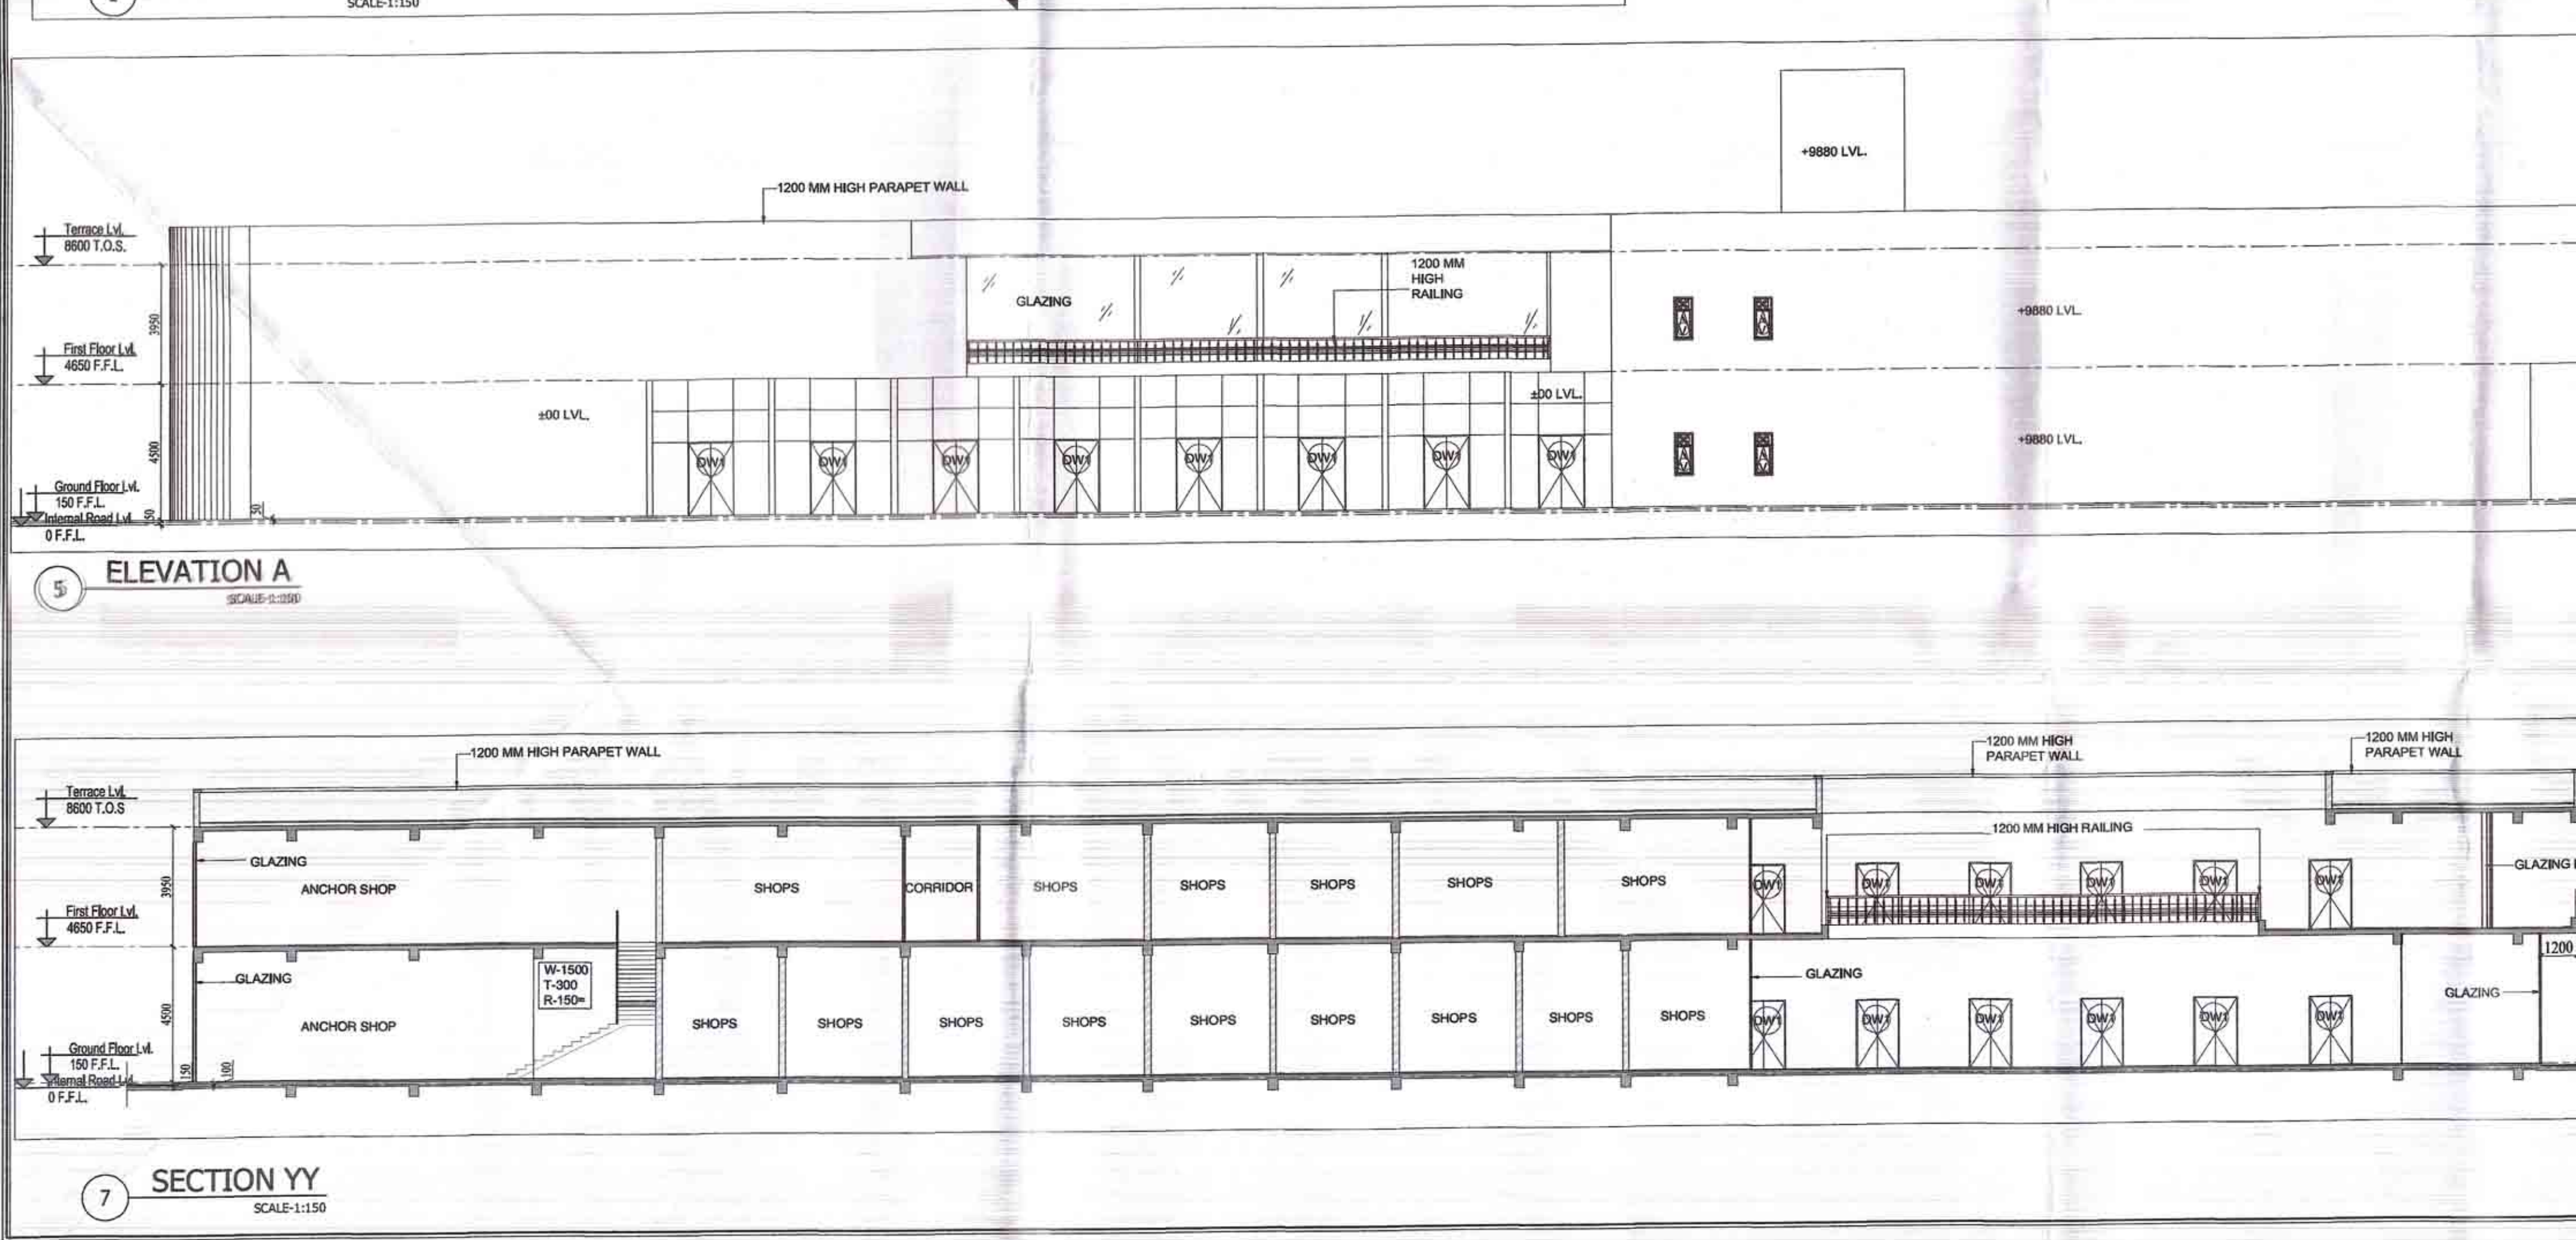

WATER TANK AREA DETAIL

TOTAL AREA	XX (ADDITION)	YY (SUBTRACTION)	TOTAL AREA
	23.562		23.562

MUMTY AREA DETAIL

TOTAL AREA	XX (ADDITION)	YY (SUBTRACTION)	TOTAL AREA
	33.180		33.180

DETAIL XX=

TYPE	ENVELOPE (ADDITION)	WIDTH	LENGTH	NOS.	AREA
A	REC	5.610	4.200	1	23.562
TOTAL XX=					23.562

DETAIL YY=

TYPE	ENVELOPE (SUBTRACTION)	WIDTH	LENGTH	NOS.	AREA
A	REC	7.900	4.200	1	33.180
TOTAL YY=					33.180