


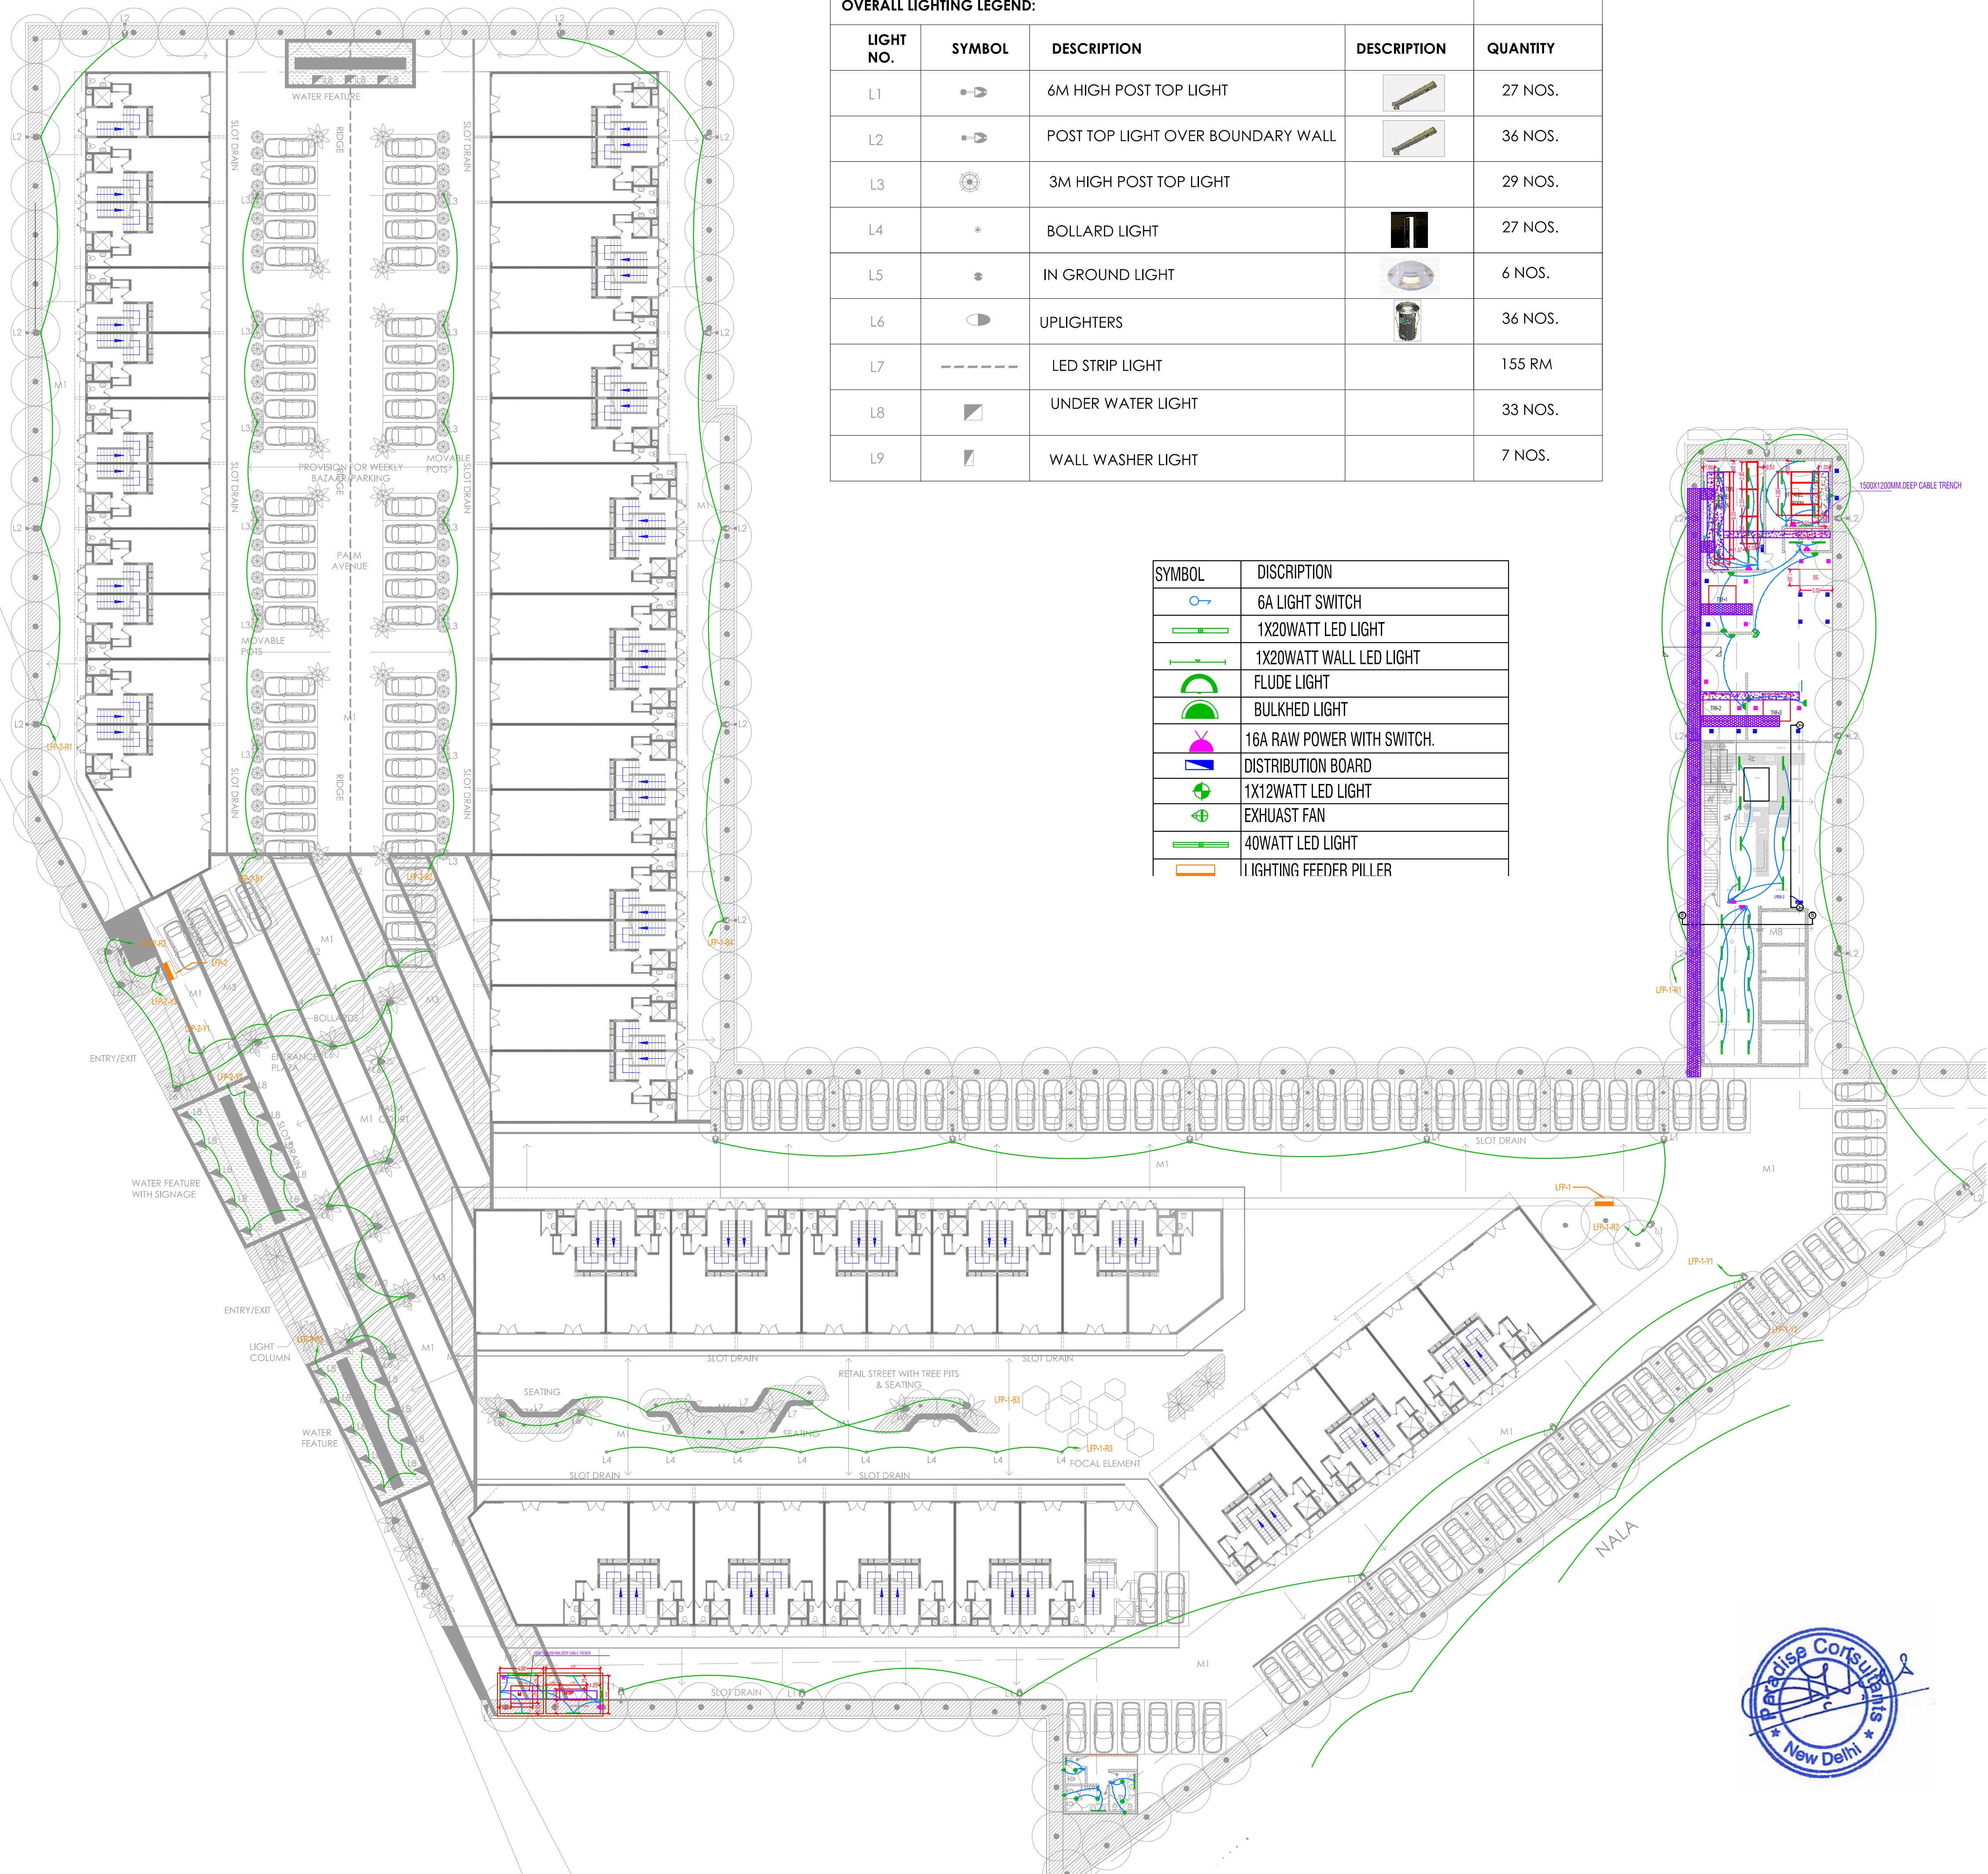

OVERALL LIGHTING LEGEND:				
LIGHT NO.	SYMBOL	DESCRIPTION	DESCRIPTION	QUANTITY
L1		6M HIGH POST TOP LIGHT		27 NOS.
L2		POST TOP LIGHT OVER BOUNDARY WALL		36 NOS.
L3		3M HIGH POST TOP LIGHT		29 NOS.
L4		BOLLARD LIGHT		27 NOS.
L5		IN GROUND LIGHT		6 NOS.
L6		UPLIGHTERS		36 NOS.
L7		LED STRIP LIGHT		155 RM
L8		UNDER WATER LIGHT		33 NOS.
L9		WALL WASHER LIGHT		7 NOS.

SYMBOL	DISCRPTION
	6A LIGHT SWITCH
	1X20WATT LED LIGHT
	1X20WATT WALL LED LIGHT
	FLUDE LIGHT
	BULKHED LIGHT
	16A RAW POWER WITH SWITCH.
	DISTRIBUTION BOARD
	1X12WATT LED LIGHT
	EXHUAST FAN
	40WATT LED LIGHT
	LIGHTING FEEDER PILLER

ISSUES				
NO.	DATE	BY	DESCRIPTION	PRINTS

REVISIONS				
NO.	DATE	BY	DESCRIPTION	

OWNER'S SIGNATURE

MEP CONSULTANTS:
PARADISE CONSULTANTS
Paradise ConsultantsPlot No. 96,
Basement, Pocket 1
Near Living Style Mall, Jasola Vihar
New Delhi - 110025Landline
+91-11-29943601, 41030619
Web www.paradiseconsultants.com

ARCHITECT'S SIGNATURE
MAAS
ARCHITECTURE, INTERIORS, PLANNING
D-229, Basement, sarvodya Enclave, New Delhi-110017
Ph. : 011-41829970/71/72/74
E-mail : studio@maasarchitects.net
Website : www.maasarchitects.net

OWNER:-
M/S EMAAR INDIA LTD.

PROJECT:-
PROPOSED PLAN OF COMMERCIAL SCO PLOTTED COLONY
(EBD-89) ON LAND MEASURING 3.7060 ACRE FALLING IN THE
REVENUE ESTATE OF VILLAGE BADHA,SECTOR 89 GURUGRAM
BEING DEVELOPED BY M/S EMAAR INDIA LTD.

DRAWING TITLE :			
EXTERNAL SITE PLAN (PART 1)			
LANDSCAPE LIGHTING LAYOUT			
scale :	1:300(A1)	drawn by :	M.S
date :	11/08/21	checked by:	ATIQ
project no :	-----	approved by :	NAFEES
drawing no :	EL-PC-SCO-SITE-103		
REVISION	R0		