

KEY PLAN

PROJECT NO: 137
 DATE: 12/2021
 DRAWN BY: [Signature]
 CHECKED BY: [Signature]
 APPROVED BY: [Signature]

- NOTES:**
1. FD TO FT 500 WASTE PIPE
 2. WASH BASIN TO FT 320 WASTE PIPE
 3. WC TO VERTICAL 1000 SOIL PIPE
 4. FT TO VERTICAL 1000 WASTE PIPE
 5. UT TO VERTICAL 1000 SOIL PIPE
 6. URINAL TO UT 400 SOIL PIPE

PLUMBING LEGEND

SYMBOL	DESCRIPTION
①	1000 SOIL & VENT PIPE
②	500 WASTE & VENT PIPE
③	750 ATYPICAL PIPE
④	COLD WATER SUPPLY (DWV) LINES
⑤	FLUSH WATER SUPPLY (DWV) (FWS)
⑥	COLD WATER RISER PIPE (CWR)
⑦	FLUSH WATER RISER PIPE (FWR)
⑧	1/2" CO. PVC SANITARY WATER PIPE (FOR BALCONY)
⑨	1/2" CO. PVC SANITARY WATER PIPE (FOR TERRACE)
⑩	FLOOR DRAIN
⑪	URINAL TRAP
⑫	FLOOR TRAP
⑬	CEILING PLUG
⑭	PRE-DRIP
⑮	BAH VALVE

DOOR WINDOW SCHEDULE FOR TOWER 2 & 3

NO.	TYPE	FINISH	GLASS	OPERATION	MARKING
1	GLASS	GLASS	GLASS	GLASS	GLASS
2	GLASS	GLASS	GLASS	GLASS	GLASS
3	GLASS	GLASS	GLASS	GLASS	GLASS
100	GLASS	GLASS	GLASS	GLASS	GLASS

Checked and based on the Public Health Department's approval letter No. 137/2021 dated 12/20/2021.

SUBMISSION DRAWING

CLIENT: [Name]
 PROJECT NO: [Number]
 DRAWING NO: [Number]

PROJECT TITLE: [Title]
 PROJECT LOCATION: [Location]
 PROJECT NO: [Number]

SERVICES CONSULTANT

NAME: [Name]
 ADDRESS: [Address]
 CONTACT: [Phone/Email]

NNC DESIGN INTERNATIONAL


NAME: [Name]
 ADDRESS: [Address]
 CONTACT: [Phone/Email]

RK & ASSOCIATES


NAME: [Name]
 ADDRESS: [Address]
 CONTACT: [Phone/Email]

ARCHITECT'S SIGNATURE: [Signature]
 OWNER'S SIGNATURE: [Signature]

DRAWING TITLE: [Title]
 DRAWING NO: [Number]
 SCALE: 1:100 @ A1
 DATE: DEC 2021

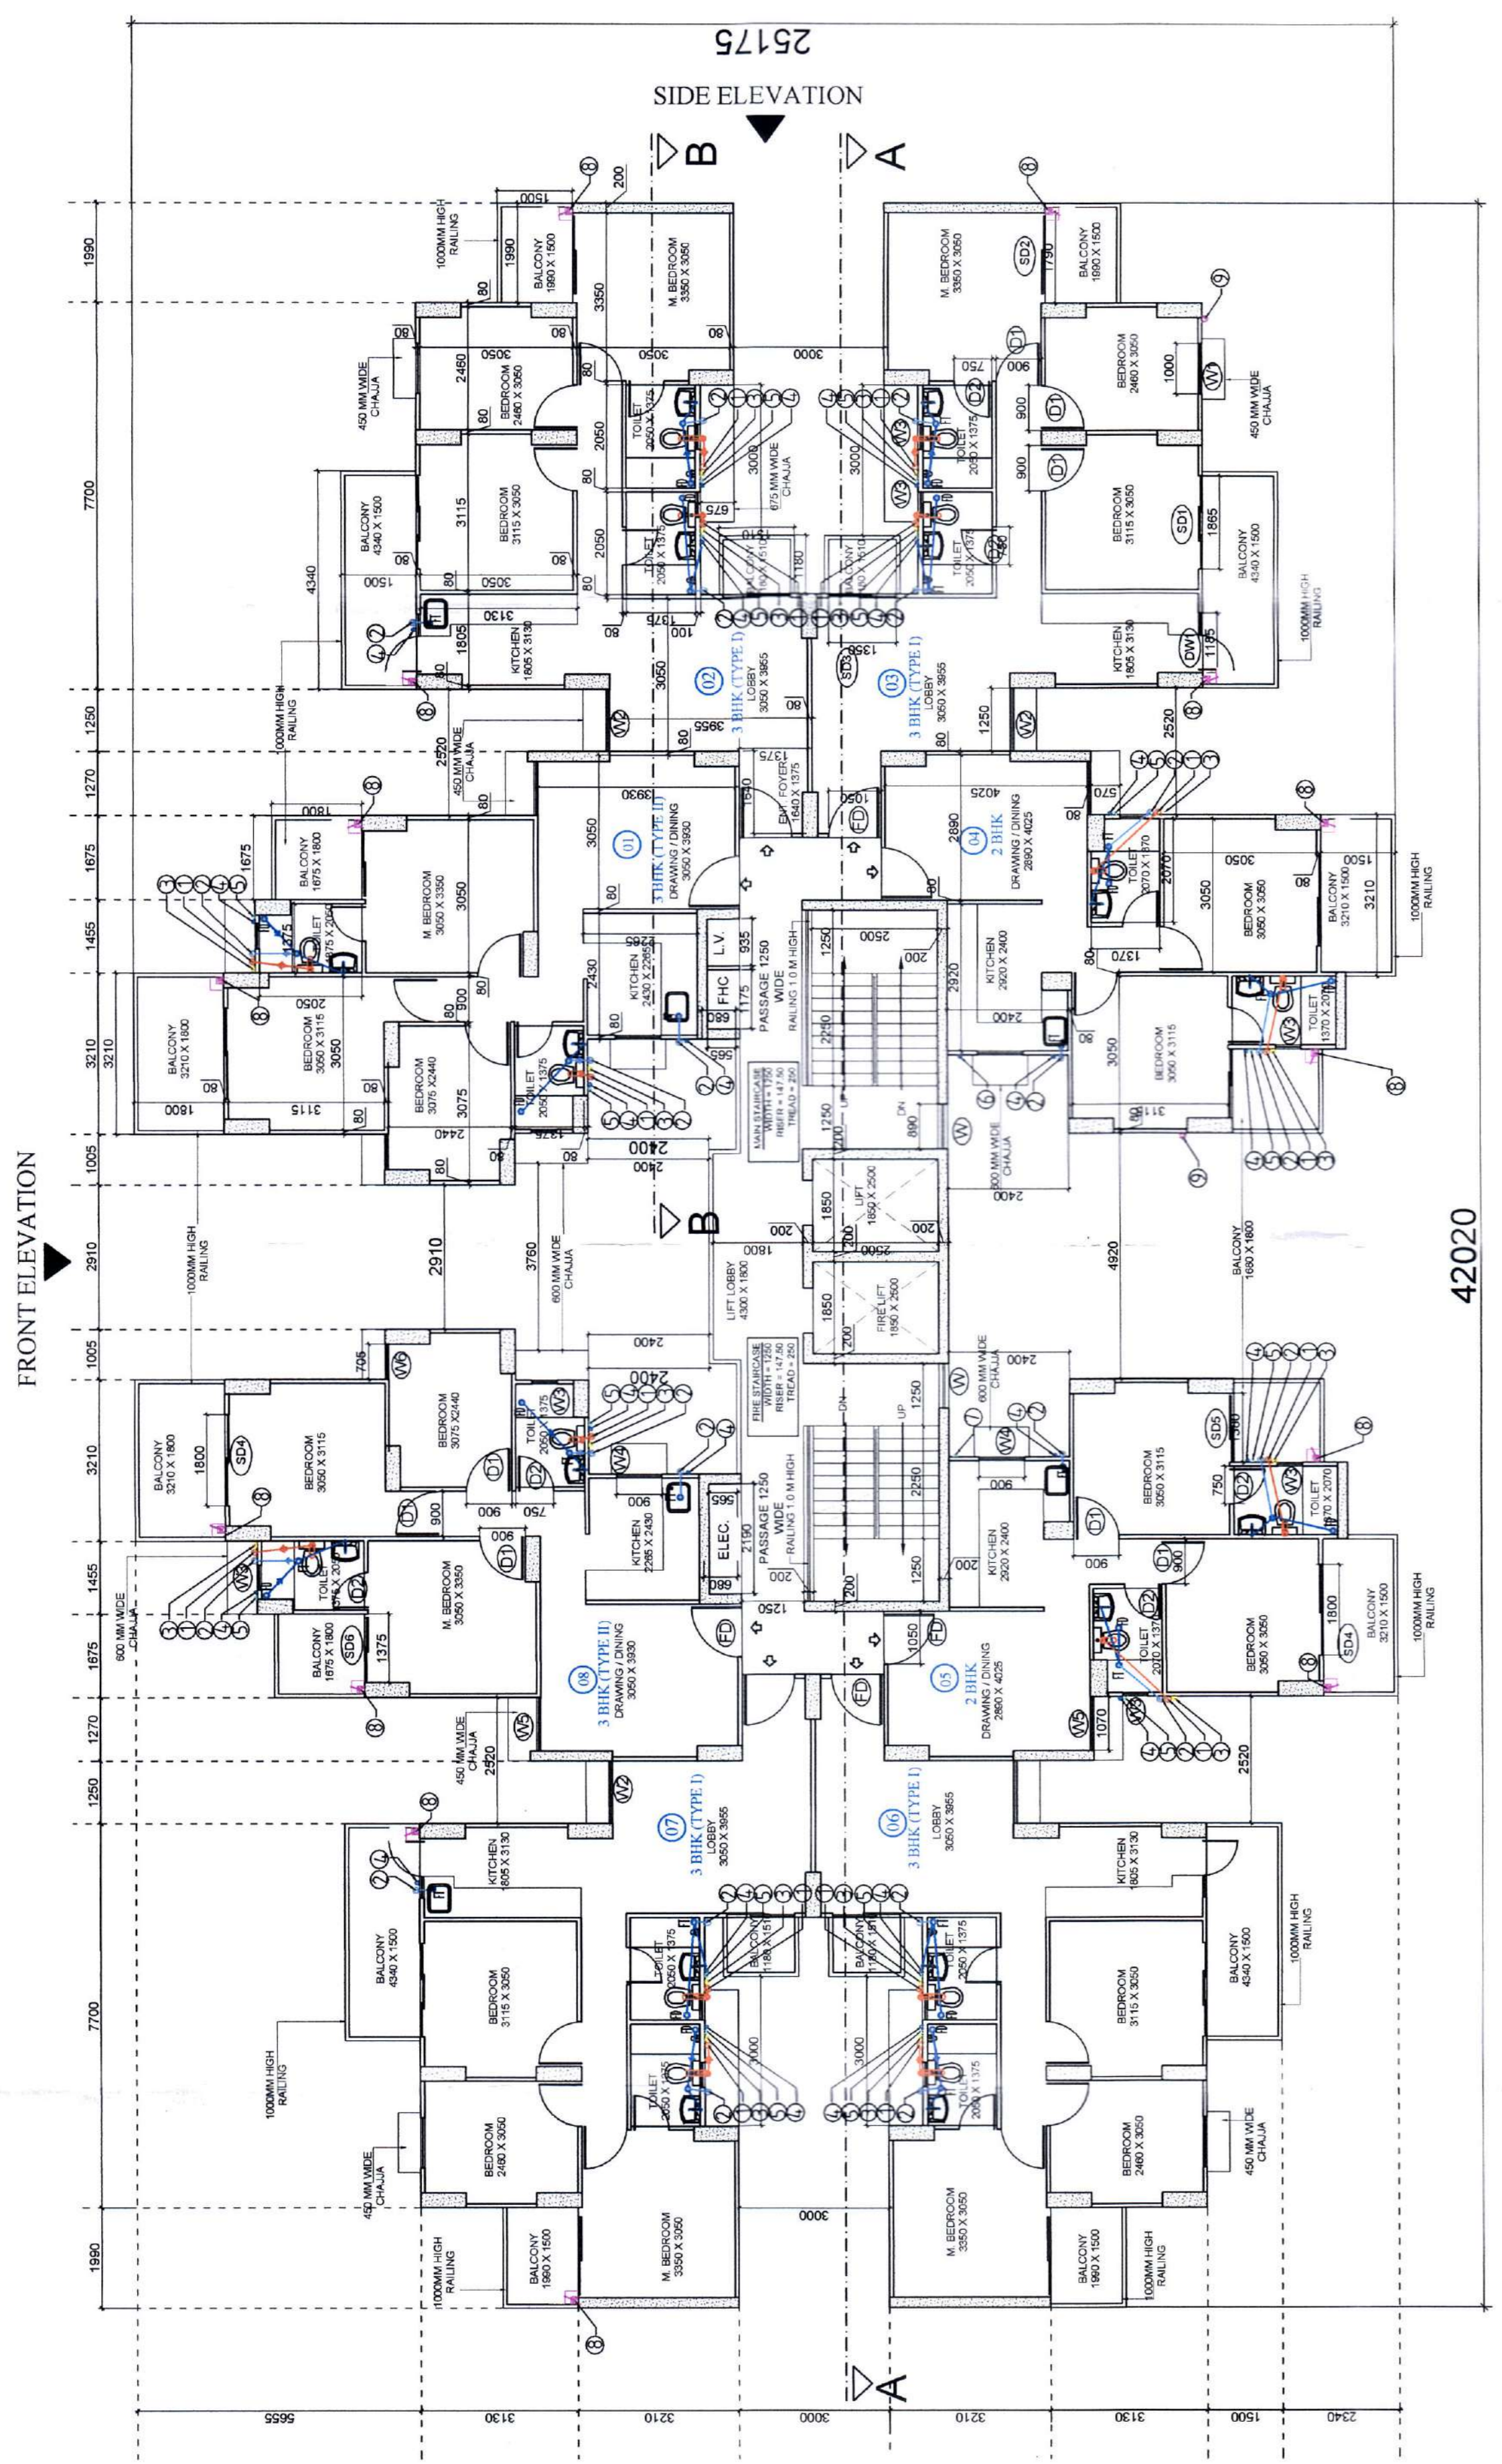


TYPICAL FLOOR PLAN (1st to 7th FLOOR)

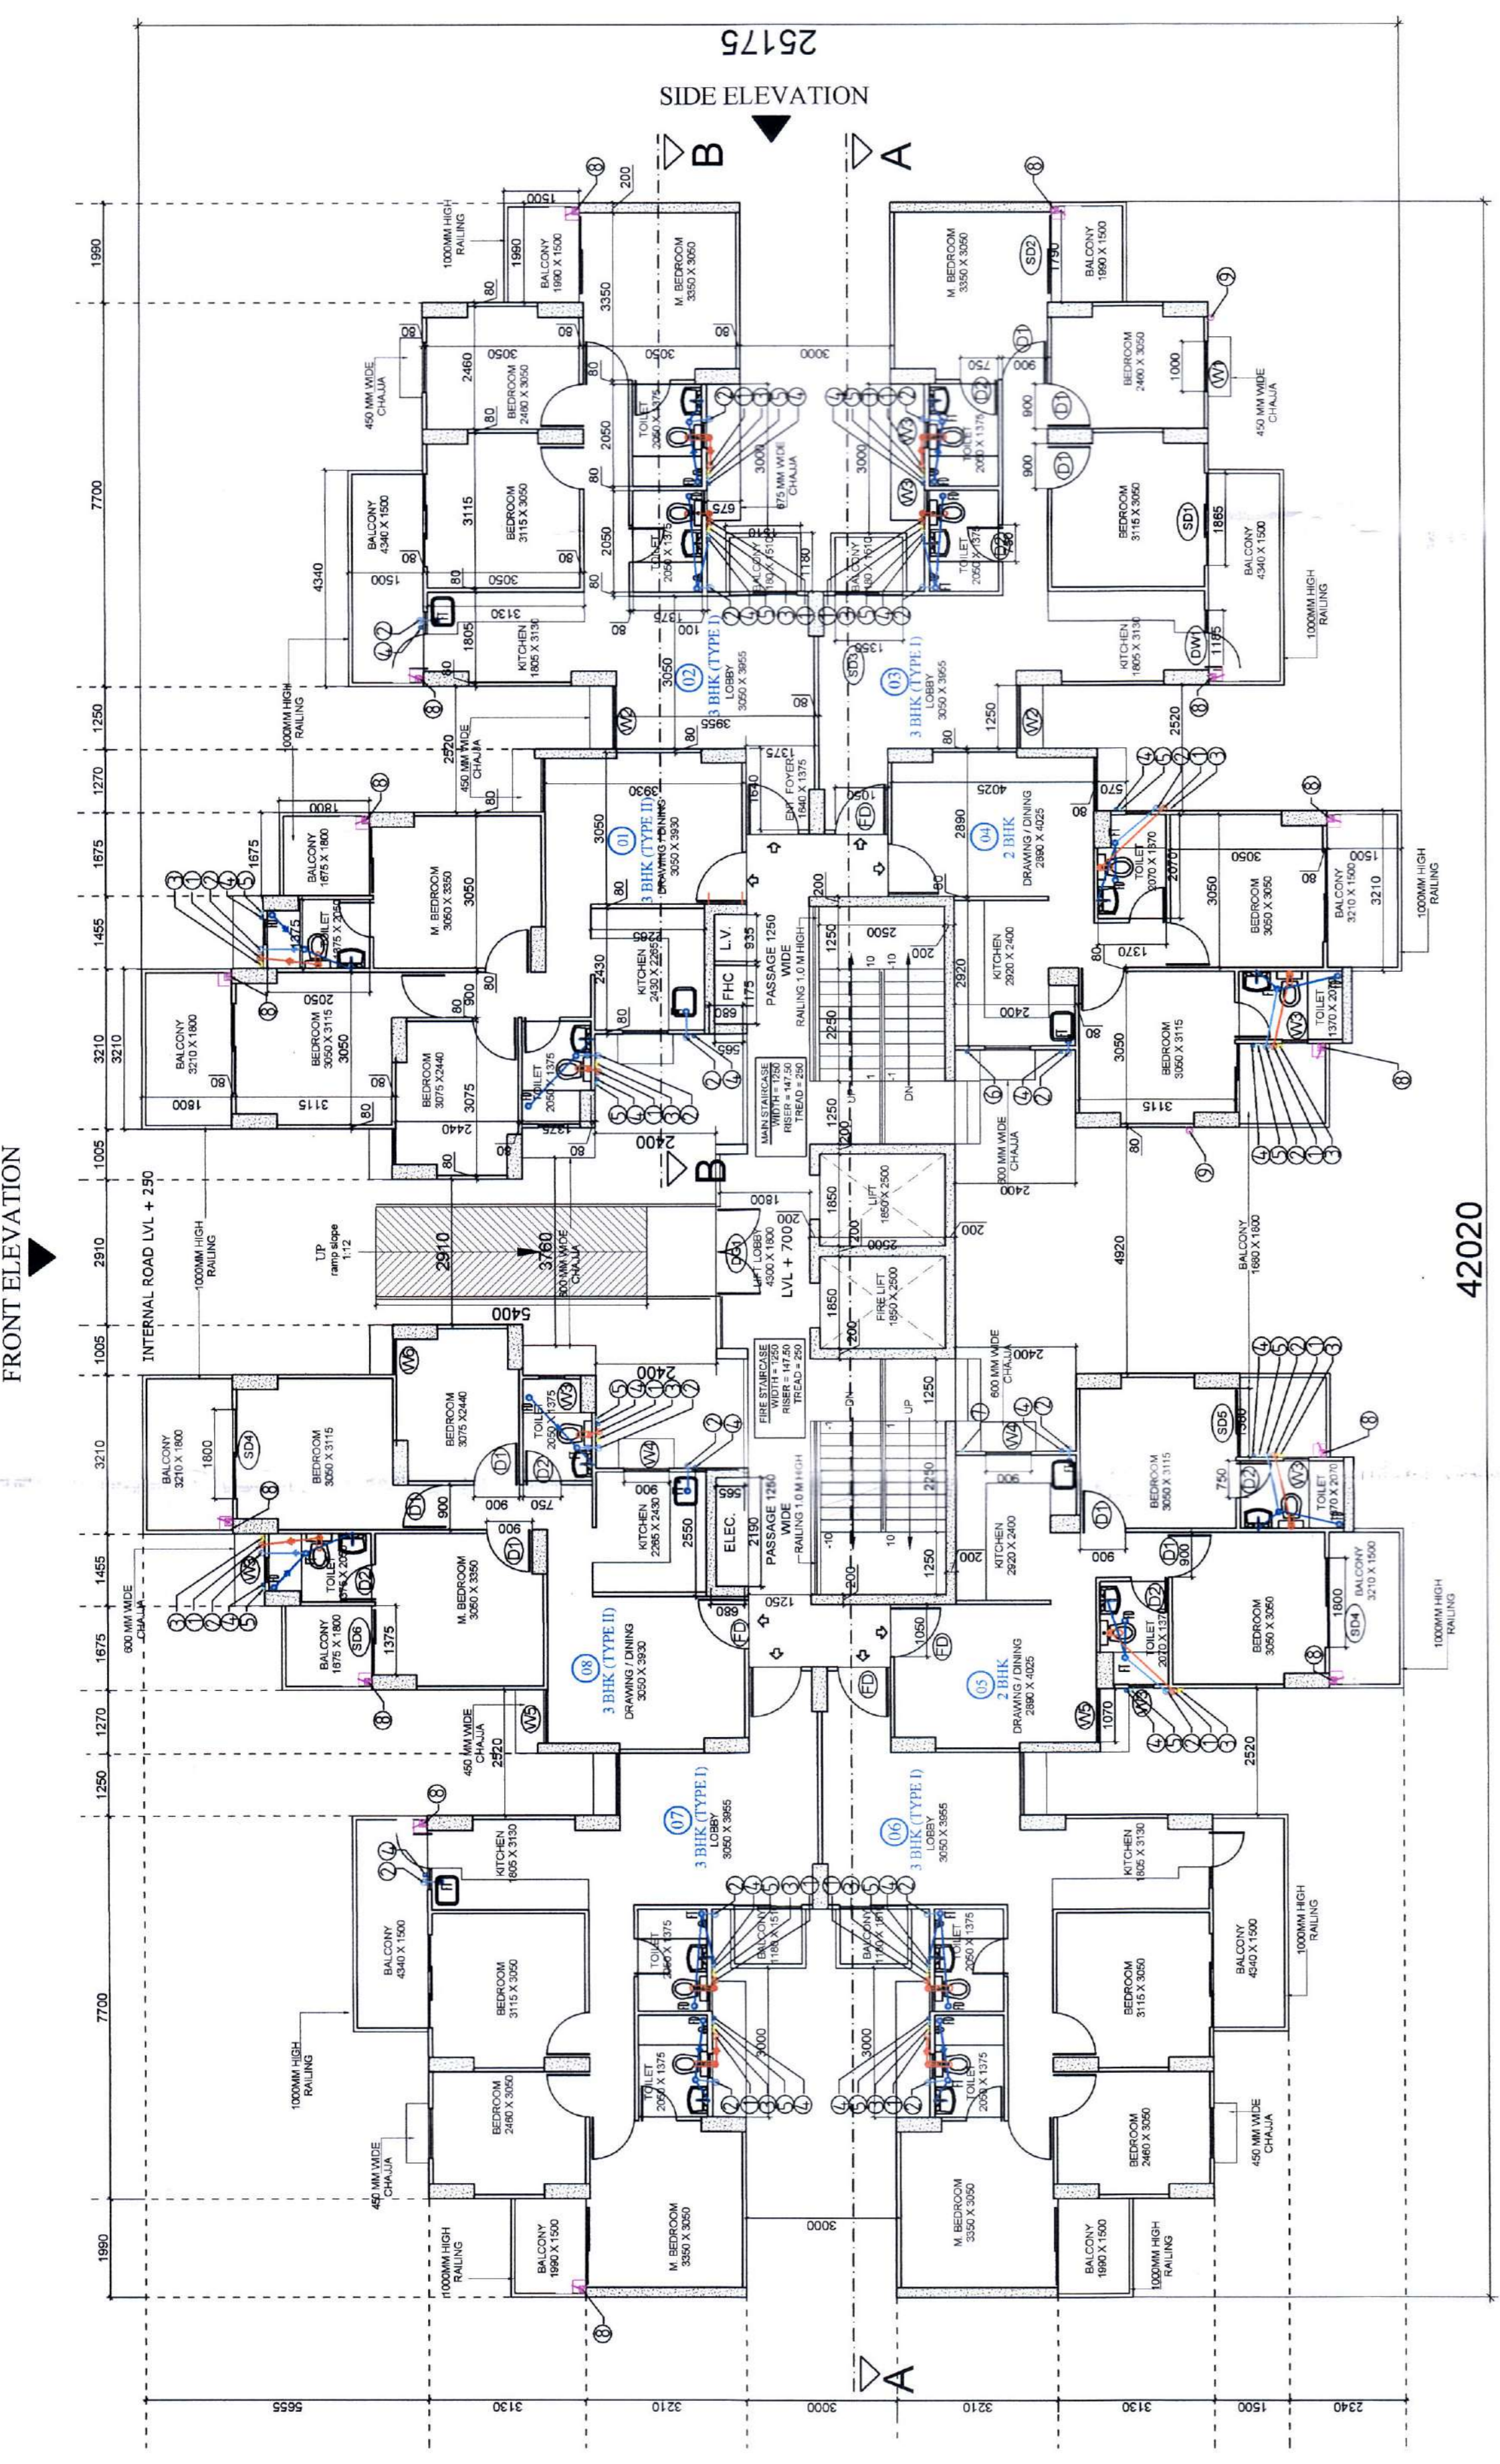

GROUND FLOOR PLAN



8th FLOOR PLAN

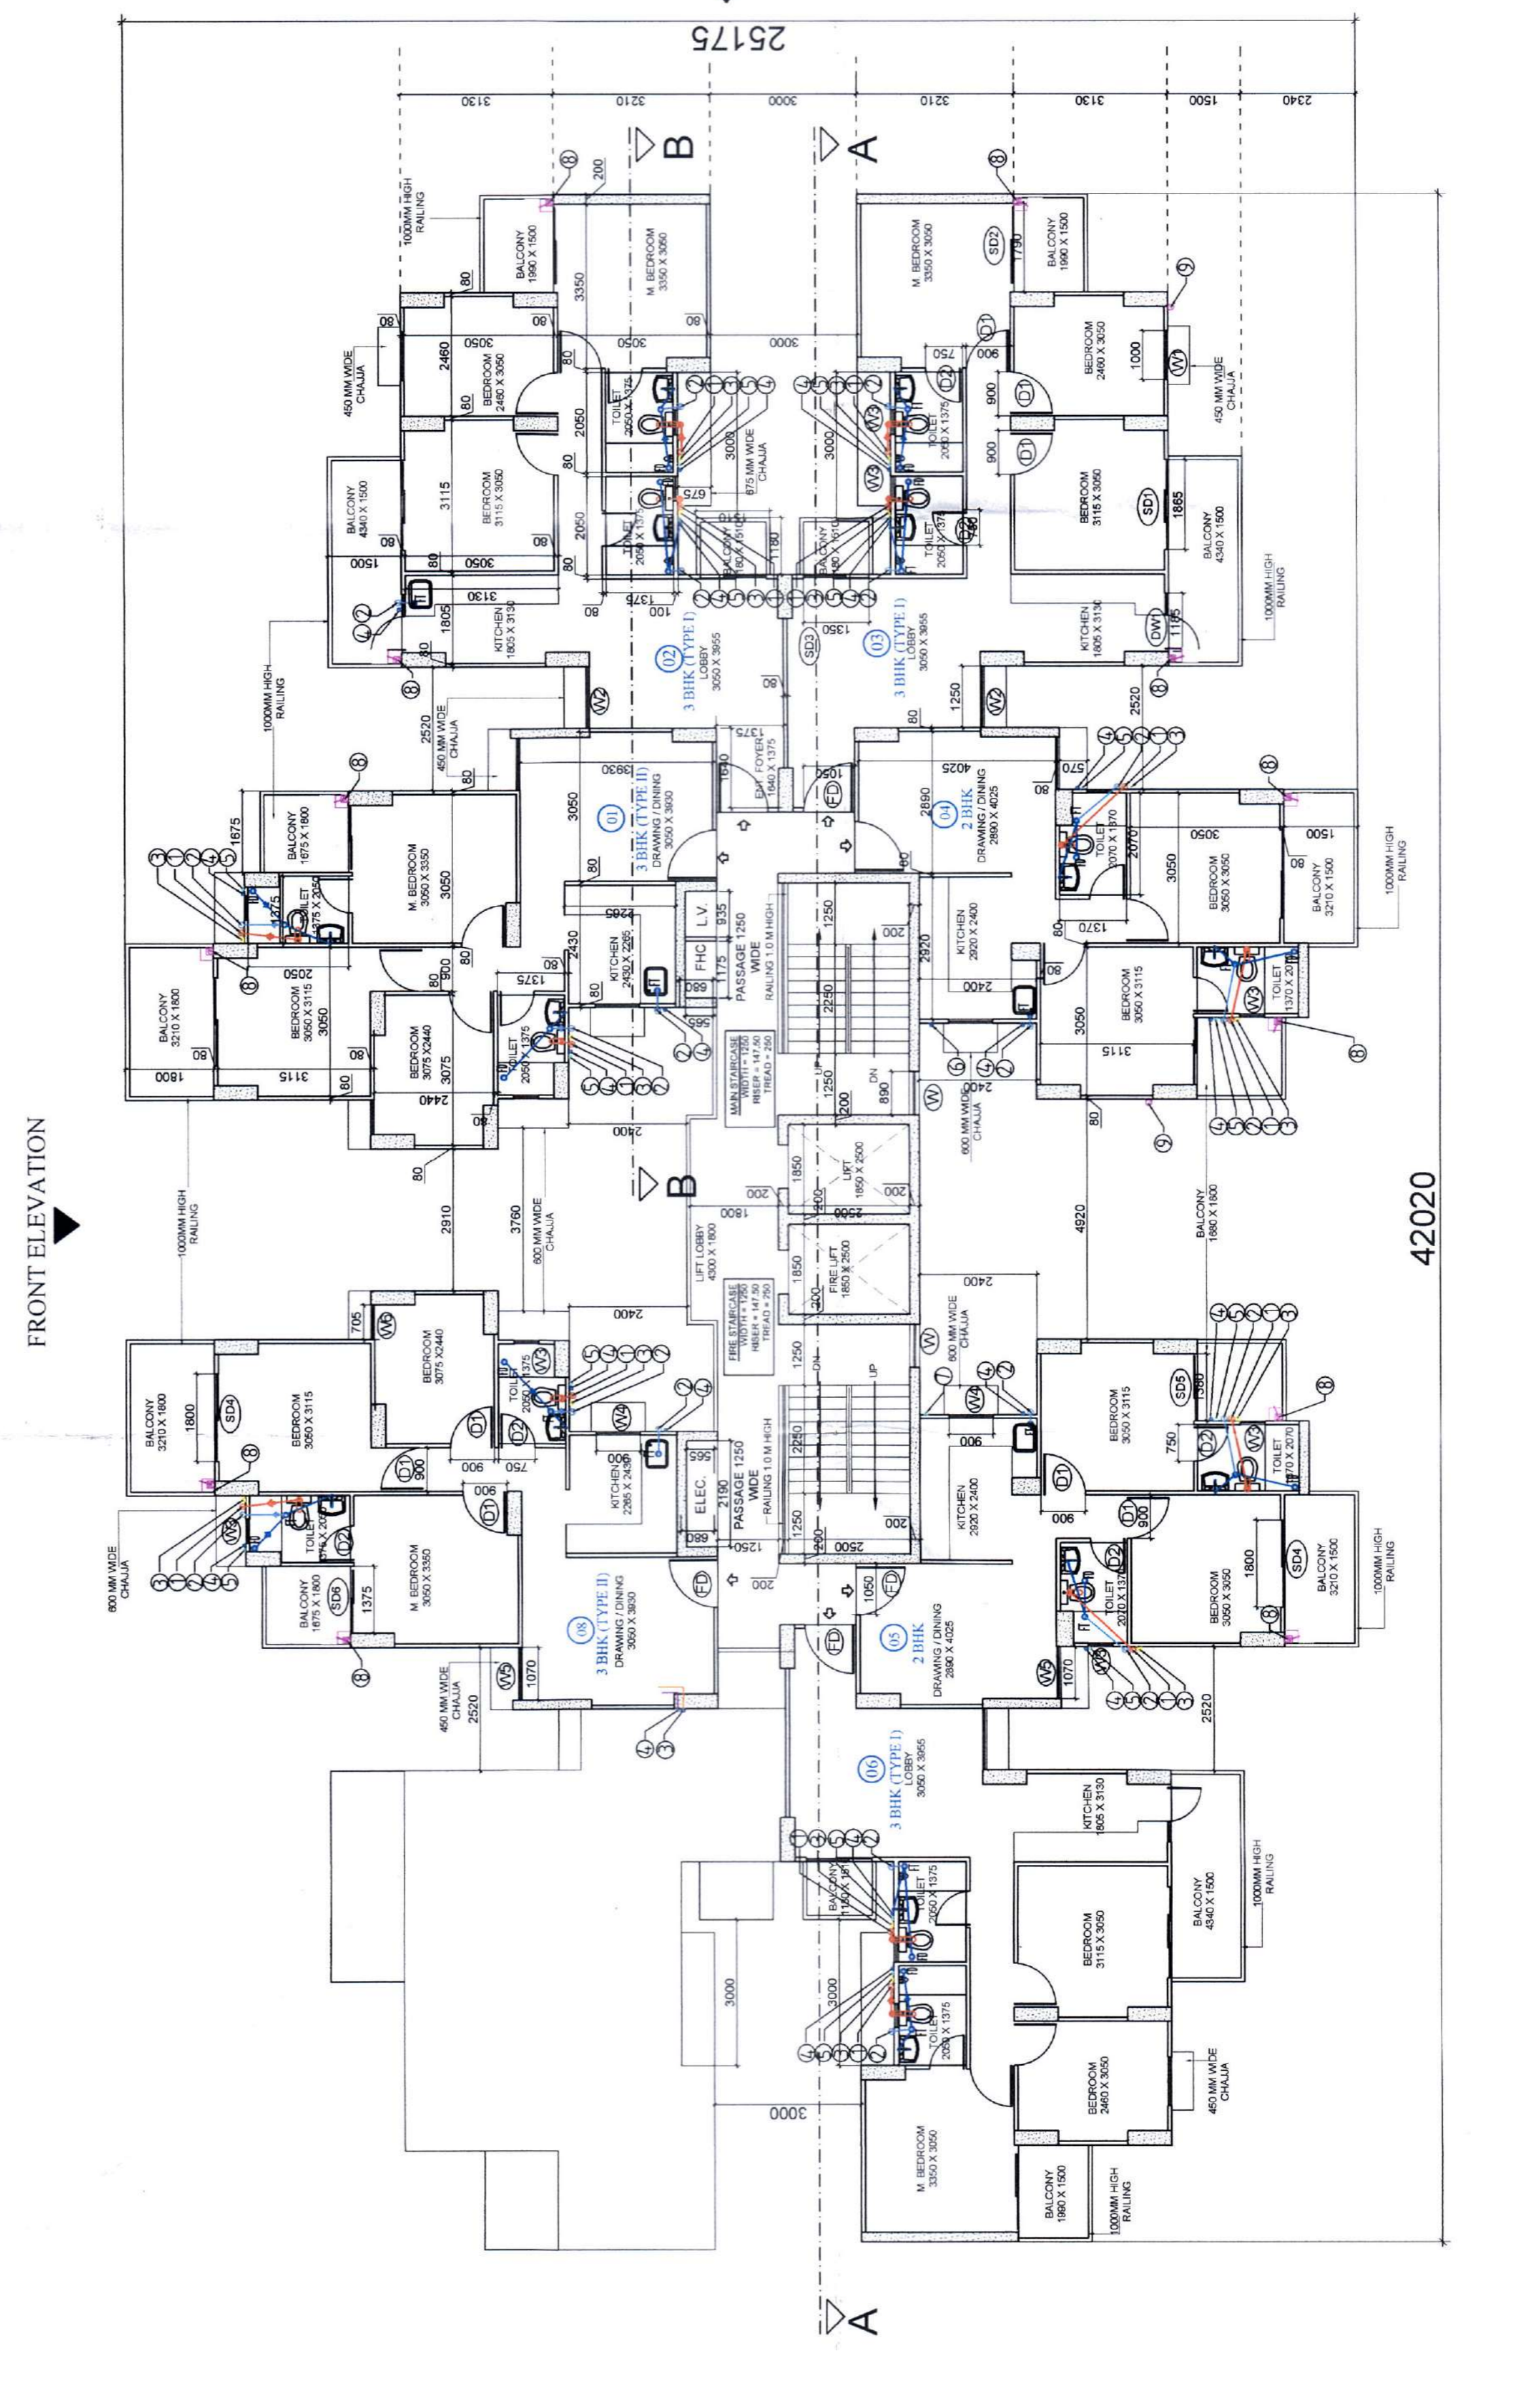

9th TO 14th FLOOR PLAN