



LEGEND:-	
SYM.	DESCRIPTION
	36W FL. WALL MOUNTED LED LIGHT FIXTURE
	36W HANGING LED LIGHT FIXTURE
	36W FL. CEILING MOUNTED LED LIGHT FIXTURE
	15W SURFACE MOUNTED LED FIXTURE
	9W SURFACE/RECESSED MOUNTED LED LIGHT FIXTURE
	22W SURFACE/RECESSED MOUNTED LED LIGHT FIXTURE
	9W LED BULK HEAD LIGHT
	5W LED MIRROR LIGHT
	EMERGENCY SYMBOL
	6AMP SWITCH BOARD EMERGENCY
	6AMP SWITCH BOARD LIGHT
	EXHAUST FAN
	6AM SOCKET OUTLET FOR EXHAUST FAN
	6/16A 3PIN SOCKET WITH SWITCH FOR HAND DRYER
	6/16A 6PIN SOCKET WITH SWITCH
	EL-LIGHT LOOPING
	EM-LIGHT LOOPING
	DISTRIBUTION BOARD


LEGEND:-		
	SMOKE DETECTOR	ON FALSE CEILING
	SPEAKER	ON FALSE CEILING
	MULTI SENSOR DETECTOR	ABOVE F.C.
	CCTV CAMERA	ON WALL
	WALL MOUNTED SPEAKER	ON WALL
	HOOTER WITH CONTROL MODULE	1800
	MANUAL CALL POINT	1250

S.NO.	EQUIPMENT	EARTHING DETAILS: PLATE, EARTHING	EARTHING CONDUCTOR IN EARTH PIT	CONNECTED TO EARTH PIT NOS.
1.	1/R-01	600X600X6mm (GI)	2 OF 50x6mm GI STRIP	EP01,EP02
2.	1/R-01	600X600X3mm (CU)	2 OF 50x6mm CU STRIP	EP03,EP04
3.	1/R-02	600X600X6mm (GI)	2 OF 50x6mm GI STRIP	EP05,EP06
4.	1/R-02	600X600X3mm (CU)	2 OF 50x6mm GI STRIP	EP07,EP08
5.	DG SET-01	600X600X6mm (GI)	2 OF 50x6mm GI STRIP	EP09,EP10
6.	DG SET-01	600X600X3mm (CU)	2 OF 50x6mm GI STRIP	EP11,EP12
7.	DG SET-02	600X600X6mm (GI)	2 OF 50x6mm GI STRIP	EP13,EP14
8.	DG SET-02	600X600X3mm (CU)	2 OF 50x6mm GI STRIP	EP15,EP16
9.	DG SET-03	600X600X6mm (GI)	2 OF 50x6mm GI STRIP	EP17,EP18
10.	DG SET-03	600X600X3mm (CU)	2 OF 50x6mm GI STRIP	EP19,EP20
11.	SERVER ROOM	600X600X3mm (CU)	2 OF 25x6mm GI STRIP	EP21,EP22
12.	LIFT-1,2	600X600X6mm (GI)	2 OF 25x6mm GI STRIP	EP23,EP24
13.	LIFT-3,4	600X600X6mm (GI)	2 OF 25x6mm GI STRIP	EP25,EP26
14.	MAIN LT PANEL	600X600X6mm (GI)	2 OF 50x6mm GI STRIP	EP27,EP28
15.	UPS-1	600X600X6mm (GI)	2 OF 25x6mm GI STRIP	EP29,EP30
16.	UPS-1	600X600X3mm (CU)	2 OF 25x6mm GI STRIP	EP31,EP32
17.	UPS-2	600X600X3mm (CU)	2 OF 25x6mm GI STRIP	EP33,EP34
18.	UPS-2	600X600X6mm (GI)	2 OF 25x6mm GI STRIP	EP35,EP36
19.	LIFT-5,6	600X600X6mm (GI)	2 OF 25x6mm GI STRIP	EP37,EP38
20.	LIFT-7,8	600X600X6mm (GI)	2 OF 25x6mm GI STRIP	EP39,EP40
21.	LIFT-9	600X600X6mm (GI)	2 OF 25x6mm GI STRIP	EP41,EP42
22.	HT PANEL	600X600X6mm (GI)	2 OF 25x6mm GI STRIP	EP43,EP44

LEGEND:-	
	EARTH ELECTRODE (600x600x3.15mm Cu Plate)
	EARTH ELECTRODE (600x600x6mm GI Plate)

LEGEND:-	
DESCRIPTION	
	EL-MAIN HOLE
	HUME PIPE RCC

SYM.	DESCRIPTION
	GATE LIGHT 35 LED
	POLE LIGHT (7.0M Height) SINGLE ARM (40W METAL HALIDE LAMP)
	SOLAR LIGHT (6.0M Height) SINGLE ARM (40W METAL HALIDE LAMP)

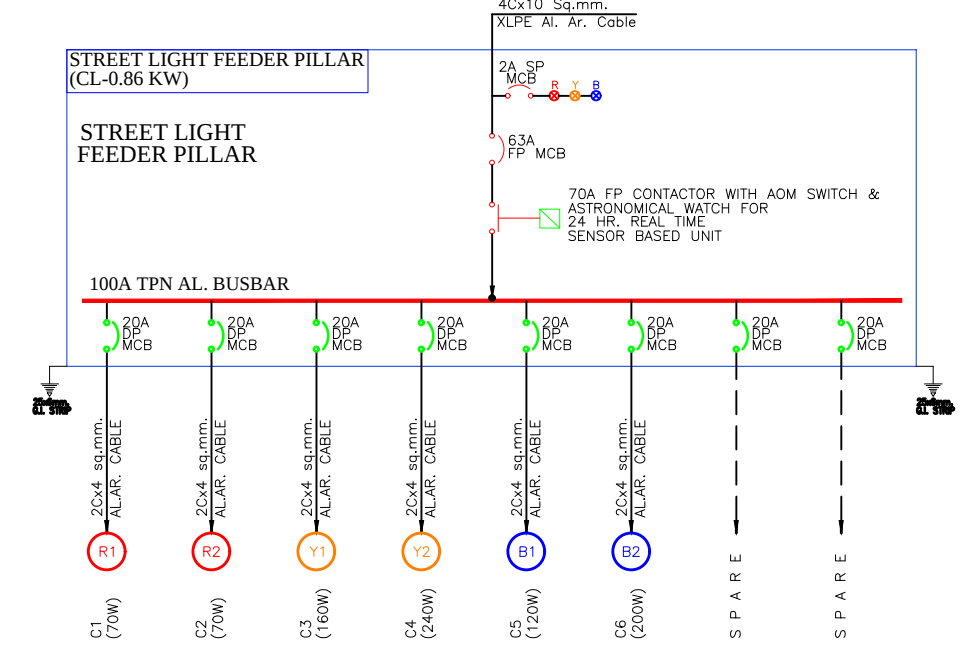

NOTES:-

- ALL DIMENSIONS ARE IN MILLIMETERS
- THIS DRAWING IS A COPYRIGHT AND PROPERTY OF THE ARCHITECT. IS NOT TO BE PRODUCED, COPIED, HANDED OVER TO THIRD PARTY OR USED FOR ANY OTHER PURPOSE OTHER THAN FOR WHICH IT IS INTENDED.
- ALL DIMENSIONS SHALL BE VERIFIED ON SITE PRIOR TO START OF WORK ANY DISCREPANCY SHALL BE BROUGHT TO THE NOTICE OF THE ARCHITECT.
- THE CONSTRUCTION MANAGER/CONTRACTOR MUST CHECK ALL DIMENSIONS AND DETAILS AND BE RESPONSIBLE FOR THE SAME. ANY DISCREPANCY SHALL BE BROUGHT TO THE NOTICE OF THE ARCHITECT.
- THIS DRAWING IS TO BE READ AND NOT SCALED.
- THIS DRAWING SHALL BE READ IN CONJUNCTION WITH ALL RELEVANT ARCHITECTURAL, STRUCTURAL AND SERVICES DRAWINGS. ANY DISCREPANCY NOTICED SHALL BE BROUGHT TO THE ATTENTION OF THE CONSULTANTS WITHIN 7 WORKING DAYS OF RECEIPT OF THIS DRAWINGS, BUT ALWAYS PRIOR TO PROCUREMENT / EXECUTION OF WORKS
- DRAWING APPROVAL IS FOR THE CONFIRMITY WITH OUTLINE DESIGN INTENT ONLY AND DOES NOT RELIEVE THE PROJECT MANAGERS / CONTRACTORS / SUB-CONTRACTORS FROM FULL RESPONSIBILITY FOR THE ACCURACY, INTEGRATION AND FITNESS FOR PURPOSE OF DESIGN
- REFR OPENING SCHEDULE FOR MASONRY OPENING.

KEY PLAN :

R5	ASIF	20.05.21	AS/PER ARCHITECT
R4	ASIF	15.04.21	AS/PER ARCHITECT
R3	ASIF	21.11.20	AS/PER ARCHITECT
R2	ASIF	02.09.19	AS/PER ARCHITECT
R1	ASIF	24.07.19	AS/PER ARCHITECT
NO.	BY	DATE	DESCRIPTION

REVISION

LANDSCAPE :

MEP SERVICES :
WAC
MEP Consultants & Project Managers
B-77 & 78, Sector-6, Noida, UP-201301
Ph.: 0120-4504693, E-mail: wac@wacmep.com

STRUCTURE :
LKT Engineering Consultants Ltd.
10/14, Subhash Nagar, New Delhi - 27
TEL : 011 - 45565818
Email :- info@lktengineering.com

ARCHITECT :
JPS DESIGN STUDIO
Plot No. N-8 Basement Floor
Panchsheel Park, New Delhi-17
TEL :- 01141410230,
Email :- jps@jpsdesignstudios.com

CLIENT :
FRENCH BUILD MART PVT. LTD.

JOB TITLE :
**Proposed Commercial Building
at Sector-66, Gurugram**

GOOD FOR CONSTRUCTION

DRAWING TITLE :
**EL-LIGHT & POWER LAYOUT
(GROUND FLOOR)**

SCALE : 1 : 250	DATE : 20.05.2021
DEALT : ASIF	CHECKED : ATHAR
DRAWING NO : WAC-/SEC-66/EL-01	REV NO. R5