

DD-HQ Member B.P.C.

PA

ATP


Checked and found ok for Public Health (Internal) Service only subject to comments in forwarding letter No. PCE(HQ) dated 09/08/21 145643

Additional Chief Engineer (HQ) HSVP, Panchajanya


DINESH KUMAR SD (HQ)

This is a "PROVISIONAL APPROVAL BUILDING PLAN" only for purpose of issuing objection from the general public. Directorate of Town and Country Planning, Haryana, Chandigarh


DOOR/WINDOW SCHEDULE					
SN.	Type	Width (mm)	Cill (mm)	Lintel (mm)	Height (mm)
1	D1	100	±00	+230 (BOB)	2300
2	D2	80	+00	+210	2100
3	D3	70	+00	+210	2100
4	V1	150	+1350	+210	750
5	DW1	1545	±00	+230 (BOB)	2300
6	DW2	1510	±00	+230 (BOB)	2300
7	DW3	1505	±00	+230 (BOB)	2300
8	DW4	150	±00	+230 (BOB)	2300
9	W1	100	±1000	+230 (BOB)	1300
10	W3	1505	±1000	+230 (BOB)	1300
11	FD1	150	±100	+230 (BOB)	2200
12	FD1	150	±100	+230 (BOB)	2200

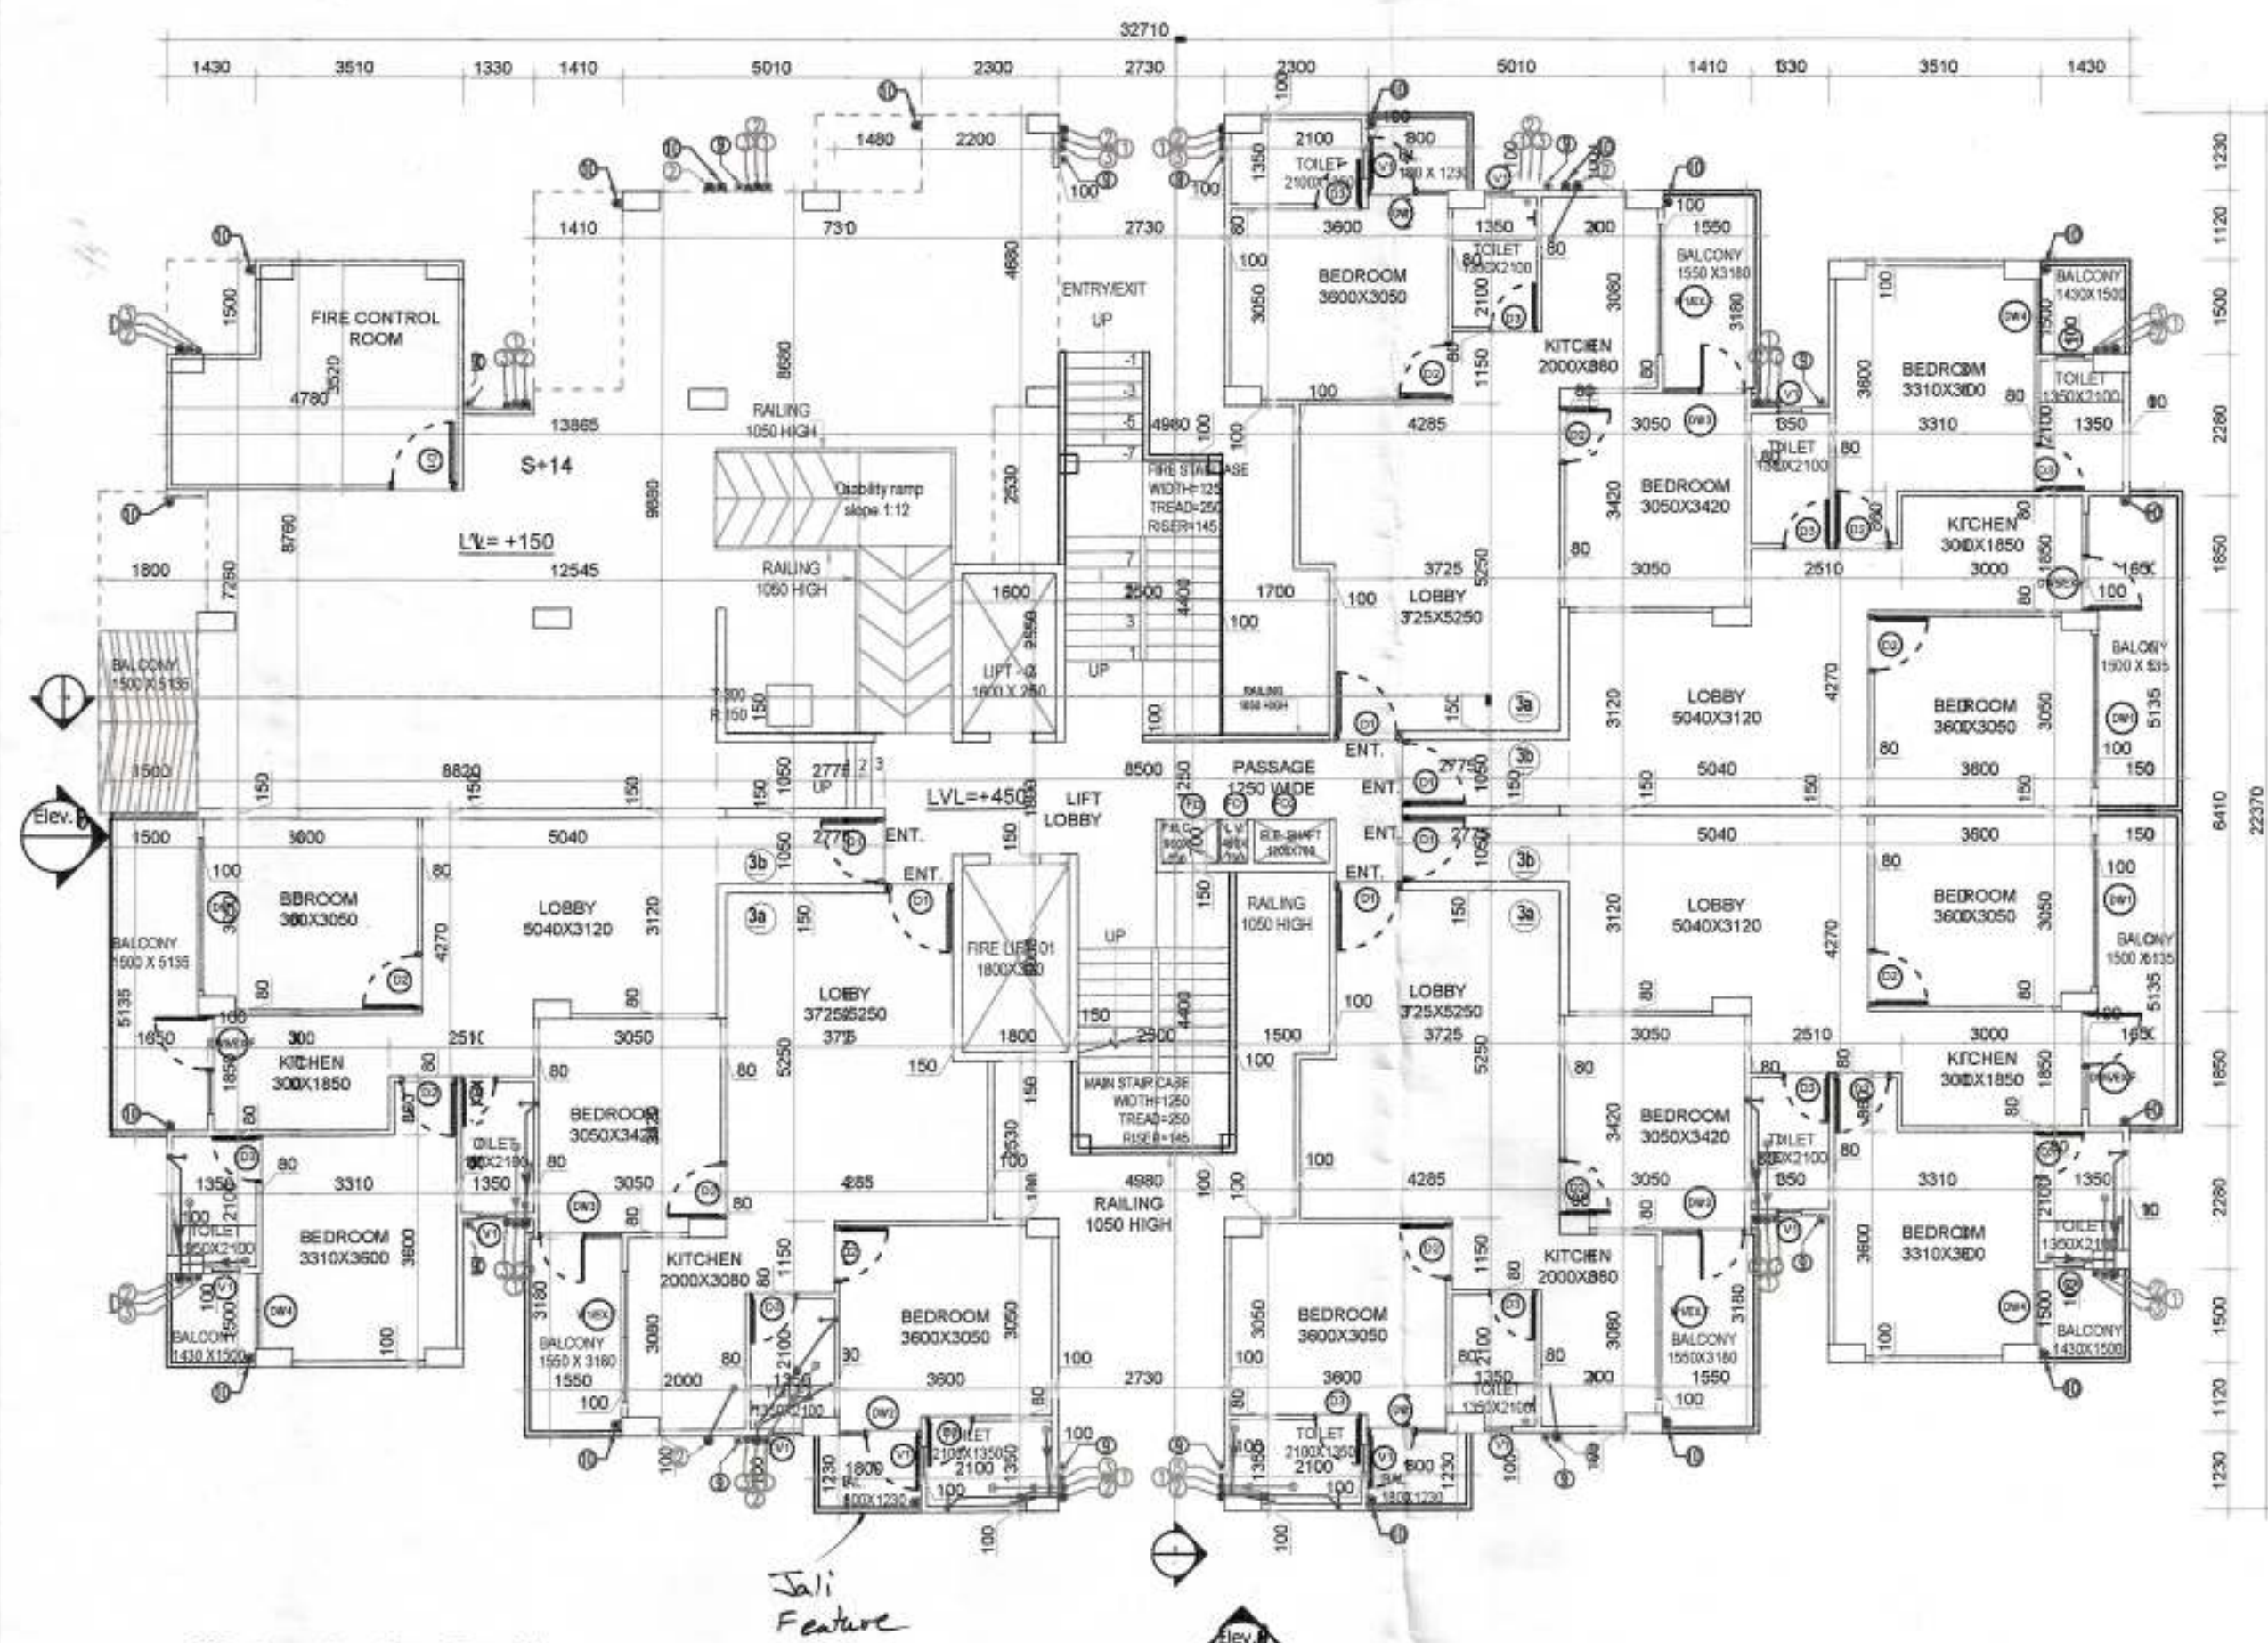

Grand floor Plan - Tower C1
TOVER C2 IS MIRROR OF TOWER C1

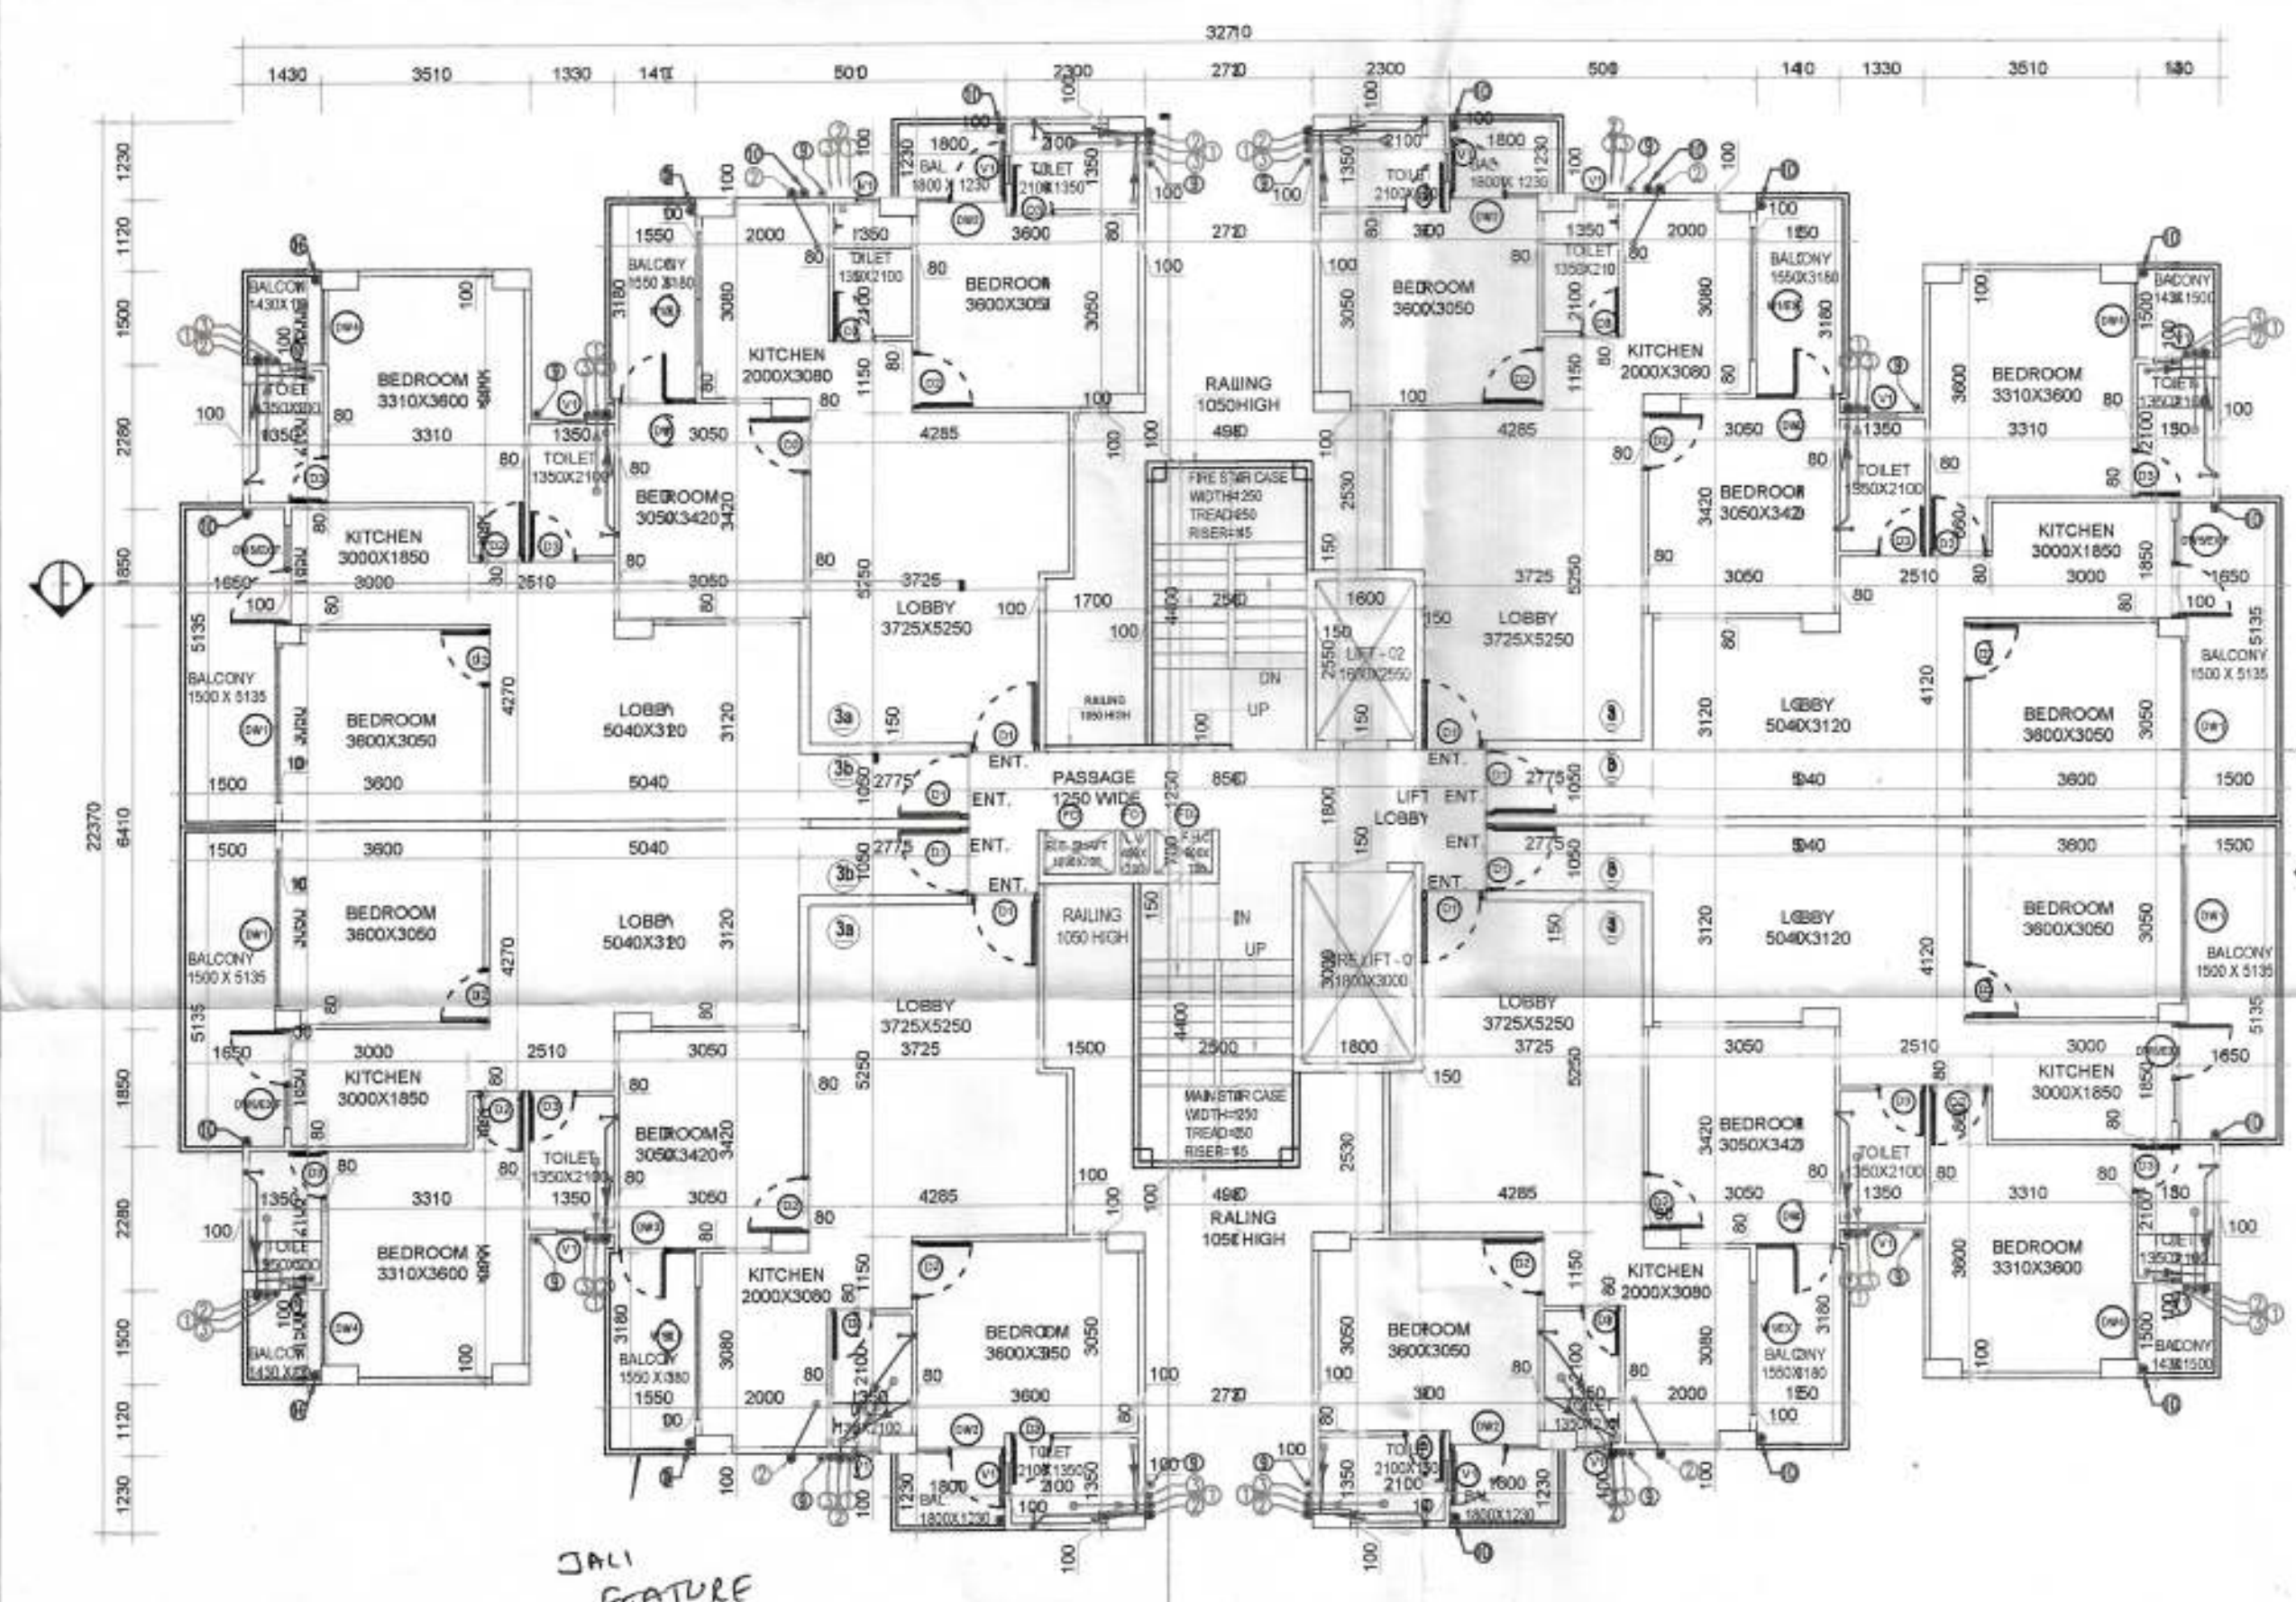

1st to 14th Floor- Tower C1, C2
TOVER C2 IS MIRROR OF TOWER C1

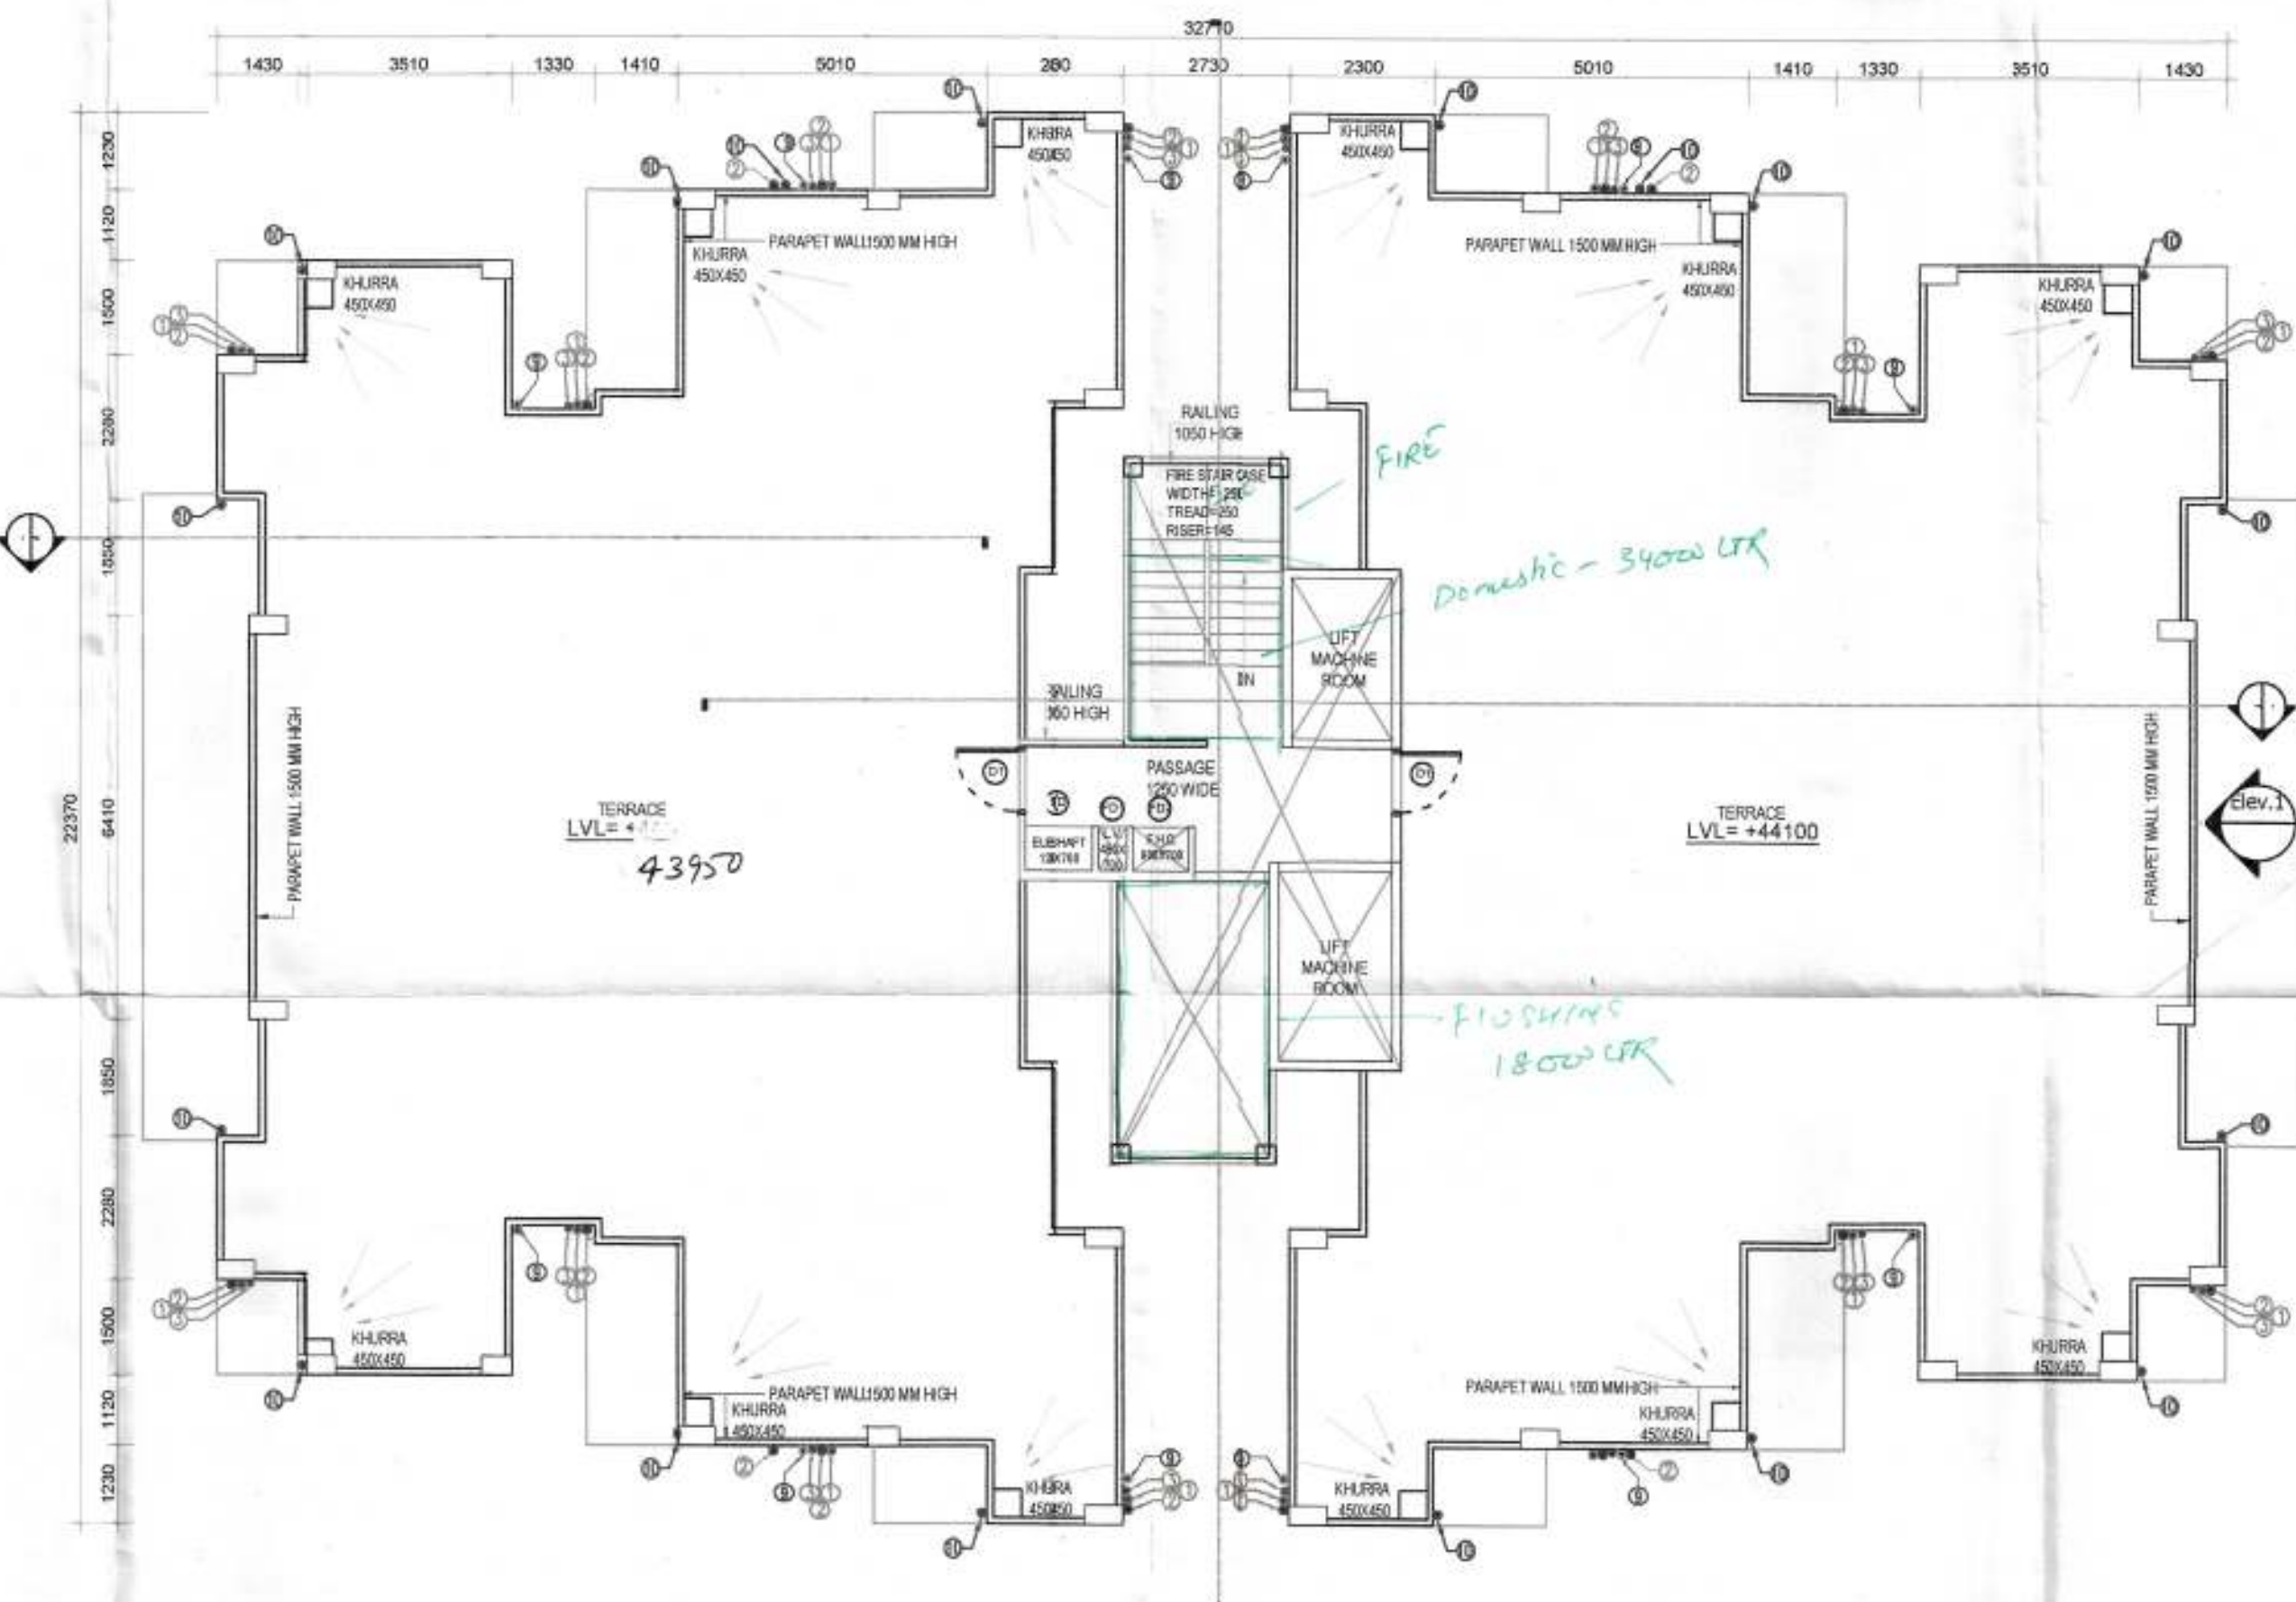

Terrace Floor- Tower C1, C2
TOVER C2 IS MIRROR OF TOWER C1

LEGEND	
①	110 OD SWR PVC SOLI & VENT PIPE
②	110 OD SWR PVC WASTE & VENT PIPE
③	110 OD SWR PVC ANTI-SYPHONIC PIPE
④	50# CWS RISER TO O.H.T. FILLING TANK
⑤	50# FWS RISER TO O.H.T. FILLING TANK
⑥	DOMESTIC WATER SUPPLY DN. TAKE PIPE
⑦	FLUSHING WATER SUPPLY DN. TAKE PIPE
⑧	110 OD uPVC RAIN WATER PIPE (TERRACE)
⑨	110 OD uPVC RAIN WATER PIPE (BALCONY)
LEGEND:-	
☑	FIRE HOSE CABINET
☑	9 Ltr WATER GAS PRESSURE TYPE FIRE EXTINGUISHER
☑	4.5 kg CO2 TYPE FIRE EXTINGUISHER
☑	BUTTERFLY VALVE SLUCE VALVE
NOTE:-	
EACH FIRE HOSE CABINET SHALL CONSIST OF	
1 No. - GUNMETAL SINGLE HEADED HYDRANT VALVE (63mm).	
2 Nos. - FIRE HOSES 63mm 15M LONG WITH ACCESSORIES.	
1 No. - SHORT BRANCH	
1 No. - FIRST AID HOSE REEL	
2 Nos. - FIRE EXTINGUISHERS	
1 No. - FIRE MAN'S AXE.	

PROJECT TITLE
ADDITIONAL AFFORDABLE GROUP HOUSING COLONY FOR AN ADDITIONAL AREA MEASURING 2.8375 ACRES IN THE AFFORDABLE GROUP HOUSING COLONY MEASURING 3.8 ACRES LICENSE NO.30 OF 2018 DATED 28.02.2019, THEREBY MAKING THE TOTAL SITE AREA 7.3375 ACRES IN SECTOR-90, GURUGRAM BEING DEVELOPED BY MRG WORLD LLP IN COLLABORATION WITH S.D. INFRADEVELOPERS PVT.LTD.

OWNER'S SIGNATURE
MRG WORLD LLP

ARCHITECT'S SIGNATURE
CA/2018/9/170

DRAWING TITLE
LAYOUT
TOWER C1 & C2
TYPE 3a+3b (2 BHK)

ARCHITECTS
MRG DESIGN TEAM
MRG World
Vastu Tower, Golf Course Road
Gurgaon

DATE	JUNE 2021	DWG. NO.	S - 103
SCALE	1:110		

PLEASE NOTE : TOWER C2 IS MIRROR OF TOWER C1