




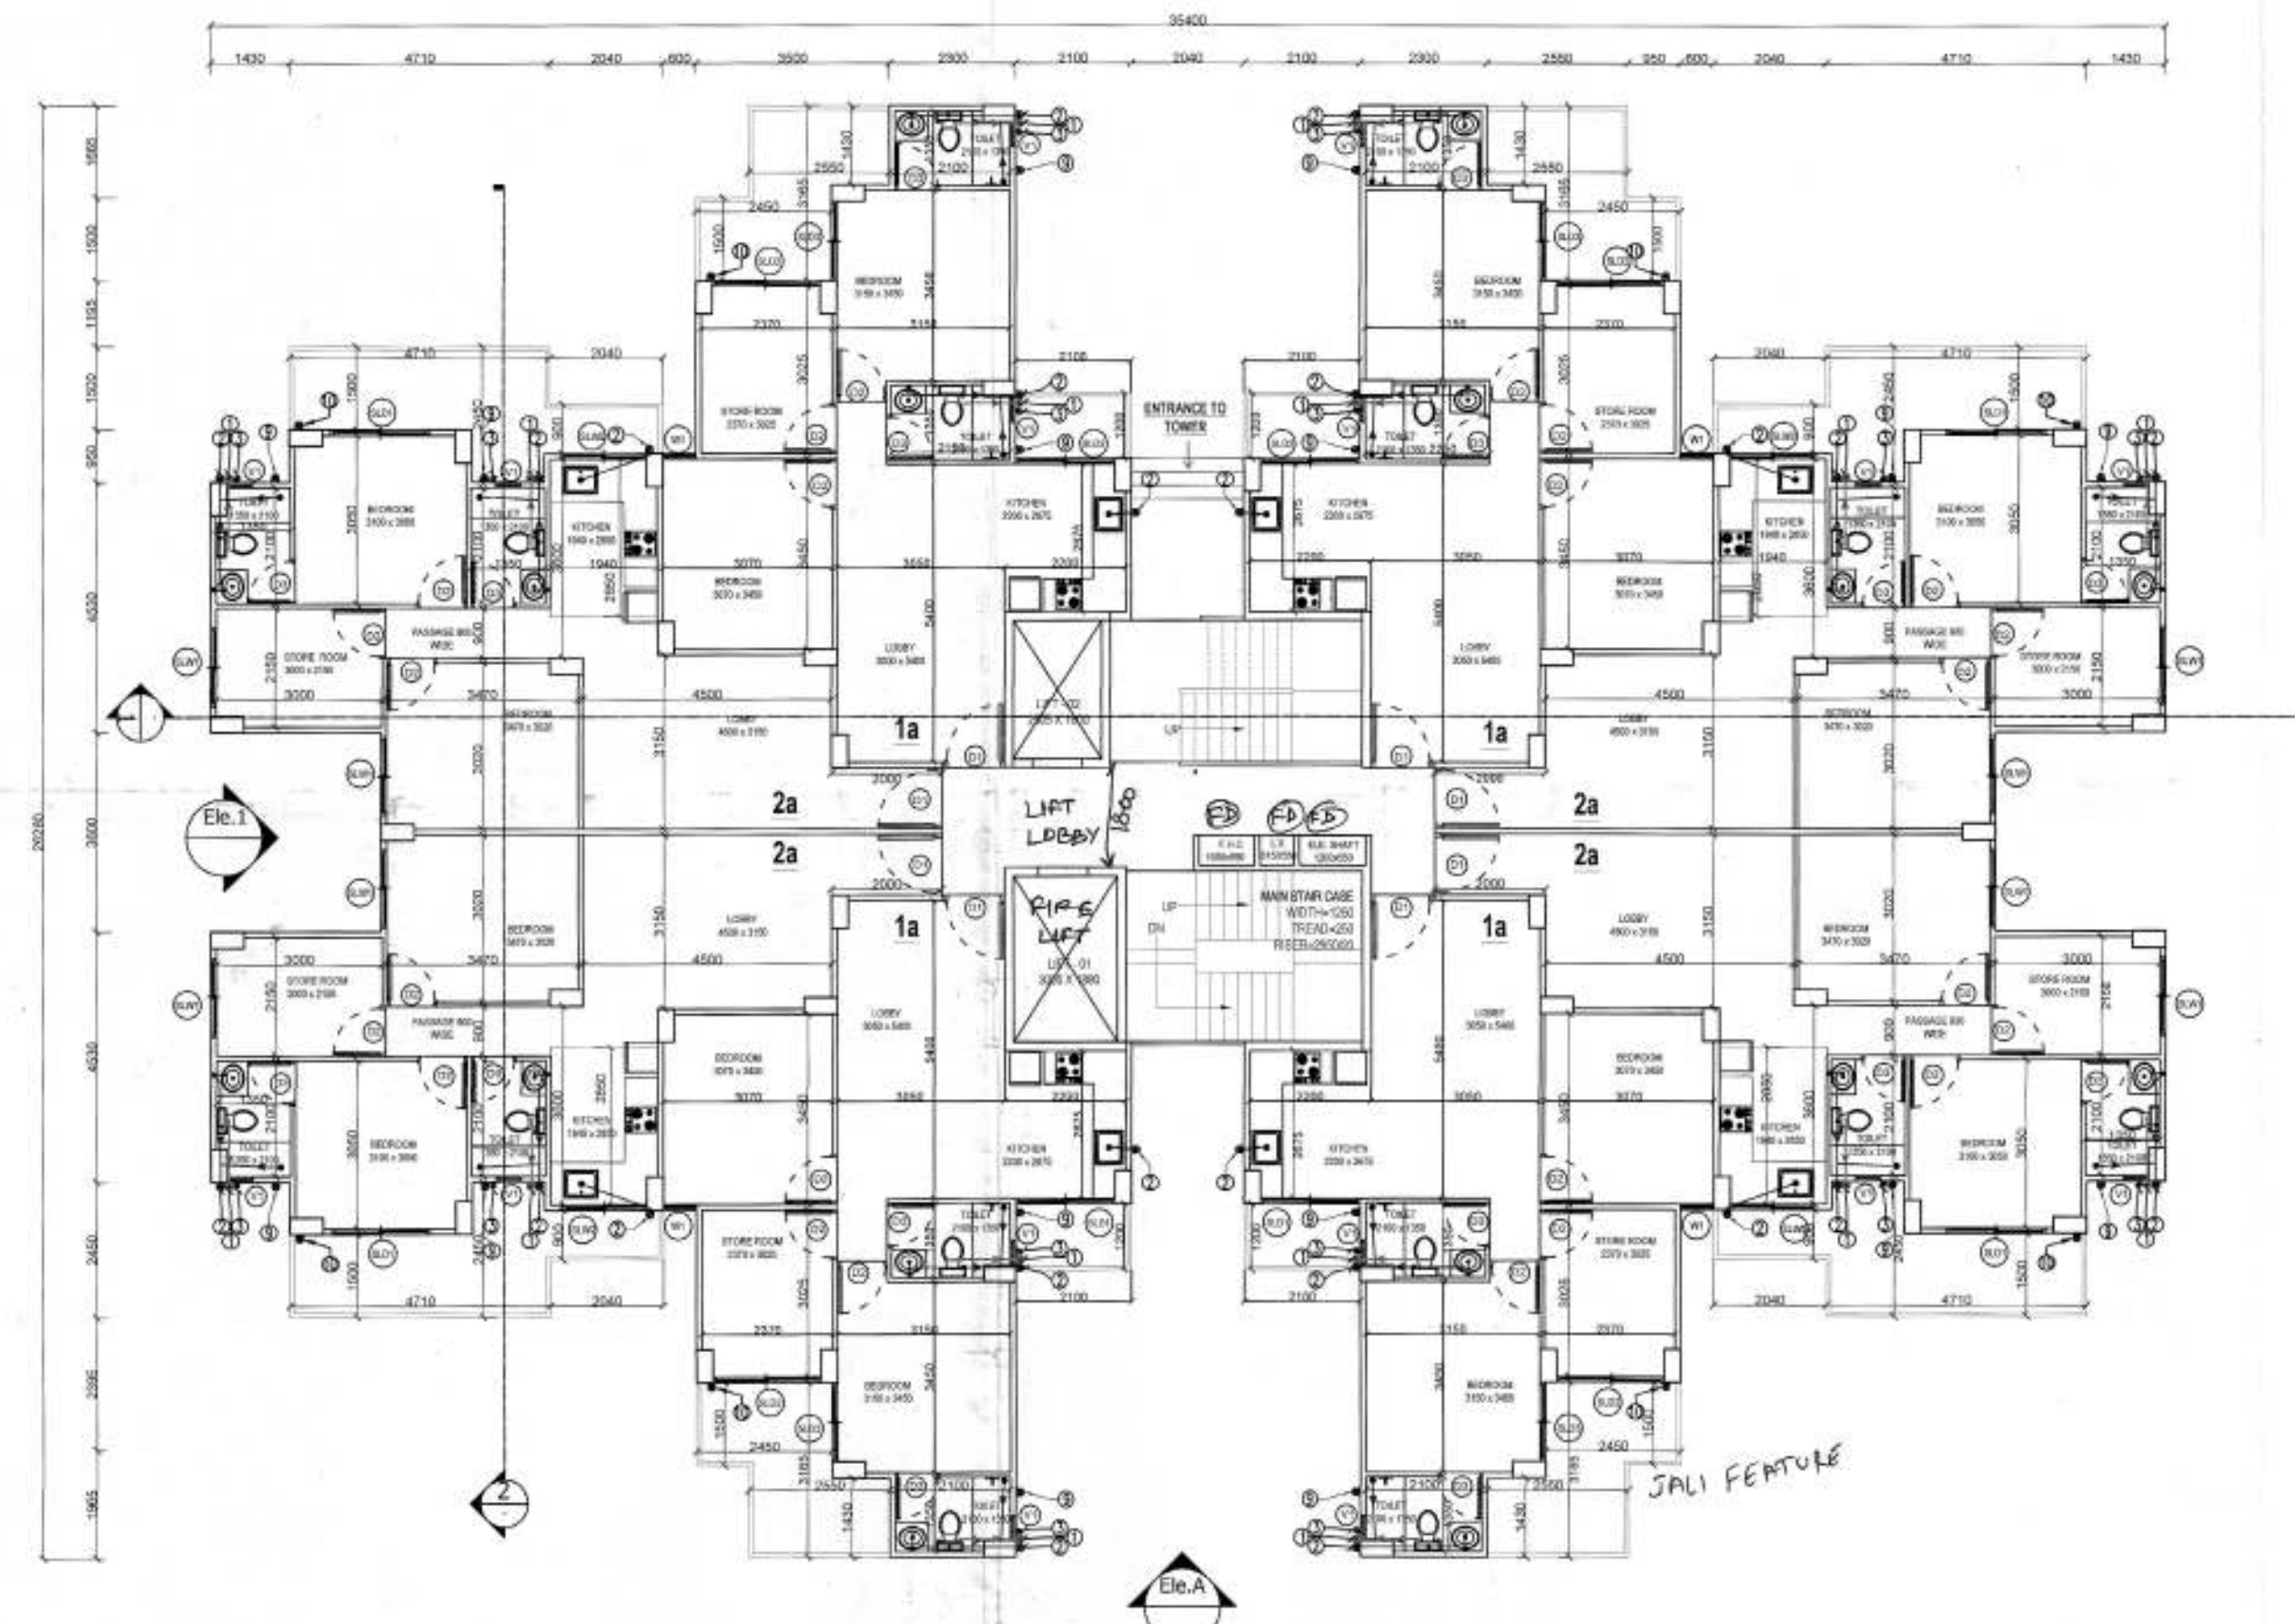


1 Ground floor Plan - Tower-D1

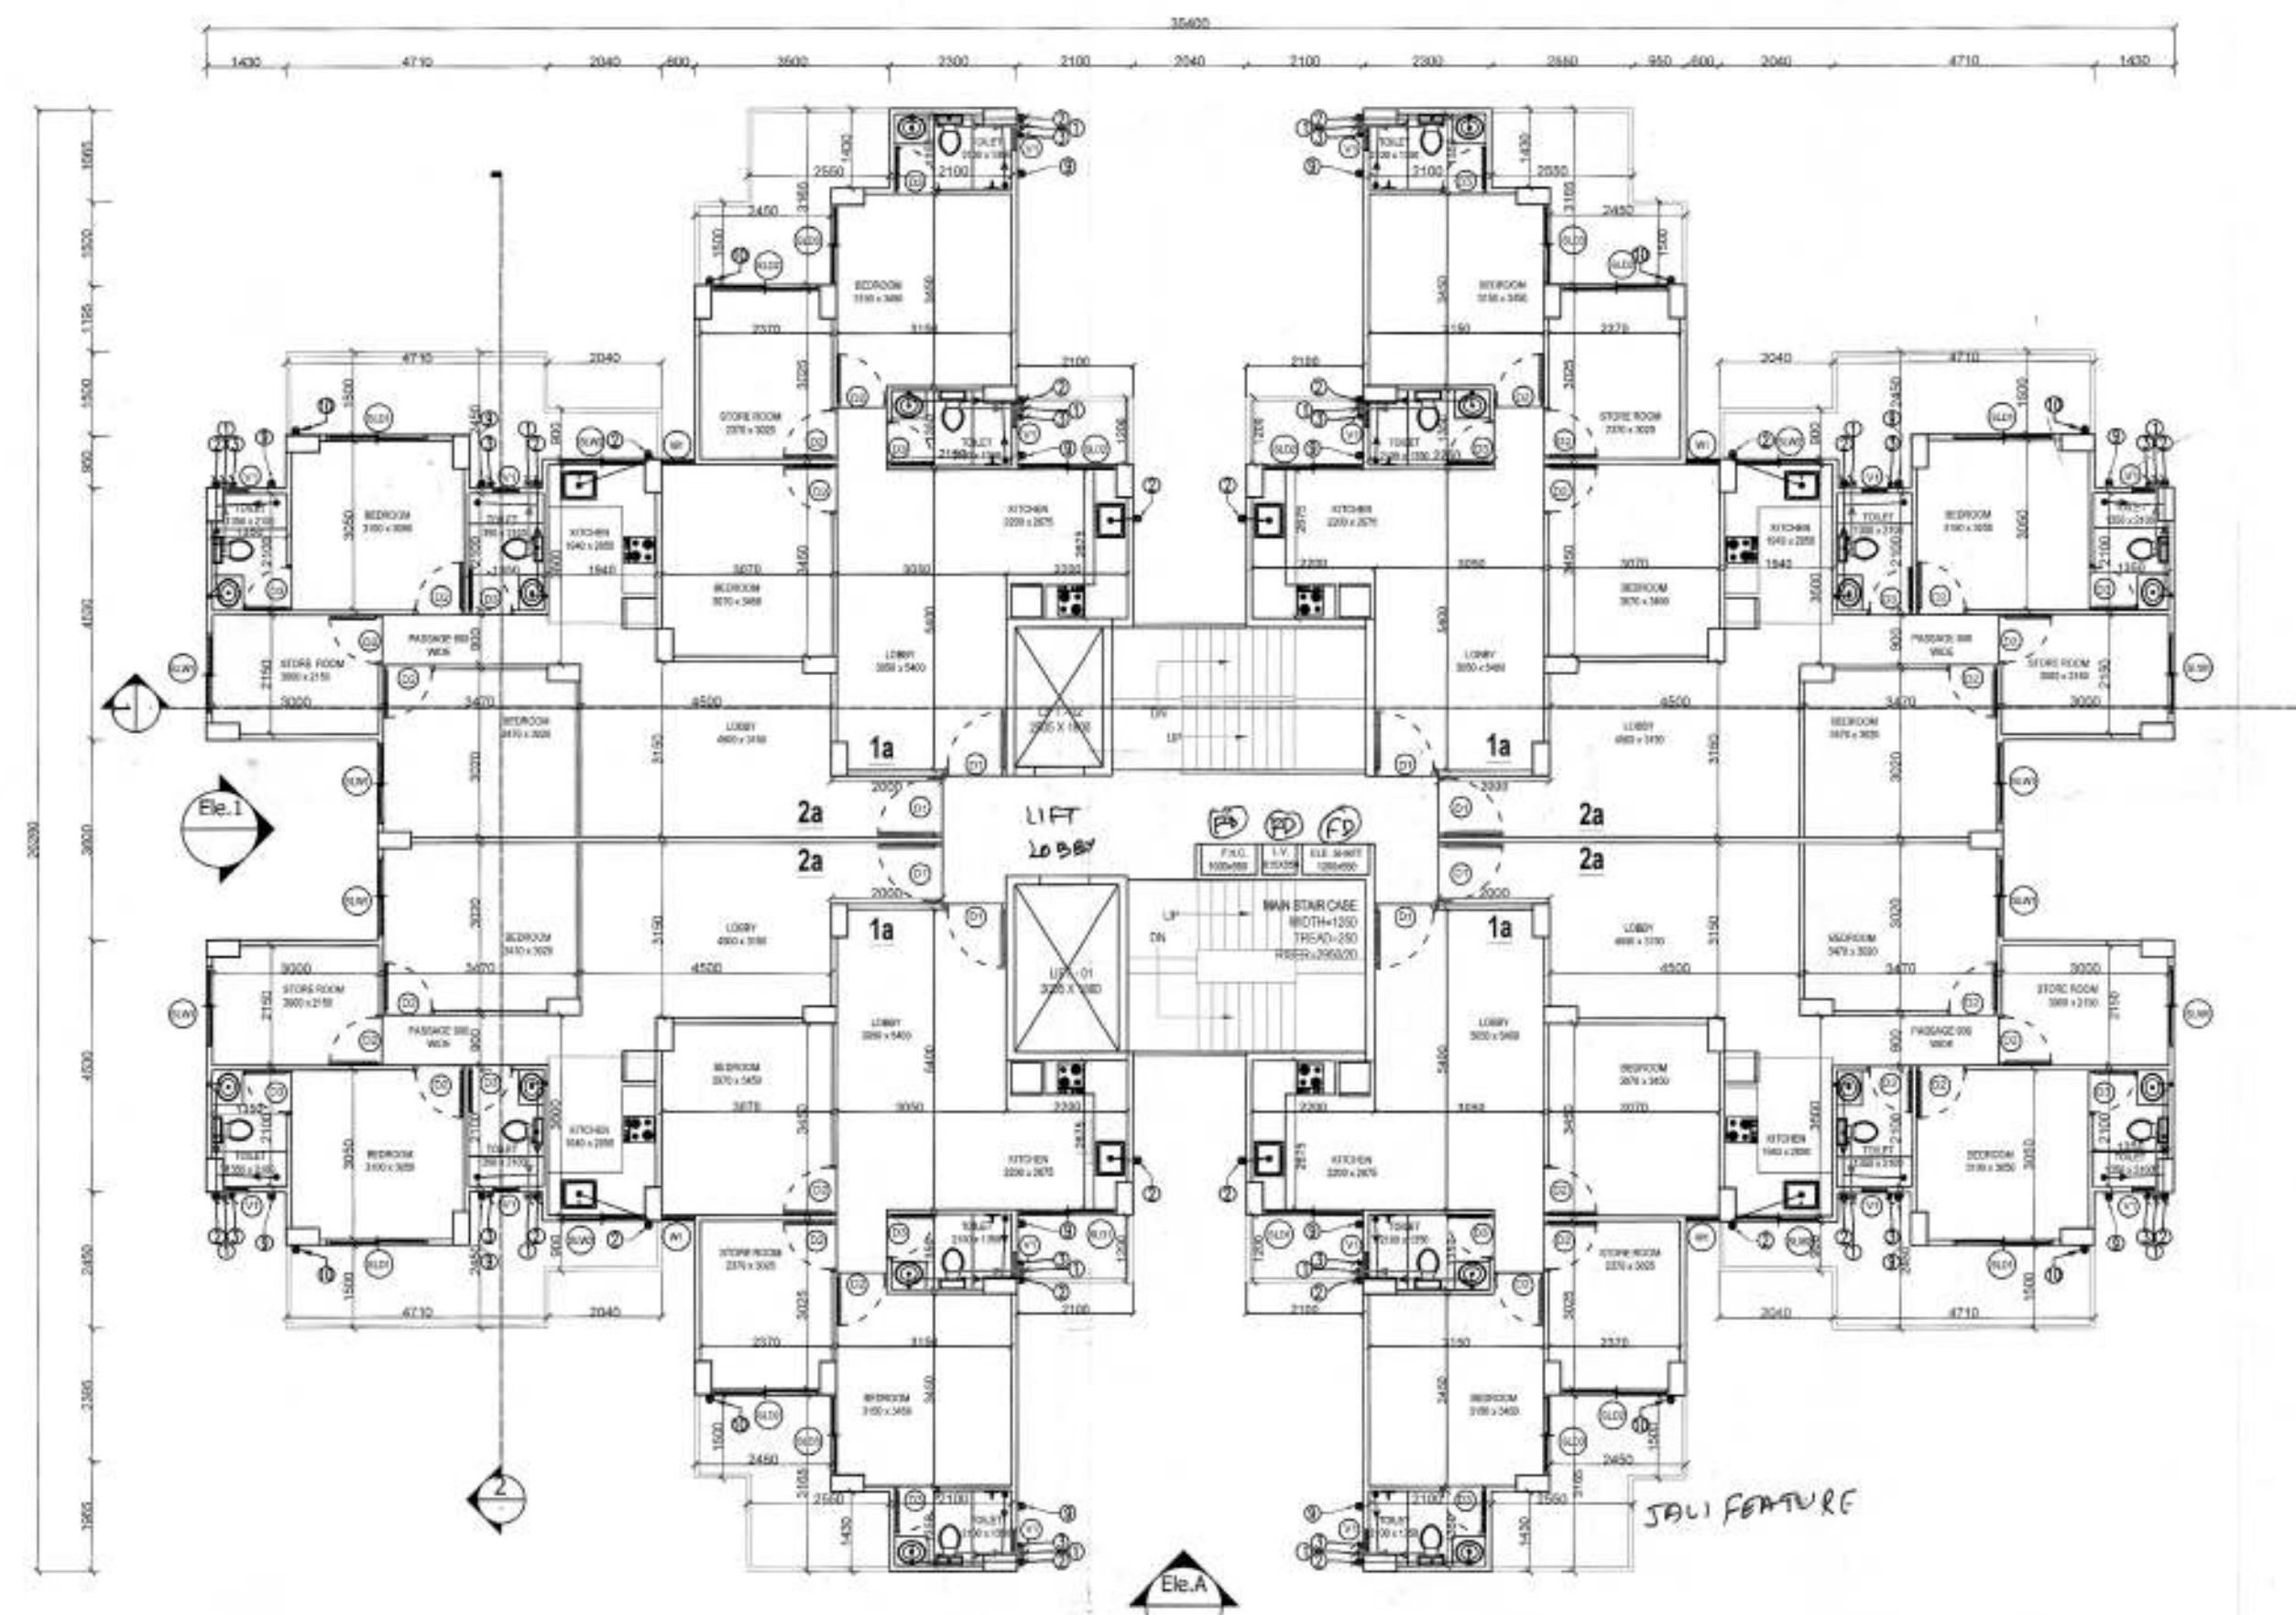

2 FIRST FLOOR PLAN TOWER-D1

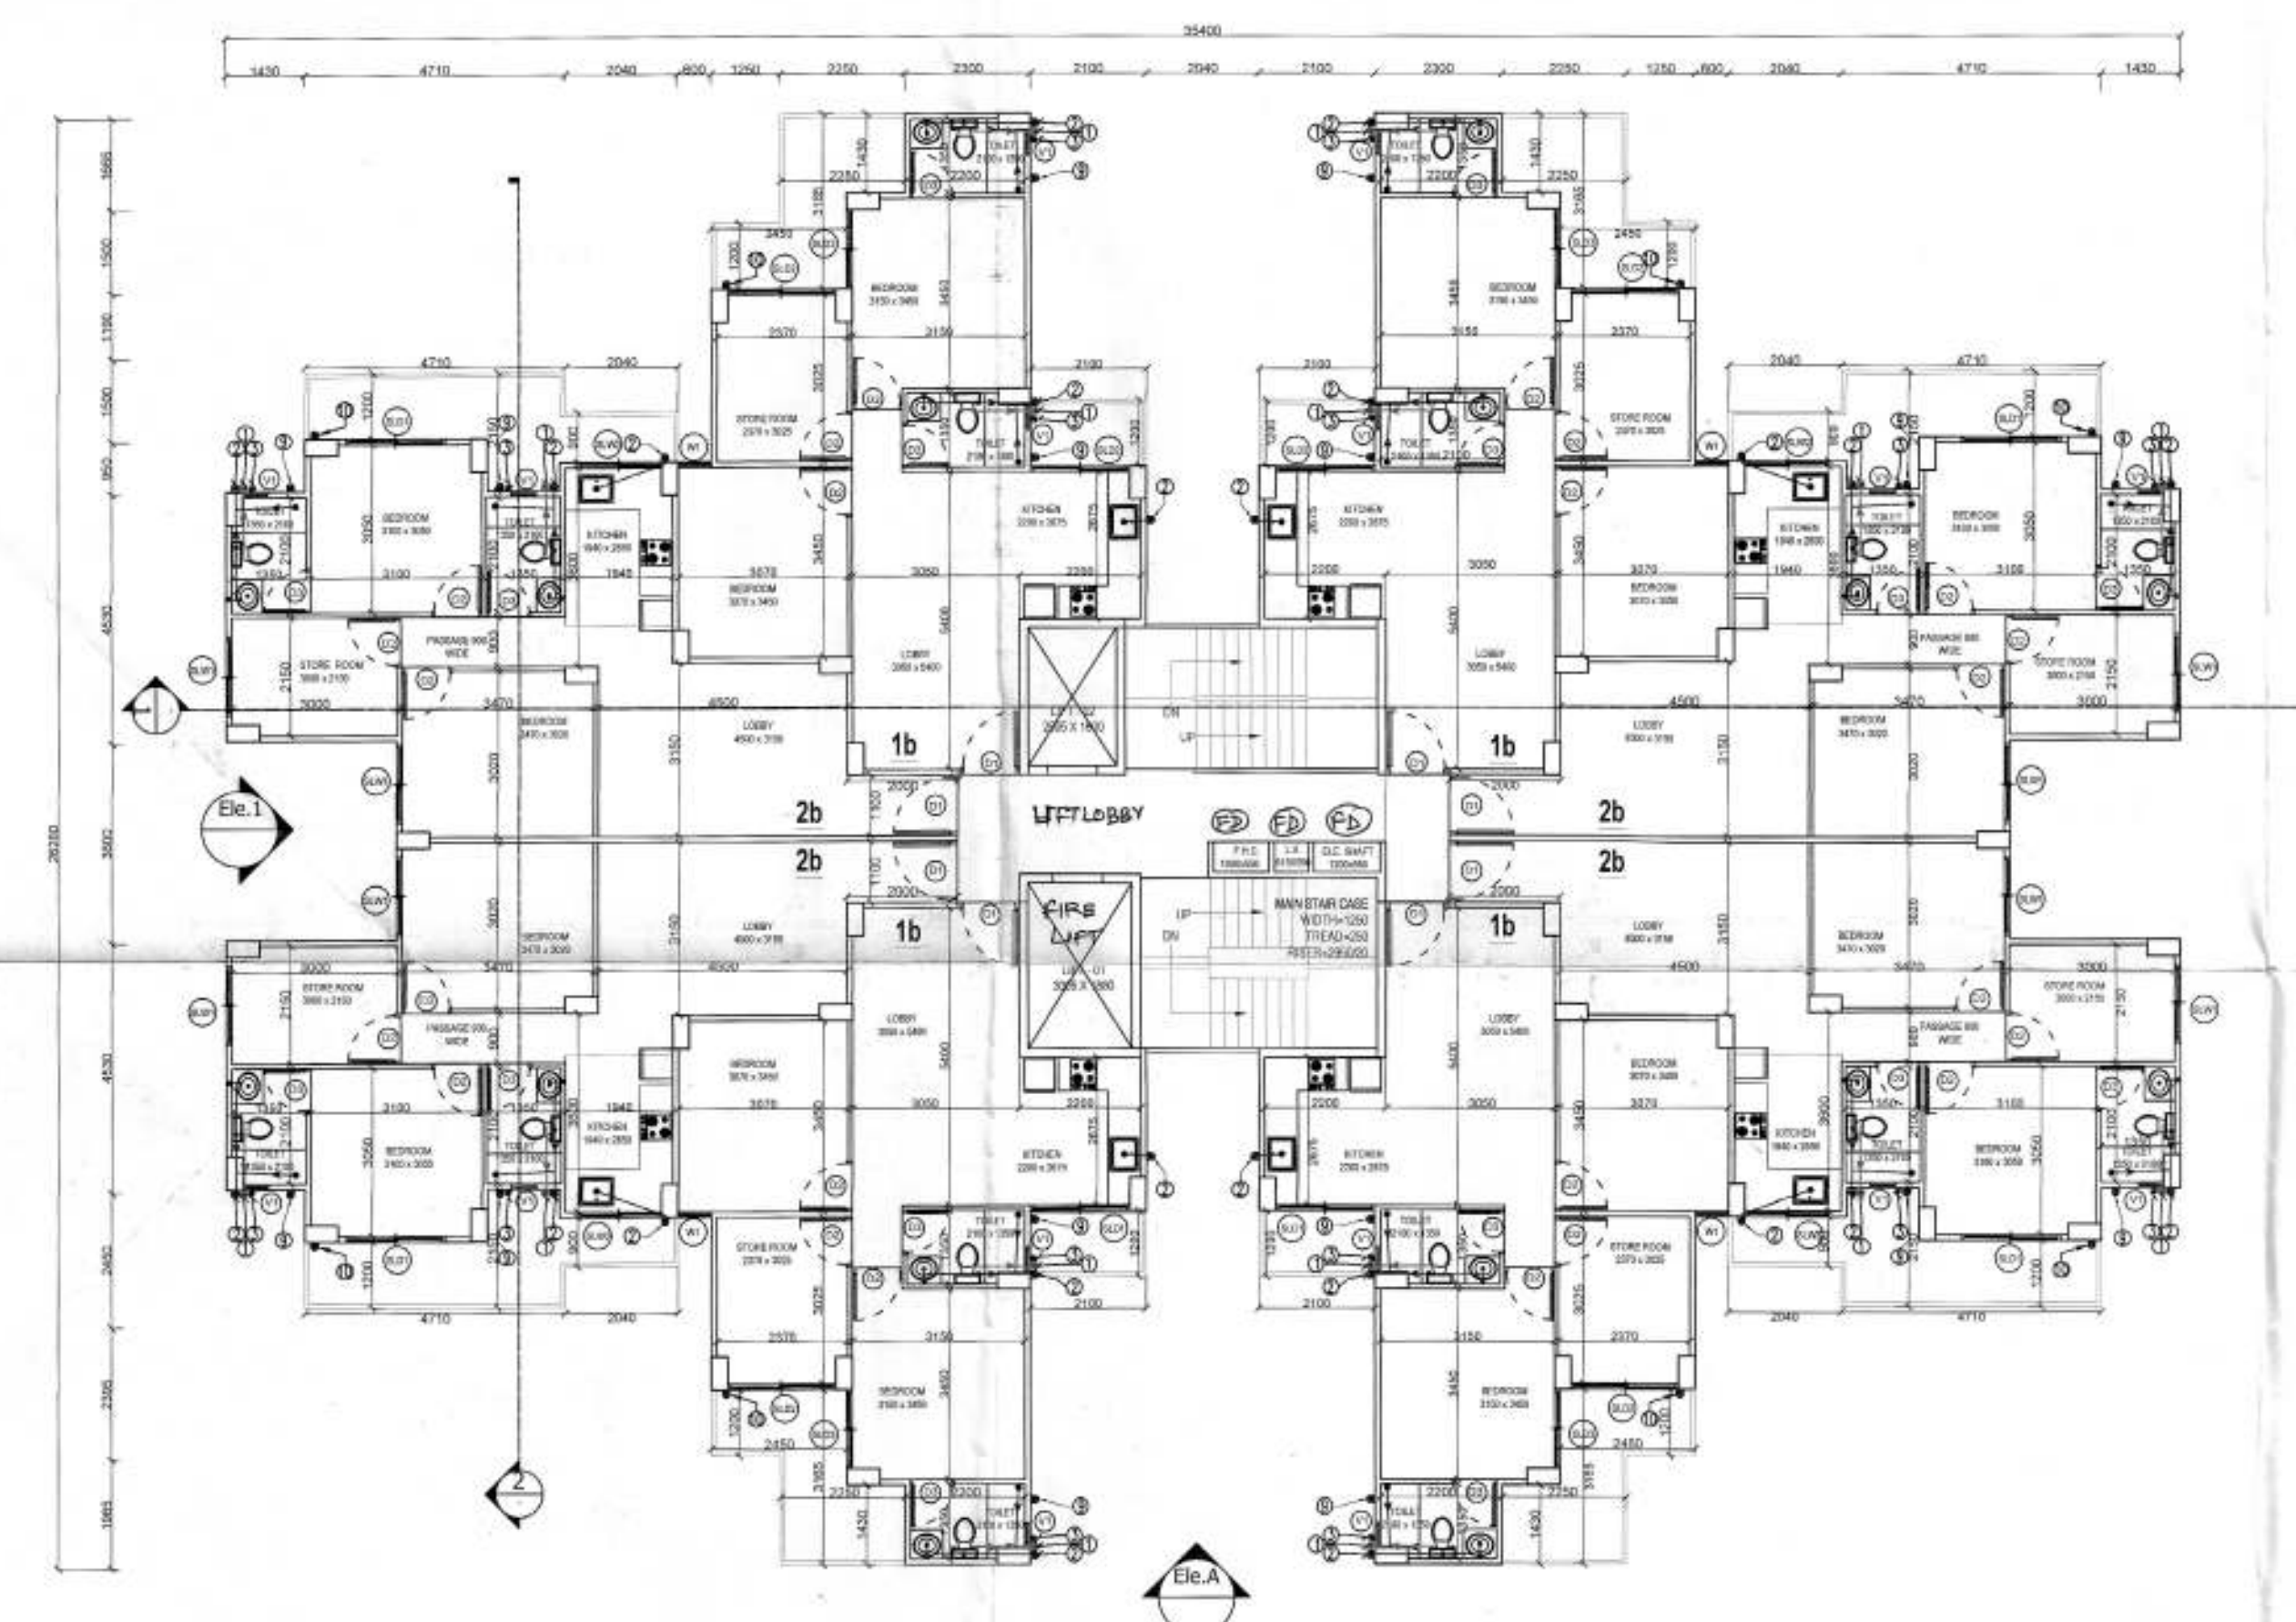

3 TYPICAL FLOOR 2nd - 12th

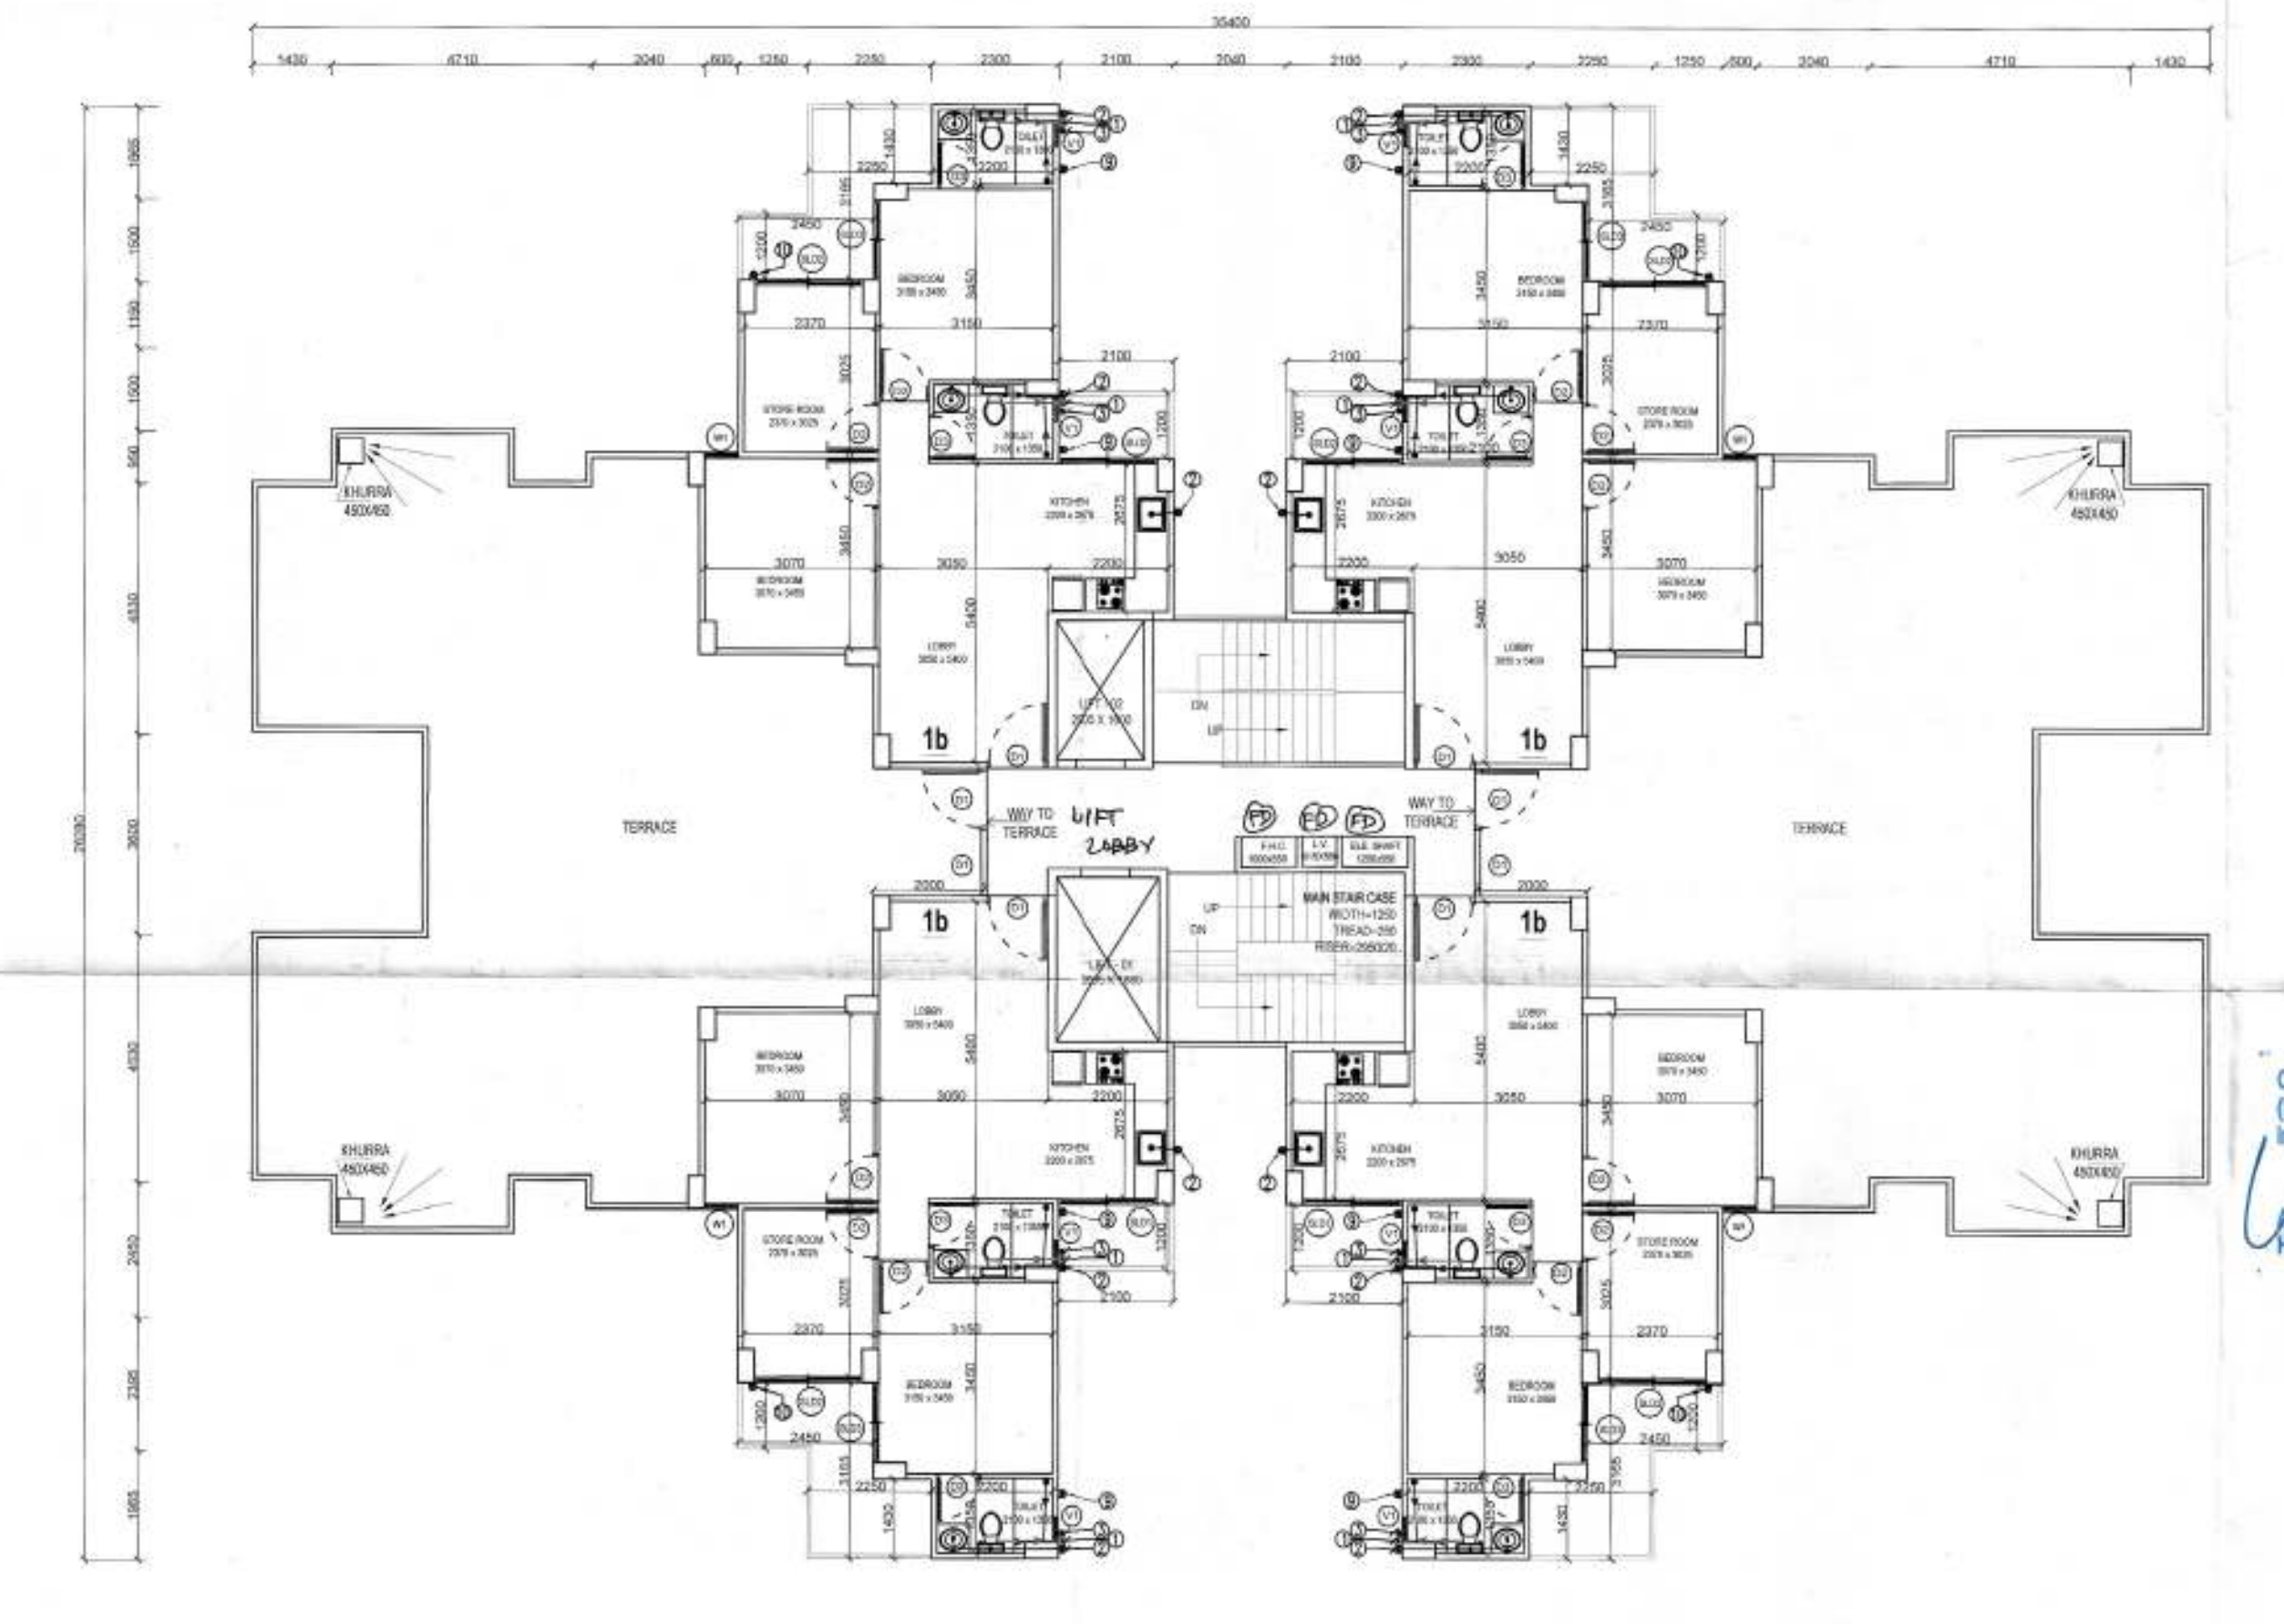

4 13th FLOOR PLAN TOWER-D1

ARCHITECT (H.Q.) S.T.P.  
 Member Secretary Member Chairman  
 B.P.C. B.P.C. B.P.C.  
 PA ATP  
 DINESH KUMAR  
 SD (H.Q.)  
 INTERNATIONAL APPROVED BUILDING PLAN  
 of Inviting  
 as general public  
 Town and Country Planning,  
 Bangalore

| DOOR/WINDOW SCHEDULE |      |            |             |             |
|----------------------|------|------------|-------------|-------------|
| SN                   | Type | Width (mm) | Lintel (mm) | Height (mm) |
| 1                    | D1   | 1100       | +00         | +2300 (BOB) |
| 2                    | D2   | 900        | +00         | +2100       |
| 3                    | D3   | 800        | +00         | +2100       |
| 4                    | V1   | 450        | +1350       | +2100       |
| 5                    | W1   | 600        | +00         | +2300 (BOB) |
| 6                    | SLD1 | 1800       | +00         | +2300 (BOB) |
| 7                    | SLD2 | 1950       | +00         | +2300 (BOB) |
| 8                    | SLD3 | 1435       | +00         | +2300 (BOB) |
| 9                    | SLW1 | 1430       | +1200       | +2300 (BOB) |
| 10                   | SLW5 | 1510       | +1200       | +2300 (BOB) |

1 DOOR FIRE RATED DOOR

| LEGEND:                                             |  |
|-----------------------------------------------------|--|
| 110 ØD SWR PVC SOIL & VENT PIPE                     |  |
| 110 ØD SWR PVC WASTE & VENT PIPE                    |  |
| 110 ØD SWR PVC ANTI-SYNDHONIC PIPE                  |  |
| 50Ø CWS RISER TO D.H.T. FILLING TANK                |  |
| 50Ø FWS RISER TO D.H.T. FILLING TANK                |  |
| DOMESTIC WATER SUPPLY DN TAKE PIPE                  |  |
| FLUSHING WATER SUPPLY DN TAKE PIPE                  |  |
| 110 ØD W/PVC RAIN WATER PIPE (E/W/ROOF)             |  |
| 110 ØD W/PVC RAIN WATER PIPE (BALCONY)              |  |
| LEGEND:-                                            |  |
| 110ØØØ FIRE HOSE CABINET                            |  |
| 9 Ltr WATER GAS PRESSURE TYPE FIRE EXTINGUISHER     |  |
| 45 kg CO <sub>2</sub> TYPE FIRE EXTINGUISHER        |  |
| BUTTERFLY VALVE / SLUCE VALVE                       |  |
| NOTE:-                                              |  |
| EACH FIRE HOSE CABINET SHALL CONSIST OF             |  |
| 1 No. - GUNMETAL SINGLE HEADED HYDRANT VALVE (63mm) |  |
| 2 Nos. - FIRE HOSES 63mm 15M LONG WITH ACCESSORIES  |  |
| 1 No. - SHORT BRANCH                                |  |
| 1 No. - FIRST AID HOSE REEL                         |  |
| 2 Nos. - FIRE EXTINGUISHERS                         |  |
| 1 No. - FIRE MAN'S KEY                              |  |

PROJECT TITLE  
 ADDITIONAL BUILDING PLANS FOR AFFORDABLE GROUP HOUSING COLONY FOR AN ADDITIONAL AREA MEASURING 2.375 ACRES IN THE AFFORDABLE GROUP HOUSING COLONY MEASURING 5.0 ACRES (LICENCE NO.30 OF 2019 DATED 28.02.2019), THEREBY MAKING THE TOTAL SITE AREA 7.335 ACRES IN SECTOR-90, GUNWARAM BEING DEVELOPED BY MRG WORLD LLP IN COLLABORATION WITH BUBRA DEVELOPERS PVT.LTD. in forwarding letter No. ACE/HQ/19/02/51  
 OWNER'S SIGNATURE  
 ARCHITECT'S SIGNATURE  
 ARCHITECT: AVANIRAJASHISH CA/2014/81670

DRAWING TITLE  
 LAYOUT (TOWER-D1)  
 TYPE 2a+2b+1a+1b  
 ARCHITECTS  
 MRG DESIGN TEAM  
 MRG World  
 White Tower, Golf Course Road  
 Gurgaon  
 DATE AUG 2021 DWG. NO.  
 SCALE NTS  
 S - 107