


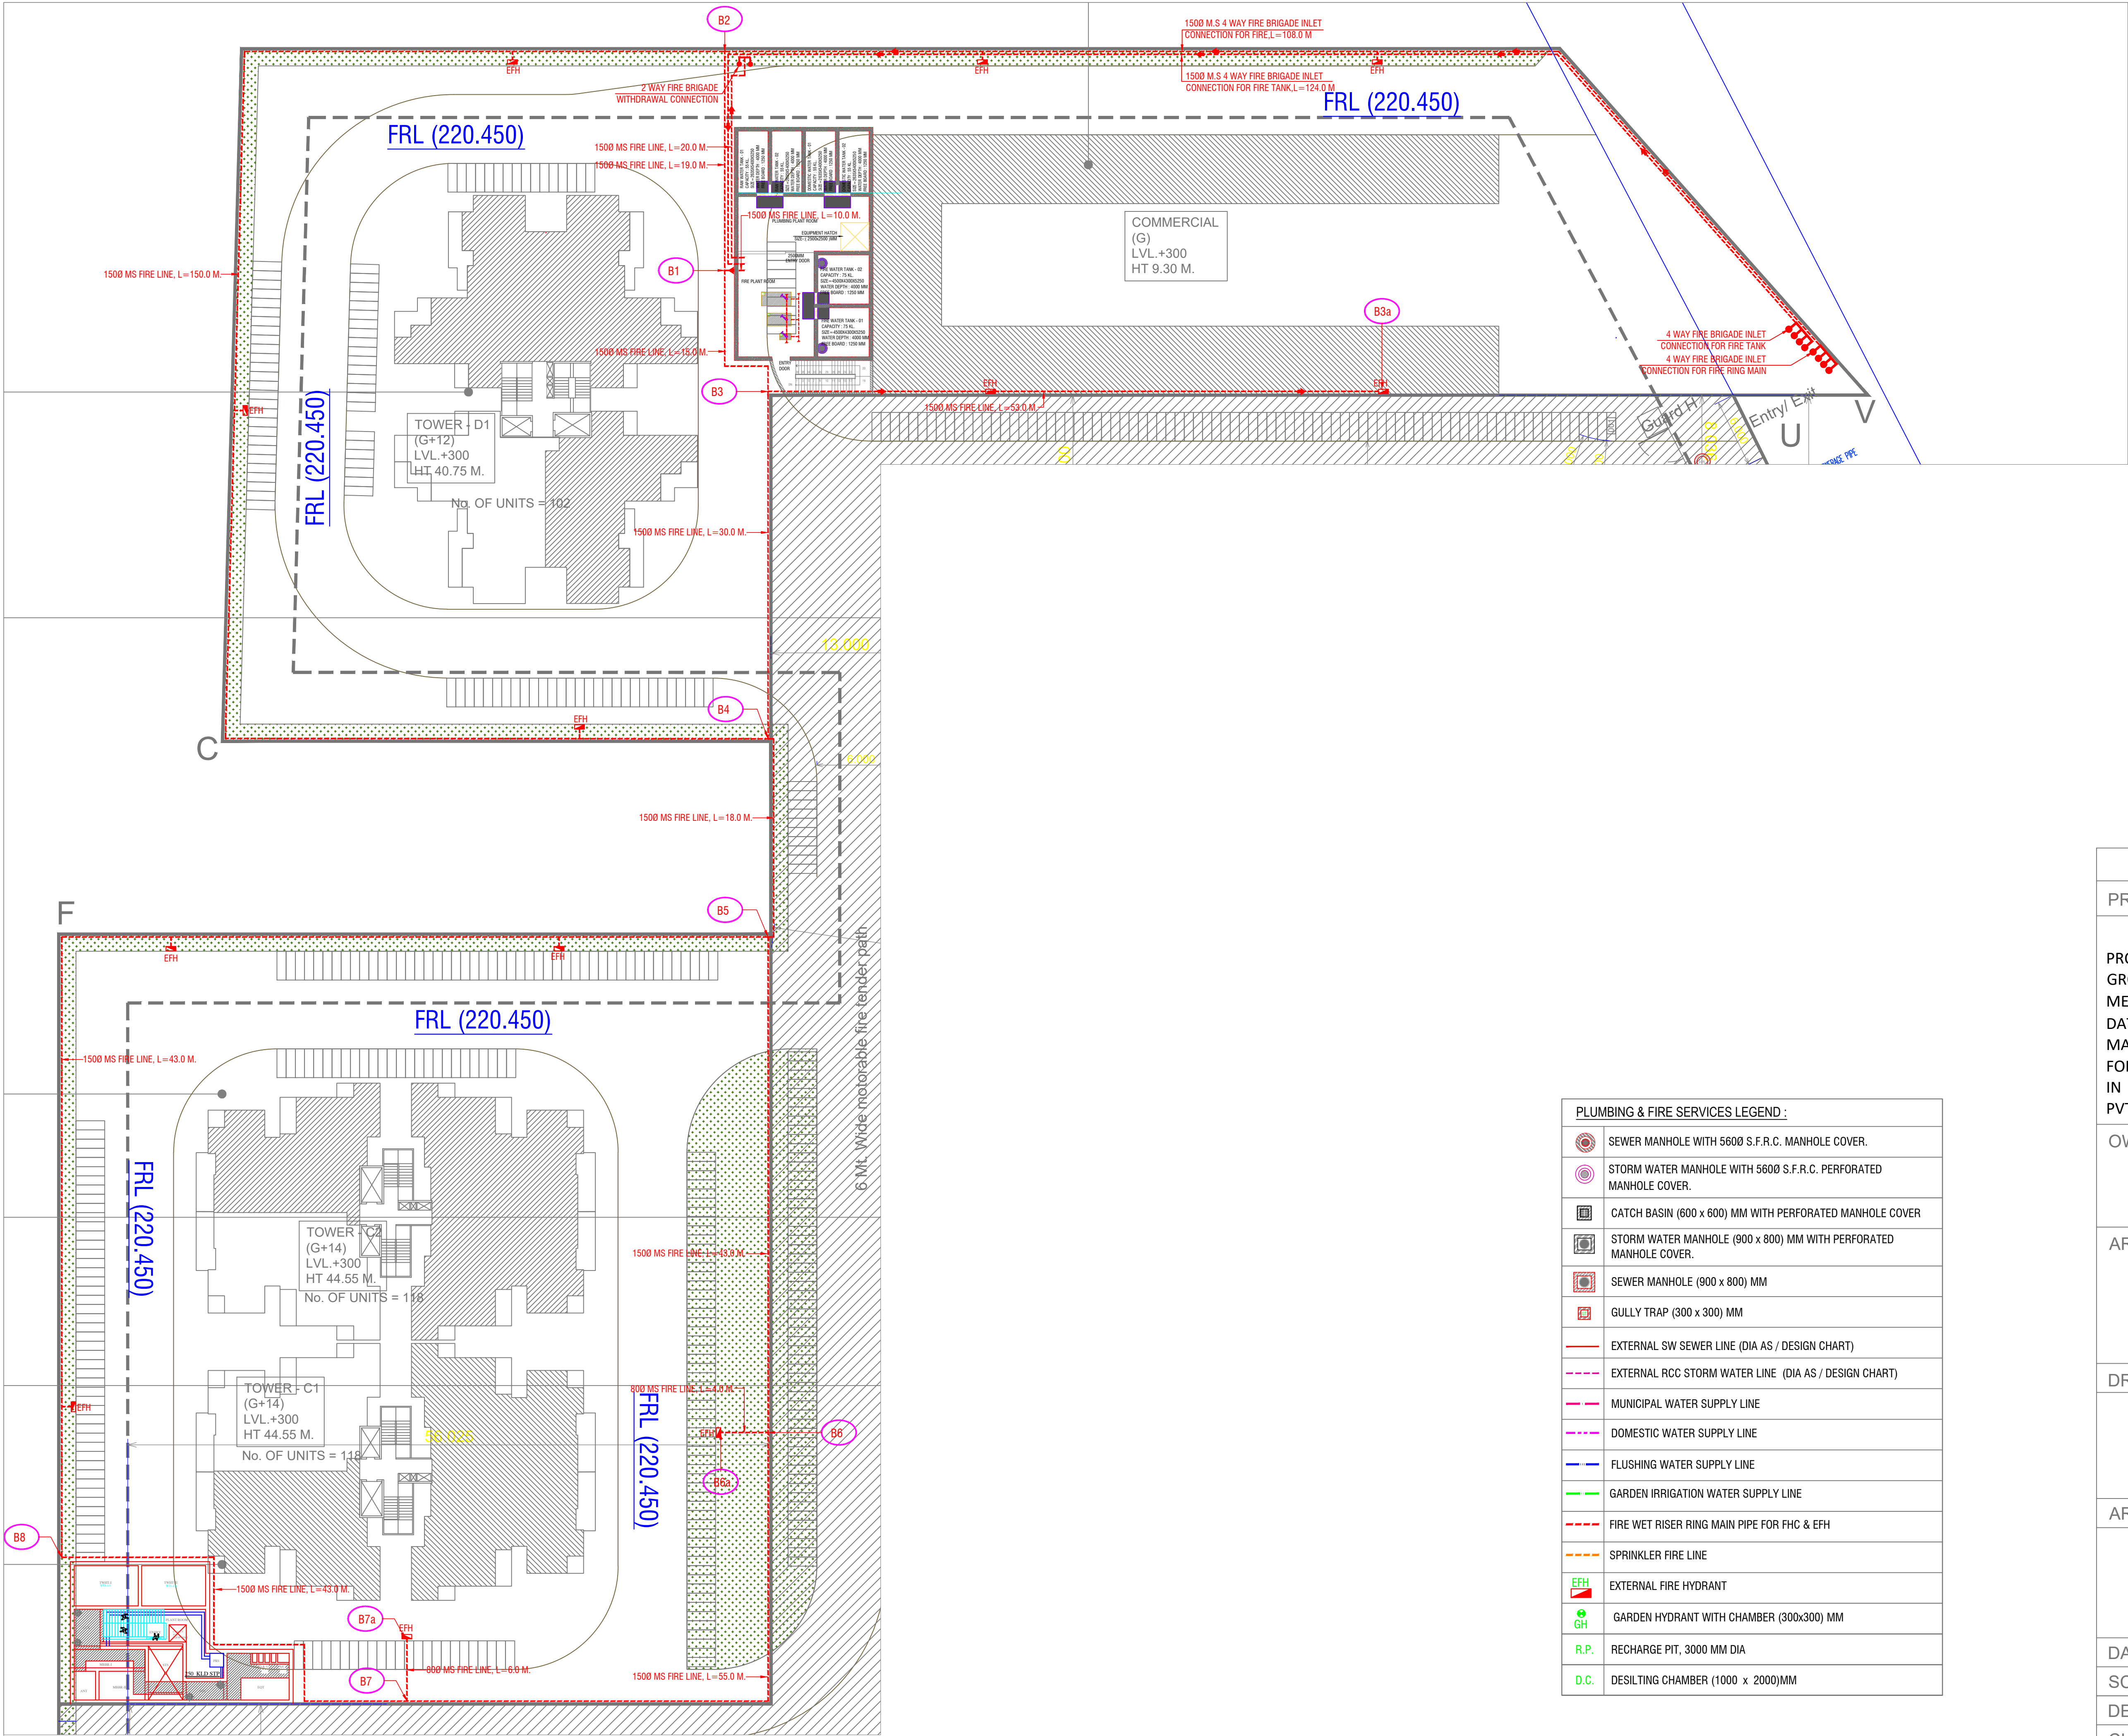

PLUMBING & FIRE SERVICES LEGEND :	
	SEWER MANHOLE WITH 5600 S.F.R.C. MANHOLE COVER.
	STORM WATER MANHOLE WITH 5600 S.F.R.C. PERFORATED MANHOLE COVER.
	CATCH BASIN (600 x 600) MM WITH PERFORATED MANHOLE COVER
	STORM WATER MANHOLE (900 x 800) MM WITH PERFORATED MANHOLE COVER.
	SEWER MANHOLE (900 x 800) MM
	GULLY TRAP (300 x 300) MM
	EXTERNAL SW SEWER LINE (DIA AS / DESIGN CHART)
	EXTERNAL RCC STORM WATER LINE (DIA AS / DESIGN CHART)
	MUNICIPAL WATER SUPPLY LINE
	DOMESTIC WATER SUPPLY LINE
	FLUSHING WATER SUPPLY LINE
	GARDEN IRRIGATION WATER SUPPLY LINE
	FIRE WET RISER RING MAIN PIPE FOR FHC & EFH
	SPRINKLER FIRE LINE
	EXTERNAL FIRE HYDRANT
	GARDEN HYDRANT WITH CHAMBER (300x300) MM
	RECHARGE PIT, 3000 MM DIA
	DESILTING CHAMBER (1000 x 2000)MM

SUBMISSION DRAWING		
PROJECT TITLE		
PROPOSED BUILDING PLANS OF AFFORDABLE GROUP HOUSING COLONY FOR AN AREA MEASURING 5.0 ACRES (LICENSE NO. 30 OF 2019 DATED 28.02.2019) IN SECTOR-90, GURUGRAM MANESAR URBAN COMPLEX BEING DEVELOPED BY FORTUNE LAND & HOUSING PVT. LTD. AND OTHERS IN COLLABORATION WITH B.D. INFRADEVELOPERS PVT. LTD.		
OWNER's SIGNATURE		
ARCHITECT's SIGNATURE		
DRAWING TITLE		
SITE PLAN FIRE LAYOUT		NORTH
ARCHITECTS		
DATE	MAY 2019	DWG. NO.
SCALE	NTS	S - 104
DEALT	SG	
CHECKED	MA	