


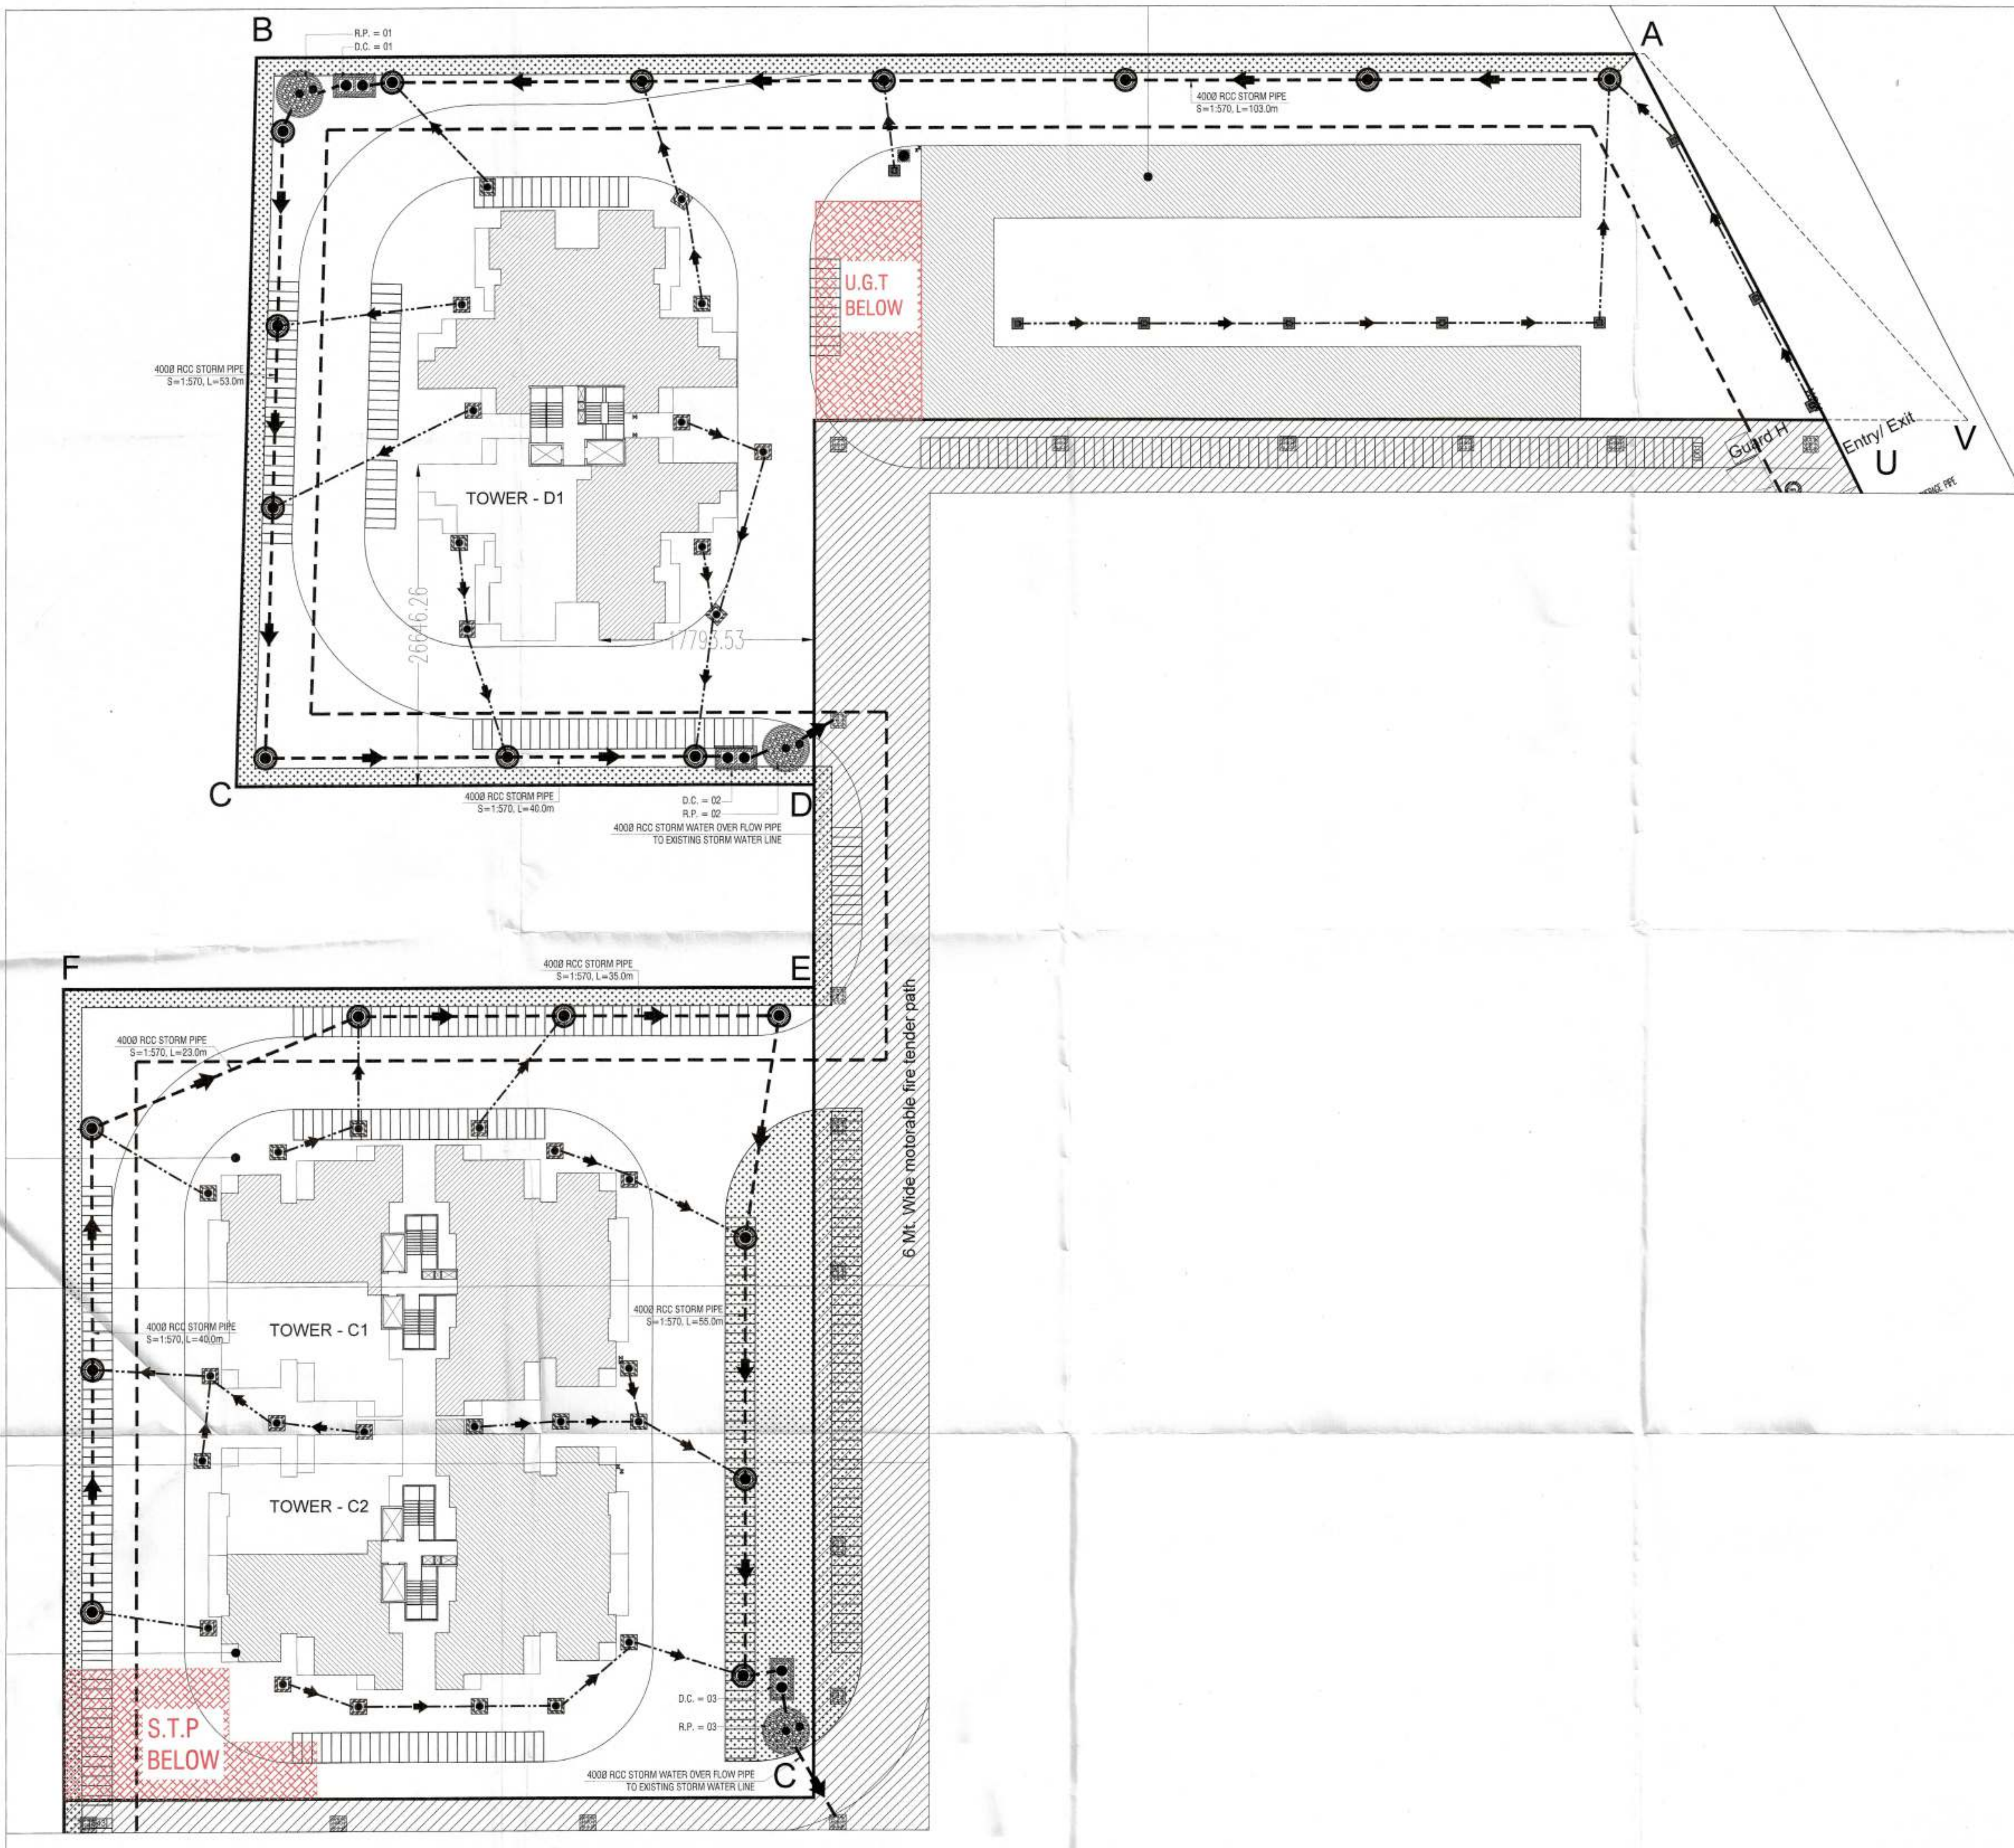

B.P.C. = 01
 D.C. = 01
 B.P.C. = 02
 D.C. = 02
 B.P.C. = 03
 D.C. = 03

Checked and found ok for Public Health
 (Internal) Service only subject to comments in
 forwarding letter to ACE(HQ) DL
 Additional Civil Engineer (HQ)
 HSVP, Pondicherry
 14/6/21
 DINESH KUMAR
 SD (HQ)

For B D INFRADEVELOPERS LLP
 Authorised Signatory

PLUMBING & FIRE SERVICES LEGEND :	
	SEWER MANHOLE WITH 5600 S.F.R.C. MANHOLE COVER.
	STORM WATER MANHOLE WITH 5600 S.F.R.C. PERFORATED MANHOLE COVER.
	CATCH BASIN (600 x 600) MM WITH PERFORATED MANHOLE COVER
	STORM WATER MANHOLE (900 x 800) MM WITH PERFORATED MANHOLE COVER.
	SEWER MANHOLE (900 x 800) MM
	GULLY TRAP (300 x 300) MM
	EXTERNAL SW SEWER LINE (DIA AS / DESIGN CHART)
	EXTERNAL RCC STORM WATER LINE (DIA AS / DESIGN CHART)
	MUNICIPAL WATER SUPPLY LINE
	DOMESTIC WATER SUPPLY LINE
	FLUSHING WATER SUPPLY LINE
	GARDEN IRRIGATION WATER SUPPLY LINE
	FIRE WET RISER RING MAIN PIPE FOR FHC & EFH
	SPRINKLER FIRE LINE
	EXTERNAL FIRE HYDRANT
	GARDEN HYDRANT WITH CHAMBER (300x300) MM
	R.P. RECHARGE PIT, 3000 MM DIA
	D.C. DESILTING CHAMBER (1000 x 2000)MM

SUBMISSION DRAWING		
PROJECT TITLE		
PROPOSED AFFORDABLE GROUP HOUSING COLONY FOR AN ADDITIONAL AREA MEASURING 2.3375 ACRES IN THE AFFORDABLE GROUP HOUSING COLONY MEASURING 5.0 ACRES (LICENCE NO.30 OF 2019 DATED 28.02.2019), THEREBY MAKING THE TOTAL SITE AREA 7.3375 ACRES IN SECTOR-90, GURUGRAM BEING DEVELOPED BY MRG WORLD LLP IN COLLABORATION WITH B D INFRADEVELOPERS PVT LTD.		
OWNER'S SIGNATURE		
ARCHITECT'S SIGNATURE		
AVANIKA VASHISTH CA/2018/91670		
DRAWING TITLE		
SITE PLAN STORM LAYOUT		
ARCHITECTS		
DATE	MAY 2019	DWG. NO.
SCALE	NTS	PL - 102
DEALT	SG	
CHECKED	MA	