

S.T.P. (S.P.)
 Member Secretary
 B.P.C.
 S.T.P. (S.P.)
 Member Secretary
 B.P.C.
 S.T.P. (S.P.)
 Member Secretary
 B.P.C.

PA
 ATP
 Member
 BPAC

Checked and found ok for Public Health
 (Internal) Service only subject to comments in
 forwarding letter to ACE(HQ)
 Additional Chief Engineer (HQ)
 HSP, Panchajanya

DINESH KUMAR
 SD (HQ)


This is a PROVISIONAL APPROVED BUILDING PLAN
 for the purpose of building
 in accordance with the provisions of the
 Town and Country Planning, Chennai Act, 1919.

DOOR/WINDOW SCHEDULE					
SN.	Type	Width (mm)	Height (mm)	Lintel (mm)	Height (mm)
1	D1	1050	±00	+2300 (BOB)	2300
2	D2	900	±00	+2100	2100
3	D3	750	±00	+2100	2100
4	V1	450	±1350	+2100	750
5	DW1	2450	±00	+2300 (BOB)	2300
6	DW2	1400	±00	+2300 (BOB)	2300
7	DW3	1330	±00	+2300 (BOB)	2300
8	DW4	1200	±00	+2300 (BOB)	2300
9	DW5	1570	±1000	+2300 (BOB)	2300/1300


NOTE: D1 1 Hour Fire Rated Door

LEGEND	
①	110 OD SWR PVC SOL & VENT PIPE
②	110 OD SWR PVC WASTE & VENT PIPE
③	110 OD SWR PVC ANTI-SYPHONIC PIPE
④	50P CWS RISER TO G.H.T. FILLING TANK
⑤	50P FWS RISER TO G.H.T. FILLING TANK
⑥	DOMESTIC WATER SUPPLY DN. TAKE PIPE
⑦	FLUSHING WATER SUPPLY DN. TAKE PIPE
⑧	110 OD uPVC RAIN WATER PIPE (TERRACE)
⑨	110 OD uPVC RAIN WATER PIPE (BALCONY)
LEGEND-	
⑩	FIRE HOSE CABINET
⑪	9L WATER GAS PRESSURE TYPE FIRE EXTINGUISHER
⑫	4.5kg CO2 TYPE FIRE EXTINGUISHER
⑬	BUTTERFLY VALVE / SLICE VALVE
NOTE:-	
EACH FIRE HOSE CABINET SHALL CONSIST OF	
1 No. - GUNMETAL SINGLE HEADED HYDRANT VALVE (63mm).	
2 Nos. - FIRE HOSES 63mm 15M LONG WITH ACCESSORIES	
1 No. - SHORT BRANCH	
1 No. - FIRST AID HOSE REEL	
2 Nos. - FIRE EXTINGUISHERS	
1 No. - FIRE MAN'S AXE	


WATER TANK CAPACITY
 No. of units = 118
 CAP. = (118X5) X 172.5
 = 10140 Lts.
 Flushing = 13,800 Lts.
 Domestic = 27,600 Lts.
 Fire = 10,000 Lts.

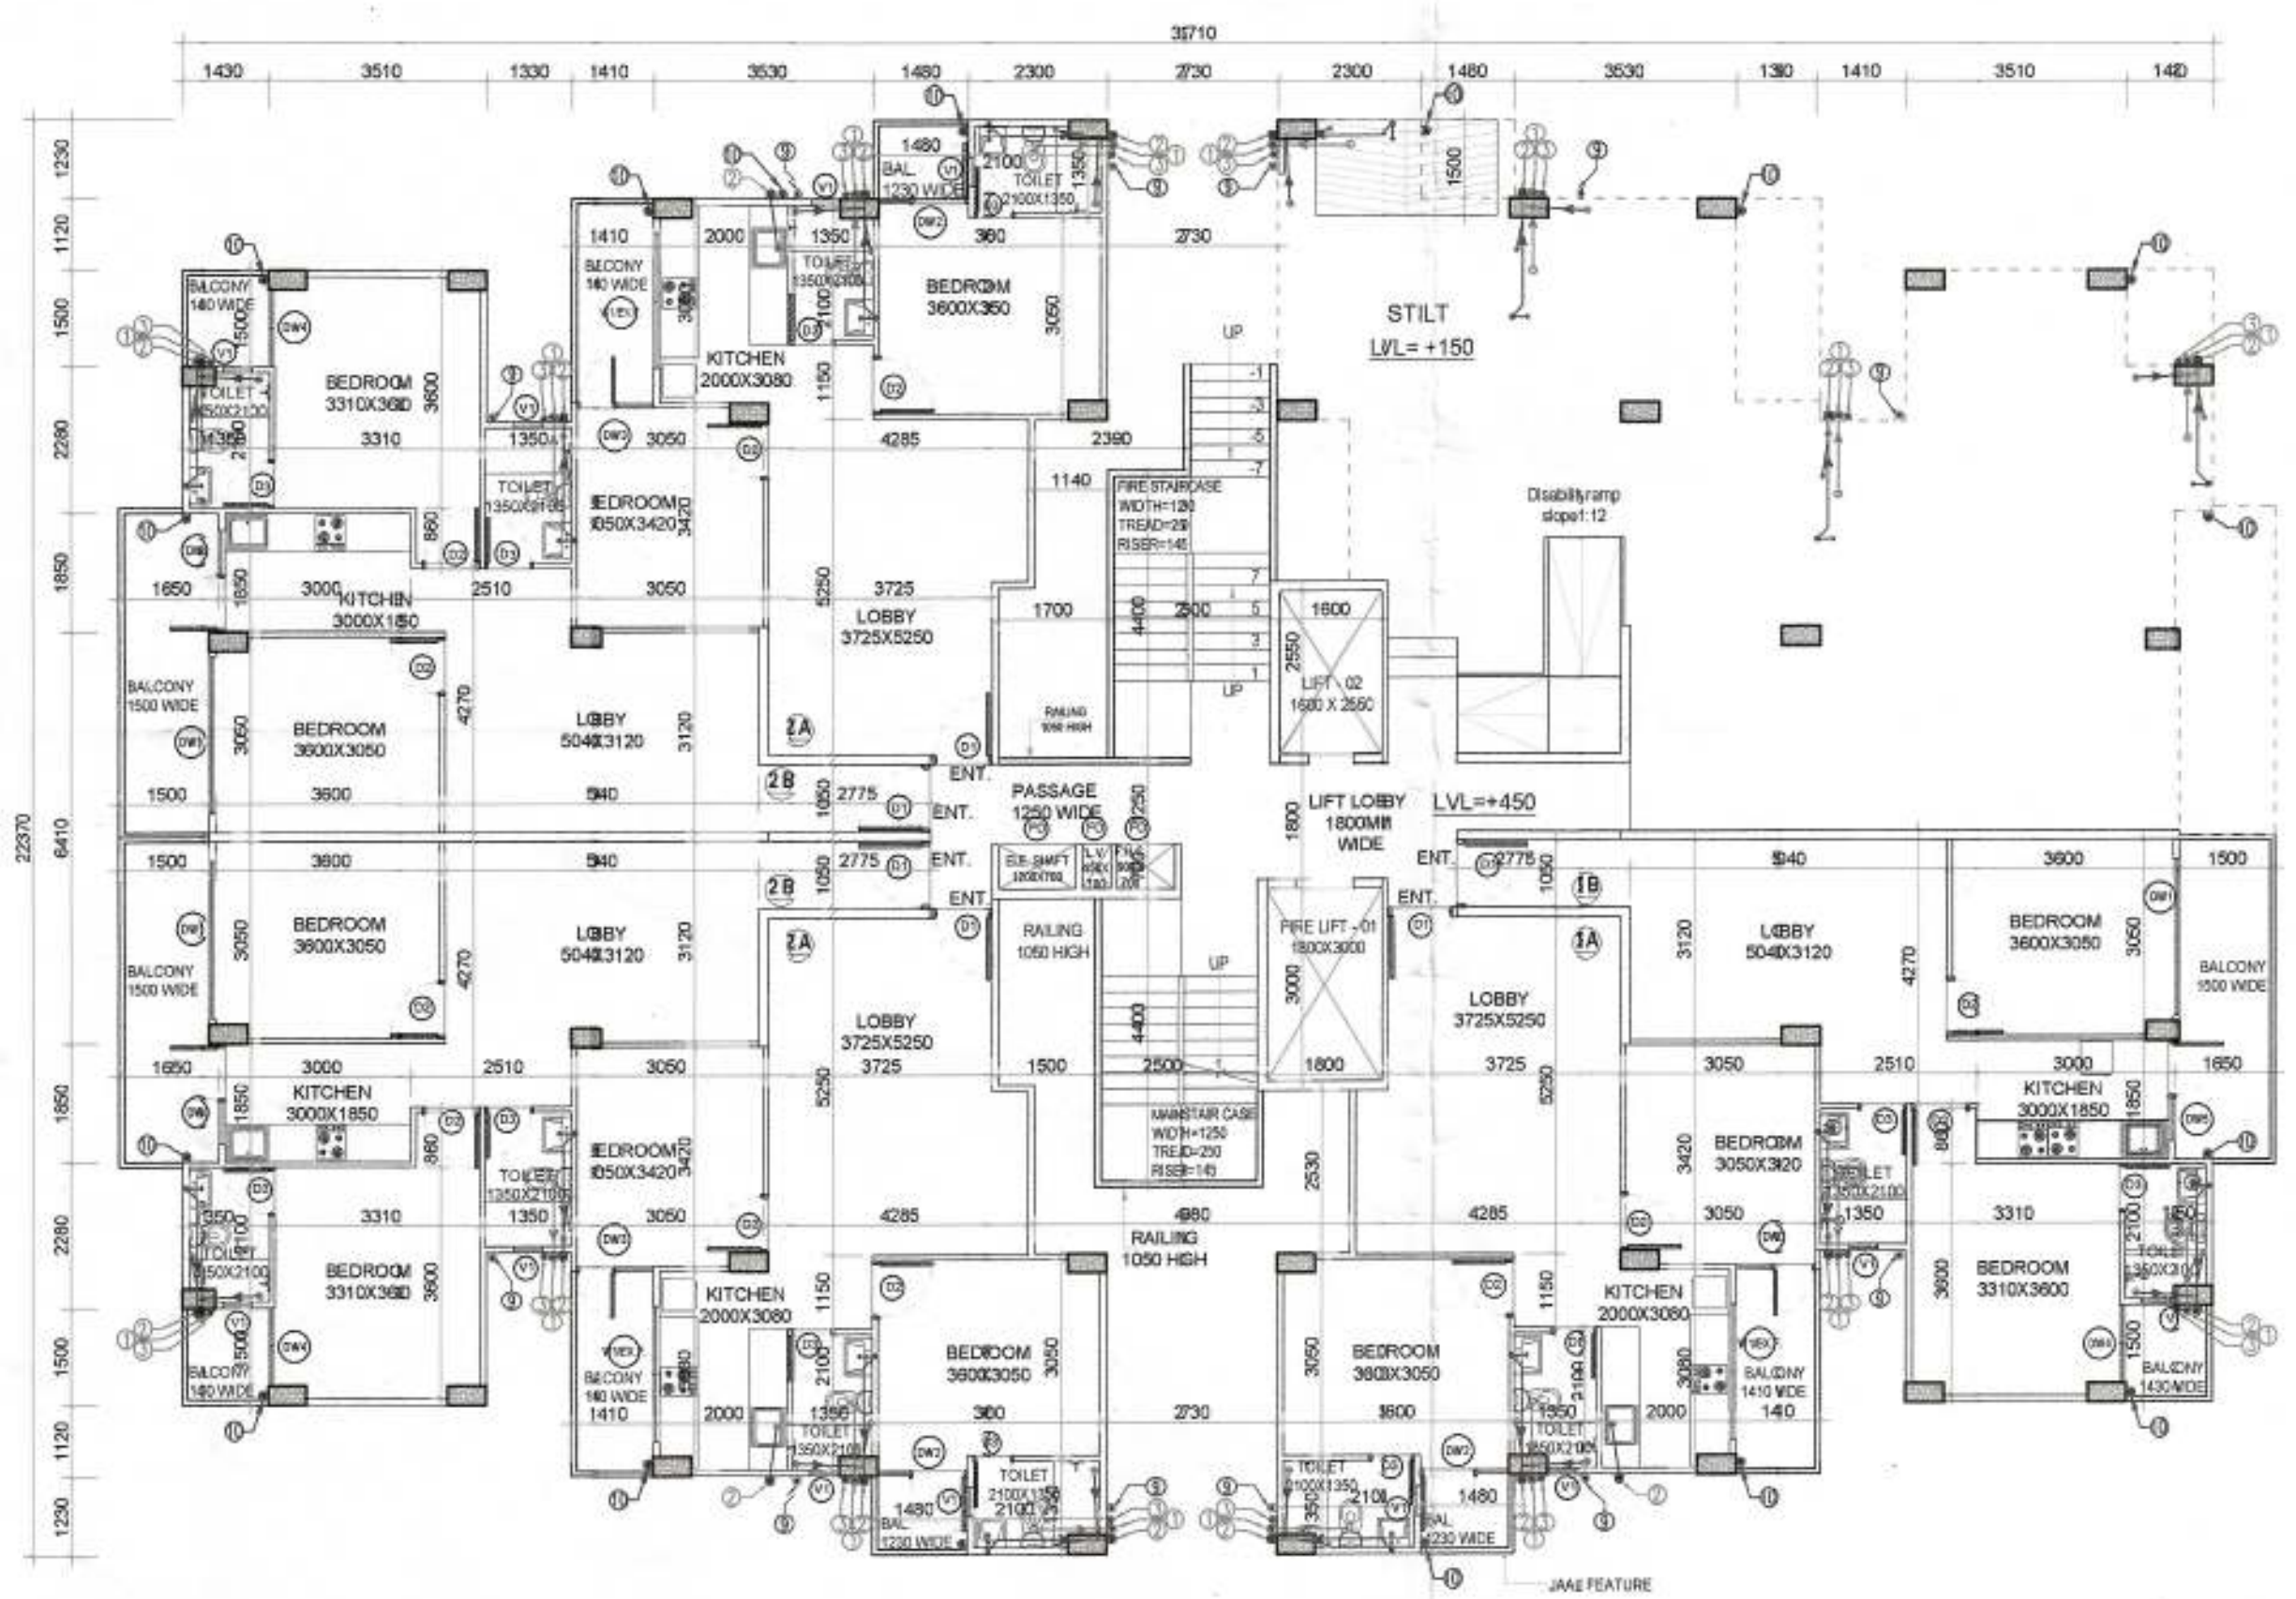


1 Ground floor Plan- Tower-A1
 TOWER A2 IS MIRROR OF A1

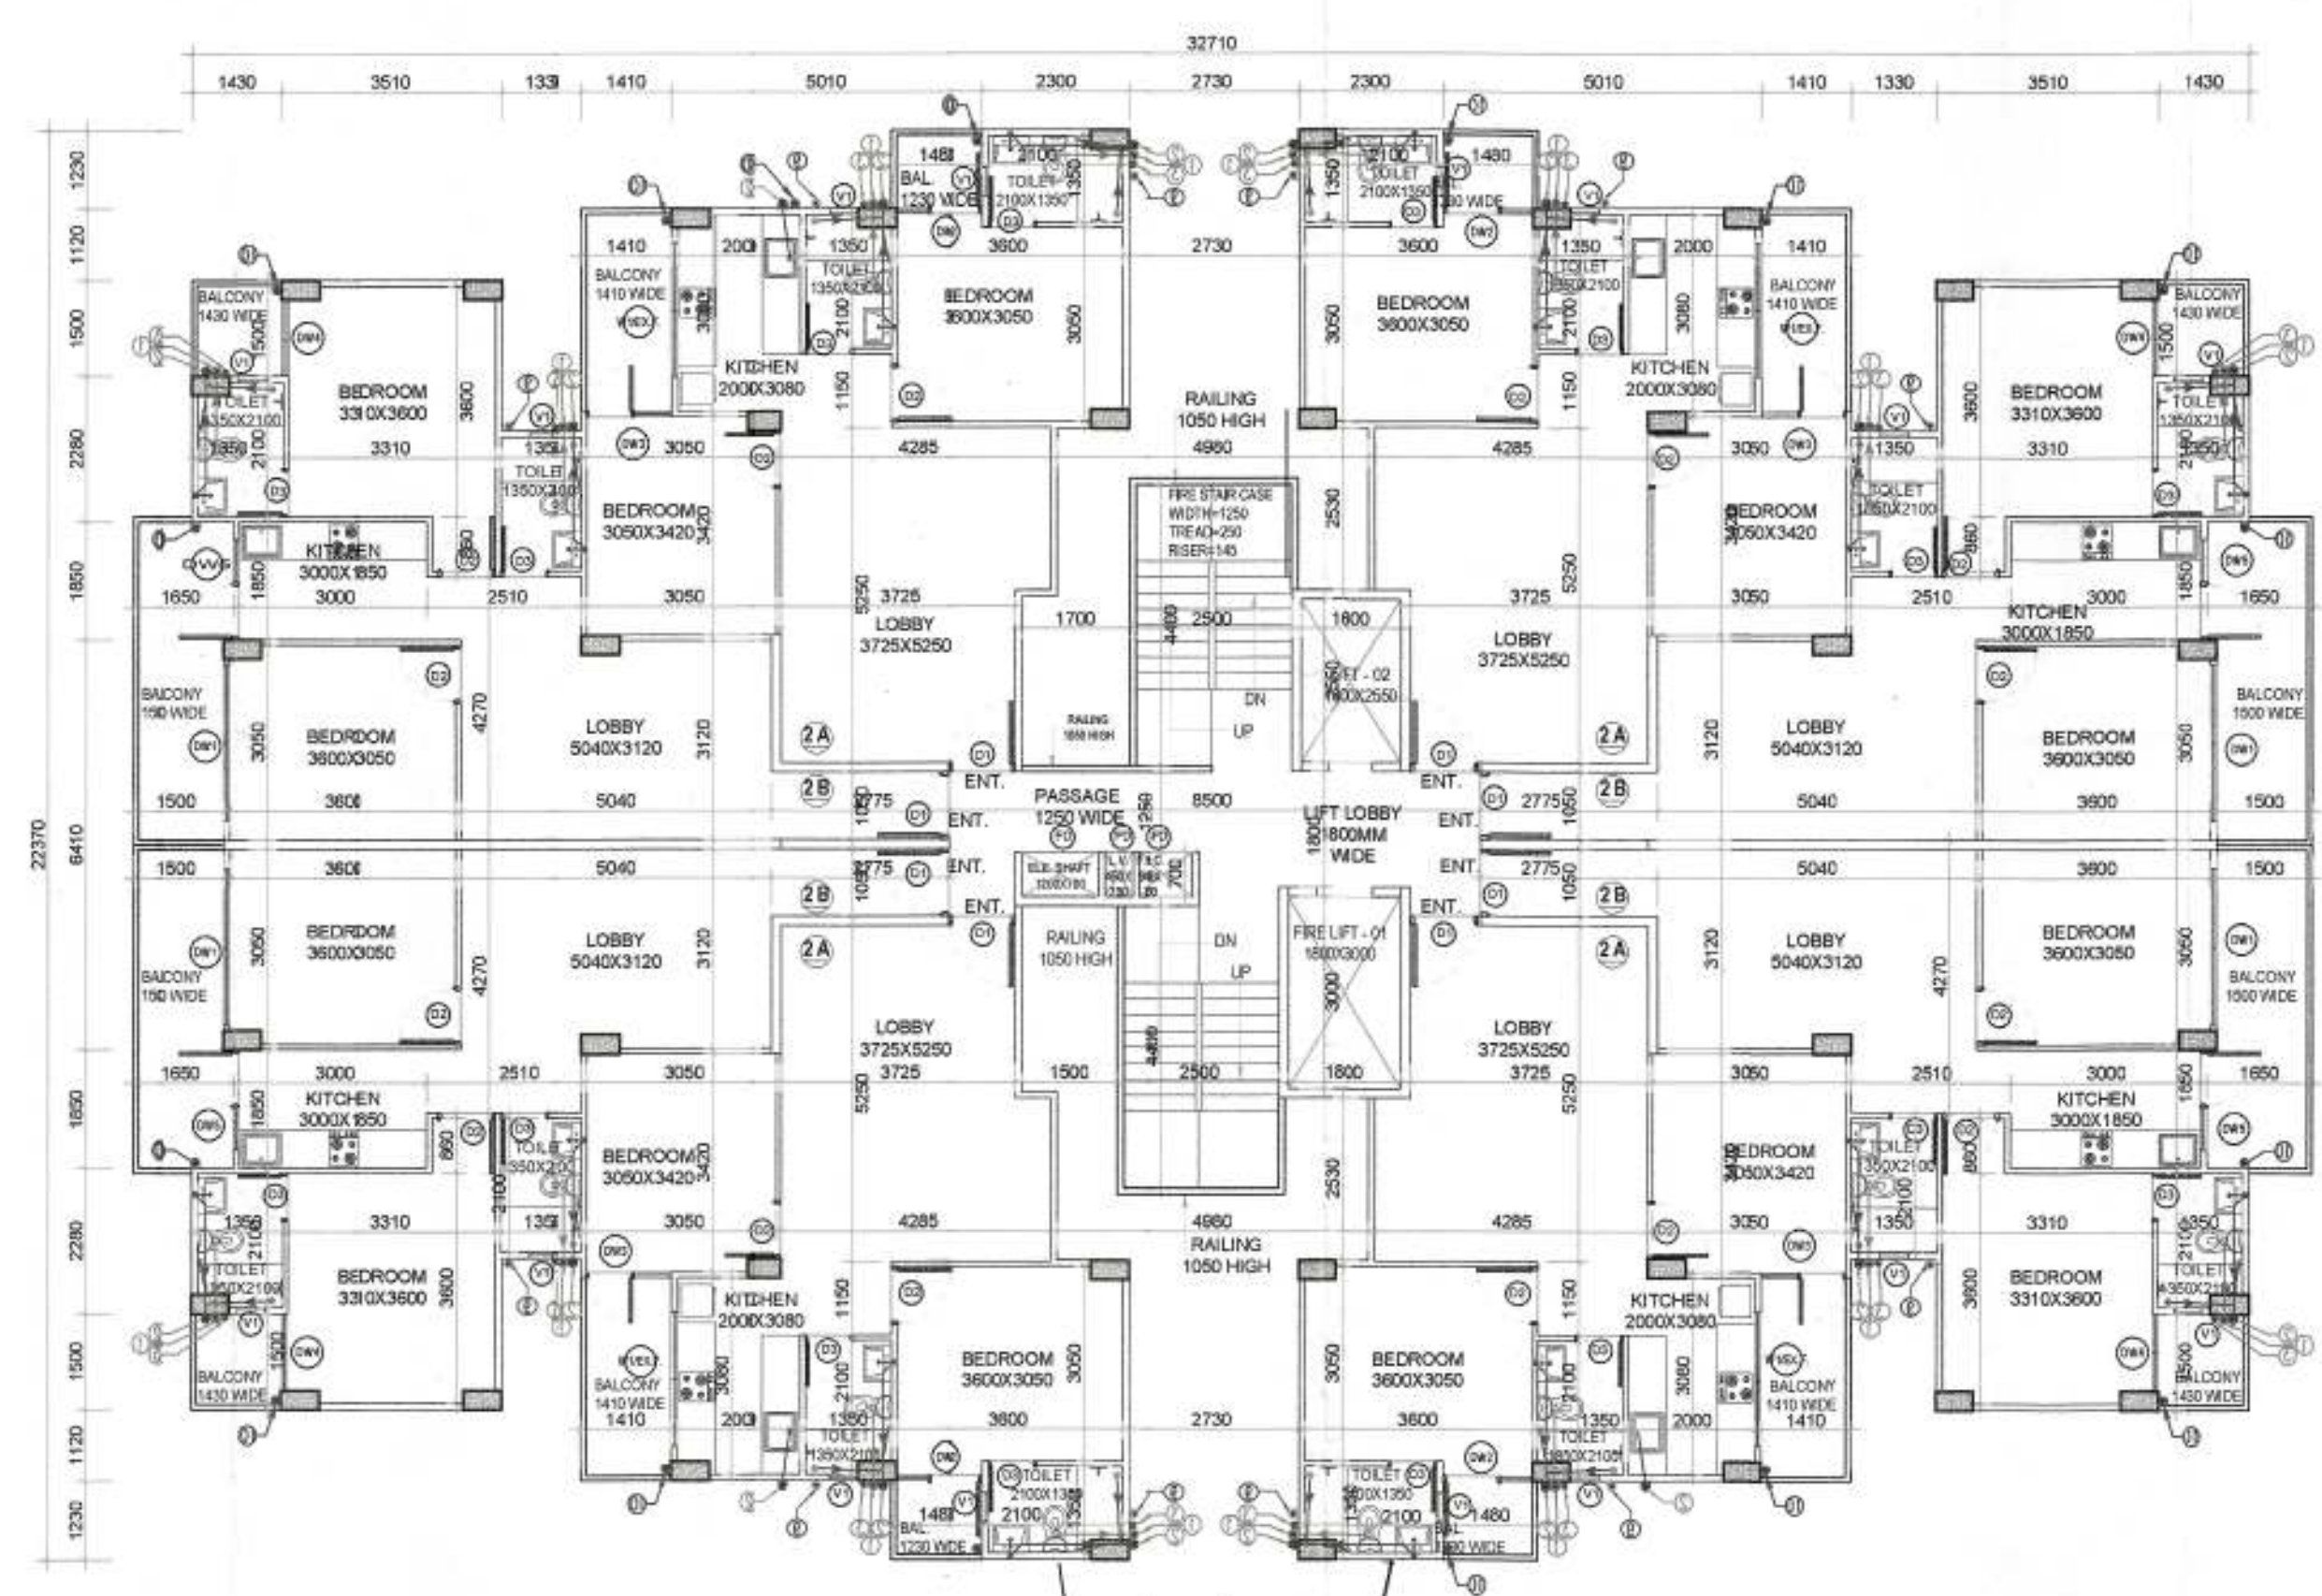

2 1st to 14th Floor- Tower A1
 TOWER A2 IS MIRROR OF A1

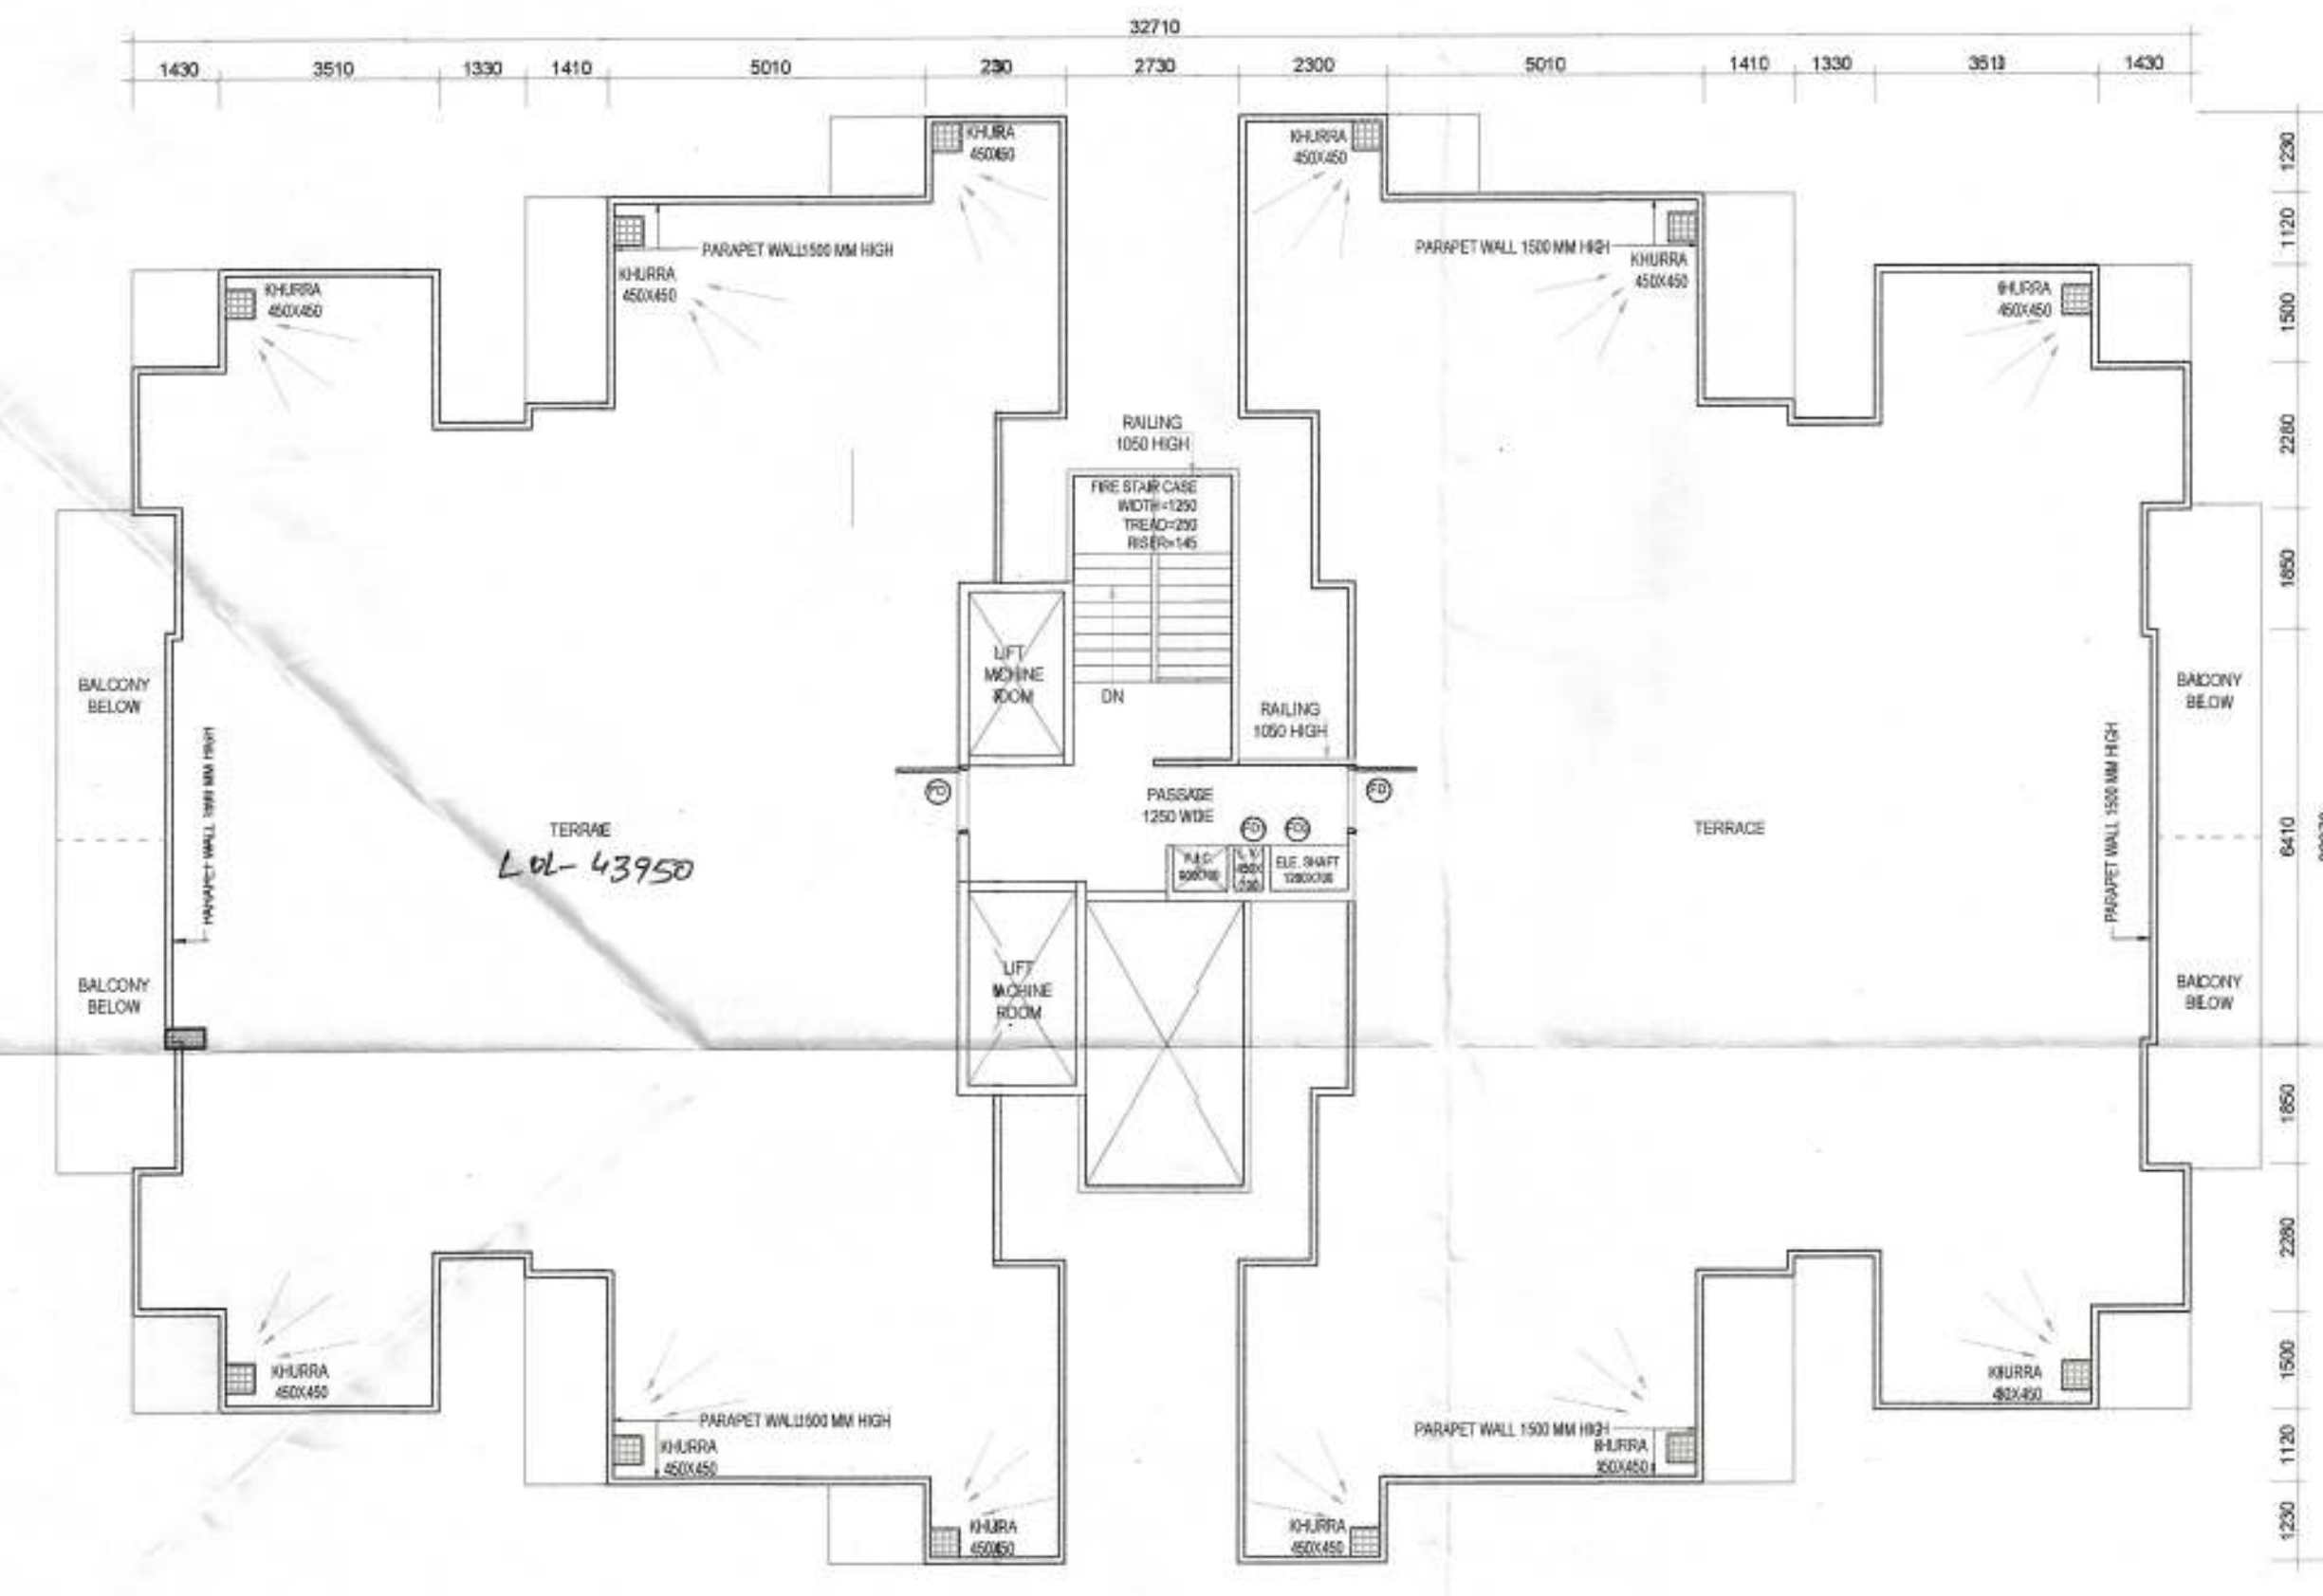

3 Terrace Floor- Tower- A1
 TOWER A2 IS MIRROR OF A1

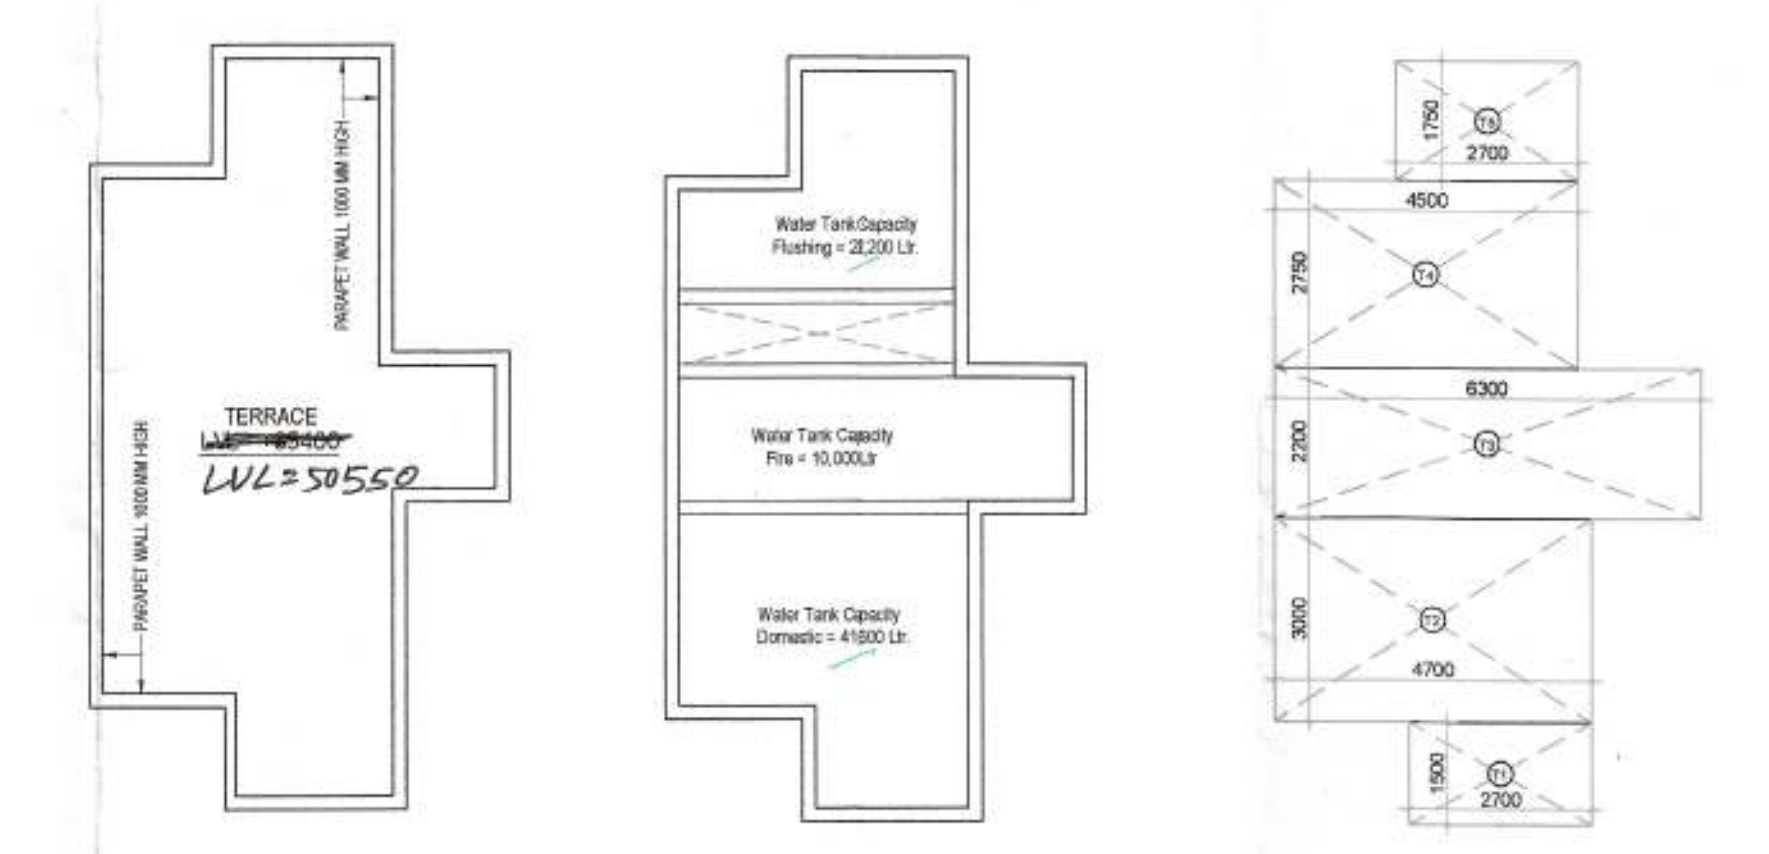

4 Mummy/Overhead water tank area DETAIL - Tower-A1
 5 OHT Plan - Tower-A1
 6 OHT Terrace - Tower-A1

PLEASE NOTE - TOWER A2 IS MIRROR OF A1

PROJECT TITLE	
PROPOSED BUILDING PLANS OF AFFORDABLE GROUP HOUSING COLONY OVER AN AREA MEASURING 5.2625 ACRES (LICENCE NO. 38 OF 2021 DATED 19/07/2021) IN SECTOR-90, GURUGRAM BEING DEVELOPED BY JAMB PROPBUILD PVT. LTD & OTHERS IN COLLABORATION WITH MRG WORLD LLP.	
OWNERS SIGNATURE	
 AVINIKA VASHISTH CA/2018/91470	
DRAWING TITLE	
LAYOUT TOWER-A1 TYPE 2A+2B (2 BHK) TOWER A2 IS MIRROR OF A1	
ARCHITECTS	
MRG DESIGN TEAM MRG World Vastu Tower, Golf Course Road Gurugram	
DATE	DWG. NO.
AUG 2021	S - 105
SCALE	
1:100	