




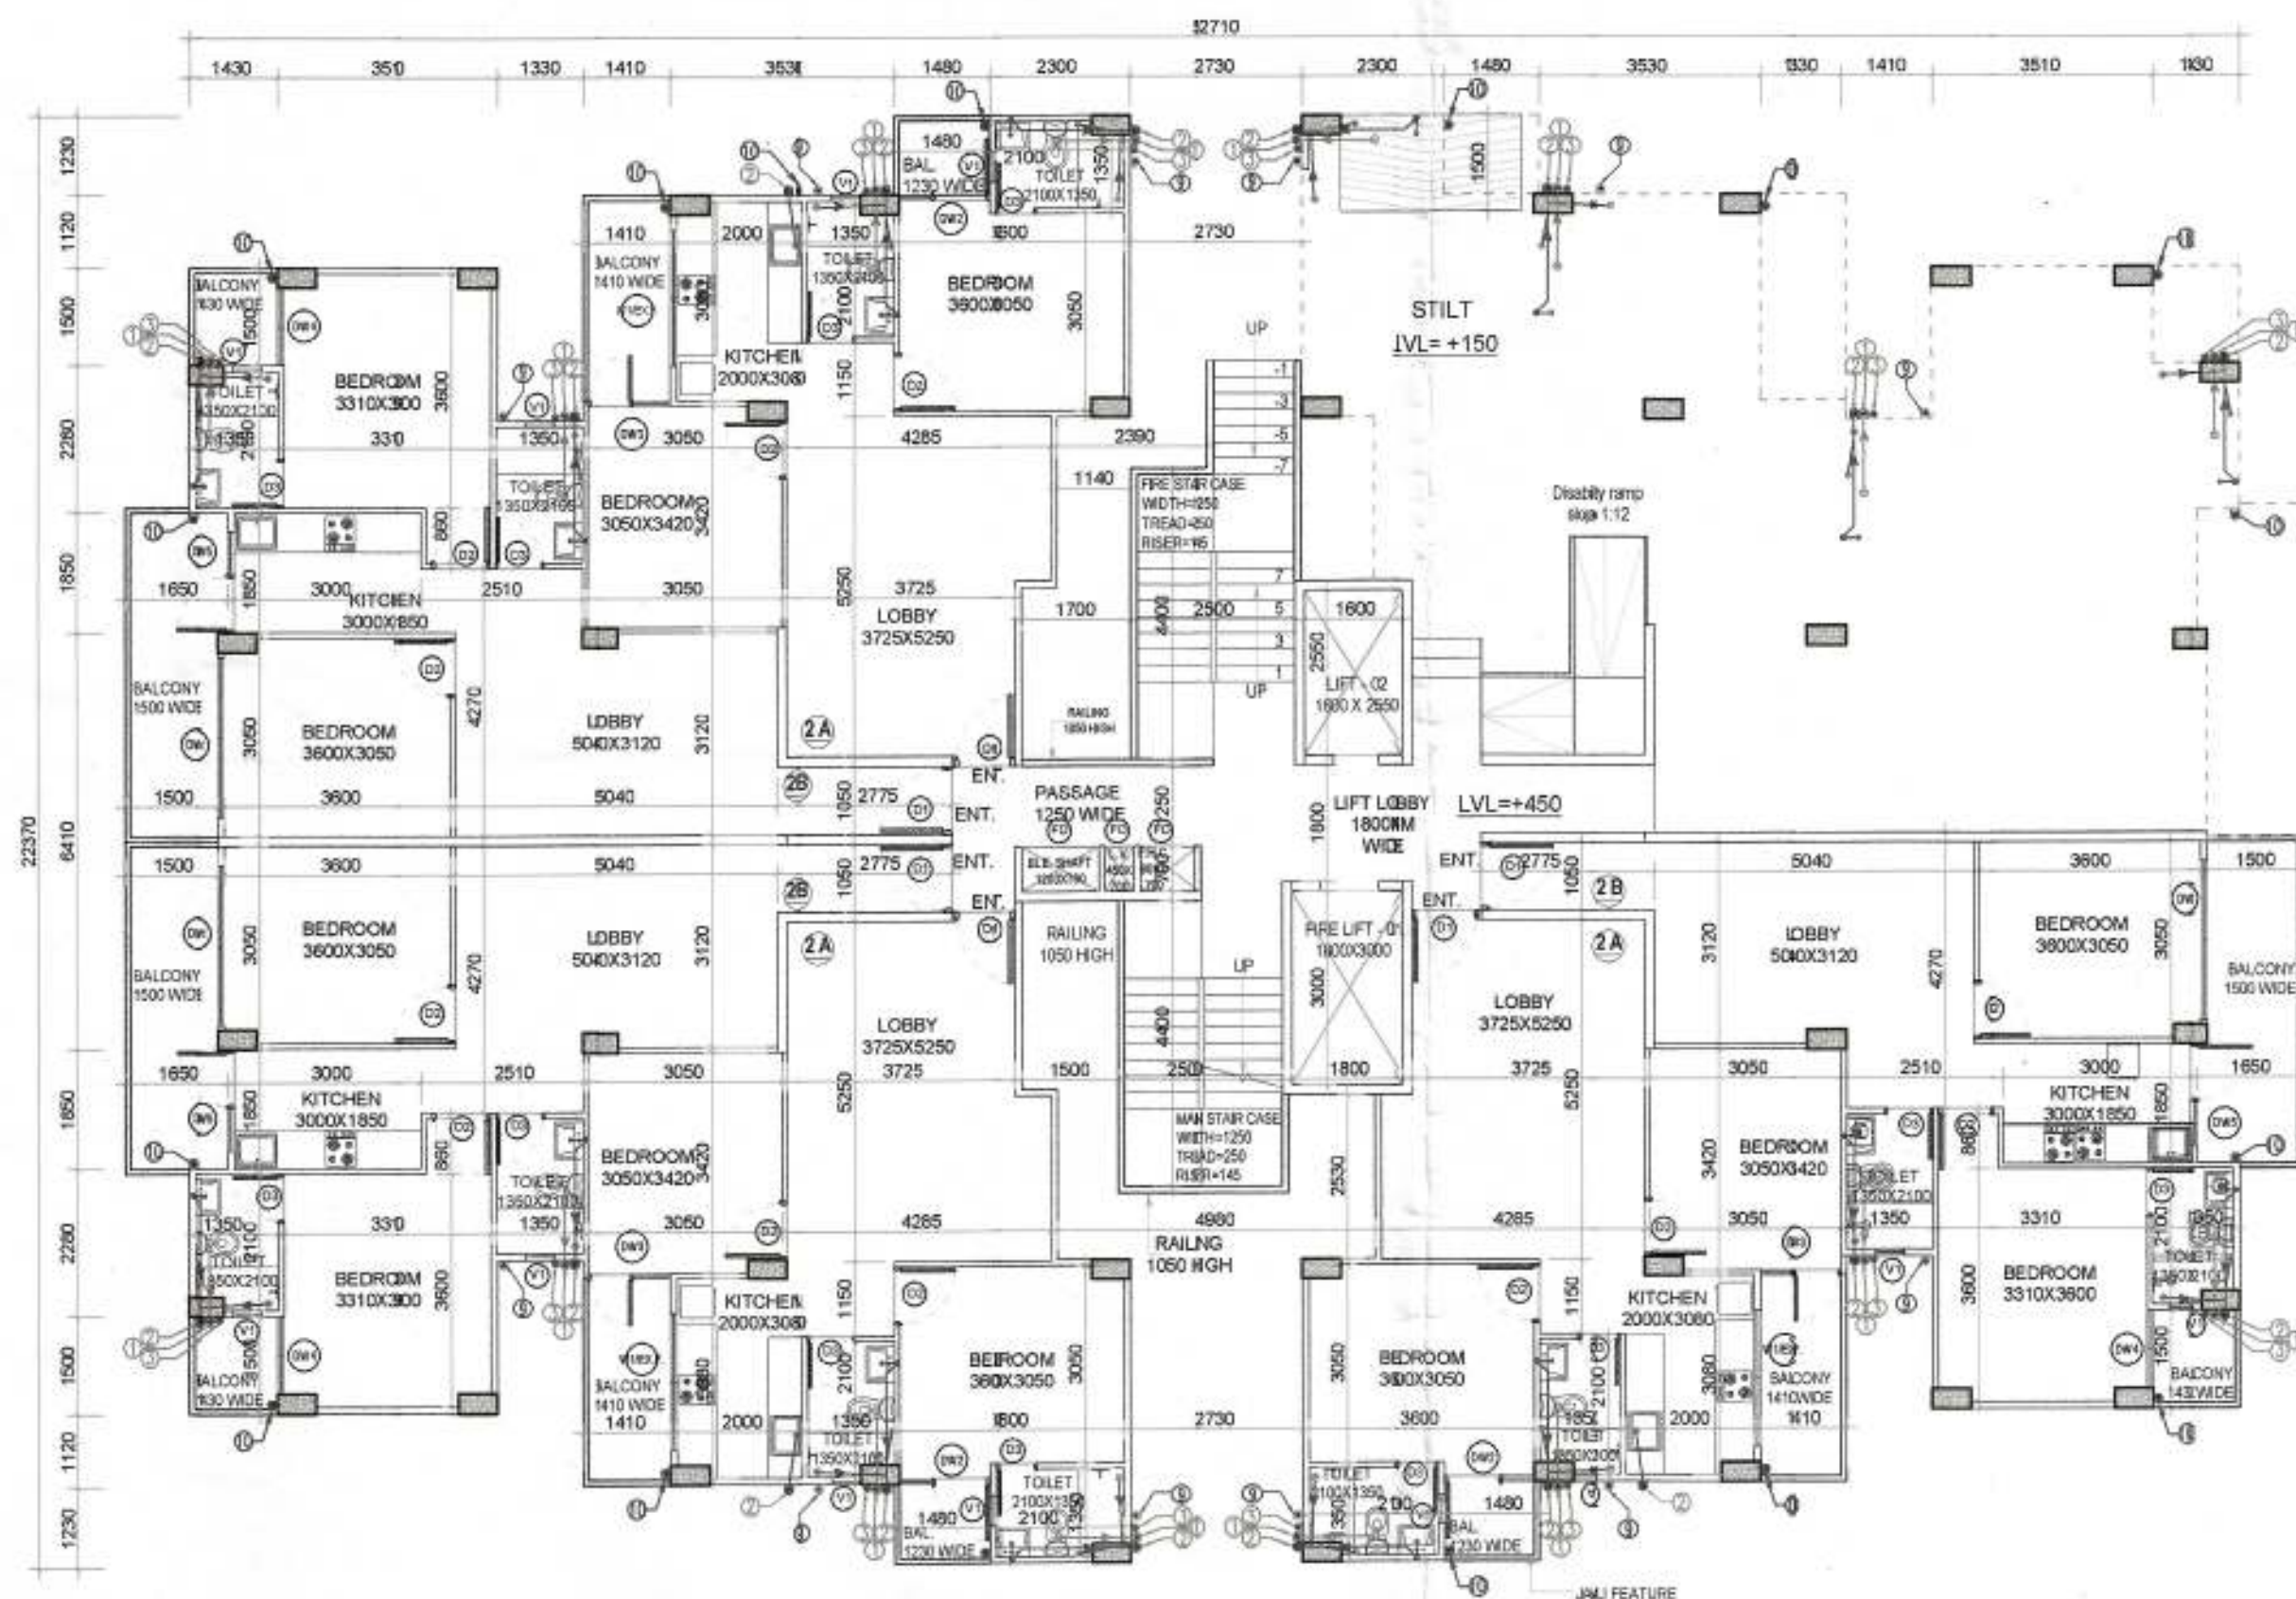


1 Ground floor Plan - Tower-A3
TOWER A4 IS MIRROR OF TOWER A3
TOWER A5 IS SAME AS TOWER A3

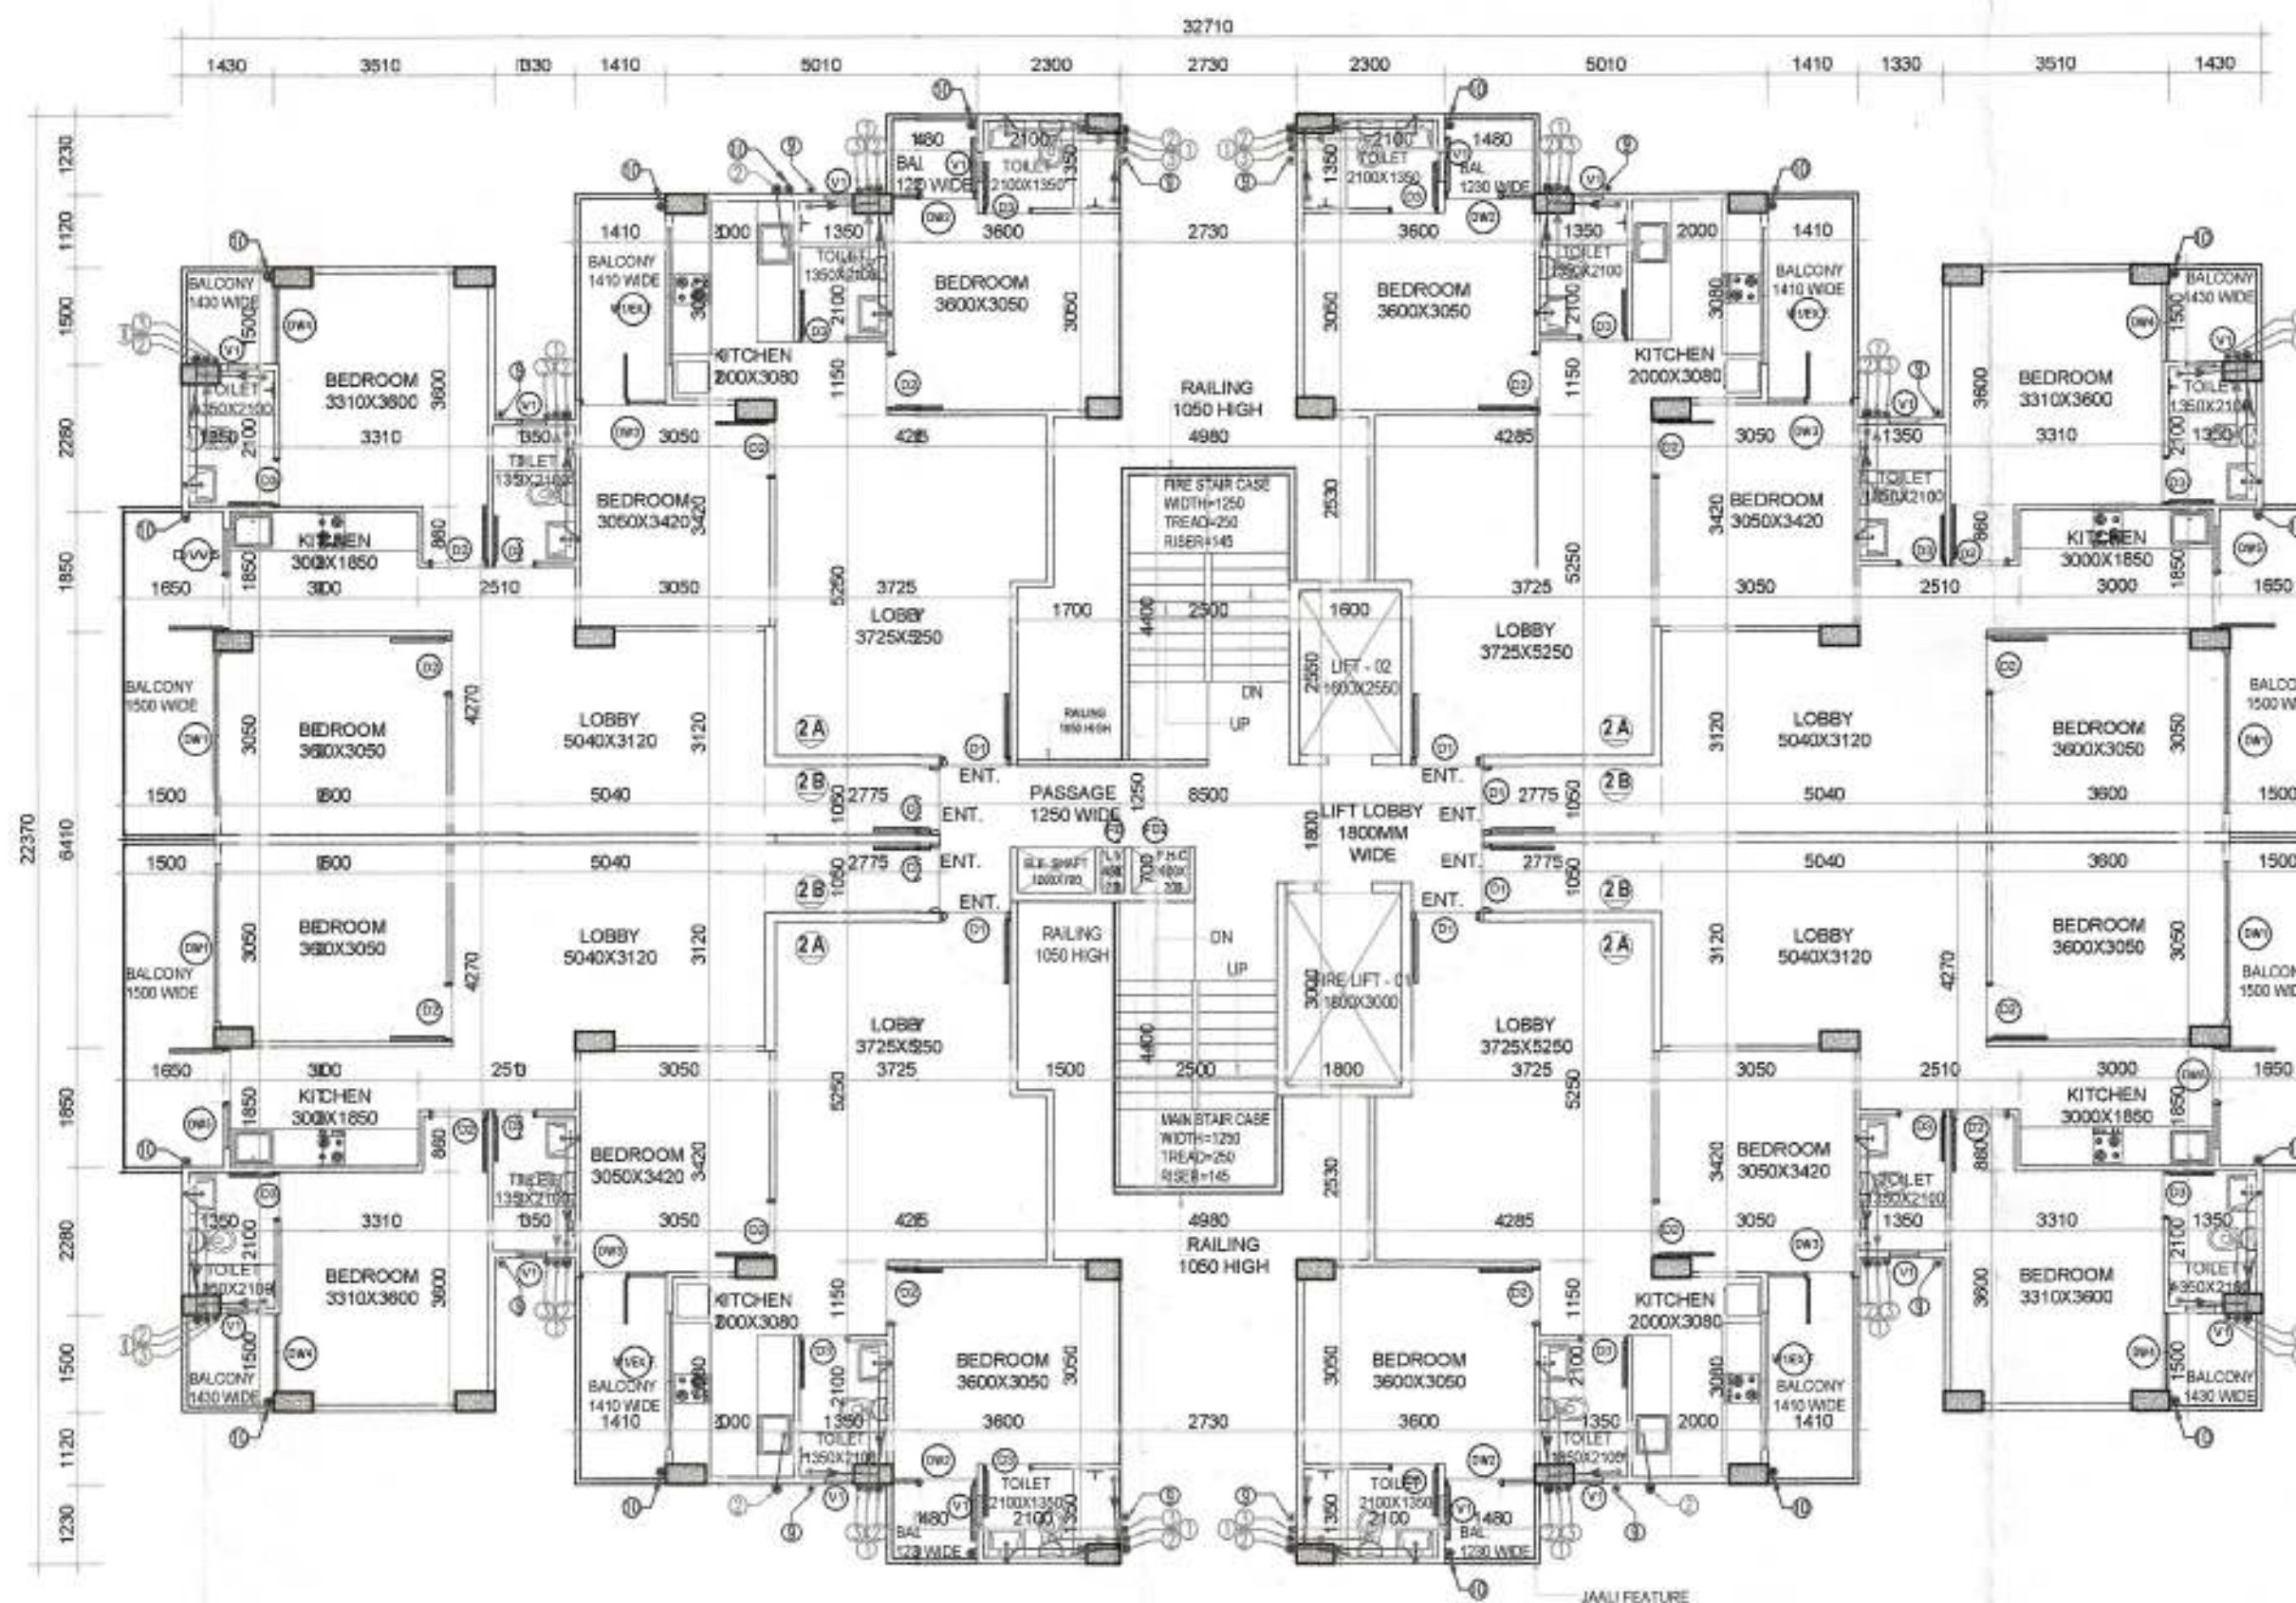


2 1st to 19th Floor - Tower A3
TOWER A4 IS MIRROR OF TOWER A3
TOWER A5 IS SAME AS TOWER A3

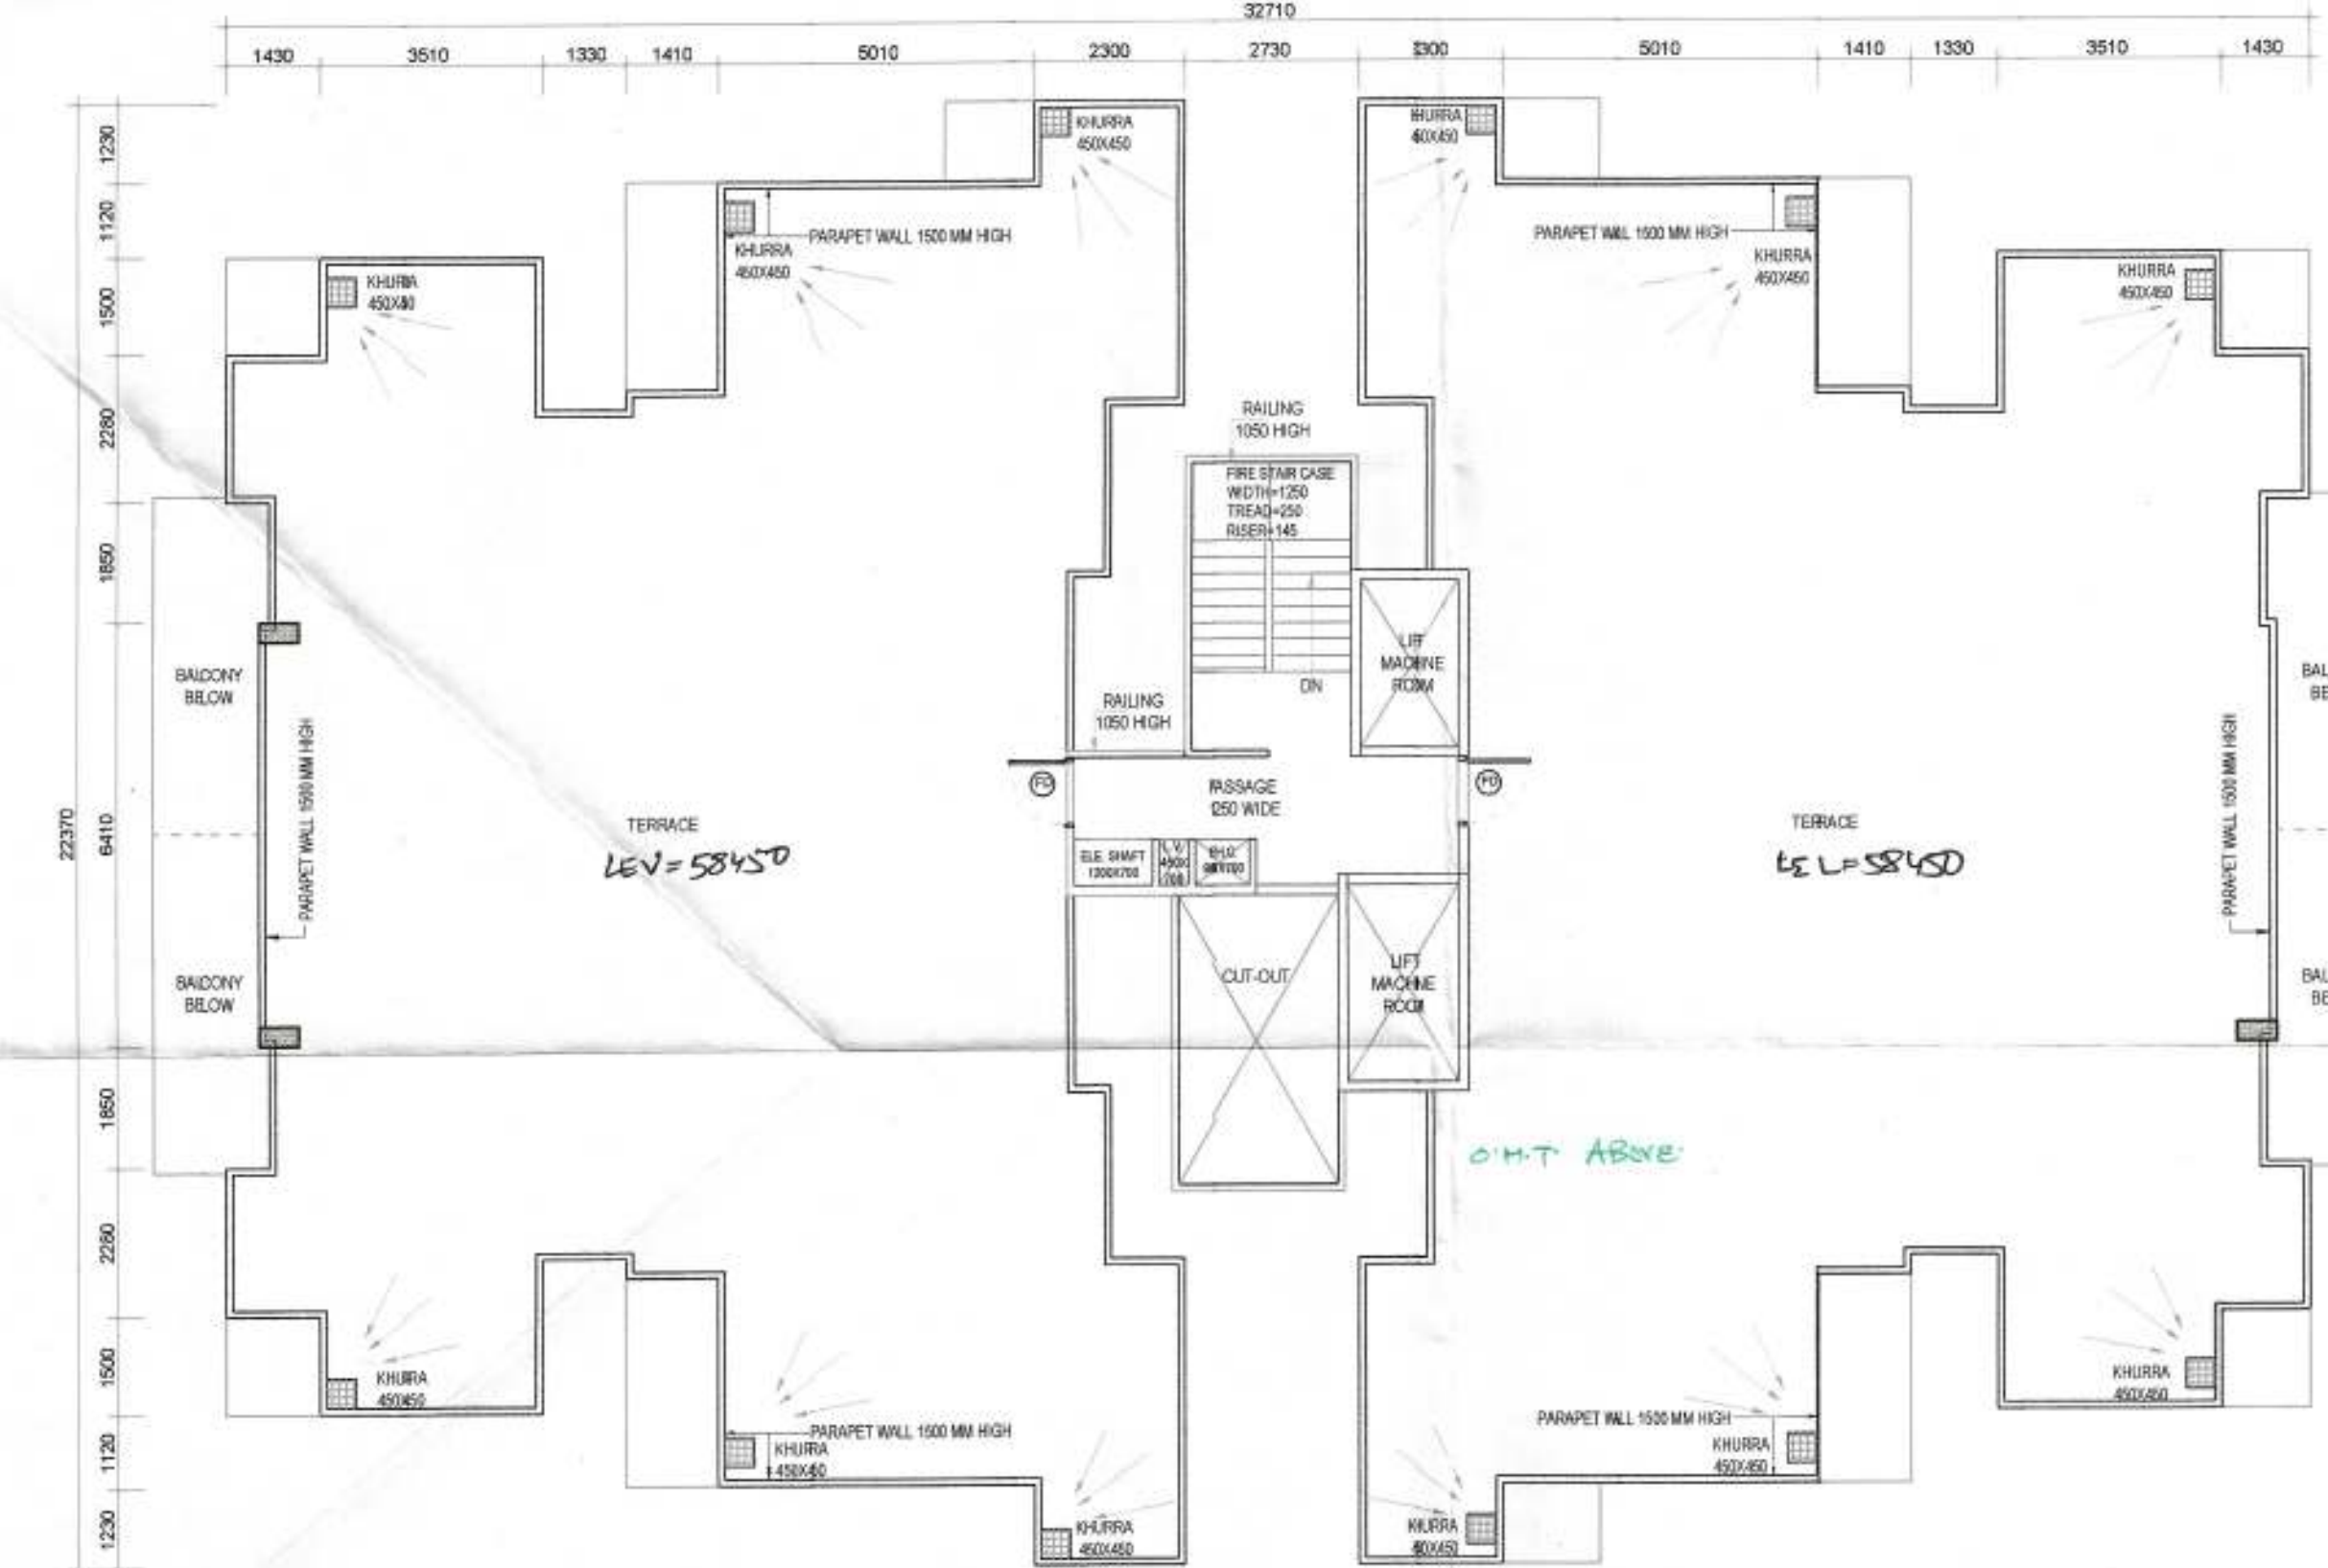


3 Terrace Floor - Tower-A3
TOWER A4 IS MIRROR OF TOWER A3
TOWER A5 IS SAME AS TOWER A3

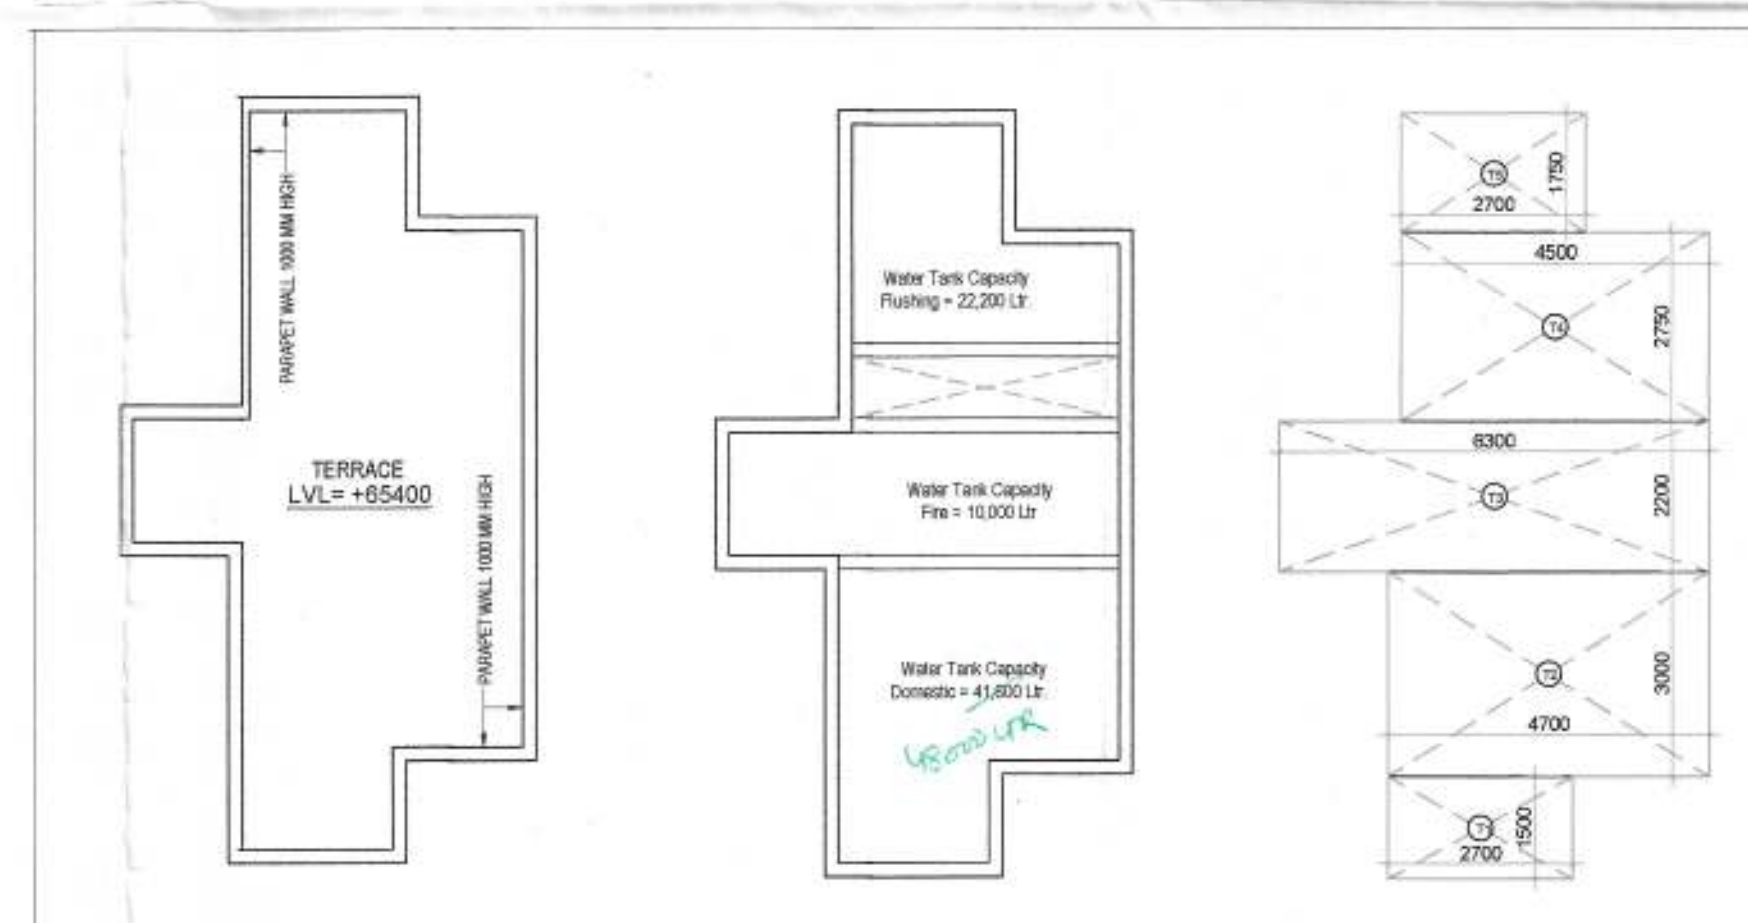

4 Mummy/Overhead water tank area DETAIL - Tower-A3

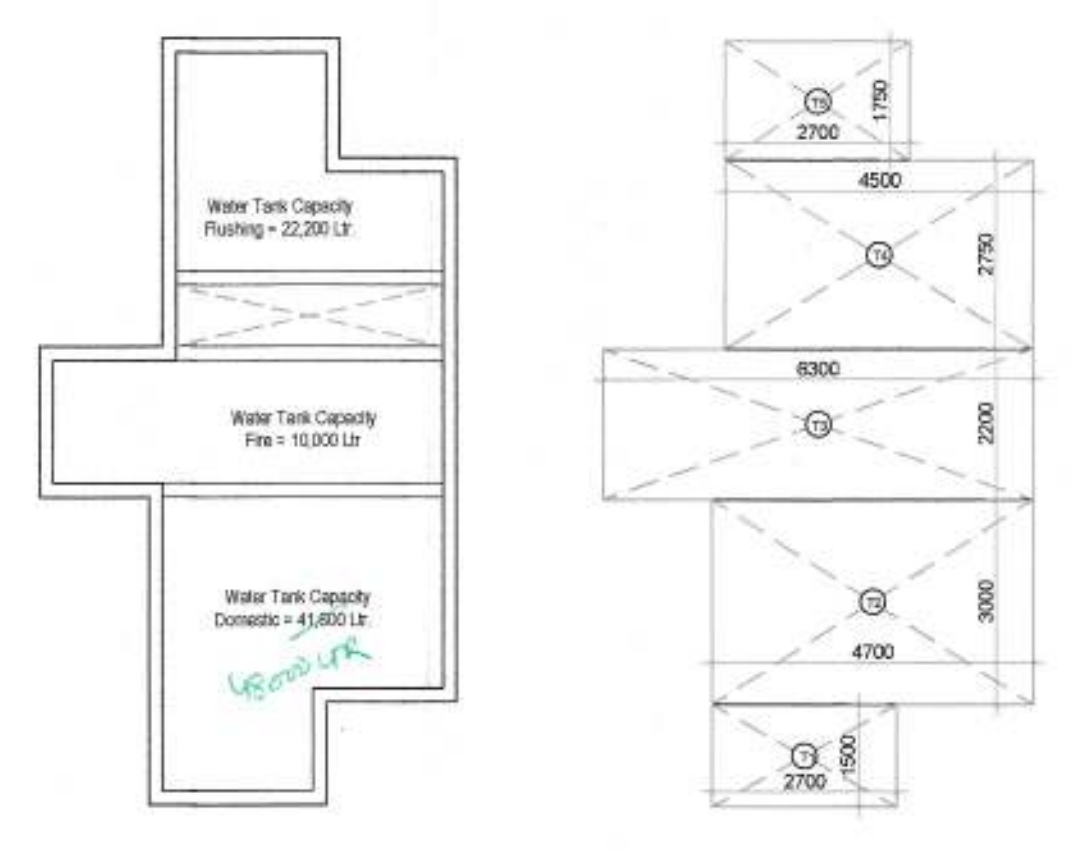

5 OHT Plan - Tower-A3

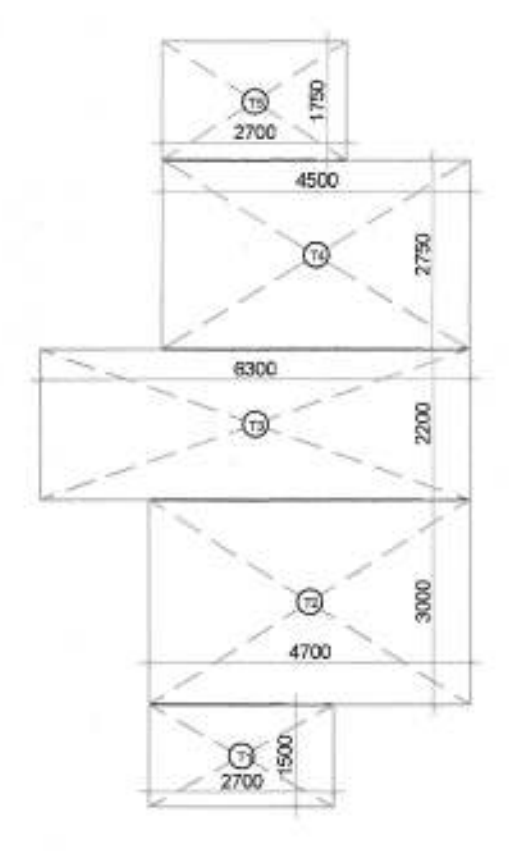

6 OHT Terrace - Tower-A3

WATER TANK CAPACITY
No. of units=158
CAP. = (158X9) X 17.5
= 24966.75 Lts.
= Say 25000 Lts.
Flushing = 23,000 Lts.
Domestic = 48,000 Lts.
Fire = 10,000 Lts.

ARCHITECT (H.Q.) STP
Member Secretary Member
B.P.C. B.P.C. B.P.C.

PA -

ATP

DINESH KUMAR
SD (HQ)

DOOR/WINDOW SCHEDULE					
SN.	Type	Width (mm)	Height (mm)	Lintel (mm)	Height (mm)
1	D1	1050	±00	+2300 (BOB)	2300
2	D2	900	+00	+2100	2100
3	D3	750	+00	+2100	2100
4	V1	450	+1350	+2100	750
5	DW1	2450	±00	+2300 (BOB)	2300
6	DW2	1400	±00	+2300 (BOB)	2300
7	DW3	1330	±00	+2300 (BOB)	2300
8	DW4	1200	±00	+2300 (BOB)	2300
9	DW5	1570	±1000	+2300 (BOB)	2300/1300

NOTE: D1 1 Hour Fire Rated Door

LEGEND	
①	110 OD SWR PVC SOIL & VENT PIPE
②	110 OD SWR PVC WASTE & VENT PIPE
③	110 OD SWR PVC ANTI-SYPHONIC PIPE
④	50mm CWS RISER TO O.H.T. FILLING TANK
⑤	50mm FWS RISER TO O.H.T. FILLING TANK
⑥	DOMESTIC WATER SUPPLY DN. TAKE PIPE
⑦	FLUSHING WATER SUPPLY DN. TAKE PIPE
⑧	110 OD uPVC RAIN WATER PIPE (TERRACE)
⑨	110 OD uPVC RAIN WATER PIPE (BALCONY)
LEGEND:-	
⑩	FIRE HOSE CABINET
⑪	9Ltr WATER GAS PRESSURE TYPE FIRE EXTINGUISHER
⑫	4.5kg CO2 TYPE FIRE EXTINGUISHER
⑬	BUTTERFLY VALVE / SLICE VALVE
NOTE:-	
EACH FIRE HOSE CABINET SHALL CONSIST OF	
1 No. - GUN/METAL SINGLE HEADED HYDRANT VALVE (63mm).	
2 Nos. - FIRE HOSES 63mm 15M LONG WITH ACCESSORIES.	
1 No - SHORT BRANCH	
1 No - FIRST AID HOSE REEL	
2 Nos - FIRE EXTINGUISHERS	
1 No - FIRE MAN'S AXE.	

PROJECT TITLE
PROPOSED BUILDING PLANS OF AFFORDABLE GROUP HOUSING COLONY OVER AN AREA MEASURING 5.2625 ACRES (LICENCE NO. 38 OF 2021 DATED 19/07/2021) IN SECTOR-90, GURUGRAM BEING DEVELOPED BY JAMB PROPBUILD PVT. LTD & OTHERS IN COLLABORATION WITH MRG WORLD LLP.

OWNER'S SIGNATURE

ARCHITECT'S SIGNATURE
AVANIKA VASHISTH
2018/9/670

DRAWING TITLE
LAYOUT TOWER-A3
TOWER A4 IS MIRROR OF TOWER A3
TOWER A5 IS SAME AS TOWER A3

ARCHITECTS
MRG DESIGN TEAM
MRG World
Vastu, Town, Golf Course Road
Gurgaon

DATE
AUG 2021
DWG. NO.
S - 107

PLEASE NOTE
TOWER A4 IS MIRROR OF TOWER A3
TOWER A5 IS SAME AS TOWER A3