


PLUMBING & FIRE SERVICES LEGEND :	
	SEWER MANHOLE WITH 5600 S.F.R.C. MANHOLE COVER.
	STORM WATER MANHOLE WITH 5600 S.F.R.C. PERFORATED MANHOLE COVER.
	EXTERNAL SW SEWER LINE (DIA AS / DESIGN CHART)
	EXTERNAL RCC STORM WATER LINE (DIA AS / DESIGN CHART)
	MUNICIPAL WATER SUPPLY LINE
	DOMESTIC WATER SUPPLY LINE
	FLUSHING WATER SUPPLY LINE
	GARDEN IRRIGATION WATER SUPPLY LINE
	FIRE WET RISER RING MAIN PIPE FOR FHC & EFH
	SPRINKLER FIRE LINE
	EXTERNAL FIRE HYDRANT
	GARDEN HYDRANT WITH CHAMBER (300x300) MM
	RECHARGE PIT, 3000 MM DIA
	DESILTING CHAMBER (1000 x 2000)MM

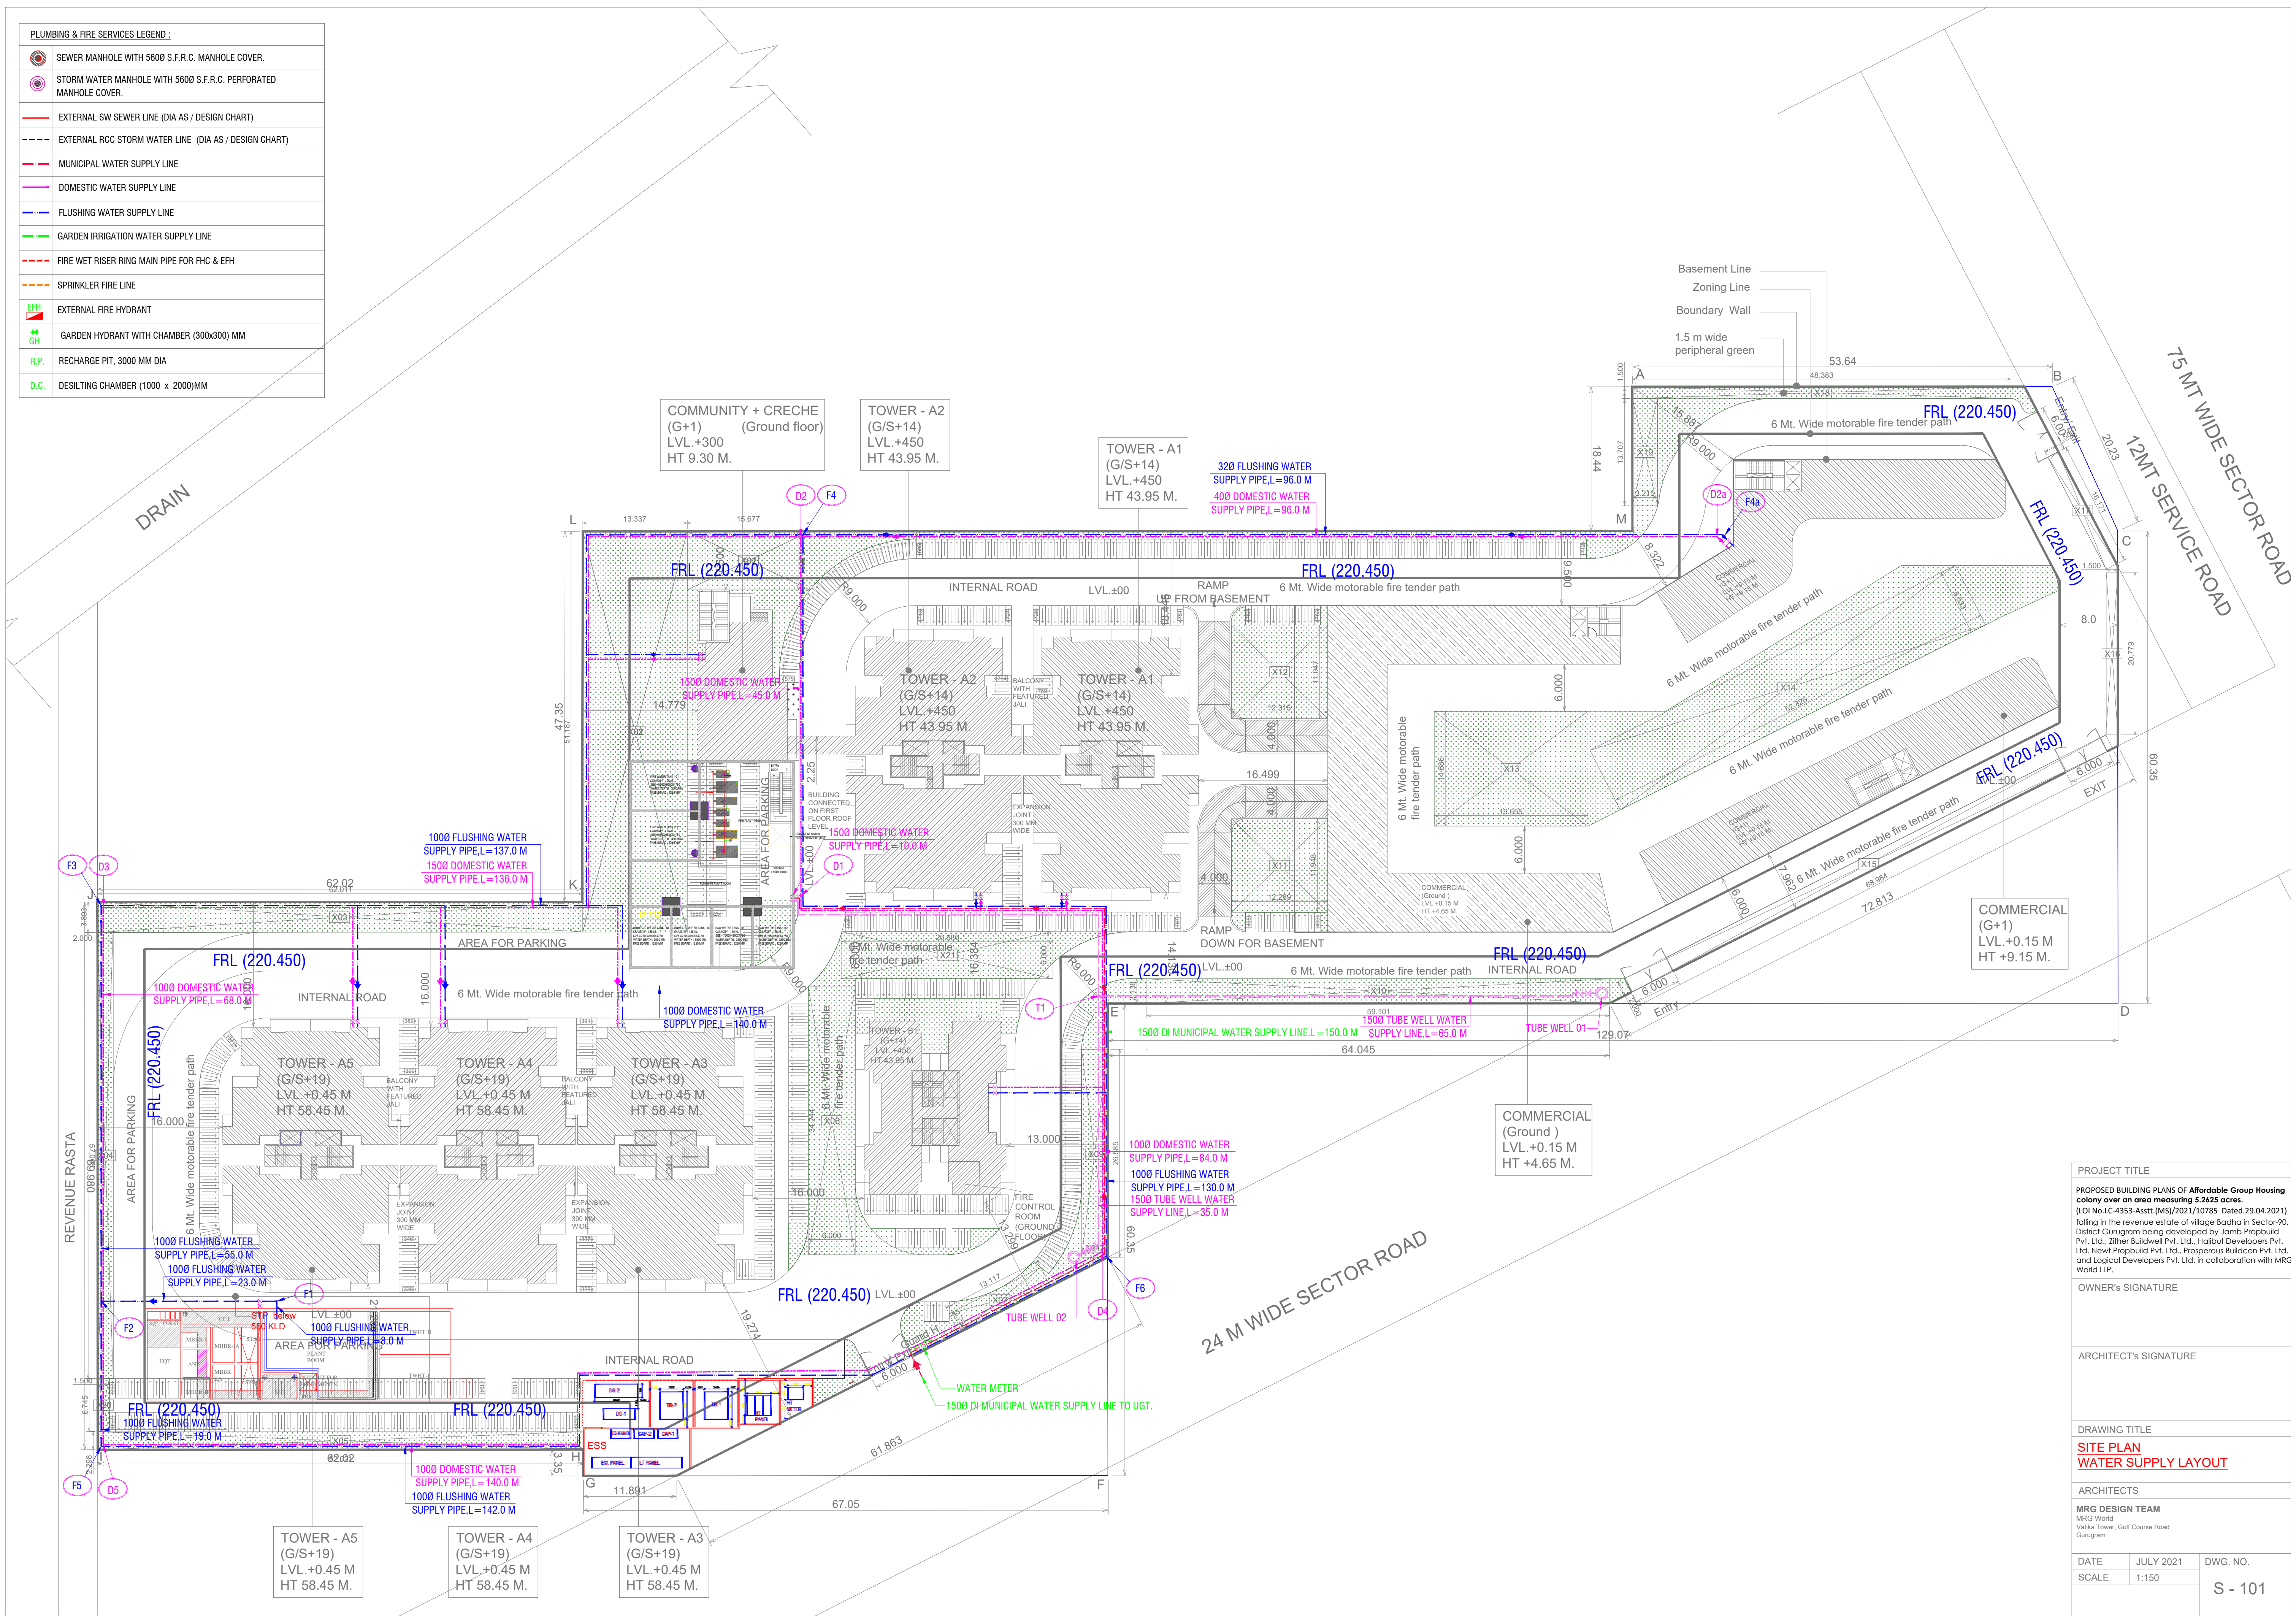

PROJECT TITLE		
PROPOSED BUILDING PLANS OF Affordable Group Housing colony over an area measuring 5.2625 acres. (LOI No.LC-4353-Asstt.(MS)/2021/10785 Dated 29.04.2021) falling in the revenue estate of village Badha in Sector-90, District Gurugram being developed by Jamb Propbuild Pvt. Ltd., Zither Buildwell Pvt. Ltd., Hatibut Developers Pvt. Ltd., Newli Propbuild Pvt. Ltd., Prosperous Buildcon Pvt. Ltd. and Logical Developers Pvt. Ltd. in collaboration with MRG World LLP.		
OWNER'S SIGNATURE		
ARCHITECT'S SIGNATURE		
DRAWING TITLE		
SITE PLAN WATER SUPPLY LAYOUT		
ARCHITECTS		
MRG DESIGN TEAM MRG World Vatika Tower, Golf Course Road Gurugram		
DATE	JULY 2021	DWG. NO.
SCALE	1:150	S - 101