


| PLUMBING & FIRE SERVICES LEGEND |                                                                  |
|---------------------------------|------------------------------------------------------------------|
|                                 | SEWER MANHOLE WITH 5000 S.F.R.C. MANHOLE COVER.                  |
|                                 | STORM WATER MANHOLE WITH 5000 S.F.R.C. PERFORATED MANHOLE COVER. |
|                                 | EXTERNAL SW SEWER LINE (DIA AS / DESIGN CHART)                   |
|                                 | EXTERNAL RCC STORM WATER LINE (DIA AS / DESIGN CHART)            |
|                                 | MUNICIPAL WATER SUPPLY LINE                                      |
|                                 | DOMESTIC WATER SUPPLY LINE                                       |
|                                 | FLUSHING WATER SUPPLY LINE                                       |
|                                 | GARDEN IRRIGATION WATER SUPPLY LINE                              |
|                                 | FIRE WET RISER RING MAIN PIPE FOR FHC & ERI                      |
|                                 | SPRINKLER FIRE LINE                                              |
|                                 | EXTERNAL FIRE HYDRANT                                            |
|                                 | GARDEN HYDRANT WITH CHAMBER (300x300) MM                         |
|                                 | RECHARGE PIT, 3000 MM DIA                                        |
|                                 | DESILTING CHAMBER (1000 x 2000)MM                                |

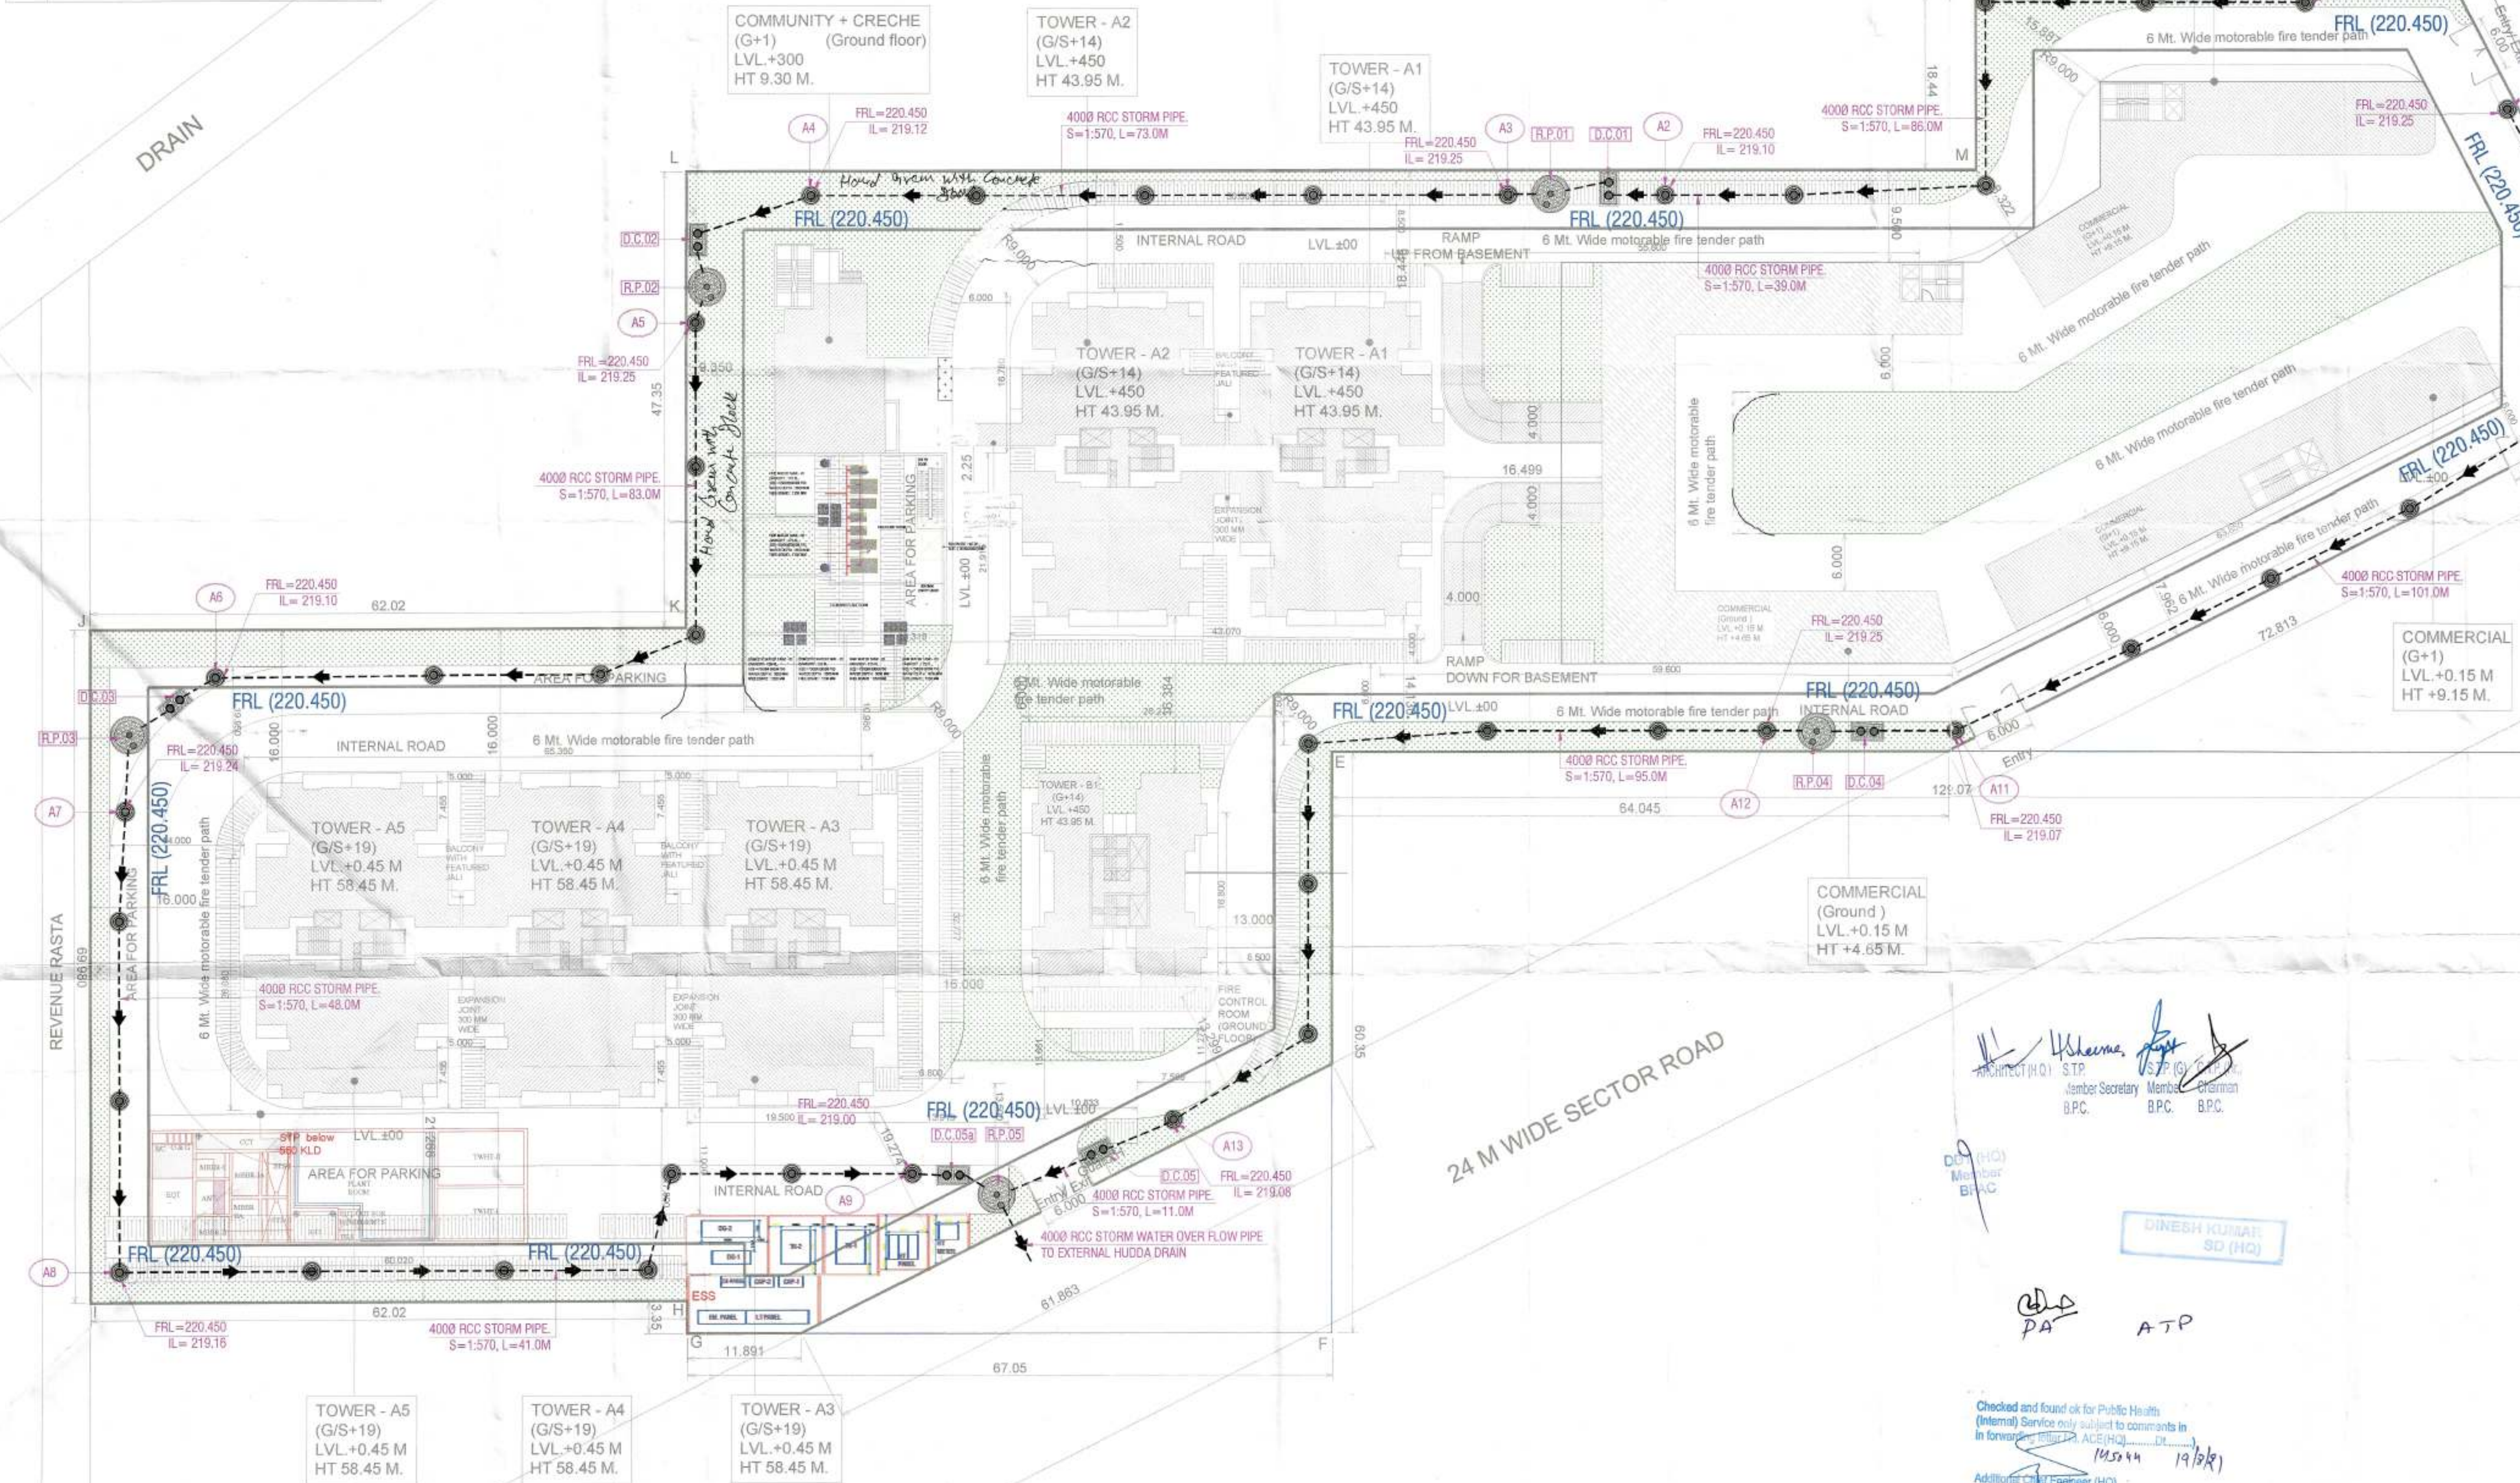

|                                                                                                                                                                                                                                                         |          |
|---------------------------------------------------------------------------------------------------------------------------------------------------------------------------------------------------------------------------------------------------------|----------|
| PROJECT TITLE                                                                                                                                                                                                                                           |          |
| PROPOSED BUILDING PLANS OF AFFORDABLE GROUP HOUSING COLONY OVER AN AREA MEASURING 5.2625 ACRES (LICENCE NO. 38 OF 2021 DATED 19/07/2021) IN SECTOR-90, GURUGRAM BEING DEVELOPED BY JAMB PROPBUILD PVT. LTD & OTHERS IN COLLABORATION WITH MRG WORLD LLP |          |
| OWNER'S SIGNATURE                                                                                                                                                                                                                                       |          |
| ARCHITECT'S SIGNATURE                                                                                                                                                                                                                                   |          |
| DRAWING TITLE                                                                                                                                                                                                                                           |          |
| SITE PLAN<br>STORM WATER LAYOUT                                                                                                                                                                                                                         |          |
| ARCHITECTS                                                                                                                                                                                                                                              |          |
| MRG DESIGN TEAM<br>MRG World<br>Vatika Tower, Golf Course Road<br>Gurgaon                                                                                                                                                                               |          |
| DATE                                                                                                                                                                                                                                                    | AUG-2021 |
| SCALE                                                                                                                                                                                                                                                   | 1:150    |
| DWG. NO.                                                                                                                                                                                                                                                | PL - 102 |

ARCHITECT (HQ) S.T.P.  
 Member Secretary B.P.C.  
  
 Member B.P.C.  
  
 Chairman B.P.C.

Member B.P.C.

DINESH KUMAR SD (HQ)

PA

ATP

Checked and found ok for Public Health  
 (Internal) Service only subject to comments in  
 in forwarding to ACE(HQ) Dr.

14/5/24 19/5/24  
 Addl. Chief Engineer (HQ)  
 HSVP, Panchsala