

ARCHITECT (H.O.) S.T.P.
Member Secretary
B.P.C.

MEMBER (G)
B.P.C.

MEMBER (H)
B.P.C.


Ram Avtar Bassi
AD(HQ)

Checked and found ok for Public Health
(Internal) Service only subject to comments in
in forwarding letter to ACE(HQ)..... DL-29/1/21

Additional Chief Engineer (HQ)
HSVP, Panchkula

DDT (T)
MEMBER
BPAO

P.A. A.T.P.

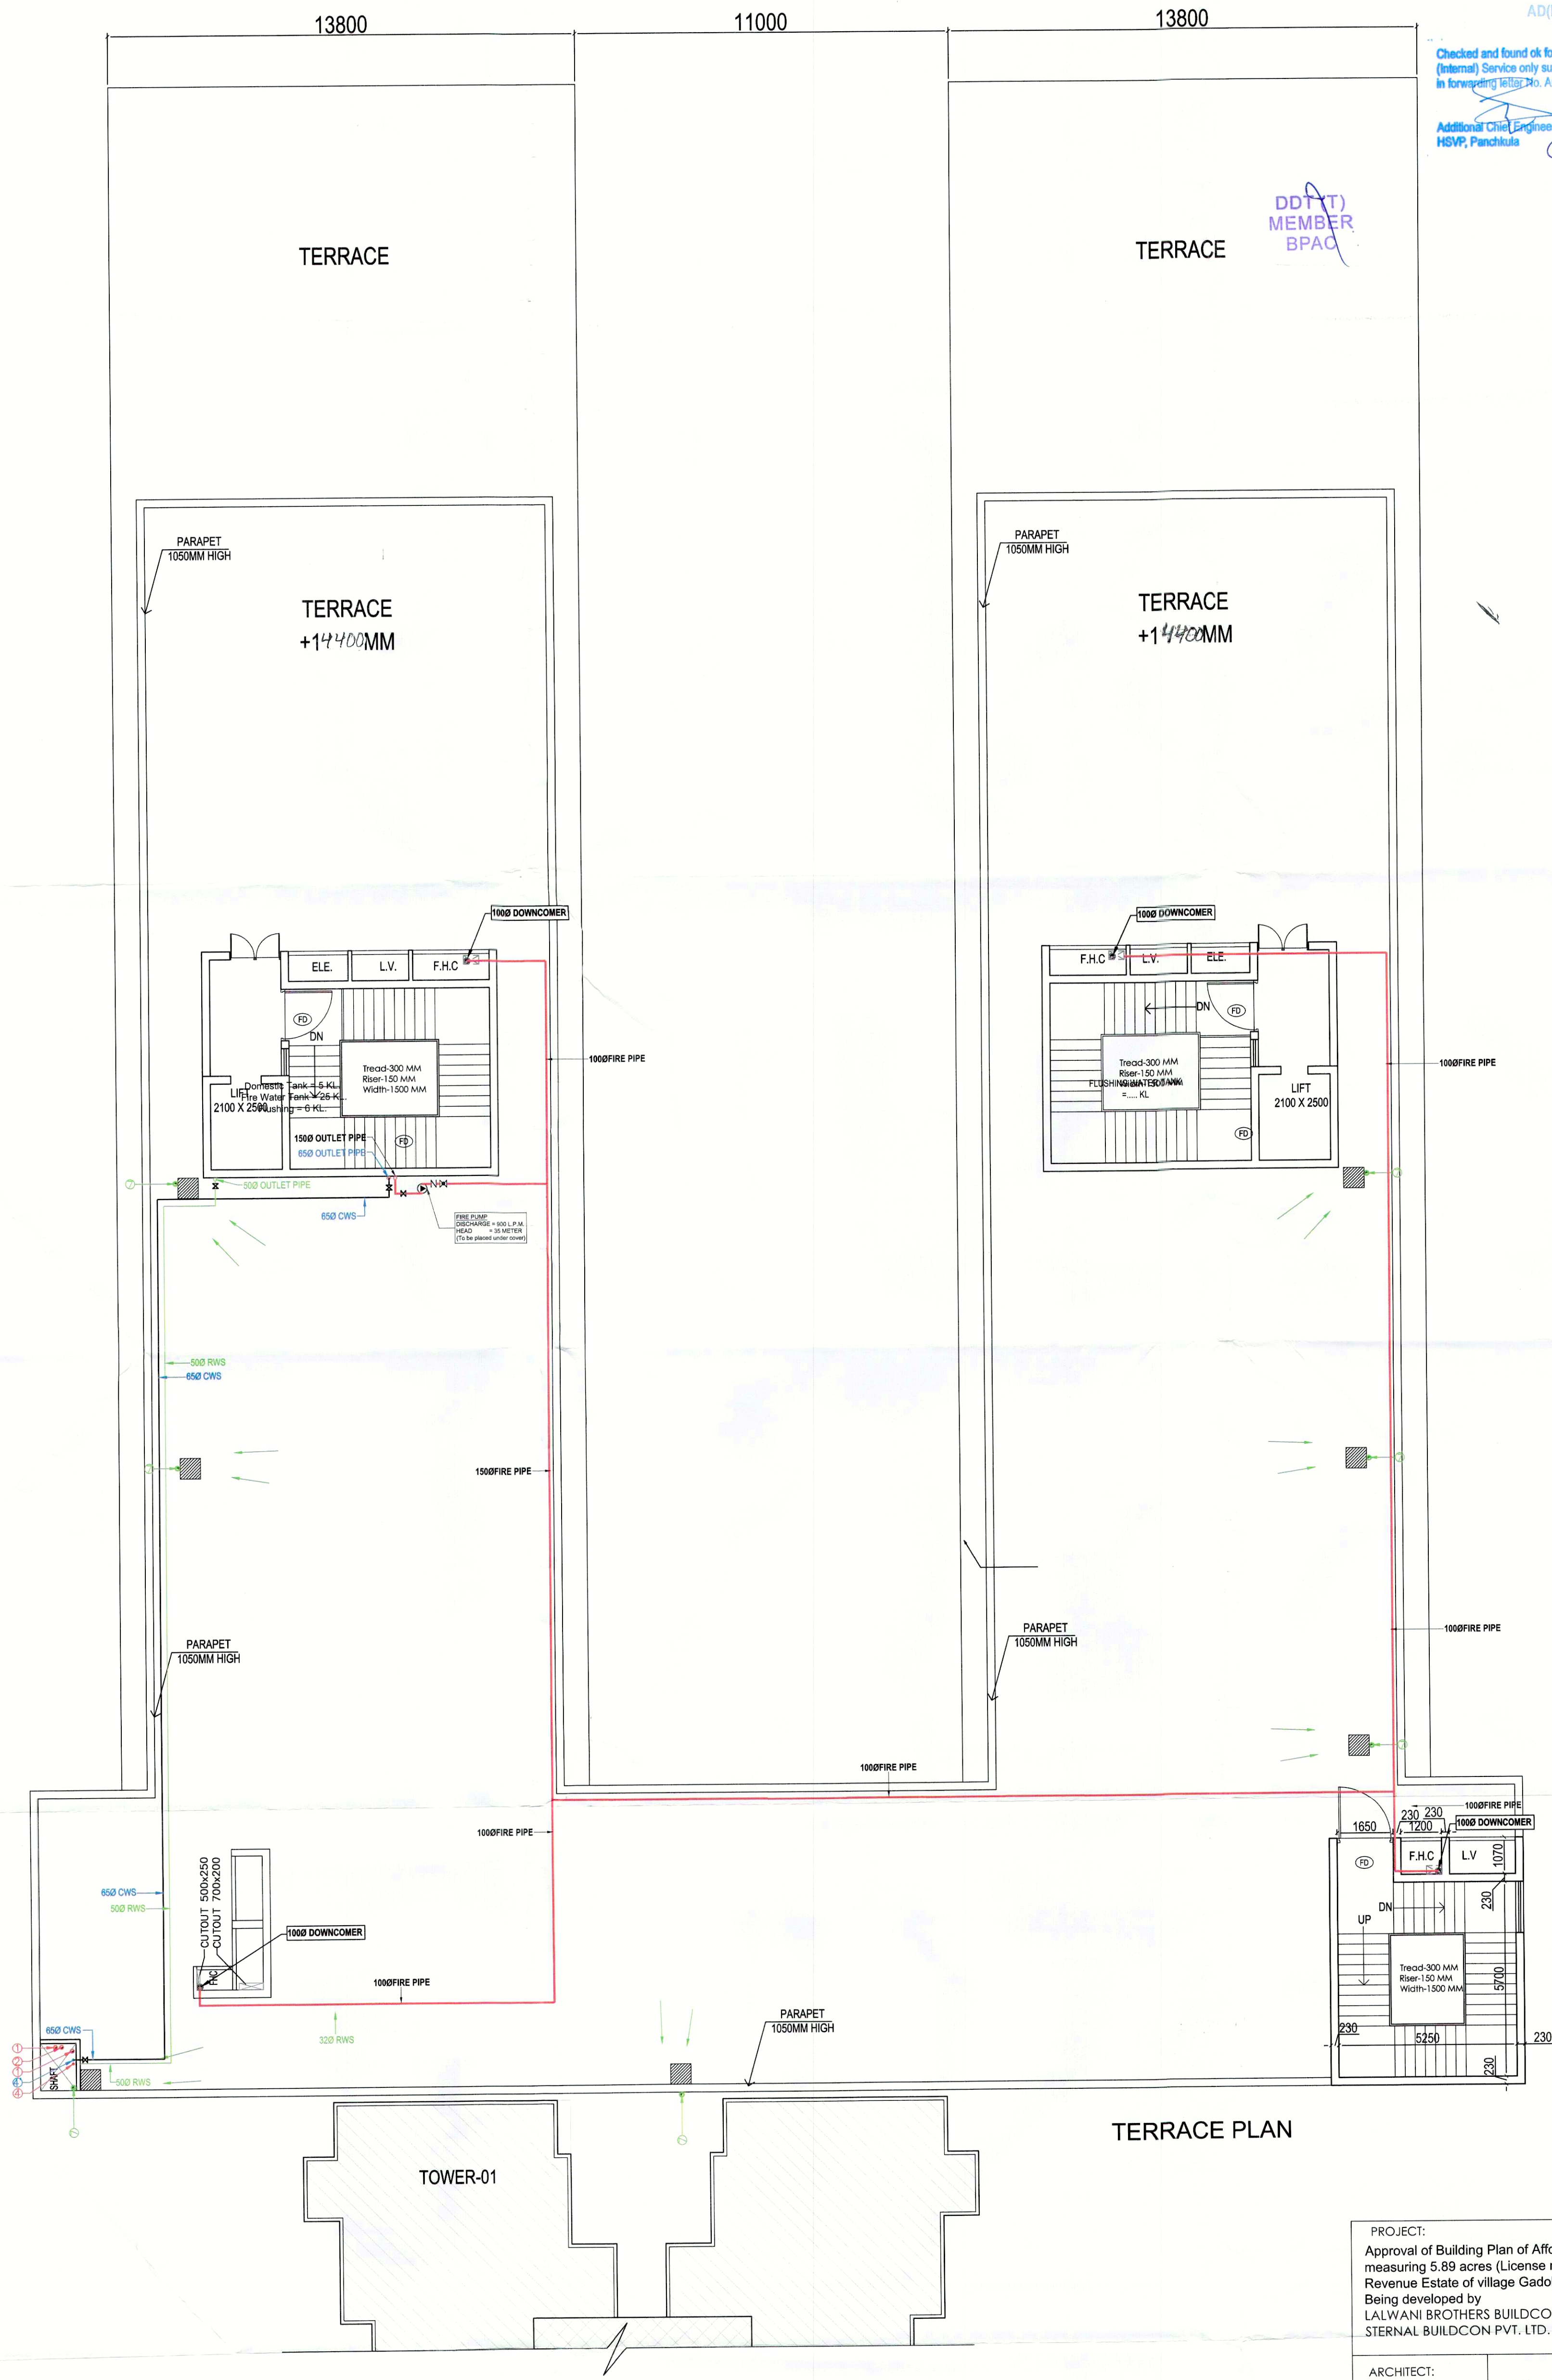

TERRACE PLAN

LEGEND: -

SYMBOL	DESCRIPTION
—	SOIL PIPE
—	WASTE PIPE
⊕ FT	FLOOR TRAP
⊗	CUTOUT
⊕ FD	FLOOR DRAIN
—	CWS PIPE
—	FWS PIPE
—	CONTROL VALVE
—	FIRE PIPE

LEGEND: -

PLUMBING LEGEND
① 110 Ø OD uPVC SP STACK
② 110 Ø OD uPVC WP STACK
③ 75 Ø A.S.P
④ DWS D/TAKE
④ DWS D/TAKE
④ FWS D/TAKE
⑤ DWS RISER
⑥ FLUSHING RISER
⑦ 110 Ø OD uPVC R.W.P
⑧ 75 Ø uPVC DRAIN PIPE(BALCONY)

PROJECT:
Approval of Building Plan of Affordable Group Housing colony
measuring 5.89 acres (License no. 63 dated 01-09-2021) in
Revenue Estate of village Gadoli Kalan in Sector 37D, Gurugram.
Being developed by
LALWANI BROTHERS BUILDCON LLP IN COLLABORATION WITH
STERNAL BUILDCON PVT. LTD.

ARCHITECT:
GIAN P. MATHUR AND ASSOCIATES (P) LTD.
C - 55, East Of Kailash, New Delhi-110065
T : 46599599 | F 46599512
E : info@gpmindia.com | W : www.gpmindia.com

services consultant
Consummate Engineering Services (P) Ltd.
Noida Office : B - 67, Sector - 67, Noida - 201 301
Tel : (0120) 2993500 (30 Lines)
Lko Office : R 006, Rohtas Plumeria, Gomti Nagar, Lucknow
e mail : mail@cespln, website : www.cespln

DRAWING TITLE:
TERRACE PLAN
COMMERCIAL
G+2 FLOORS

D.N. - SG/AH/SUB/AR-38	ARCHITECT'S SIGN	OWNER'S SIGN
SCALE:- 1:100	GIAN P. MATHUR ARCHITECT B. Arch., M.C.A. I.I.A. CA No. 80/5769	
DATE:- 20 AUG 2021		
DRAWN BY:- ANANT		
CHECK BY:- NAMITA		

