


ARCHITECT (H.Q.) S.T.P. Member Secretary B.P.C. K.T. (G) Member B.P.C. T.P. (H) Chairman B.P.C. Ram Arjit Bassi AD(HQ)

Checked and found ok for Public Health (Internal) Service only subject to comments in forwarding letter to ACE(HQ).....DL.....16/6/23 Additional Chief Engineer (H.Q.) H.S.V.P. Pandikula

P.A. A.T.P.

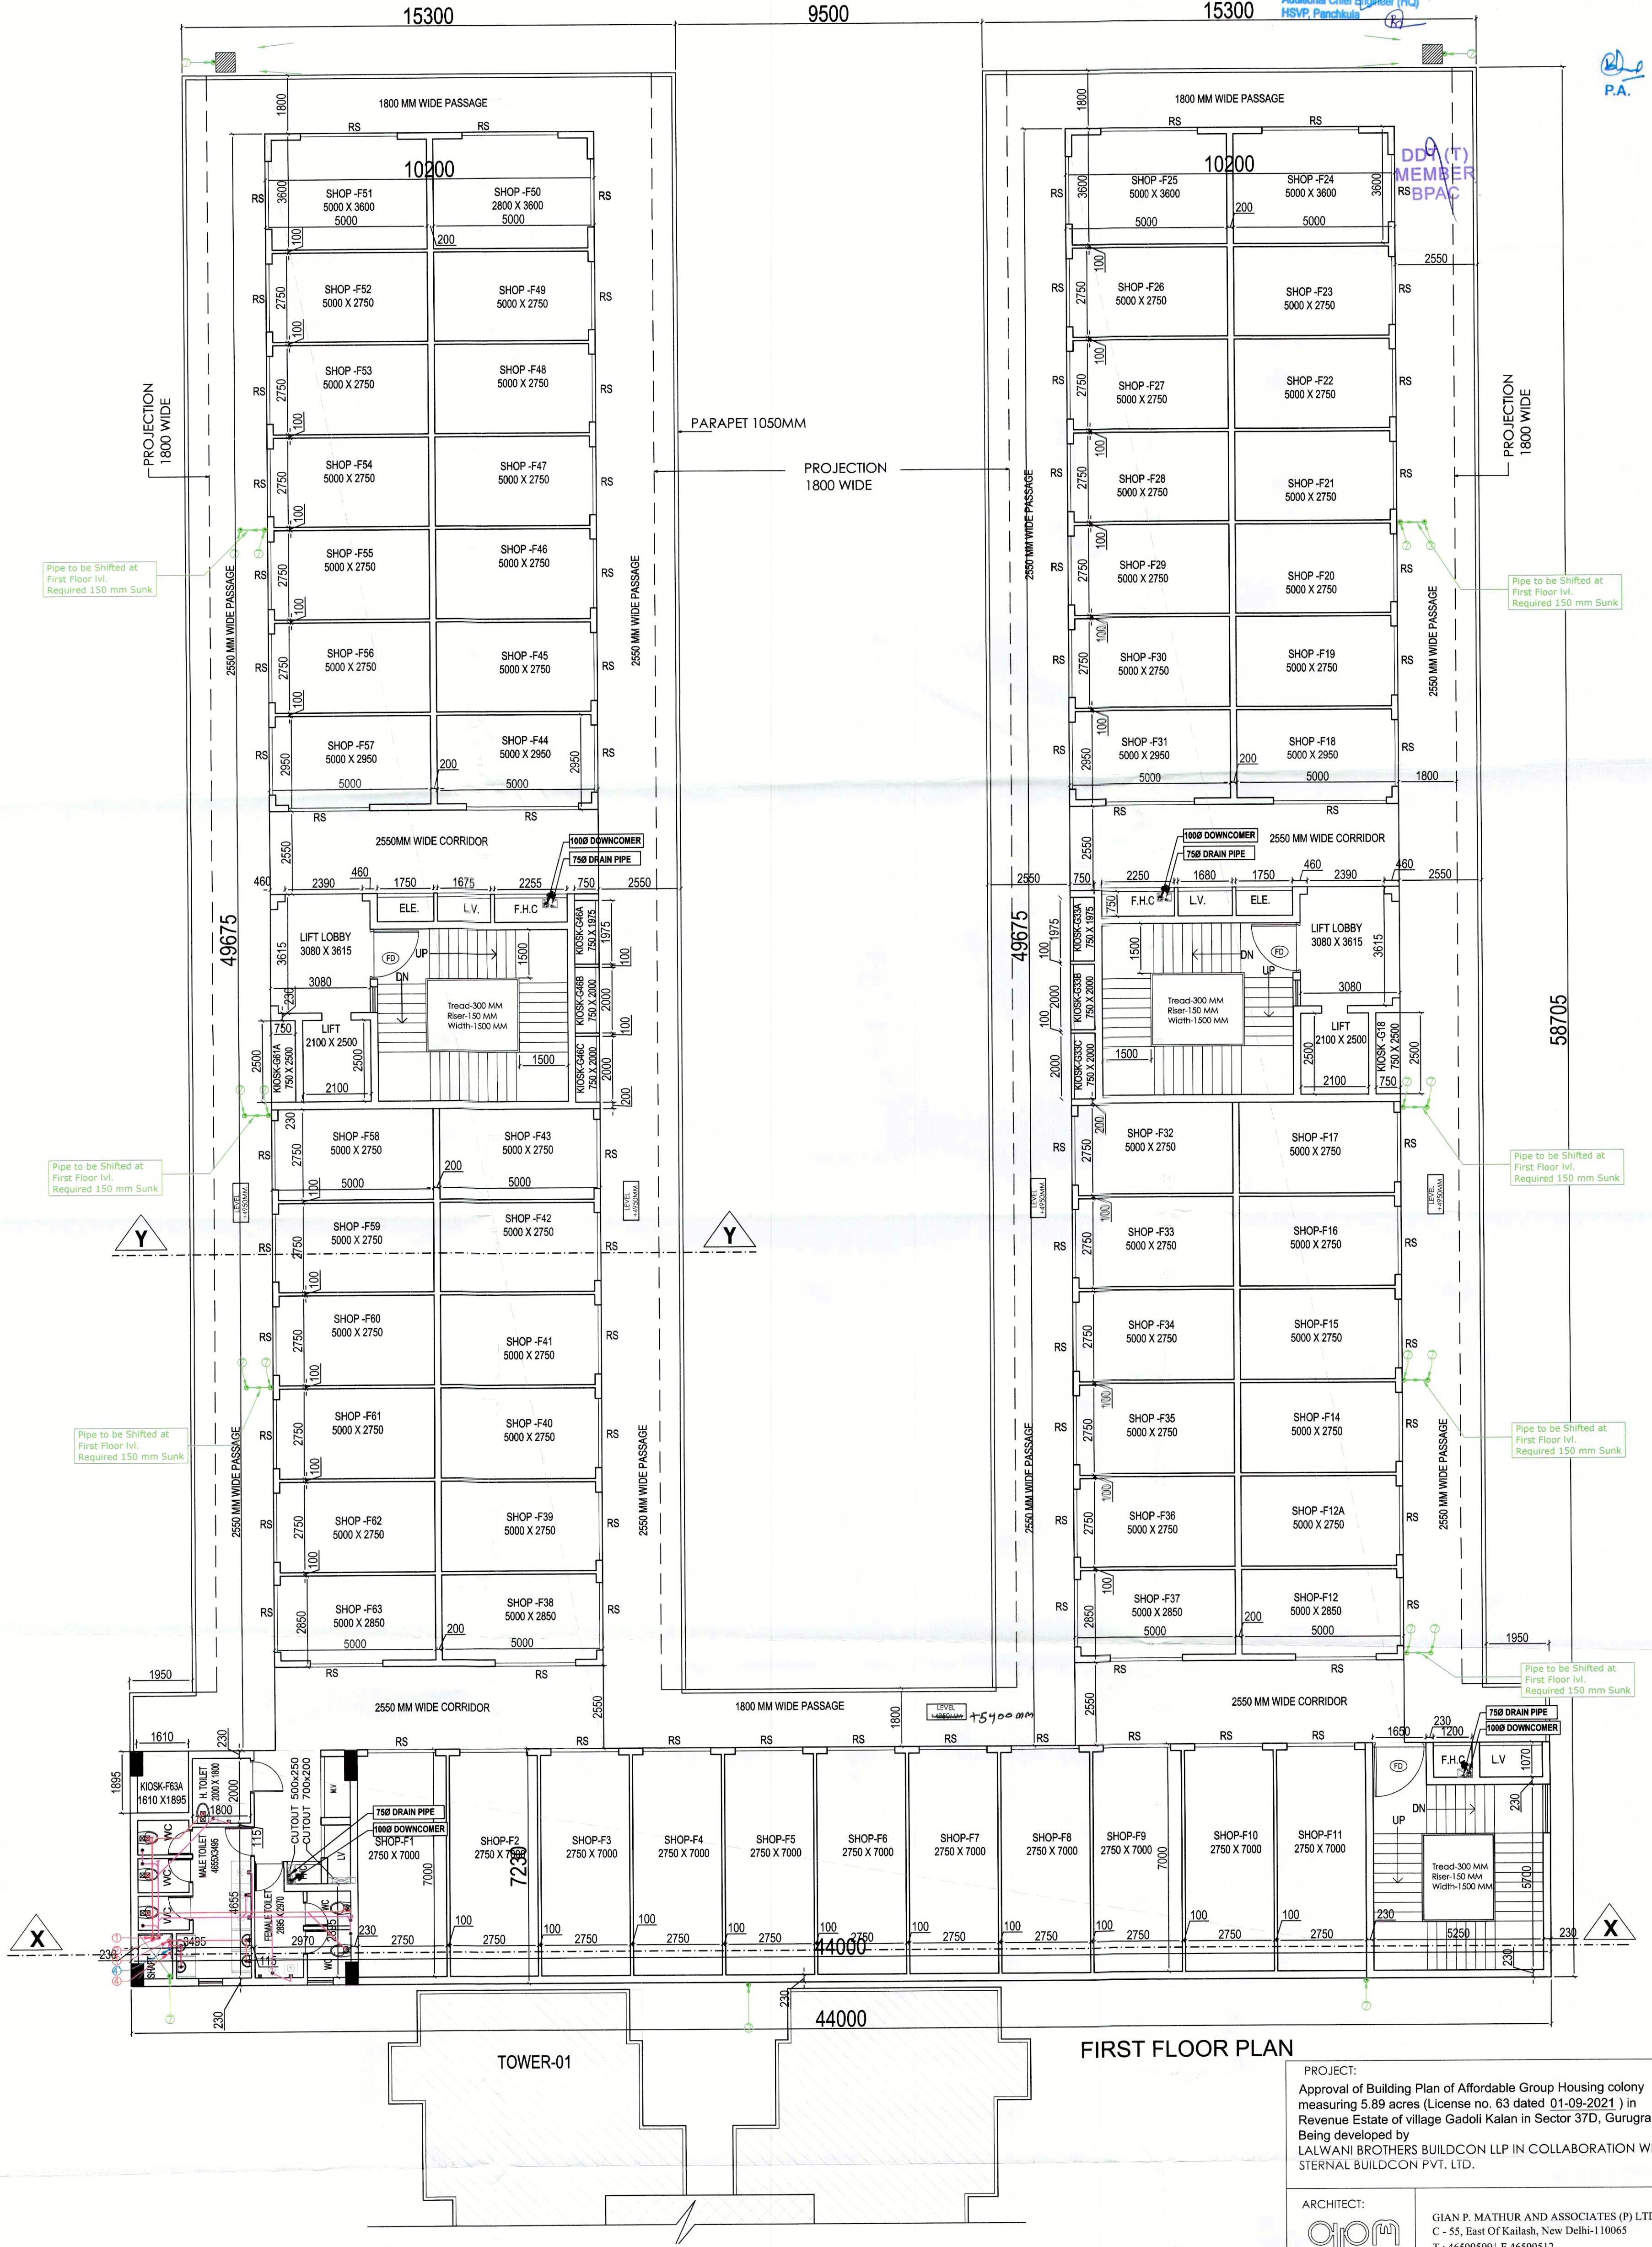

LEGEND: -

SYMBOL	DESCRIPTION
	SOIL PIPE
	WASTE PIPE
	FLOOR TRAP
	CUTOUT
	FLOOR DRAIN
	CWS PIPE
	FWS PIPE
	CONTROL VALVE
	FIRE PIPE

LEGEND: -

PLUMBING LEGEND	
①	110Ø OD uPVC SP STACK
②	110Ø OD uPVC WP STACK
③	75Ø A.S.P
④	DWS D/TAKE
⑤	DWS D/TAKE
⑥	DWS RISER
⑦	FLUSHING RISER
⑧	110Ø OD uPVC R.W.P
⑨	75Ø uPVC DRAIN PIPE(BALCONY)

PROJECT: Approval of Building Plan of Affordable Group Housing colony measuring 5.89 acres (License no. 63 dated 01-09-2021) in Revenue Estate of village Gadoli Kalan in Sector 37D, Gurugram. Being developed by LALWANI BROTHERS BUILDCON LLP IN COLLABORATION WITH SERNAL BUILDCON PVT. LTD.

ARCHITECT: GIAN P. MATHUR AND ASSOCIATES (P) LTD. C - 55, East Of Kailash, New Delhi-110065 T : 465995991 F 46599512 E : info@gpmindia.com I W : www.gpmindia.com

services consultant Consummate Engineering Services (P) Ltd. Noida Office : B - 67, Sector - 67, Noida - 201 301 Tel : (0120) 2593500 (30 Lines) Lko. Office : R 006, Rohas Plumeria, Gomti Nagar, Lucknow e mail : mail@cespl.in, website : www.cespl.in

DRAWING TITLE: FIRST FLOOR PLAN COMMERCIAL G+2 FLOORS

D.N. - SG/AH/SUB/AR-36	ARCHITECT'S SIGN	OWNER'S SIGN
SCALE:- 1:100	GIAN P. MATHUR ARCHITECT	
DATE:- 20 AUG 2021	B. Arch., M. A. T. I. A. CA N	
DRAWN BY:- ANANT		
CHECK BY:- NAMITA		

