


ARCHITECT (H.Q.) S.T.P. Member Secretary Member Chairman B.P.C. B.P.C. B.P.C. Ram Avtar Bansi AD(HQ)

Checked and found ok for Public Health (Internal) Service only subject to comments in forwarding letter No. ACE(HQ).....DL.....29/11/21 169833 Additional Chief Engineer (HQ) HSPV, Panchkula

PA. A.T.P.

DDT (T) MEMBER BPAC

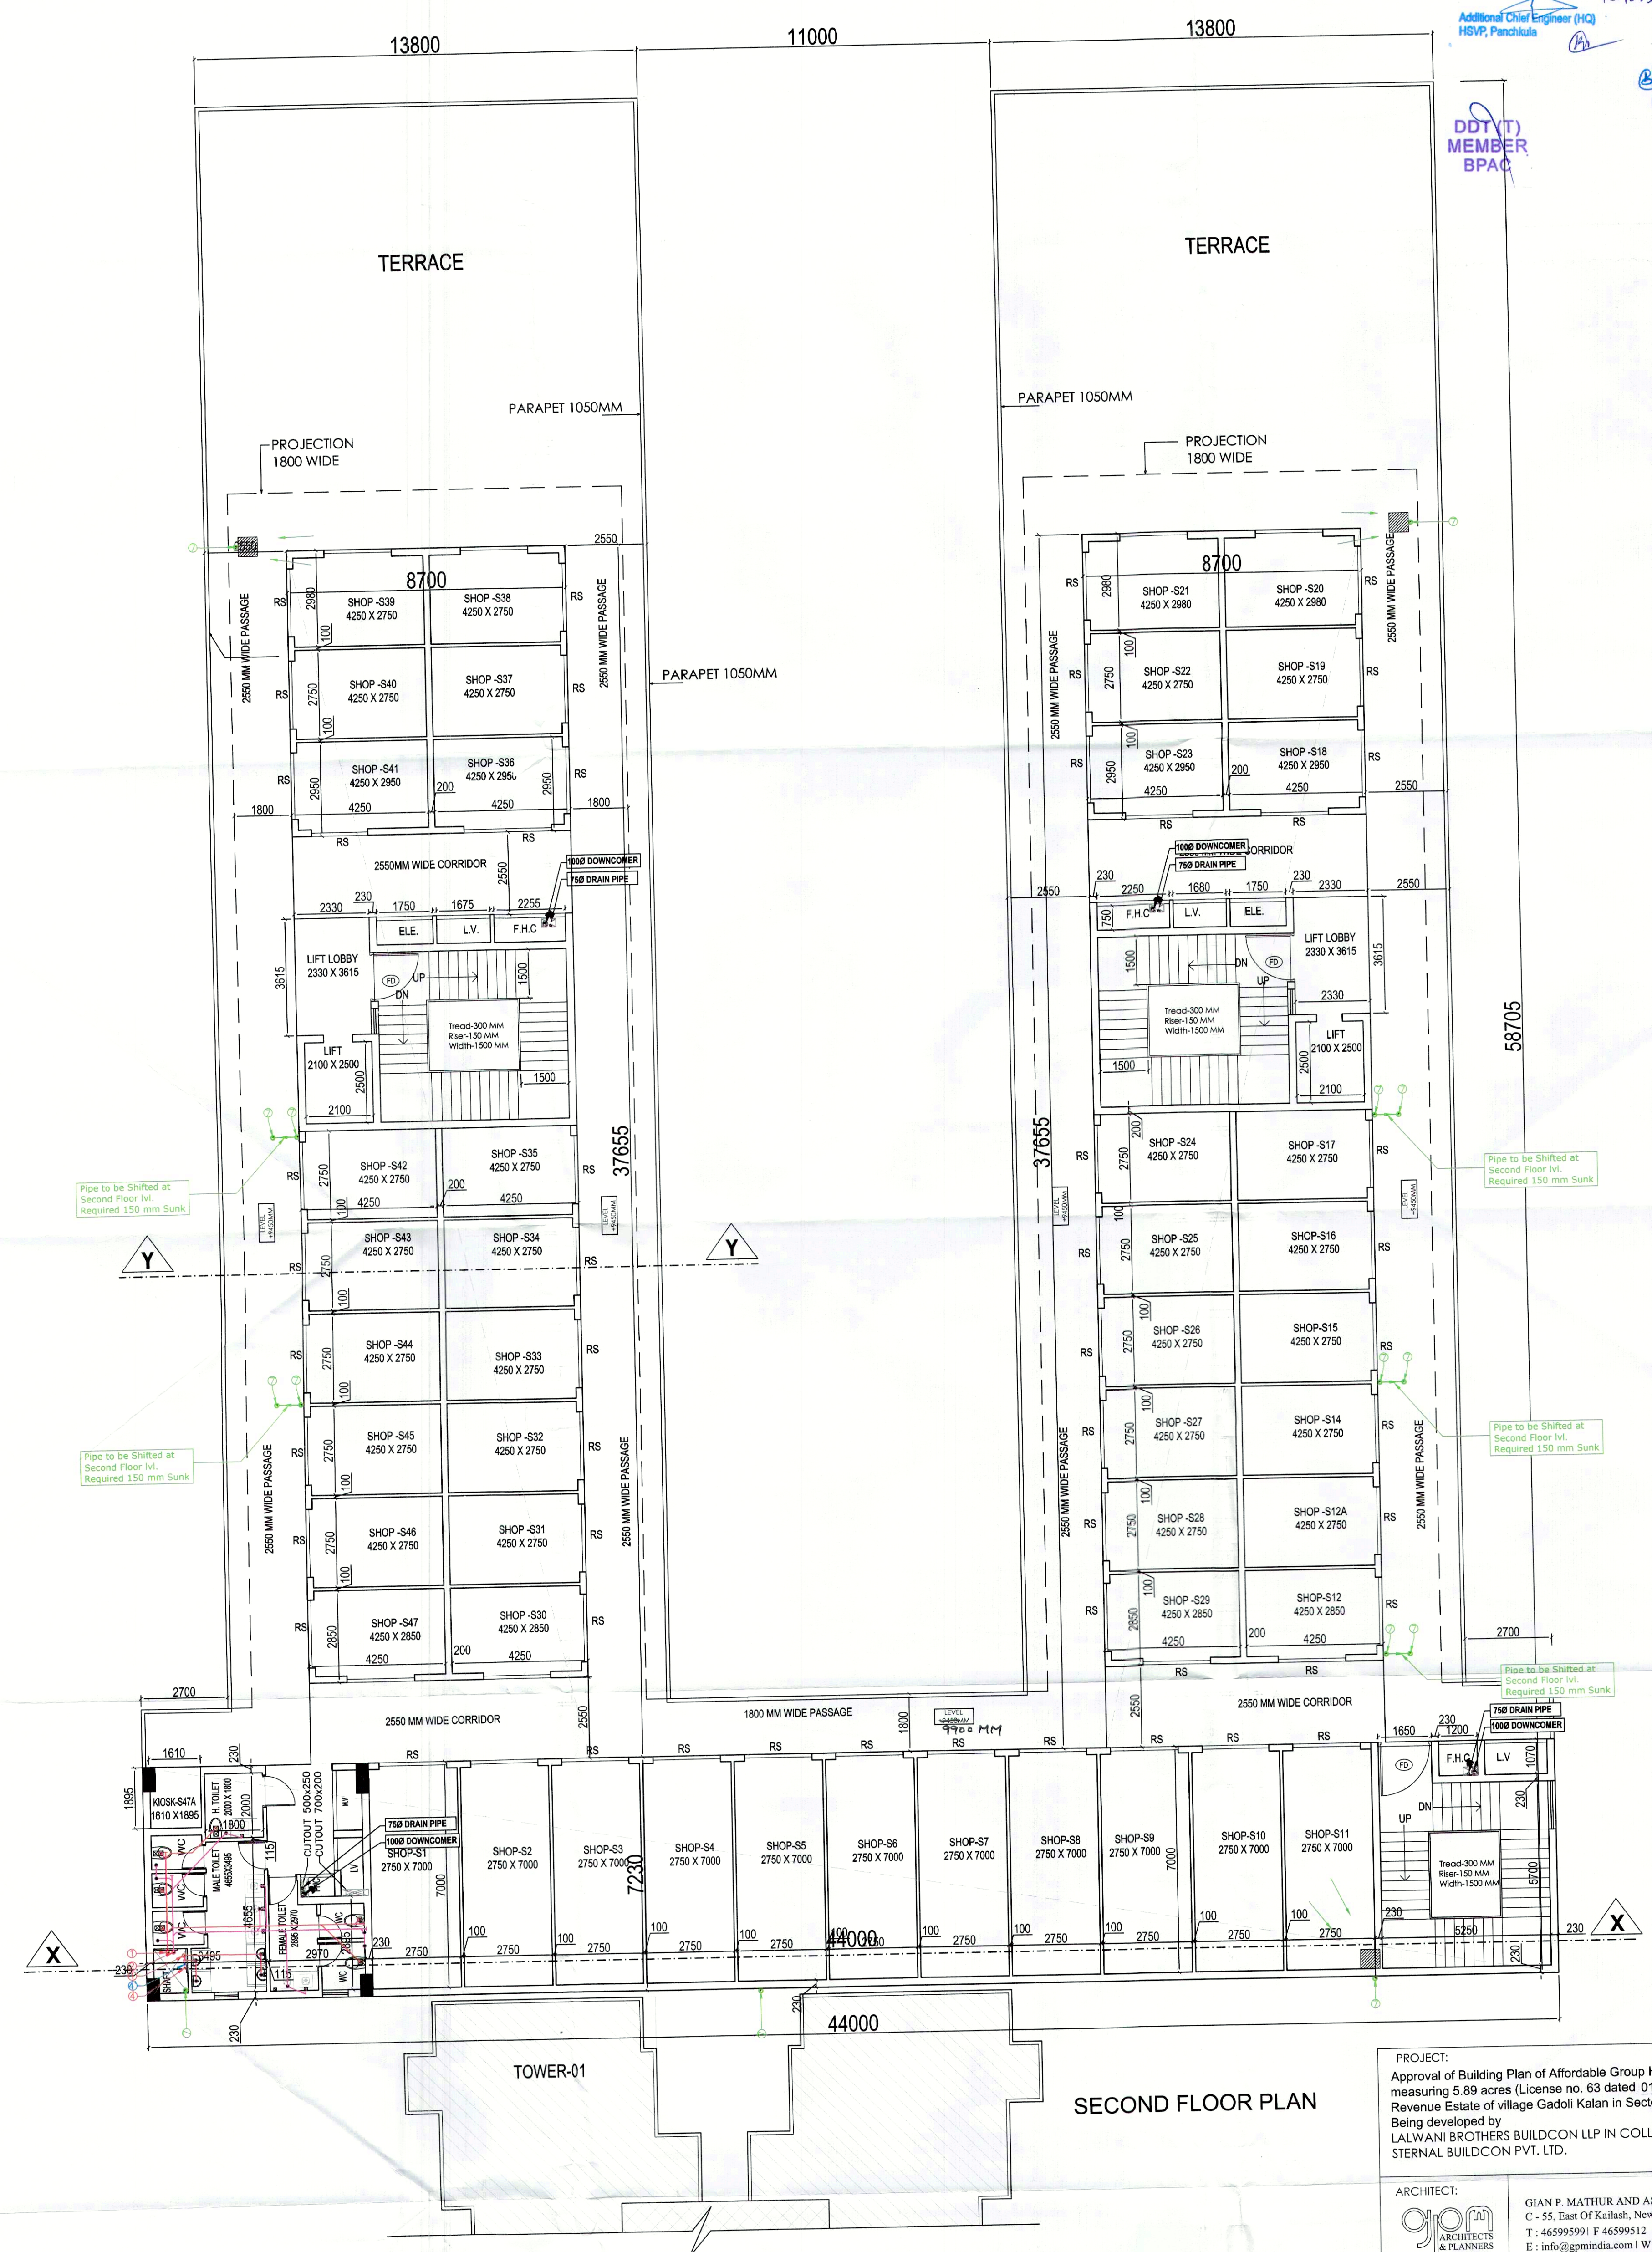

LEGEND: -

SYMBOL	DESCRIPTION
—	SOIL PIPE
—	WASTE PIPE
⊕	FLOOR TRAP
⊗	CUTOUT
⊙	FLOOR DRAIN
—	CWS PIPE
—	FWS PIPE
—	CONTROL VALVE
—	FIRE PIPE

LEGEND: -

PLUMBING LEGEND
① 110Ø OD uPVC SP STACK
② 110Ø OD uPVC WP STACK
③ 75Ø A.S.P
④ DWS D/TAKE
④ DWS D/TAKE
④ FWS D/TAKE
⑤ DWS RISER
⑥ FLUSHING RISER
⑦ 110Ø OD uPVC R.W.P
⑧ 75Ø uPVC DRAIN PIPE(BALCONY)

PROJECT: Approval of Building Plan of Affordable Group Housing colony measuring 5.89 acres (License no. 63 dated 01-09-2021) in Revenue Estate of village Gadoli Kalan in Sector 37D, Gurugram. Being developed by LALWANI BROTHERS BUILDCON LLP IN COLLABORATION WITH SERNAL BUILDCON PVT. LTD.

ARCHITECT: GIAN P. MATHUR AND ASSOCIATES (P) LTD. C - 55, East Of Kailash, New Delhi-110065 T : 465995991 F 46599512 E : info@gpmindia.com | W : www.gpmindia.com

services consultant Consummate Engineering Services (P) Ltd. Noida Office : B - 67, Sector - 67, Noida - 201 301 Tel : (0120) 2993500 (30 Lines) Lko Office : R 006, Rohas Plumeria, Gomti Nagar, Lucknow e mail : mail@cespl.in, website : www.cespl.in

DRAWING TITLE: SECOND FLOOR PLAN COMMERCIAL G+2 FLOORS D.N. - SG/AH/SUB/AR-37 ARCHITECT'S SIGN OWNER'S SIGN SCALE:- 1:100 GIAN P. MATHUR ARCHITECT DATE:- 20 AUG 2021 B. Arch., M.C.E., I.I.A. CA No. 8075769 DRAWN BY:- ANANT CHECK BY:- NAMITA

