
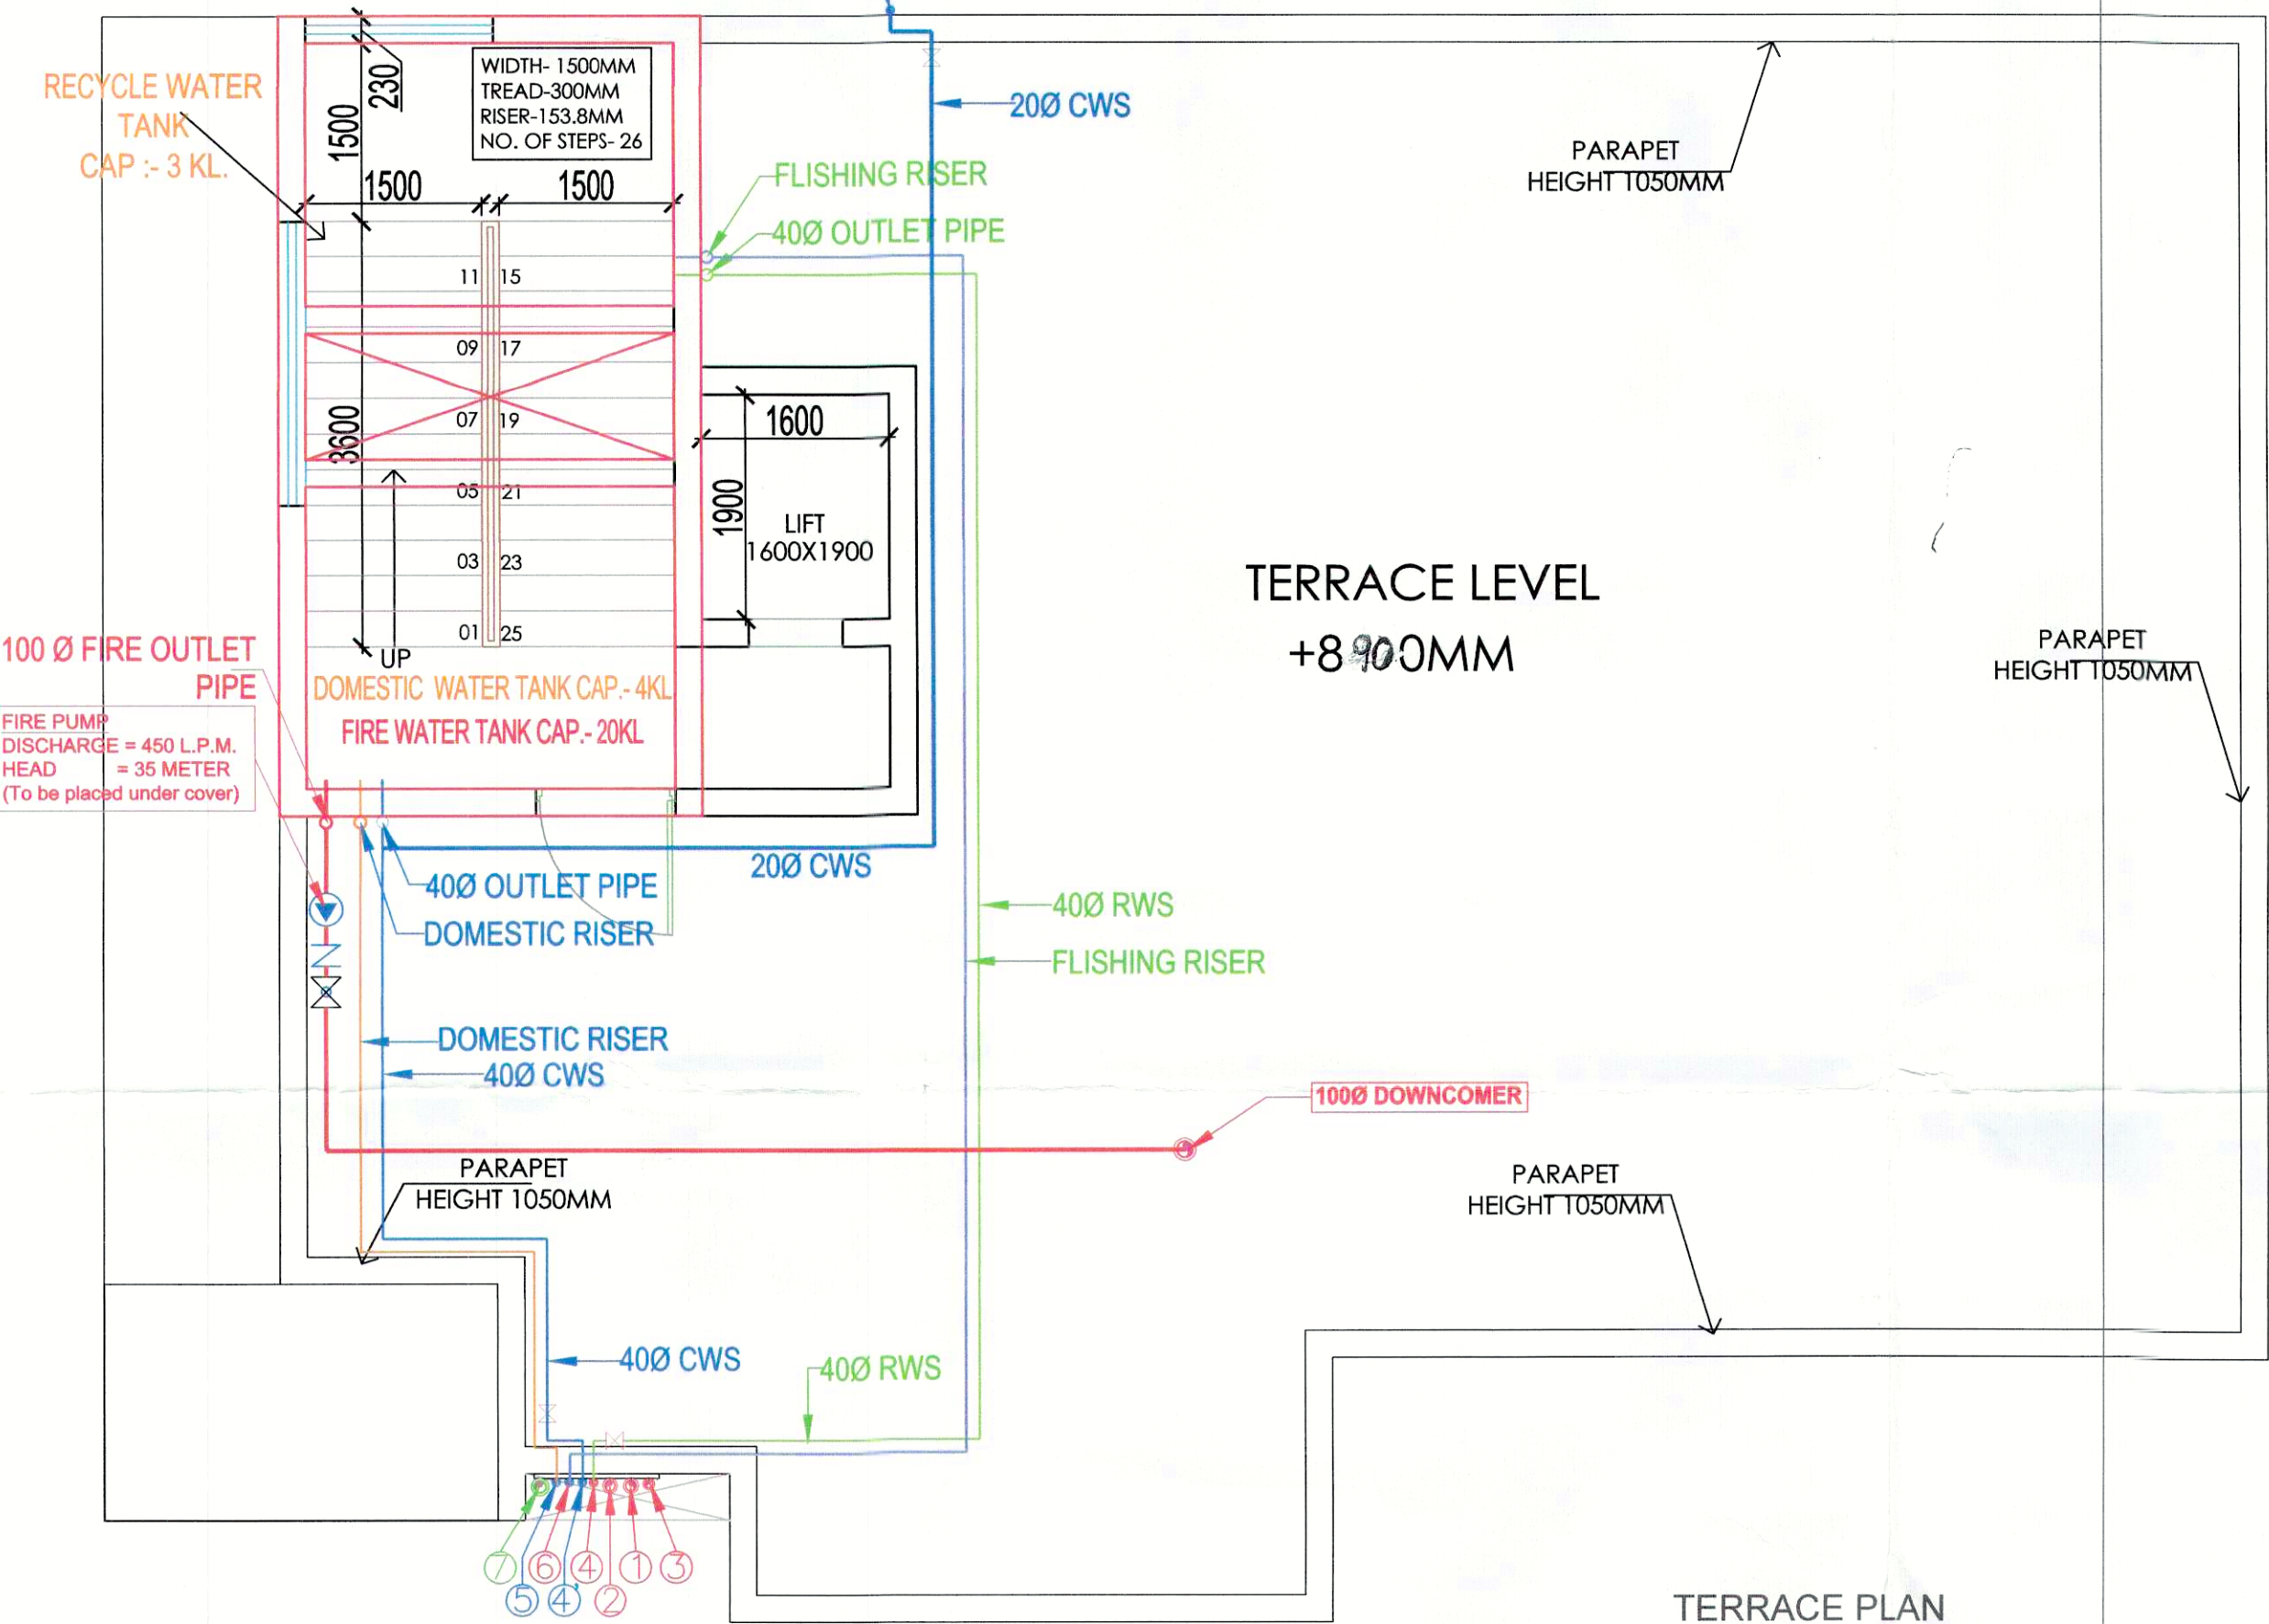
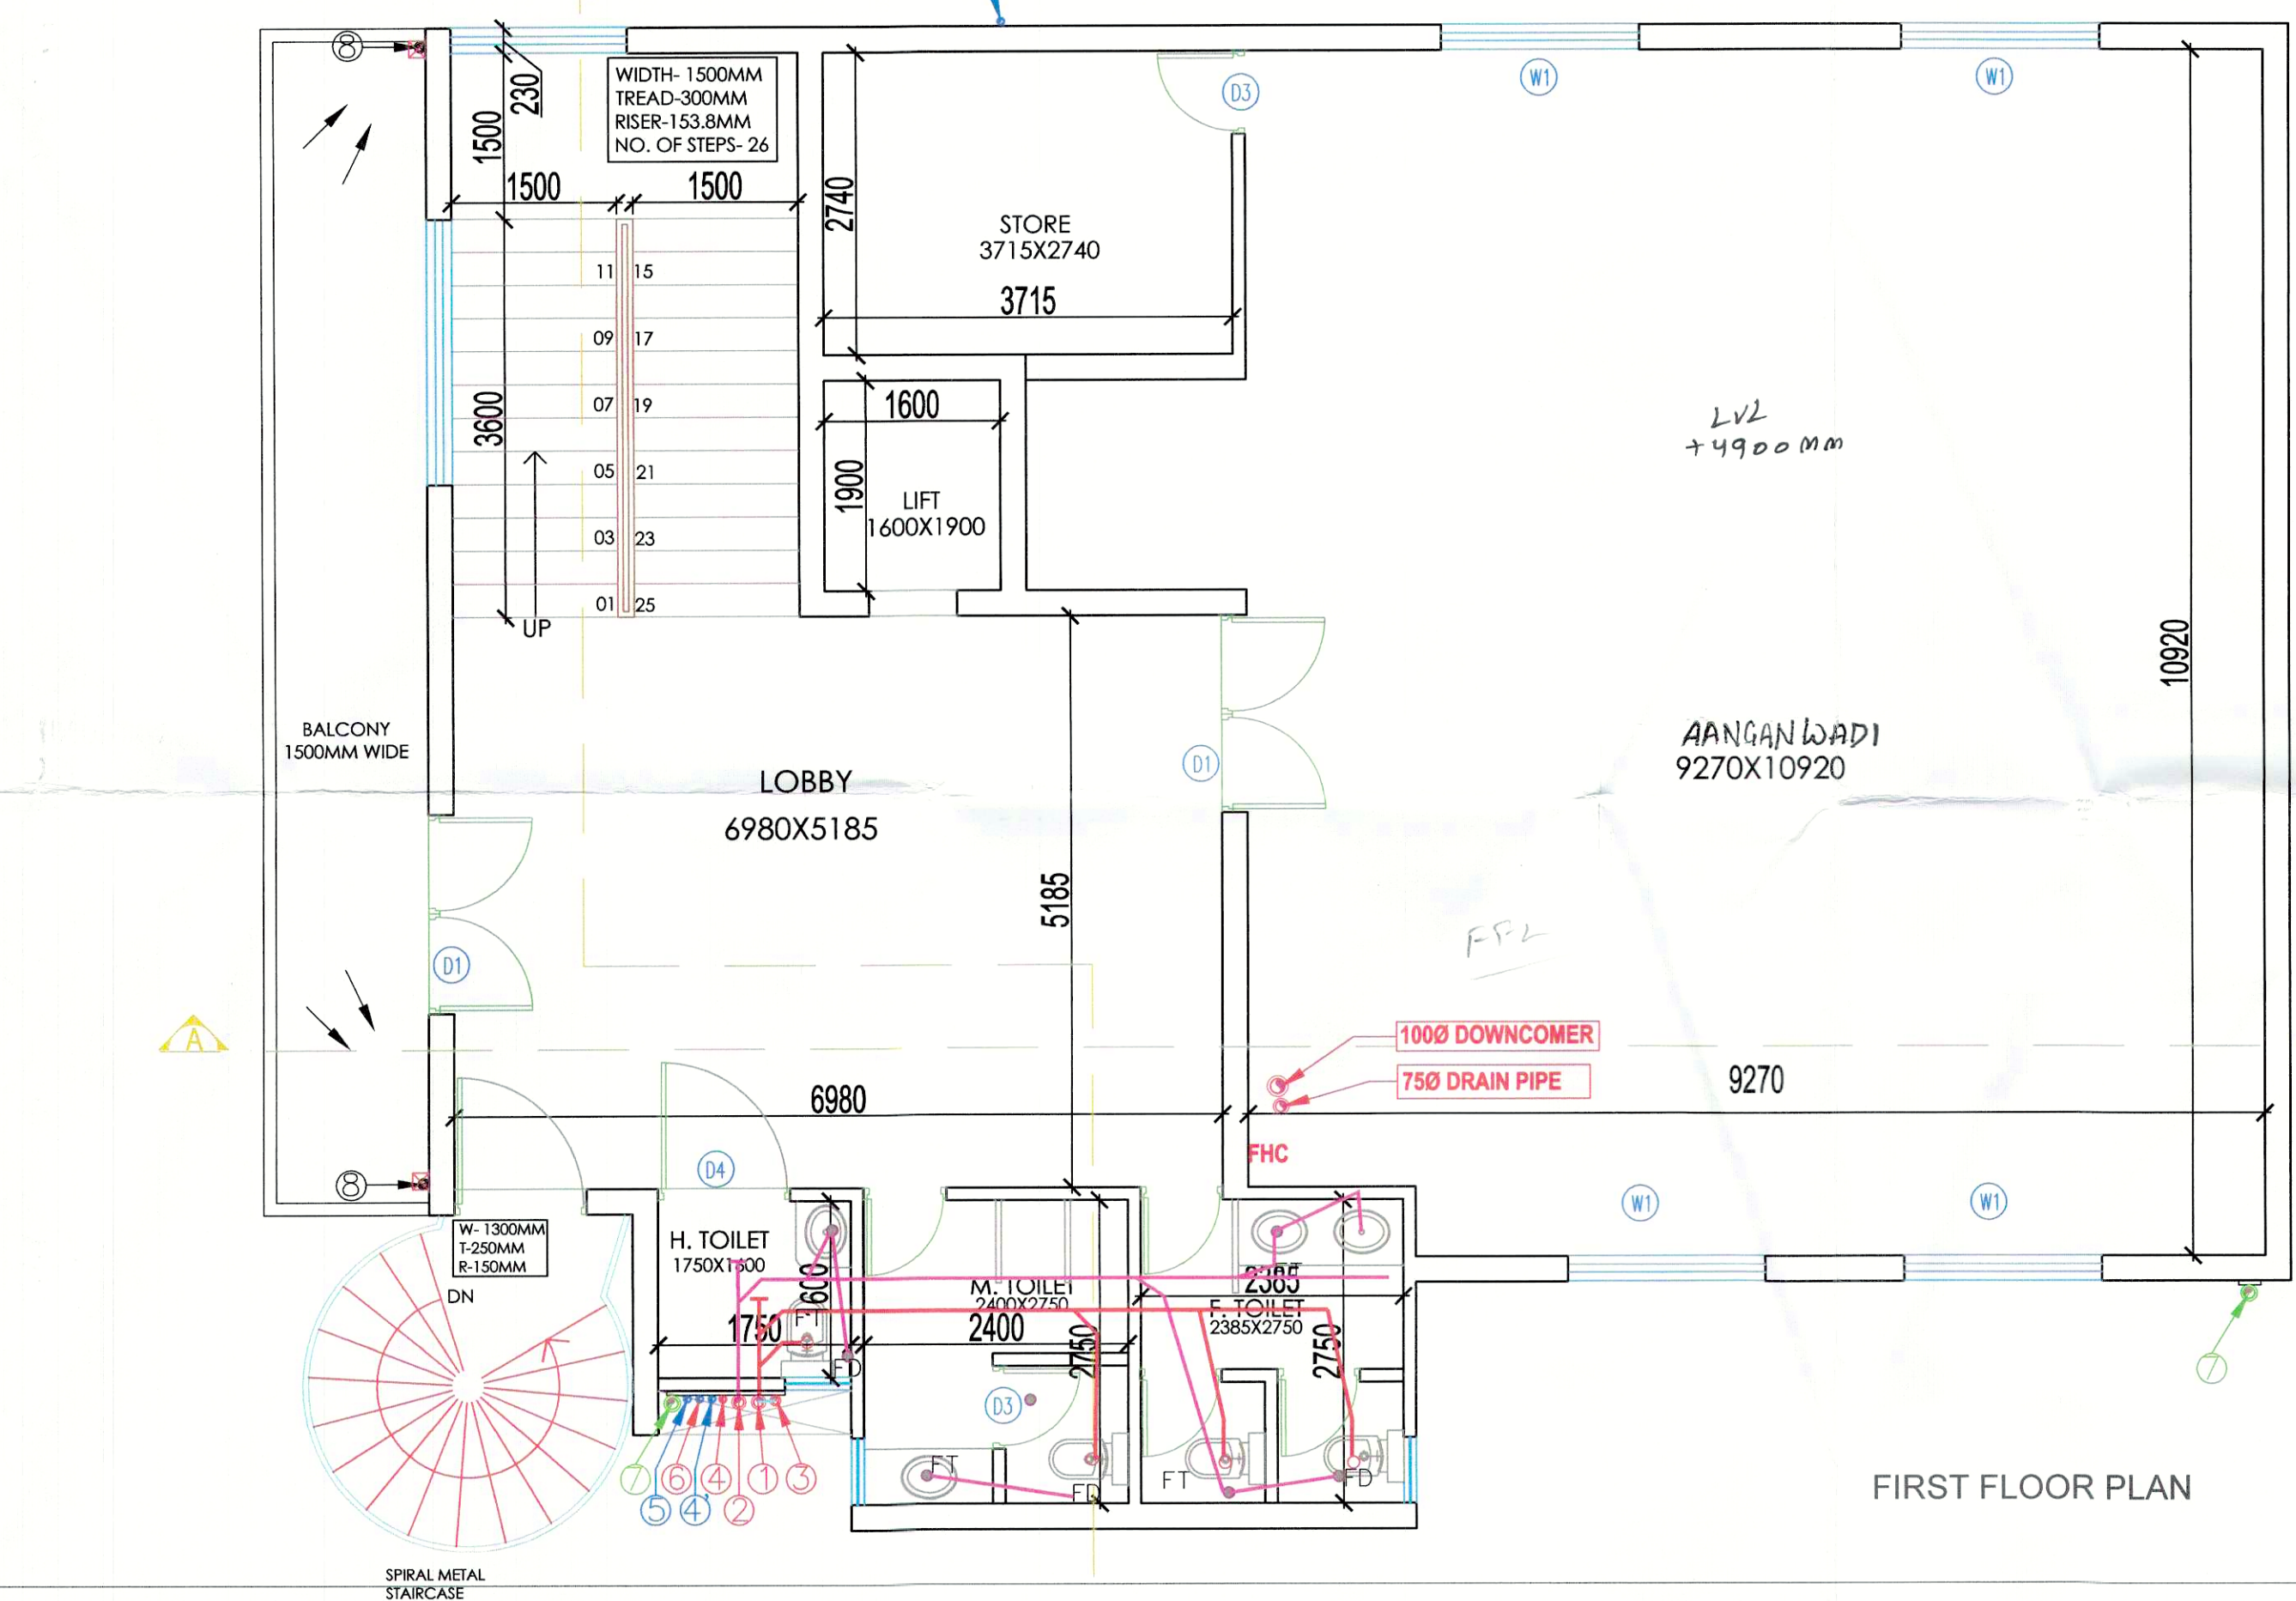


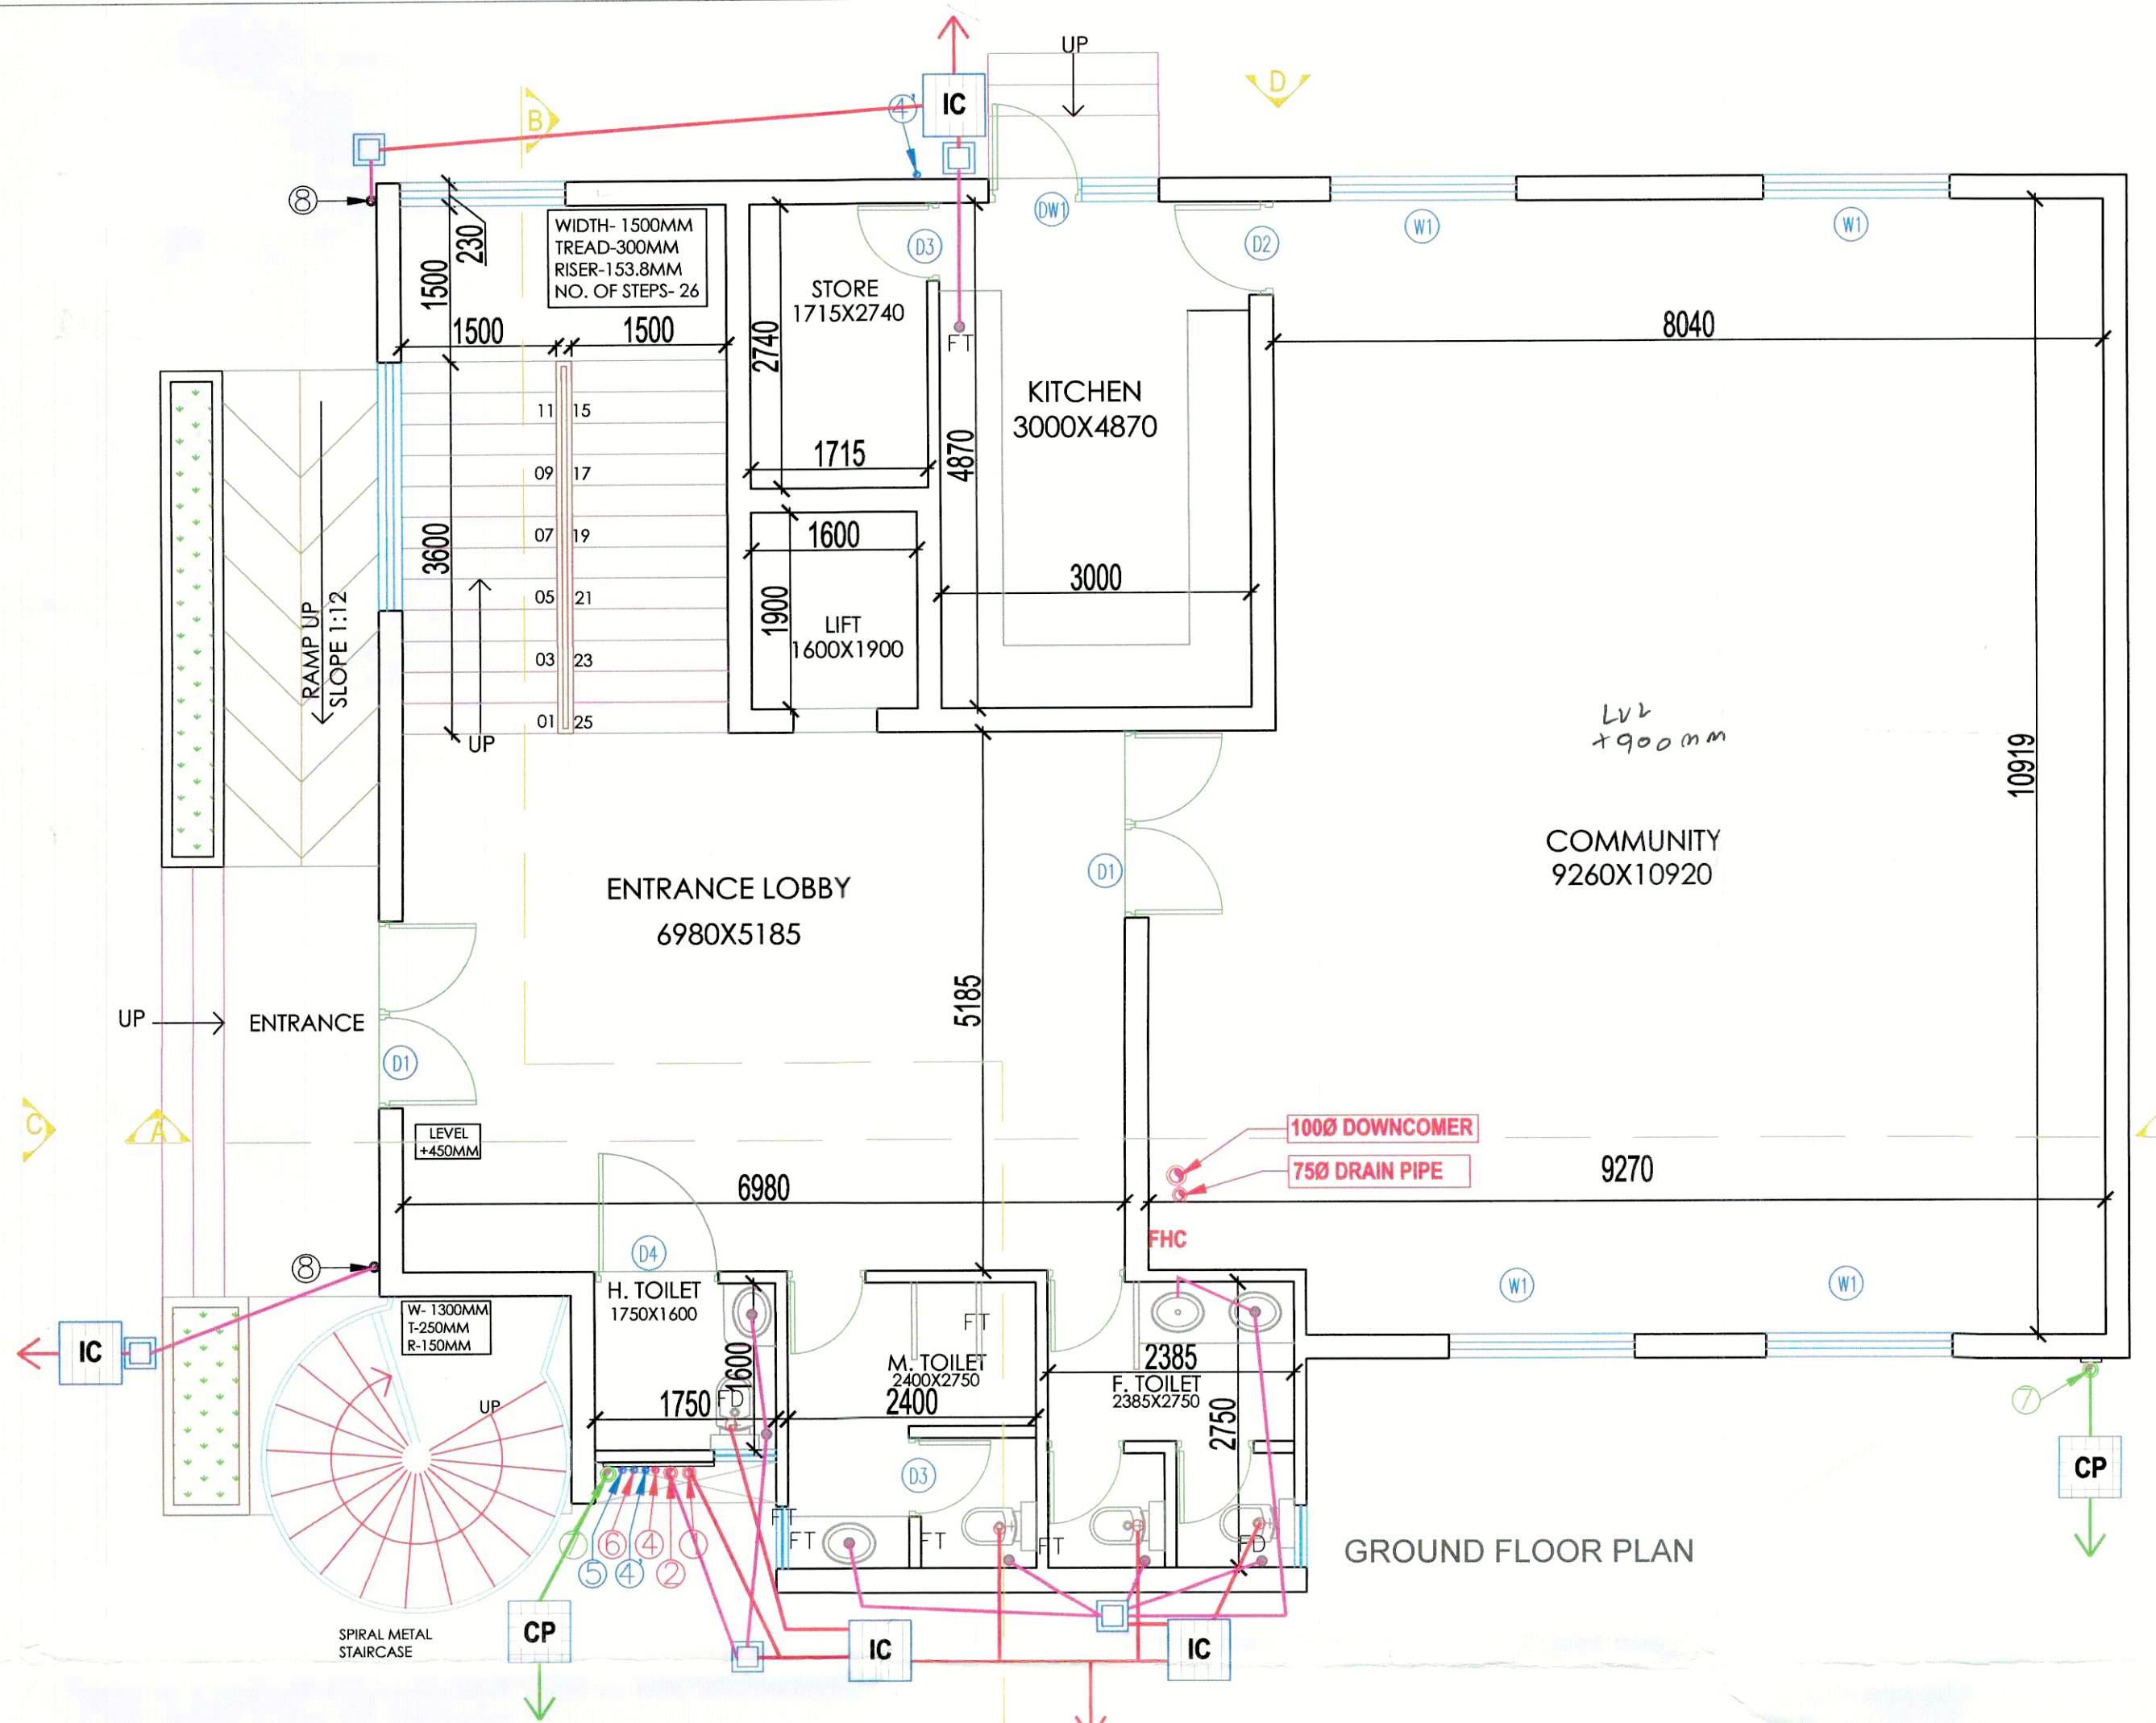

LEGEND:-

| PLUMBING LEGEND |                               |
|-----------------|-------------------------------|
| ①               | 110ø OD uPVC SP. STACK        |
| ②               | 110ø OD uPVC WP. STACK        |
| ③               | 75ø A.S.P.                    |
| ④               | DWS D/TAKE                    |
| ⑤               | FWS D/TAKE                    |
| ⑥               | DWS RISER                     |
| ⑦               | FLUSHING RISER                |
| ⑧               | 110ø OD uPVC R.W.P.           |
| ⑨               | 75ø uPVC DRAIN PIPE (BALCONY) |

LEGEND:-

| SYMBOL | DESCRIPTION   |
|--------|---------------|
| —      | SOIL PIPE     |
| —      | WASTE PIPE    |
| ⊕ FT   | FLOOR TRAP    |
| ⊗      | CUTOUT        |
| ⊙ FD   | FLOOR DRAIN   |
| —      | CWS PIPE      |
| —      | FWS PIPE      |
| —      | CONTROL VALVE |
| —      | FIRE PIPE     |

DOOR WINDOW OPENING SCHEDULE

| TYPE | OPENING |           | SILL HEIGHT | LUNTEL HEIGHT | REMARK             |
|------|---------|-----------|-------------|---------------|--------------------|
|      | WIDTH   | HEIGHT    |             |               |                    |
| D1   | 1800    | 2250      | 00          | 2250          | ENTRY              |
| D2   | 1200    | 2100      | 00          | 2100          | KITCHEN            |
| D3   | 750     | 2100      | 00          | 2100          | TOILET             |
| D3   | 1200    | 2100      | 00          | 2100          | H.TOILET           |
| D4   | 1200    | 2100      | 00          | 2100          | TERRACE            |
| DW1  | 900x750 | 2100,1050 | 00,1050     | 2100          | KITCHEN            |
| W1   | 1800    | 1800      | 600         | 2400          | MULTI-PURPOSE HALL |
| W2   | 900     | 1350      | 1050        | 2400          | KITCHEN            |
| SW   | 1600    | 1200      | 1050        | 2250          | STAIRCASE          |
| V1   | 600     | 1200      | 1050        | 2250          | TOILET             |

ARCHITECT (H.Q.) S.T.P. Member Secretary BPC.

S.T.P. (G) C.T.P. Member Chairman BPC.

Checked and found ok for Public Health (Internal) Service only subject to comments in forwarding letter No. ACE(HQ).....DL...25/9/21

Additional Chief Engineer (HQ) HSPV, Panchkula

DDP (T) MEMBER BPAC

P.A. A.T.P.

PROJECT:  
Approval of Building Plan of Affordable Group Housing colony measuring 5.89 acres (License no. 63 dated 01-09-2021) in Revenue Estate of village Gadoli Kalan in Sector 37D, Gurugram. Being developed by LALWANI BROTHERS BUILDCON LLP in collaboration with SERNAL BUILDCON PVT. LTD.

ARCHITECT:  
GIAN P. MATHUR AND ASSOCIATES (P) LTD.  
C-55, East Of Kailash, New Delhi-110065  
T: 465995991 F: 46599512  
E: info@gpmindia.com I W: www.gpmindia.com

services consultant  
**Consummate Engineering Services (P) Ltd.**  
Noida Office : B-67, Sector - 67, Noida - 201 301  
Tel : (0120) 2593500 (30 Lines)  
Lko. Office : R-006, Rohas Plumeria, Gomti Nagar, Lucknow  
e mail : mail@cespl.in, website : www.cespl.in

DRAWING TITLE:  
FLOOR PLAN FOR COMMUNITY AND AANGANWADI G+1 FLOOR

|                        |                                                        |              |
|------------------------|--------------------------------------------------------|--------------|
| D.N. - SG/AH/SUB/AR-32 | ARCHITECT'S SIGN                                       | OWNER'S SIGN |
| SCALE:- 1:50           | <p>GIAN P. MATHUR<br/>ARCHITECT<br/>CA No. 8015769</p> |              |
| DATE:- 04 SEP 2021     |                                                        |              |
| DRAWN BY:- ANANT       |                                                        |              |
| CHECK BY:- NAMITA      |                                                        |              |