


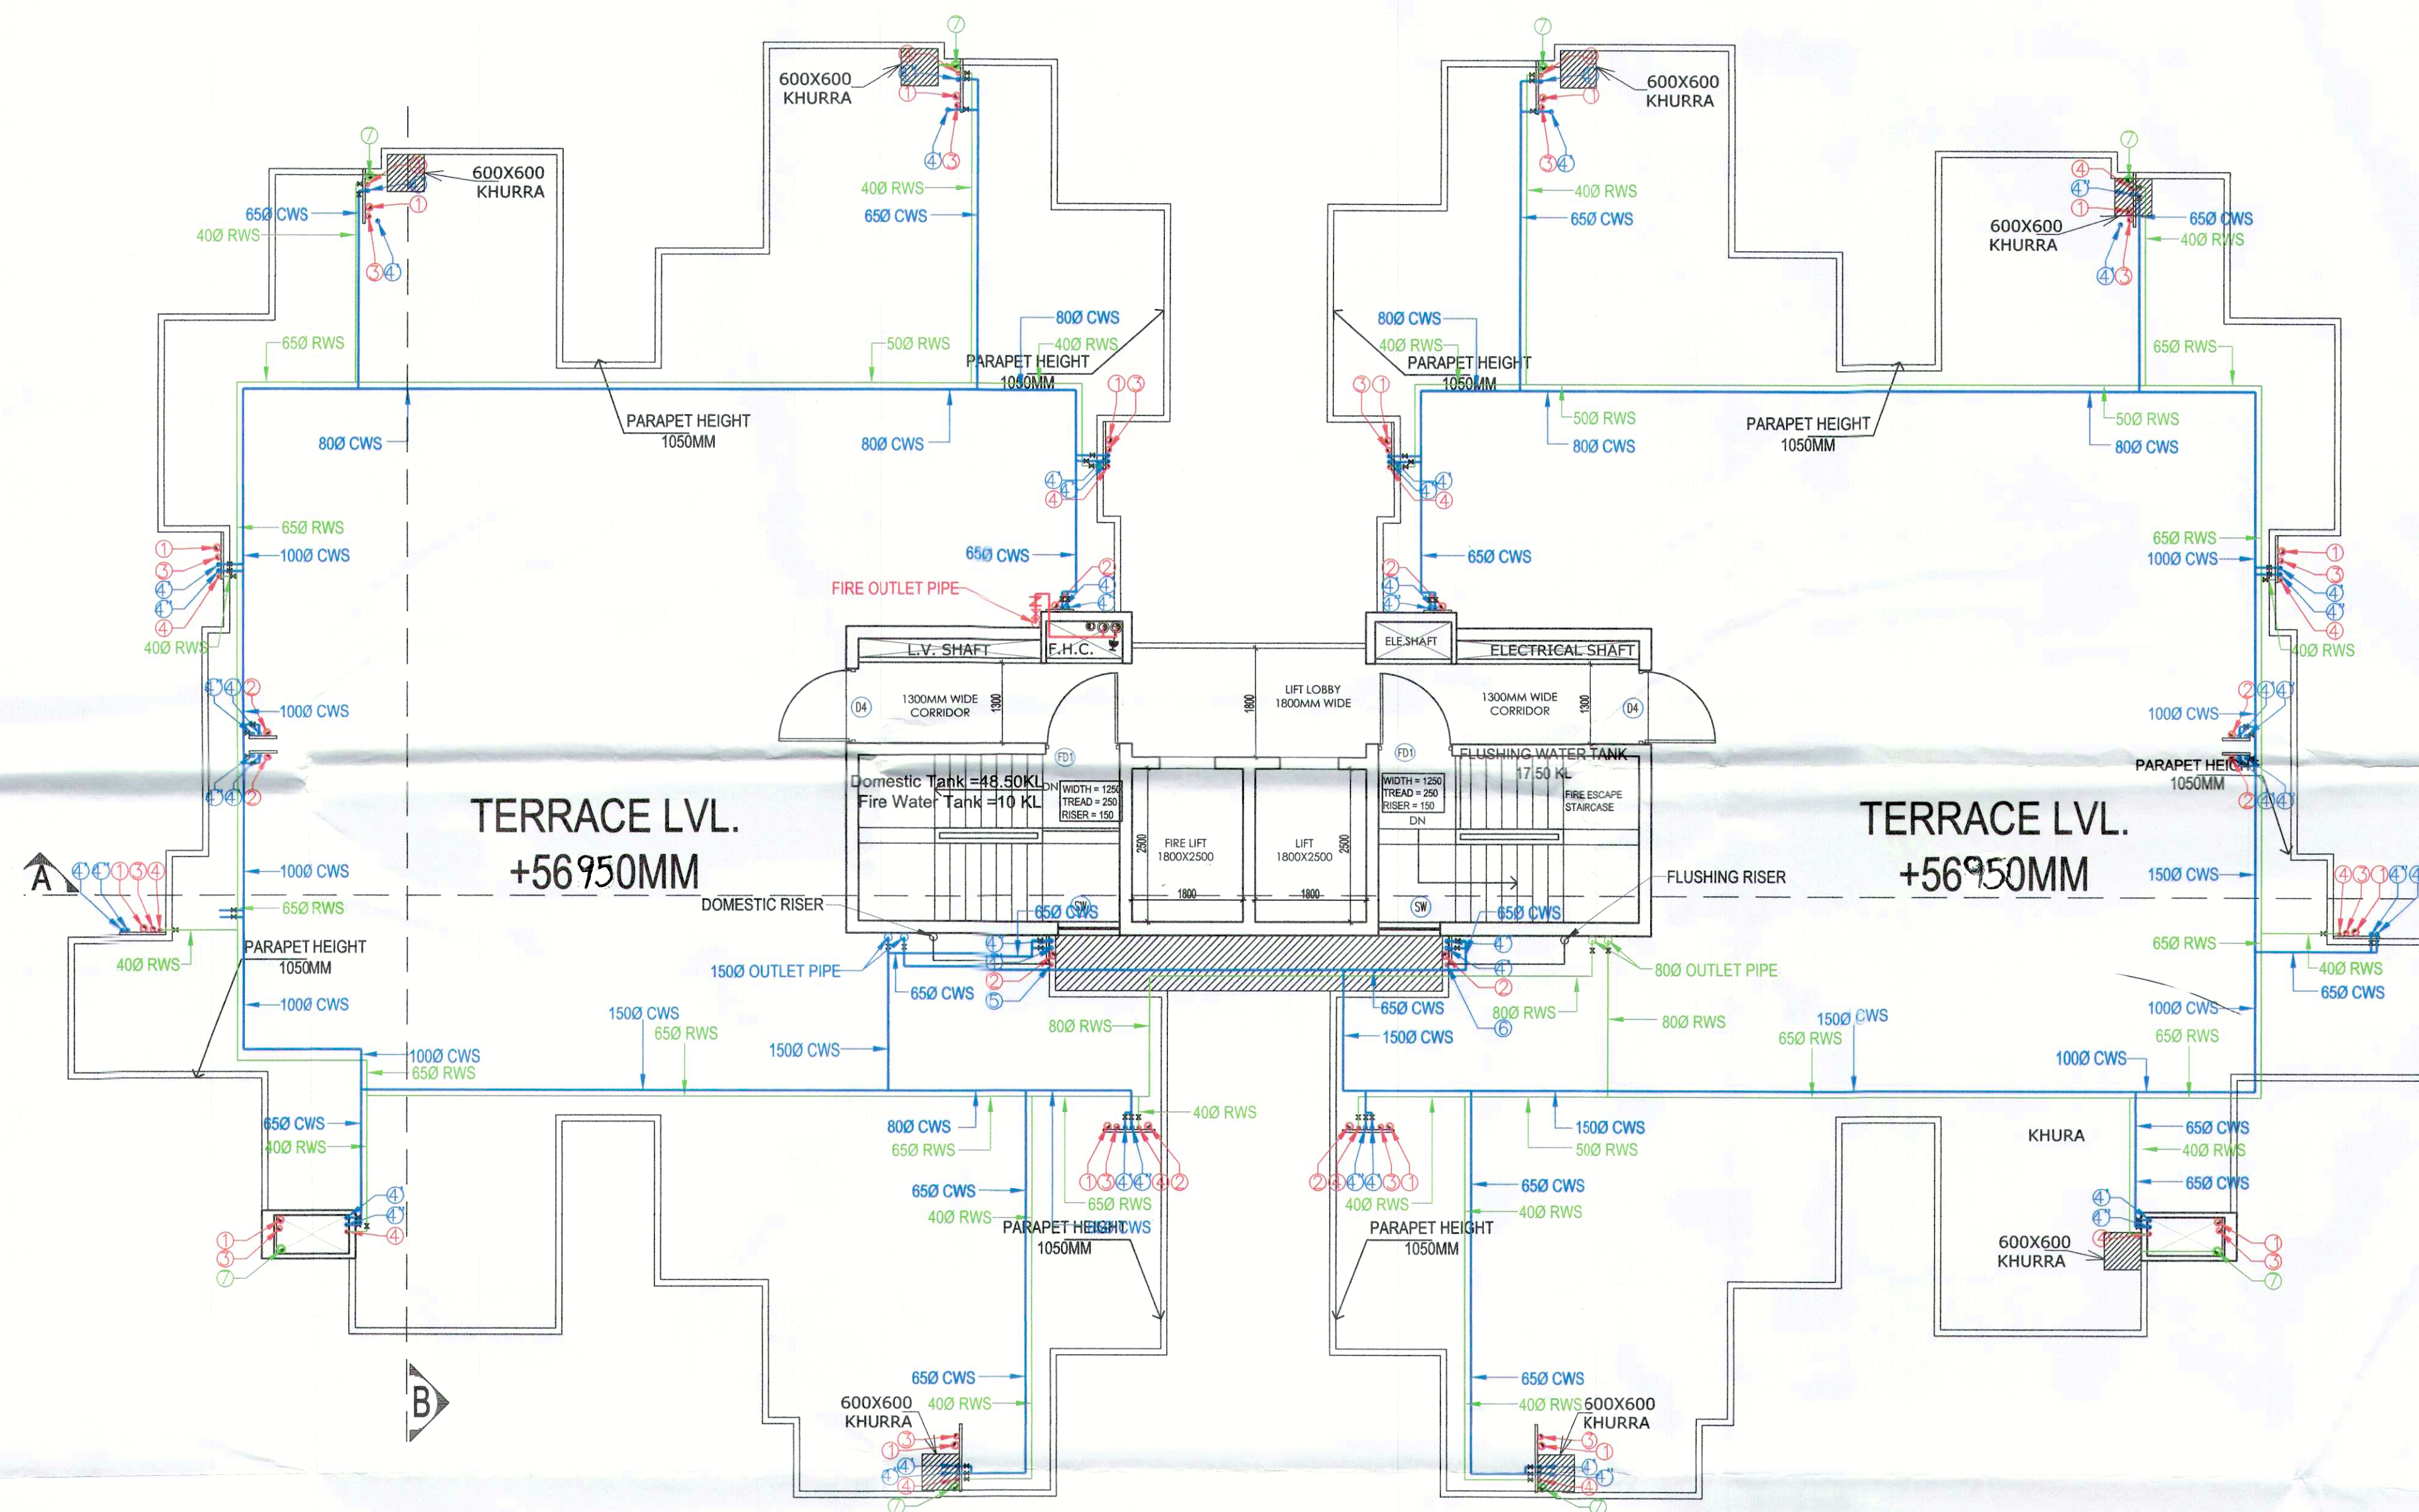

TERRACE PLAN

LEGEND: -

PLUMBING LEGEND	
①	110Ø OD uPVC SP STACK
②	110Ø OD uPVC WP STACK
③	75Ø A.S.P
④	DWS D/TAKE Checked and found ok for Public Health (Internal) Service only subject to comments in forwarding letter for ACE(HQ) DL 27/1/21
④	DWS D/TAKE Additional Chief Engineer (HQ) HSP, Panikula
⑤	DWS RISER
⑥	FLUSHING RISER
⑦	110Ø OD uPVC R.W.P
⑧	75Ø uPVC DRAIN PIPE (BALCONY)

MEMBER BPAC

LEGEND: -

SYMBOL	DESCRIPTION
	SOIL PIPE
	WASTE PIPE
	FT FLOOR TRAP
	CUTOUT
	FD FLOOR DRAIN
	CWS PIPE
	FWS PIPE
	CONTROL VALVE
	FIRE PIPE

ARCHITECT (H.Q.) S.T.P. Member Secretary B.P.C.
S.T.P. (H.Q.) Member Chairman B.P.C.

Ram Awar Bansi
AD(HQ)

P.A. A.T.P.

PROJECT:
Approval of Building Plan of Affordable Group Housing colony measuring 5.89 acres (License no. 63 dated 01-09-2021) in Revenue Estate of village Gadoli Kalan in Sector 37D, Gurugram. Being developed by LALWANI BROTHERS BUILDCON LLP IN COLLABORATION WITH STERNAL BUILDCON PVT. LTD.

ARCHITECT:
GIAN P. MATHUR AND ASSOCIATES (P) LTD.
C - 55, East Of Kailash, New Delhi-110065
T : 46599599 | F 46599512
E : info@gpmindia.com | W : www.gpmindia.com

services consultant
Consummate Engineering Services (P) Ltd.
Noida Office : B - 67, Sector - 67, Noida - 201 301
Tel : (0120) 2393500 (30 Lines)
Lko. Office : R 006, Rohas Plumeria, Gomti Nagar, Lucknow
e mail : mail@cespl.in, website : www.cespl.in

DRAWING TITLE:
TERRACE PLAN
TOWER - 02 & 03 (2BHK)
G+18 FLOORS

D.N. - SG/AH/SUB/AR-11	ARCHITECT'S SIGN 	OWNER'S SIGN
SCALE:- 1:75	GIAN P. MATHUR ARCHITECT B.Arch, M.C.A. I.I.T. C.No. 80/5769	DIRECTION
DATE:- 20 AUG 2021		
DRAWN BY:- ANANT		
CHECK BY:- NAMITA		