


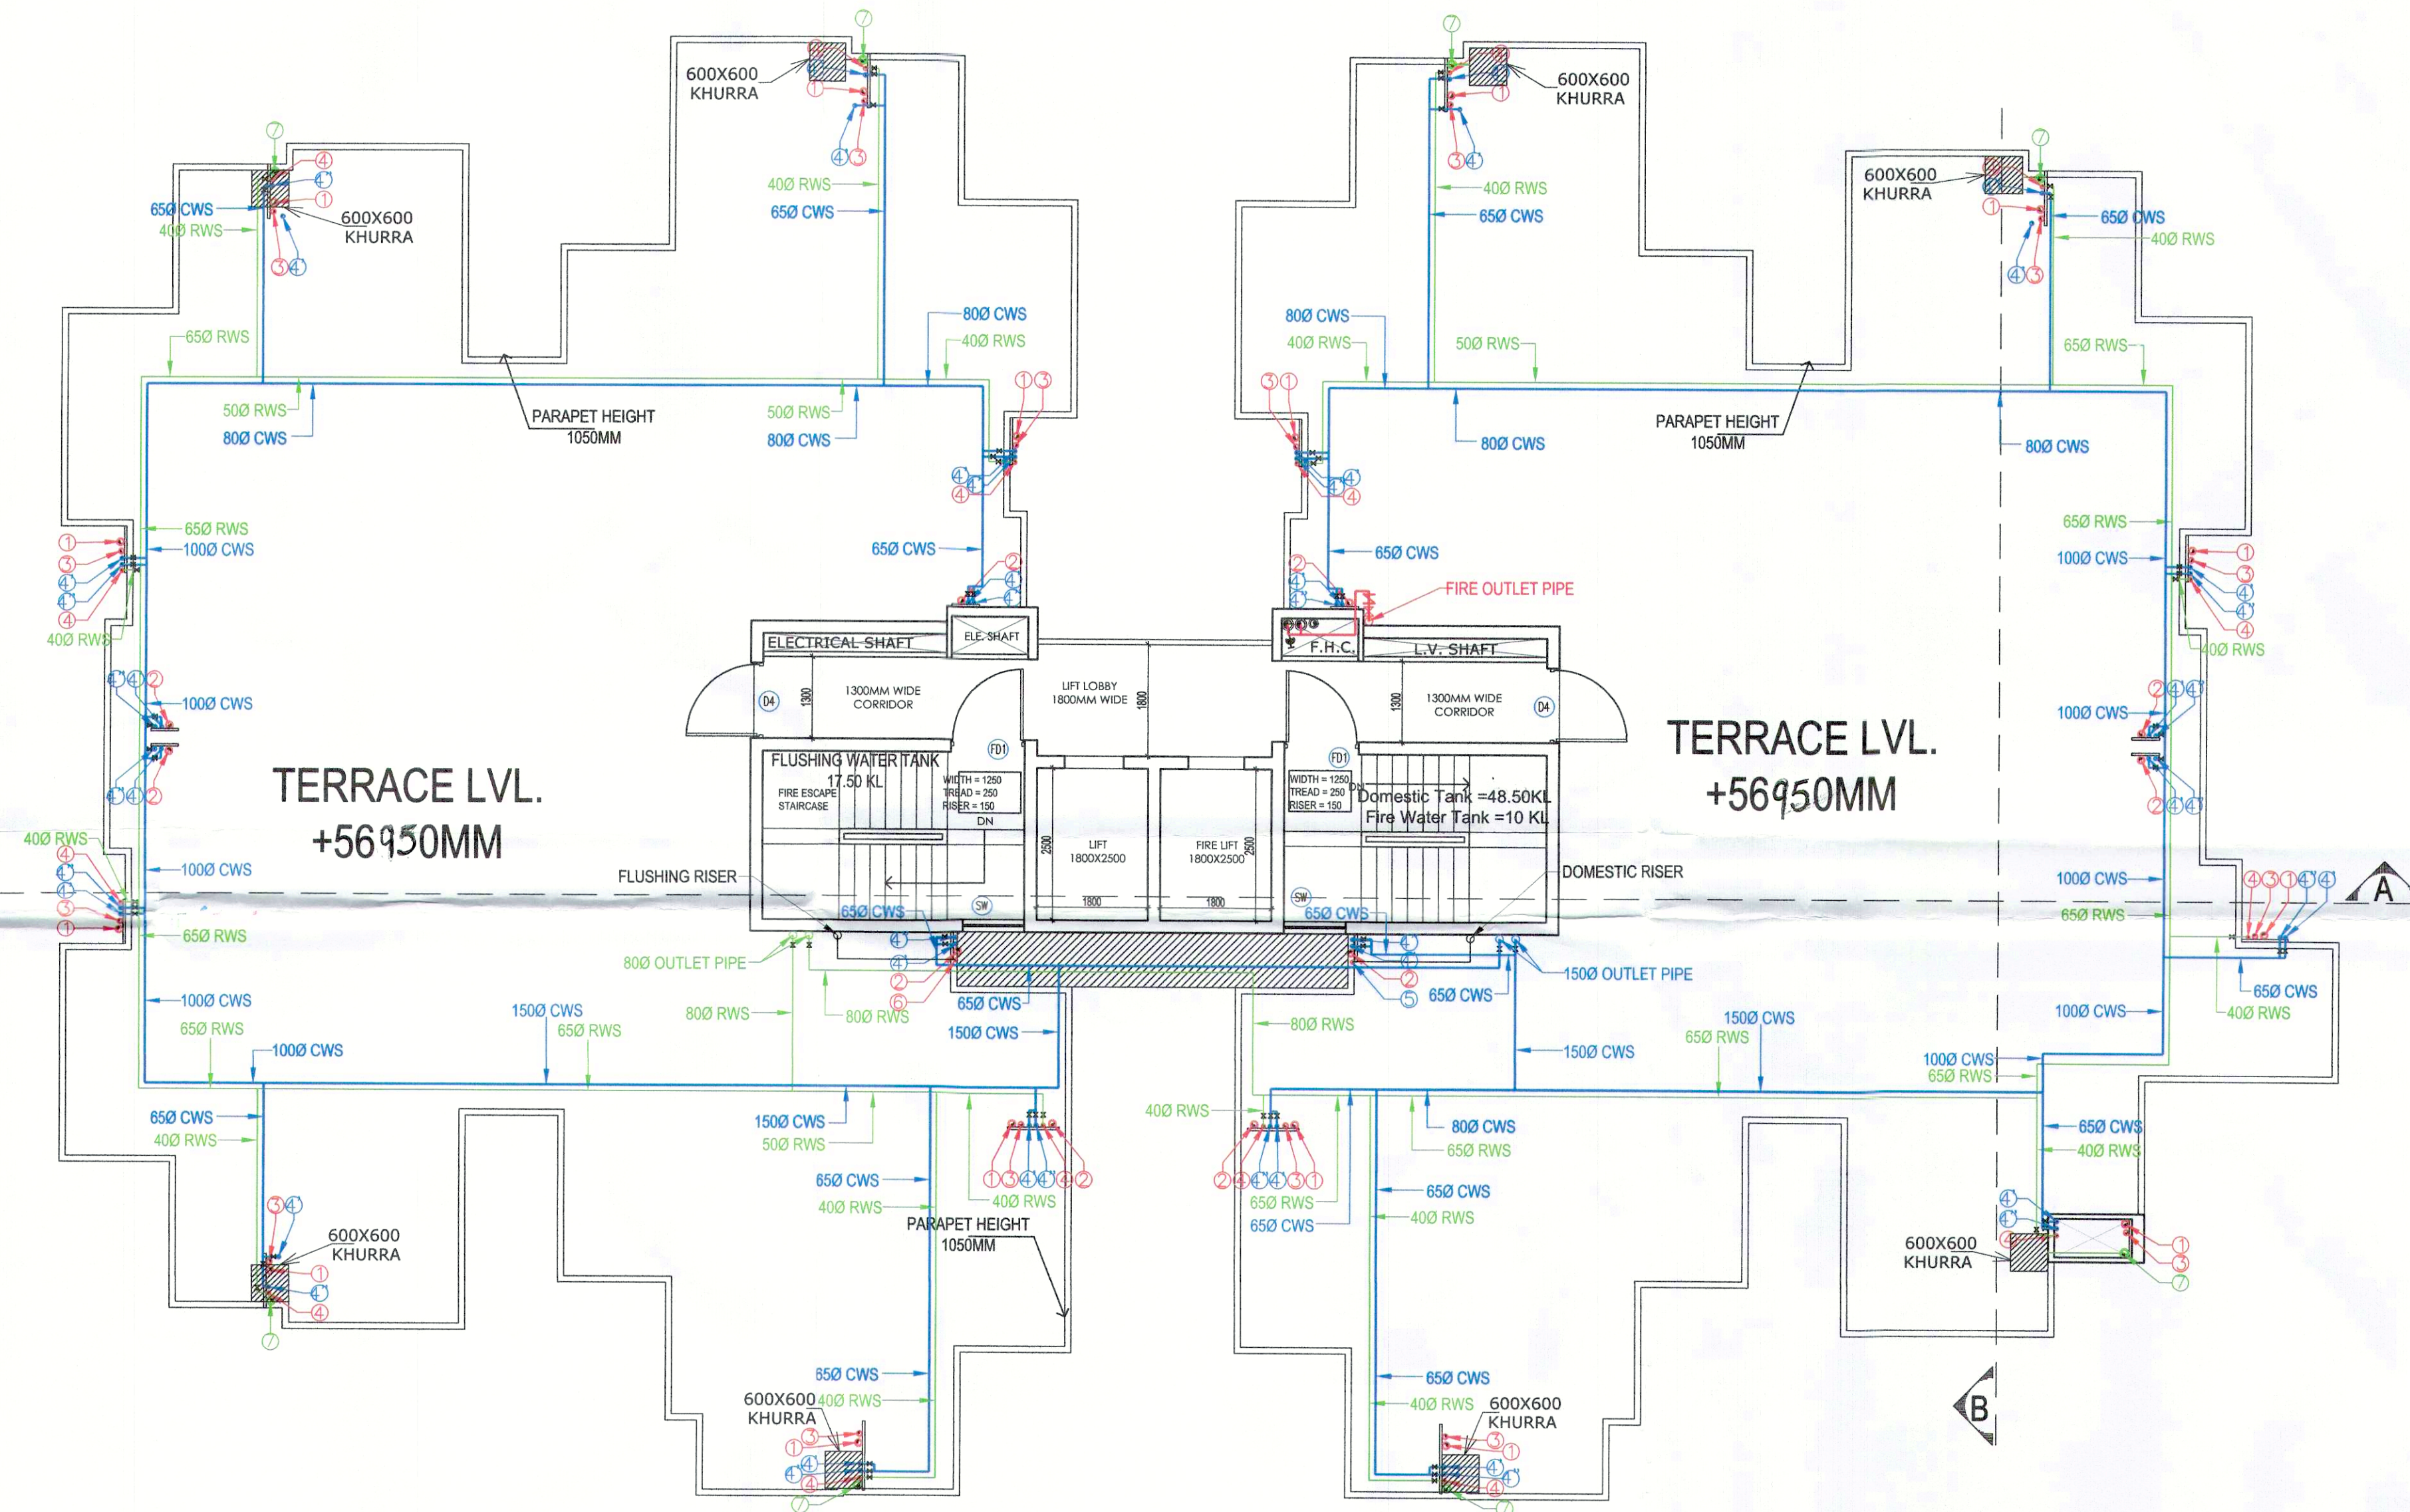

TERRACE PLAN

LEGEND: -

PLUMBING LEGEND	
①	110Ø OD uPVC SP STACK
②	110Ø OD uPVC WP STACK
③	75Ø A.S.P. Checked and found ok for Public Health
④	DWS D/TAKE (Internal) Service only subject to comments in forwarding letter to the A.C.E. (H.Q.)
⑤	FWS D/TAKE Additional Chief Engineer (H.Q.)
⑥	DWS RISER HQ/P, Panchsala
⑦	FLUSHING RISER
⑧	110Ø OD uPVC R.W.P.
⑨	75Ø uPVC DRAIN PIPE(BALCONY)

LEGEND: -

SYMBOL	DESCRIPTION
	SOIL PIPE
	WASTE PIPE
	FLOOR TRAP
	CUTOUT
	FLOOR DRAIN
	CWS PIPE
	FWS PIPE
	CONTROL VALVE
	FIRE PIPE

ARCHITECT (H.Q.) S.T.P.
 Member Secretary B.P.C.
 Member B.P.C.
 Chairman B.P.C.
 Ram Arvind Bassi
 AD(HQ)

P.A.
 A.T.P.

PROJECT:

Approval of Building Plan of Affordable Group Housing colony measuring 5.89 acres (License no. 63 dated 01-09-2021) in Revenue Estate of village Gadoli Kalan in Sector 37D, Gurugram. Being developed by LALWANI BROTHERS BUILDCON LLP IN COLLABORATION WITH SERNAL BUILDCON PVT. LTD.

ARCHITECT:



GIAN P. MATHUR AND ASSOCIATES (P) LTD.
 C - 55, East Of Kailash, New Delhi-110065
 T : 46599599 | F 46599512
 E : info@gpmindia.com | W : www.gpmindia.com

services consultant

Consummate Engineering Services (P) Ltd.



Noida Office : B - 67, Sector - 67, Noida - 201 301
 Tel : (0120) 2993500 (30 Lines)
 Lko Office : R 006, Rohas Plumeria, Gomti Nagar, Lucknow
 e mail : mail@cespl.in, website : www.cespl.in

DRAWING TITLE:

TERRACE PLAN
TOWER - 04 (2BHK)
G+18 FLOORS

D.N. -
SG/AH/SUB/AR-16

SCALE:- 1:75

DATE:-
20 AUG 2021

DRAWN BY:-
ANANT

CHECK BY:- NAMITA

ARCHITECT'S SIGN

GIAN P. MATHUR
 ARCHITECT
 B.Arch., U.C.A. I.I.A.
 CA No. 80/5769

OWNER'S SIGN

DIRECTION