



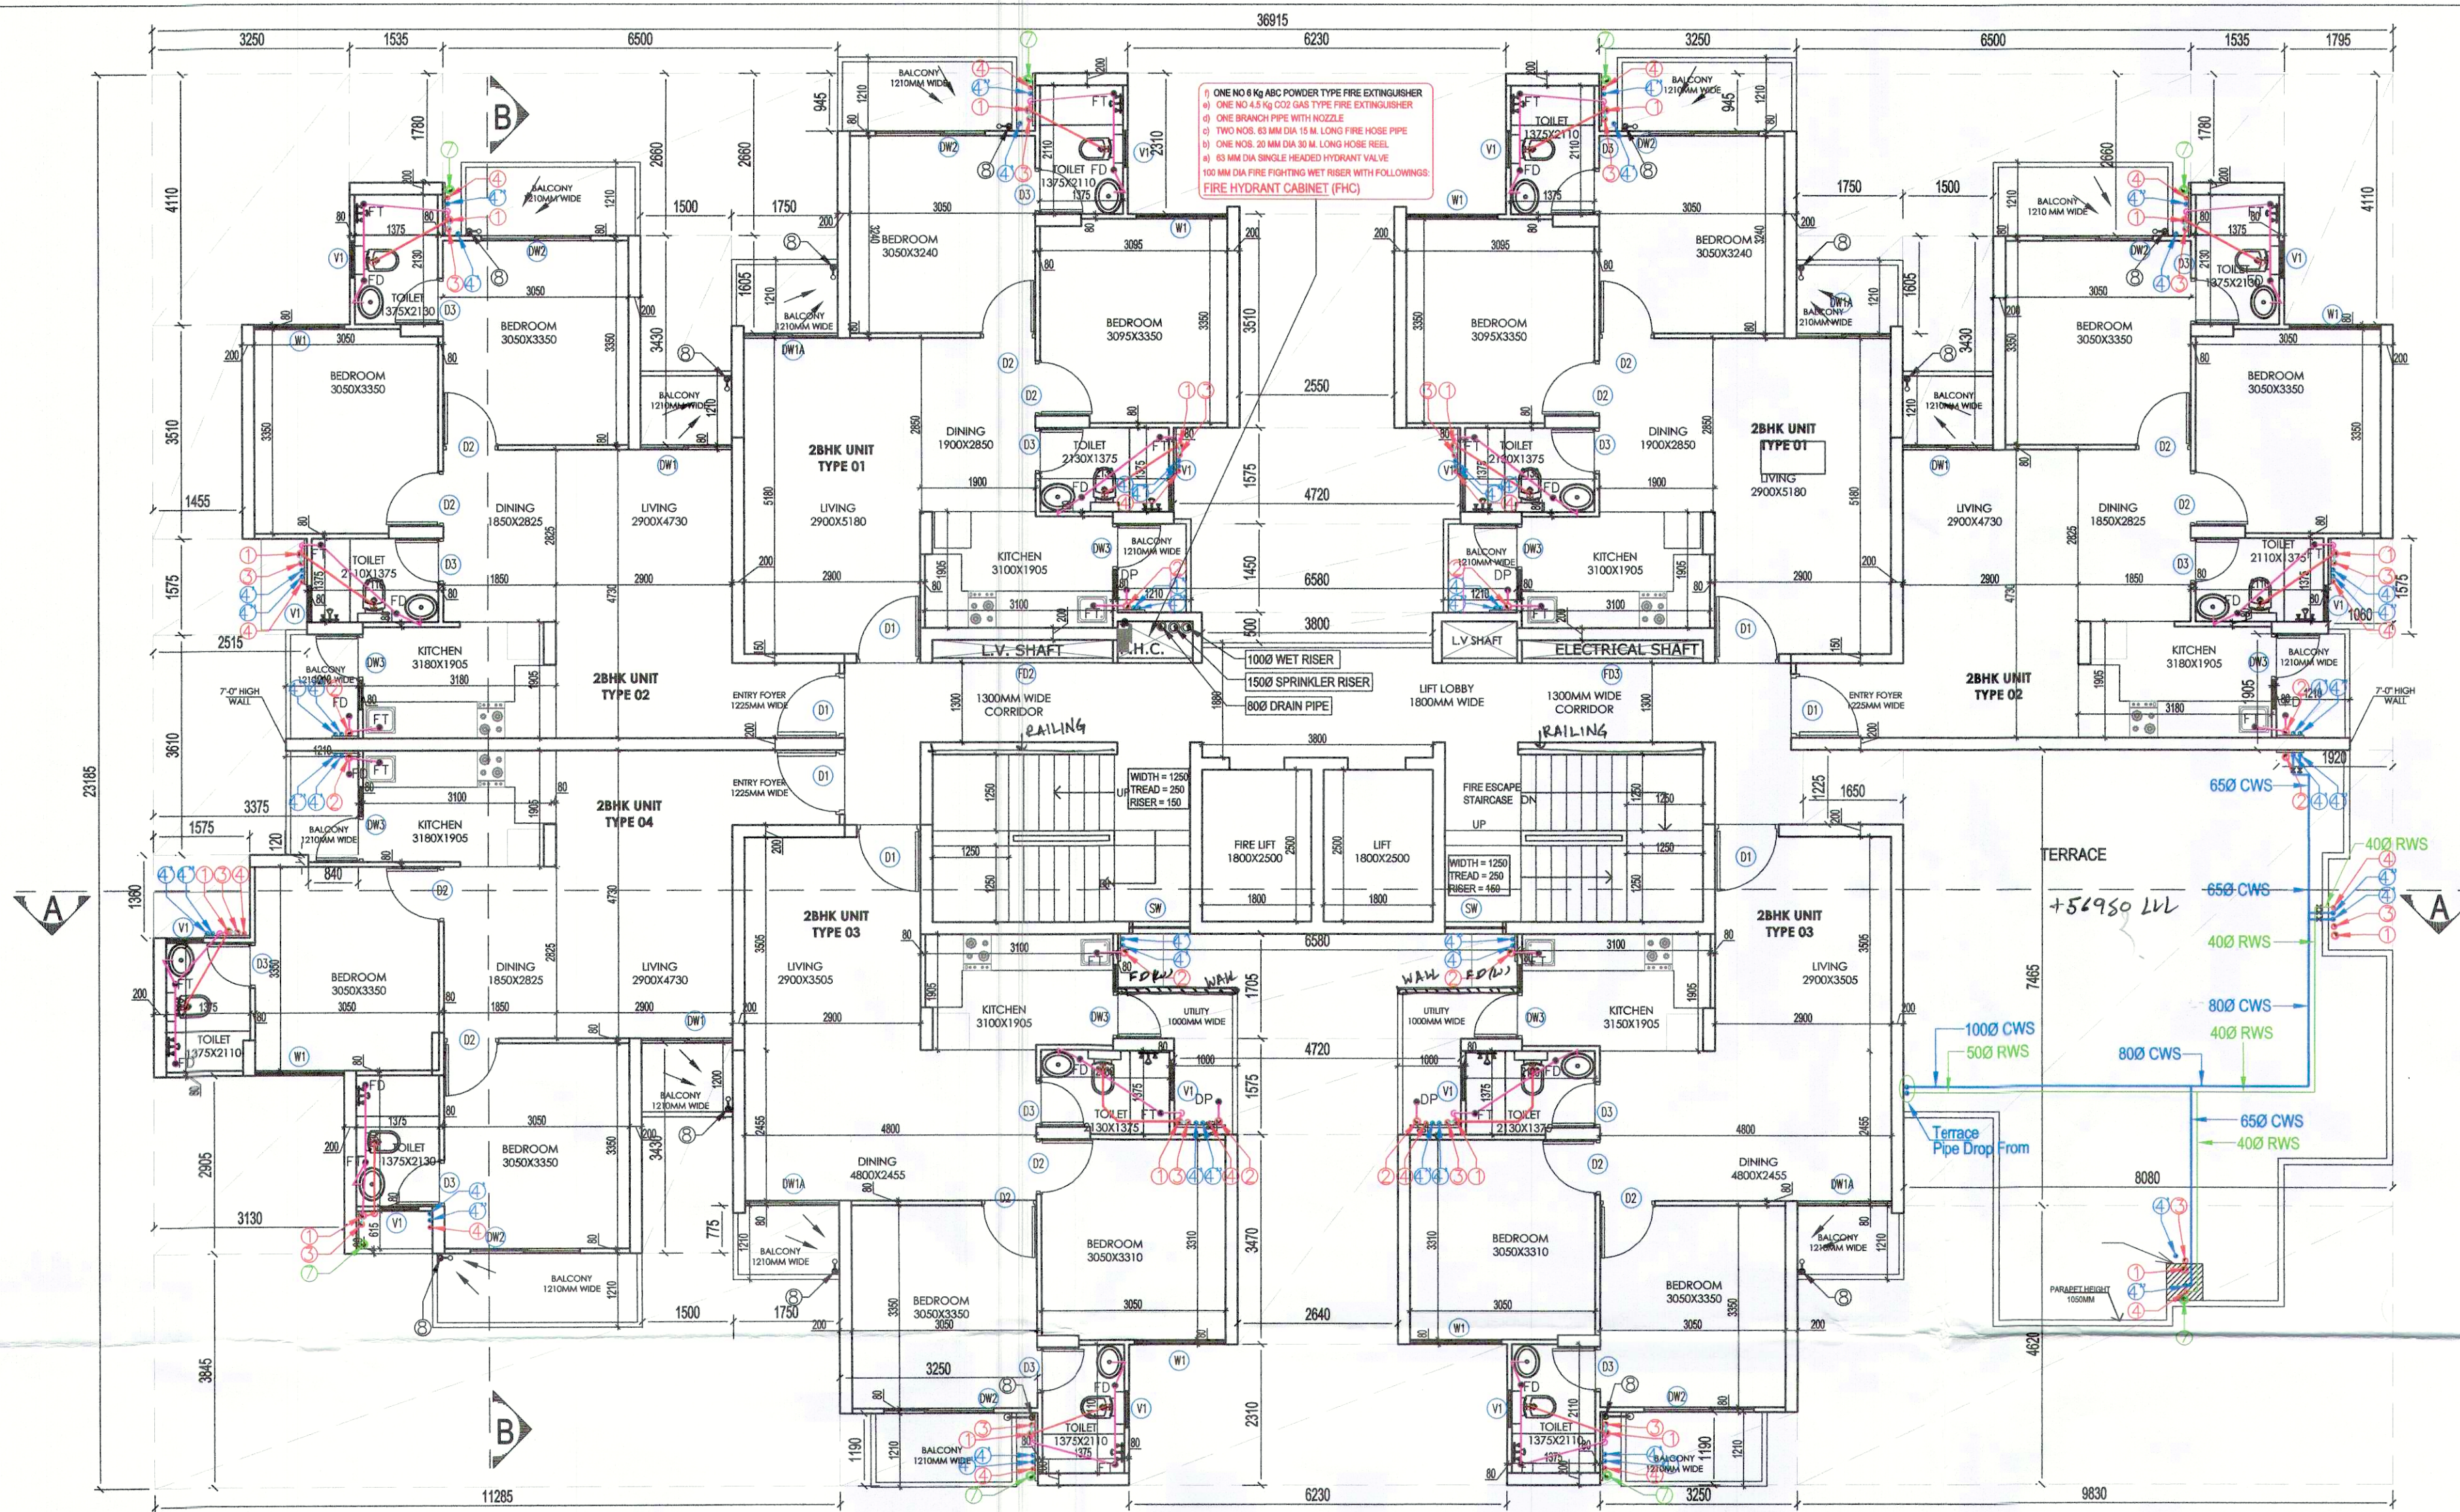

19TH FLOOR PLAN

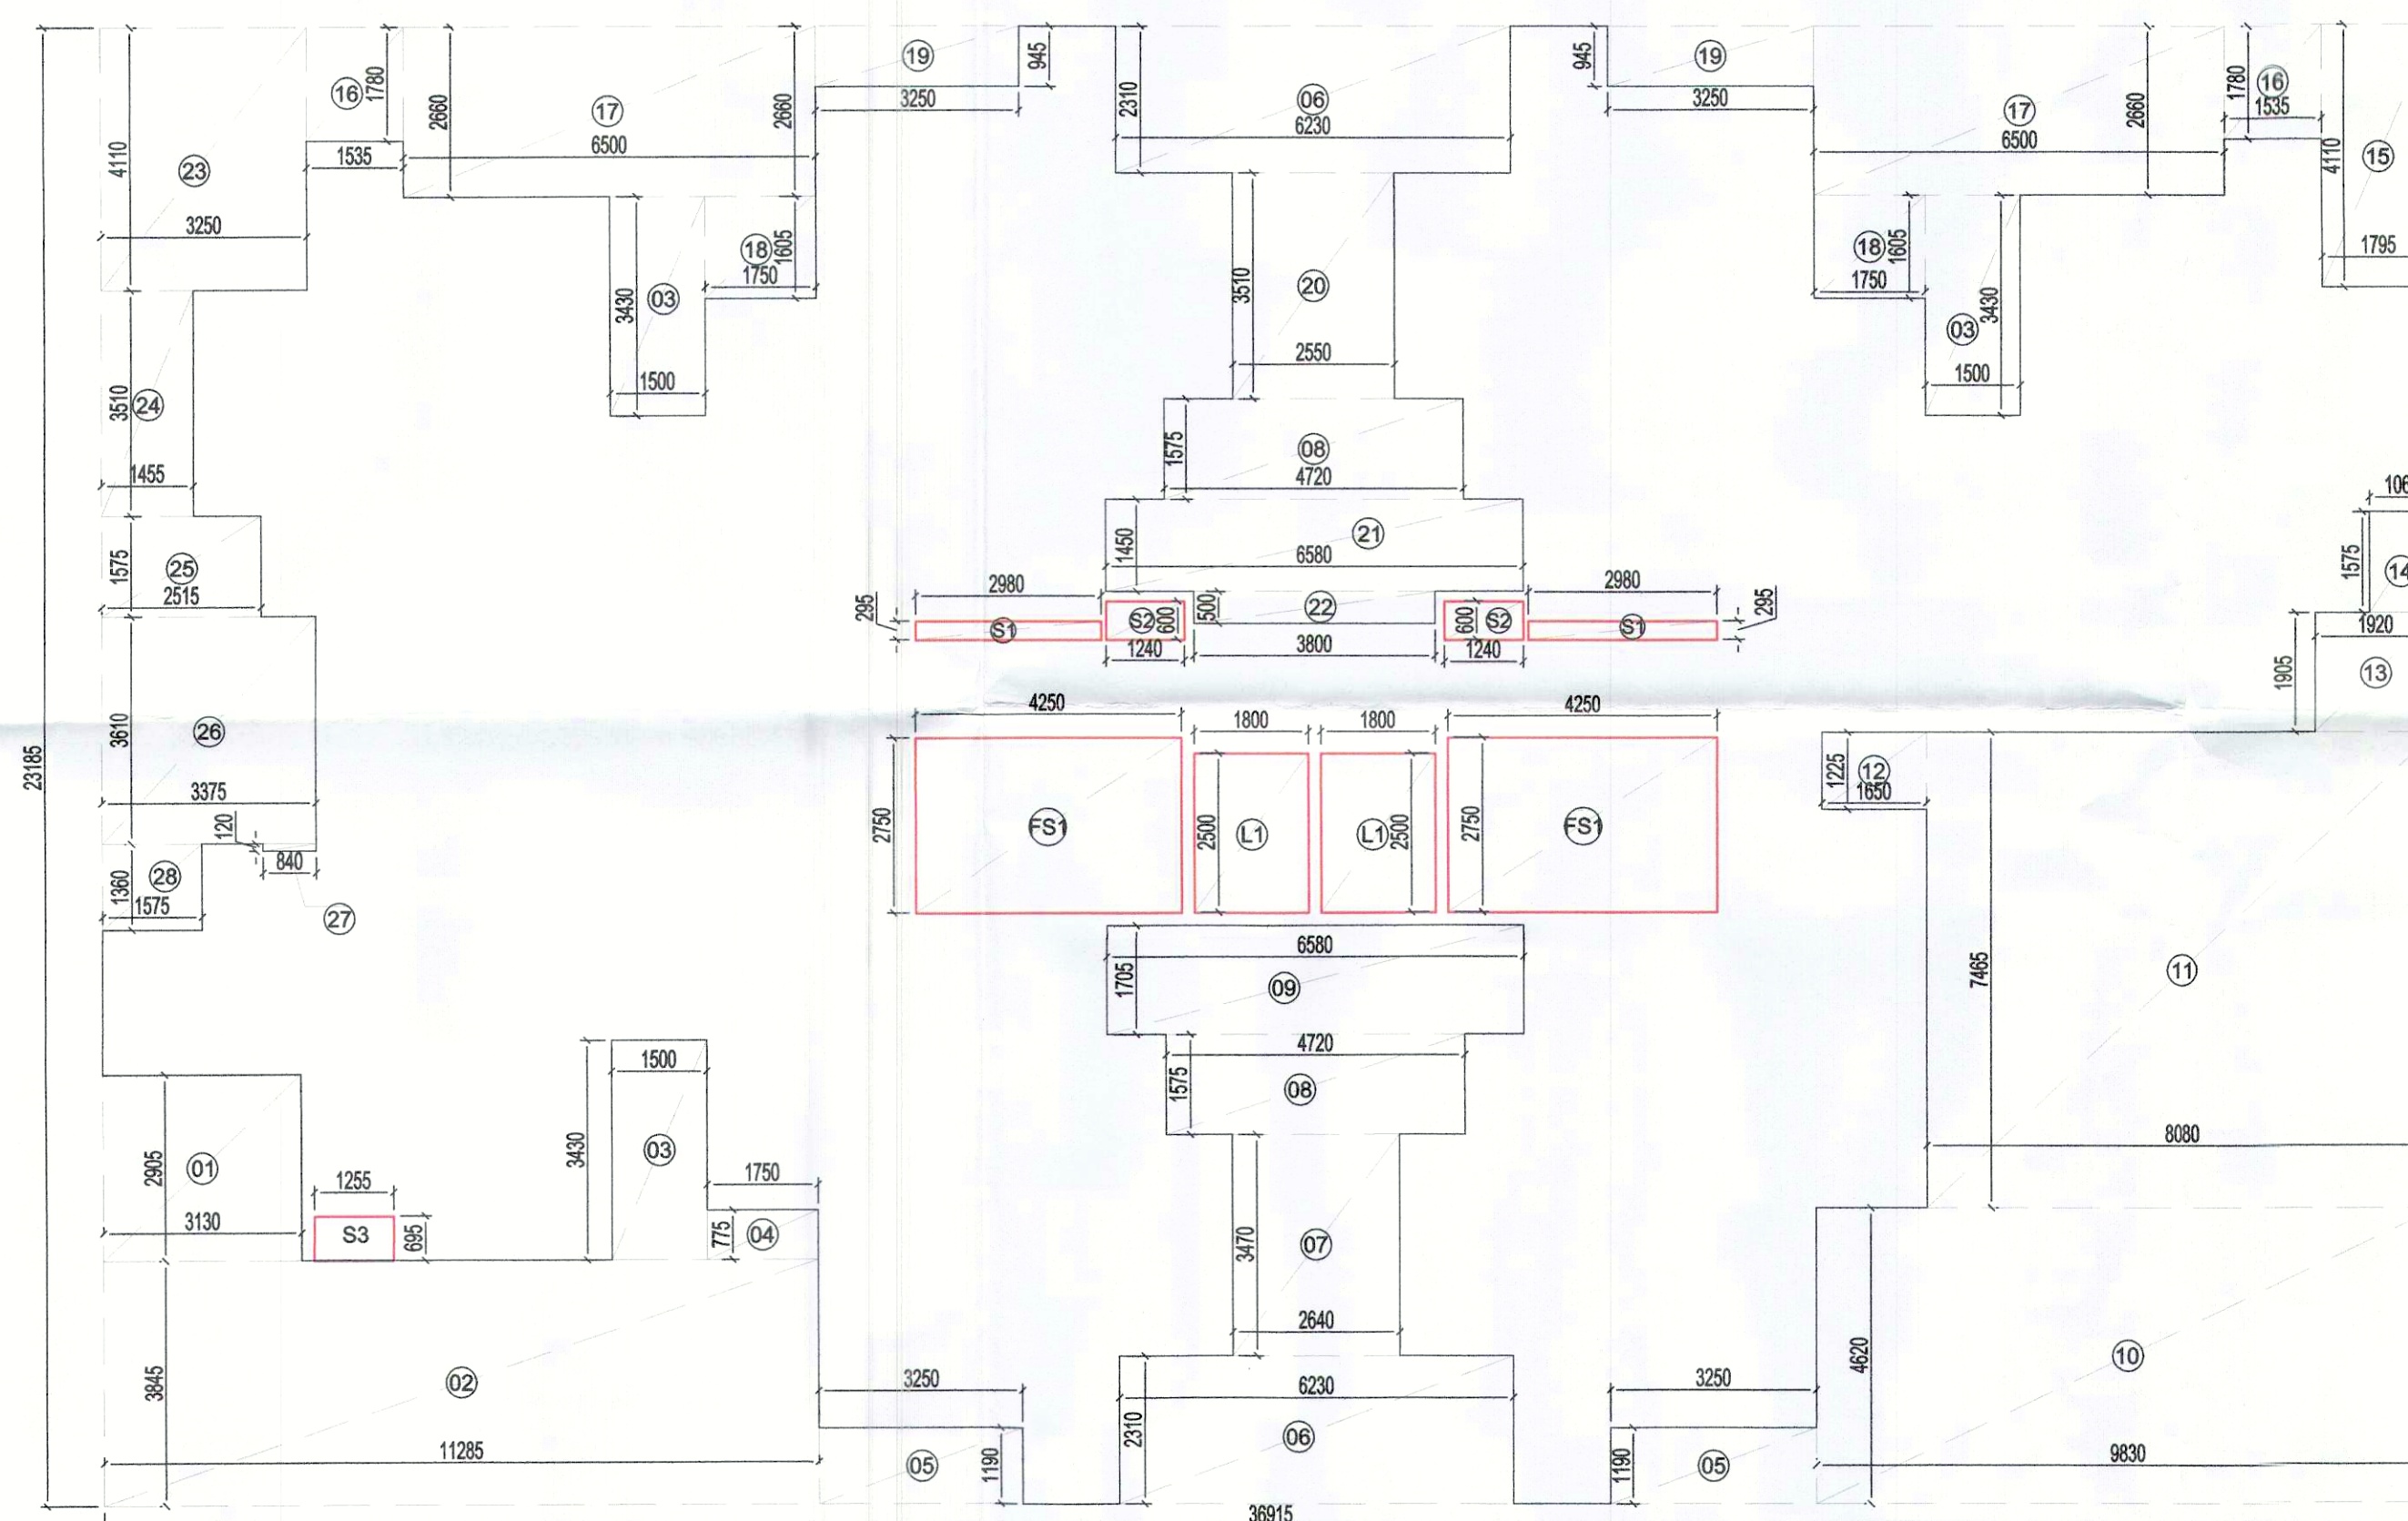

AREA DIAGRAM FOR 19TH FLOOR

19TH FLOOR AREA CALCULATION				
PART	AREA CALCULATION	NO.	TOTAL AREA IN SQ. MT	
1	36.915 X 23.185	1	855.874	
TOTAL A1			855.874	
DEDUCTION				
2	3.13 X 2.905	1	9.093	
3	11.285 X 3.945	1	44.591	
4	1.5 X 3.45	1	5.175	
5	1.75 X 0.775	1	1.356	
6	3.25 X 1.19	2	7.755	
7	6.39 X 2.31	2	29.788	
8	2.64 X 3.47	1	9.161	
9	4.72 X 1.575	2	14.868	
10	6.58 X 1.705	1	11.229	
11	9.88 X 4.62	1	45.445	
12	8.08 X 7.465	1	60.317	
13	1.65 X 1.225	1	2.021	
14	1.92 X 2.905	1	5.578	
15	1.06 X 1.575	1	1.670	
16	1.795 X 4.11	1	7.377	
17	1.585 X 1.78	2	5.465	
18	6.5 X 2.66	2	34.580	
19	1.75 X 1.605	2	5.618	
20	3.25 X 0.945	2	6.143	
21	2.55 X 3.51	1	8.951	
22	6.58 X 1.45	1	9.541	
23	3.8 X 0.5	1	1.900	
24	3.25 X 4.11	1	13.388	
25	1.455 X 3.51	1	5.107	
26	2.515 X 1.575	1	3.961	
27	3.375 X 3.61	1	12.184	
28	0.84 X 0.12	1	0.101	
29	1.575 X 1.36	1	2.142	
TOTAL D1			370.546	
SERVICE SHAFTS				
S1	2.98 X 0.25	2	1.798	
S2	1.34 X 0.6	2	1.488	
S3	1.255 X 0.695	1	0.872	
L1	1.8 X 2.5	2	9.000	
TOTAL A2			13.158	
STAIRCASE				
S3	4.25 X 2.75	2	23.375	
TOTAL A3			23.375	
NET AREA FOR 19TH FLOOR (A1-D1-A2-A3)			448.885	SQ. MT

LEGEND:-

PLUMBING LEGEND	
①	110Ø OD uPVC SP STACK
②	110Ø OD uPVC WP STACK
③	75Ø A.S.P
④	DWS D/TAKE
⑤	DWS D/TAKE
⑥	FWS D/TAKE
⑦	DWS RISER
⑧	FLUSHING RISER
⑨	110Ø OD uPVC R.W.P
⑩	75Ø uPVC DRAIN PIPE(BALCONY)

LEGEND:-

SYMBOL	DESCRIPTION
—	SOIL PIPE
—	WASTE PIPE
⊙	FLOOR TRAP
⊗	CUTOUT
⊙	FLOOR DRAIN
—	CWS PIPE
—	FWS PIPE
—	CONTROL VALVE
—	FIRE PIPE

Checked and found ok for Public Health
(Internal) Service only subject to comments in
in following letter to ACE(HQ) DL 24/9/21
189633
Additional City Engineer (HQ)
H&P, Panaji
P
Ram Arfar Bassi
AD(HQ)
B.P.C.
B.P.C.
B.P.C.
P.A.
A.T.P.

DOOR WINDOW OPENING SCHEDULE					
TYPE	WIDTH	HEIGHT	SILL HEIGHT	UNIT HEIGHT	REMARK
D1	1050	2100	00	2100	ENTRY TO UNITS
D2	800	2100	00	2100	BEDROOMS
D3	750	2100	00	2100	TOILET
D4	1200	2100	00	2100	TERRACE
DW1	1540	2320	00	2320	BALCONY(LIVING)
DW1A	1590	2320	00	2320	BALCONY(LIVING)
DW2	1800	2320	00	2320	BALCONY(BEDROOM)
DW3	750+450	2320,1270	00,1050	2320	BALCONY(KITCHEN)
W1	1500	2020	300	2320	BEDROOM WINDOW
V1	600	1270	1050	2320	TOILET VENTILATOR
FD1	1200	2100	00	2100	STAIRCASE
FD2	800	2000	100	2100	LV SHAFT
FD3	1500	2000	100	2100	ELECT. SHAFT
SW	1000	1050	1050	2100	STAIRCASE WINDOW

PROJECT:

Approval of Building Plan of Affordable Group Housing colony measuring 5.89 acres (License no. 63 dated 01-09-2021) in Revenue Estate of village Gadoli Kalan in Sector 37D, Gurugram. Being developed by LALWANI BROTHERS BUILDCON LLP IN COLLABORATION WITH SERNAL BUILDCON PVT. LTD.

ARCHITECT:

GIAN P. MATHUR AND ASSOCIATES (P) LTD.
C - 55, East Of Kailash, New Delhi-110065
T : 465995991 F 46599512
E : info@gpmindia.com I W : www.gpmindia.com

services consultant

Consummate Engineering Services (P) Ltd.

Noida Office : B - 67, Sector - 67, Noida - 201 301
Tel : (0120) 2993500 (30 Lines)
Lko. Office : R 006, Rohas Plumeria, Gomti Nagar, Lucknow
e mail : mail@cespl.in, website : www.cespl.in

DRAWING TITLE:

19TH FLOOR PLAN
TOWER - 05 (2BHK)
G+19 FLOORS

D.N. -

SG/AH/SUB/AR-23

SCALE:- 1:75

DATE:-

20 AUG 2021

DRAWN BY:-

ANANT

CHECK BY:- NAMITA

ARCHITECT'S SIGN

OWNER'S SIGN

GIAN P. MATHUR
ARCHITECT
B.Arch, M.C.A. I.I.A.
CANo. 80/5769

DIRECTION

NORTH