


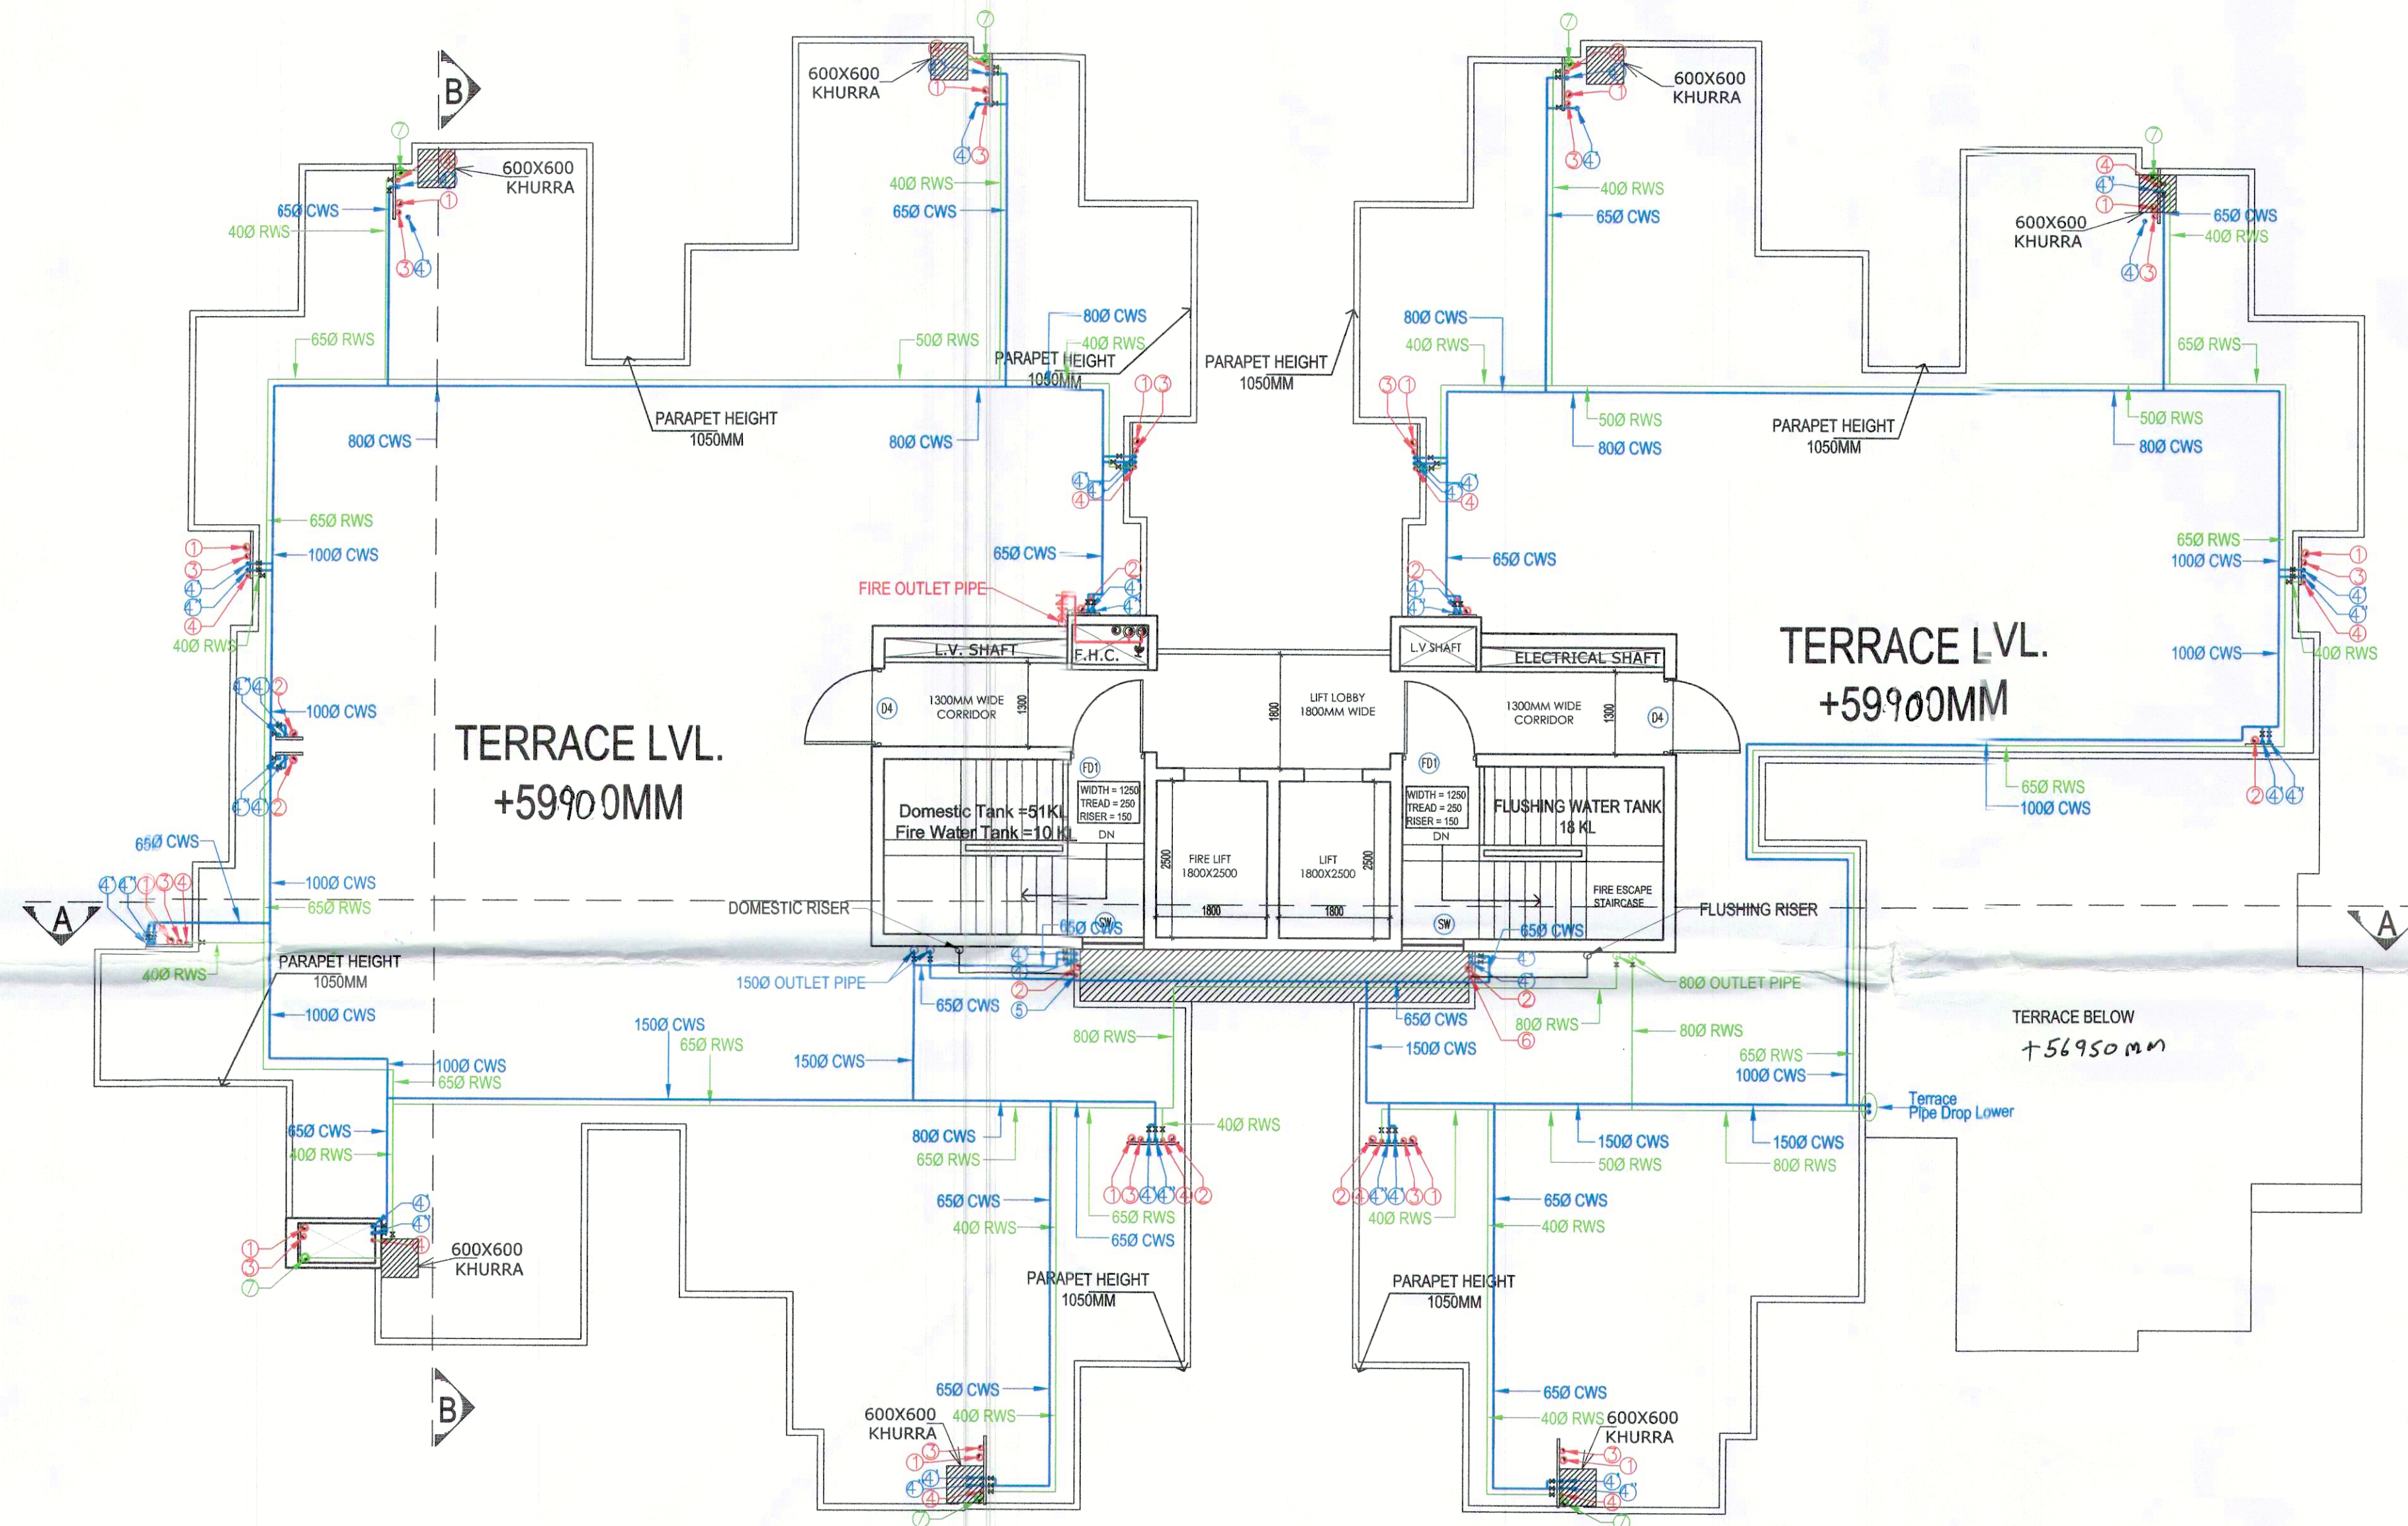

TERRACE PLAN

LEGEND: -

PLUMBING LEGEND	
①	110Ø OD uPVC SP STACK
②	110Ø OD uPVC WP STACK
③	75Ø A.S.P. Checked and found ok for Public Health (Internal) Service only subject to comments in in forwarding letter No. ACE(HQ).....DL-29/1/24 169433
④	DWS D/TAKE Additional Chief Engineer (HQ) HSWP, Palwal
⑤	DWS RISER
⑥	FLUSHING RISER
⑦	110Ø OD uPVC R.W.P
⑧	75Ø uPVC DRAIN PIPE(BALCONY)

LEGEND: -

SYMBOL	DESCRIPTION
	SOIL PIPE
	WASTE PIPE
	FLOOR TRAP
	CUTOUT
	FLOOR DRAIN
	CWS PIPE
	FWS PIPE
	CONTROL VALVE
	FIRE PIPE

[Signature]
ARCHITECT (H.Q.) S.T.P. S.P. (G. O.P.P. Hr.)
Member Secretary Member Chairman
B.P.C. B.P.C. B.P.C.

[Signature]
Ram Avtar Bassi
AD(HQ)

[Signature] P.A.
[Signature] A.T.P.

PROJECT:

Approval of Building Plan of Affordable Group Housing colony measuring 5.89 acres (License no. 63 dated 01-09-2021) in Revenue Estate of village Gadoli Kalan in Sector 37D, Gurugram. Being developed by LALWANI BROTHERS BUILDCON LLP IN COLLABORATION WITH STERNAL BUILDCON PVT. LTD.

ARCHITECT:



GIAN P. MATHUR AND ASSOCIATES (P) LTD.
C-55, East Of Kailash, New Delhi-110065
T: 46599599 | F: 46599512
E: info@gpmindia.com | W: www.gpmindia.com

services consultant

Consummate Engineering Services (P) Ltd.

cespi
Noida Office : B-67, Sector-67, Noida - 201 301
Tel : (0120) 2993500 (30 Lines)
Lko. Office : R-006, Rohas Puri, Gomti Nagar, Lucknow
e mail : mail@cespi.in, website : www.cespi.in

DRAWING TITLE:

TERRACE PLAN
TOWER - 05 (2BHK)
G+19 FLOORS

D.N. -
SG/AH/SUB/AR-24

SCALE:- 1:75

DATE:-
20 AUG 2021

DRAWN BY:-
ANANT

CHECK BY:- NAMITA

ARCHITECT'S SIGN

[Signature]

GIAN P. MATHUR

ARCHITECT
B.Arch., M.C.A. I.I.A.
CA No. 80/5769

OWNER'S SIGN

DIRECTION

