

PLUMBING LEGEND:-

- 11000 CI SOIL & VENT PIPE
- 21000 CI WASTE & VENT PIPE
- 3ANTI-SYPHONAGE PIPE
- 4DOMESTIC WATER DN TAKE PIPE
- 5aFLUSHING WATER DN. TAKE PIPE
- 5bHOT WATER RETURN
- 6DOMESTIC WATER RISER
- 7FLUSHING WATER RISER
- 81000 RAIN WATER PIPE
- 91500 RAIN WATER PIPE
- 122000 CI SOIL PIPE
- 132000 RAIN WATER PIPE

LEGEND:-
DOMESTIC WATER SUPPLY DWS
FLUSHING WATER SUPPLY FWS
FLOOR TRAP 100x100(deep seal) FT
FLOOR DRAIN 65x50 FD
VALVE

DETAIL OF PIPE CONNECTIONS

FROM WC TO STACK/WH 1000 CI SOIL PIPE
FROM UT TO STACK/WH 1000 CI SOIL PIPE
FROM FT TO STACK/FT 1000 CI WASTE PIPE
FROM WC WASTE TO FT 500 GI PIPE
FROM WB WASTE TO FT 320 GI PIPE

TOILET REQUIREMENTS: (3 sq.mt./1 person)

W.C.	FOR MALE:		FOR FEMALE:	
	REQUIRED	PROVIDED	REQUIRED	PROVIDED
WASH BASIN	8	9	15	12
URINAL	50	50		

SCHEDULE OF DOOR AND WINDOW

Sl. No.	DOOR	Sl. No.	WINDOW
1	D 1 1500 X 2100	1	W 1 1500 X 2100
2	D 2 1200 X 2100	2	W 2 1200 X 2100
3	D 3 1050 X 2100	3	W 3 1050 X 2100
4	D 4 750 X 2100	4	W 4 750 X 2100
5	D 5 600 X 2100	5	W 5 600 X 2100
6	GL 3620 X 2400	6	W 6 3620 X 2400
7	GL 1 3300 X 2400	7	W 7 3300 X 2400
8	GL 2 2940 X 2400	8	W 8 2940 X 2400
9	GL 3 3000 X 2400	9	W 9 3000 X 2400
10	GL 4 2400 X 2400	10	W 10 2400 X 2400
11	GL 5 2865 X 2400	11	W 11 2865 X 2400
12	GL 6 2765 X 2400	12	W 12 2765 X 2400
13	GL 7 2105 X 2400	13	W 13 2105 X 2400
14	GL 8 3430 X 2400	14	W 14 3430 X 2400
15	GL 9 2865 X 2400	15	W 15 2865 X 2400
16	GL 10 1800 X 2400	16	W 16 1800 X 2400
17	GL 11 3125 X 2400	17	W 17 3125 X 2400
18	GL 12 2555 X 2400	18	W 18 2555 X 2400
19	GL 13 3300 X 2400	19	W 19 3300 X 2400
20	GL 14 2055 X 2400	20	W 20 2055 X 2400
21	GL 15 5985 X 2400	21	W 21 5985 X 2400
22	W 2535 X 2400	22	W 22 2535 X 2400

SUBMISSION DRAWING

PROJECT: APPROVAL OF REVISED BUILDING PLANS FOR COMMERCIAL COLONY MEASURING IN AREA OF 4.237 ACRES (LICENSE NO. 291 DATED 31/12/2007) IN SECTOR - 67 GURGAON MANESAR URBAN COMPLEX IN FAVOUR OF M/S ANSAL PROPERTIES & INFRASTRUCTURE LTD.

OWNER:

ANSAL PROPERTIES & INFRASTRUCTURE LTD.
115,ANSAL BHAWAN
16,KASTURBA GANDHI MARG
NEW DELHI 110001

DRAWING TITLE:

GROUND FLOOR PLAN

SCALE:

1:100

DATE:

04.02.2012

ARCHITECT

SPECTRAL
SERVICE CONSULTANTS PVT. LTD.
A-197, Sector-43, Noida, India
Ph: 0120-4049000
Fax: 91-120-4049001

OWNER SIGNATURE:

For Ansal Properties & Infrastructure Ltd.
Kasturba Gandhi Marg
New Delhi 110001




ARCHITECT SIGNATURE:

For Spectral
Service Consultants Pvt. Ltd.
A-197, Sector-43, Noida, India
Ph: 0120-4049000
Fax: 91-120-4049001

ARCHITECTURAL ELEVATION

Architectural Elevation
Ground Floor
Scale: 1:100
Date: 04.02.2012

Sanctioned

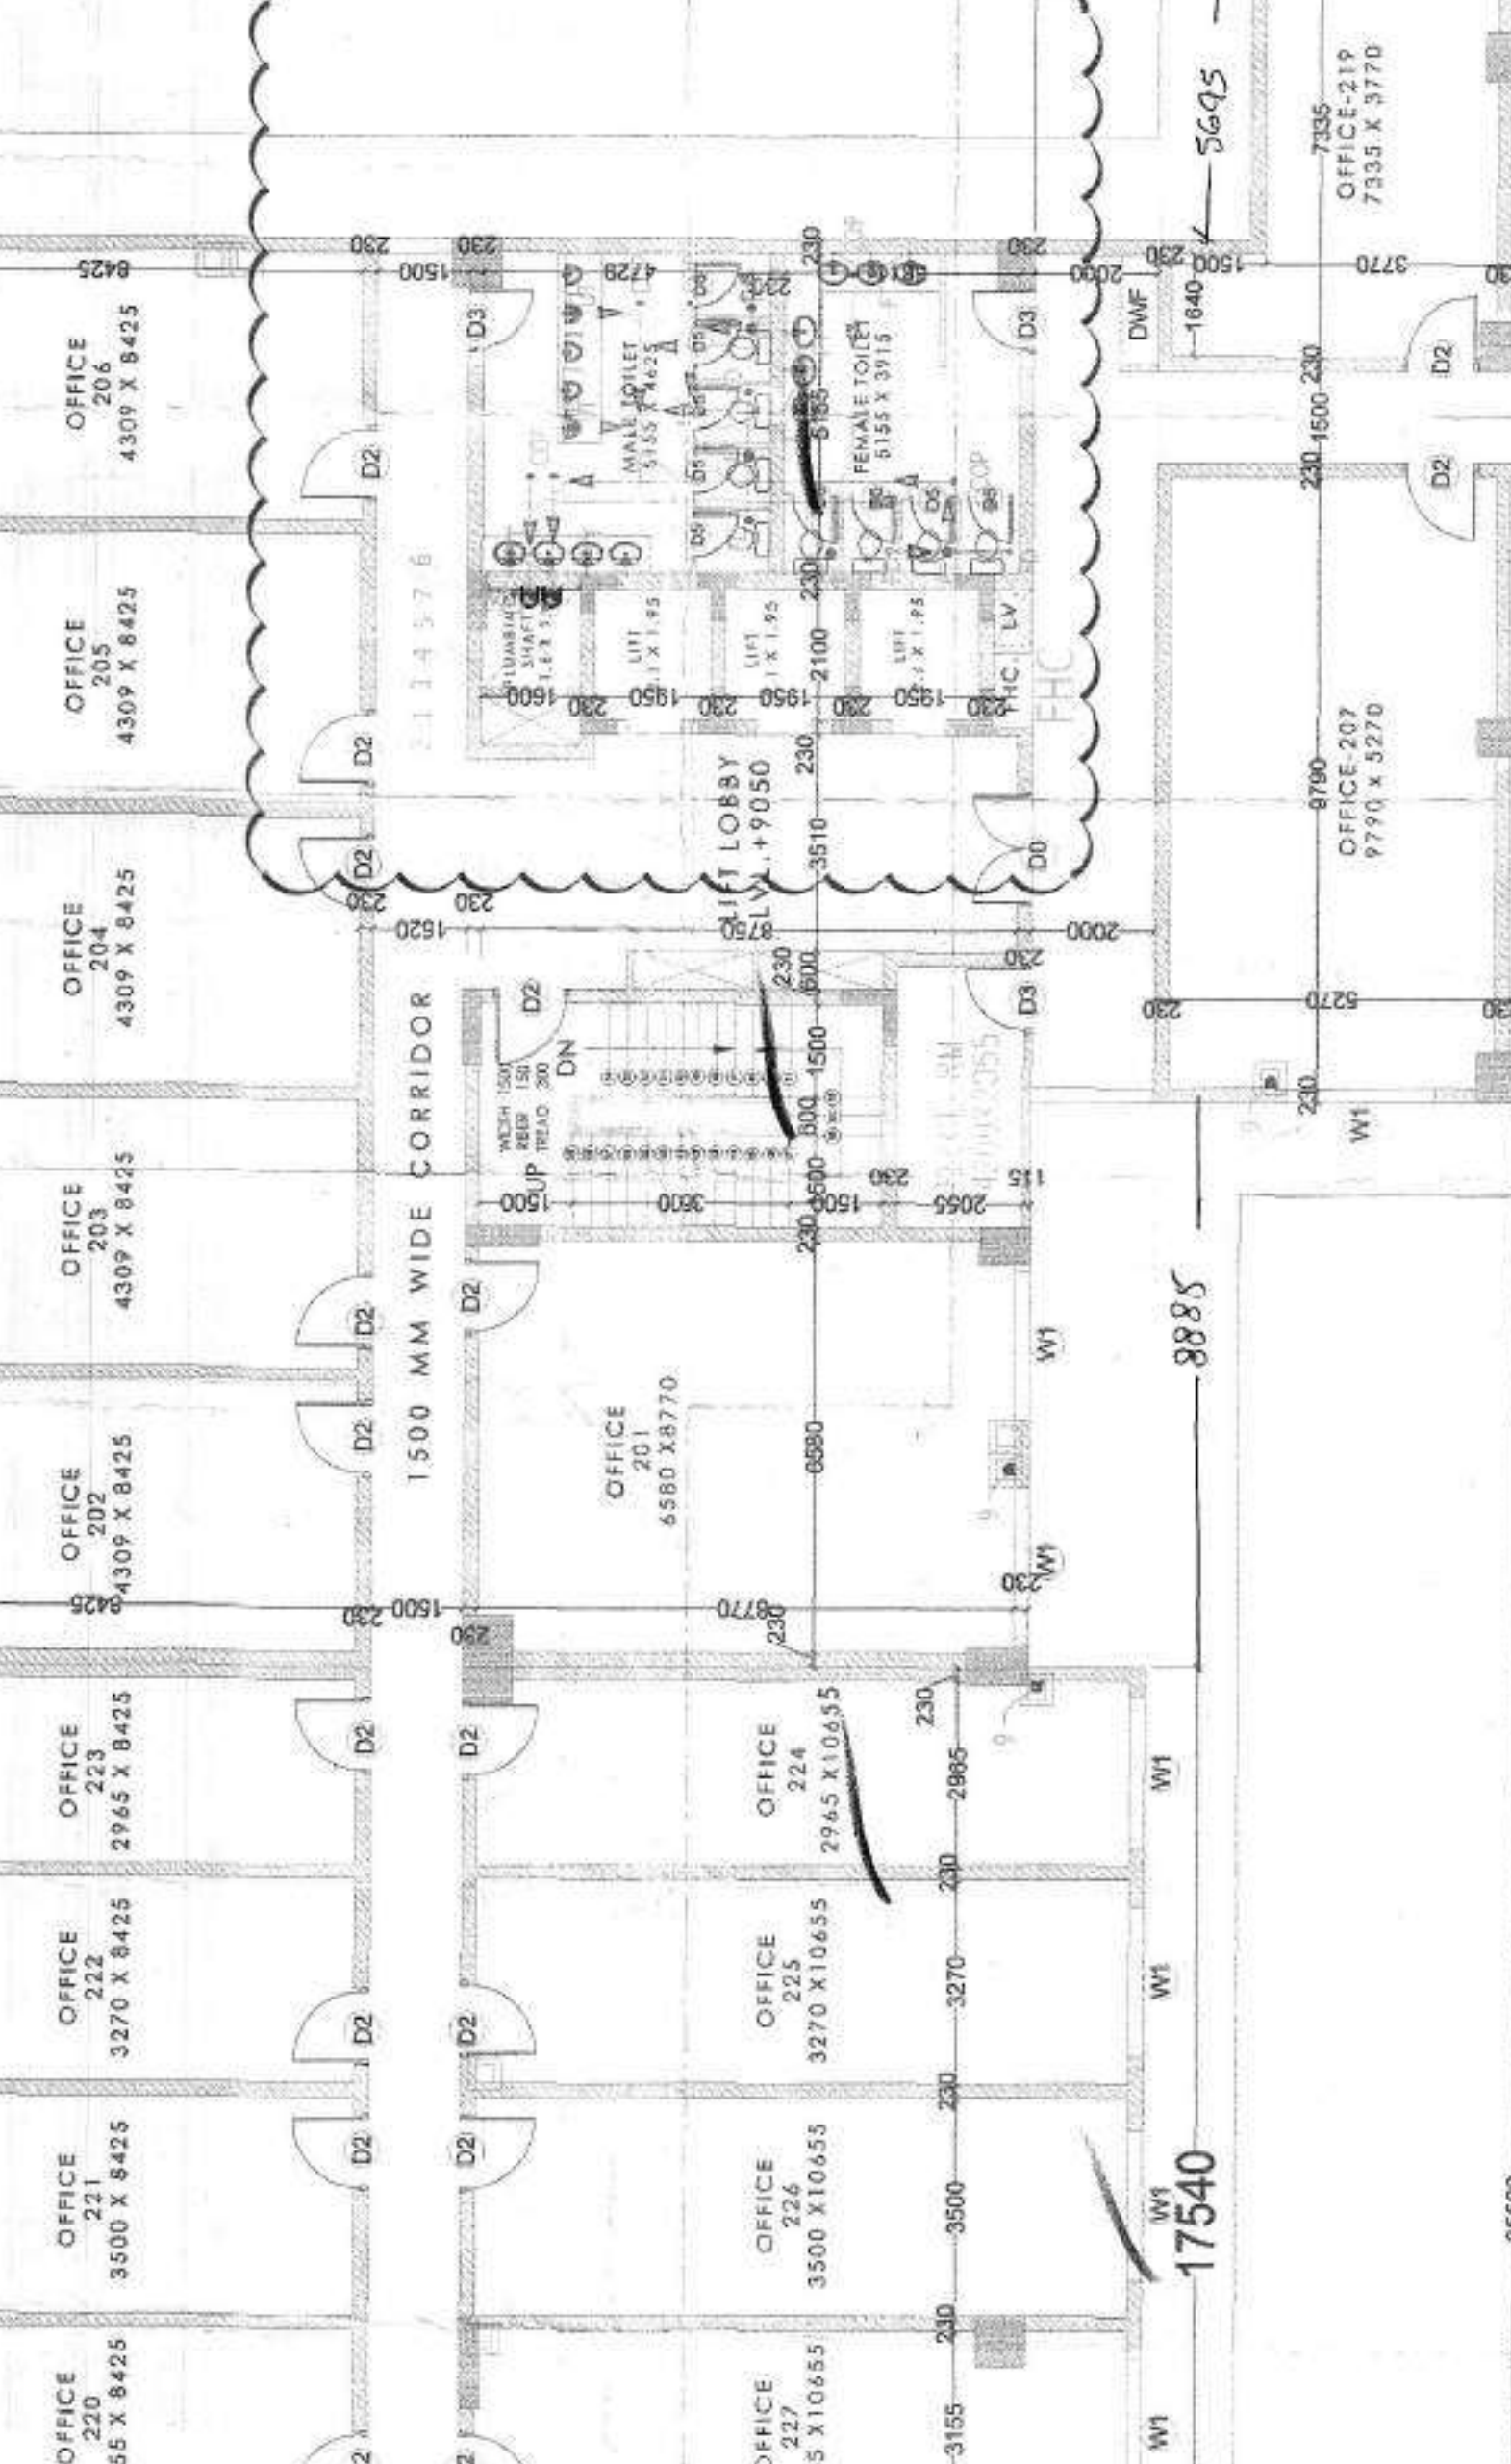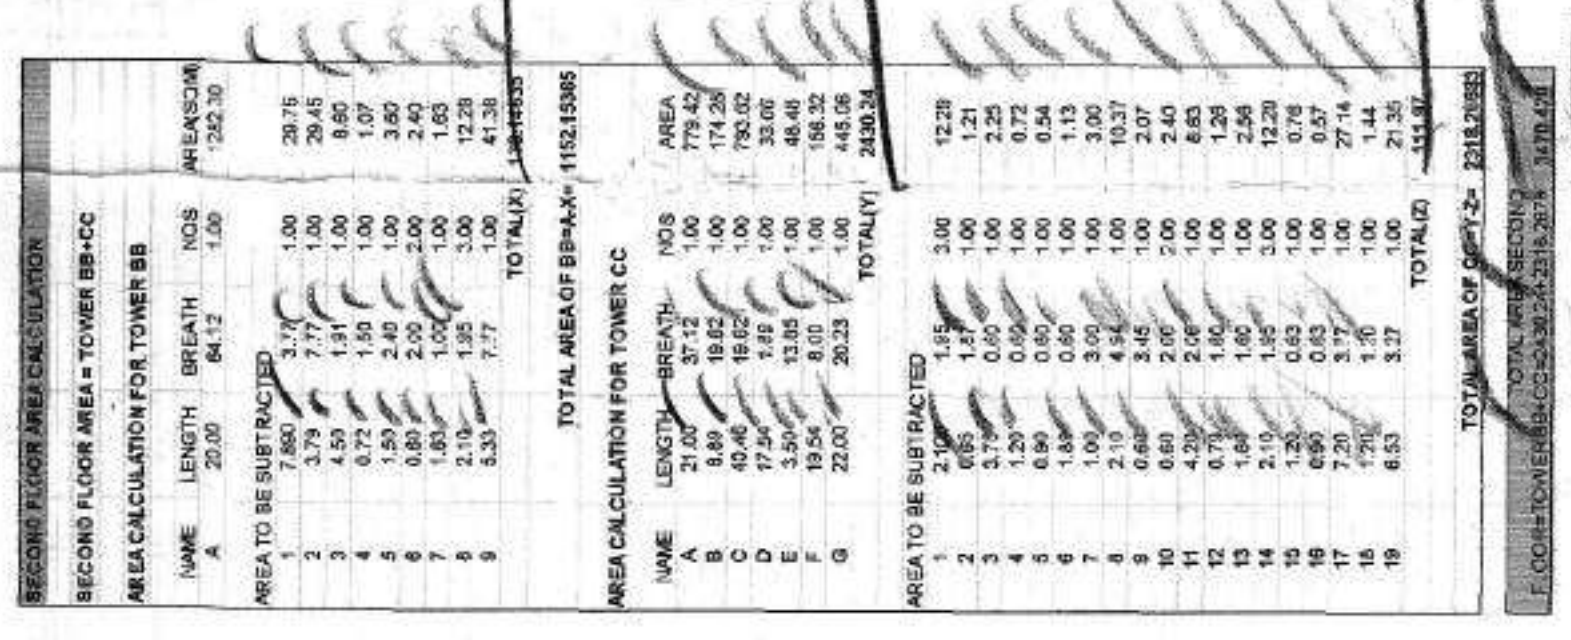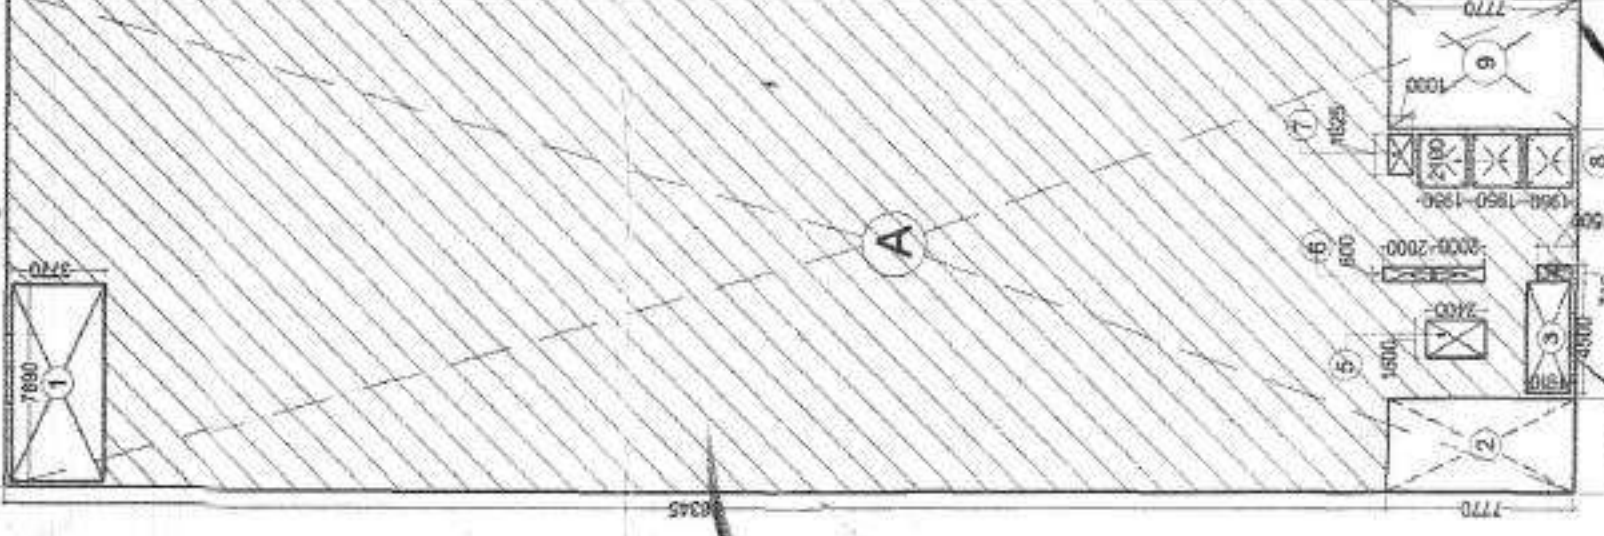

	FOR MALE:		FOR FEMALE:		TOTAL:	
	REQUIRED	PROVIDED	REQUIRED	PROVIDED	REQUIRED	PROVIDED
W.C.	6	7	6	7	12	19
WASH BASIN	6	12	4	10	10	22
URINAL	6	9			6	9

LAYOUT PLAN TOWER CC

SCALE:	1:100	DATE:	26.11.2011
NORTH:		DRG. NO.:	S.D. 08

ARCHITECT SIGNATURE:

RAVIN KUMAR
B. Arch

SPECTRAL
SERVICE CONSULTANTS PVT. LTD.
A-197, Sector-63, Noida, India
Ph.: 0120-4049000
Fax: 91-120-4049001

SNO.	TRG.	SIZE	COLL. RT.	WATER
1	D 1	1500 X 2100	---	2100
2	D 2	1200 X 2100	---	2100
3	D 3	1050 X 2100	---	2100
4	D 4	750 X 2100	---	2100
5	W	3300 X 1800	600	2400
6	W	3300 X 1800	600	2400
7	W	3300 X 1800	600	2400
8	W	3300 X 1800	600	2400
9	W	3300 X 1800	600	2400
10	W	3300 X 1800	600	2400
11	W	3300 X 1800	600	2400
12	W	3300 X 1800	600	2400
13	DW	2340 X 2100	300	2400

PLUMBING LEGEND:


- 1000 CI SOIL & VENT PIPE
- 1000 CI WASTE & VENT PIPE
- ANTI-SIPHONAGE PIPE
- DOMESTIC WATER ON TAKE PIPE
- FLUSHING WATER ON TAKE PIPE
- HOT WATER ON TAKE PIPE
- HOT WATER RETURN
- DOMESTIC WATER RISER
- FLUSHING WATER RISER
- 1500 CI RAIN WATER PIPE
- 2000 CI SOIL PIPE
- 2000 CI RAIN WATER PIPE

TOILET REQUIREMENTS: (10 sq.mt. / 1 person)

FOR MALE:	FOR FEMALE:	TOTAL:
REQUIRED	REQUIRED	REQUIRED
6	7	13
6	12	18
6	9	15
6	10	16
6	6	12
6	9	15

TOILET REQUIREMENTS: (10 sq.mt. / 1 person)


FOR MALE:	FOR FEMALE:	TOTAL:
REQUIRED	REQUIRED	REQUIRED
6	7	13
6	12	18
6	9	15
6	10	16
6	6	12
6	9	15

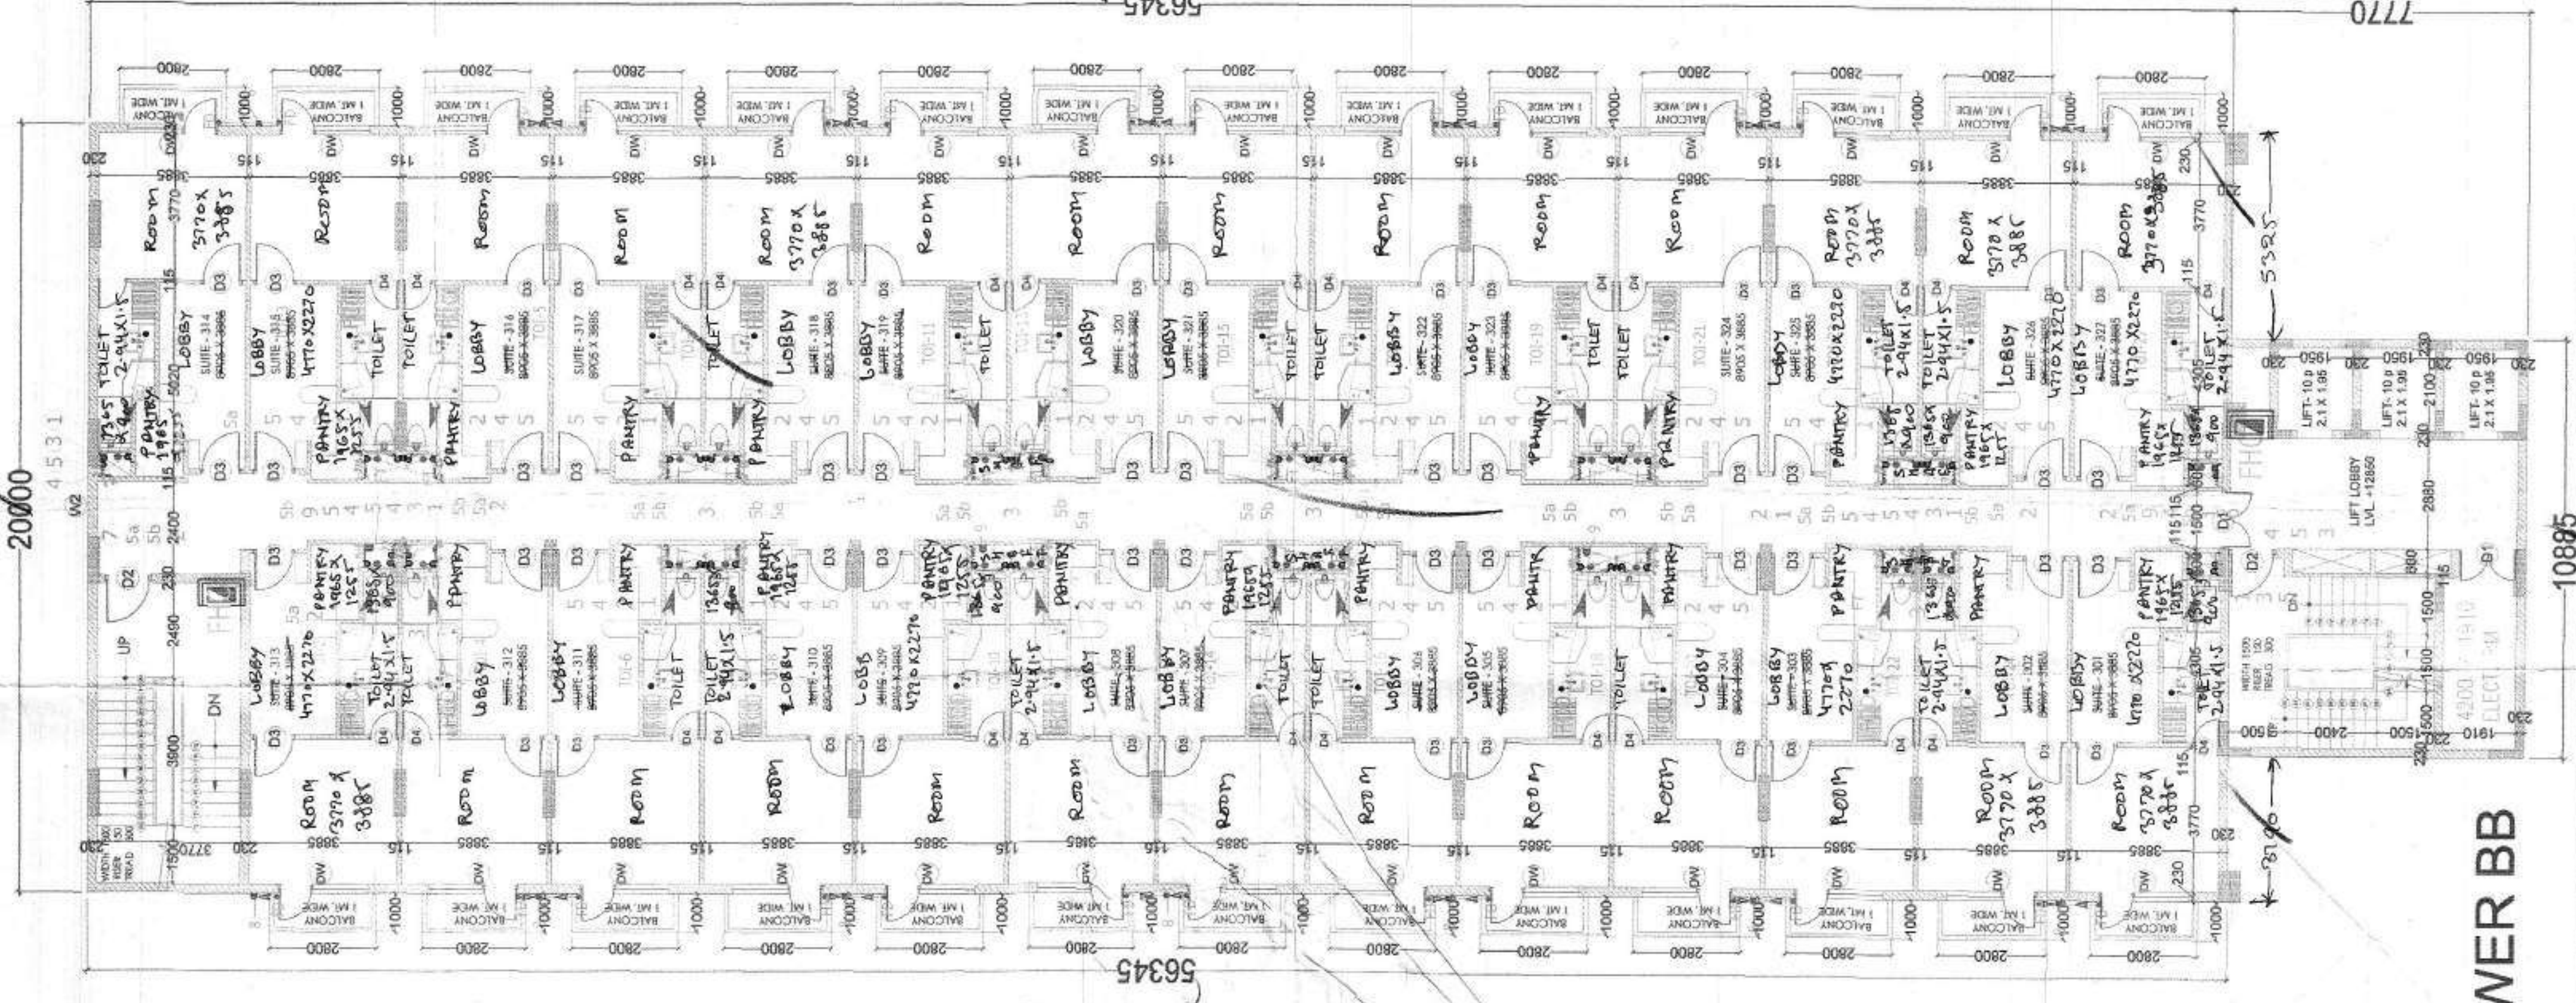

LAYOUT PLAN TOWER BB

THIRD FLOOR AREA CALCULATION	TOWER BB-CC
NAME	AREA (SQ. FT.)
1	7.850
2	1.000
3	0.000
4	0.000
5	0.000
6	0.000
7	0.000
8	0.000
9	0.000
10	0.000
11	0.000
12	0.000
TOTAL (A)	8.850

THIRD FLOOR AREA CALCULATION	TOWER BB-CC
NAME	AREA (SQ. FT.)
1	7.850
2	1.000
3	0.000
4	0.000
5	0.000
6	0.000
7	0.000
8	0.000
9	0.000
10	0.000
11	0.000
12	0.000
TOTAL (A)	8.850

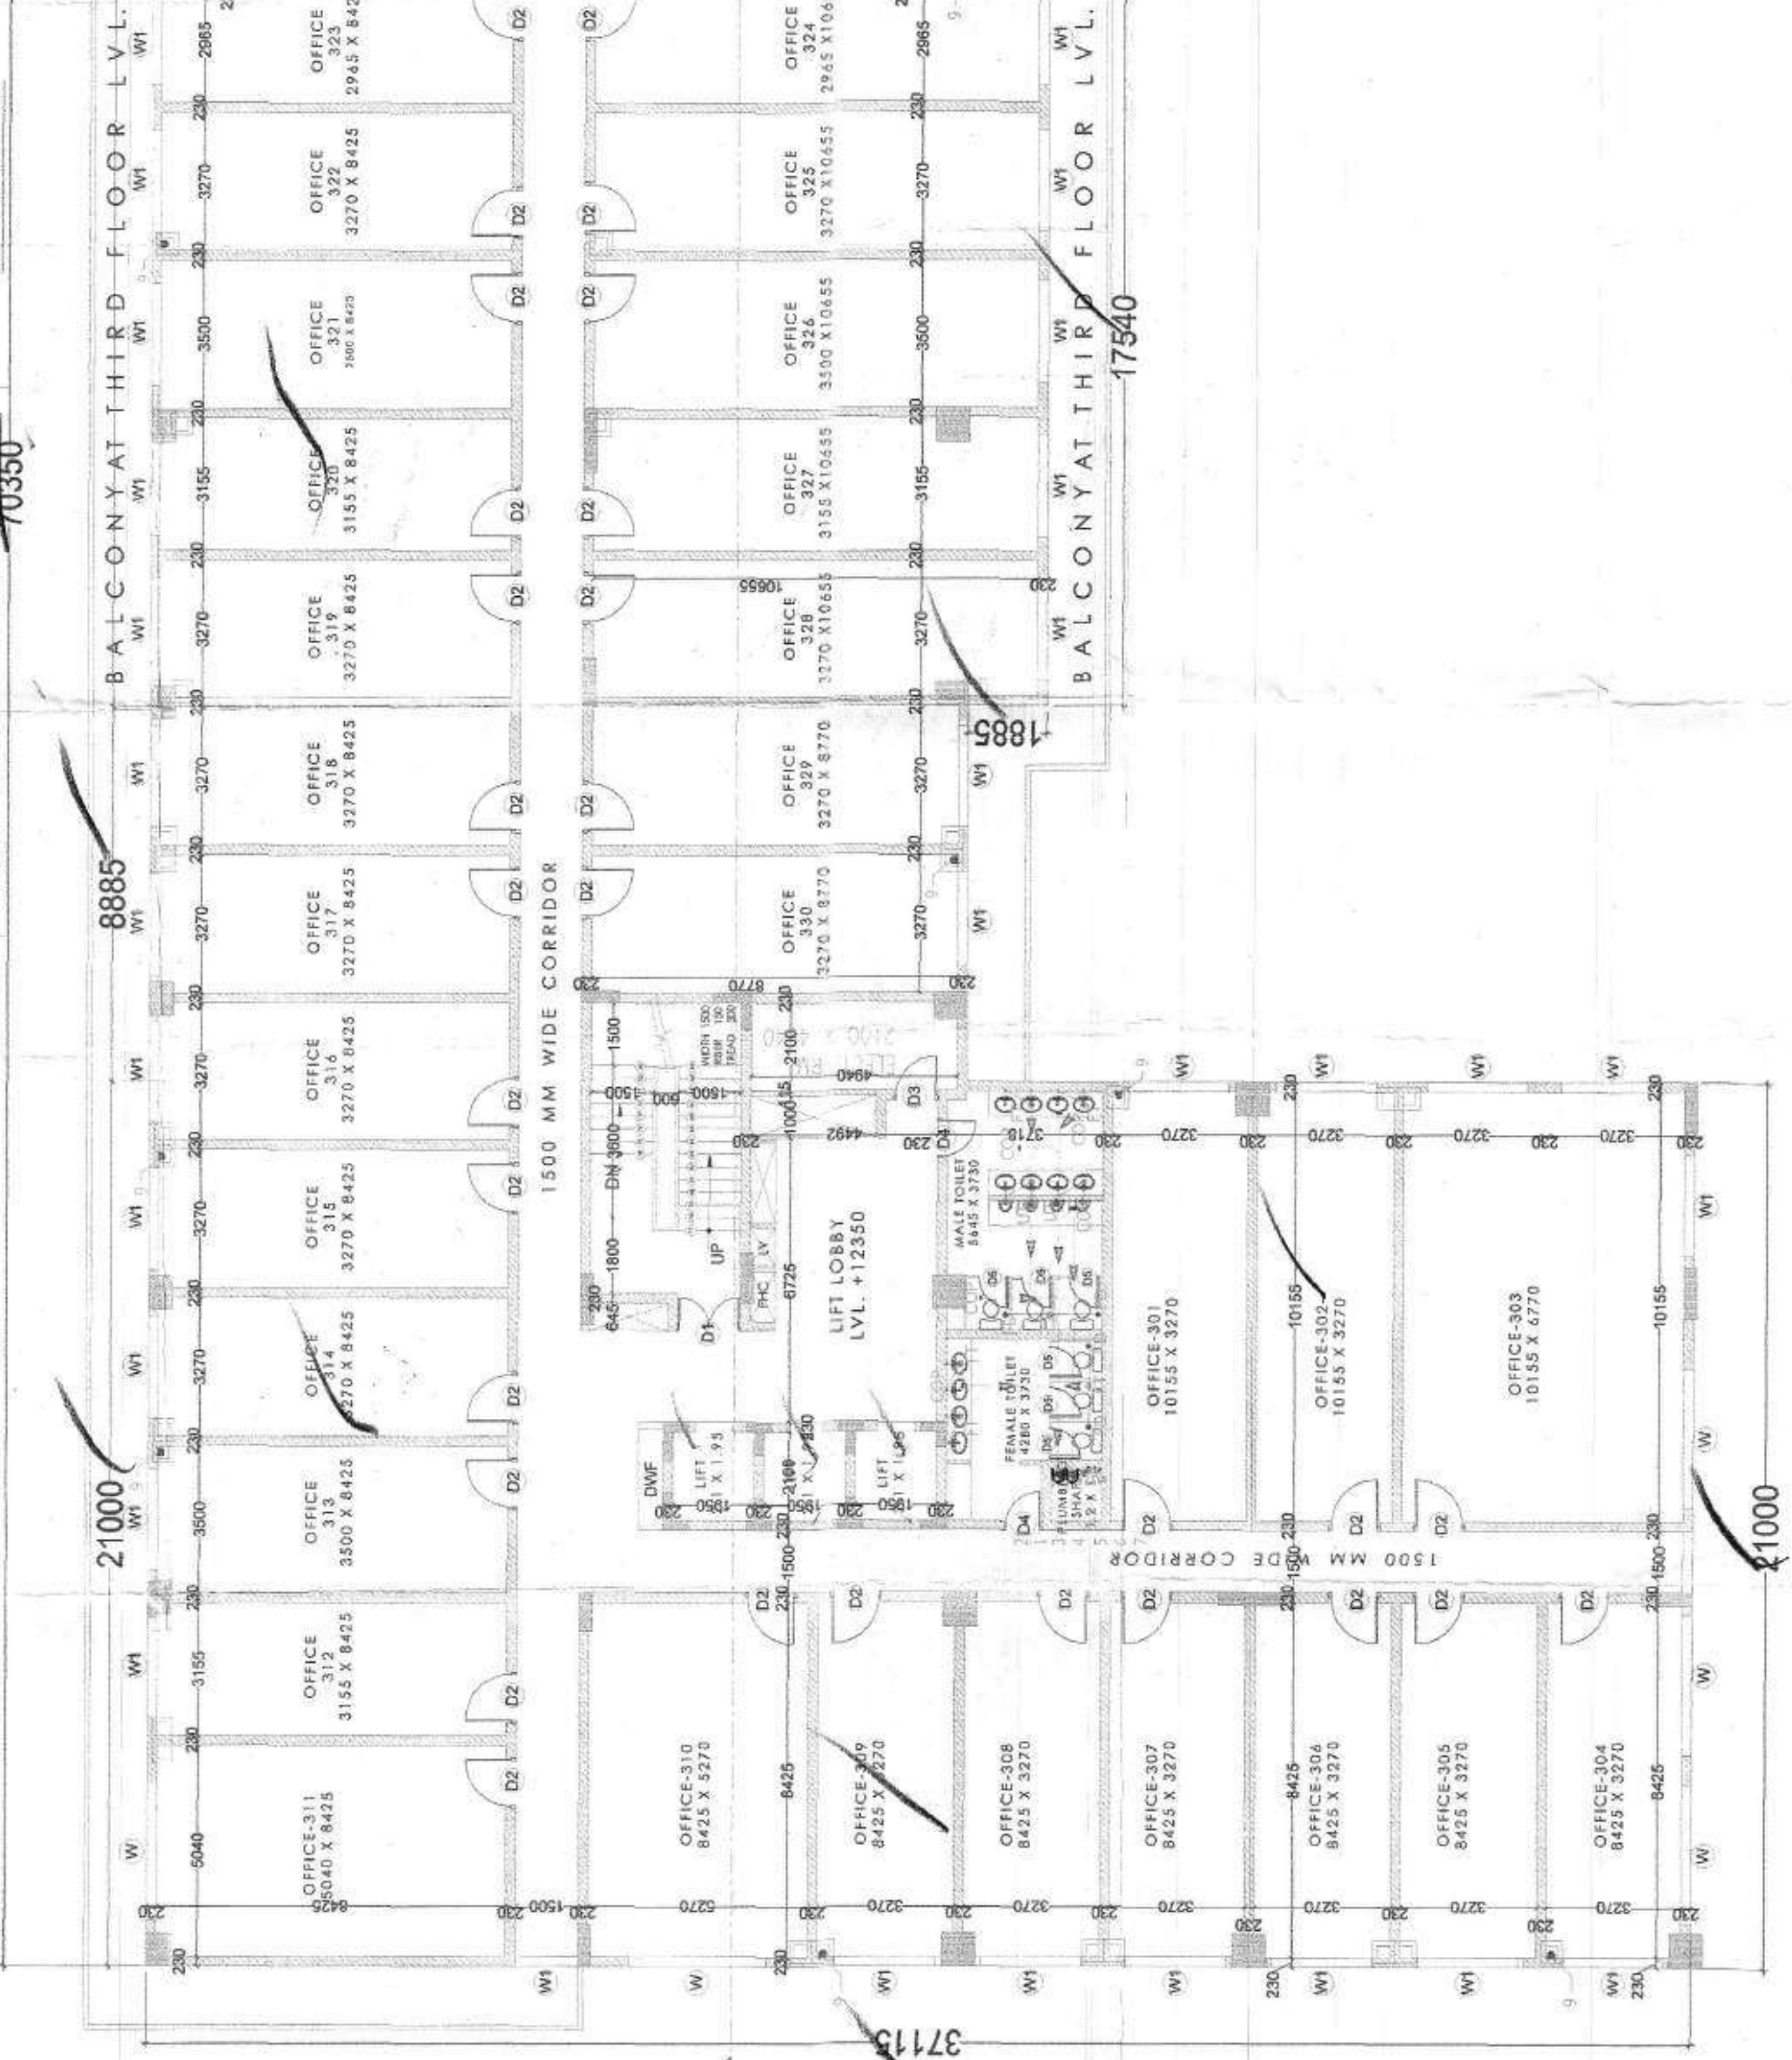

LAYOUT PLAN TOWER CC

SUBMISSION DRAWING

- NOTES**
1. BUILDING SHALL BE DESIGNED TO RESIST EARTHQUAKE RESISTANCE.
 2. BUILDING SHALL BE DESIGNED TO RESIST EARTHQUAKE RESISTANCE.
 3. ALL TOILETS ARE MECHANICALLY VENTILATED (w/ Fan). Back up, including...

PROJECT:

APPROVAL OF REVISED BUILDING PLANS FOR COMMERCIAL COLONY MEASURING IN AREA OF 4.237 ACRES (LICENSE NO. 291 DATED 31/12/2007) IN SECTOR - 67 GURGAON MANESAR URBAN COMPLEX IN FAVOUR OF M/S ANSAL PROPERTIES & INFRASTRUCTURE LTD.

OWNER:

ANSAL PROPERTIES & INFRASTRUCTURE LTD.
115, ANSAL BHAWAN
16, KASTURBA GANDHI MARG
NEW DELHI 110001

DRAWING TITLE:

THIRD FLOOR PLAN NORTH: & AREA DETAIL

SCALE:

1:100

DATE:

26.11.2011

ARCHITECT

SPECTRAL
SERVICE CONSULTANTS PVT. LTD.
A-197, Sector-43, Noida, India
Ph: 0120-4049000
Fax: 91-120-4049001

OWNER SIGNATURE:

[Signature]
For Owner: Anshul K. Ansal
By: (Signature)
Name: Anshul K. Ansal
Designation: Director

ARCHITECT SIGNATURE:

[Signature]
For Architect: Nayan Kumar
By: (Signature)
Name: Nayan Kumar
Designation: Architect



SANCTIONED
By: Nayan Kumar
Date: 26.11.2011
Project No: 2003/2003/ATMA-168
To be used in compliance with
HMD No. --- DUL