

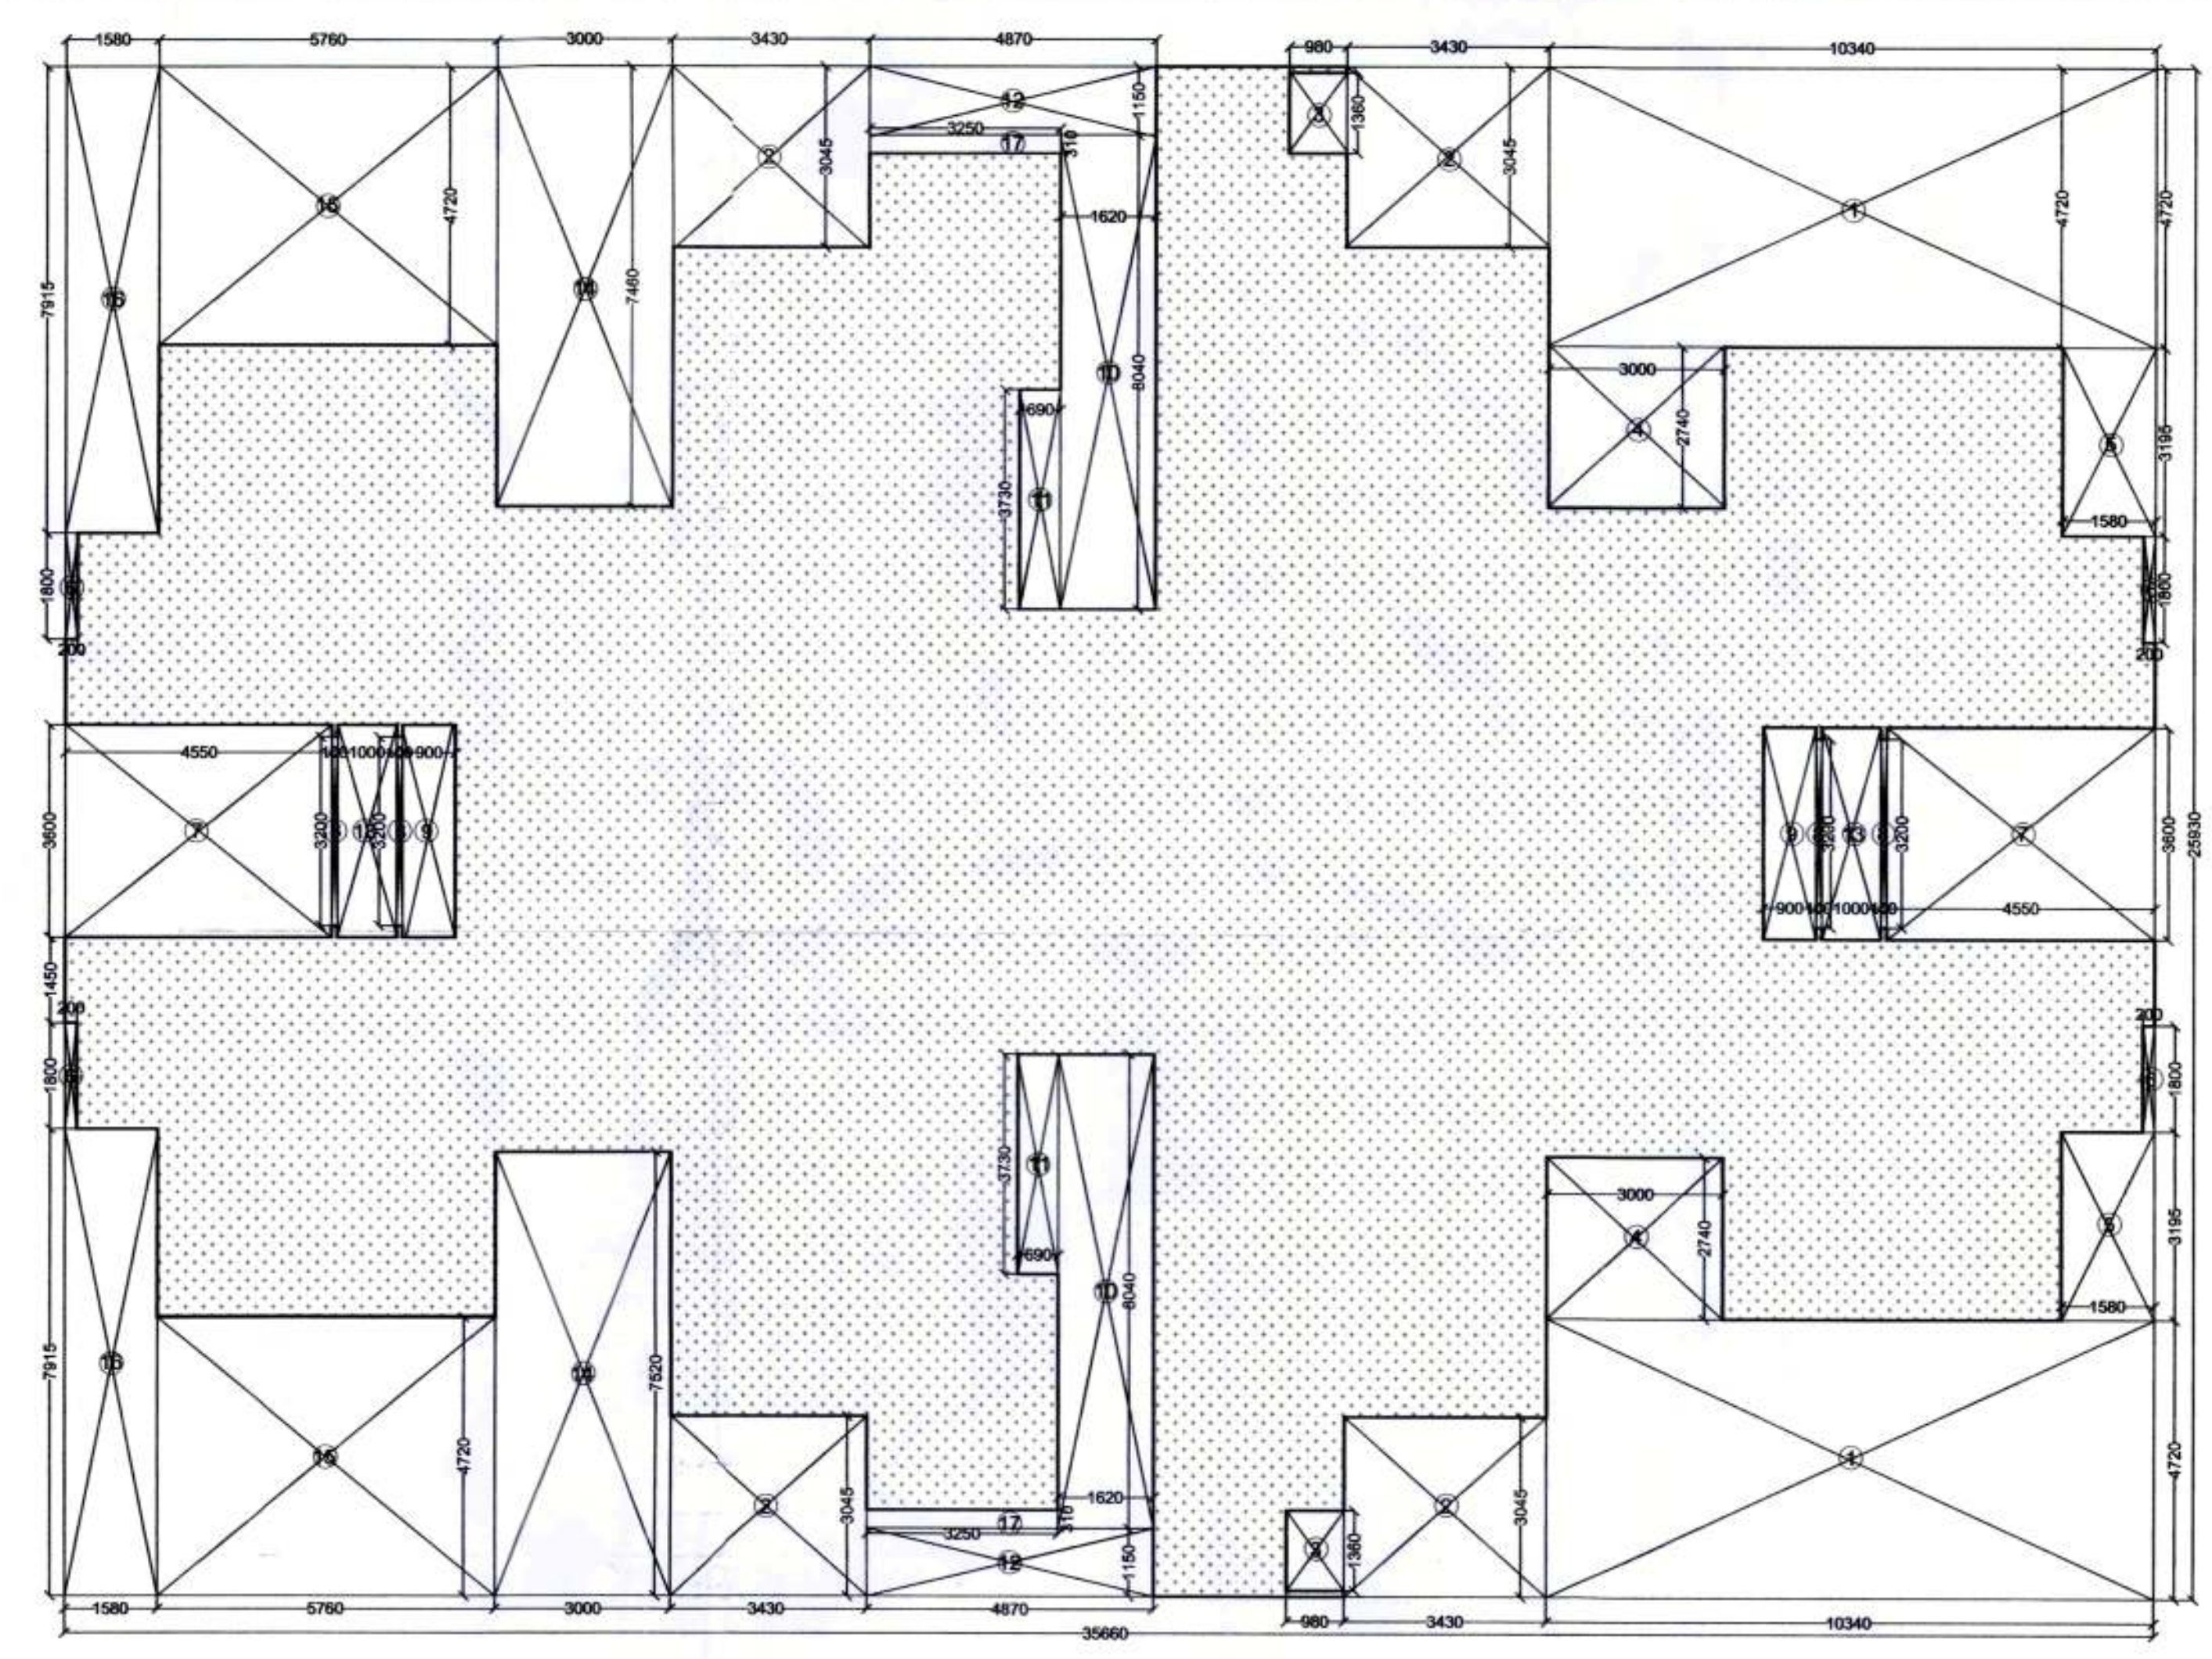


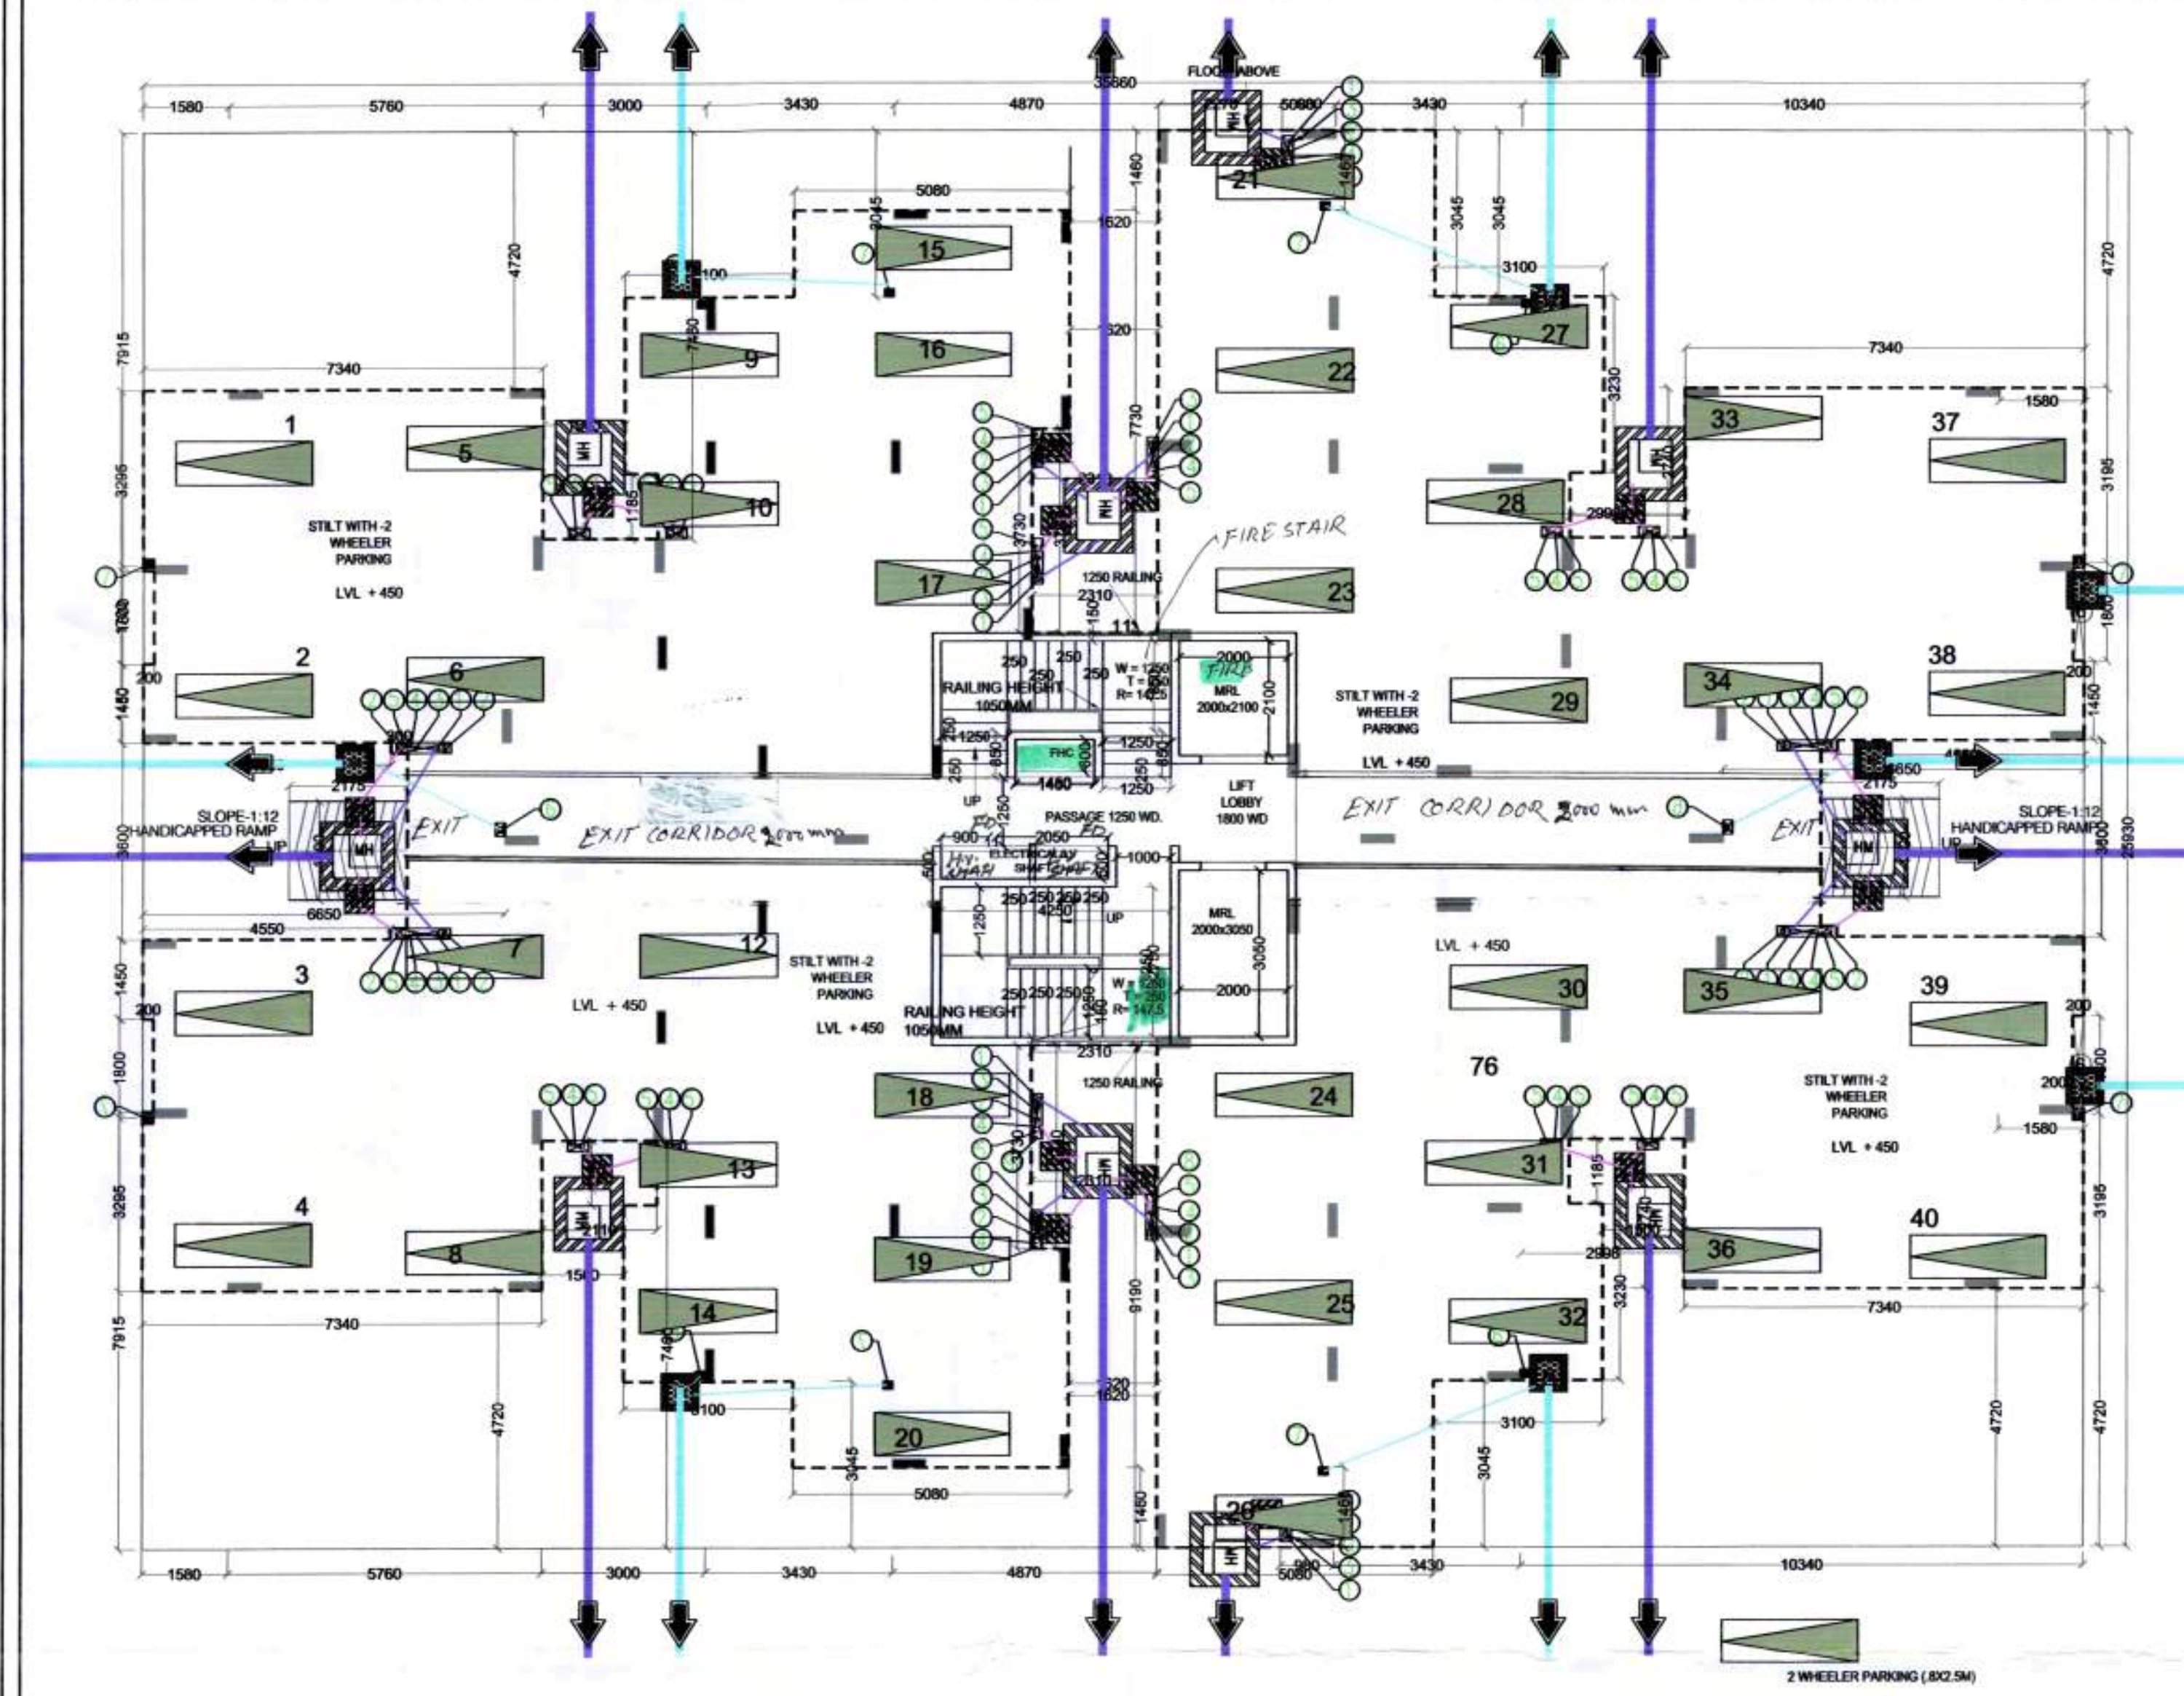

1 STILT FLOOR PLAN TOWER- G,H,I,J
Scale: 1:100

2 GROUND COVERAGE CALCULATION TOWER G,H,I,J
Scale: 1:100

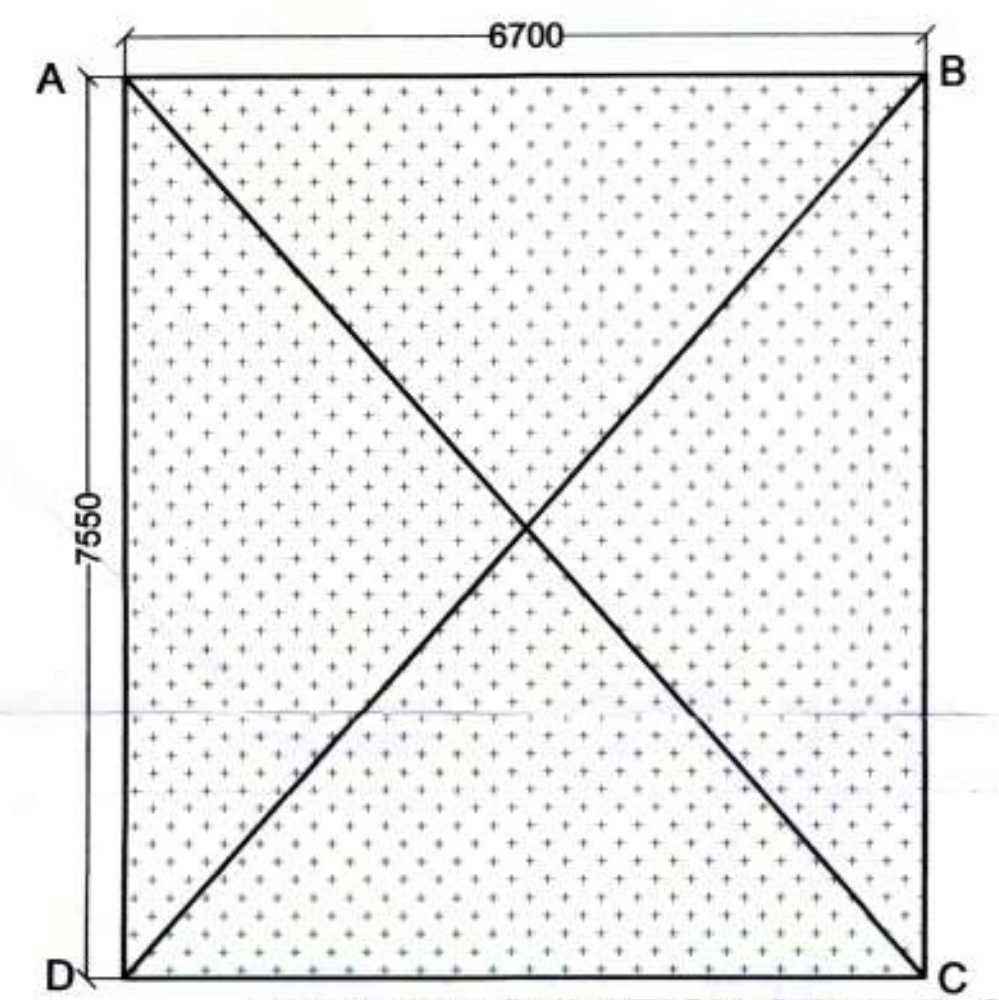

10 AREA CALCULATION STILT FLOOR TOWER- G,H,I,J
Scale: 1:100

STILT FAR AREA CALCULATION					
TYPE	QUANTITY	SHAPE	FORMULA	DETAIL	CALCULATION EACH AREA IN SQ.M
COVERAGE (ADDITION)					
ABCD	1	RECTANGLE	L x B	6.700	7.550
TOTAL					50.585
NET COVERED AREA = ABCD					50.585

- SEWERAGE MANHOLE
- GULLY TRAP
- CATCH BASIN

- FLOOR TRAP (110x110mm)
- FLOOR DRAIN (110x110mm)
- BALCONY DRAIN (110x110mm)

PLUMBING NOTES:-

- WASH BASIN TO FLOOR DRAIN (FD) NO DD UPVC WASTE PIPE
- KITCHEN SINK TO FLOOR TRAP (FT) 50 DD UPVC WASTE PIPE
- FLOOR DRAIN (FD) TO FLOOR TRAP (FT) 50 DD UPVC WASTE PIPE
- 110 DD UPVC PIPE USED FOR SINK & WASTE
- 110 DD UPVC PIPE USED FOR TERRACE RAIN WATER

SCHEDULE OF PIPES

PIPE NO.	DESCRIPTION
1	110 DD UPVC SINK & VENT PIPE
2	110 DD UPVC WASTE & VENT PIPE
3	NO DD UPVC UNDERPASSAGE PIPE
4	DOMESTIC WATER SUPPLY D/W TANK PIPE
5	FLOODING WATER SUPPLY D/W TANK PIPE
6	50 DD UPVC BALCONY RAIN WATER PIPE
7	110 DD UPVC TERRACE RAIN WATER PIPE
8	DOMESTIC WATER SUPPLY RISER PIPE
9	FLOODING WATER SUPPLY RISER PIPE

GROUND COVERAGE AREA CALCULATION						
TYPE	QUANTITY	SHAPE	FORMULA	DETAIL		CALCULATION EACH AREA IN SQ.M
COVERAGE (ADDITION)						
ABCD	1	RECTANGLE	L x B	35.660	25.930	924.664
TOTAL						924.664
COVERAGE (DEDUCTION)						
1	2	RECTANGLE	L x B	10.340	4.720	97.600
2	4	RECTANGLE	L x B	3.430	3.045	41.777
3	2	RECTANGLE	L x B	0.980	1.360	2.666
4	2	RECTANGLE	L x B	3.000	2.740	16.440
5	2	RECTANGLE	L x B	1.580	3.195	10.096
6	4	RECTANGLE	L x B	0.200	1.800	1.440
7	2	RECTANGLE	L x B	4.550	3.600	32.760
8	4	RECTANGLE	L x B	0.100	3.200	1.280
9	2	RECTANGLE	L x B	0.900	3.600	6.480
10	2	RECTANGLE	L x B	1.620	8.040	26.050
11	2	RECTANGLE	L x B	0.690	3.730	5.147
12	2	RECTANGLE	L x B	4.870	1.150	11.201
13	2	RECTANGLE	L x B	1.000	3.600	7.200
14	2	RECTANGLE	L x B	3.000	7.520	45.120
15	2	RECTANGLE	L x B	5.760	4.720	54.374
16	2	RECTANGLE	L x B	1.580	7.915	25.011
17	2	RECTANGLE	L x B	0.310	3.250	2.015
TOTAL						386.658
NET COVERED AREA = ABCD - 1 TO 17						538.006

SANCTIONED
TO BE READ WITH THIS OFFICE
MEMO NO: 18
DATED: 18/08/2020

PRINCIPLE ARCHITECT
dfi
DESIGN FORUM INTERNATIONAL
K-47, KAILASH COLONY NEW DELHI-48
PHONE: 011-46556600 FAX: 46556601

CLIENT:
MEGA INFRA TECH PVT. LTD.

PROJECT NAME AND ADDRESS
PROPOSED BUILDING PLAN FOR
AFFORDABLE GROUP HOUSING COLONY
FOR AN AREA MEASURING 9.0625
ACRES (LICENCE NO. 28 OF 2020)
DT. 7.10.2020 IN SECTOR 95B,
GURUGRAM MANESAR URBAN COMPLEX

DRAWING TITLE:
STILT FLOOR & AREA CALCULATION TOWER-
G,H,I,J

OWNER'S SIGNATURE
ARCHITECT'S SIGNATURE
ANJO TEVATIA
B. Arch. (Hons.)
CA/95/18739

SCALE: 1:100
DATE:
SHEET NO. 13