



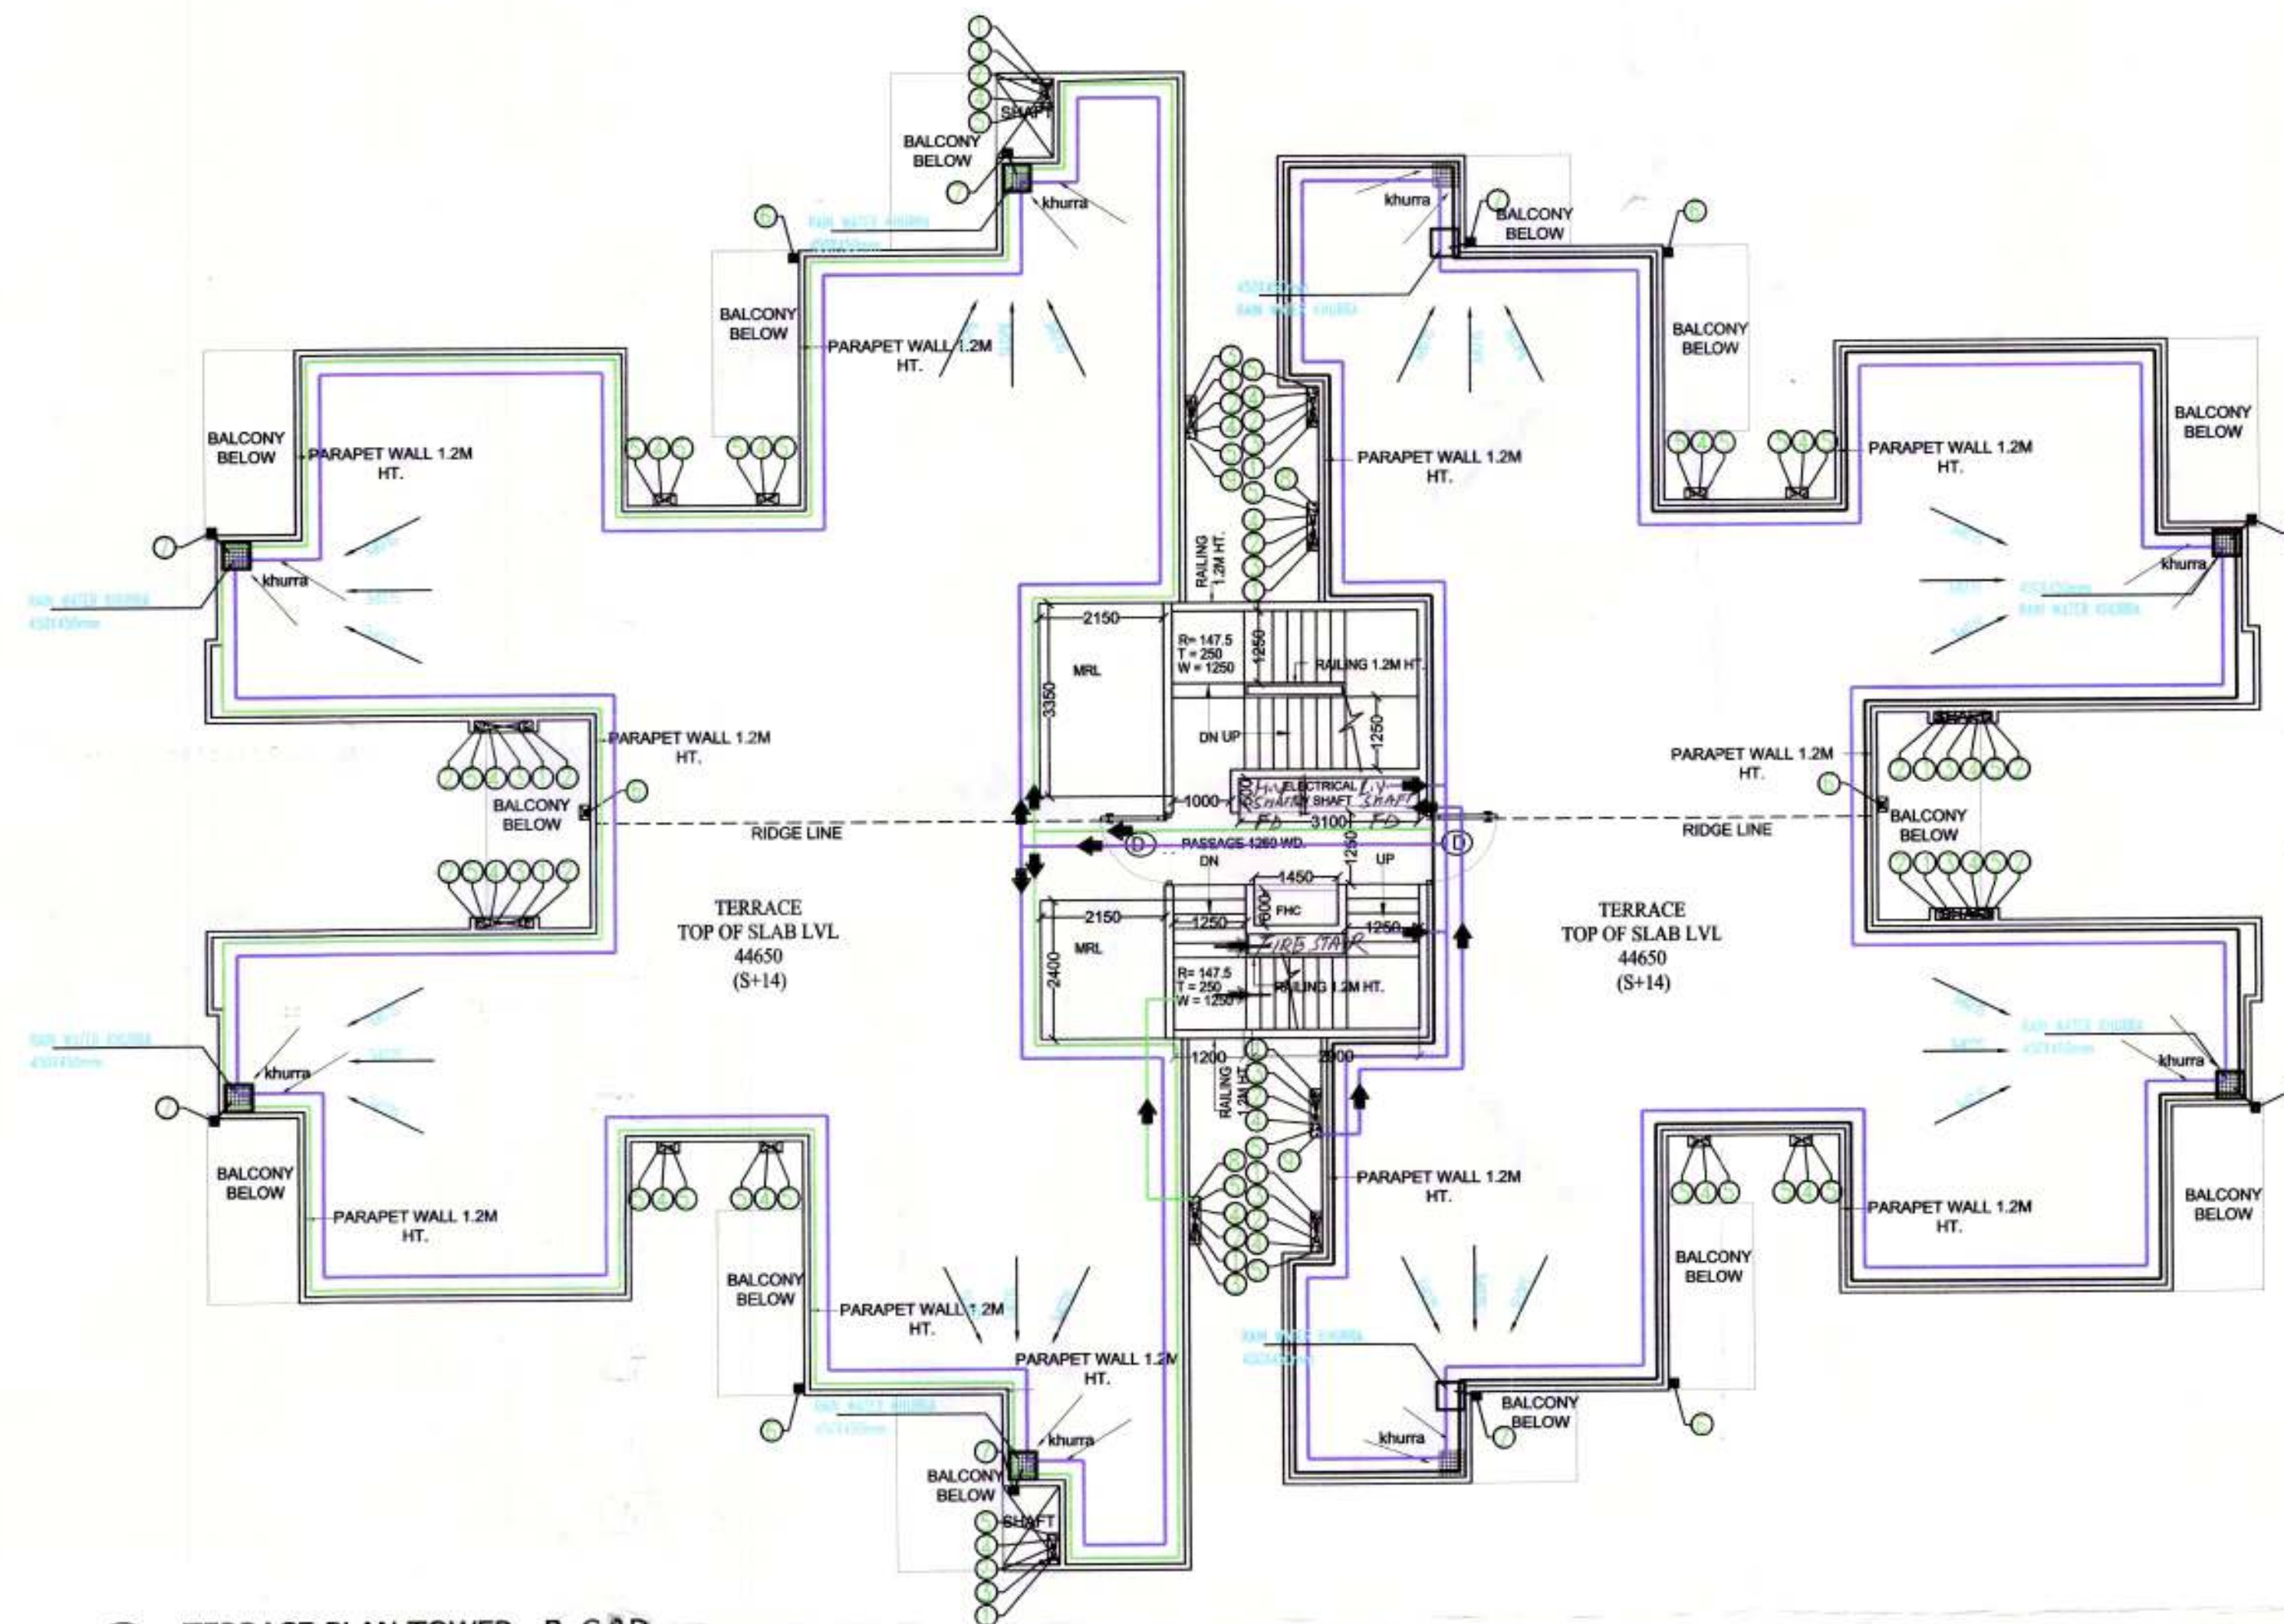

1 TERRACE PLAN TOWER- B, C & D
Scale: 1:100

(MUMTY) AREA CALCULATION					
TYPE	QUANTITY	SHAPE	FORMULA	DETAIL	CALCULATION EACH AREA IN SQ.M
COVERAGE (ADDITION)					
ABCD	1	RECTANGLE	L x B	7.550	4.550
TOTAL					34.353
S1	1	RECTANGLE	L x B	2.750	4.250
S2	1	RECTANGLE	L x B	4.250	1.650
S3	1	RECTANGLE	L x B	1.250	0.850
S4	2	RECTANGLE	L x B	1.450	0.600
S5	2	RECTANGLE	L x B	1.250	0.850
S6	1	RECTANGLE	L x B	3.100	0.500
TOTAL (Y)					22.125
NET COVERED AREA = ABCD - (Y)					12.228

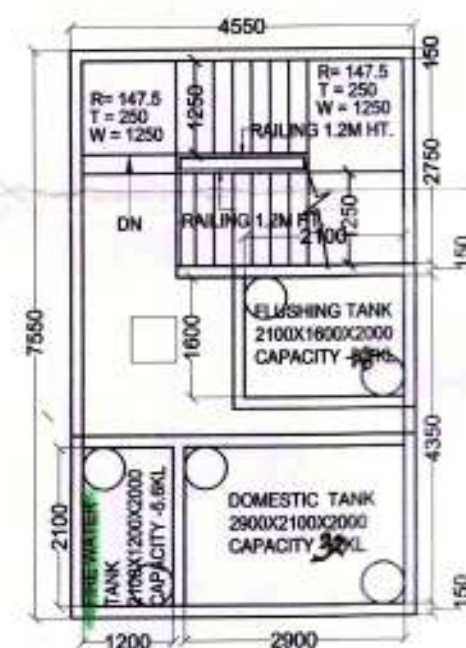


2 TANK ROOM LEVEL TOWER- B, C & D
Scale: 1:100



3 TANK TERRACE PLAN TOWER- B, C & D
Scale: 1:100

OHT AREA CALCULATION					
TYPE	QUANTITY	SHAPE	FORMULA	DETAIL	CALCULATION EACH AREA IN SQ.M
COVERAGE (ADDITION)					
ABCD	1	RECTANGLE	L x B	4.550	7.550
TOTAL					34.353
NET COVERED AREA = ABCD					34.353

4 MUMTY AREA CALCULATION TOWER- B, C & D
Scale: 1:100

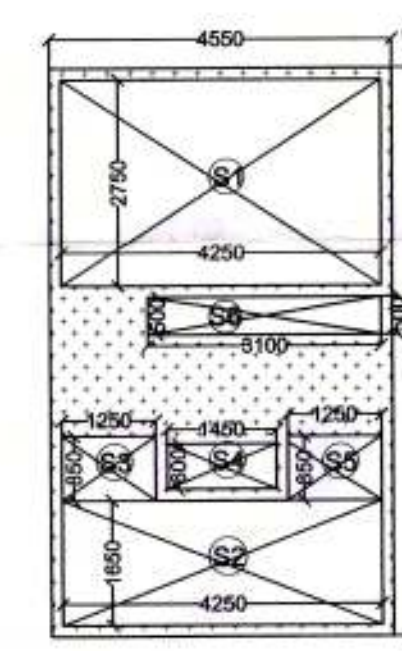

5 OHT AREA CALCULATION TOWER- B, C & D
Scale: 1:100

SEWERAGE MANHOLE	
GULLY TRAP	
CATCH BASIN	

FLOOR TRAP (110X110mm)	
FLOOR DRAIN (110X50mm)	
BALCONY DRAIN (110X50mm)	

PLUMBING NOTES:-

1. WASH BASIN TO FLOOR DRAIN (FD) 40 OD UPVC WASTE PIPE.
2. KITCHEN SINK TO FLOOR TRAP (FT) 50 OD UPVC WASTE PIPE.
3. FLOOR DRAIN (FD) TO FLOOR TRAP (FT) 50 OD UPVC WASTE PIPE.
4. 110 OD UPVC PIPE USED FOR SOIL & WASTE.
5. 110 OD UPVC PIPE USED FOR TERRACE RAIN WATER.

SCHEDULE OF PIPES

PIPE NO.	DESCRIPTION
1	110 OD UPVC SOIL & VENT PIPE.
2	110 OD UPVC WASTE & VENT PIPE.
3	90 OD UPVC ANTISIPHONAGE PIPE.
4	DOMESTIC WATER SUPPLY 1/2" TAKE PIPE.
5	FLUSHING WATER SUPPLY 1/2" TAKE PIPE.
6	90 OD UPVC BALCONY RAIN WATER PIPE.
7	110 OD UPVC TERRACE RAIN WATER PIPE.
8	DOMESTIC WATER SUPPLY RISER PIPE.
9	FLUSHING WATER SUPPLY RISER PIPE.

DOOR WINDOW SCHEDULE

S.No.	TAG	SIZE OF OPENING	CILL	LINTEL
1	D	1050 X 2100.	-	2100
2	D1	900 X 2100.	-	2100
3	D2	750 X 2100.	-	2100
4	DW1	1185 X 2100.	00/100	2100
5	DW2	1850 X 2100.	00/100	2100
6	DW3	1485 X 2100.	00/100	2100
7	DW4	1480 X 2100.	00/100	2100
8	W	1150 X 1200	900	2100
9	W1	675 X 1050	1050	2100
10	W2	800 X 1200	900	2100
11	W3	725 X 1050	1050	2100
12	V1	600 X 600	1500	2100

NOTE: 1.) ASSUMING FLR. FINISH LEVELS AS ± 0.00 FOR D/W FIXING
2.) FD= FIRE DOOR

PRINCIPLE ARCHITECT dfi DESIGN FORUM INTERNATIONAL K-47, KALASH COLONY NEW DELHI-46 PHONE: 011-46559600 FAX: 46559601	
CLIENT: MEGA INFRATECH PVT. LTD.	
PROJECT NAME AND ADDRESS PROPOSED BUILDING PLAN FOR AFFORDABLE GROUP HOUSING COLONY FOR AN AREA MEASURING 9.0625 ACRES (LICENCE NO. 28 OF 2020) DT. 7.10.2020 IN SECTOR 95B, GURUGRAM MANESAR URBAN COMPLEX	
DRAWING TITLE: TERRACE FLOOR PLAN, OHT ROOM & OHT ROOM TERRACE (TOWER- B)	
OWNER'S SIGNATURE For Mega Infratech Pvt. Ltd. Anand	ARCHITECT'S SIGNATURE ANOJ TEVATIA B. (Hons.) Enr/95/18739
SCALE: 1:100 DATE:	SHEET NO. 09