


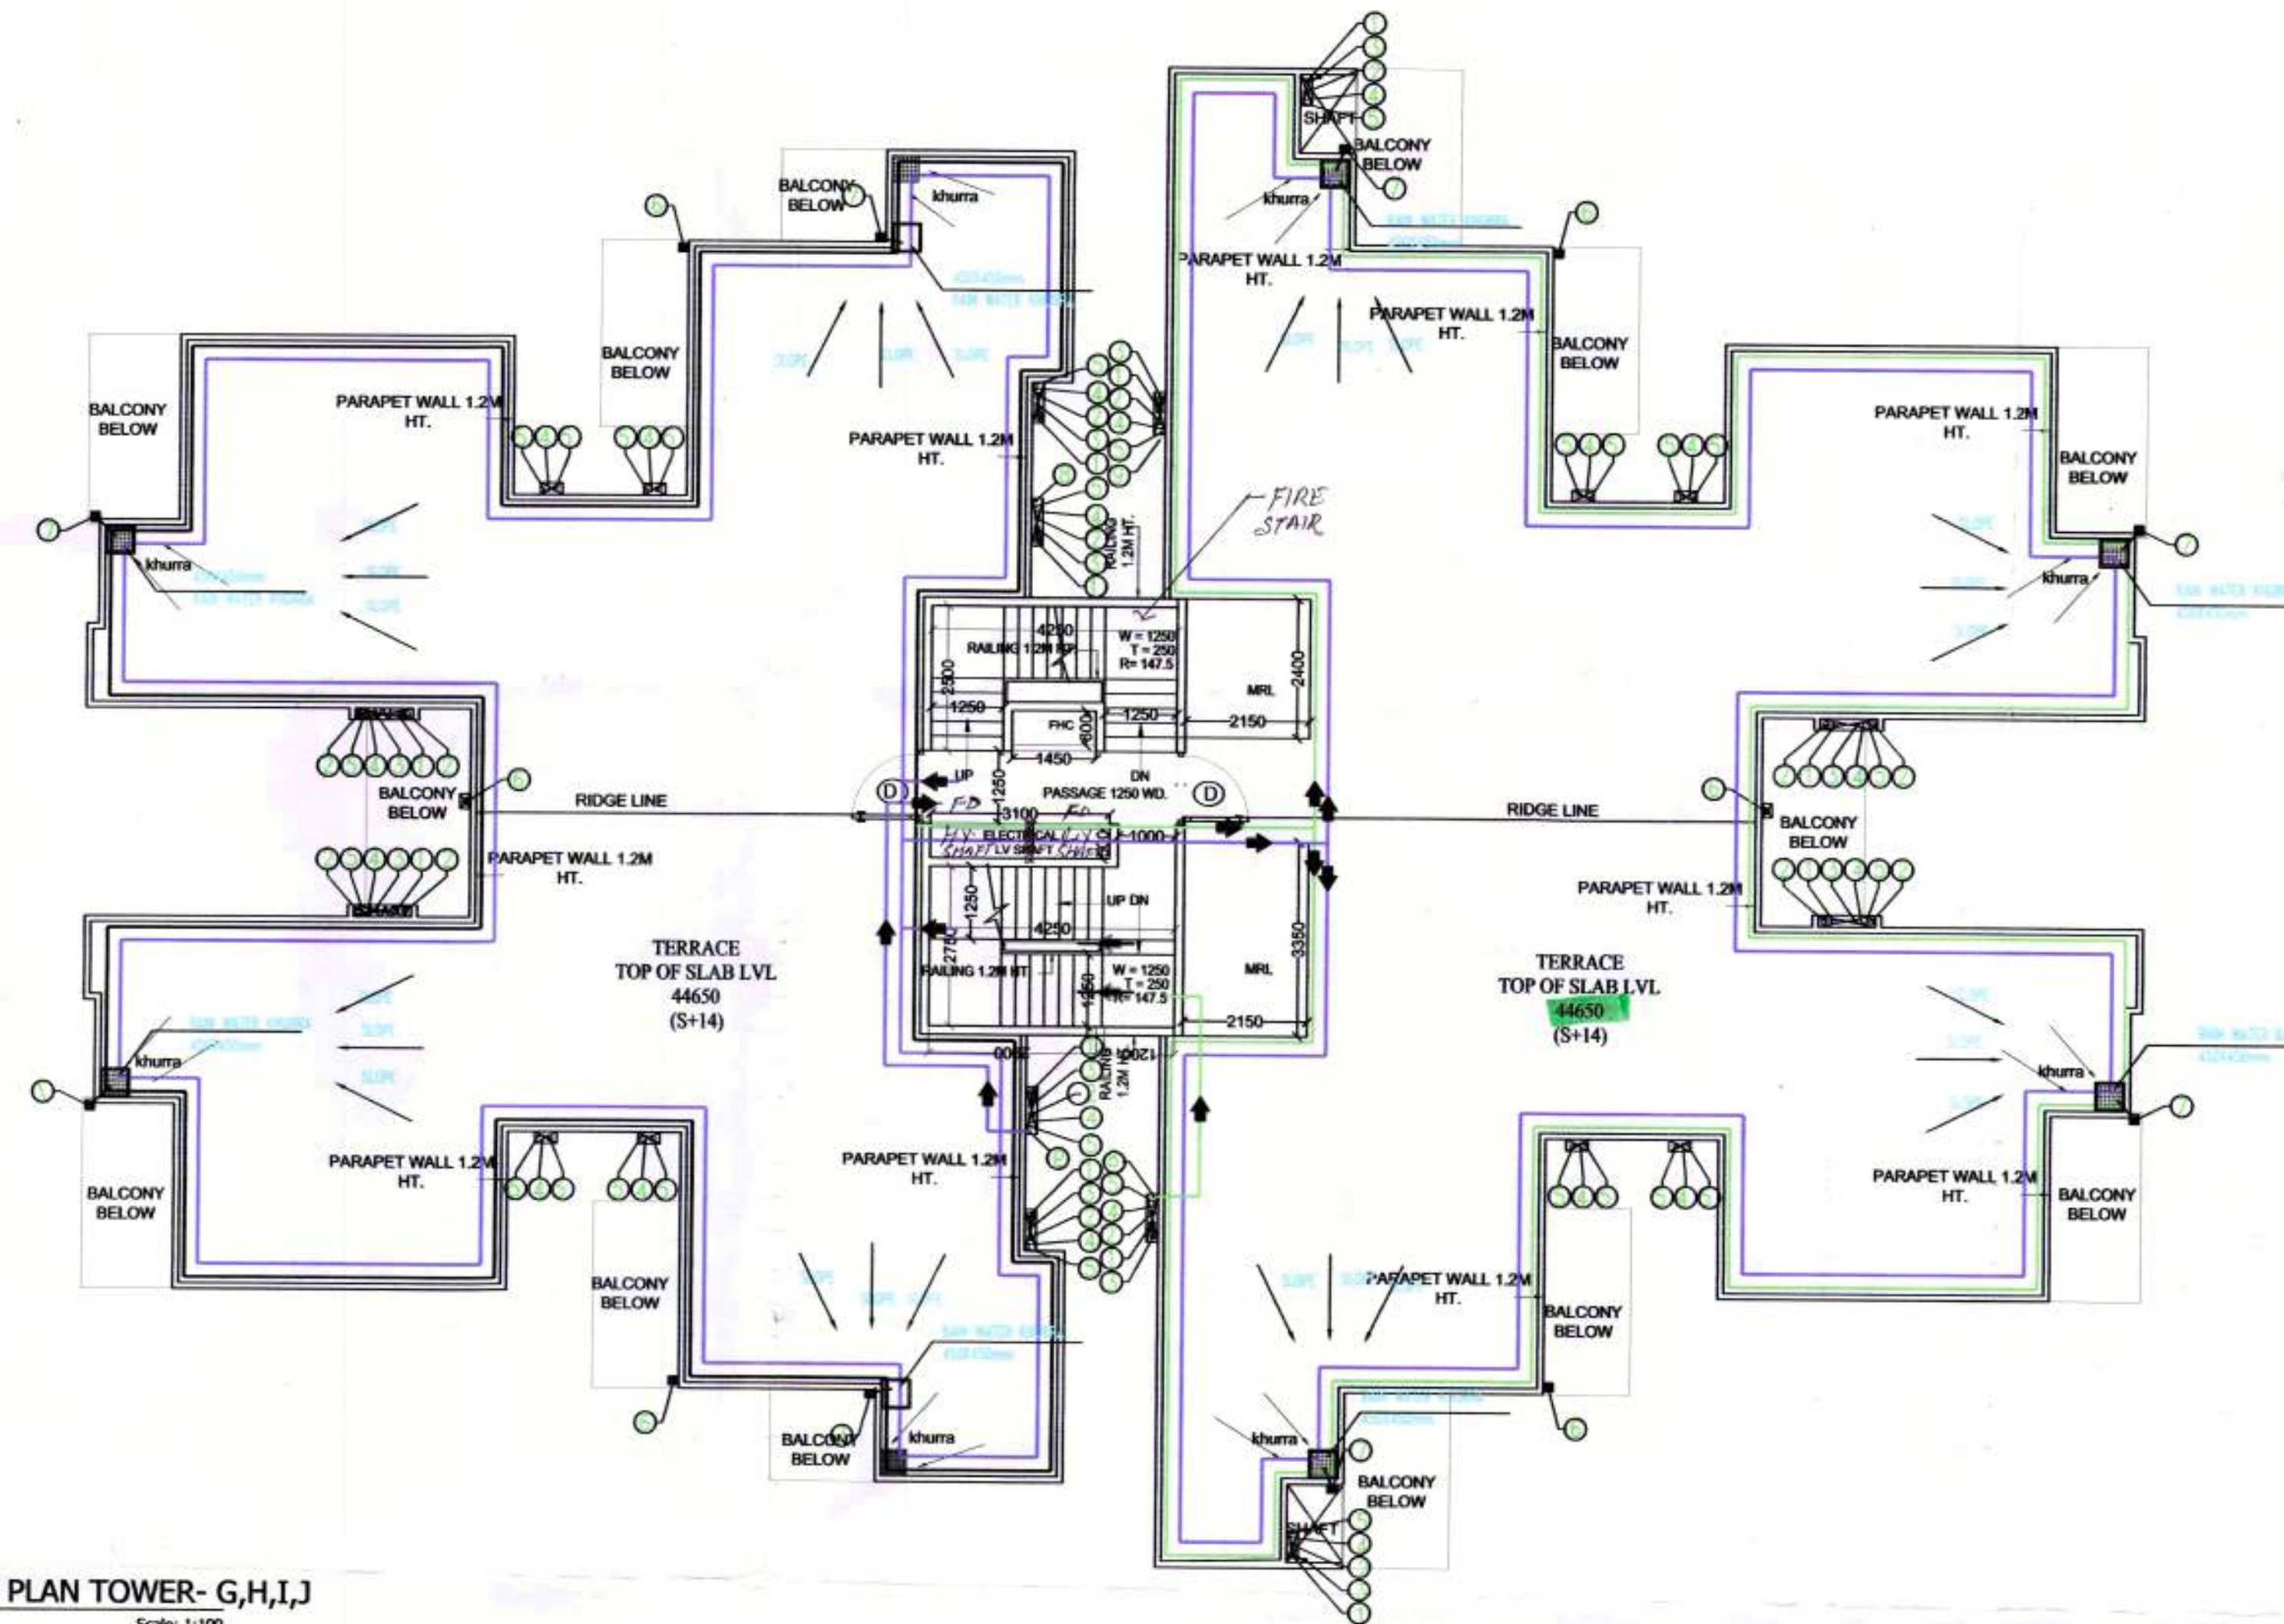

	SEWERAGE MAINHOLE
	GULLY TRAP
	CATCH BASIN

	FLOOR TRAP (110X100mm)
	FLOOR DRAIN (110X50mm)
	BALCONY DRAIN (110X50mm)

PLUMBING NOTES:-

1. WASH BASIN TO FLOOR DRAIN (FD) 40.00 UPVC WASTE PIPE
2. KITCHEN SINK TO FLOOR TRAP (FT) 50.00 UPVC WASTE PIPE
3. FLOOR DRAIN (FD) TO FLOOR TRAP (FT) 30.00 UPVC WASTE PIPE
4. 110.00 UPVC PIPE USED FOR SOIL & WASTE
5. 110.00 UPVC PIPE USED FOR TERRACE RAIN WATER

SCHEDULE OF PIPES

PIPE NO.	DESCRIPTION
1	110.00 UPVC SOIL & VENT PIPE
2	110.00 UPVC WASTE & VENT PIPE
3	80.00 UPVC ANTICORROSION PIPE
4	DOMESTIC WATER SUPPLY D/W TAKE PIPE
5	FLOODING WATER SUPPLY D/W TAKE PIPE
6	80.00 UPVC BALCONY RAIN WATER PIPE
7	110.00 UPVC TERRACE RAIN WATER PIPE
8	DOMESTIC WATER SUPPLY RISER PIPE
9	FLOODING WATER SUPPLY RISER PIPE

DOOR WINDOW SCHEDULE




S.No.	TAG	SIZE OF OPENING	CILL	LINTEL
1	D	1050 X 2100.	1050	2100
2	D1	900 X 2100.	-	2100
3	D2	750 X 2100.	-	2100
4	DW1	1185 X 2100.	00/100	2100
5	DW2	1850 X 2100.	00/100	2100
6	DW3	1485 X 2100.	00/100	2100
7	DW4	1480 X 2100.	00/100	2100
8	W	1150 X 1200	900	2100
9	W1	675X1050	1050	2100
10	W2	800 X 1200	900	2100
11	W3	725 X 1050	1050	2100
12	V1	600X600	1500	2100

NOTE: 1.) ASSUMING FLR. FINISH LEVELS AS ± 0.00 FOR D/W FIXING
2.) FD= FIRE DOOR

1 TERRACE PLAN TOWER- G,H,I,J
Scale: 1:100

(MUMTY) AREA CALCULATION					
TYPE	QUANTITY	SHAPE	FORMULA	DETAIL	CALCULATION EACH AREA IN SQ.M
COVERAGE (ADDITION)					
ABCD	1	RECTANGLE	L x B	7.550	4.550
TOTAL					34.353
S1	1	RECTANGLE	L x B	2.750	4.250
S2	1	RECTANGLE	L x B	4.250	1.650
S3	1	RECTANGLE	L x B	1.250	0.850
S4	2	RECTANGLE	L x B	1.450	0.600
S5	2	RECTANGLE	L x B	1.250	0.850
S6	1	RECTANGLE	L x B	3.100	0.500
TOTAL (Y)					22.125
NET COVERED AREA = ABCD - (Y)					12.228

OHT AREA CALCULATION					
TYPE	QUANTITY	SHAPE	FORMULA	DETAIL	CALCULATION EACH AREA IN SQ.M
COVERAGE (ADDITION)					
ABCD	1	RECTANGLE	L x B	4.550	7.550
TOTAL					34.353
NET COVERED AREA = ABCD					34.353

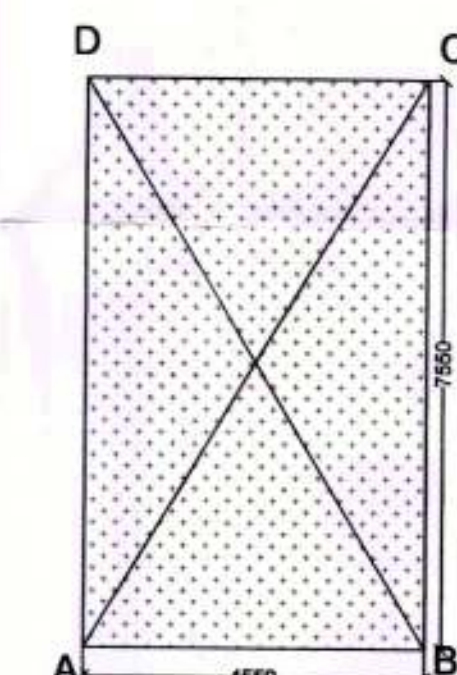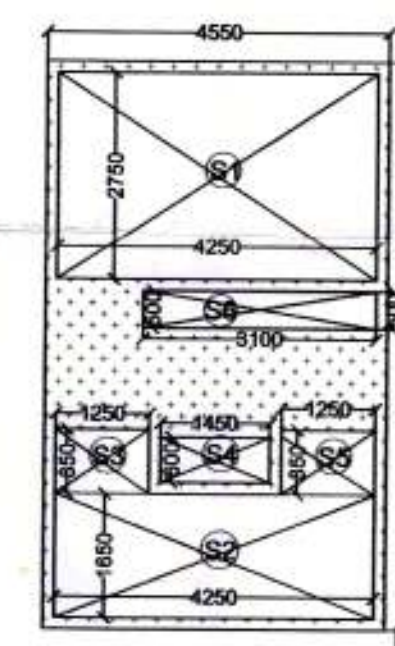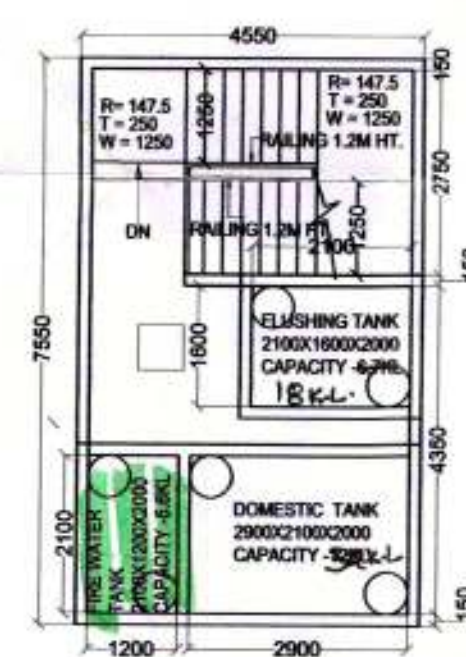

2 TANK ROOM LEVEL TOWER-G,H,I,J
Scale: 1:100

3 TANK TERRACE PLAN TOWER- G,H,I,J
Scale: 1:100

4 MUMTY AREA CALCULATION TOWER-G,H,I,J
Scale: 1:100

5 OHT AREA CALCULATION TOWER- G,H,I,J
Scale: 1:100

PRINCIPLE ARCHITECT
dfi
DESIGN FORUM INTERNATIONAL
K-47, KAILASH COLONY NEW DELHI-48
PHONE: 011-45556600 FAX: 45556601

CLIENT:
MEGA INFRATECH PVT. LTD.

PROJECT NAME AND ADDRESS
PROPOSED BUILDING PLAN FOR AFFORDABLE GROUP HOUSING COLONY FOR AN AREA MEASURING 9.0625 ACRES (LICENCE NO. 28 OF 2020) DT.7.10.2020 IN SECTOR 95B, GURUGRAM MANESAR URBAN COMPLEX

DRAWING TITLE:
TERRACE FLOOR PLAN, OHT ROOM & OHT ROOM TERRACE (TOWER- G,H,I,J)

OWNER'S SIGNATURE: *[Signature]*
ARCHITECT'S SIGNATURE: *[Signature]*
ANJO TEVATIA
B. Arch. (Hons.)
CA/95/18739

SCALE: 1:100
DATE:
SHEET NO. 15