


PROJECT (H.O.) S.P. Member Secretary Member B.P.C. B.P.C. B.P.C.

PLOT AREA = 20866.5703 SQ. MT.
= (5.15625 ACRES)
ALL DIMENSIONS ARE IN MM


AUTHORITY SIGNATURE

- NOTES
1. ALL DIMENSIONS ARE IN MILLIMETER UNLESS STATED OTHERWISE.
 2. THE CONSTRUCTION OF THE BUILDINGS SHALL BE GOVERNED BY PROVISIONS OF HARYANA BUILDING CODE, 20 POINTS WHERE HARYANA BUILDING CODE, 2017 IS SILENT THE NATIONAL BUILDING CODE OF INDIA, 2016 SHALL BE FOLLOWED.
 3. THE GATE AND BOUNDARY WALL BE CONSTRUCTED AS/CODE.
 4. THE CONSTRUCTION OF BASEMENT BE EXECUTED AS/CODE.
 5. LIFTS & RAMPS IN BUILDING AS/CODE.
 6. PROPER FIRE SAFETY MEASURES PROVISIONS AS PER CODES.
 7. INSTALLATION OF SOLAR POWER PLANT AS/CODE.
 8. ADEQUATE PARKING SPACES - COVERED, OPEN OR IN THE BASEMENT AS/CODE.
 9. PROVISION OF SEWAGE TREATMENT PLANT AS/CODE.

LOCATION PLAN

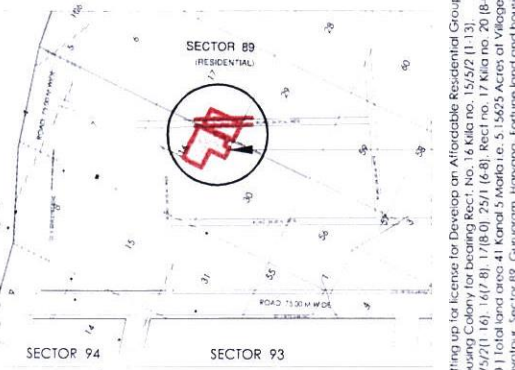

KEY PLAN

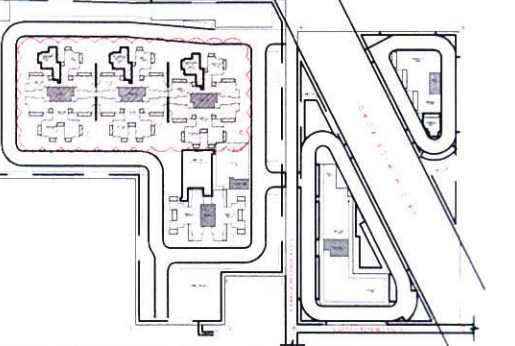

JOB TITLE

PROPOSED BUILDING PLAN OF AFFORDABLE GROUP HOUSING COLONY OVER AN AREA MEASURING 5.15625 ACRES (LICENCE NO. 49 DATED 12.08.2021) IN SECTOR-89, GURUGRAM BEING DEVELOPED BY KIWI LAND & HOUSING PT. LTD.

OWNER
KIWI LAND & HOUSING PVT. LTD

PROJECT
PROPOSED AFFORDABLE GROUP HOUSING COLONY AT SECTOR-89, GURUGRAM

MEP CONSULTANTS
KAMBO DESIGN STUDIO
209/1, STREET No. 03,
VIRENDER NAGAR
NEW DELHI - 110058
EMAIL - kambostudio@gmail.com

ARCHITECT
LINEAR CONCEPTS DESIGNS LLP
407, A09 GD ITL NORTH-EX TOWERS,
NETAJI SUBHASH PLACE
NEW DELHI - 110034, INDIA
EMAIL: STUDIO@LINEARCONCEPTS.IN
TEL: +91 11 43016035

DESCRIPTION
SUBMISSION DRAWING

SCALE 1 : 100 @ A
SHEET NO. DDT(YT)
DATE ISSUED MEMBER BPAC
DRAWN BY
CHECKED BY


ARCHITECT'S SIGNATURE AND SEAL OWNER'S SIGNATURE AND SEAL

STALEEN JETHI
CA201360819
ARCHITECT


TOWER-1, 2 & 3
(3BHK)

ELEVATIONS


PROJECT NO. DRAWING NO. AGH-AR-08

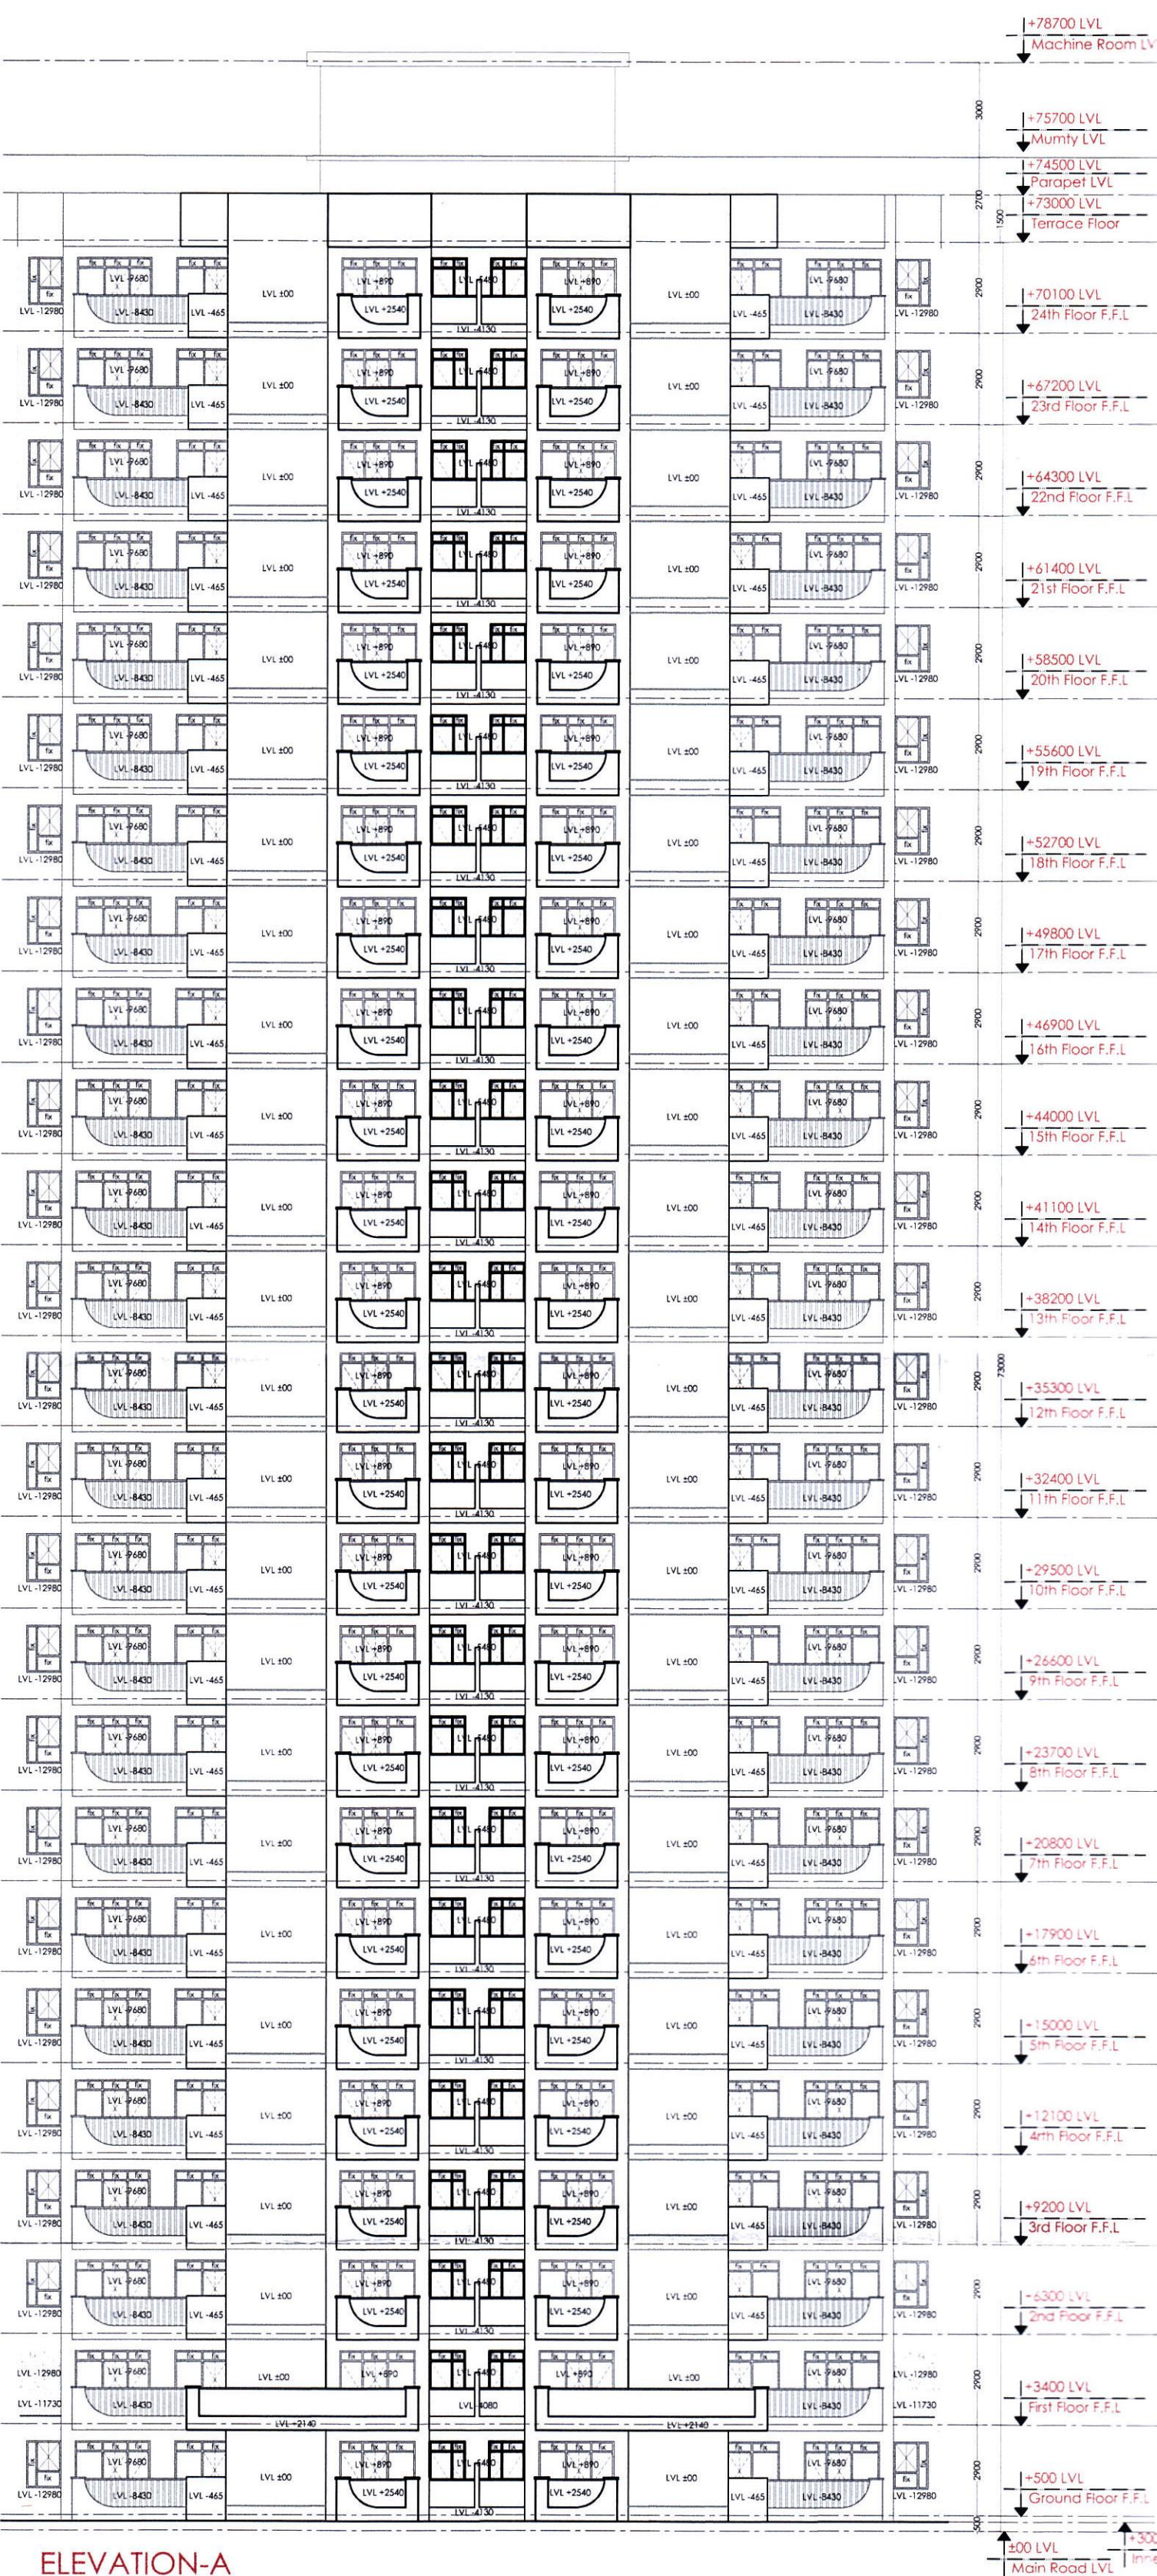

ELEVATION-A

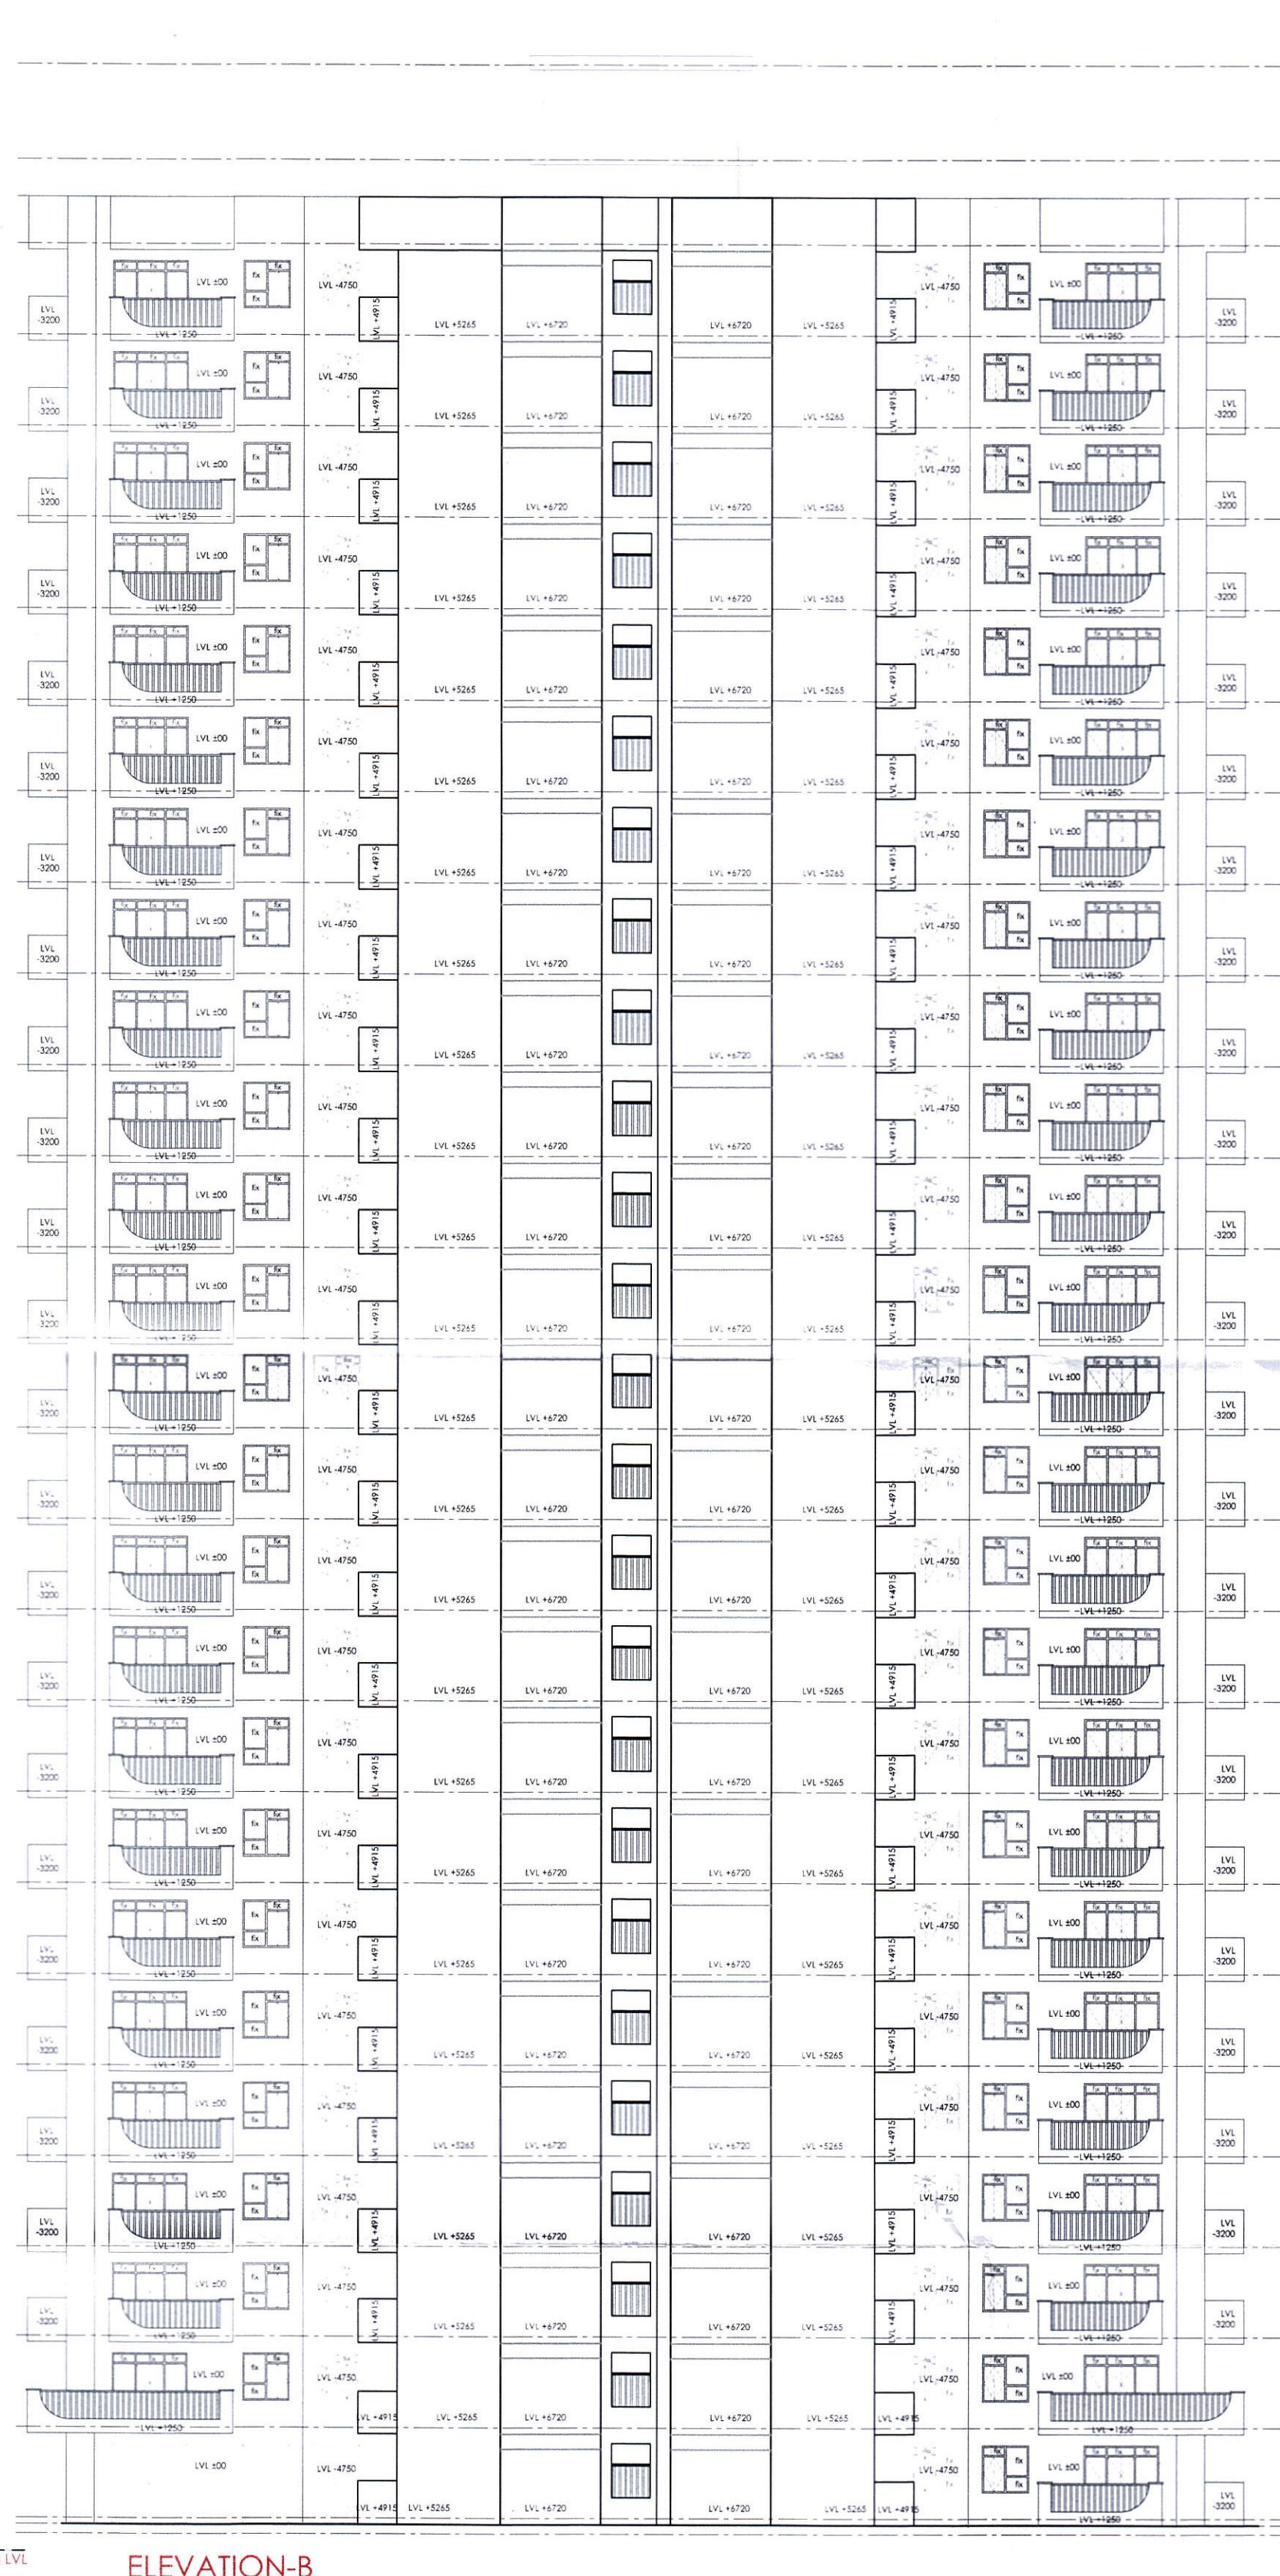

ELEVATION-B

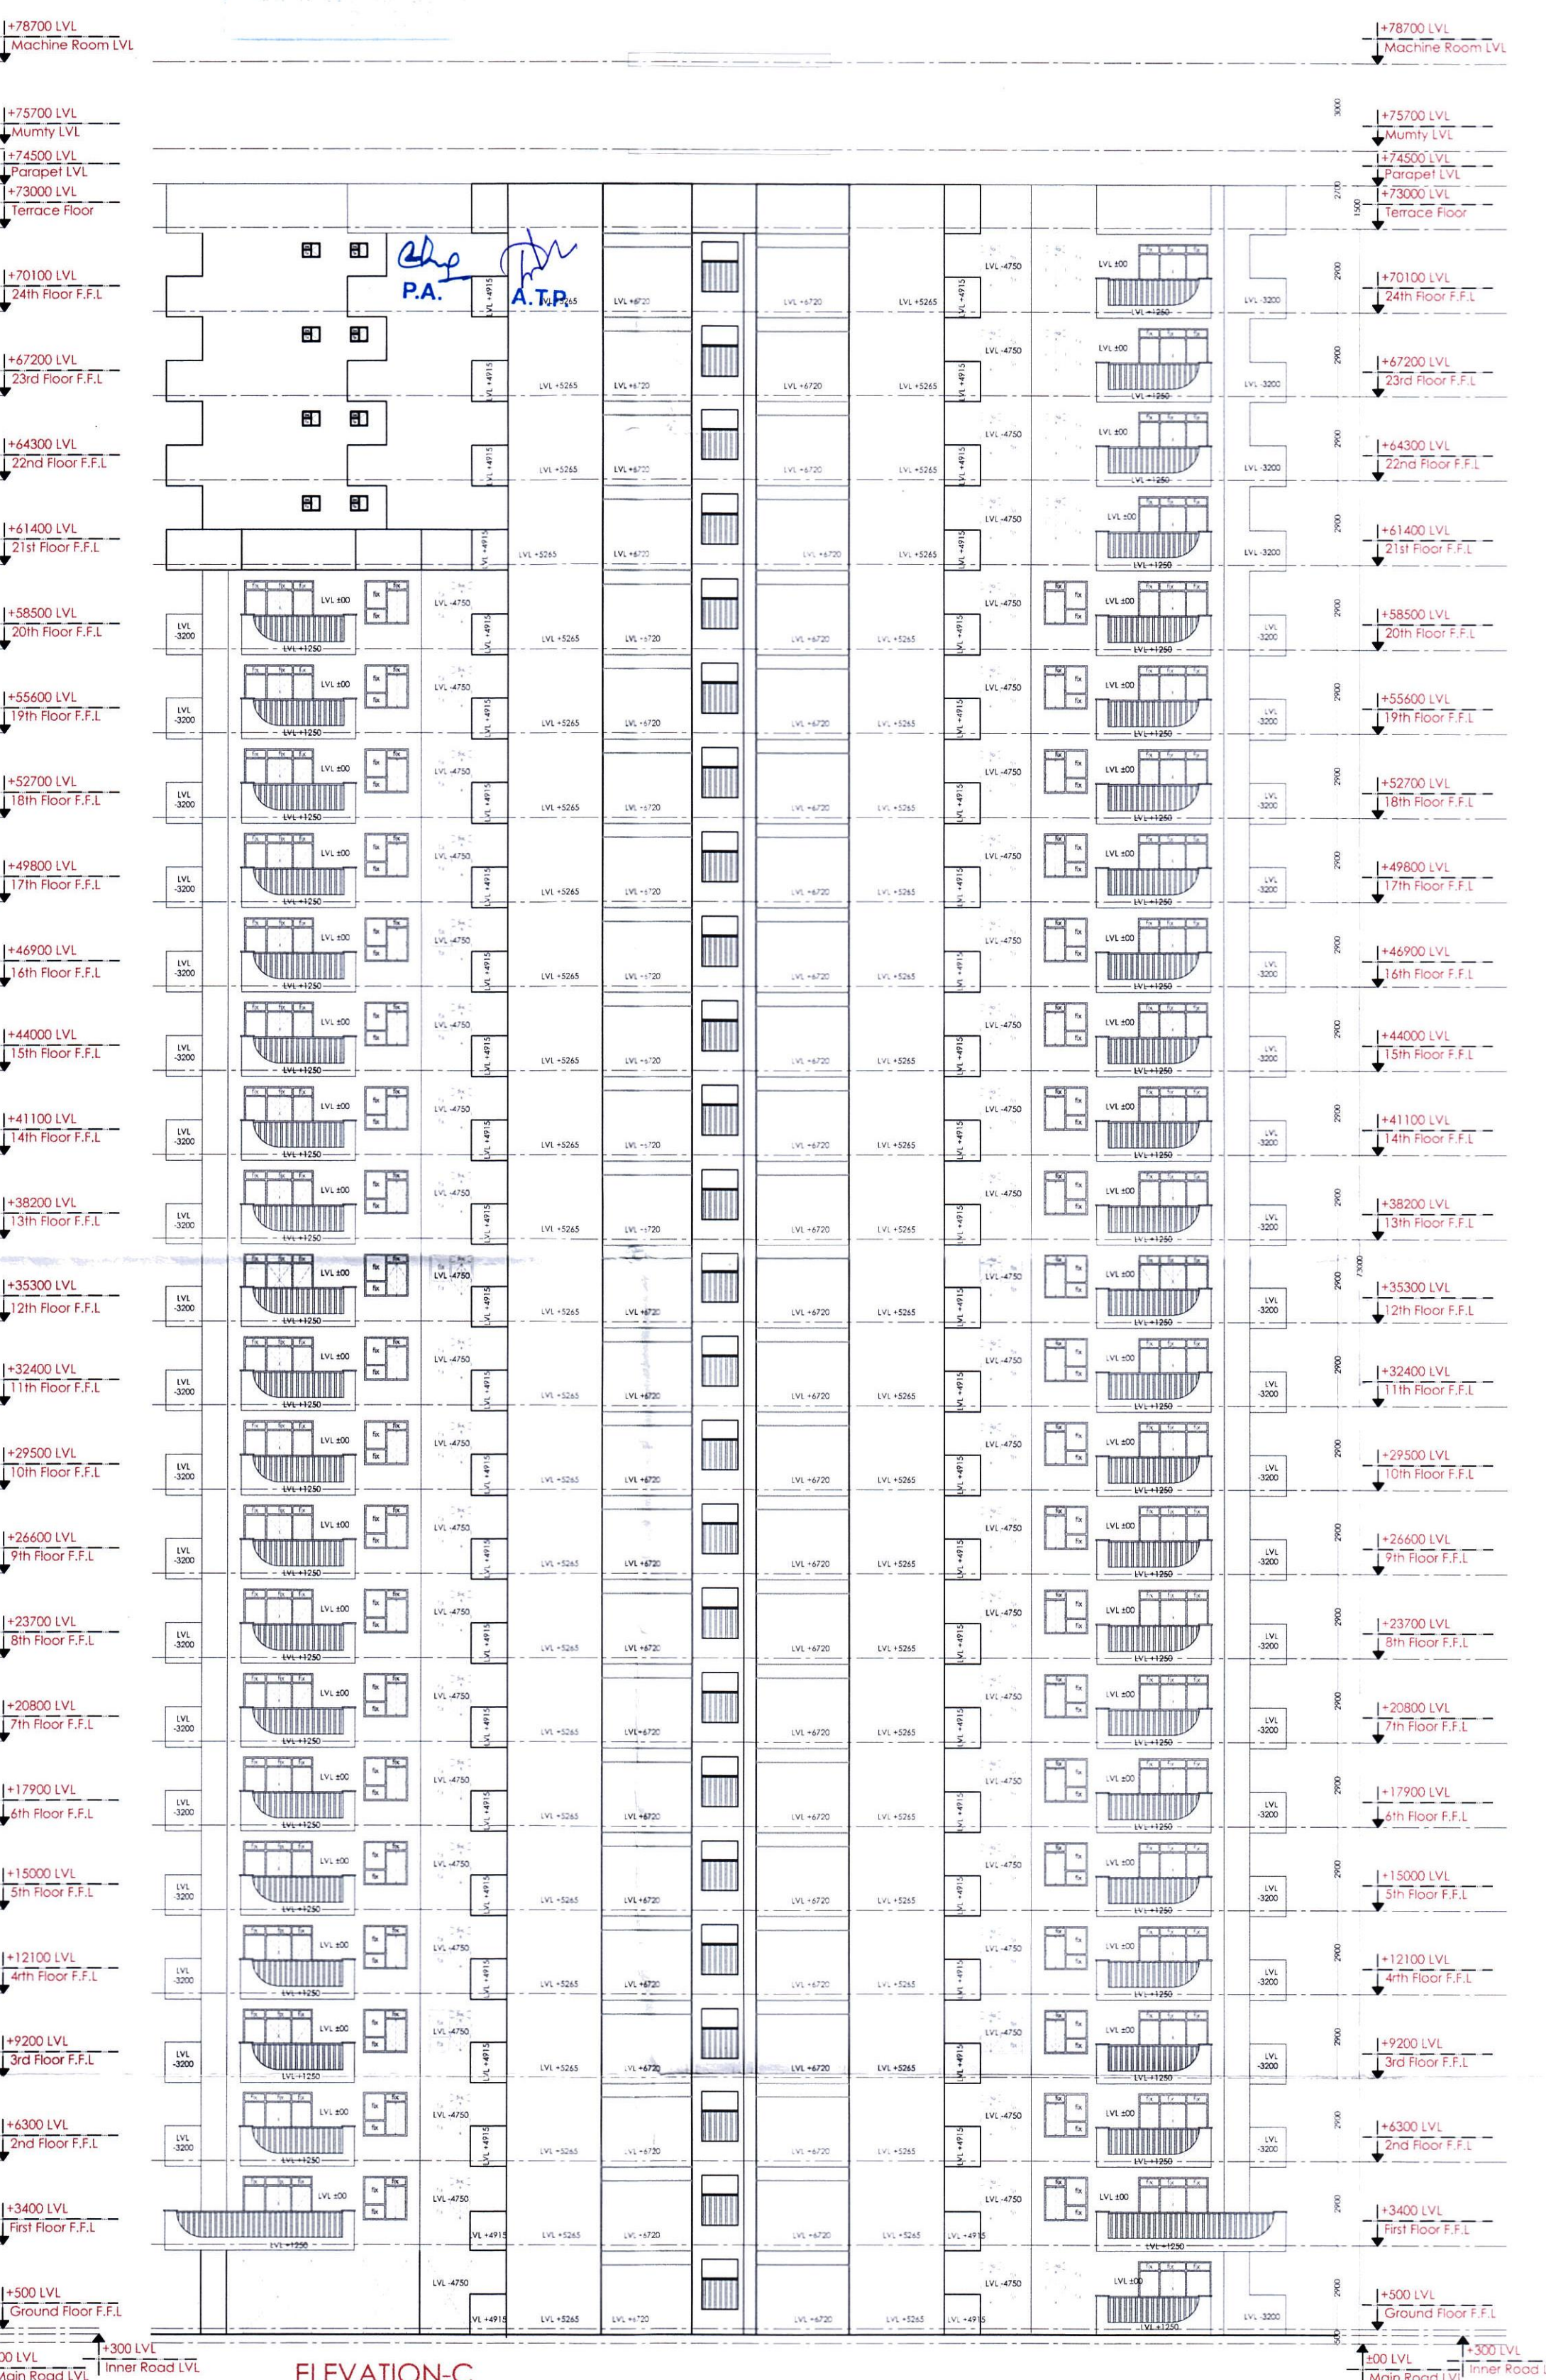

ELEVATION-C