




ELEVATION- A

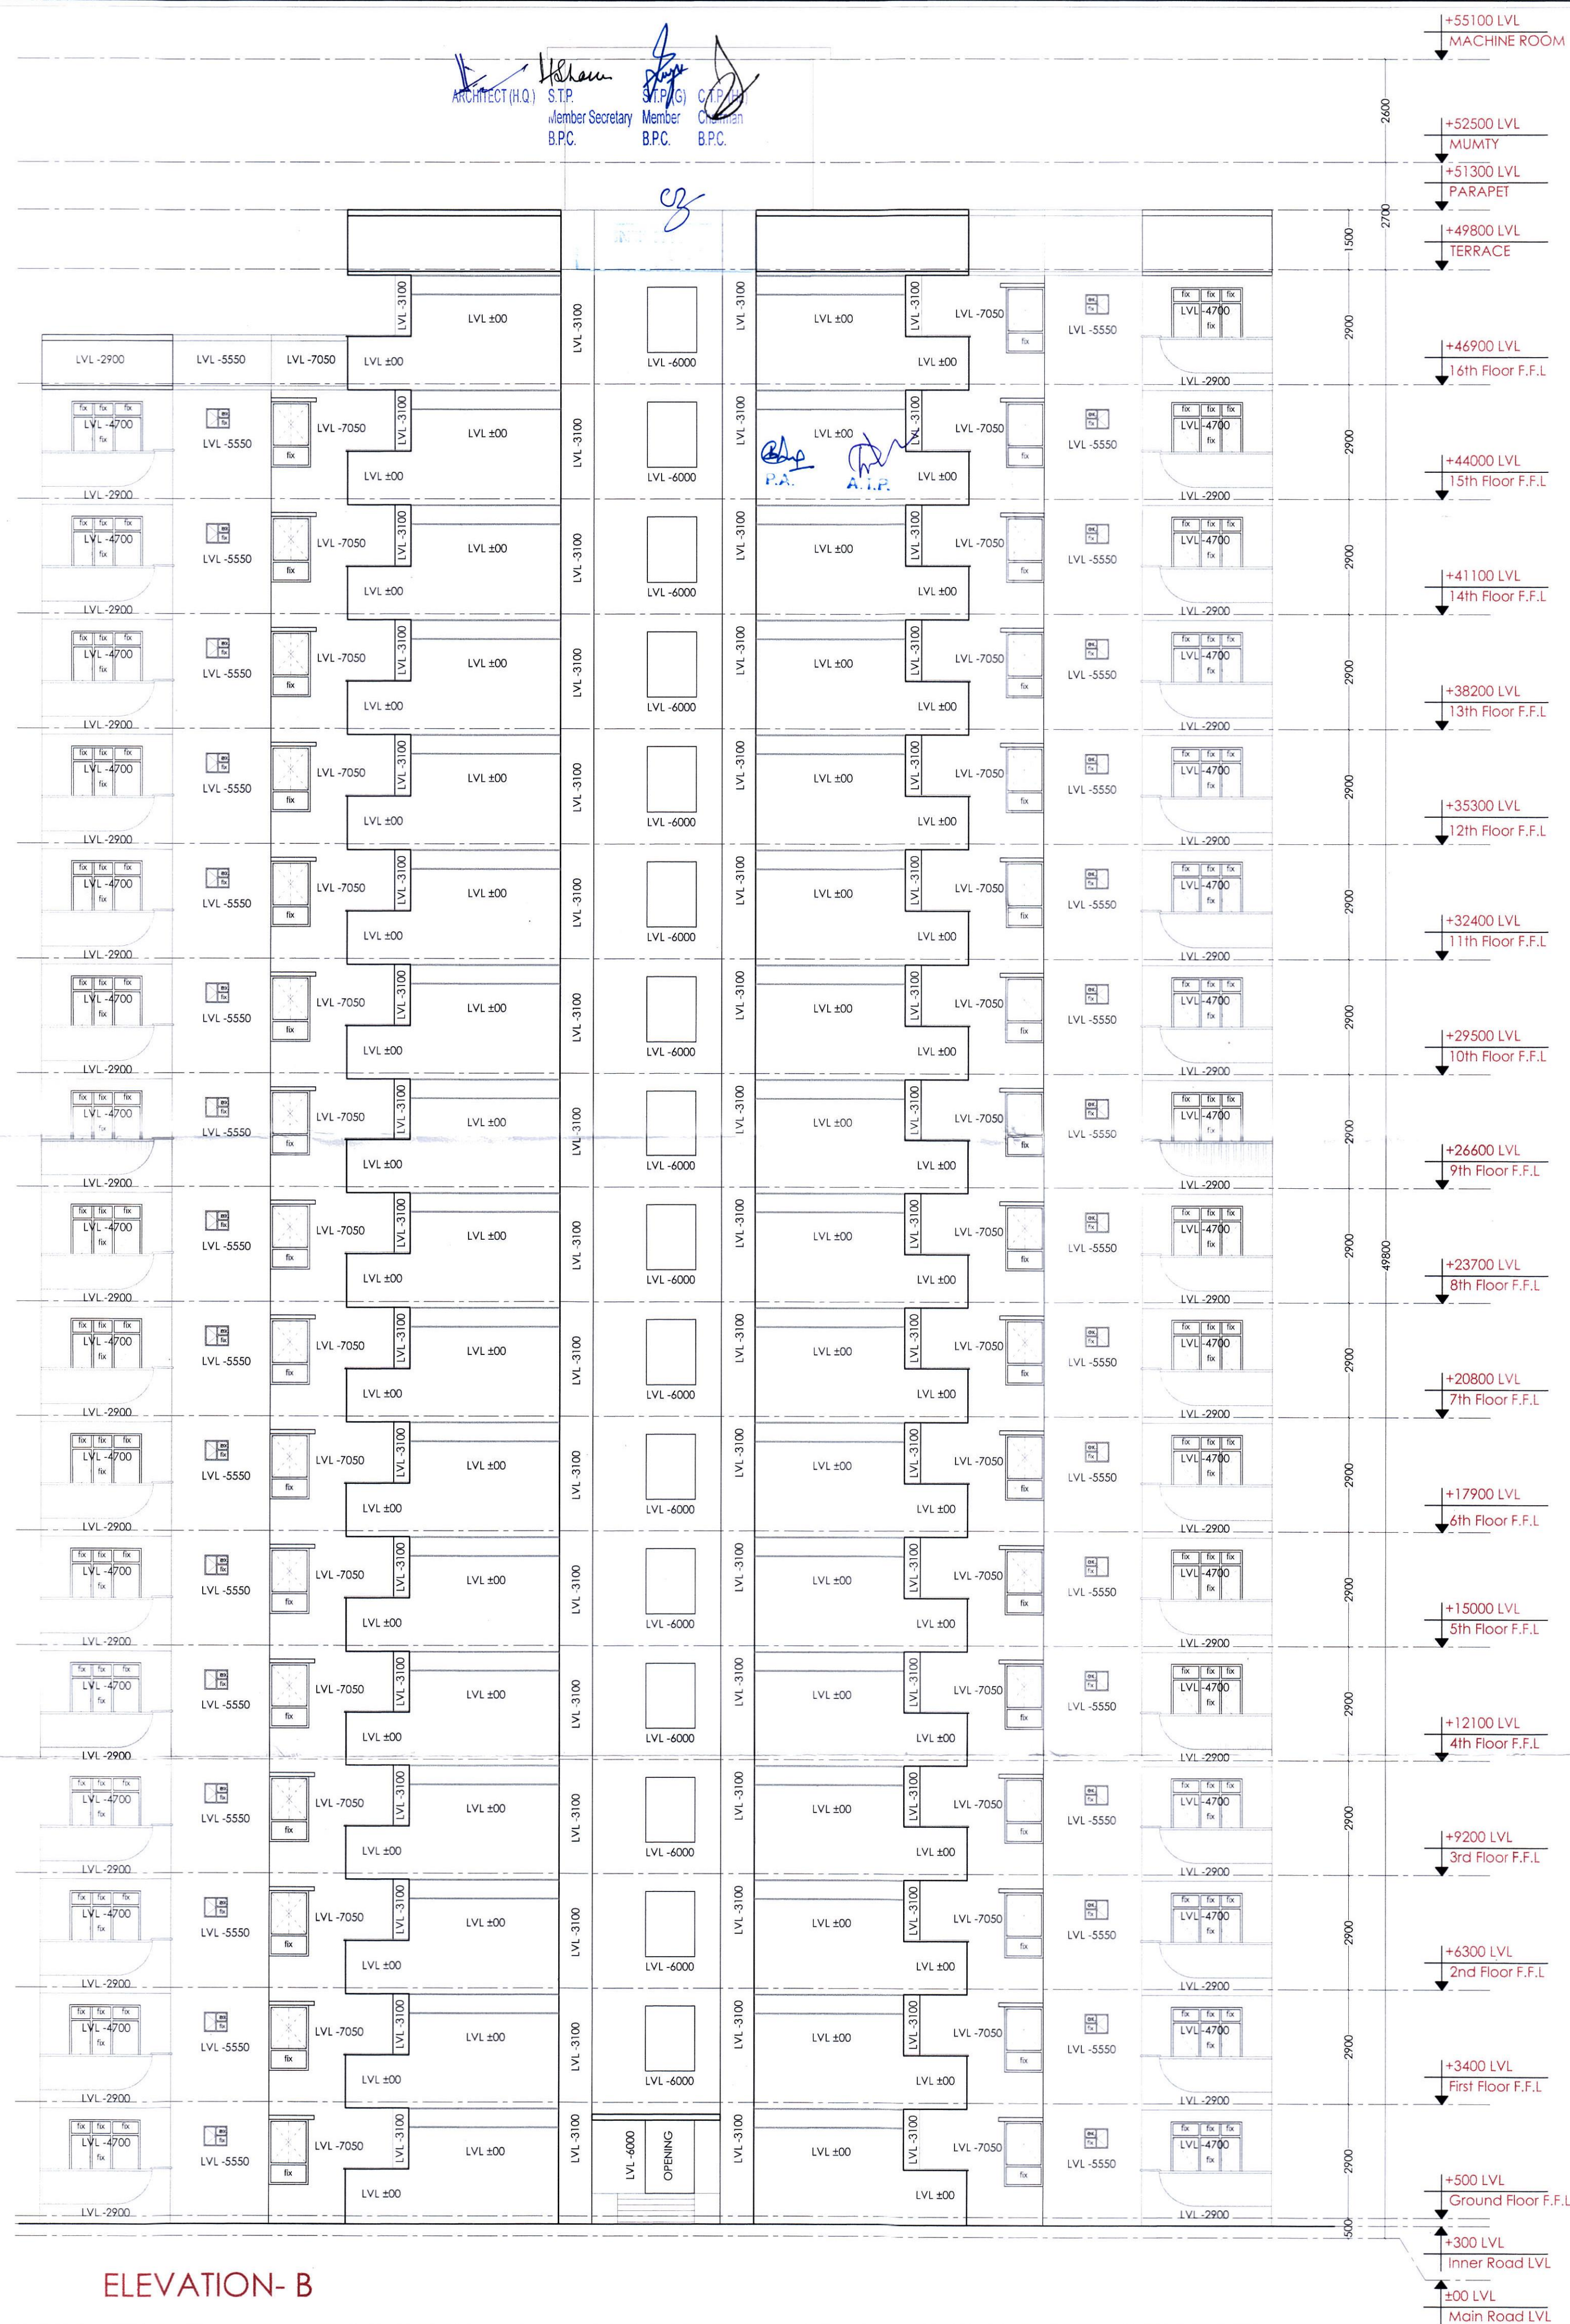

ELEVATION- B

PROJECT NO.

DRAWING NO.

AGH-AR-11

DATE ISSUED

30-08-2021

DRAWN BY

DDP (T) MEMBER BPAC

CHECKED BY

ARCHITECT'S SIGNATURE AND SEAL

OWNER'S SIGNATURE AND SEAL

TOWER-4 (1BHK)

ELEVATIONS

SCALE

1 : 100 @ A

SHEET NO.

DESCRIPTION

ARCHITECT

LINEAR CONCEPTS DESIGNS LLP

407, A09 GD I/TL NORTH-EX TOWERS, NETAJI SUBHASH PLACE, NEW DELHI - 110034, INDIA

EMAIL: STUDIO@LINEARCONCEPTS.IN

TEL: +91 11 43016035

MEP CONSULTANTS

KAMBO DESIGN STUDIO

209/1, STREET No. 03, VIRENDER NAGAR, NEW DELHI - 110058

EMAIL: - kambostudio@gmail.com

PROJECT

PROPOSED AFFORDABLE GROUP HOUSING COLONY AT SECTOR-89, GURUGRAM

OWNER

KIWI LAND & HOUSING PVT. LTD

JOB TITLE

PROPOSED BUILDING PLAN OF AFFORDABLE GROUP HOUSING COLONY OVER AN AREA MEASURING 5.15625 ACRES (LICENCE NO. 49 DATED 12.08.2021) IN SECTOR-89, GURUGRAM BEING DEVELOPED BY KIWI LAND & HOUSING PT. LTD.

KEY PLAN

LOCATION PLAN

NOTES

1.ALL DIMENSIONS ARE IN MILLIMETER UNLESS STATED OTHERWISE.
2.THE CONSTRUCTION OF THE BUILDINGS SHALL BE GOVERNED BY PROVISIONS OF HARYANA BUILDING CODE, 20 POINTS WHERE HARYANA BUILDING CODE, 2017 IS SILENT THE NATIONAL BUILDING CODE OF INDIA, 2016 SHALL BE FOLLOWED.
3.THE GATE AND BOUNDARY WALL BE CONSTRUCTED AS/CODE.
4.THE CONSTRUCTION OF BASEMENT BE EXECUTED AS/CODE.
5.LIFTS & RAMPS IN BUILDING AS/CODE.
6.INSTALLATION OF SOLAR POWER PLANT AS/CODE.
7.ADEQUATE PARKING SPACES - COVERED, OPEN OR IN THE BASEMENT AS/CODE.
8.PROVISION OF SEWAGE TREATMENT PLANT AS/CODE.

AUTHORITY SIGNATURE

PLOT AREA = 20866.5703 SQ. MT. = (5.15625 ACRES)

ALL DIMENSIONS ARE IN MM