


PLOT AREA = 20866.5703 SQ. MT.
= (5.15625 ACRES)
ALL DIMENSIONS ARE IN MM


AUTHORITY SIGNATURE

- NOTES
1. ALL DIMENSIONS ARE IN MILLIMETER UNLESS STATED OTHERWISE.
 2. THE CONSTRUCTION OF THE BUILDINGS SHALL BE GOVERNED BY PROVISIONS OF HARYANA BUILDING CODE, 2017 IS SILENT THE NATIONAL BUILDING CODE OF INDIA, 2016 SHALL BE FOLLOWED.
 3. THE GATE AND BOUNDARY WALL BE CONSTRUCTED AS/CODE.
 4. THE CONSTRUCTION OF BASEMENT BE EXECUTED AS/CODE.
 5. LIFTS & RAMPS IN BUILDING AS/CODE.
 6. PROPER FIRE SAFETY MEASURES PROVISIONS AS PER CODES.
 7. INSTALLATION OF SOLAR POWER PLANT AS/CODE.
 8. ADEQUATE PARKING SPACES - COVERED, OPEN OR IN THE BASEMENT AS/CODE.
 9. PROVISION OF SEWAGE TREATMENT PLANT AS/CODE.

LOCATION PLAN

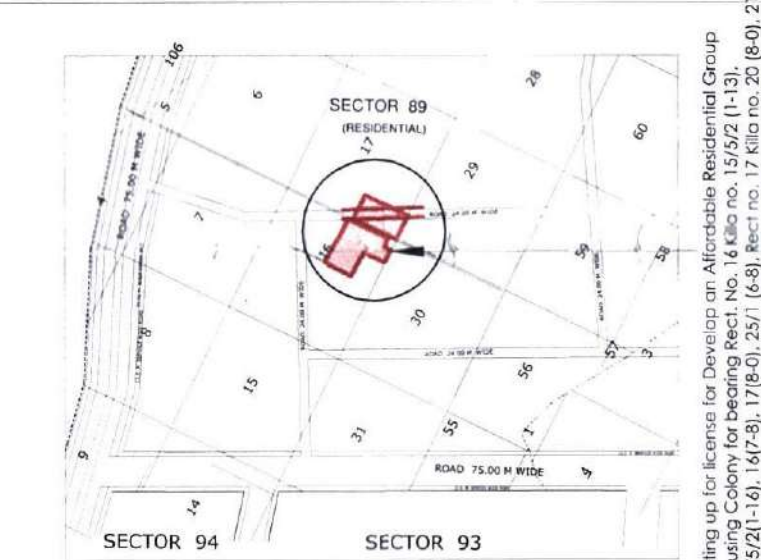

KEY PLAN

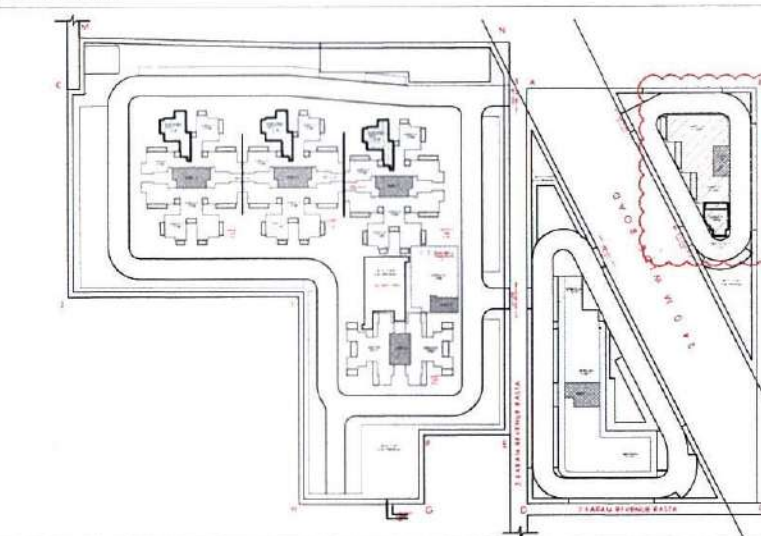

JOB TITLE

PROPOSED BUILDING PLAN OF
AFFORDABLE GROUP HOUSING COLONY
OVER AN AREA
MEASURING 5.15625 ACRES
(LICENCE NO. 49 DATED 12.08.2021) IN
SECTOR-89, GURUGRAM BEING
DEVELOPED BY
KIWI LAND & HOUSING PVT. LTD.

OWNER
KIWI LAND & HOUSING PVT. LTD

PROJECT
PROPOSED AFFORDABLE
GROUP HOUSING COLONY
AT SECTOR-89, GURUGRAM

CONSULTANTS
KAMBO DESIGN STUDIO
208/1, STREET NO. 03,
VIRENDER NAGAR
NEW DELHI - 110058
EMAIL: kamboastudio@gmail.com

ARCHITECT
LINEAR CONCEPTS DESIGNS LLP

407, A09 GD I/TL NORTH-EX TOWERS,
NETAJI SUBHASH PLACE,
NEW DELHI - 110054, INDIA
EMAIL: STUDIO@LINEARCONCEPTS.IN
TEL: +91 11 43016035

DESCRIPTION

SUBMISSION DRAWING

SCALE 1 : 100 @

SHEET NO. A

DATE ISSUED 30-08-2021

DRAWN BY

CHECKED BY

ARCHITECT'S SIGNATURE AND SEAL OWNER'S SIGNATURE AND SEAL



COMMERCIAL-02

FLOOR PLANS &
AREA DETAILS

PROJECT NO. DRAWING NO. AGH-AR-15

