


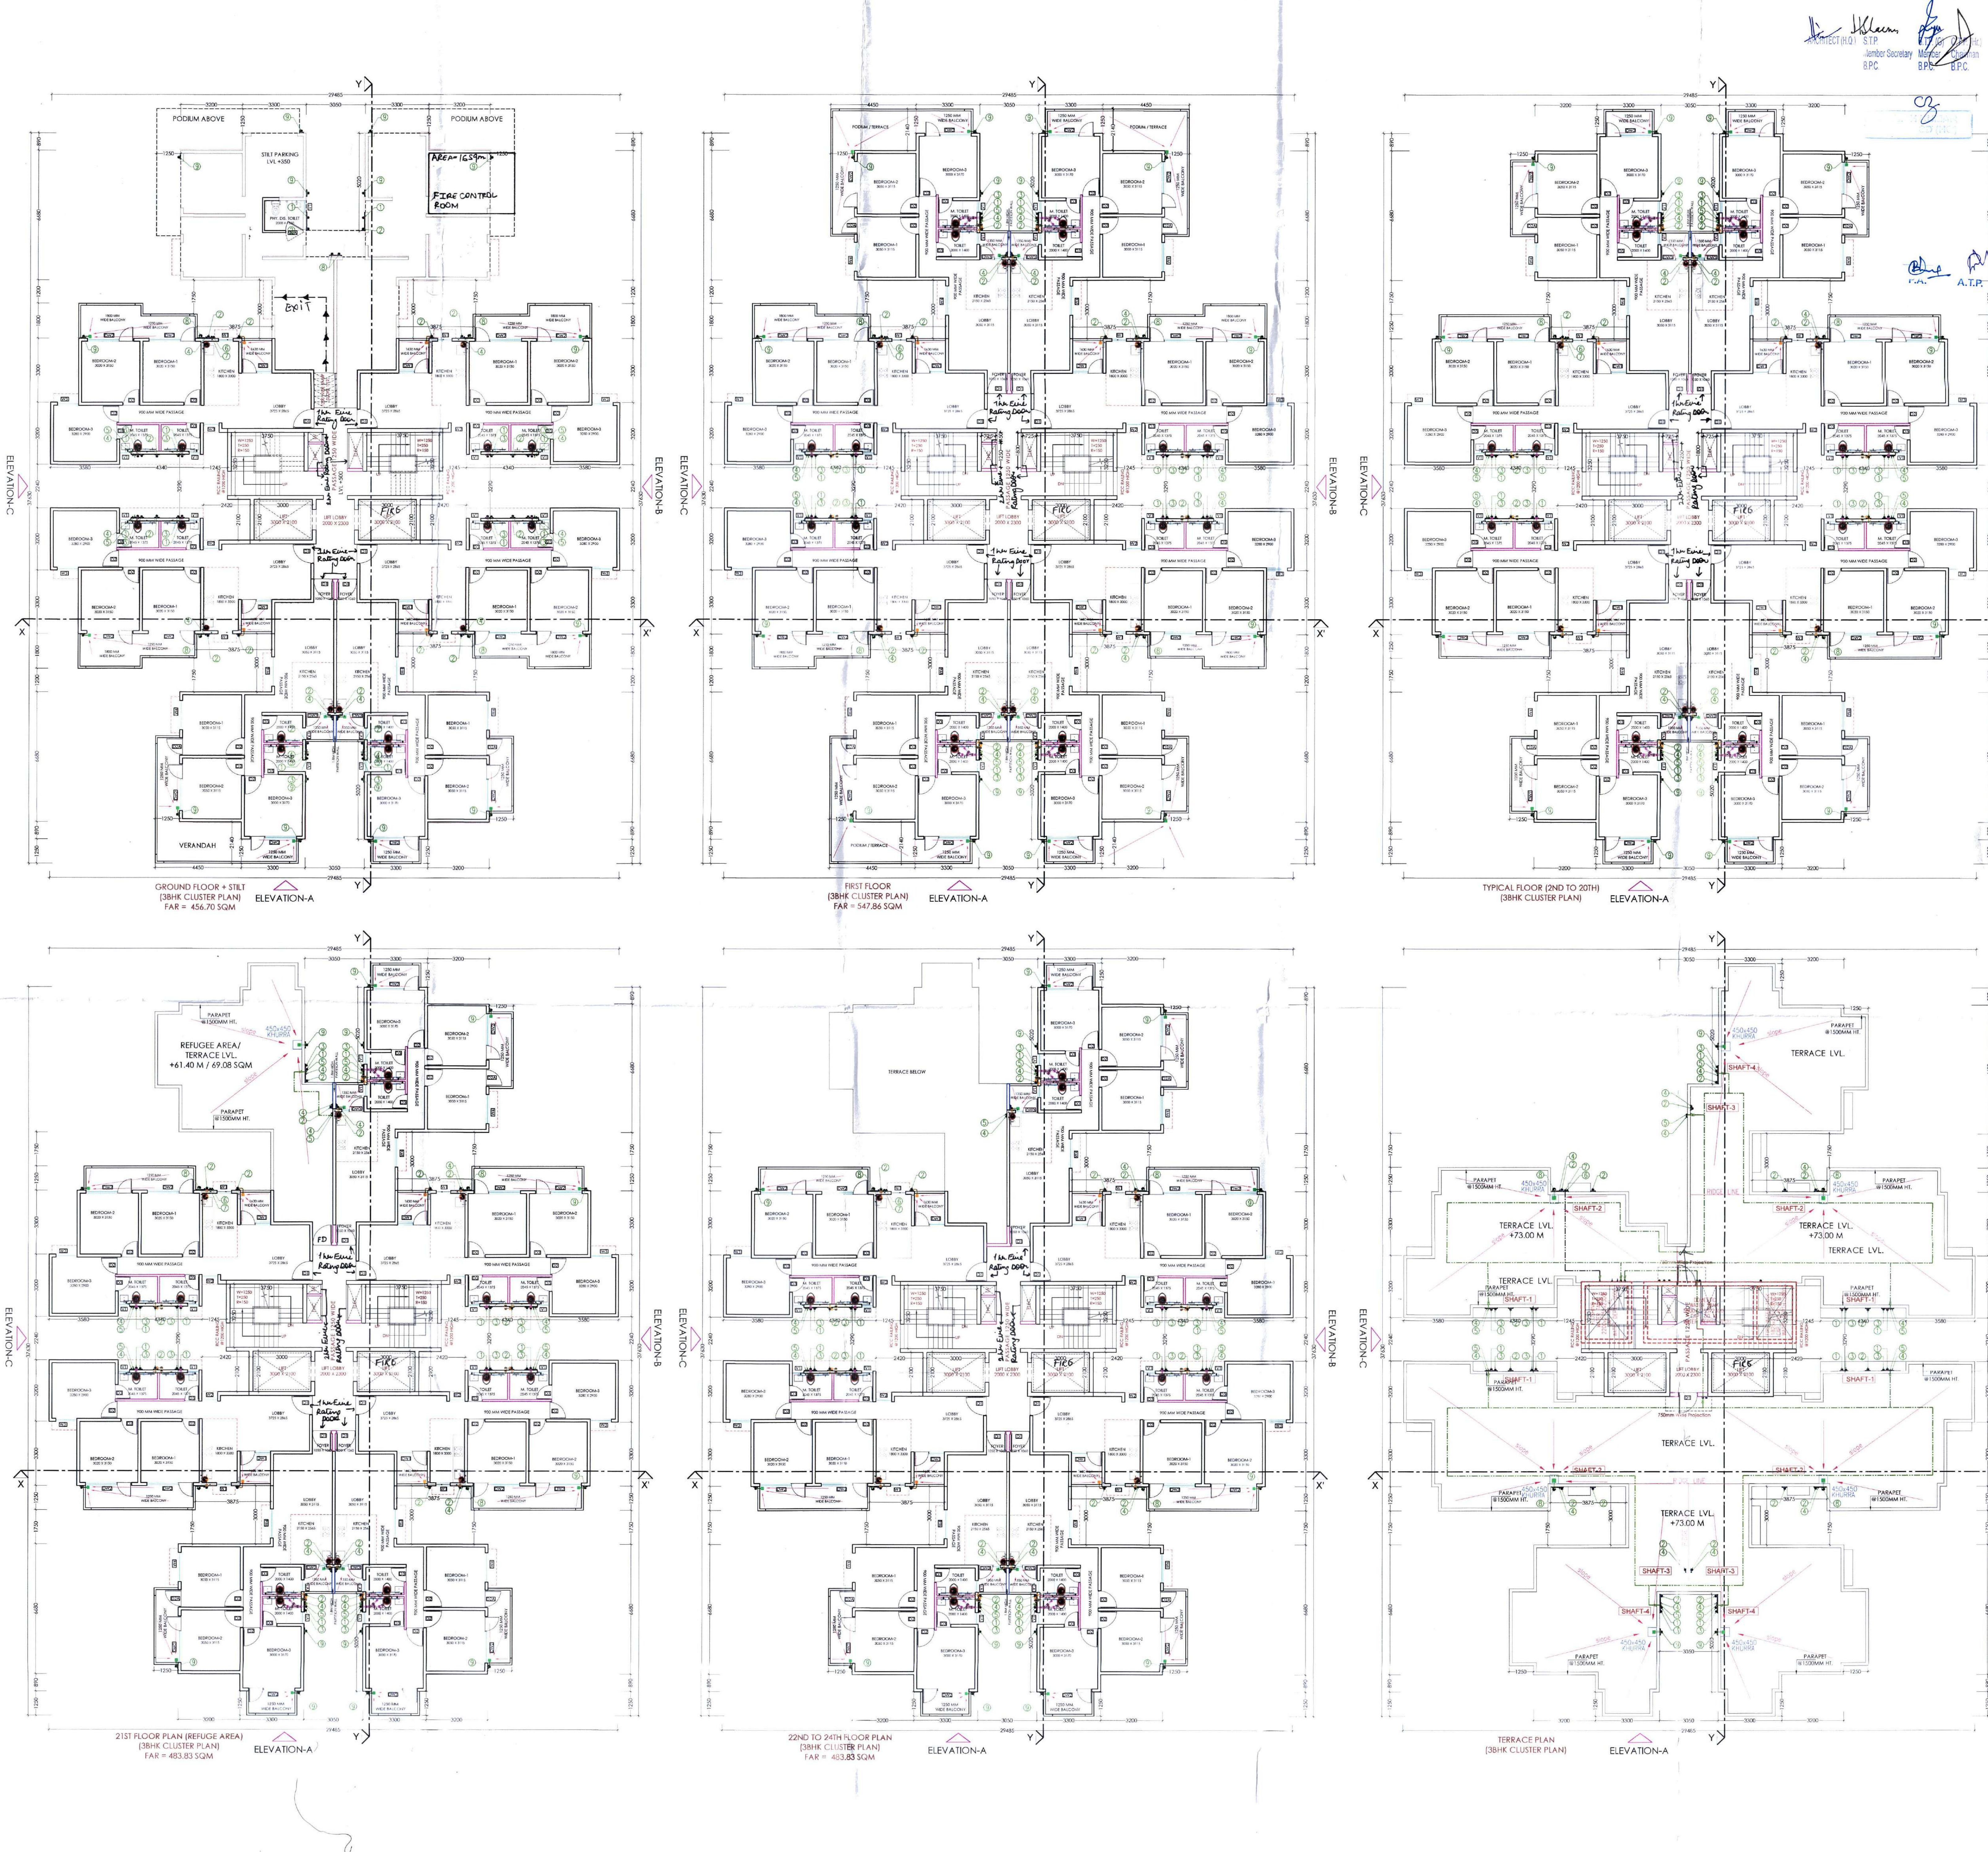

| DOOR & WINDOW |             |            |            |                 |            |
|---------------|-------------|------------|------------|-----------------|------------|
| Tag           | Size        | Slit Level | Unit Level | Location        | Type       |
| D1            | 1000 x 2100 | -          | 2100       | Main Entrance   | Type - 1.2 |
| D2            | 900 x 2100  | -          | 2100       | BED ROOM        | Type - 1.2 |
| D3            | 750 x 2100  | -          | 2100       | TOILET          | Type - 1.2 |
| DW1           | 1075 x 2400 | -          | 2400       | LOBBY           | Type - 1   |
| DW2           | 2400 x 2400 | -          | 2400       | BED ROOM        | Type - 1.2 |
| DW3           | 1150 x 2400 | 1050       | 2400       | KITCHEN         | Type - 2   |
| W1            | 750 x 1350  | 1050       | 2400       | KITCHEN         | Type - 1   |
| W2            | 810 x 1500  | 900        | 2400       | LOBBY (PASSAGE) | Type - 1   |
| W3            | 1100 x 1500 | 900        | 2400       | LOBBY           | Type - 1   |
| W4            | 1500 x 1500 | 900        | 2400       | LOBBY           | Type - 2   |
| W1            | 600 x 500   | 1900       | 2400       | TOILET          | Type - 1.2 |

\* D1 - 1mm, Fire Rated Door

| WATER SUPPLY LEGEND:- |                             |
|-----------------------|-----------------------------|
| DWS                   | DOMESTIC WATER SUPPLY       |
| FWS                   | FLUSHING WATER SUPPLY       |
| DWR                   | DOMESTIC WATER SUPPLY RISER |
| FWR                   | FLUSHING WATER SUPPLY RISER |
| HWS                   | HOT WATER SUPPLY            |
| BD                    | BUTTERFLY VALVE             |
| HF                    | HEALTH FAUCET               |
| AV                    | ANGLE VALVE                 |
| SH                    | SHOWER                      |
| OST                   | OSTERN                      |

LEGENDS :

- 110 OD SOIL AND VENT PIPE (SWR TYPE-B)
- 110 OD WASTE AND VENT PIPE (SWR TYPE-B)
- 90 OD ANTI-SIPHONAGE PIPE (SWR TYPE-B)
- DOMESTIC WATER SUPPLY DN. TAKE (PPR LAYERS)
- FLUSHING WATER SUPPLY DN. TAKE (PPR LAYERS)
- DOMESTIC WATER SUPPLY RISER TO O.H.T. (PPR LAYERS)
- FLUSHING WATER SUPPLY RISER TO O.H.T. (PPR LAYERS)
- 180 OD RAIN WATER PIPE (SWR TYPE-B)
- 110 OD RAIN WATER PIPE (SWR TYPE-B)

DETAIL OF PIPES CONNECTION:-

- FROM WC TO STACK/MH.....110 OD PIPE (SWR TYPE-B)
- FROM FT TO STACK/GT.....110 OD PIPE (SWR TYPE-B)
- FROM WB TO FV.....60 OD UPVC PIPE
- FROM WC WASTE TO FT.....60 OD UPVC PIPE
- FROM FD TO FT.....90 OD UPVC PIPE
- FROM GT TO MH.....110 OD UPVC PIPE
- FROM MH TO MH.....210 OD UPVC PIPE

PLUMBING IMPORTANT NOTES :

- ALL PIPE DIAMETERS ARE IN MM.
- THIS DRAWING SHALL BE READ IN CONJUNCTION WITH ALL RELEVANT ARCHITECTURAL AND STRUCTURAL DRAWING.
- ALL HORIZONTAL SOIL AND WASTE PIPES SHALL BE LAID TO A SLOPE NOT FLATTER THAN 1:70, UNLESS SPECIFIED OTHERWISE.
- NO PIPE WORK SHALL BE CONCEALED IN WALLS OR BURIED IN FLOORS WITHOUT BEING SUBJECTED TO WATER TESTING AS PER THE DIRECTION OF THE SITE ENGINEER.

PLUMBING LEGEND:-

- F.T. FLOOR (P) TRAP
- F.D. FLOOR DRAIN
- U.T. URINAL (P) TRAP
- F.C.O. FLOOR CLEAN OUT PLUG
- C.O.P. CLEAN OUT PLUG

PIPES SLOPE :-

- 50# PIPE 1:40
- 110# PIPE 1:60
- 160# PIPE 1:100
- 210# PIPE 1:150
- 250# PIPE 1:190

PLOT AREA = 20866.5703 SQ. MT.  
= (5.15625 ACRES)  
ALL DIMENSIONS ARE IN MM

AUTHORITY SIGNATURE

Checked and found ok for Public Health  
(Internal) Service only subject to comments in  
the accompanying drawings (H.Q.)  
H.S.V.P. Panel

DD (T)  
MEMB  
BPC

NOTES

1. ALL DIMENSIONS ARE IN MILLIMETER UNLESS STATED OTHERWISE.
2. THE CONSTRUCTION OF THE BUILDINGS SHALL BE GOVERNED BY PROVISIONS OF HARYANA BUILDING CODE, 20 POINTS WHERE HARYANA BUILDING CODE, 2017 IS SILENT THE NATIONAL BUILDING CODE OF INDIA, 2016 SHALL BE FOLLOWED.
3. THE GATE AND BOUNDARY WALL BE CONSTRUCTED AS/CODE.
4. THE CONSTRUCTION OF BASEMENT BE EXECUTED AS/CODE.
5. LIFTS & RAMPS IN BUILDING AS/CODE.
6. PROPER FIRE SAFETY MEASURES PROVISIONS AS PER CODES.
7. INSTALLATION OF SOLAR POWER PLANT AS/CODE.
7. ADEQUATE PARKING SPACES - COVERED, OPEN OR IN THE BASEMENT AS/CODE.
8. PROVISION OF SEWAGE TREATMENT PLANT AS/CODE.

LOCATION PLAN

KEY PLAN

JOB TITLE

PROPOSED BUILDING PLAN OF AFFORDABLE GROUP HOUSING COLONY OVER AN AREA MEASURING 5.15625 ACRES (LICENCE NO. 49 DATED 12.08.2021) IN SECTOR-89, GURUGRAM BEING DEVELOPED BY KIWI LAND & HOUSING PT. LTD.

OWNER

KIWI LAND & HOUSING PVT. LTD

PROJECT

PROPOSED AFFORDABLE GROUP HOUSING COLONY AT SECTOR-89, GURUGRAM

MEP CONSULTANTS

KAMBO DESIGN STUDIO  
209/1, STREET No. 03,  
VIRENDER NAGAR  
NEW DELHI - 110058  
EMAIL :- kambostudio@gmail.com

ARCHITECT

LINEAR CONCEPTS DESIGNS LLP  
407, A09 GD I/L NORTH-EX TOWERS,  
NETAJI SUBHASH PLACE  
NEW DELHI - 110034, INDIA  
EMAIL: STUDIO@LINEARCONCEPTS.IN  
TEL: +91 11 43016035

DESCRIPTION

SUBMISSION DRAWING

SCALE

1 : 100 @ A

SHEET NO.

DATE ISSUED

30-08-2021

DRAWN BY

CHECKED BY

ARCHITECT'S SIGNATURE AND SEAL

OWNER'S SIGNATURE AND SEAL

TOWER-3

FLOOR PLANS

AGH-AR-06