



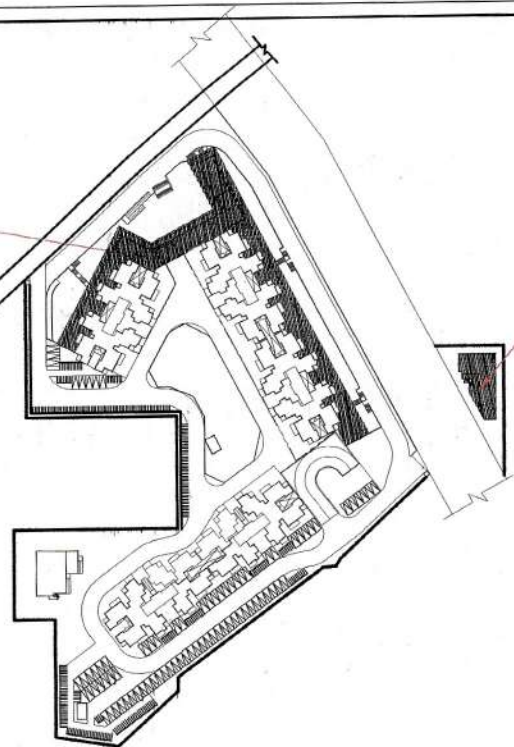

KEY PLAN

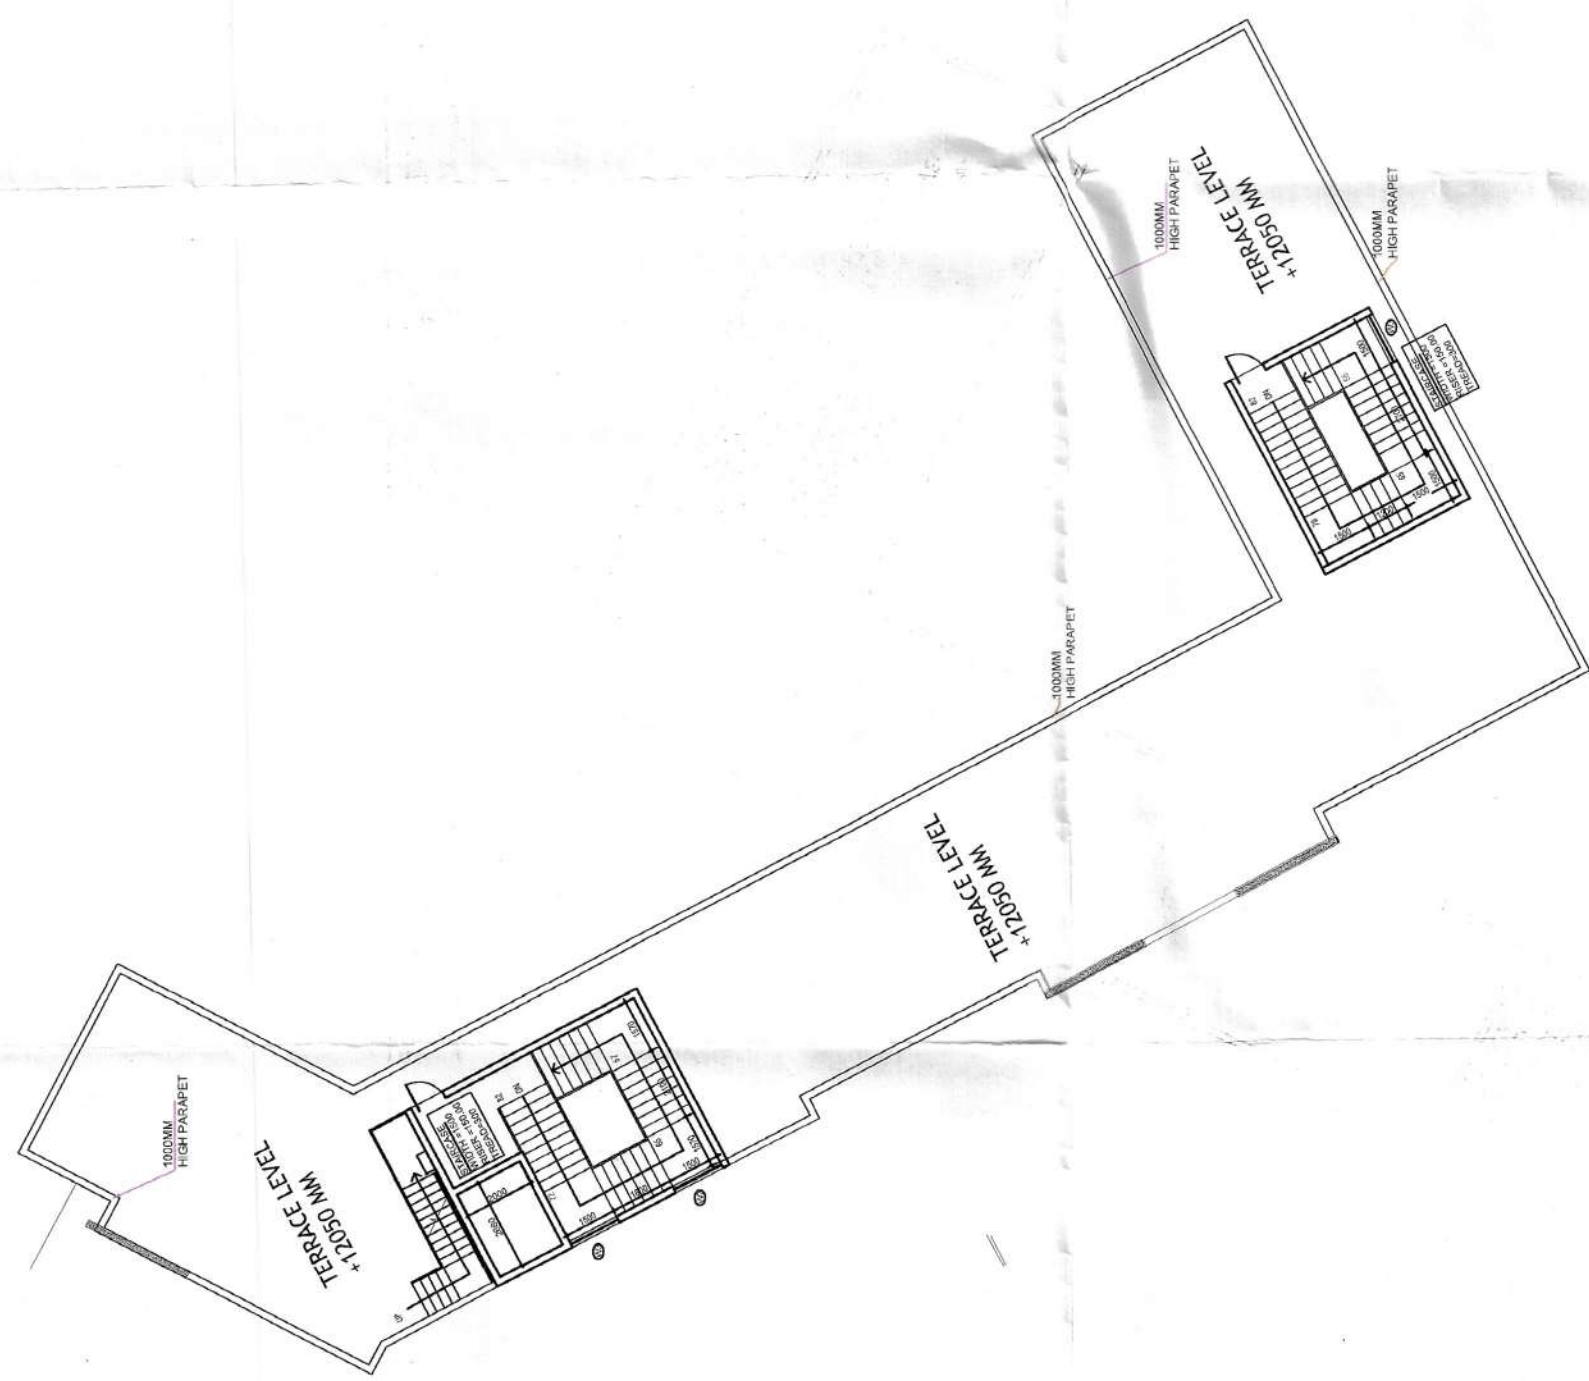

ROOF FLOOR PLAN : COMMERCIAL BLOCK -1

DOOR WINDOW SCHEDULE			TYPE	SIZE	CHILL	LINTEL	DESCRIPTION
D	0	1000 x 2100	---	2100			TILET
D1	01	500 x 2100	---	2100			TILET
D2	02	500 x 2100	---	2100			TILET
D3	03	1000 x 2100	---	2100			TILET
D4	04	700 x 500	1300	2100			TILET
D5	05	700 x 500	1300	2100			TILET
D6	06	700 x 500	1300	2100			TILET
D7	07	700 x 500	1300	2100			TILET
D8	08	700 x 500	1300	2100			TILET
D9	09	700 x 500	1300	2100			TILET
D10	10	700 x 500	1300	2100			TILET
D11	11	700 x 500	1300	2100			TILET
D12	12	700 x 500	1300	2100			TILET
D13	13	700 x 500	1300	2100			TILET
D14	14	700 x 500	1300	2100			TILET
D15	15	700 x 500	1300	2100			TILET
D16	16	700 x 500	1300	2100			TILET
D17	17	700 x 500	1300	2100			TILET
D18	18	700 x 500	1300	2100			TILET
D19	19	700 x 500	1300	2100			TILET
D20	20	700 x 500	1300	2100			TILET
D21	21	700 x 500	1300	2100			TILET
D22	22	700 x 500	1300	2100			TILET
D23	23	700 x 500	1300	2100			TILET
D24	24	700 x 500	1300	2100			TILET
D25	25	700 x 500	1300	2100			TILET
D26	26	700 x 500	1300	2100			TILET
D27	27	700 x 500	1300	2100			TILET
D28	28	700 x 500	1300	2100			TILET
D29	29	700 x 500	1300	2100			TILET
D30	30	700 x 500	1300	2100			TILET
D31	31	700 x 500	1300	2100			TILET
D32	32	700 x 500	1300	2100			TILET
D33	33	700 x 500	1300	2100			TILET
D34	34	700 x 500	1300	2100			TILET
D35	35	700 x 500	1300	2100			TILET
D36	36	700 x 500	1300	2100			TILET
D37	37	700 x 500	1300	2100			TILET
D38	38	700 x 500	1300	2100			TILET
D39	39	700 x 500	1300	2100			TILET
D40	40	700 x 500	1300	2100			TILET
D41	41	700 x 500	1300	2100			TILET
D42	42	700 x 500	1300	2100			TILET
D43	43	700 x 500	1300	2100			TILET
D44	44	700 x 500	1300	2100			TILET
D45	45	700 x 500	1300	2100			TILET
D46	46	700 x 500	1300	2100			TILET
D47	47	700 x 500	1300	2100			TILET
D48	48	700 x 500	1300	2100			TILET
D49	49	700 x 500	1300	2100			TILET
D50	50	700 x 500	1300	2100			TILET
D51	51	700 x 500	1300	2100			TILET
D52	52	700 x 500	1300	2100			TILET
D53	53	700 x 500	1300	2100			TILET

Checked and found ok for Public Health
(Internal) Service only subject to comments in
in forwarding letter No. ACE/HQ/.....DT-28/10-1
180035

Additional Civil Engineer (HQ)
HSVP, Pondicherry

SUBMISSION DRAWING

CLIENT
SYNERGYSHINE INFRA. LLP IN COLLABORATION WITH GULMOHAR
FINANCE LTD.

PROJECT TITLE	PROPOSED BUILDING PLANS OF AFFORDABLE GROUP HOUSING COLLOCATED ON LAND MEASURING 5.7875 ACRES (LICENSE NO. 43 OF 2021) IN THE REVENUE ESTATE OF VILLAGE ULLAWAS SECTOR 62, DISTRICT GURUGRAM - MANESAR URBAN COMPLEX BEING DEVELOPED BY SYNERGYSHINE INFRA LLP IN COLLABORATION WITH GULMOHAR FINANCE LTD.



MMC
NANCY M. COLEMAN
Principal Consultant
MMC
NC DESIGN INTERNATIONAL
6-70, 2nd floor, Jiwang Plaza, Main Sanya Vival Road,
Orchid, New South - 110025
Tel : +91-11-26940754/50/7 Fax: +91-11-26940726
E-mail: mmc_consultants@hotmail.com

R.K. & ASSOCIATES
Architects, Engineers & Planners
E-31, GREEN PARK MAIN, NEW DELHI - 110046, INDIA
Tel.: 26 86 31 15 8, 26 51 47 51, 26 56 73 57
Fax: (011) 2656-2540 E-mail: rsa.architects@gmail.com

ARCHITECT'S SIGNATURE


OWNER'S SIGNATURE

FOR SYMBIONESE LIBERATION ARMY

Adolf F. Siskind

DRAWING TITLE (SUBMISSION DRAWING)	 	DRG. NO.
COMMERCIAL BLOCK 01		


	PLANS & COMMERCIAL BLOCK 02 PLANS / ELEVATION / SECTION	SCALE 1:250 @ A0	DATE - DEC 2024
	25		

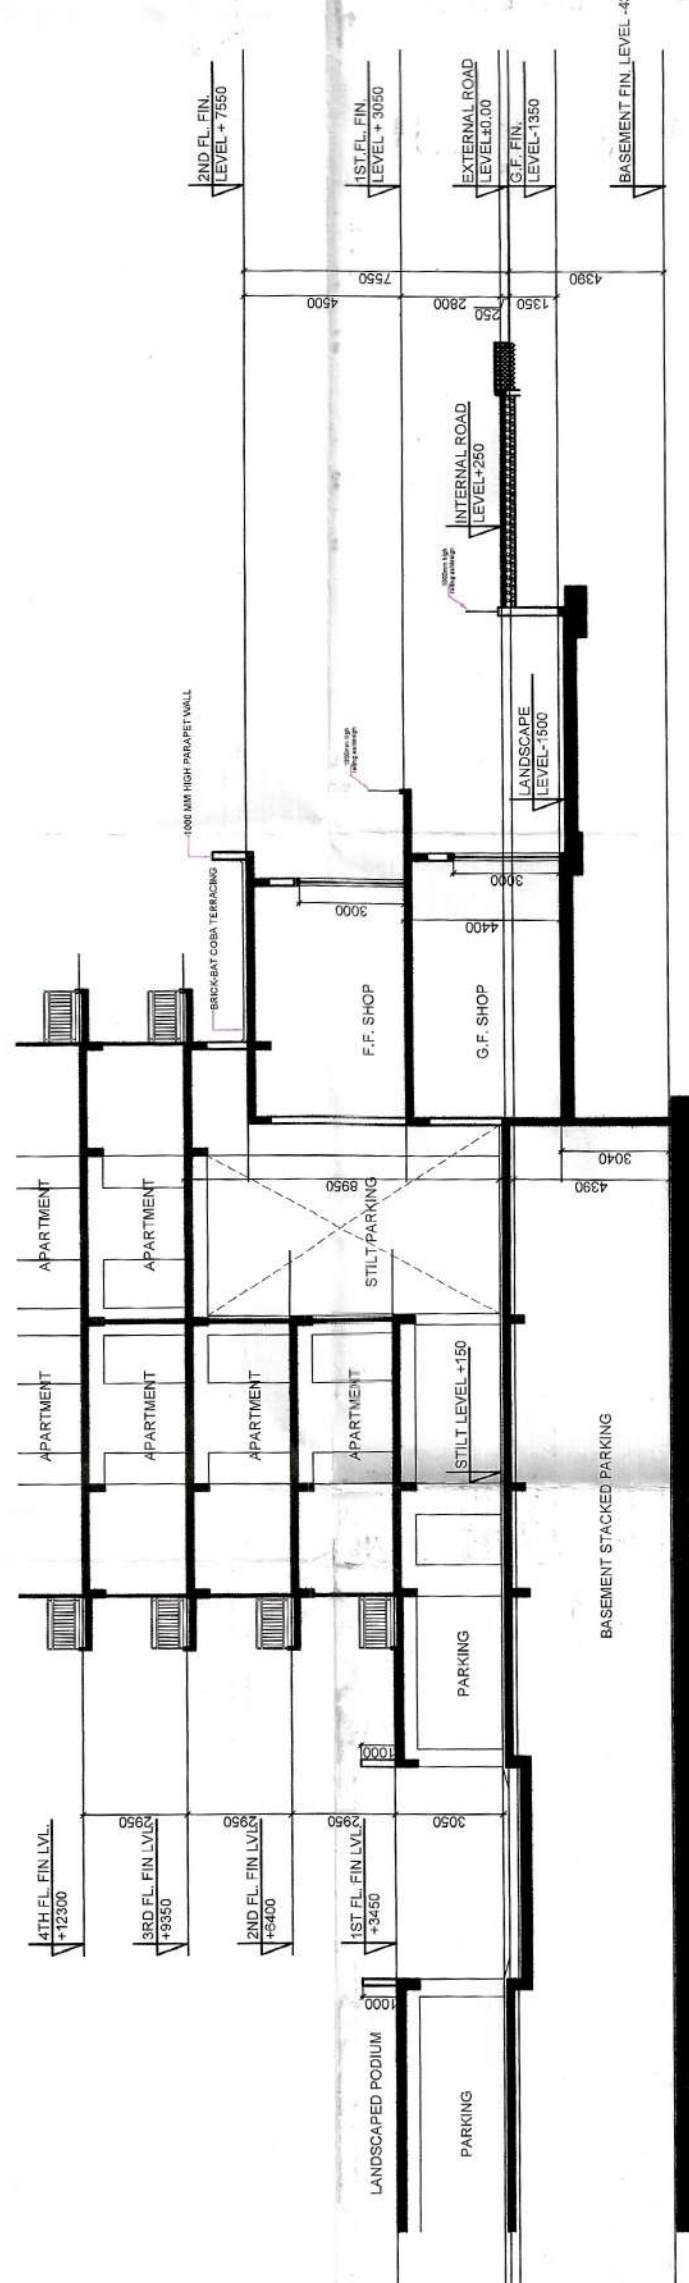


SECTION XX

PLUMBING LEGEND:-

①	1000 SOIL & VENT PIPE	1000 SOIL & VENT PIPE
②	1000 WASTE & VENT PIPE	1000 WASTE & VENT PIPE
③	750 ANTISIPHON PIPE	750 ANTISIPHON PIPE
④	COLD WATER SUPPLY DN175 (CWS)	COLD WATER SUPPLY DN175 (CWS)
⑤	FLUSH WATER SUPPLY DN175 (FWS)	FLUSH WATER SUPPLY DN175 (FWS)
⑥	COLD WATER RISER PIPE (CWR)	COLD WATER RISER PIPE (CWR)
⑦	FLUSH WATER RISER PIPE (FWR)	FLUSH WATER RISER PIPE (FWR)
⑧	110 OD UPVC RAIN WATER PIPE (FOR BALCONY)	110 OD UPVC RAIN WATER PIPE (FOR BALCONY)
⑨	110 OD UPVC RAIN WATER PIPE (FOR TERRACE)	110 OD UPVC RAIN WATER PIPE (FOR TERRACE)
⑩	FLOOR TRAP	FLOOR TRAP
⑪	FLOOR DRAIN	FLOOR DRAIN
⑫	URINAL TRAP	URINAL TRAP
⑬	CLEAN OUT PLUG	CLEAN OUT PLUG
⑭	PIPE DROP	PIPE DROP
⑮	BAAL VALVE	BAAL VALVE

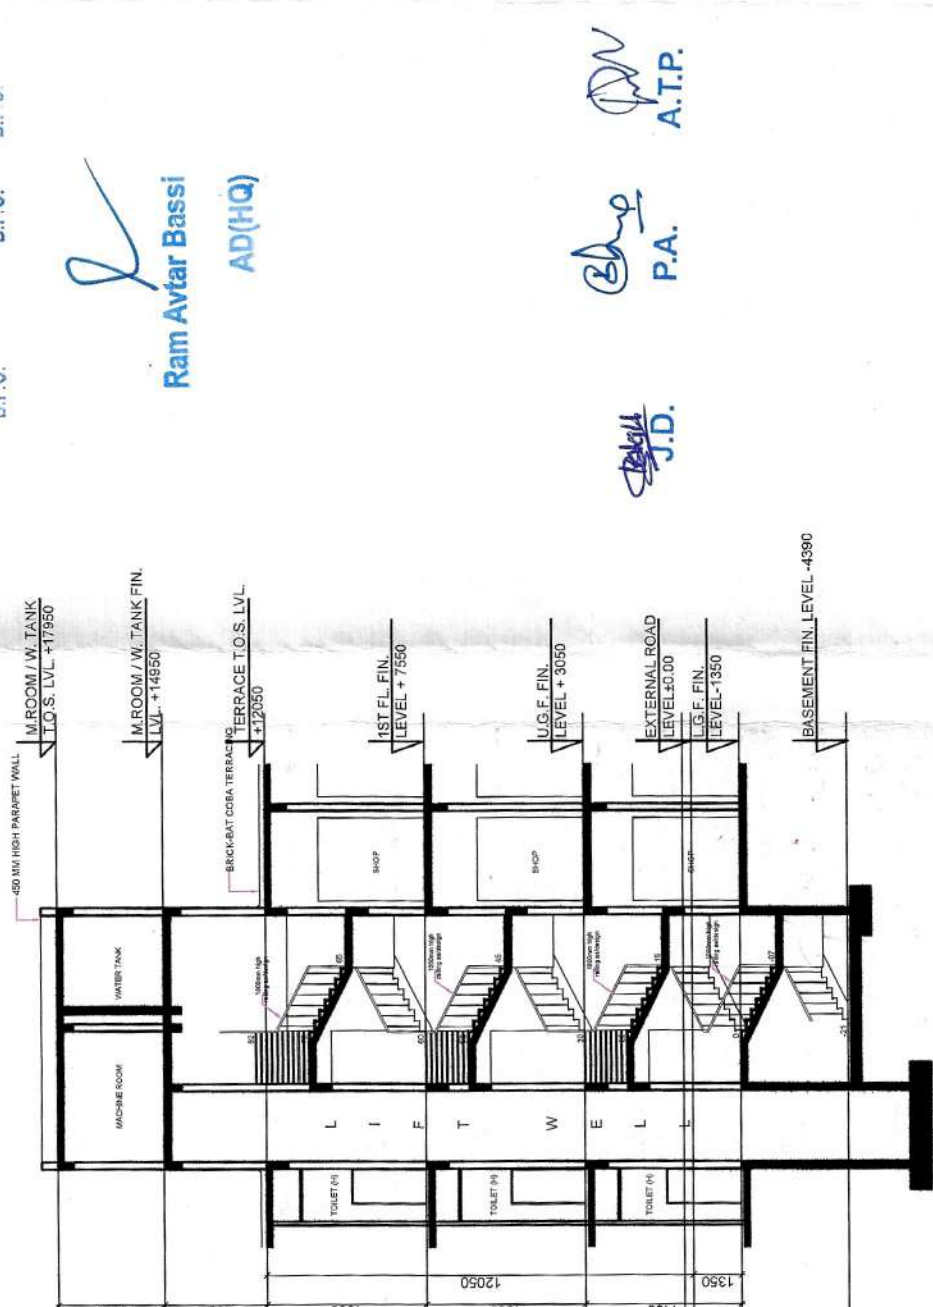


SECTION YY

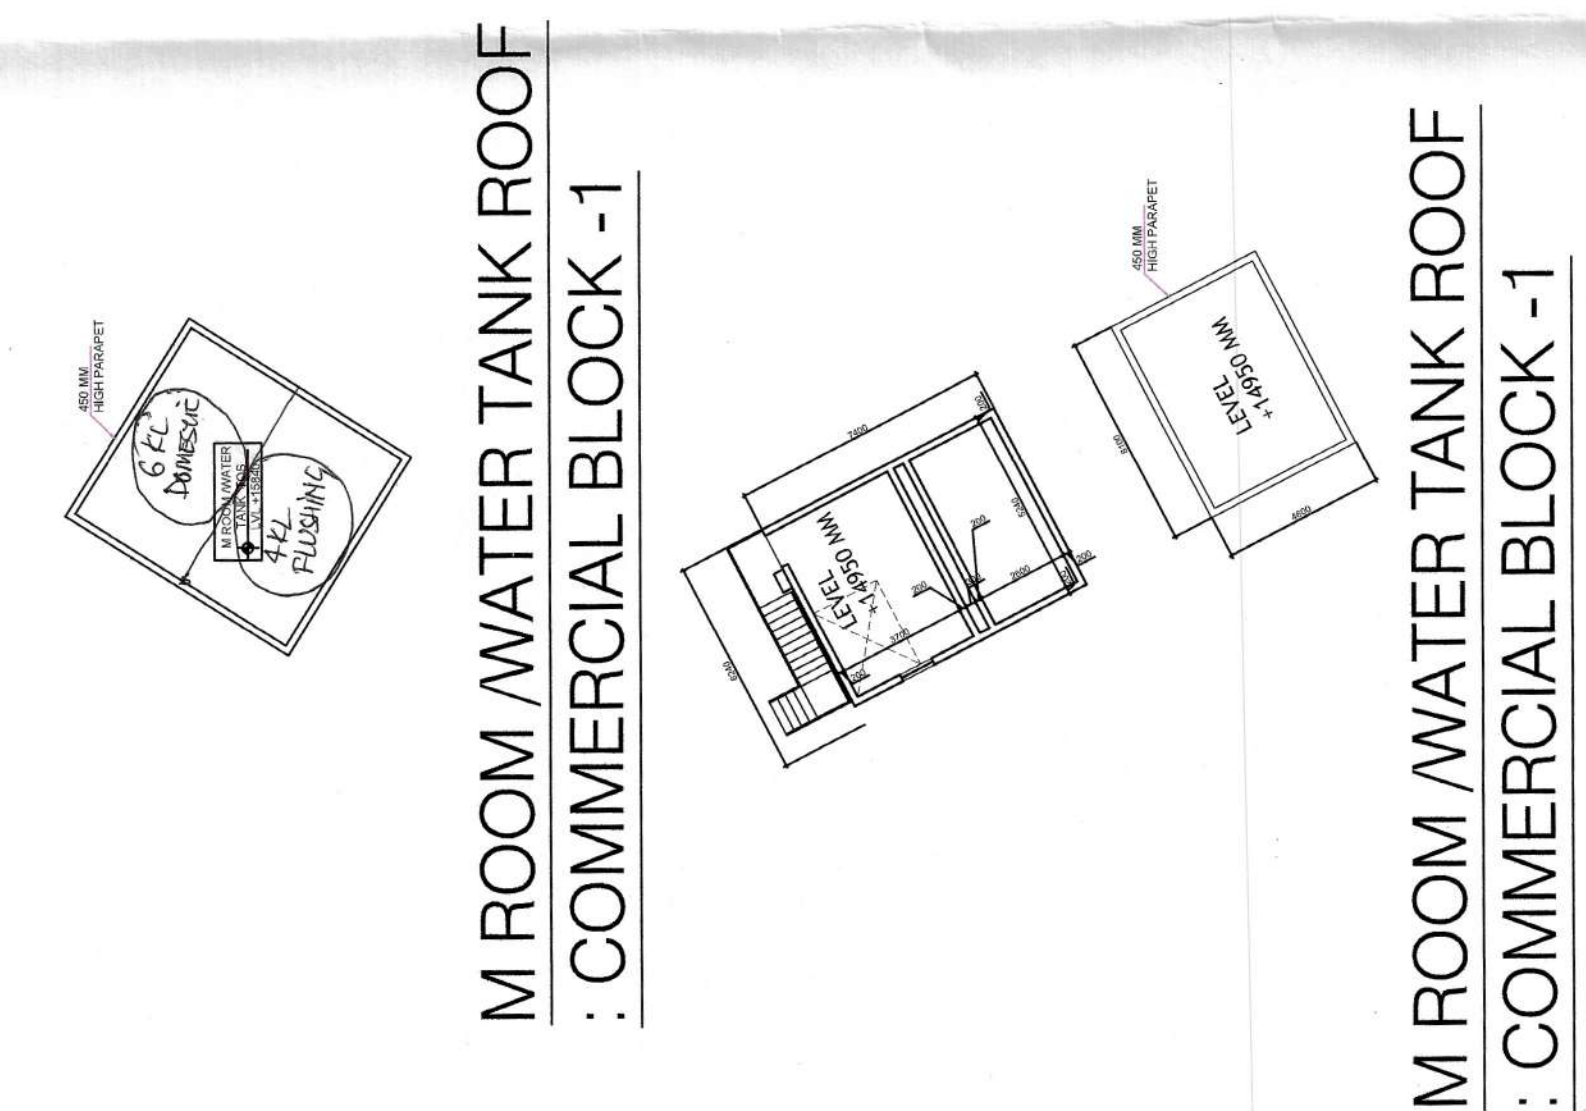


M ROOM /WATER TANK ROOF
: COMMERCIAL BLOCK -1



SECOND FLOOR PLAN : COMMERCIAL BLOCK -1

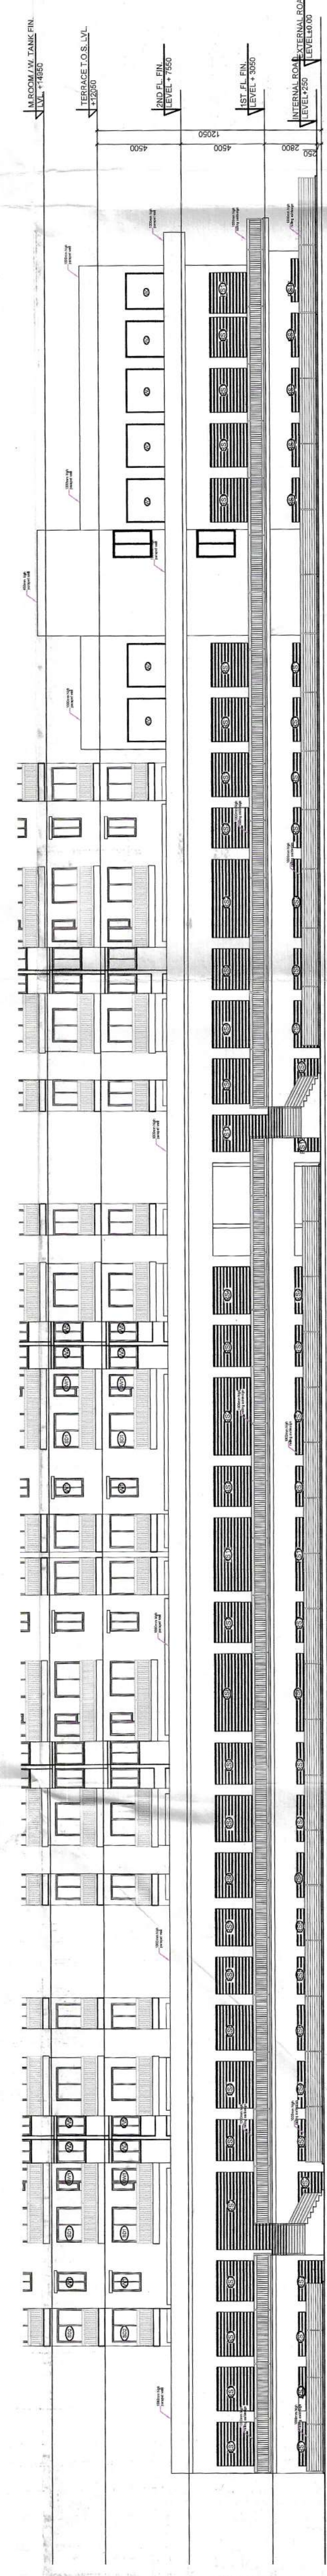

ELEVATION A

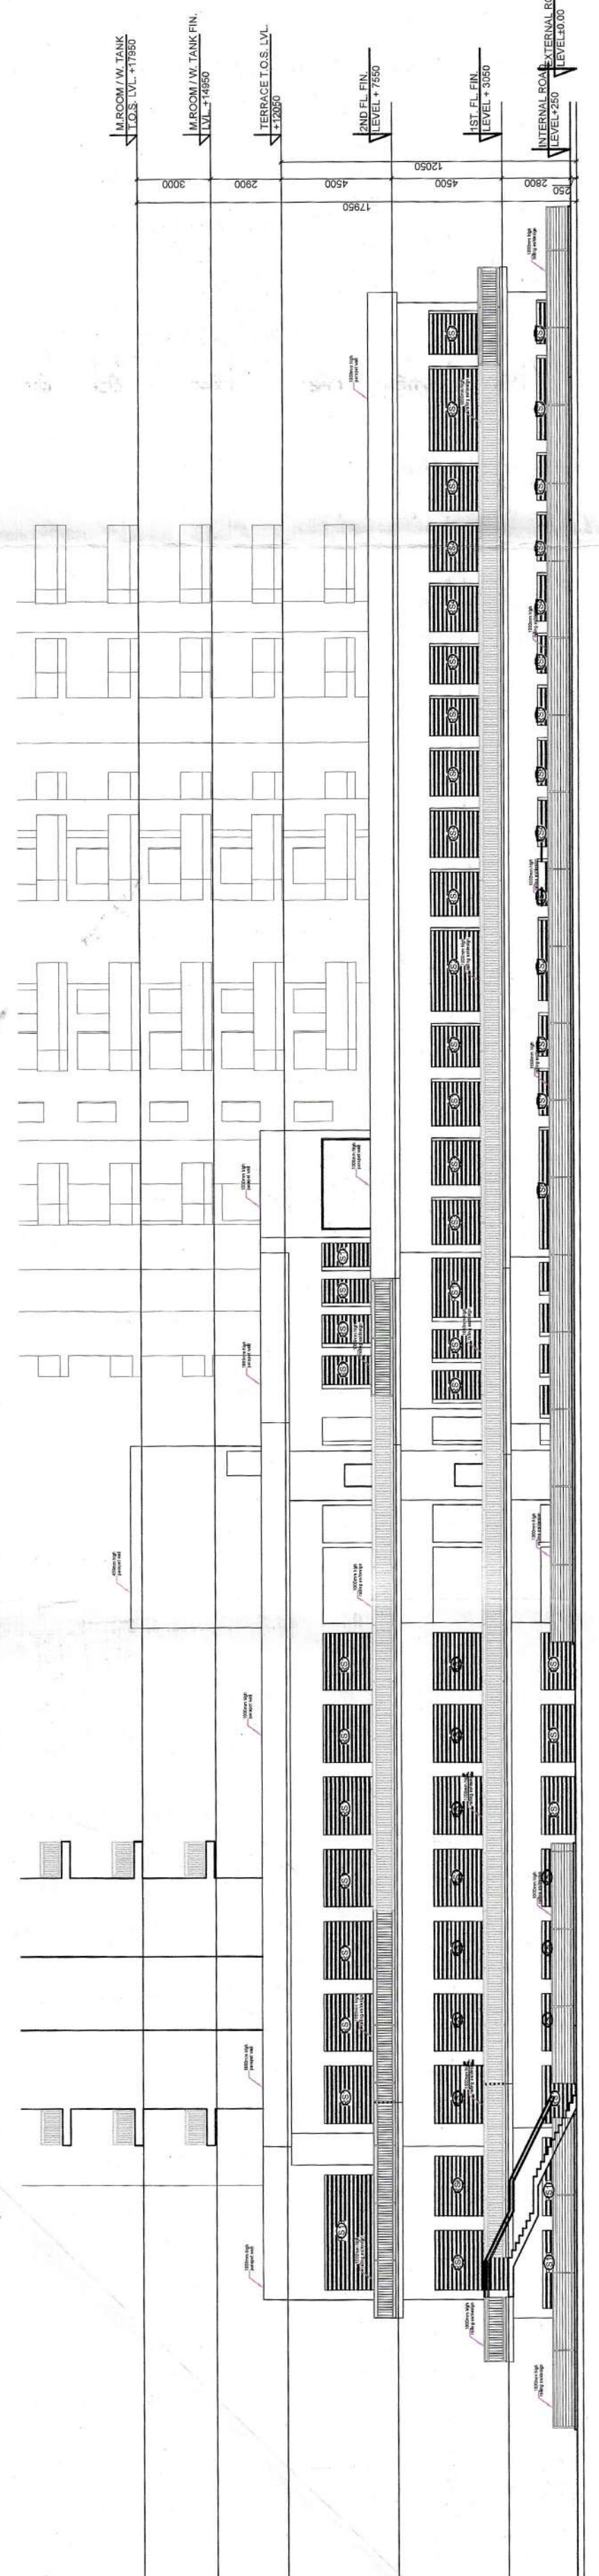

ELEVATION B