
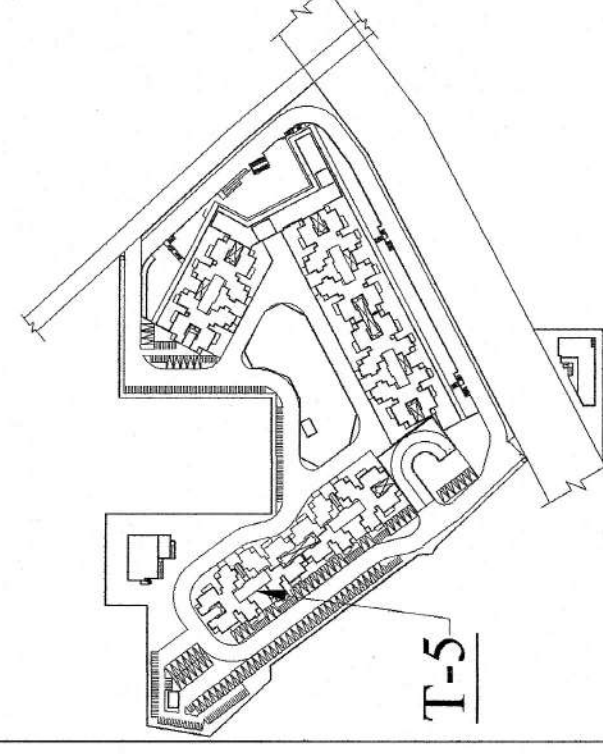
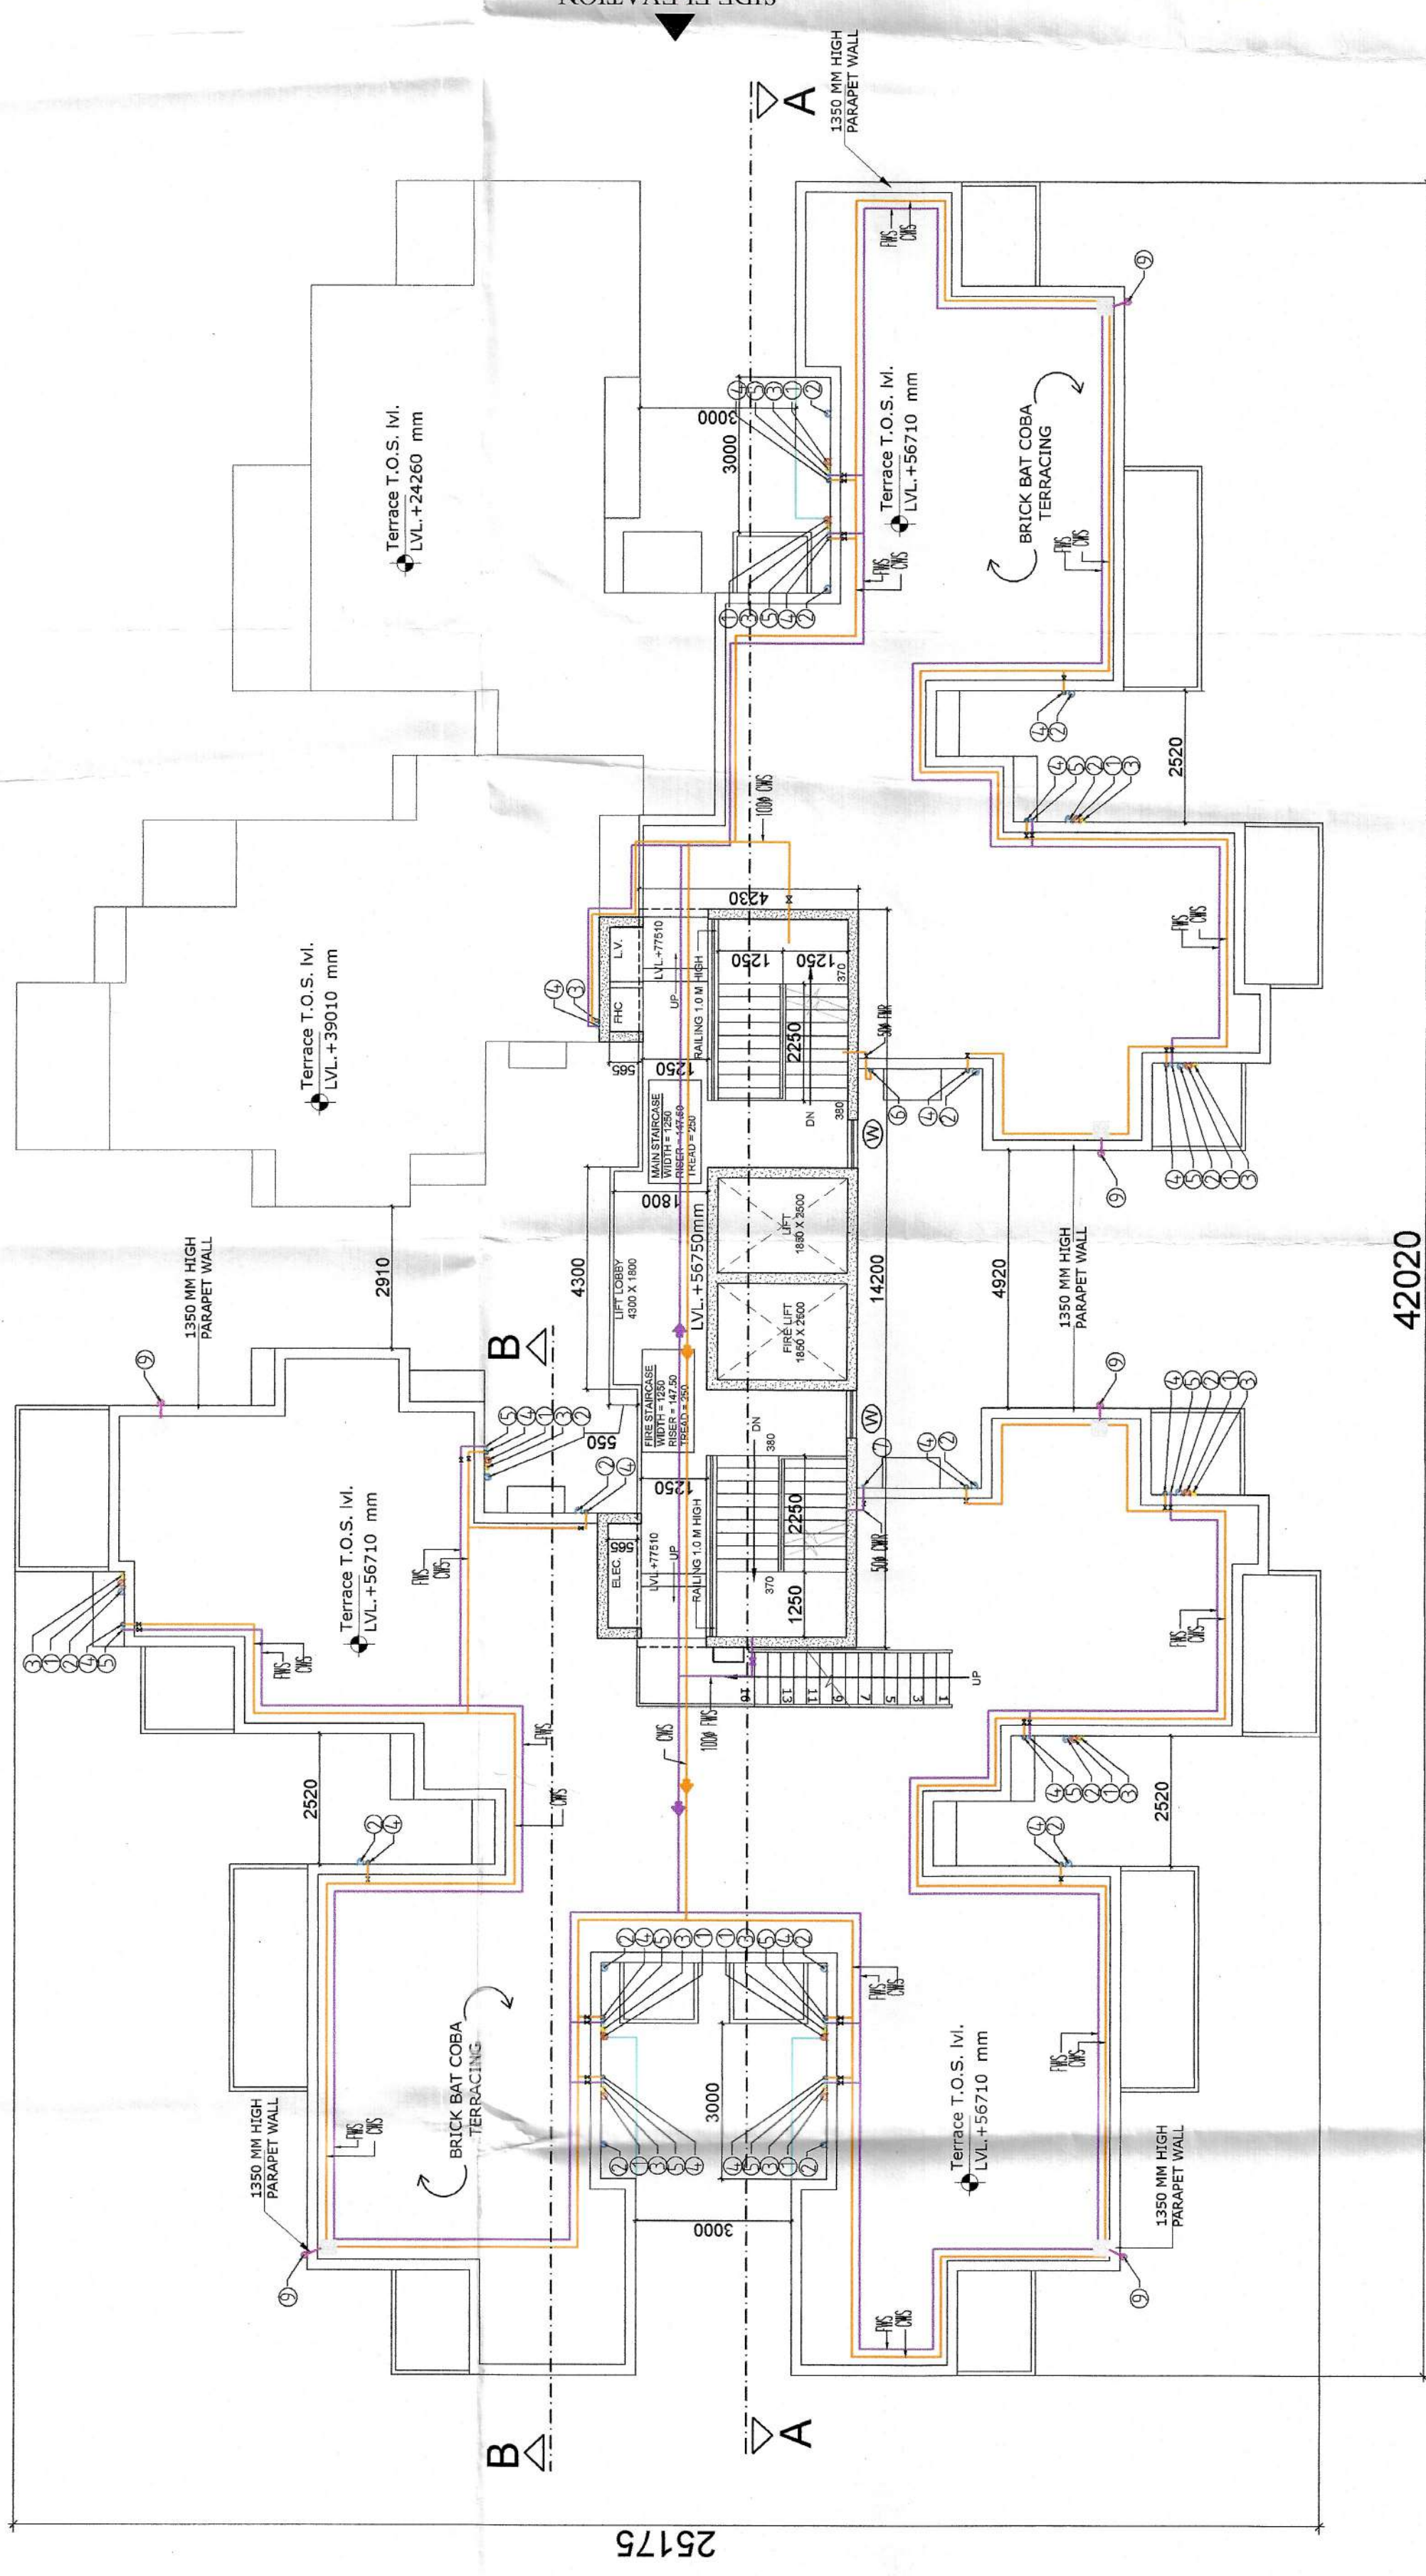
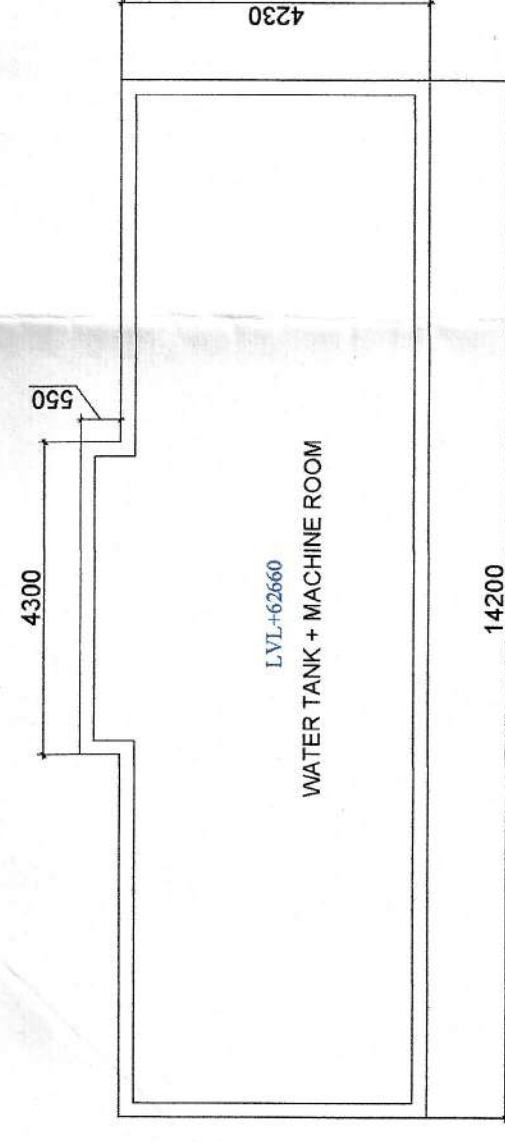
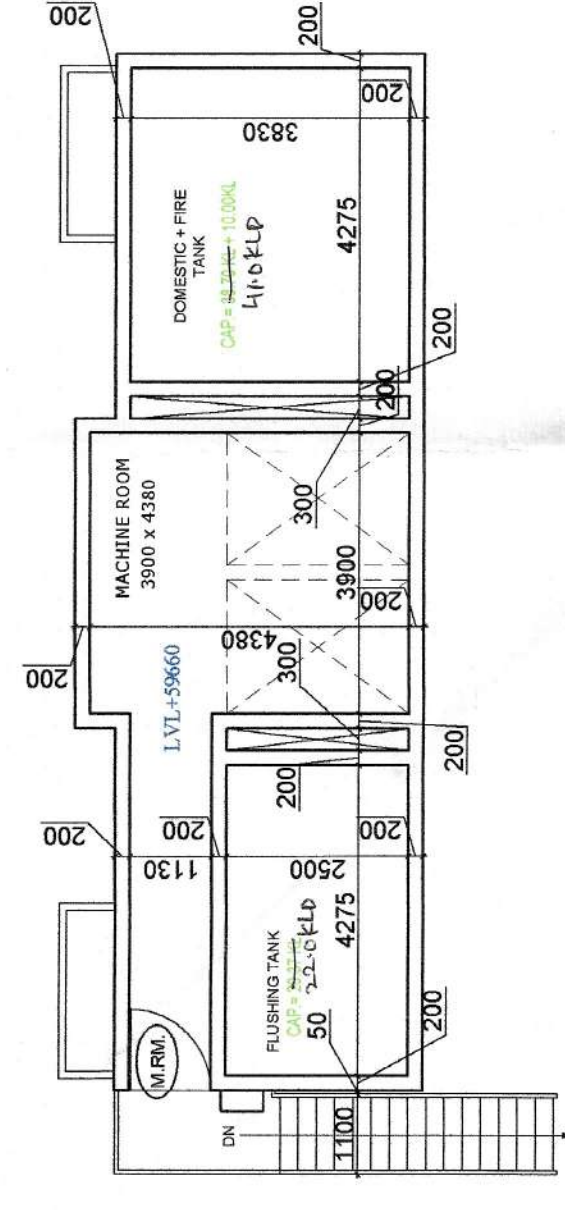


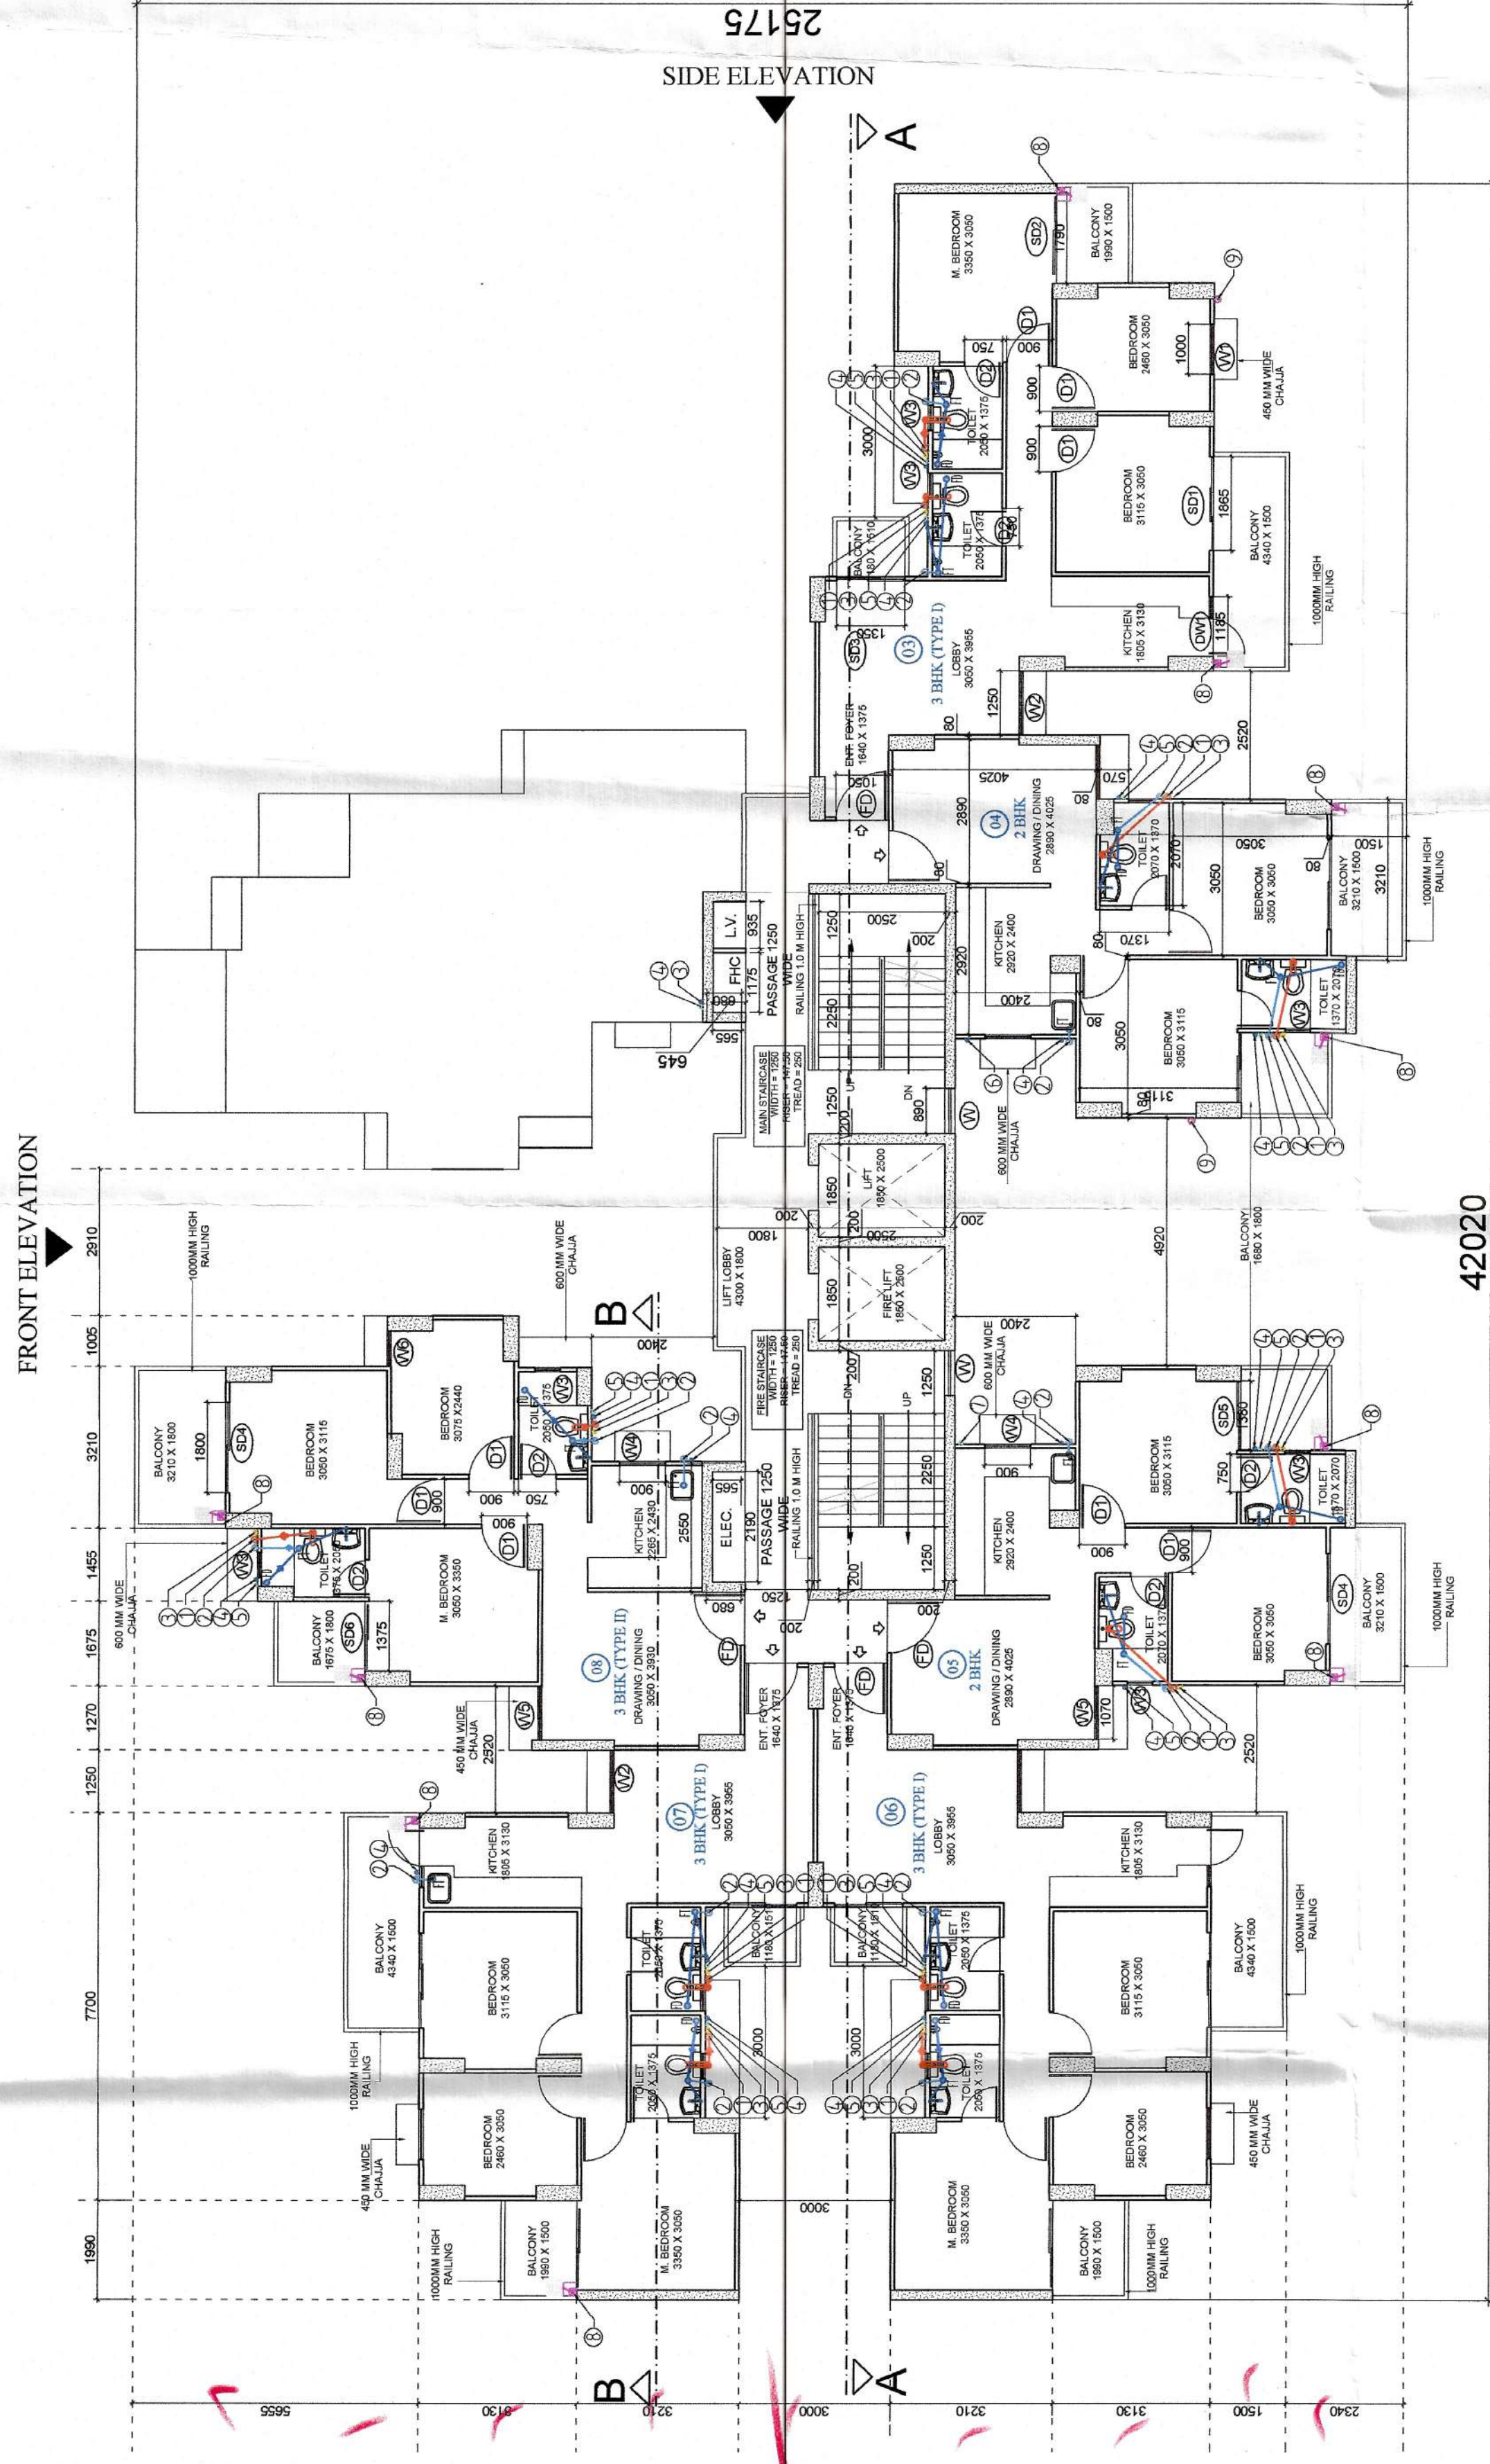

- NOTES:**
1. FD TO FT 500' WASTE PIPE
  2. WASH BASIN TO FT 320' WASTE PIPE
  3. WC TO VERTICAL 1000' SOIL PIPE
  4. FT TO VERTICAL 1000' WASTE PIPE
  5. UT TO VERTICAL 1000' SOIL PIPE
  6. URINAL TO UT 400' SOIL PIPE

| PLUMBING LEGEND: | SPRINK. SYMBOL | SYMBOL | DESCRIPTION                       |
|------------------|----------------|--------|-----------------------------------|
|                  | 1              |        | 100' S&L S&L VENT PIPE            |
|                  | 2              |        | 100' WASTE & VENT PIPE            |
|                  | 3              |        | 75' AIR INTAKE PIPE               |
|                  | 4              |        | COLD WATER SUPPLY (DWI)           |
|                  | 5              |        | COLD WATER SUPPLY (DWI) (FNS)     |
|                  | 6              |        | COLD WATER SUPPLY (DWI) (FNS)     |
|                  | 7              |        | FLUSH WATER RESEED PIPER          |
|                  | 8              |        | 10' COLD WATER PIPE (FOR BALCONY) |
|                  | 9              |        | 10' COLD WATER PIPE (FOR BSEAL)   |
|                  | 10             |        | FLOOR TRAP                        |
|                  | 11             |        | FLOOR DRAIN                       |
|                  | 12             |        | URINAL TRAP                       |
|                  | 13             |        | CLEAN OUT PLUG                    |
|                  | 14             |        | PIPE DROP                         |
|                  | 15             |        | BAUL VALVE                        |

[illegible]

Checked and found ok for Public Health  
(Internal) Service only subject to comments in  
in forwarding letter NO. 245E(HQ)  
1983  
Additional Chief Engineer (HQ)  
1/1

|                    |                                                                                           |
|--------------------|-------------------------------------------------------------------------------------------|
| SUBMISSION DRAWING | <p>CLIENT</p> <p>SPYERGHSHINE INFRA, LLP IN COLLABORATION WITH GULMCHHAR FINANCE LTD.</p> |
|--------------------|-------------------------------------------------------------------------------------------|

PROPOSED BUILDING PLANS OF AFFORDABLE GROUP HOUSING COLON ON LAND MEASURING 5.7975 ACRES (LICENSE NO. 43 OF 2021) IN THE REVENUE ESTATE OF VILLAGE ULLAWAS SECTOR 62, DIST. GURUGRAM - MANESAR URBAN COMPLEX BEING DEVELOPED BY SYNERGYSHINE INFRA LLP IN COLLABORATION WITH GULMOHAR FINANCE LTD.

[illegible]

**R.K. & ASSOCIATES**  
**Architects, Engineers & Planners**  
 E-31, GREEN PARK MAIN, NEW DELHI - 110016, INDIA  
 Tel.: 2686-3115, 2651-8751, 2656-7557  
 Fax: (91) 2686-2940 E-mail: [rk.architect@gmail.com](mailto:rk.architect@gmail.com)

|                                   |                       |          |           |
|-----------------------------------|-----------------------|----------|-----------|
| ADP-1<br>10/11/2006<br>10/11/2006 | Partner<br>10/11/2006 | DRG. NO. | TOWER T-5 |
|-----------------------------------|-----------------------|----------|-----------|

|                   |                 |
|-------------------|-----------------|
| SCALE - 1:100 @A0 | DATE - DEC 2021 |
|-------------------|-----------------|