


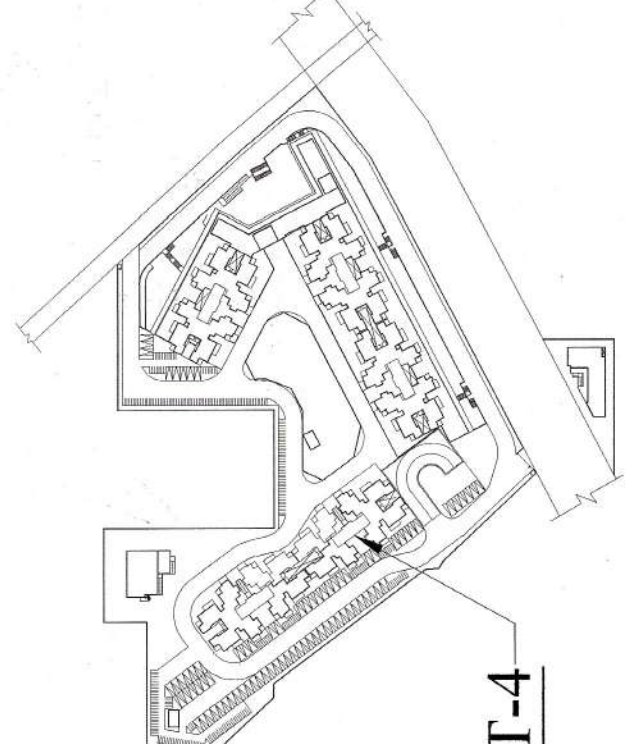

KEY PLAN

- NOTES:
1. FD TO FT 500 WASTE PIPE
 2. WASH BASIN TO FT 500 WASTE PIPE
 3. WC TO VERTICAL 1000 SOIL PIPE
 4. FT TO VERTICAL 1000 WASTE PIPE
 5. UT TO VERTICAL 1000 SOIL PIPE
 6. URINAL TO UT 400 SOIL PIPE

PLUMBING LEGEND:

SYMBOL	DESCRIPTION
1	1000 SOIL & VENT PIPE
2	1000 WASTE & VENT PIPE
3	750 ANTISIPHON PIPE
4	COLD WATER SUPPLY (DWK) (CWS)
5	FLUSH WATER SUPPLY (DWK) (FWS)
6	COLD WATER RISER PIPE (CWR)
7	FLUSH WATER RISER PIPE (FWR)
8	110 (D) PC SAN WATER PIPE (FOR BALCONY)
9	110 (D) PC SAN WATER PIPE (FOR TERRACE)
10	FI FLOOR DRAIN
11	UT URINAL TRAP
12	COP CLEAN OUT PLUG
13	PPE DROP
14	BAL VALVE

DOOR WINDOW SCHEDULE FOR TOWER 2 & 3

TYPE	SIZE	UNIT	DESCRIPTION
1	1000x2000	1	GLASS DOOR
2	1000x2000	1	GLASS DOOR
3	1000x2000	1	GLASS DOOR
100	1000x2000	1	GLASS DOOR

SUBMISSION DRAWING

CLIENT: PHARMACEUTICALS LTD.

PROJECT TITLE: PHARMACEUTICALS LTD. PHARMACEUTICALS LTD. PHARMACEUTICALS LTD.

DESIGNED BY: PHARMACEUTICALS LTD. PHARMACEUTICALS LTD. PHARMACEUTICALS LTD.

CHECKED BY: PHARMACEUTICALS LTD. PHARMACEUTICALS LTD. PHARMACEUTICALS LTD.

DATE: 10/10/2020

SCALE: 1:100 @ A0


DATE: DEC 2021

17


2 & 3 BHK UNIT (G-7/1418)

SCALE - 1:100 @ A0


DATE - DEC 2021

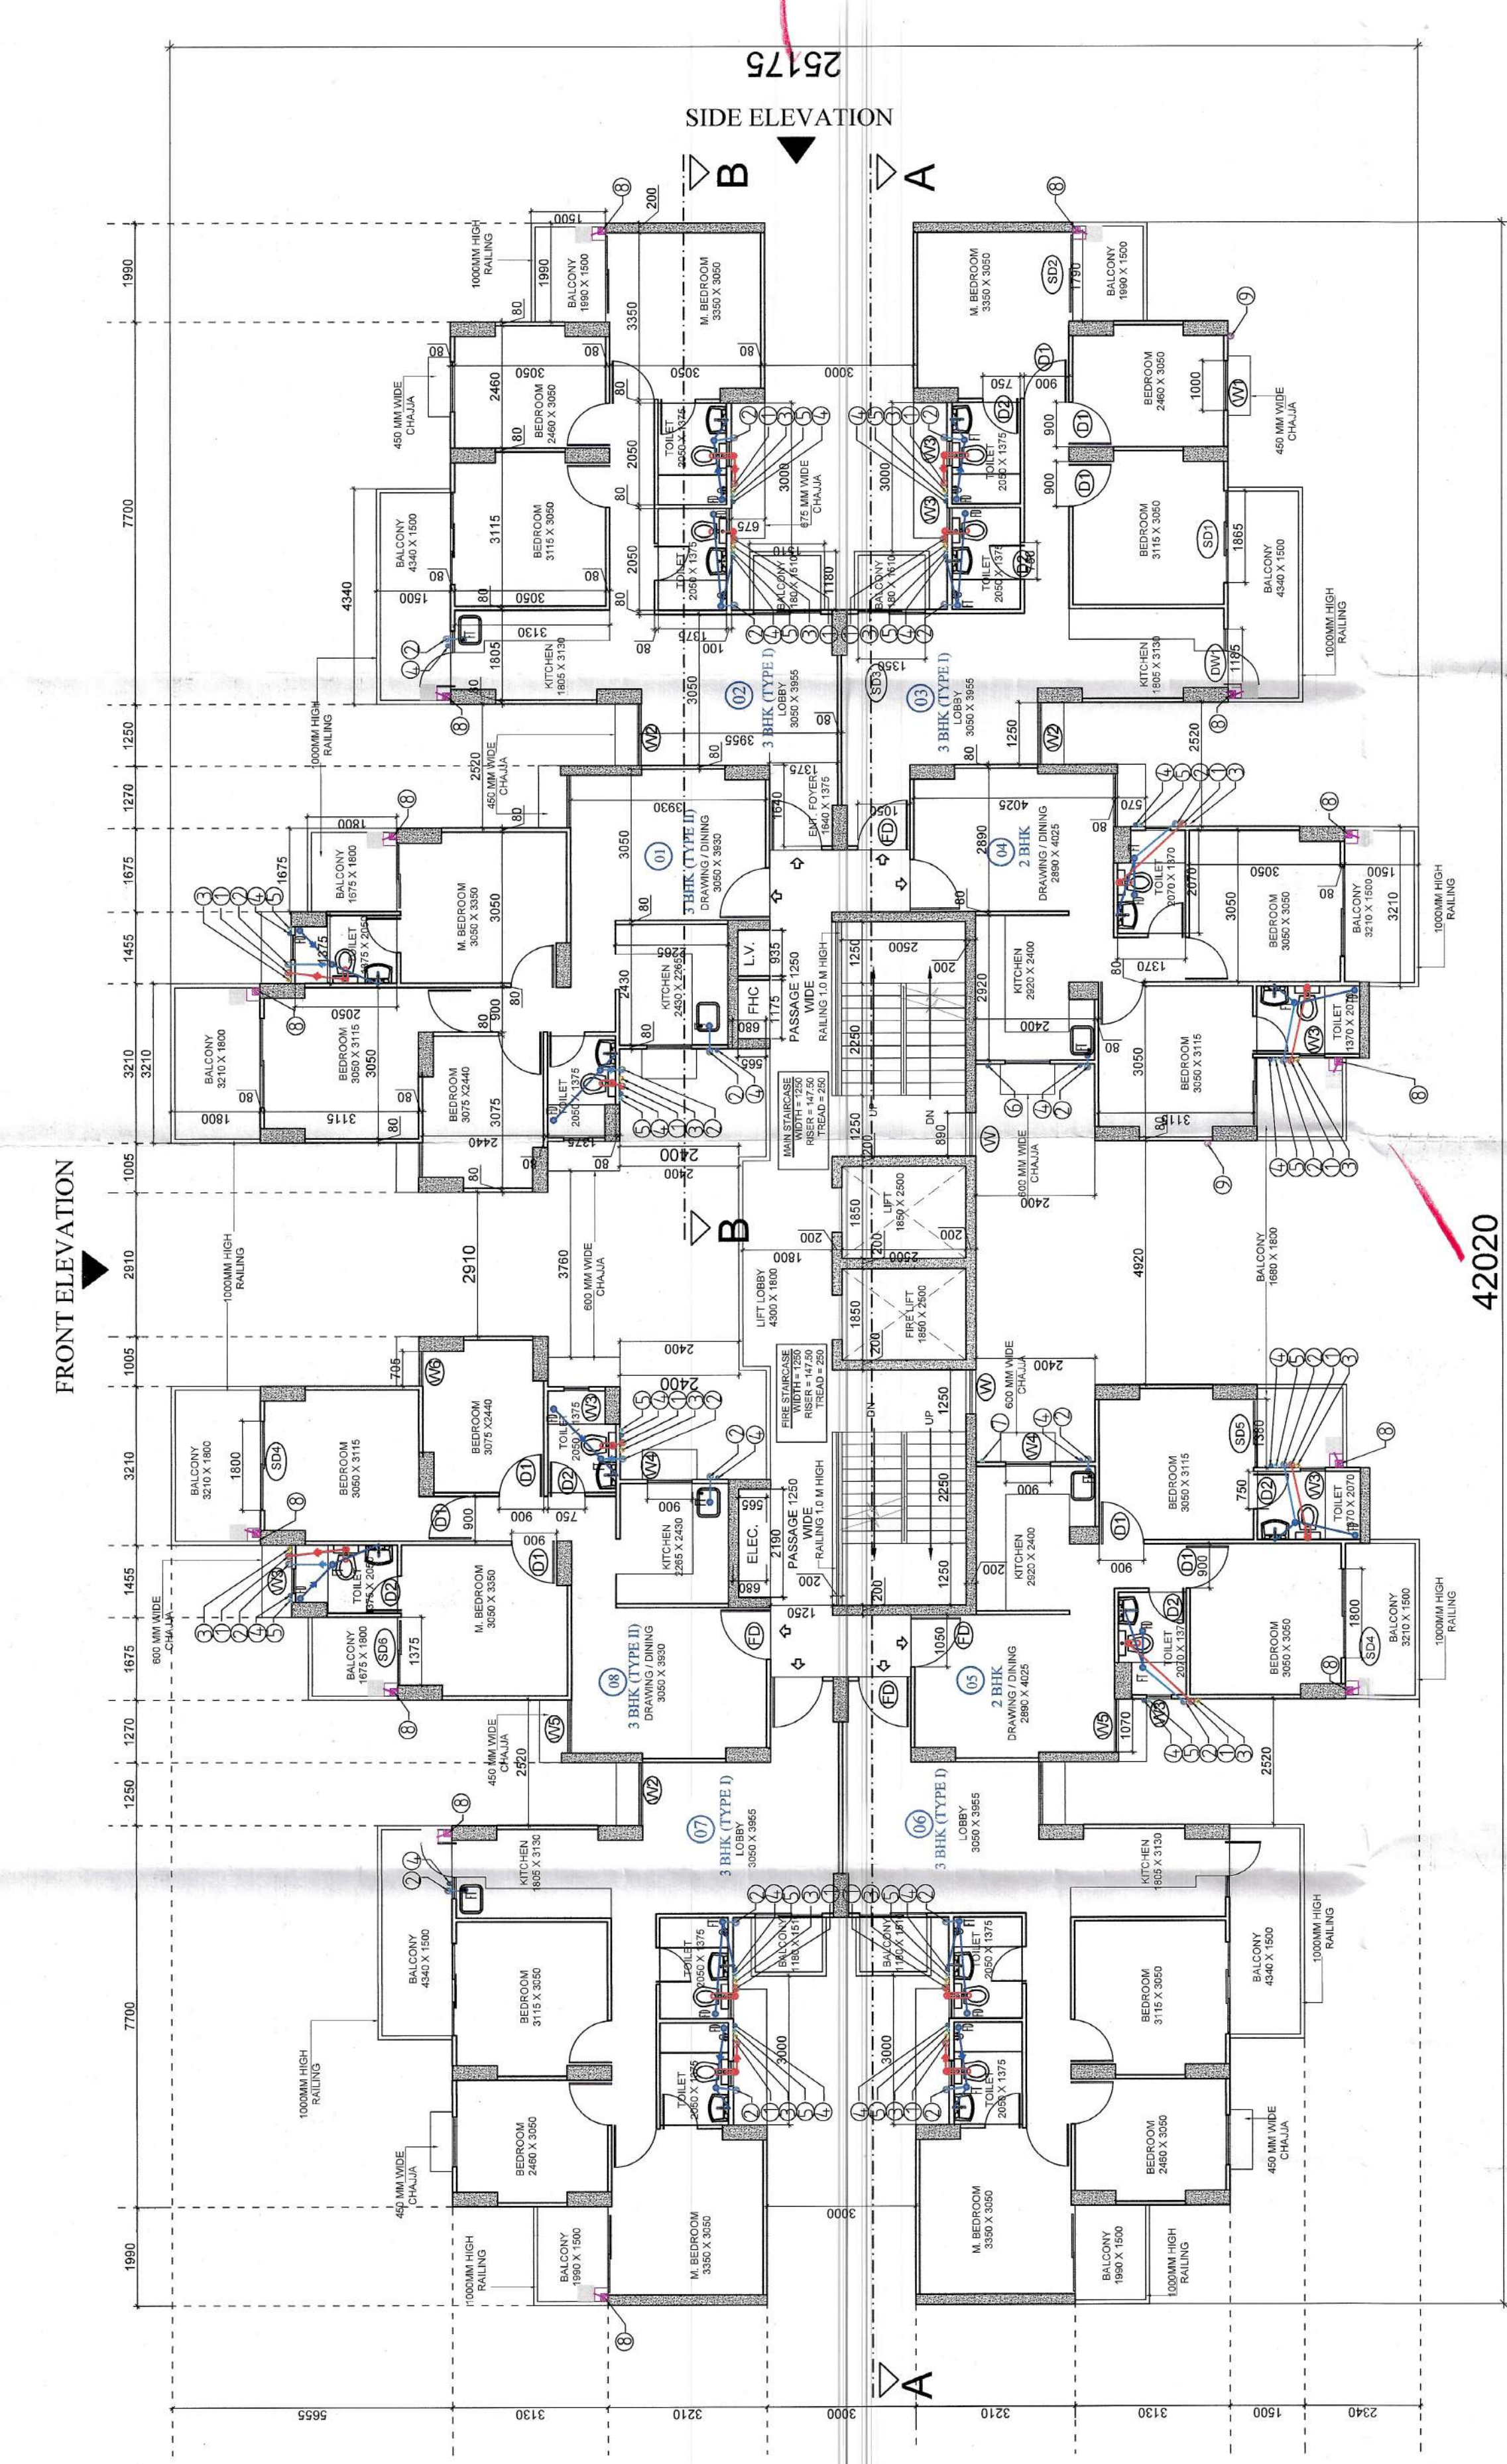


TYPICAL FLOOR PLAN (1st TO 7th FLOOR)

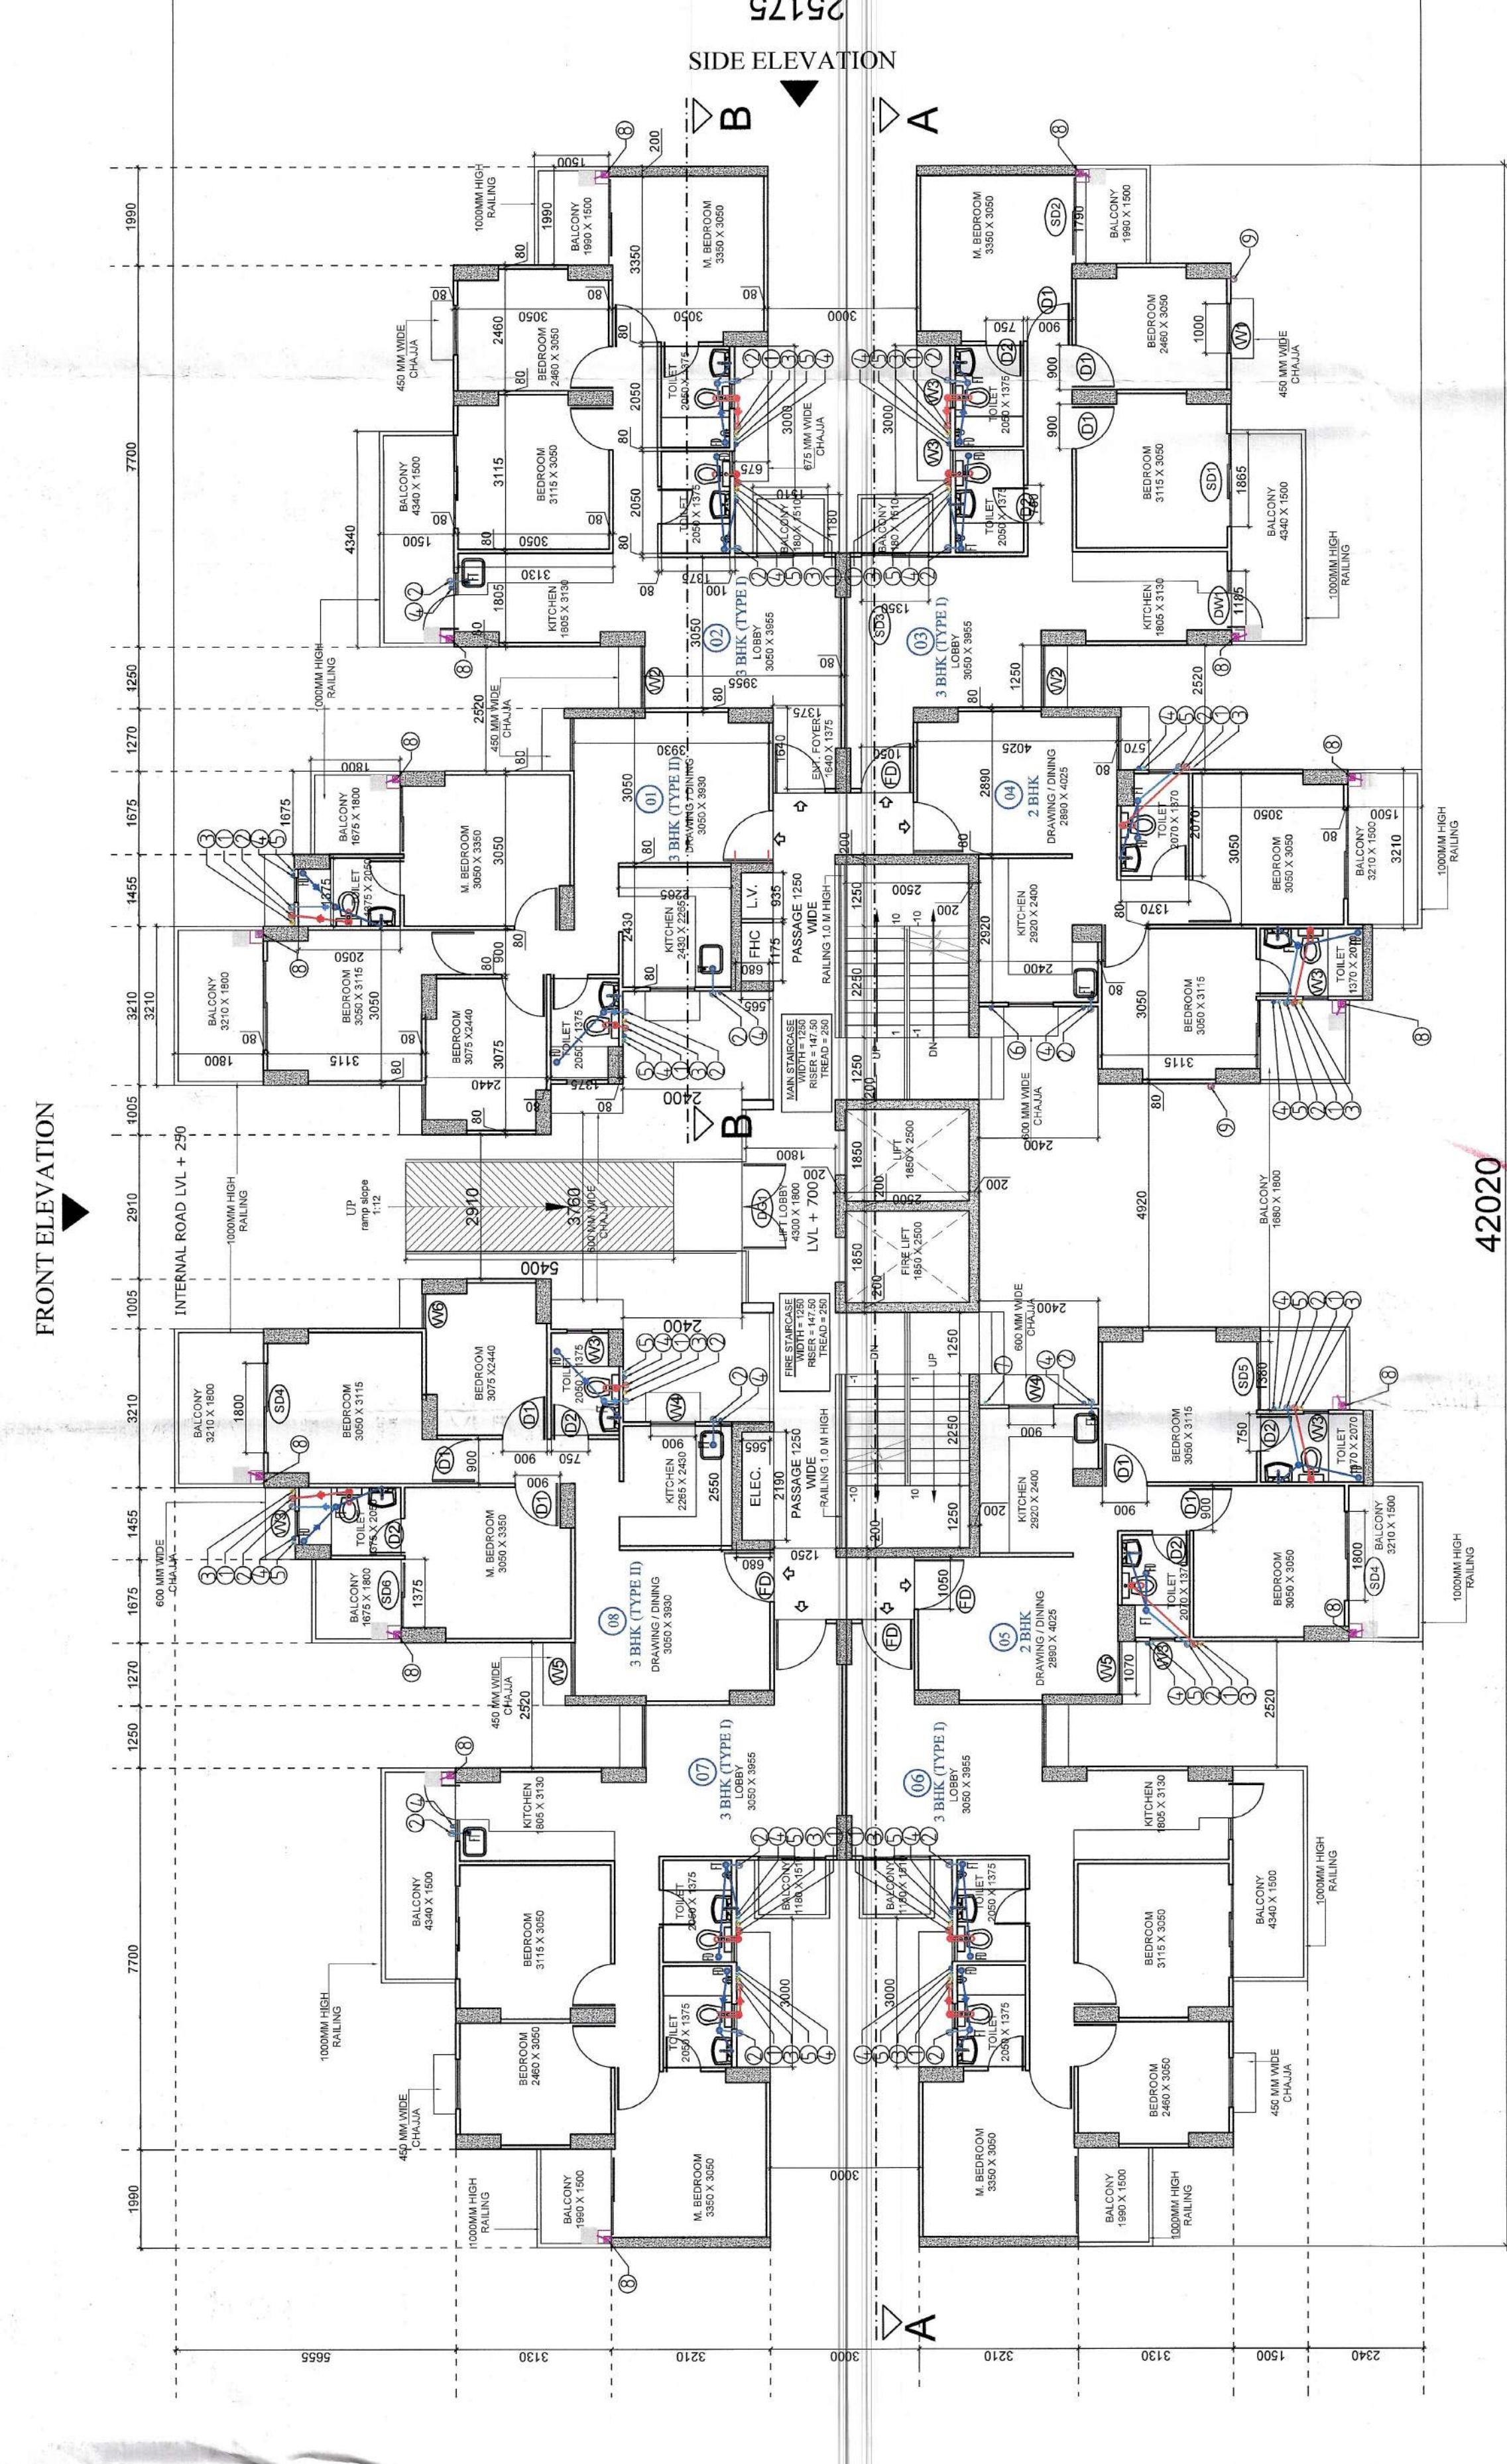

GROUND FLOOR PLAN

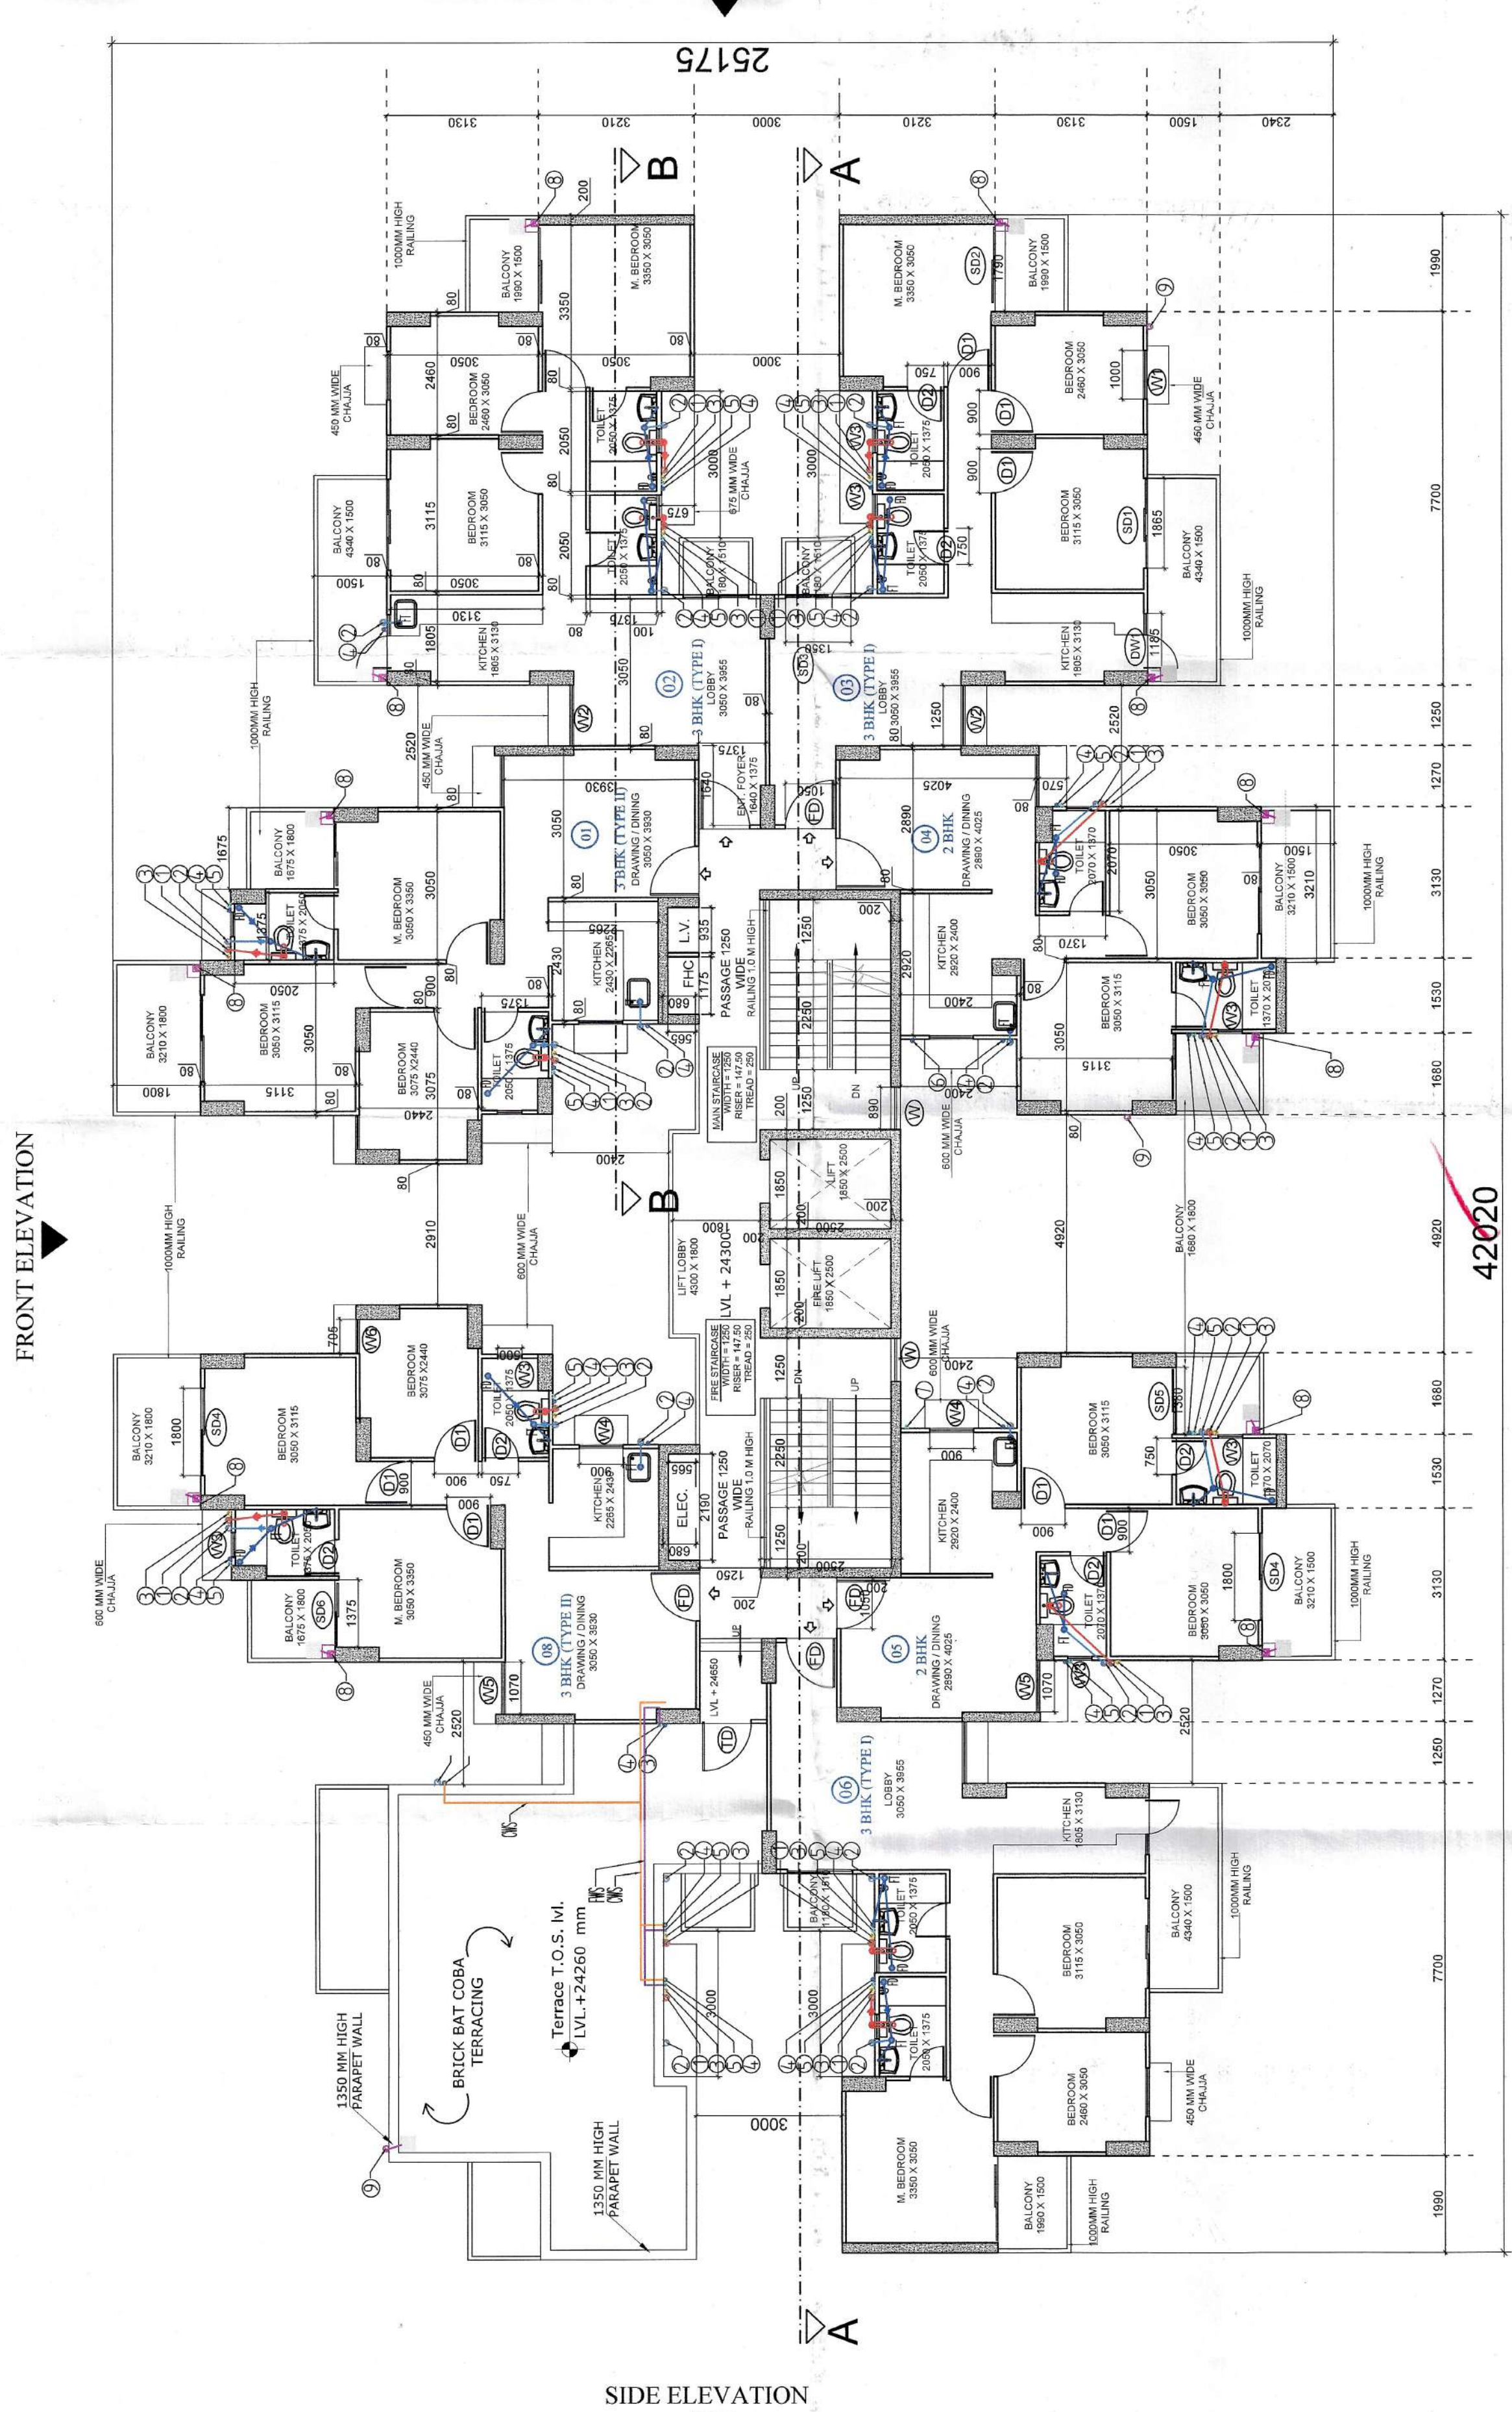

8th FLOOR PLAN

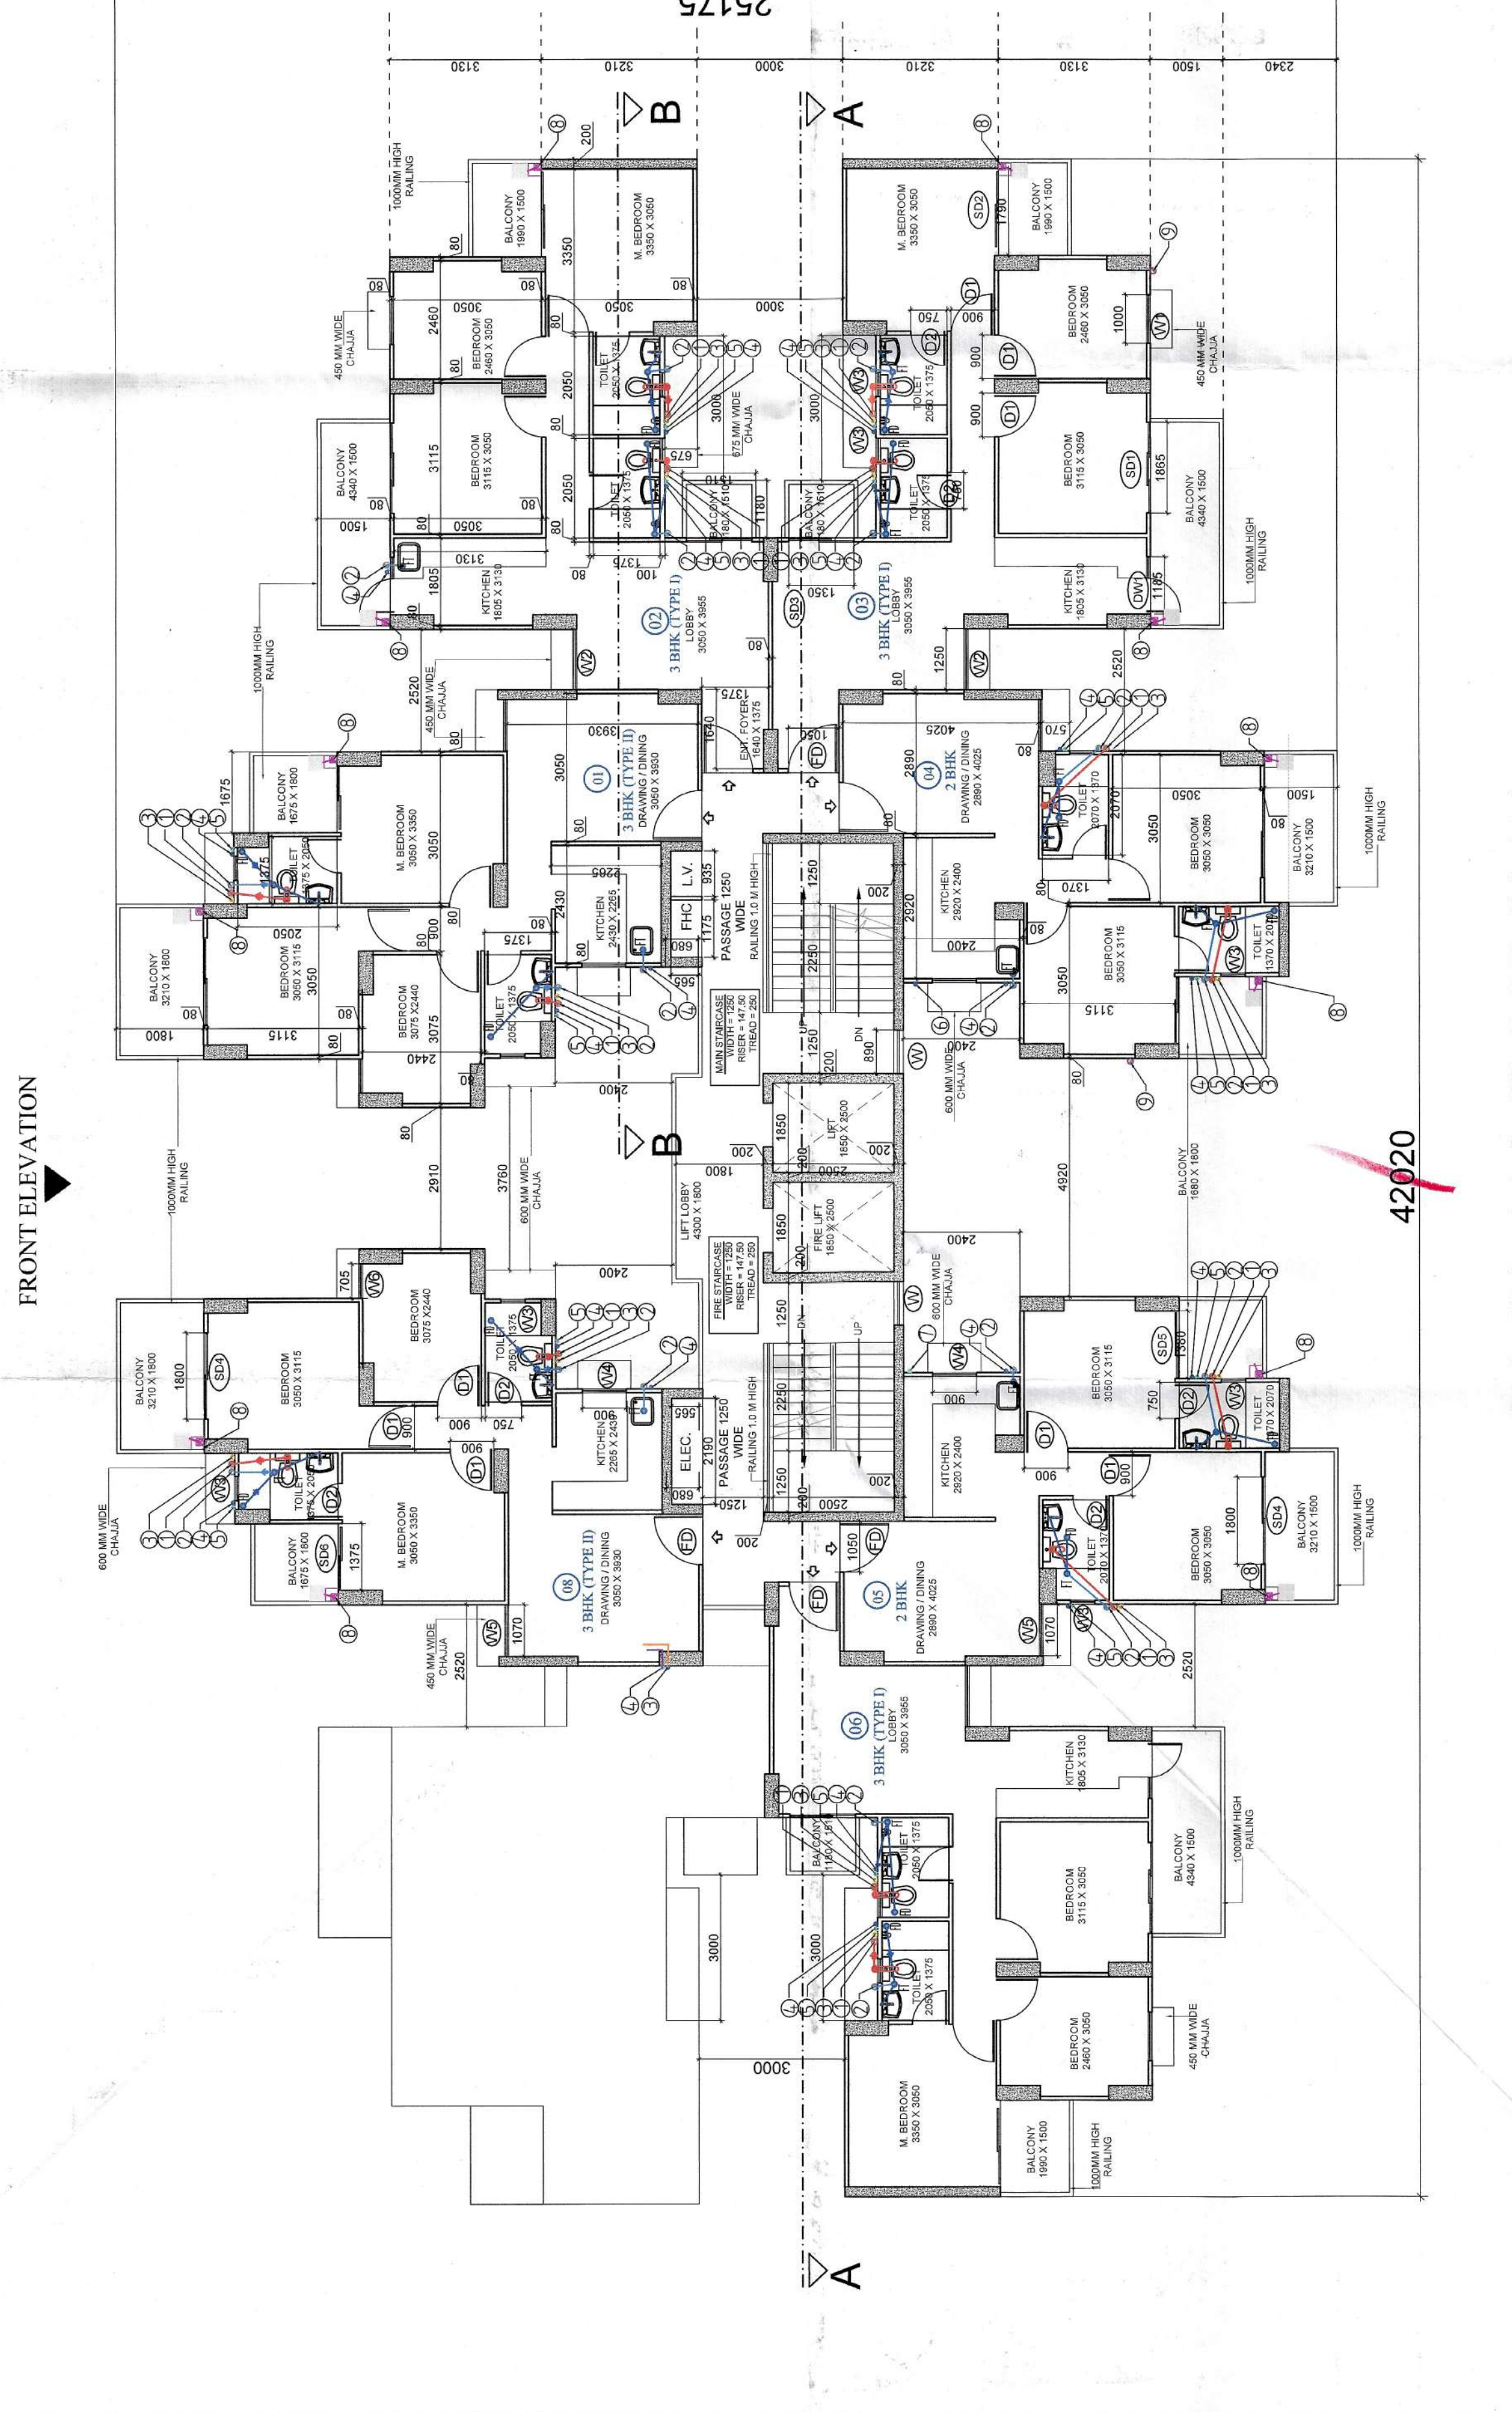

9th TO 14th FLOOR PLAN