


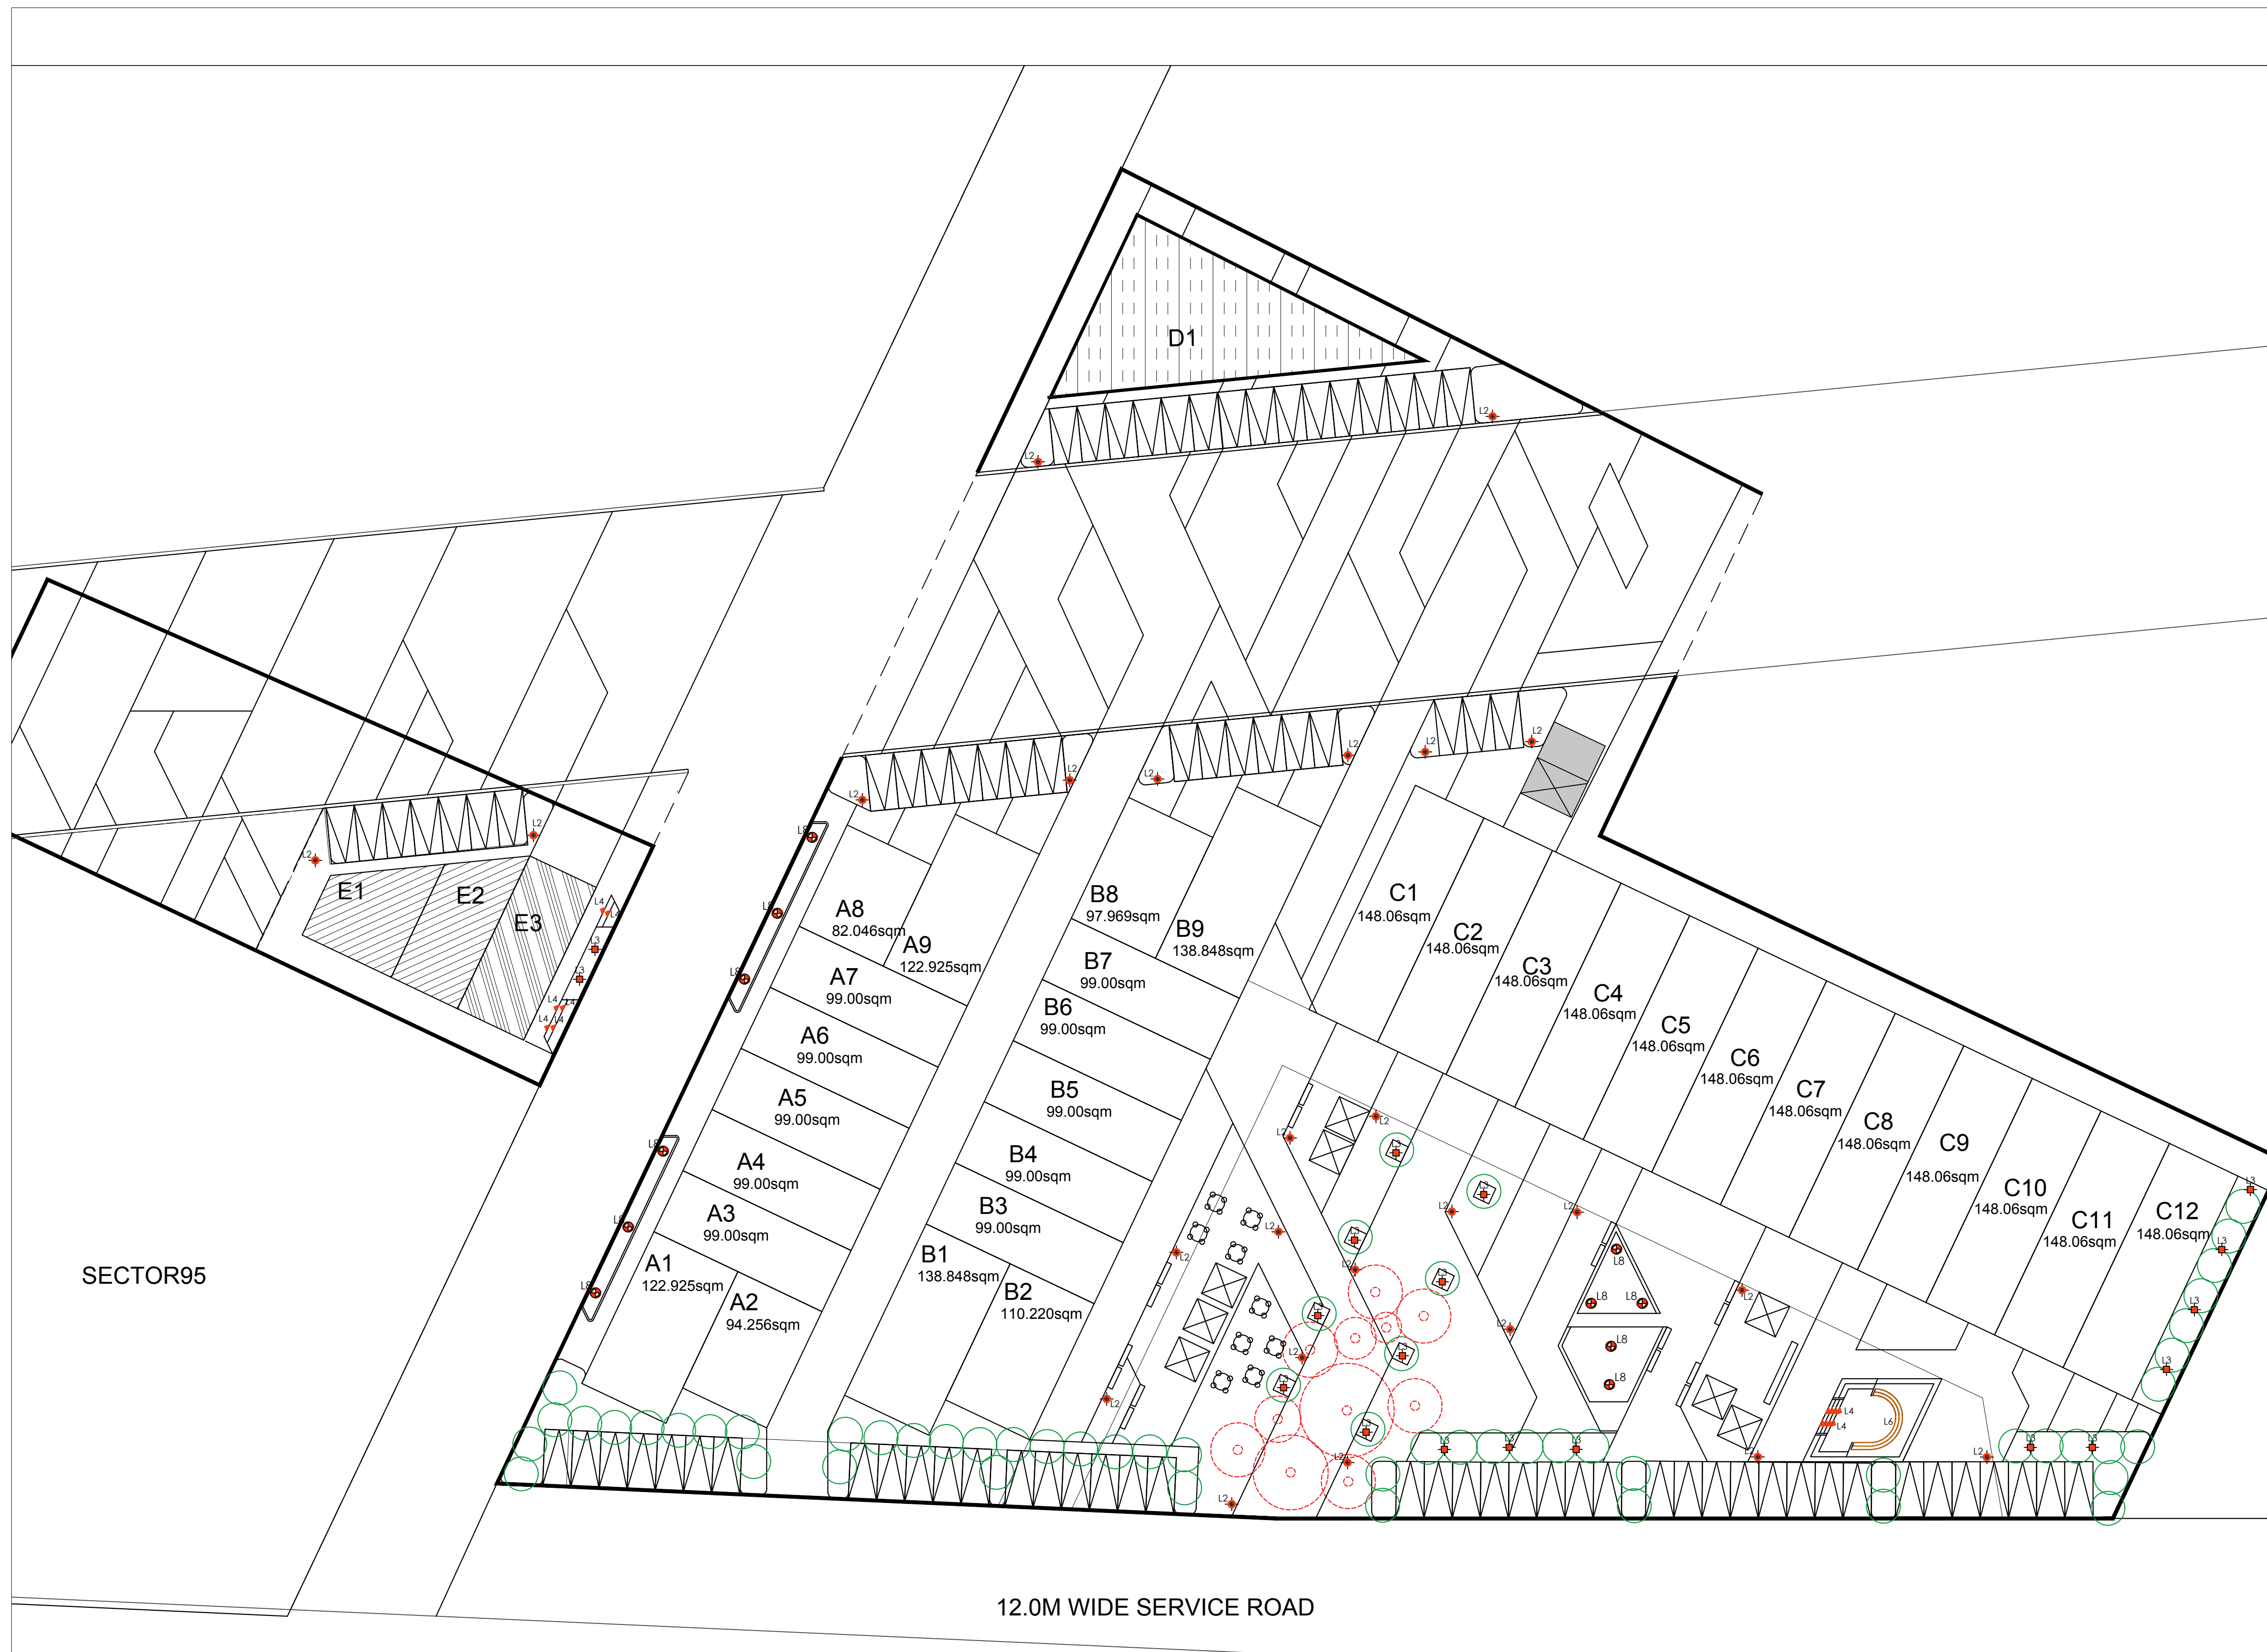

SECTOR95

12.0M WIDE SERVICE ROAD

EXISTING 60.0M WIDE SECTOR DIVIDING ROAD

LEGEND FOR LIGHTS				
SYMBOL	TYPE	MAKE	MODEL NO.	WATT.
	L1 POST TOP LIGHT	PHILIPS	Helios LED BPS900 pedestrian	35W
	L3 UPLIGHTERS-SPIKE MOUNTED	PHILIPS	GARDEN SPIKE	12W
	L4 STEP LIGHT	PHILIPS	STEPLIGHT 34151	2W
	L6 LED STRIP LIGHT	PHILIPS	AS PER SPPROVED SAMPLE	3 WATT PER METRE
	L8 UNDERWATER FLOOR LIGHTS	ARTLIGHT	LEDS C4	

PRINCIPAL ARCHITECT:

ACPL

ISO 9001:2015

Architecture
Management
Planning

ACPL Design Ltd

www.acplonline.com

E-24 South Extension -1
New Delhi 110049, India

E: contact@acplonline.com

T: +91 11 24622195

+91 11 24646709


F: +91 11 24634069

CLIENT:-

GLS INFRAPROJECTS PVT. LTD.

PROJECT:-

DEMARICATION PLAN OF PLOTTED COMMERCIAL COLONY DEVELOPED UNDER LICENCE NO. 103 OF 2021 DATED 08.12.2021 ON AN AREA MEASURING 2.95625 ACRES IN THE REVENUE ESTATE OF VILLAGE DHORKA, SECTOR-95, DISTT. GURUGRAM - GLS INFRAPROJECTS PVT. LTD.

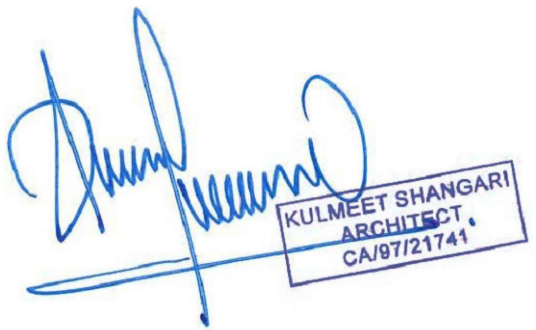
KULMEET SHANGANI
ARCHITECT
CA/87/21741

OWNER/AUTH. SIGNATURE

ARCHITECT'S SIGNATURE

DRAWING TITLE

LIGHTING PLAN

DRAWING NO.

A-4

SCALE :

1 : 300