


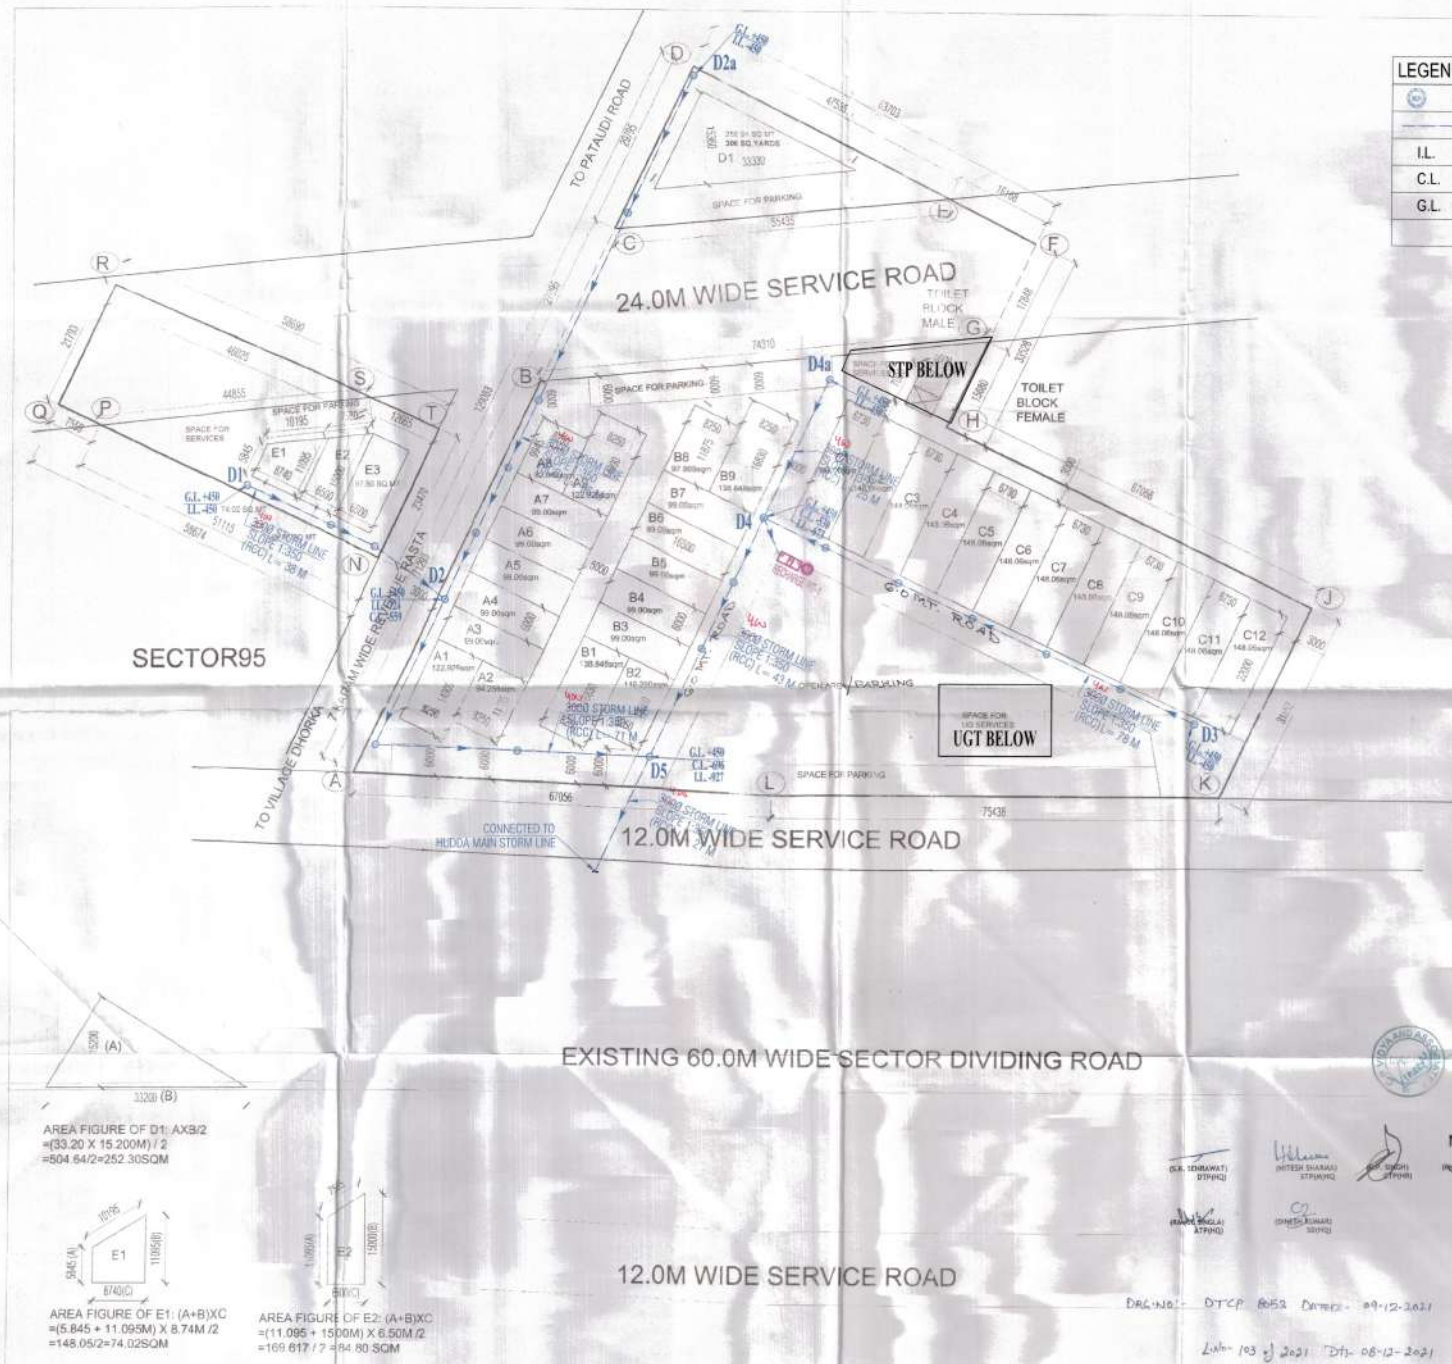

LEGEND:-

	STORM MANHOLE
	STORM PIPE
	I.L. INVERT LEVEL
	C.L. CONNECTION LEVEL
	G.L. GROUND LEVEL

AREA DETAIL

ITEM NO.	DESCRIPTION	AREA (SQ. M.)	NO. OF PLOTS	TOTAL AREA
1	TOTAL AREA	11.500	1	11.500
2	PERMANENT F.A.R.	11.500	1	11.500
3	PROPOSED C.C.	11.500	1	11.500
4	PROPOSED F.A.R.	11.500	1	11.500
5	TOTAL NO. OF PLOTS	11.500	1	11.500
6	RATIO OF F.A.R. TO TOTAL PLOTS	11.500	1	11.500

BLOCK A AREA DETAIL

ITEM NO.	DESCRIPTION	AREA (SQ. M.)	NO. OF PLOTS	TOTAL AREA
1	TOTAL AREA	11.500	1	11.500
2	PERMANENT F.A.R.	11.500	1	11.500
3	PROPOSED C.C.	11.500	1	11.500
4	PROPOSED F.A.R.	11.500	1	11.500
5	TOTAL NO. OF PLOTS	11.500	1	11.500
6	RATIO OF F.A.R. TO TOTAL PLOTS	11.500	1	11.500

BLOCK B AREA DETAIL

ITEM NO.	DESCRIPTION	AREA (SQ. M.)	NO. OF PLOTS	TOTAL AREA
1	TOTAL AREA	11.500	1	11.500
2	PERMANENT F.A.R.	11.500	1	11.500
3	PROPOSED C.C.	11.500	1	11.500
4	PROPOSED F.A.R.	11.500	1	11.500
5	TOTAL NO. OF PLOTS	11.500	1	11.500
6	RATIO OF F.A.R. TO TOTAL PLOTS	11.500	1	11.500

BLOCK C AREA DETAIL

ITEM NO.	DESCRIPTION	AREA (SQ. M.)	NO. OF PLOTS	TOTAL AREA
1	TOTAL AREA	11.500	1	11.500
2	PERMANENT F.A.R.	11.500	1	11.500
3	PROPOSED C.C.	11.500	1	11.500
4	PROPOSED F.A.R.	11.500	1	11.500
5	TOTAL NO. OF PLOTS	11.500	1	11.500
6	RATIO OF F.A.R. TO TOTAL PLOTS	11.500	1	11.500

BLOCK D AREA DETAIL

ITEM NO.	DESCRIPTION	AREA (SQ. M.)	NO. OF PLOTS	TOTAL AREA
1	TOTAL AREA	11.500	1	11.500
2	PERMANENT F.A.R.	11.500	1	11.500
3	PROPOSED C.C.	11.500	1	11.500
4	PROPOSED F.A.R.	11.500	1	11.500
5	TOTAL NO. OF PLOTS	11.500	1	11.500
6	RATIO OF F.A.R. TO TOTAL PLOTS	11.500	1	11.500

PRINCIPAL ARCHITECT

ACPL

ACPL Design Ltd

CLIENT:-

GLS INFRAPROJECTS PVT. LTD.

PROJECT:-

SITE PLAN OF PROPOSED LICENSE TO SET UP PLOTTED COMMERCIAL COLONY ON AN AREA MEASURING 2.95625 ACRES IN THE REVENUE ESTATE OF VILLAGE DHORKA, SECTOR-95, DIST. GURUGRAM - GLS INFRAPROJECTS PVT. LTD.

Only For Service Plan Estimate

Superintending Engineer, HVP, Circle, Gurugram.

Authorised Signat.

OWNER/AUTH. SIGNATURE

ARCHITECT'S SIGNATURE

DRAWING TITLE

DRAINAGE LAYOUT SITE PLAN

DRAWING NO. PL/D-A-1

SCALE 1:300

DWG. No. - DTCP R/S2 DATED - 09-12-2021

Link- 103 of 2021 Dtd- 08-12-2021