


Flushing W/S

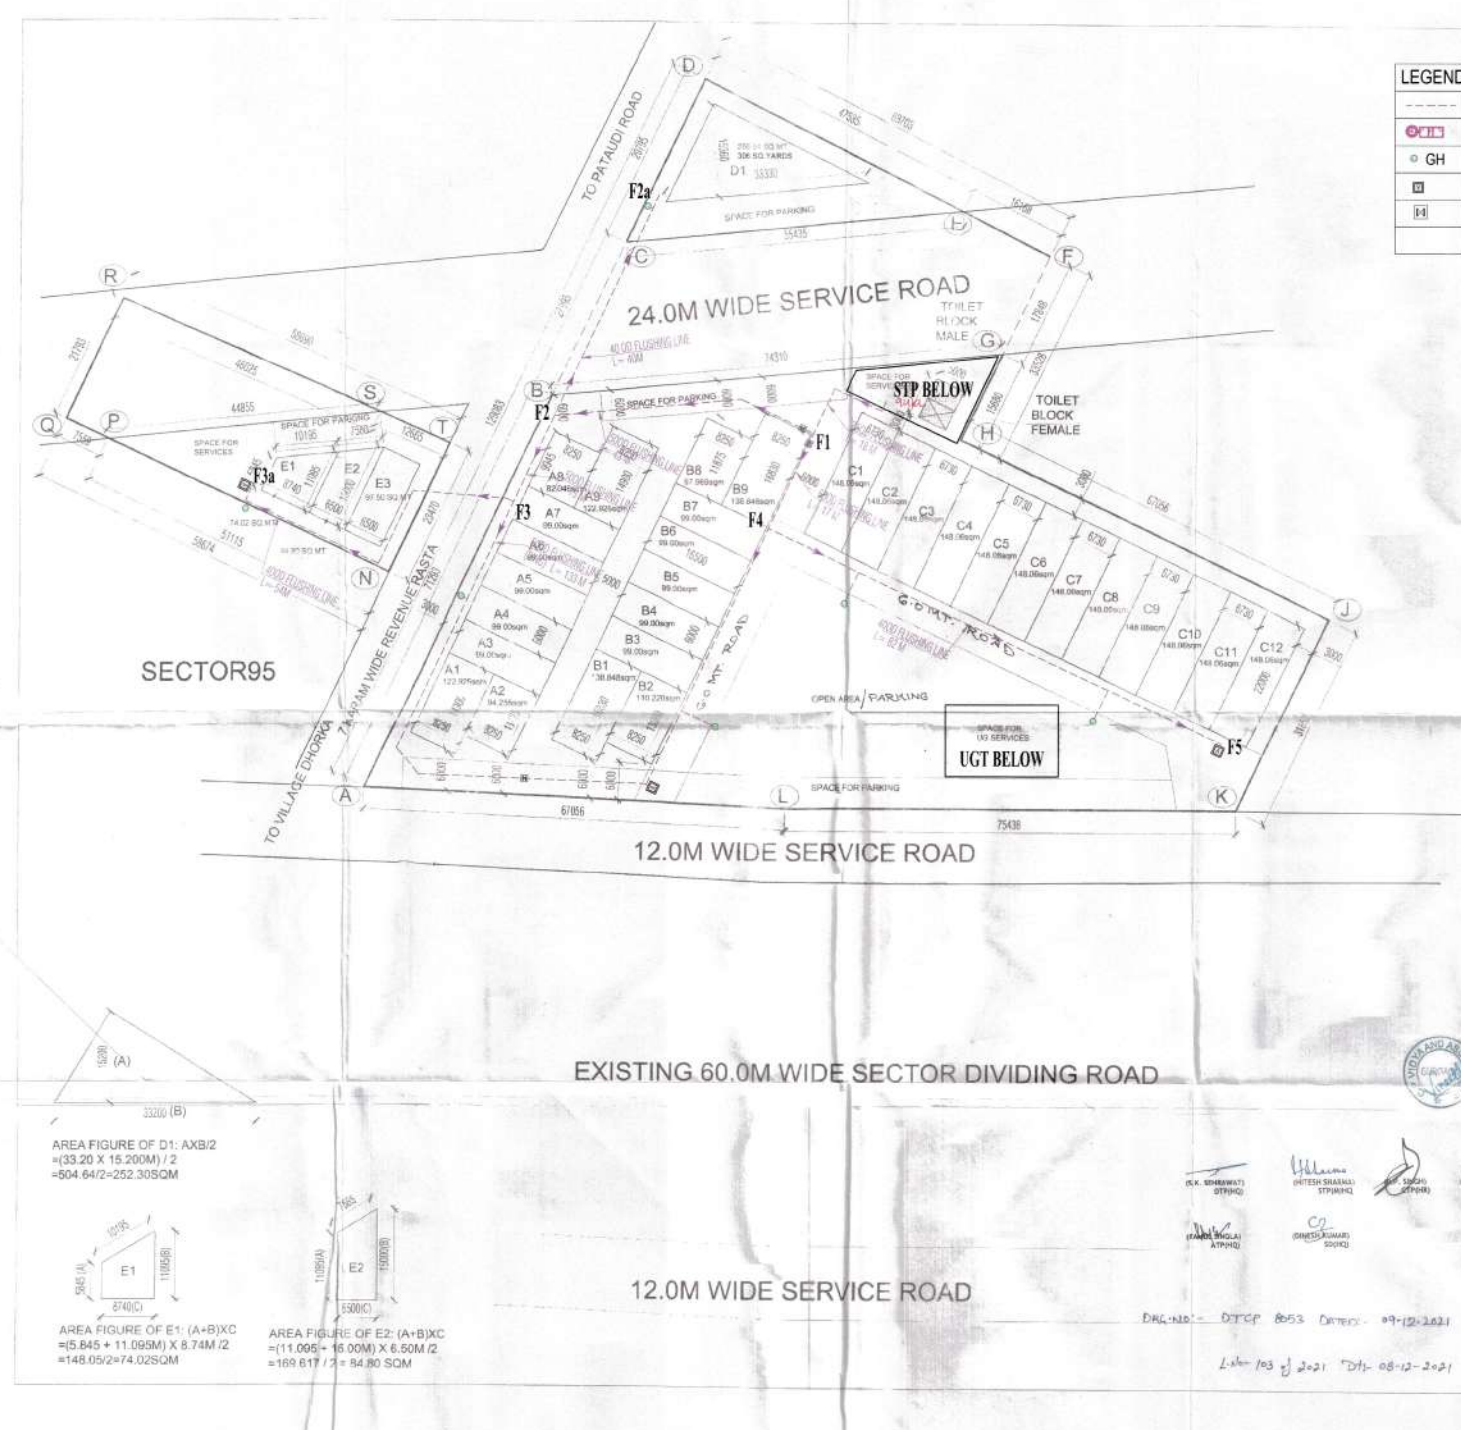

LEGEND:-

---	FLUSHING LINE
○	RECHARGE PIT
○	GH EXTERNAL GARDEN
□	AIR RELEASE VALVE
□	VALVE WITH CHAMBER

AREA DETAIL			
DESCRIPTION	FACTOR	AREA	NO. OF PLOTS
TOTAL AREA		2.95825	124
PERMITTED F.A.R.	1.500	4.43738	180
PROPOSED F.A.R.	1.500	4.43738	180
TOTAL NO. OF PLOTS			124
RATIO OF F.A.R. TO THE AREA OF THE SITE = 1.500 / 2.95825 = 0.50704			

BLOCK - A AREA DETAIL			
PLOT NO.	PLOT SIZE	AREA (SQ. MT.)	NO. OF PLOTS
A1	12.0000	144.0000	1
A2	12.0000	144.0000	1
A3	12.0000	144.0000	1
A4	12.0000	144.0000	1
A5	12.0000	144.0000	1
A6	12.0000	144.0000	1
A7	12.0000	144.0000	1
A8	12.0000	144.0000	1
A9	12.0000	144.0000	1
A10	12.0000	144.0000	1
A11	12.0000	144.0000	1
A12	12.0000	144.0000	1
TOTAL		1728.0000	12

BLOCK - B AREA DETAIL			
PLOT NO.	PLOT SIZE	AREA (SQ. MT.)	NO. OF PLOTS
B1	12.0000	144.0000	1
B2	12.0000	144.0000	1
B3	12.0000	144.0000	1
B4	12.0000	144.0000	1
B5	12.0000	144.0000	1
B6	12.0000	144.0000	1
B7	12.0000	144.0000	1
B8	12.0000	144.0000	1
B9	12.0000	144.0000	1
B10	12.0000	144.0000	1
B11	12.0000	144.0000	1
B12	12.0000	144.0000	1
TOTAL		1728.0000	12

BLOCK - C AREA DETAIL			
PLOT NO.	PLOT SIZE	AREA (SQ. MT.)	NO. OF PLOTS
C1	12.0000	144.0000	1
C2	12.0000	144.0000	1
C3	12.0000	144.0000	1
C4	12.0000	144.0000	1
C5	12.0000	144.0000	1
C6	12.0000	144.0000	1
C7	12.0000	144.0000	1
C8	12.0000	144.0000	1
C9	12.0000	144.0000	1
C10	12.0000	144.0000	1
C11	12.0000	144.0000	1
C12	12.0000	144.0000	1
TOTAL		1728.0000	12

BLOCK - D AREA DETAIL			
PLOT NO.	PLOT SIZE	AREA (SQ. MT.)	NO. OF PLOTS
D1	12.0000	144.0000	1
D2	12.0000	144.0000	1
D3	12.0000	144.0000	1
D4	12.0000	144.0000	1
D5	12.0000	144.0000	1
D6	12.0000	144.0000	1
D7	12.0000	144.0000	1
D8	12.0000	144.0000	1
D9	12.0000	144.0000	1
D10	12.0000	144.0000	1
D11	12.0000	144.0000	1
D12	12.0000	144.0000	1
TOTAL		1728.0000	12

AREA FIGURE OF D1: AXB/2
 $= (33.20 \times 15.200M) / 2$
 $= 604.642 = 252.305 SQM$

AREA FIGURE OF E1: (A+B)XC
 $= (5.845 + 11.095M) \times 8.74M / 2$
 $= 148.052 = 74.025 SQM$

AREA FIGURE OF E2: (A+B)XC
 $= (11.095 + 16.00M) \times 6.50M / 2$
 $= 168.617 / 2 = 84.309 SQM$

PRINCIPAL ARCHITECT:

ACPL

ACPL Design Ltd.

CLIENT:-

GLS INFRAPROJECTS PVT. LTD.

PROJECT:-

SITE PLAN OF PROPOSED LICENSE TO SET UP PLOTTED COMMERCIAL COLONY ON AN AREA MEASURING 2.95825 ACRES IN THE REVENUE ESTATE OF VILLAGE DHORKA, SECTOR-95, DIST. GURUGRAM - GLS INFRAPROJECTS PVT. LTD.

Only For Service Plan Estimate

Executive Engineer
 HSRP, Division No. 5, Gurugram

Supervising Engineer
 HSRP, Circle, Gurugram

OWNER/AUTH. SIGNATURE

ARCHITECT'S SIGNATURE

DRAWING TITLE **FLUSHING WATER SUPPLY LAYOUT**

SITE PLAN

DRAWING NO **PL/F-A-1** SCALE **1 : 300**

DRAWING NO: DTCP 8053 DATED: 09-12-2021

DATE: 03-12-2021