



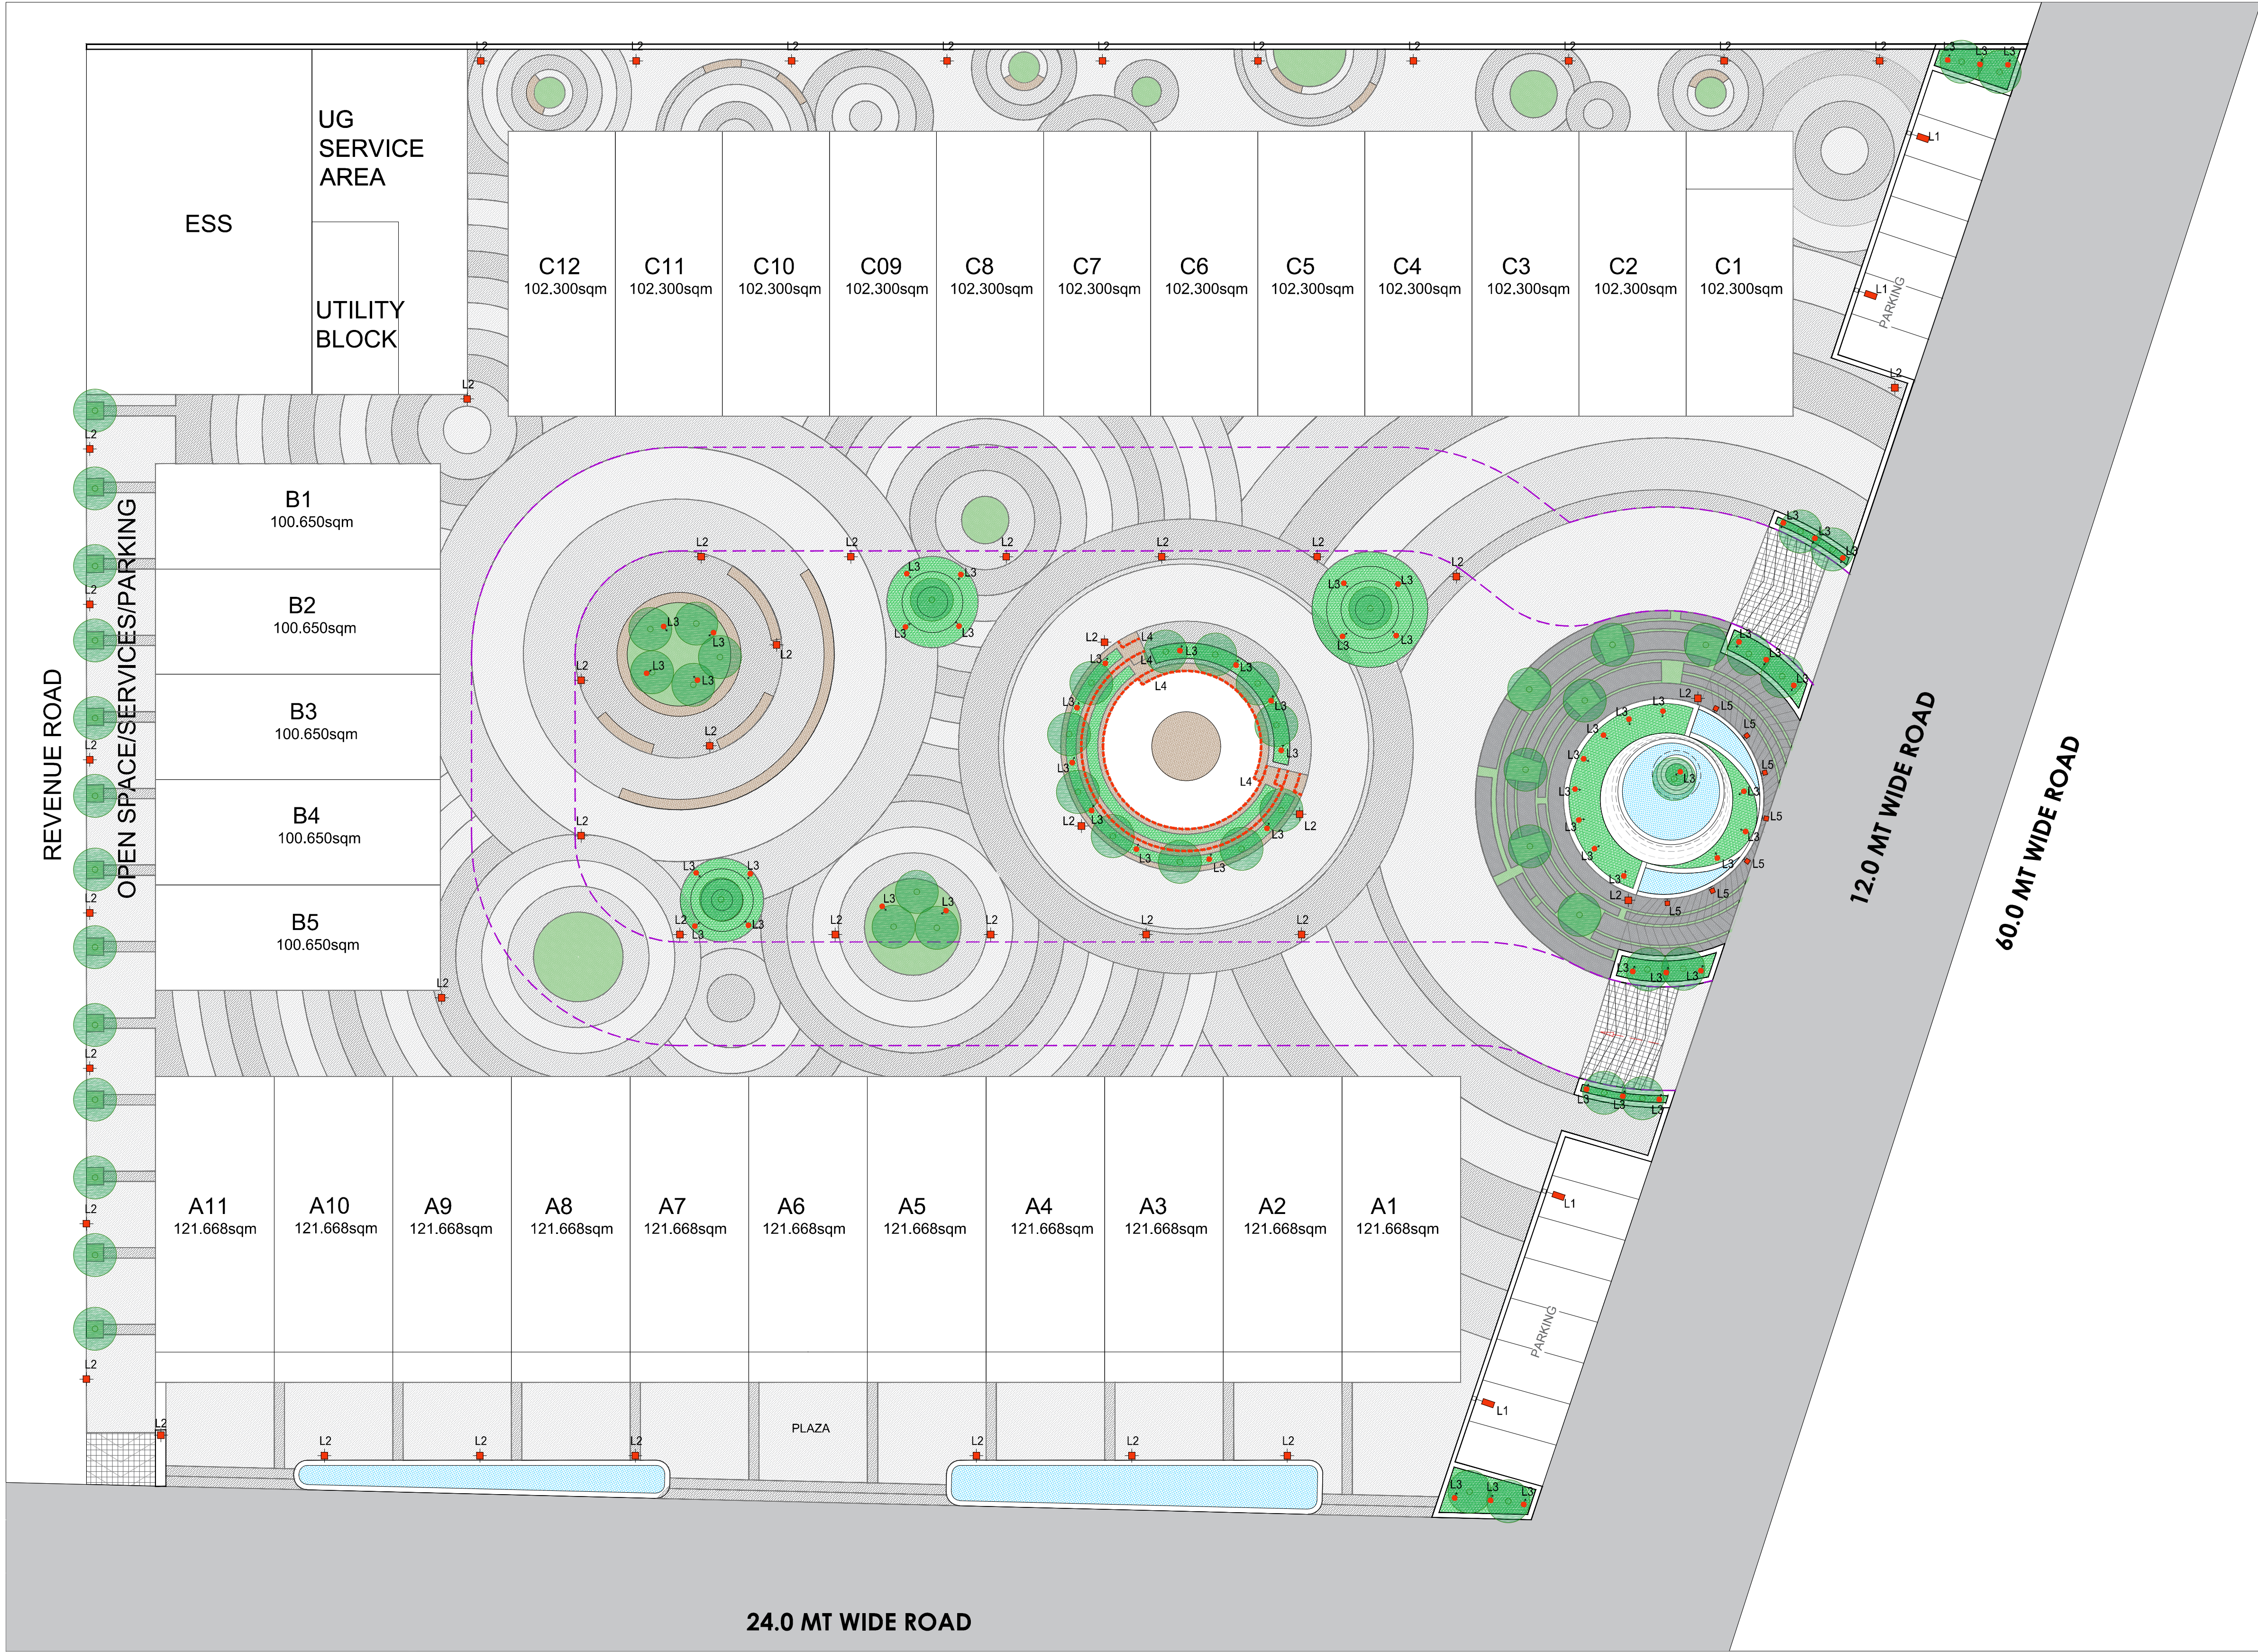

LANDSCAPE LIGHTING PLAN
SCALE 1:200

S.NO.	SYMBOL	TYPE	USAGE	NOS.
L1		STREET LIGHT	DRIVEWAY	04
L2		POST TOP LIGHT	PLAZA AREA	47
L3		ADJUSTABLE UPLIGHTER -2 (SPIKE MOUNTED)	SHRUB LIGHT IN PLANTERS	59
L4		LED STRIP LIGHT	ENTRANCE STEPS, AMPHI. STEPS	61.05M
L5		WALL MOUNTED LIGHT	TOE WALLS, CORRIDORS	07

PRINCIPAL ARCHITECT

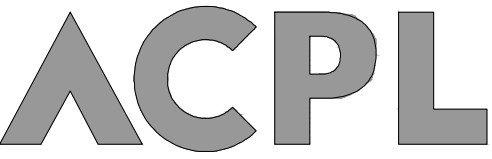


ISO 9001:2015
Architecture
Management
Planning

ACPL Design Ltd
www.acplonline.com

E-24 South Extension -1
New Delhi 110049 India
E: contact@acplonline.comT: +91 11 24622195
+91 11 24646709
F: +91 11 24634069

PROJECT:-
LANDSCAPE LIGHTING PLAN OF
COMMERCIAL PLOTTED COLONY ON THE
LAND MEASURING 2.16875 ACRES IN THE
REVENUE ESTATE OF VILLAGE BEGUMPUR
KHATOLA SECTOR-73, DISTRICT GURUGRAM
FOR PYRAMID INFRATECH PVT. LTD.

OWNER/AUTH. SIGNATURE

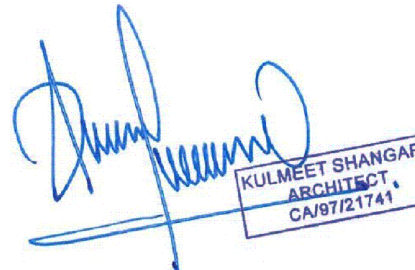ARCHITECT'S SIGNATURE

KULMEET SHANGANI
ARCHITECT
CAPTIVITY

DRAWING TITLE
LANDSCAPE LIGHTING PLAN

DRAWING NO. A-4 SCALE : 1 : 250

