

FIRE & IRRIGATION

For Approval: Signature

1. No. of floors: 10
2. No. of floors: 10
3. No. of floors: 10
4. No. of floors: 10
5. No. of floors: 10
6. No. of floors: 10
7. No. of floors: 10
8. No. of floors: 10
9. No. of floors: 10
10. No. of floors: 10



Project:
PROPOSED GROUP HOUSING SCHEME
MEASURING 17.35 ACRES (LURANCE
NO. 14 OF 2008 IN SECTOR-58
GURGAON, HARYANA
CONVEYANCE DEED NO. 101/2008
HIS ORIGINATOR: HARYANA PVT. LTD.
HIS ADDITION: HARYANA PVT. LTD.
HIS BASE: HARYANA PVT. LTD.

Authorised Signature

STRUCTURAL CONSULTANT

Consulting MEP

Architect's Sign

Morphogenesis

10-555, Park Road, New Delhi
(N. 11) 1100001 Fax: 81 11
1100001

Drawing Title

SITE PLAN

For Service: 10/10/2008

Drawing No. 10/10/2008

Scale: 1:500

Date: 10/10/2008

10/10/2008

10/10/2008

10/10/2008

10/10/2008

10/10/2008

10/10/2008

10/10/2008

10/10/2008


10/10/2008

10/10/2008

10/10/2008

10/10/2008

10/10/2008

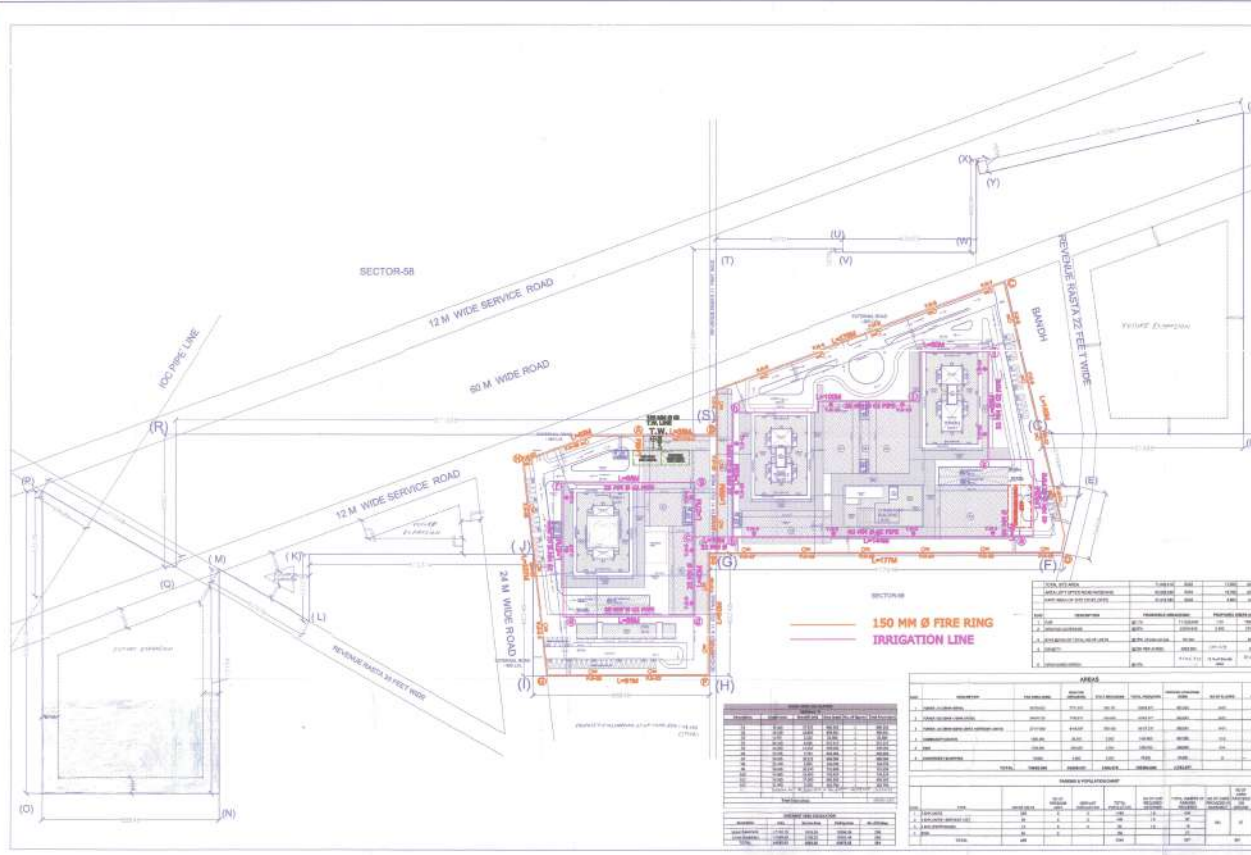

Area	Area	Area	Area	Area	Area
1. 100 FT LINE	100 FT LINE	100 FT LINE	100 FT LINE	100 FT LINE	100 FT LINE
2. 12 M WIDE SERVICE ROAD	12 M WIDE SERVICE ROAD	12 M WIDE SERVICE ROAD	12 M WIDE SERVICE ROAD	12 M WIDE SERVICE ROAD	12 M WIDE SERVICE ROAD
3. 60 M WIDE ROAD	60 M WIDE ROAD	60 M WIDE ROAD	60 M WIDE ROAD	60 M WIDE ROAD	60 M WIDE ROAD
4. 24 M WIDE ROAD	24 M WIDE ROAD	24 M WIDE ROAD	24 M WIDE ROAD	24 M WIDE ROAD	24 M WIDE ROAD
5. 150 MM Ø FIRE RING	150 MM Ø FIRE RING	150 MM Ø FIRE RING	150 MM Ø FIRE RING	150 MM Ø FIRE RING	150 MM Ø FIRE RING
6. IRRIGATION LINE	IRRIGATION LINE	IRRIGATION LINE	IRRIGATION LINE	IRRIGATION LINE	IRRIGATION LINE

Area	Area	Area	Area	Area	Area
1. 100 FT LINE	100 FT LINE	100 FT LINE	100 FT LINE	100 FT LINE	100 FT LINE
2. 12 M WIDE SERVICE ROAD	12 M WIDE SERVICE ROAD	12 M WIDE SERVICE ROAD	12 M WIDE SERVICE ROAD	12 M WIDE SERVICE ROAD	12 M WIDE SERVICE ROAD
3. 60 M WIDE ROAD	60 M WIDE ROAD	60 M WIDE ROAD	60 M WIDE ROAD	60 M WIDE ROAD	60 M WIDE ROAD
4. 24 M WIDE ROAD	24 M WIDE ROAD	24 M WIDE ROAD	24 M WIDE ROAD	24 M WIDE ROAD	24 M WIDE ROAD
5. 150 MM Ø FIRE RING	150 MM Ø FIRE RING	150 MM Ø FIRE RING	150 MM Ø FIRE RING	150 MM Ø FIRE RING	150 MM Ø FIRE RING
6. IRRIGATION LINE	IRRIGATION LINE	IRRIGATION LINE	IRRIGATION LINE	IRRIGATION LINE	IRRIGATION LINE

FIRE & IRRIGATION



ROAD

