


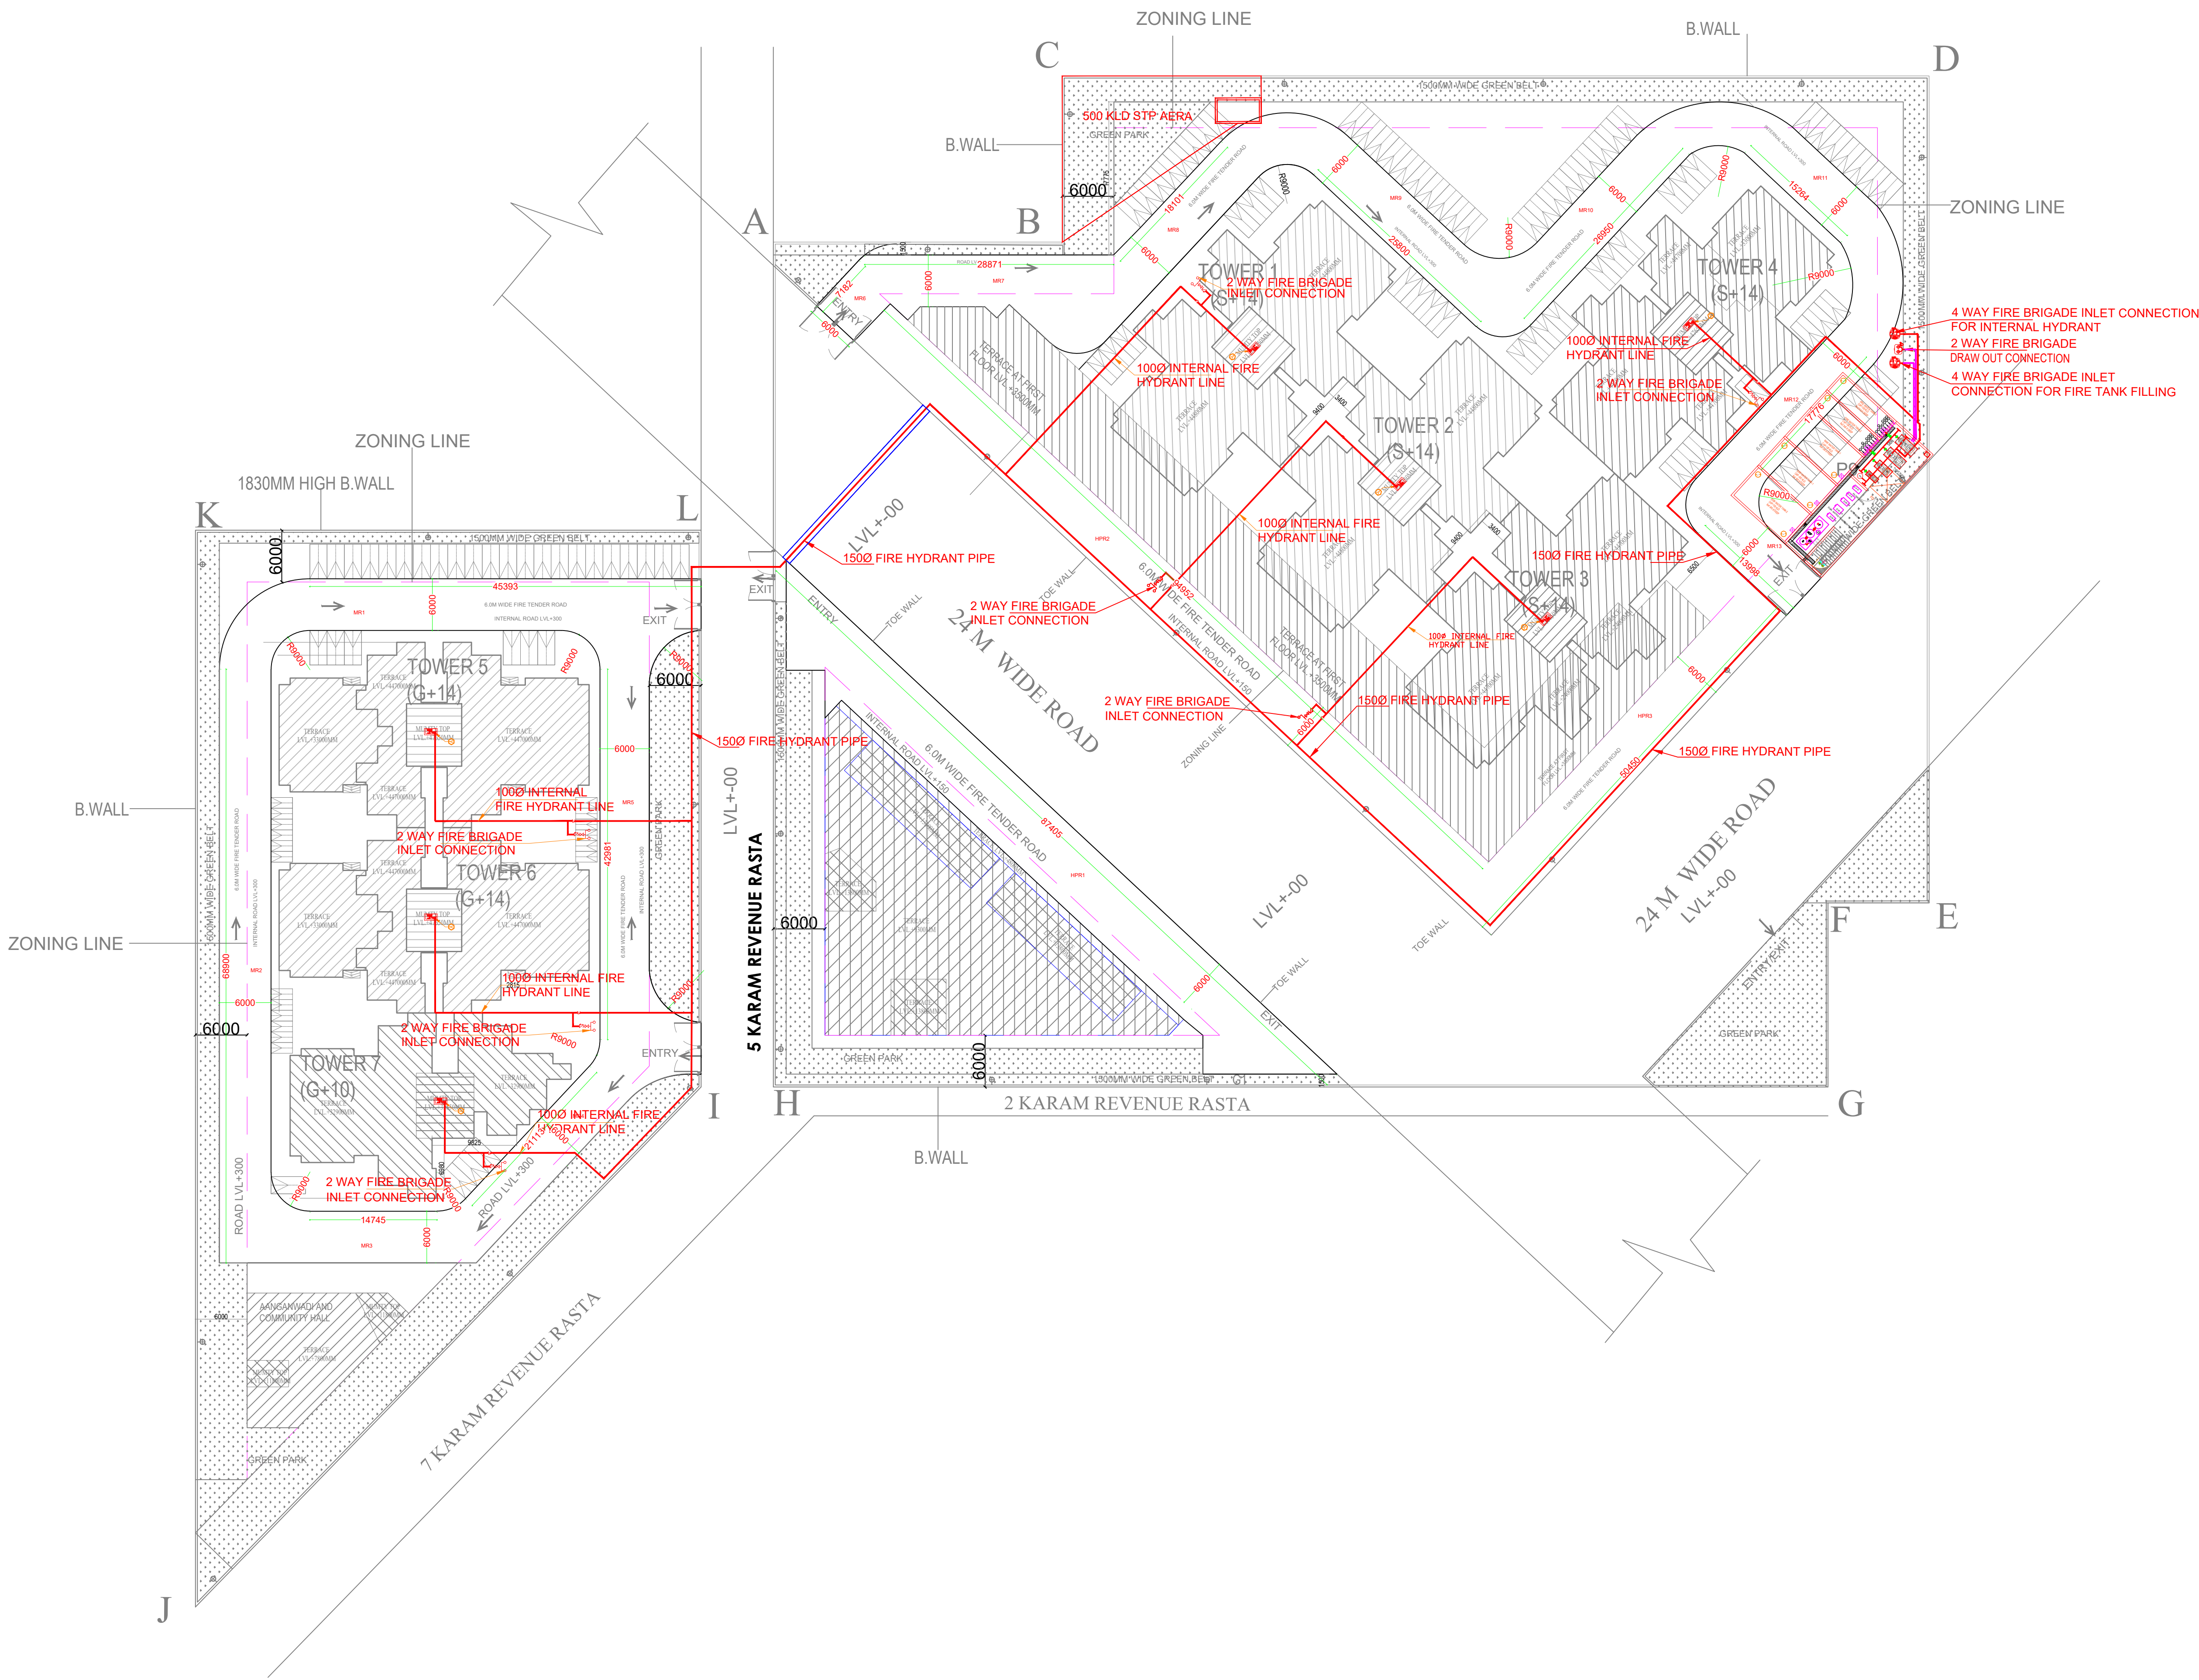

FIRE LEGEND:-		
01	1500 FIRE HYDRANT PIPE	
02	4 WAY FIRE BRIGADE INLET CONNECTION	
03	2 WAY FIRE BRIGADE WITHDRAW CONNECTION	

CLIENT:- M/S DHARMBIR IN COLLABORATION WITH APRICUS HILLS PVT. LTD.

PROJECT : -
PROPOSED BUILDING PLAN OF AFFORDABLE GROUP HOUSING COLONY OVER AN AREA MEASURING 5.0375 ACRE(LICENCE NO.101 DATED 08-12-2021) IN SECTOR-104, GURUGRAM BEING DEVELOPED BY DHARMBIR IN COLLABORATION WITH APRICUS HILLS PVT. LTD.

DRAWING. TITLE:-
SITE PLAN

ARCHITECTS

Pinnacle Architects Pvt.Ltd.
938 , SECTOR 14 , GURGAON
HARYANA

CONSULTANTS:-

SERVICES CONSULTANTS:

MEP CONSULTANTS

ONE DESIGN & CONSULTANTS
7/ 8, LGF, Nehru Enclave, Kalkaji Extension,
New Delhi- 110019
E-MAIL:- onedesignconsultants@gmail.com
web mail:- info@onedesignconsultants.com
MOB:- 99580-79000

SHEET TITLE SITE PLAN FIRE FIGHTING LAYOUT

DRAWN :- PK	CHECKED BY:- AS	
DRG.NO. FF-LA-01	SCALE:- 1:350	REV. NO.
JOB NO.-	DATE:-8-03-2022	R0