


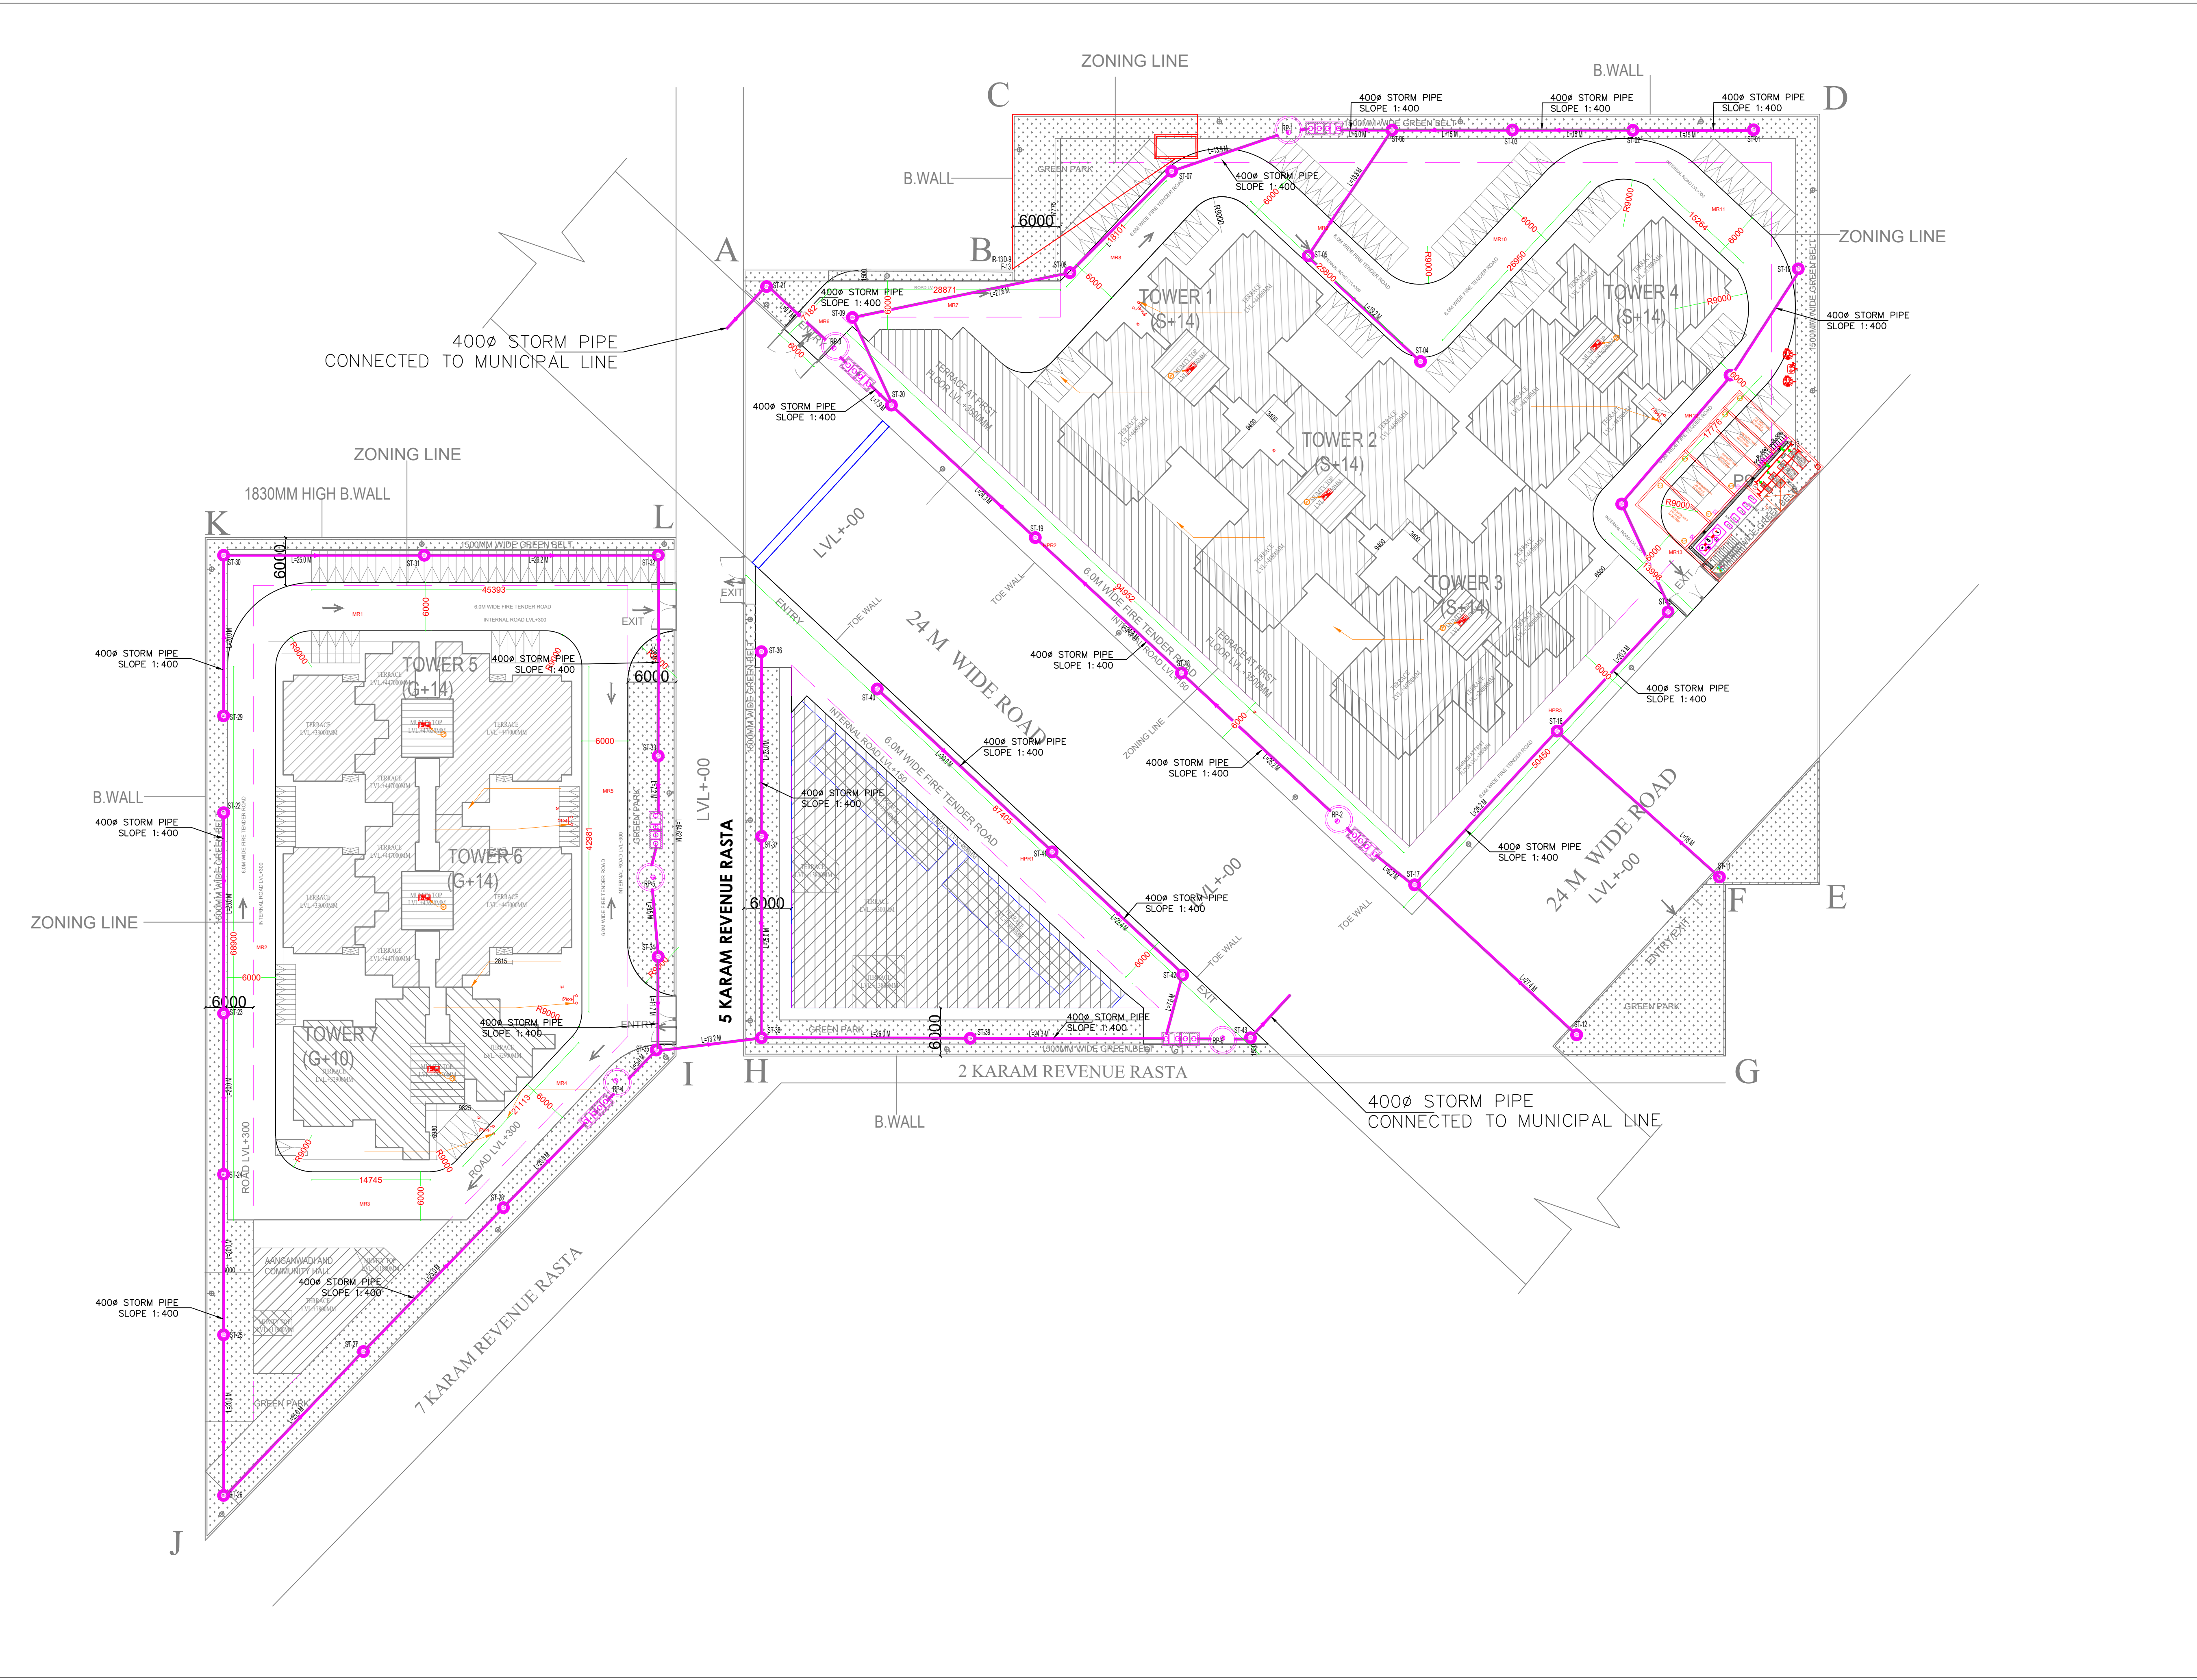

S.N. PLUMBING LEGENDS:-		
01	STORM LINE	
02	STORM MANHOLE	
03	DE-SILTING CHAMBER (2000X1200)	DSC
04	OIL GREASE SEPARATOR (2000X1200)	OGS
05	RECHARGE PIT (3000Ø)	RWH
06	CATCH BASIN	CB


CLIENT:- M/S DHARMBIR IN COLLABORATION WITH APRICUS HILLS PVT. LTD.

PROJECT : - PROPOSED BUILDING PLAN OF AFFORDABLE GROUP HOUSING COLONY OVER AN AREA MEASURING 5.0375 ACRE (LICENCE NO.101 DATED 08-12-2021) IN SECTOR-104, GURUGRAM BEING DEVELOPED BY DHARMBIR IN COLLABORATION WITH APRICUS HILLS PVT. LTD.

DRAWING. TITLE:-

SITE PLAN

ARCHITECTS

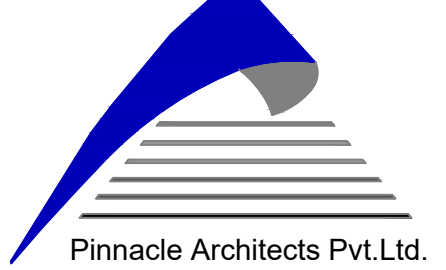

Pinnacle Architects Pvt.Ltd.
938 , SECTOR 14 , GURGAON
HARYANA

CONSULTANTS:-

SERVICES CONSULTANTS:

MEP CONSULTANTS



ONE DESIGN & CONSULTANTS
7/ 8, LGF, Nehru Enclave, Kalkaji Extension,
New Delhi- 110019
E-MAIL:- onedesignconsultants@gmail.com
web mail:- info@onedesignconsultants.com
MOB:- 99580-79000

SHEET TITLE		
STORM WATER LAYOUT		
DRAWN :- SK	CHECKED BY:- AS	
DRG.NO. PL-01	SCALE:- 1:350	REV. NO.
JOB NO.-	DATE:-8-03-2022	R0