


- PLUMBING LEGEND:-
- ① 100 MM Ø SOIL & VENT PIPE
 - ② 100 MM Ø WASTE & VENT PIPE
 - ③ 75 MM Ø ANTI-SIPHONAGE PIPE
 - ④ DOMESTIC WATER IN TAKE PIPE
 - ⑤ FISHING WATER IN TAKE PIPE
 - ⑥ DOMESTIC WATER RISER
 - ⑦ FISHING WATER RISER

Sanctioned
MEMO NO. :
DATED :
DD (T)
MEMBER
BPC

Sanctioned
MEMO NO. :
DATED :
J.D.
P.A.
A.T.P.

Checked and found ok for Public Health
(Internal) Service only subject to comments in
forwarding letter to RISEONIC REALTY PVT. LTD.
Additional Chief Engineer (HQ)
HSVP, Panchkula

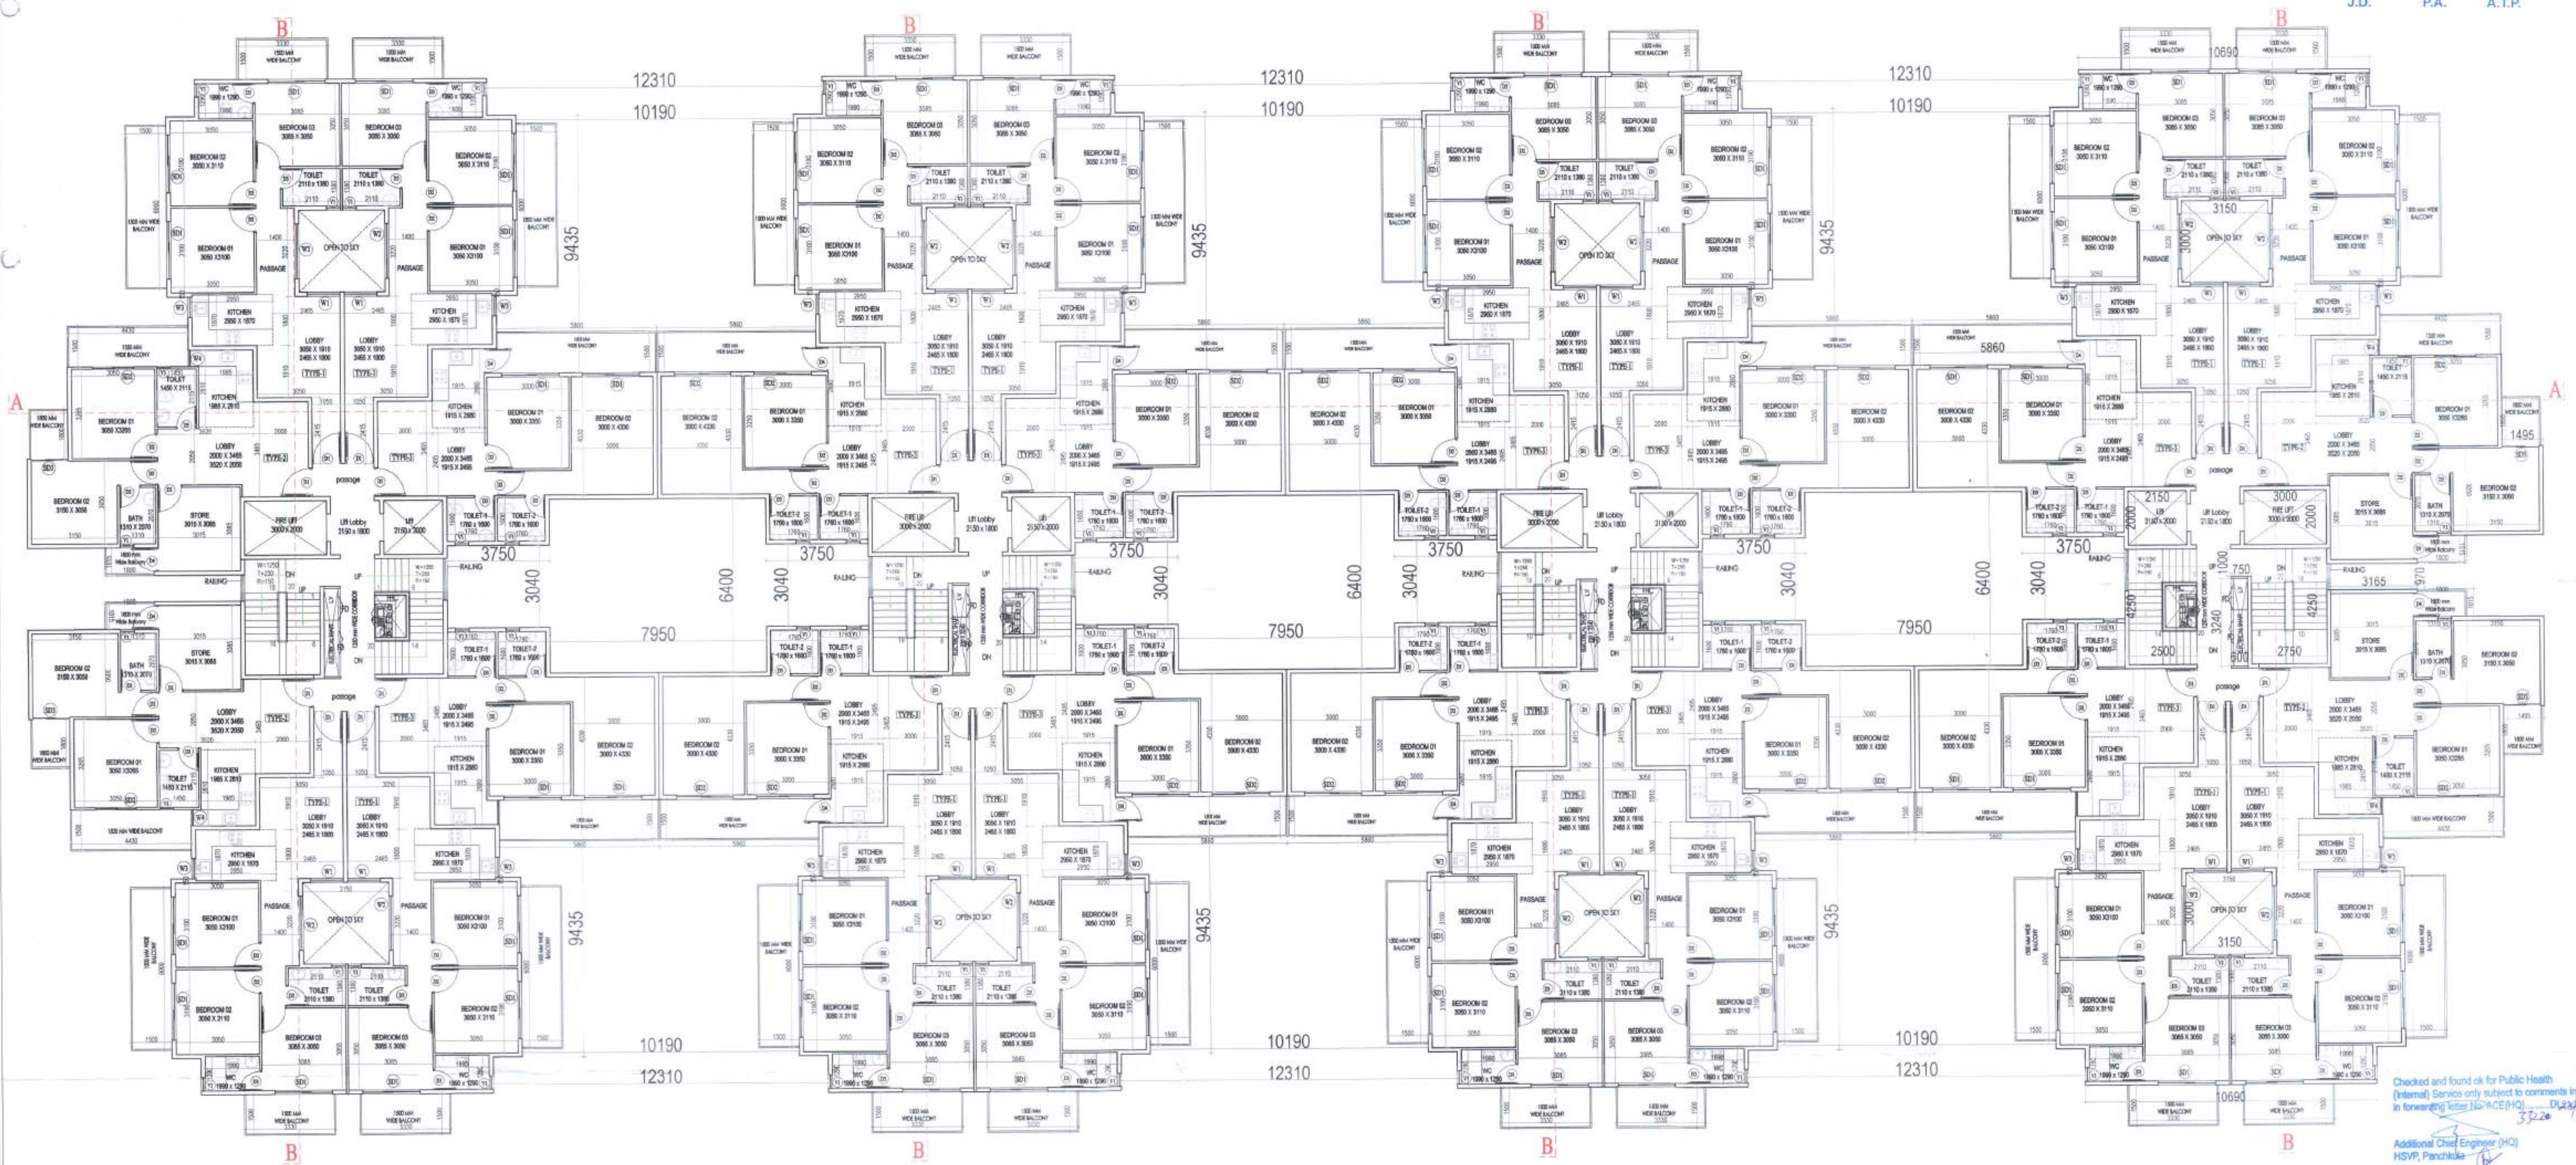

TOWER-1&8
2ND.FLOOR PLAN TOILET DETAIL (TYPICAL)

TOWER-2&7
2ND.FLOOR PLAN TOILET DETAIL (TYPICAL)

TOWER-3&6
2ND.FLOOR PLAN TOILET DETAIL (TYPICAL)

TOWER-4&5
2ND.FLOOR PLAN TOILET DETAIL (TYPICAL)

CLIENT:- SH. JAGDISH S/O SH. LAXMI NARAYAN AND OTHERS IN COLLABORATION WITH RISEONIC REALTY PVT. LTD. PROJECT :- PROPOSED BUILDING PLAN OF AFFORDABLE GROUP HOUSING COLONY OVER AN AREA MEASURING 5.15 ACRE (LIECENCE NO 03 DATED 07.01.2022) IN SECTOR-70, GURUGRAM BEING DEVELOPED BY SH. JAGDISH S/O SH. LAXMI NARAYAN AND OTHERS IN COLLABORATION WITH RISEONIC REALTY PVT. LTD.	ARCHITECTS  SCALE : 1:100 DRAWING NAME COMPOSITE TOWER PLAN DRAWING NO. - 15	Riseonic Realty Pvt. Ltd. Authorised Signatory APPLICANT'S SIGN. ARCHITECT'S SIGN VIMAL BAJAJ Architect CA/96/19791 9/8, Sector-14, Gurgaon
--	--	--