

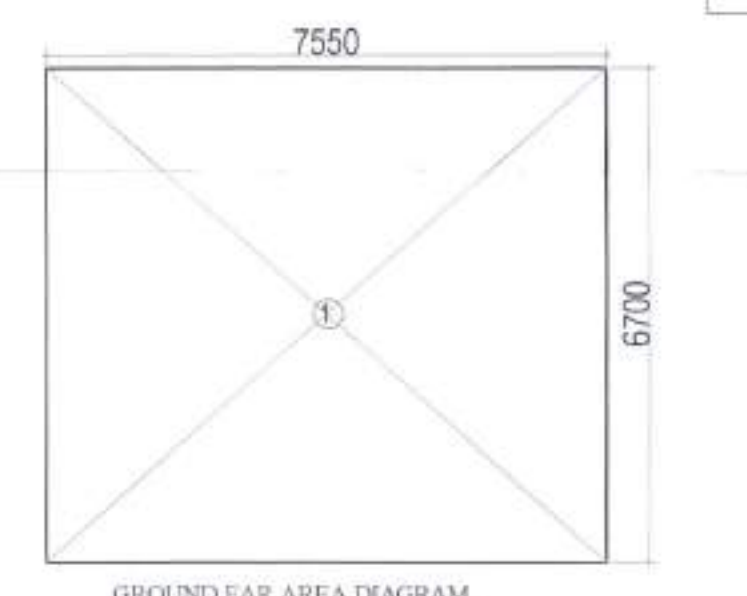


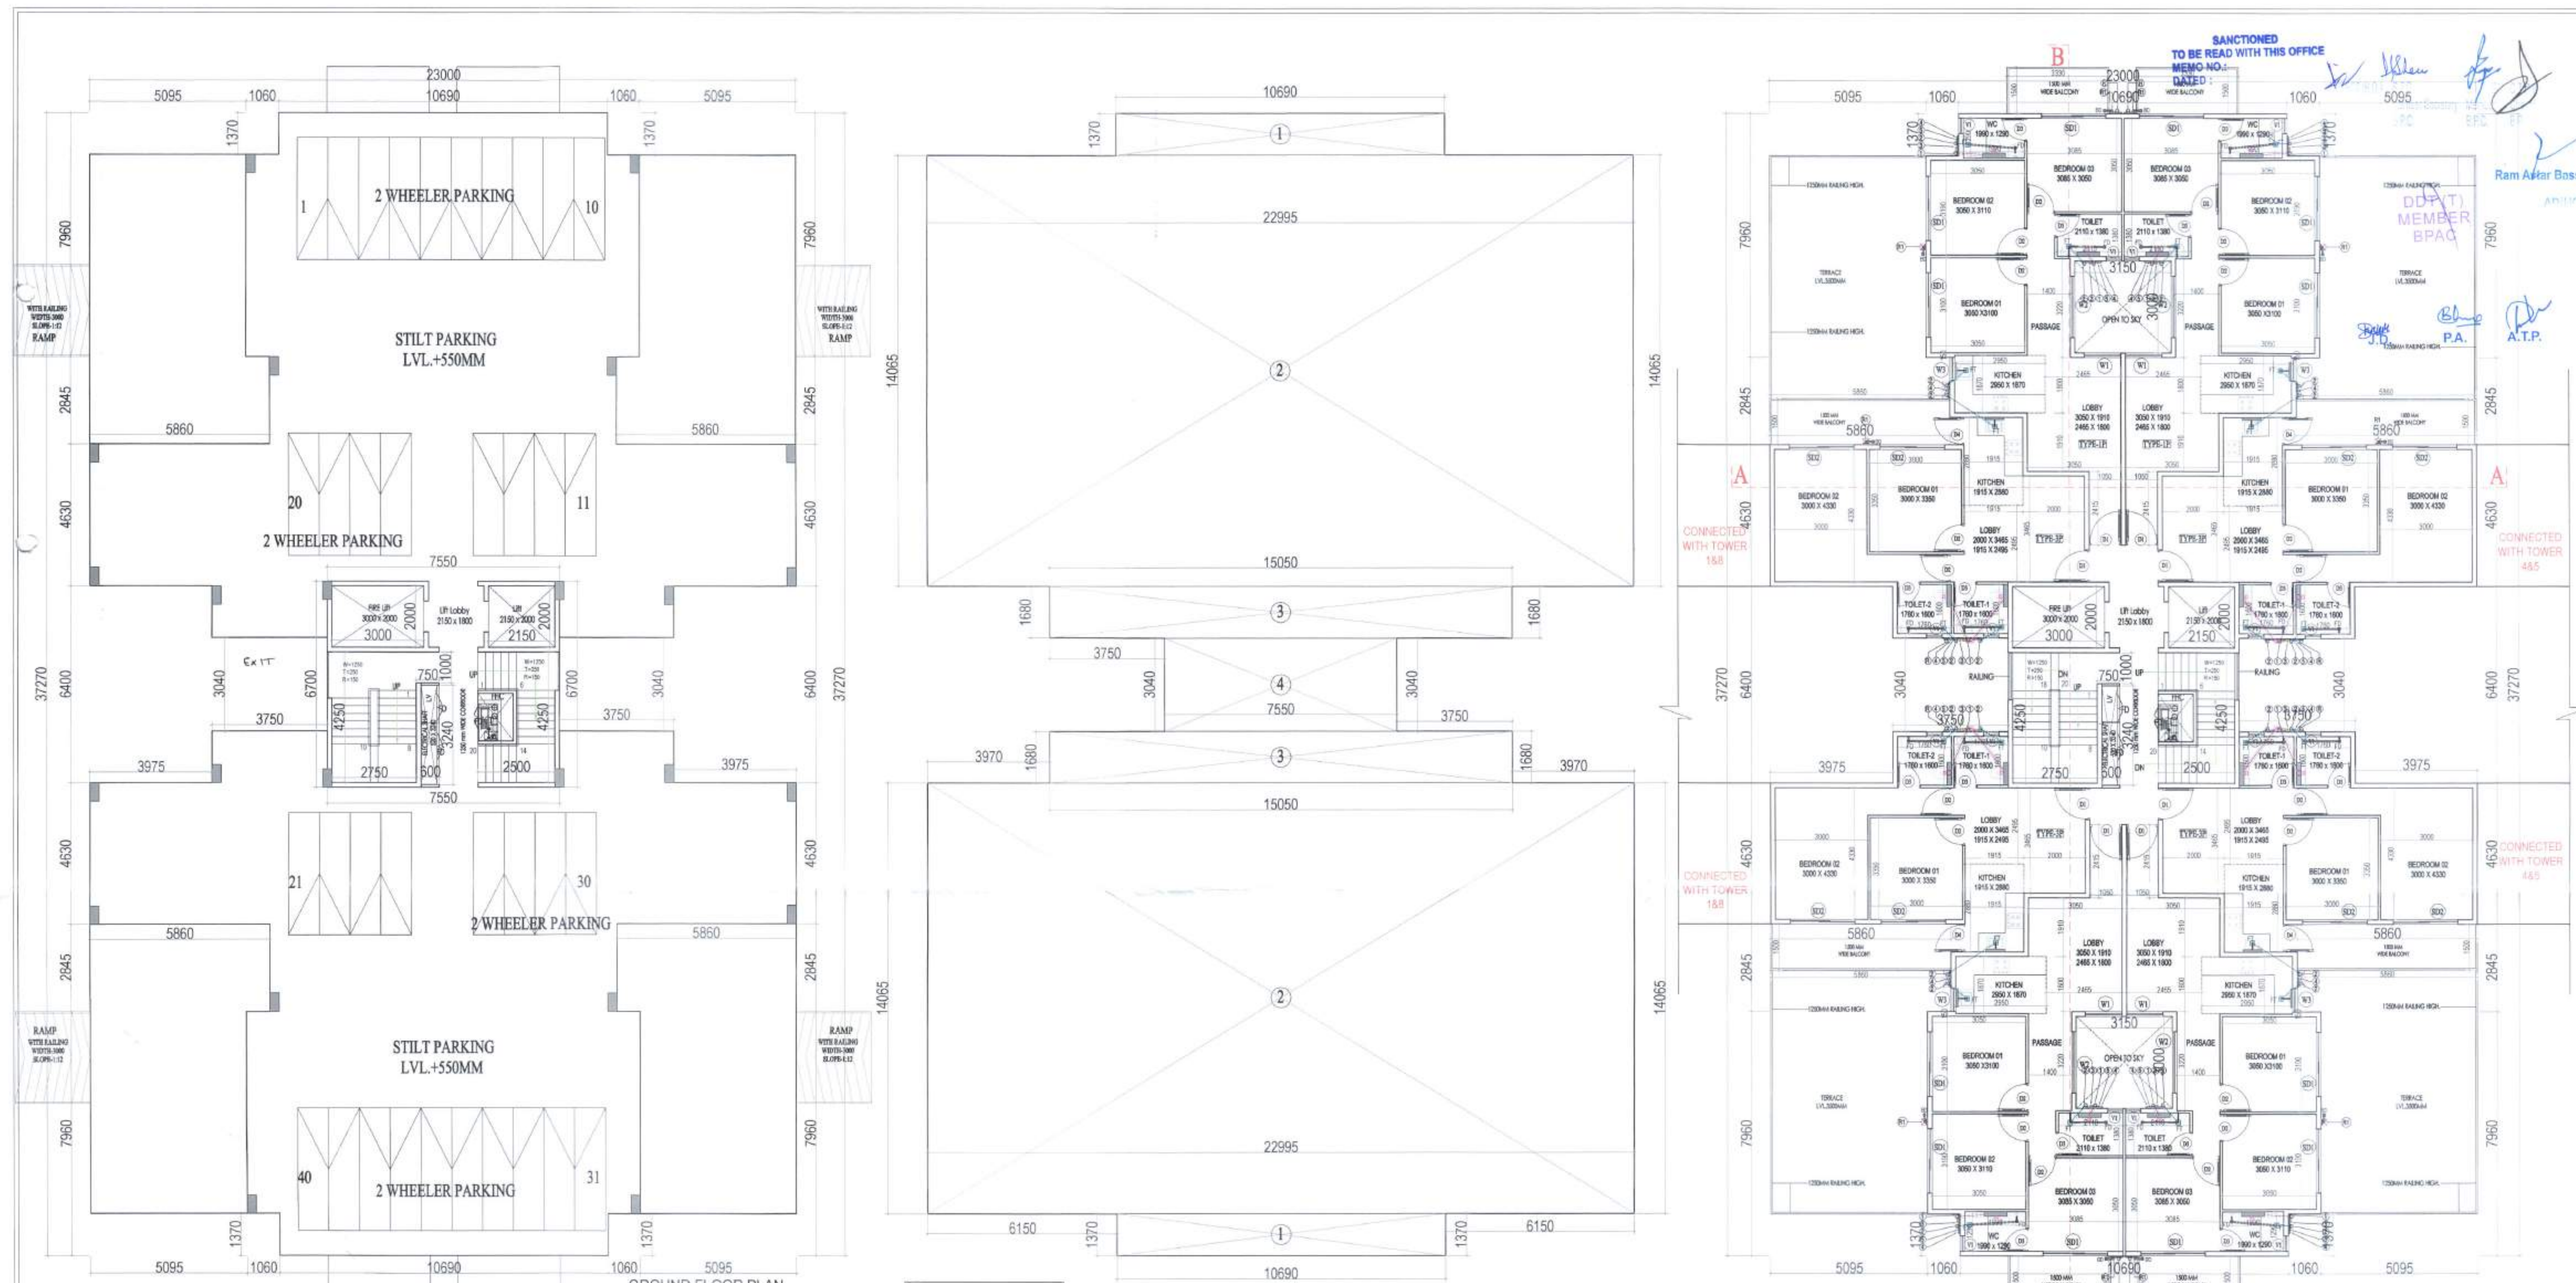

GROUND FLOOR FAR AREA CHART				
A	1	X	7.550	X 6.700 = 50.59
NET FAR AREA				
50.59				

STILT PARKING AREA CHART				
GROUND COVERAGE	749.66			SQMT
GROUND FAR	50.59			SQMT
STILT PARKING AREA	699.07			SQMT

TOWER TOTAL FAR AREA				
GROUND FLOOR FAR AREA	50.59			SQMT
TYPICAL FLOOR FAR (1ST TO 14TH.)	6924.40			SQMT
TOTAL FAR AREA	6974.99			SQMT

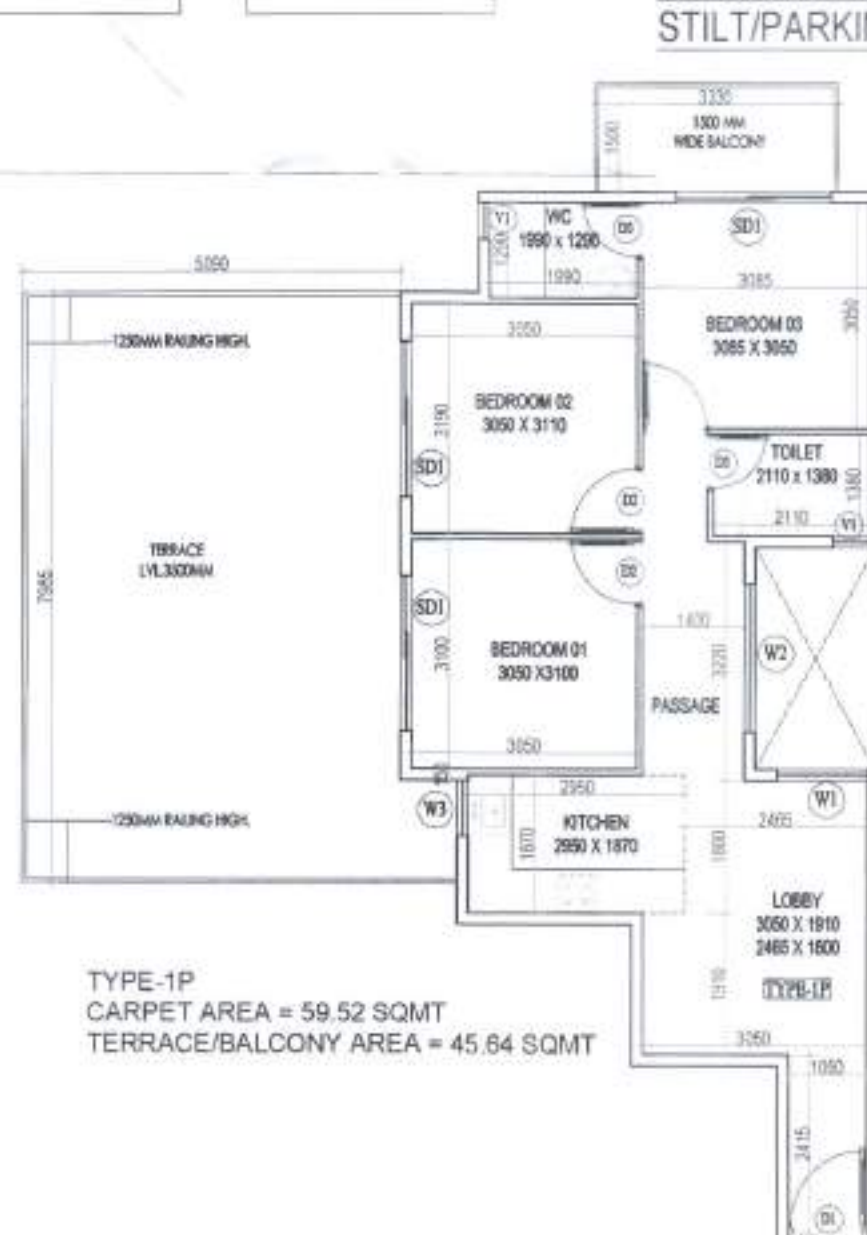

CARPET AREA CHART TYPE-1P				
1	5.155	X	1.970	= 7.06
2	1.695	X	3.140	= 5.29
3	4.530	X	6.290	= 28.49
4	3.765	X	1.950	= 7.34
5	1.400	X	1.910	= 2.67
6	0.600	X	3.710	= 2.23
7	1.050	X	6.125	= 6.43
NET CARPET AREA = 59.52				
BALCONY/TERRACE AREA CHART TYPE-1P				
1	3.330	X	1.500	= 4.995
2	5.090	X	7.985	= 40.644
NET BALCONY/TERRACE AREA = 45.64				



GROUND COVERAGE AREA CHART				
1	2	X	10.690	X 1.370 = 29.29
2	2	X	22.995	X 14.065 = 646.85
3	2	X	15.050	X 1.680 = 50.57
4	1	X	7.550	X 3.040 = 22.95
GROSS PLATE AREA				
749.66				

GROUND FLOOR AREA DIAGRAM

CARPET AREA CHART TYPE-3P				
1	3.600	X	1.680	= 6.05
2	8.075	X	4.330	= 34.96
3	2.000	X	3.465	= 6.93
4	2.365	X	1.045	= 2.47
NET CARPET AREA = 50.41				
BALCONY AREA CHART TYPE-3P				
1	5.860	X	1.500	= 8.790
NET BALCONY AREA = 8.79				

1ST FLOOR PLAN

BUILTUP AREA CHART				
A	1	X	23.000	X 37.270 = 857.21
GROSS PLATE AREA				
857.21				
DEDUCTIONS				
8	4	X	1.000	X 1.370 = 5.81
9	4	X	5.095	X 7.985 = 140.22
10	4	X	5.860	X 2.845 = 66.69
11	2	X	3.975	X 6.400 = 50.88
12	2	X	3.750	X 3.040 = 22.80
TOTAL				
308.40				
NET AREA				
548.81				
TOTAL BUILTUP				
1406.02				
GROUND COVERAGE				
749.66				
MUMTY AREA				
50.59				
TOTAL BUILTUP				
1456.61				

PLUMBING LEGEND				
1	FORMING SOLEVENT PIPE			
2	100 MM WASTE & VENT PIPE			
3	75 MM AIR DUCT/VENT PIPE			
4	DOMESTIC WATER IN TAKE			
5	FINISHING WATER IN TAKE			
6	DOMESTIC WATER RISER			
7	FINISHING WATER RISER			

NOTE: SHAFTS ARE MECHANICALLY VENTILATED

CLIENT:- SH. JAGDISH S/O SH. LAXMI NARAYAN AND OTHERS IN COLLABORATION WITH RISEONIC REALITY PVT. LTD. (A COMPANY INCORPORATED IN INDIA)

PROJECT:- PROPOSED BUILDING PLAN OF AFFORDABLE GROUP HOUSING CO-OPERATIVE SOCIETY IN SECTOR-10, GURUGRAM BEING DEVELOPED BY SH. JAGDISH S/O SH. LAXMI NARAYAN AND OTHERS IN COLLABORATION WITH RISEONIC REALITY PVT. LTD.

ARCHITECTS: RISEONIC REALITY PVT. LTD. (A COMPANY INCORPORATED IN INDIA)
SCALE: 1:100
DRAWING NAME: TOWER-2, 3, 5 & 7
GROUND, TYPICAL FLOOR PLAN & AREA DIAGRAM, UNITS PLAN & AREA
DRAWING NO. - 06
APPLICANT'S SIGN: VIMAL BAJAJ
ARCHITECT'S SIGN: VIMAL BAJAJ