

Recycling: (flush w/s)

Checked subject to comments
in forwarding letter No. 23774
Dt. 10/05/2011. And notes
attached with the estimate

 
Additional Chief Engineer
for Civil Engineering, ADP
Pune

Only for Service
Plan Estimate

For Civil
Engineering

GENERAL NOTES:-

- All dimensions in millimeters unless otherwise specified.
- Drawings are to be read in the light of the following:
 - All dimensions are to be taken to the center of the line unless otherwise specified.
 - The drawing is to be read in conjunction with the notes, large scale drawings, schedule, elevations, sections and other relevant drawings.
 - All dimensions are to be taken to the center of the line unless otherwise specified.
 - Standard construction details shall be as per the relevant specifications.
 - Standard construction details shall be as per the relevant specifications.
 - Standard construction details shall be as per the relevant specifications.
- Standard construction details shall be as per the relevant specifications.
- Standard construction details shall be as per the relevant specifications.
- Standard construction details shall be as per the relevant specifications.



PROJECT TITLE:-

ADDITIONAL BUILDING PLANS
OF GROUP HOUSING COLONY
MEASURING 13.2118 ACRES
(LICENCE NO. 83 OF 2014 DATED
13.08.2014) IN SECTOR-48(HD
ZONE), GURGAON MANAGER
URBAN COMPLEX DEVELOPED
BY HANS PROPCON PVT
LTD AND OTHERS

OWNER:-

HANS PROPCON PVT. LTD.
OFFICE NO. 122-A, DEVIKA TOWER,
13TH FLOOR, NEHRU PLACE,
NEW DELHI-110018

STRUCTURAL ENGINEER

CIVTECH CONSULTANT PVT LTD
A-45 SECTOR-64,
NOIDA-201301(U.P.)

MEP CONSULTANTS

M/S Kurnar Endcom Pvt. Ltd.
ENGINEERING DESIGN CONSULTANTS
E-212, Greater Kailash-2
New Delhi-110048
India +91 11 45438784, +91 11 29233231

LANDSCAPE CONSULTANTS

Designs International Studio Pvt. Ltd.
A-108, Noida, New Delhi-110021
India +91 11 24114595, +91 11 24114591

DESIGN ARCHITECT




REVISION / COMMISSION DRAWINGS

DRAWING TITLE: **Site Plan**
SITING PLAN FOR GROUP HOUSING COLONY
PODIUM FLOOR PLAN

SCALE: 1:400 DATE: OCT 2018
MUN-ST-100

SIGNATURE & SEAL OF ARCHITECT
SIGNATURE & SEAL OF OWNER
SIGNATURE & SEAL OF ARCHITECT
SIGNATURE & SEAL OF OWNER

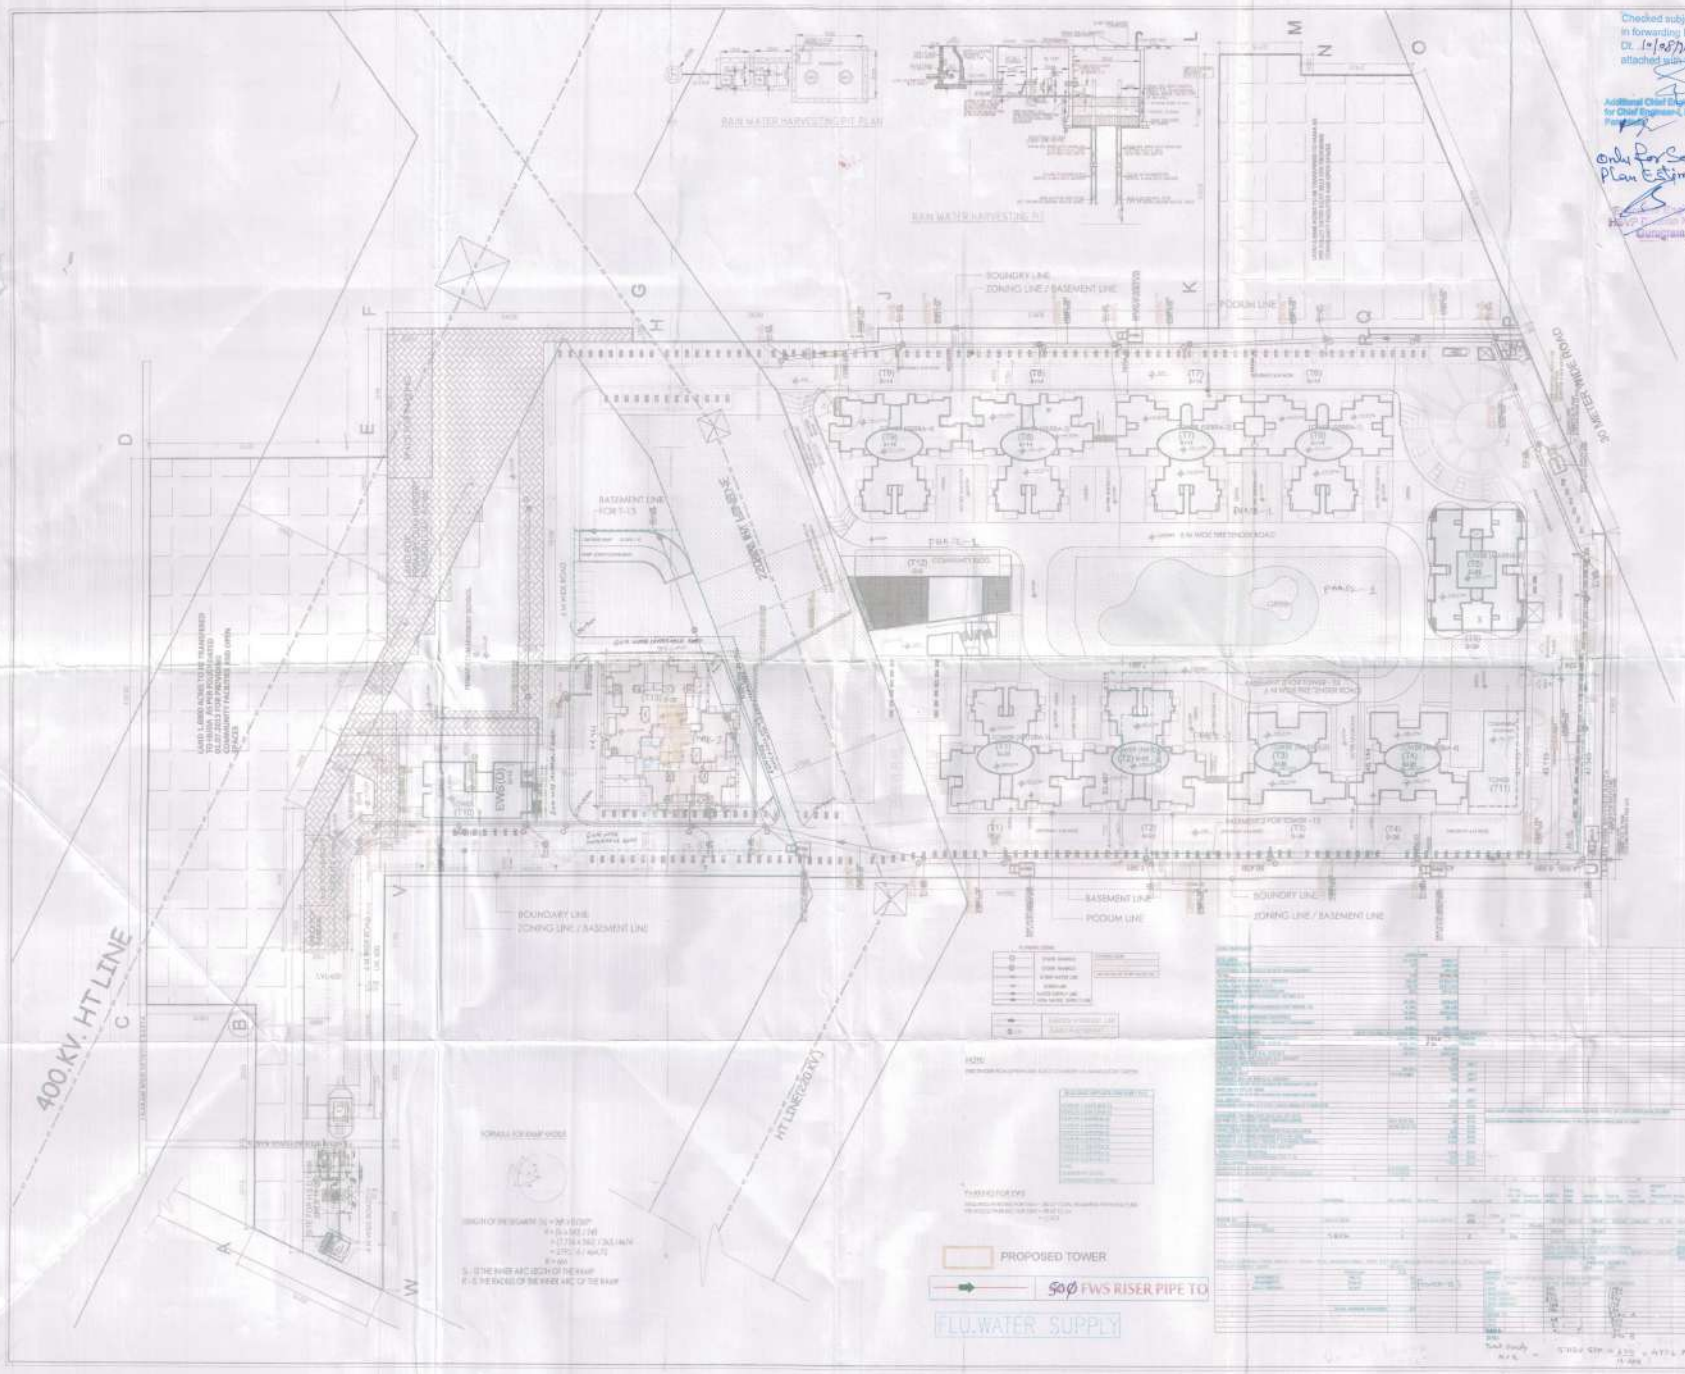

PROPOSED TOWER
Sewer FWS RISER PIPE TO
FLU WATER SUPPLY