


ELECTRICAL LAYOUT PLAN OF PLOTTED COLONY UNDER DDJAY FOR M/S. VIJAY LAXMI INFRABUILD (P) LTD.

SEC-29, VILLAGE JAUNDHI, JHAJJAR

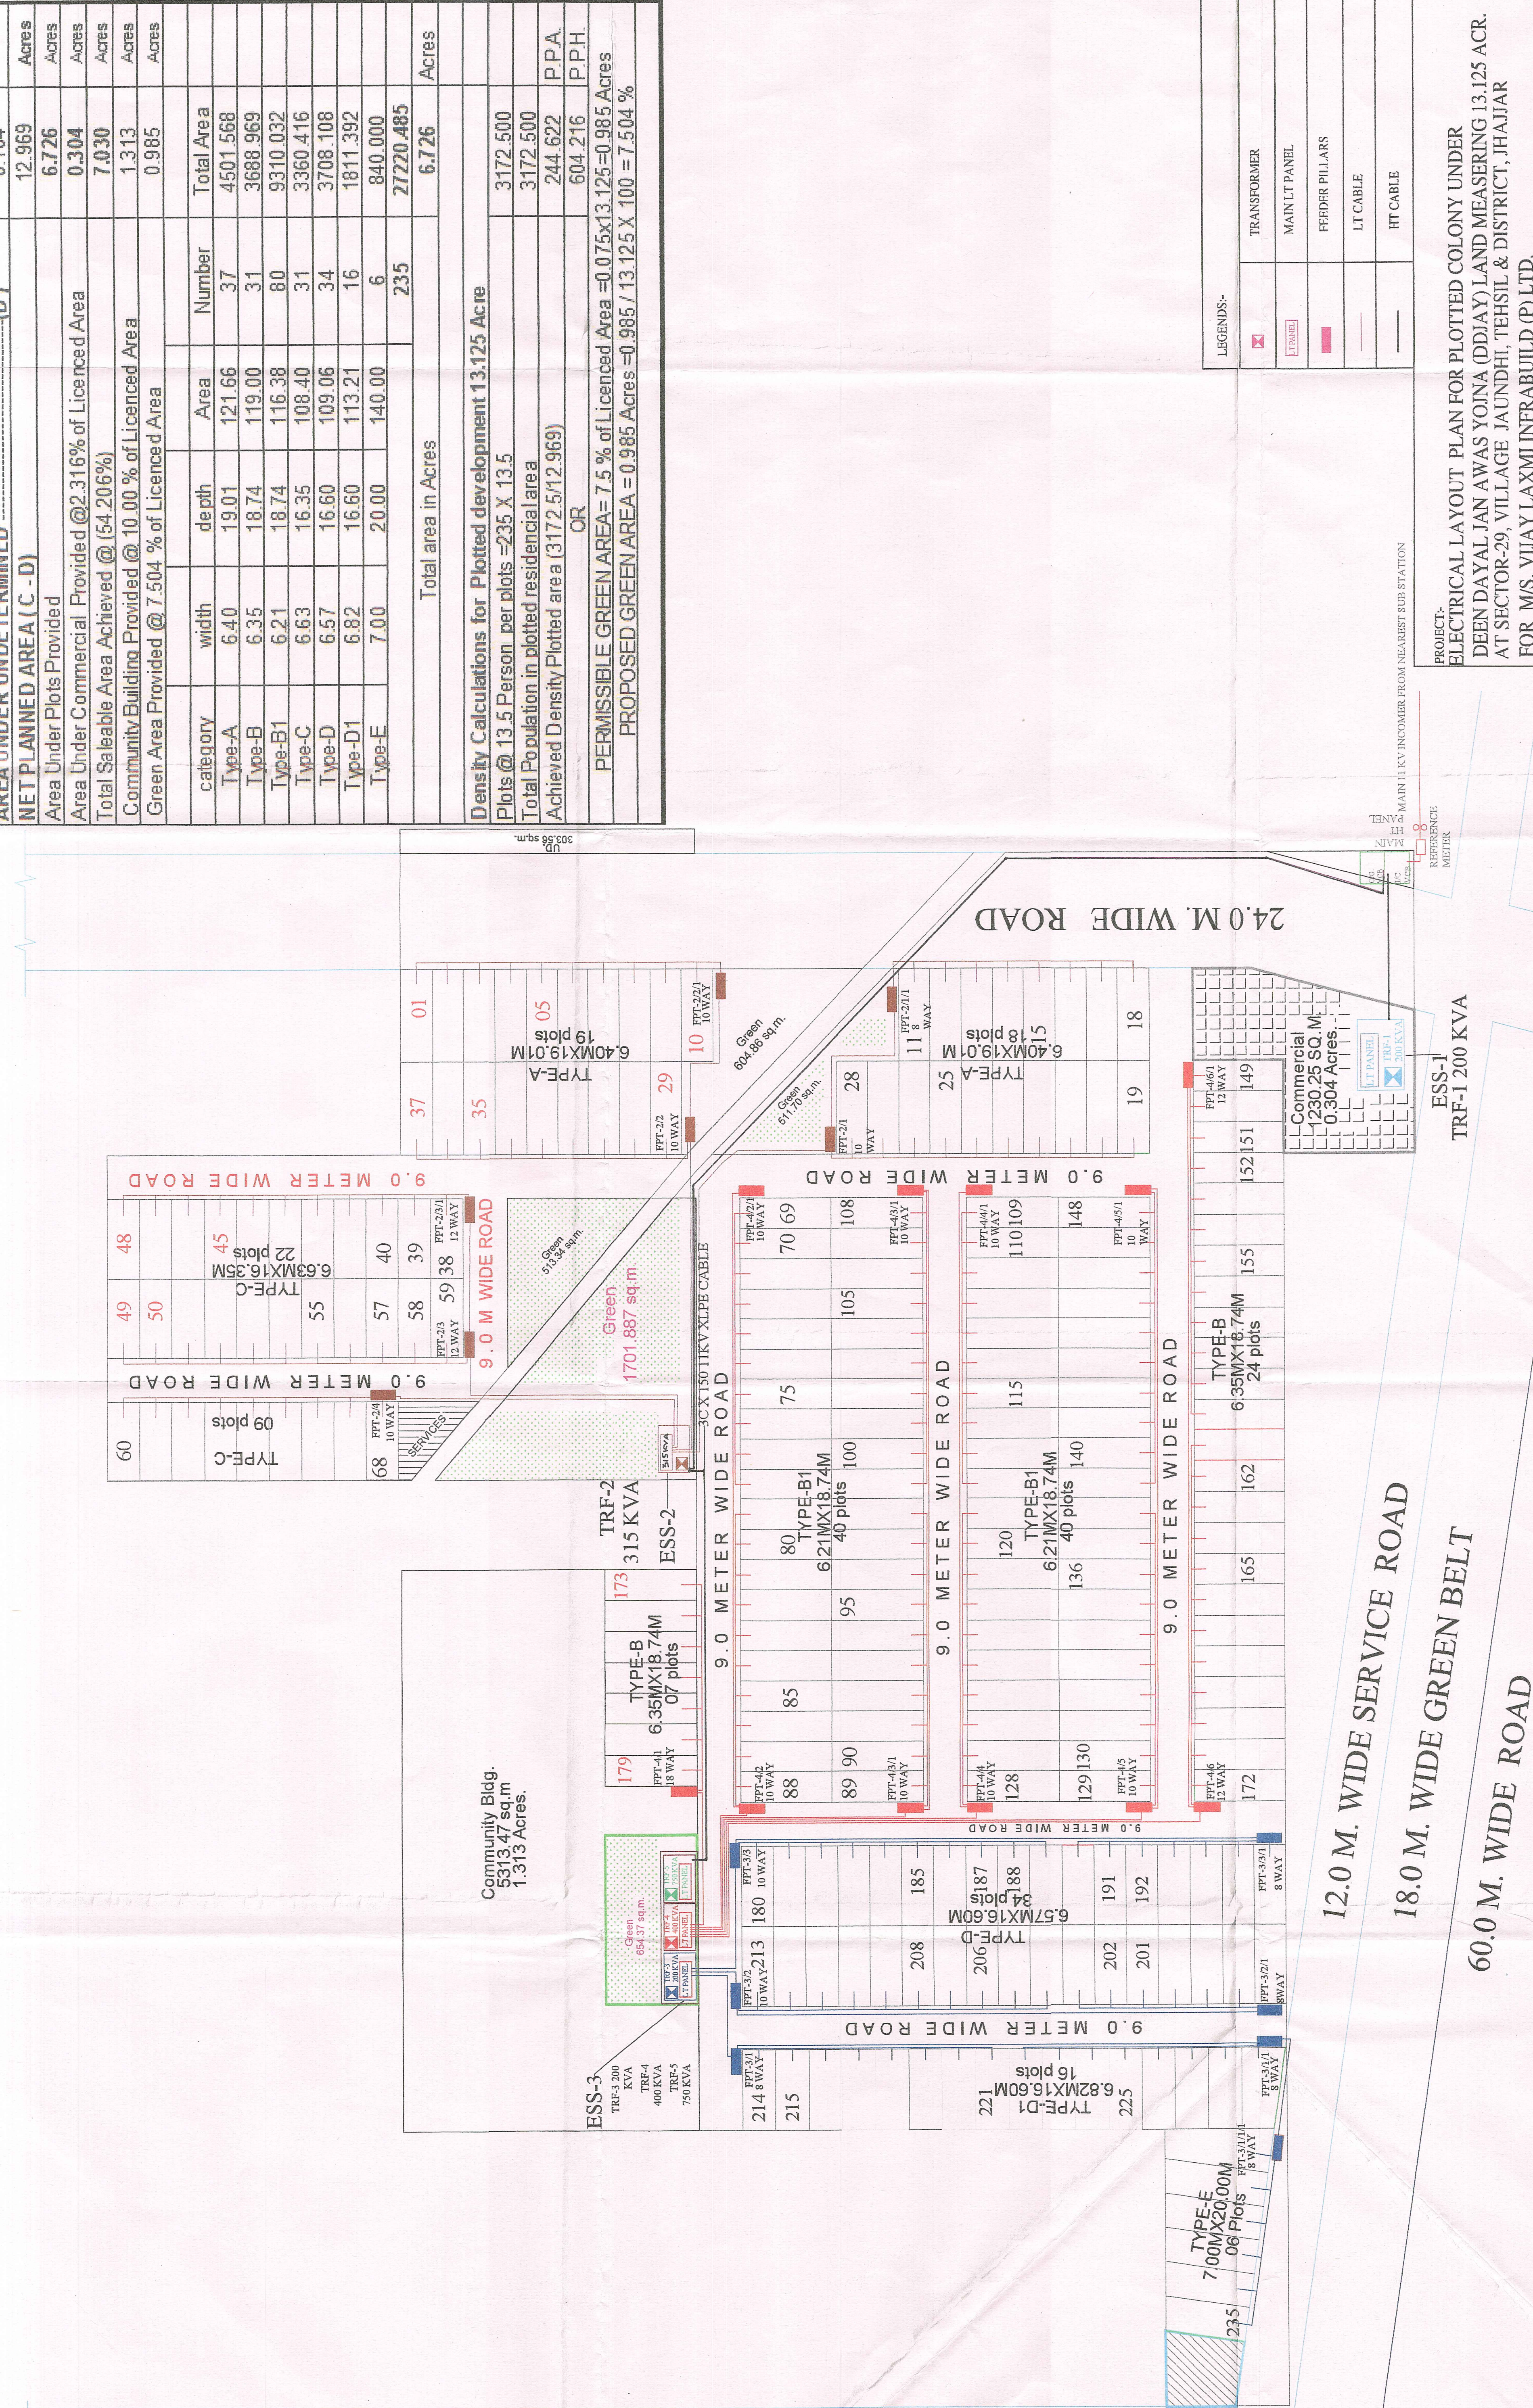

PROJECT:-
ELECTRICAL LAYOUT PLAN FOR PLOTTED COLONY UNDER
DEEN DAYAL JIAN AWAS YOINA (DDJAY) LAND MEASURING 13.125 ACR.
AT SECTOR-29, VILLAGE JAUNDHI, TEHSIL & DISTRICT, JHAJJAR
FOR M/S. VIJAY LAXMI INFRABUILD (P) LTD.

DRAWING TITLE:- MAIN ELECTRICAL LAYOUT PLAN

NAME OF OWNER
M/S. VIJAY LAXMI INFRABUILD (P) LTD.

NAME OF ARCHITECT
S.D.O. 'OP' CITY
UHBVN, JHAJJAR

SIGNATURE
(Signature)

SIGNATURE
(Signature)

DRG. NO.
MEP-EL-01

DATE
10/2018

SCALE
1:1000

REVISION
10/2018

- NOTE:
- 450MMX450MM CHAMBERS ARE MADE AT THE COMMON WALLS OF PLOTS FOR CONSUMERS SERVICE MAINS
 - 150MM DIA HDPE PIPES ARE LAID AT THE DEPTH OF 500MM FOR CONSUMERS SERVICE MAINS
 - 150 MM HDPE PIPES ARE USED FOR ROAD CROSSING FOR LAYING OF HT AND LT CABLES AT DEPTH OF 750MM FOR LT CABLES AND 1000MM FOR HT CABLES

Dr. Secretary/Technical
UHBVN, Panchkula