


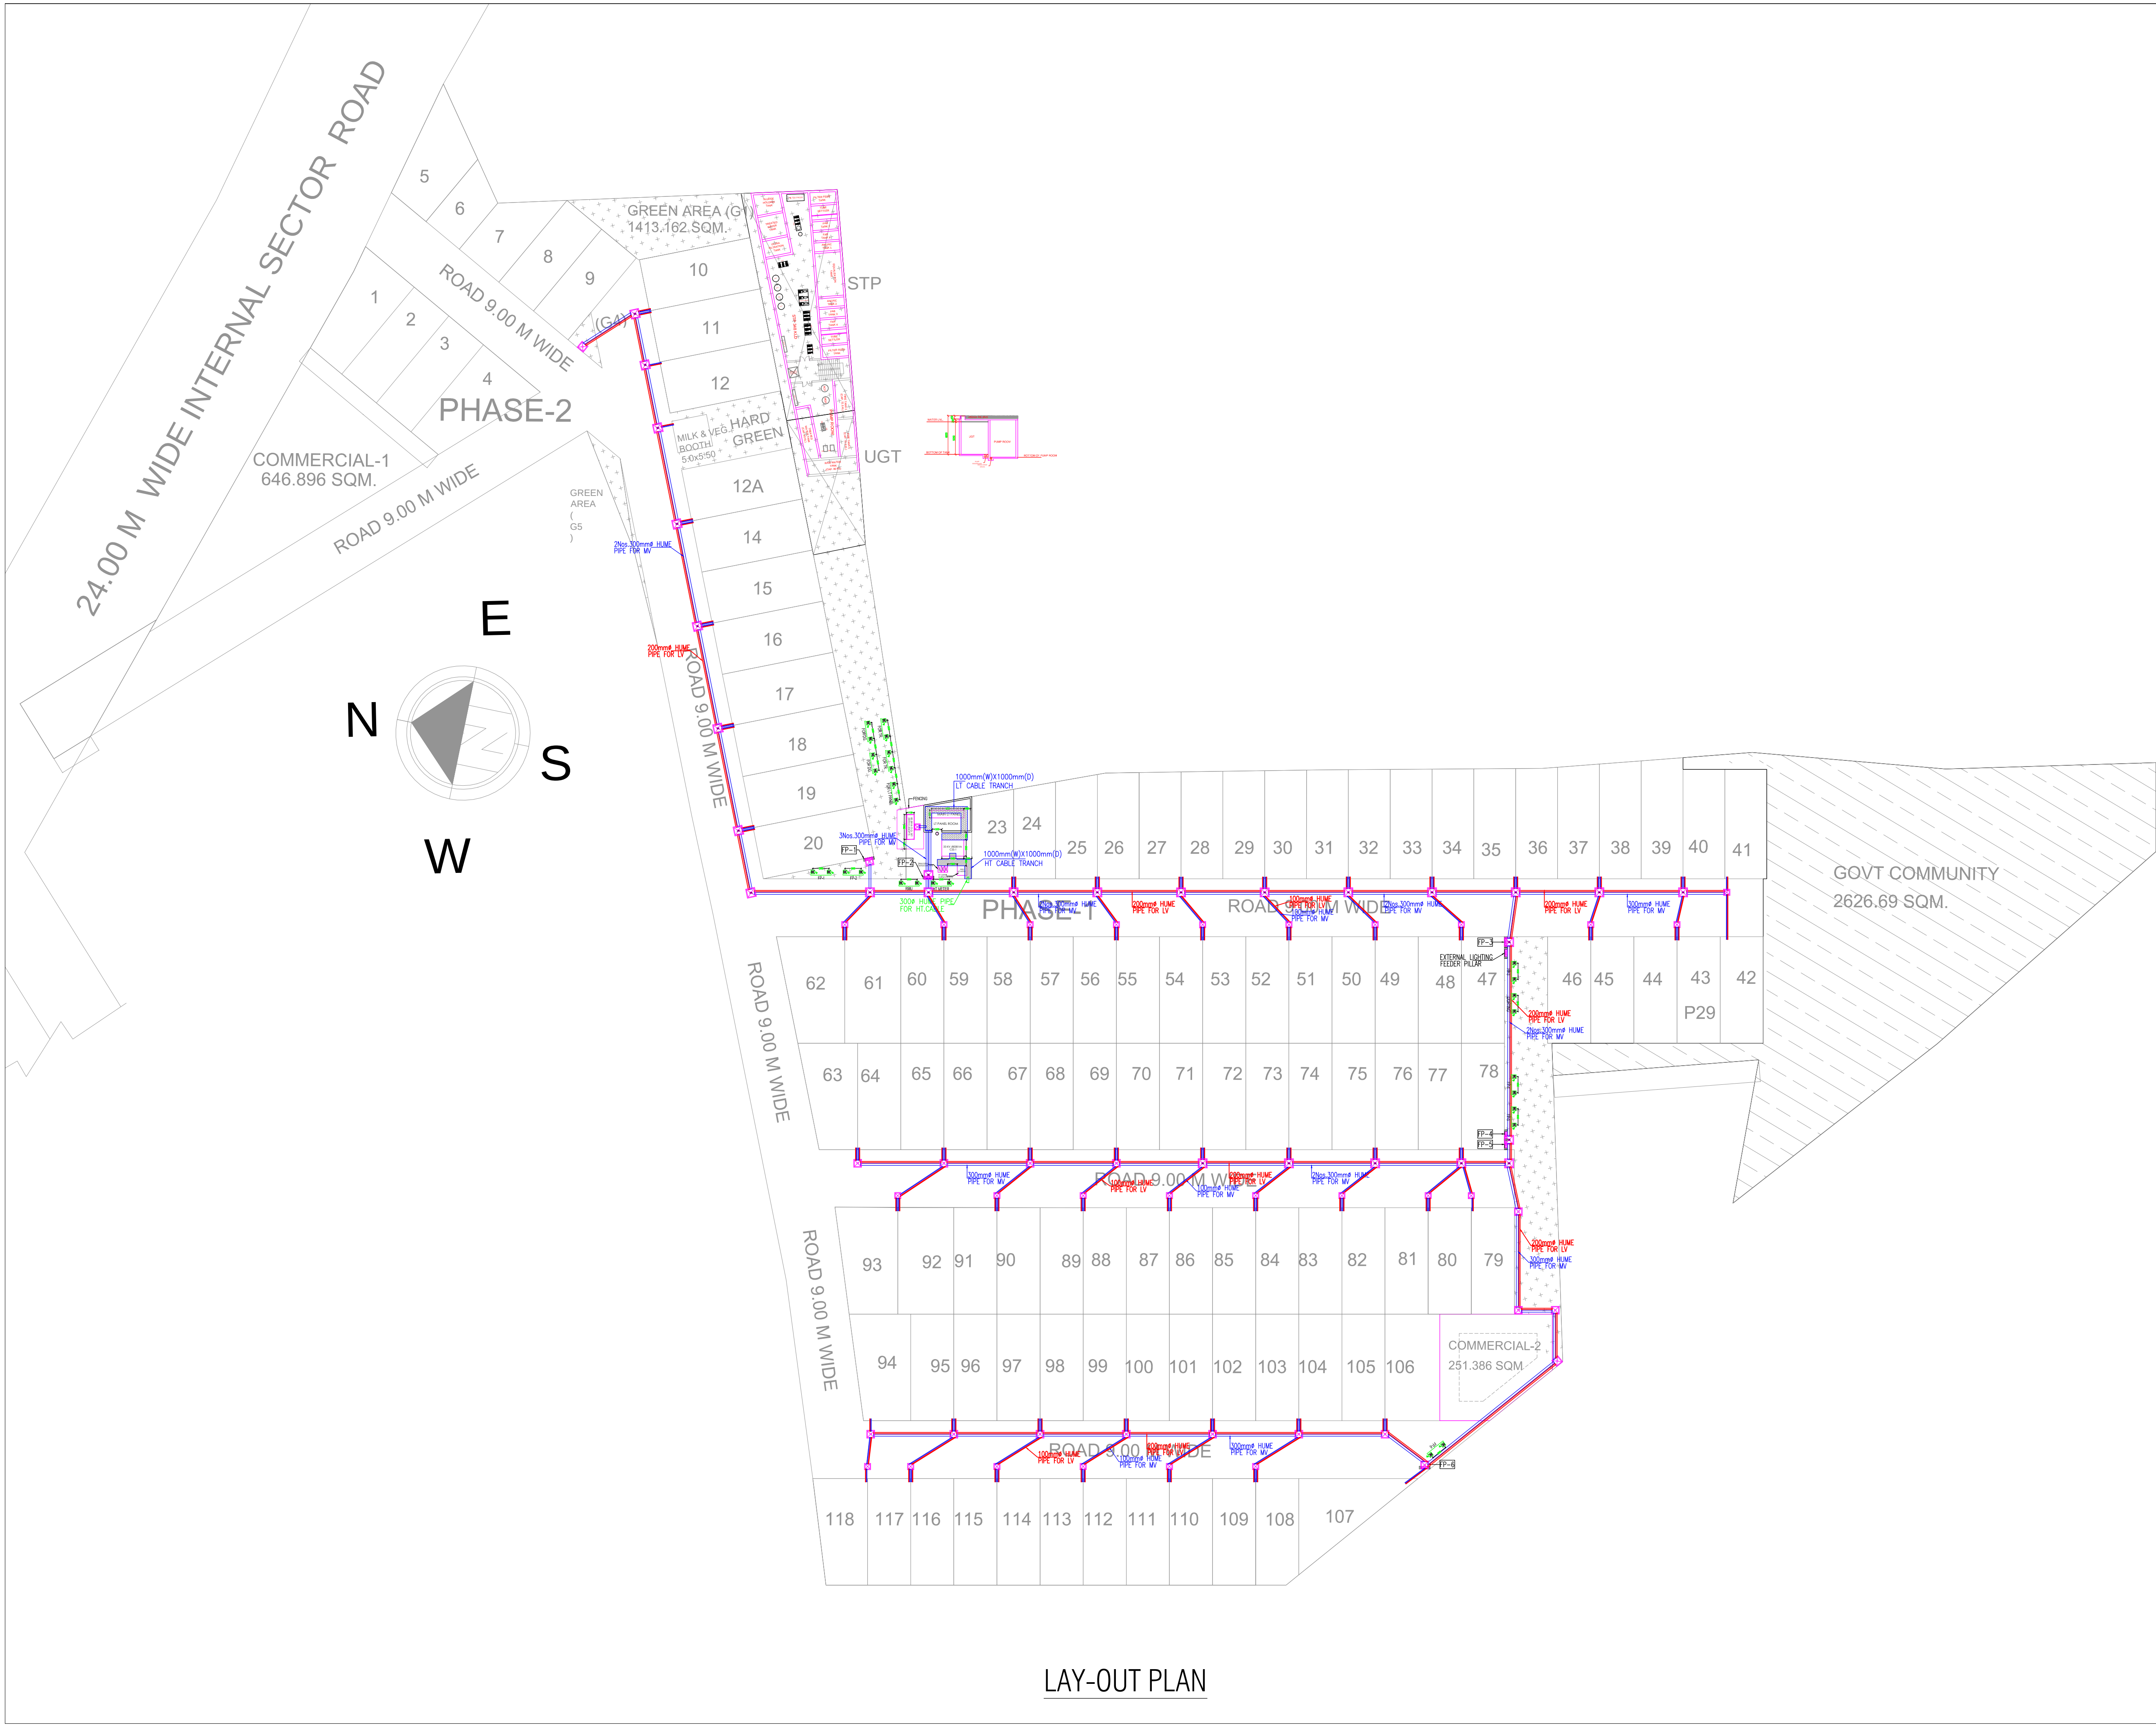

LEGEND	
SYMBOL	DESCRIPTION
	BODY EARTHING PIT
	NEUTRAL EARTHING PIT
	HUME PIPE FOR LV
	HUME PIPE FOR MV
	HUME PIPE FOR HT
	(750x750 WIDEX750MM DEEP MANHOLE) FOR LV & LT CABLE
	(1000x1000 WIDEX1200MM DEEP MANHOLE) FOR LV & LT CABLE
	(1200x1200 WIDEX1600MM DEEP MANHOLE) FOR LV & LT CABLE
	(1000x1000 WIDEX1500MM DEEP MANHOLE) FOR HT CABLE
	FEEDER PILLAR

DATE	REVISION	DESCRIPTION	BY
		B-50, BASEMENT, SOAMI NAGAR NEW DELHI-110017 TEL No: 011-49848197 & 49849205 EMAIL: INFO@VCONSULTING.CO.IN	
ARCHITECTS			
	RAO AND ASSOCIATE		
ARCHITECTS, PLANNERS, ENGINEERS, INTERIORS VALUERS 374,UDYOG VIHAR, PHASE-4, SEC-18 GURGAON,HARYANA (INDIA) PH. (0124) - 2347706, 2347707 FAX 0124 - 2347707			
PROJECT			
PROPOSED LAY-OUT PLAN OF AFFORDABLE PLOTTED COLONY (DDJAY) IN REVENUE ESTATE, VILLAGE SIKHOPUR & NAURANGPUR, SECTOR-78, DISTT. GURUGRAM (HR) LAND MEASURING 6.3012 ACRES (LC NO.-LC-4507-JE.(VA)-2021/29505 DATED 18-11-2021 BELONGING TO M/S-CONMIN INFRA DEVELOPERS LLP.			
TITLE:			
SITE PLAN ELECTRICAL LAYOUT AS PER PLOT			
DATE	11-05-2022		NORTH :
SCALE	1:450(A1)		
DRAWN.BY	HARENDRA		
CHKD.BY	ANIL KAMBOJ		
DRG.NO. : EL-EXT-01			