
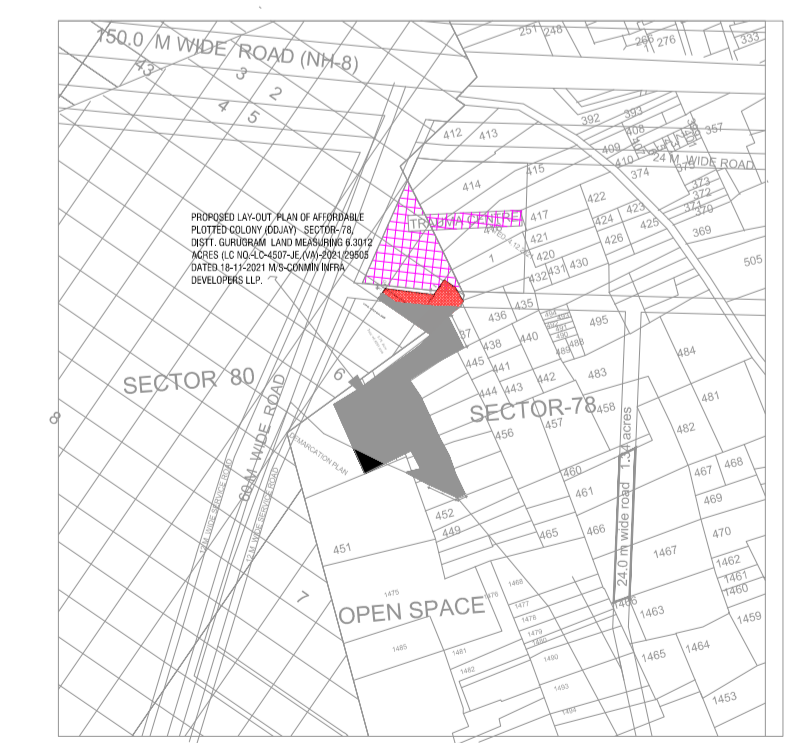


NOTE:- 150Ø SEWERAGE PIPE ROAD CROSSING RCC NP3 PIPE  
 200Ø DRAINAGE PIPE ROAD CROSSING RCC NP3 PIPE  
 CATCH BASIN ON ROAD (600X600X600)  
 SEWERAGE CHAMBER ON ROAD (600X600X700)

LEGEND FOR PLUMBING	
M.H. (C)	MANHOLE FOR SEWERAGE
□	SEWERAGE CHAMBER ON ROAD (600X600)IL-0.7
□	SEWERAGE CHAMBER IN PLOT (600X600)IL-0.6
—	SEWERAGE PIPE
—	SEWERAGE CHAMBER TO MANHOLE
DMH (C)	DRAINAGE MANHOLE
—	DRAINAGE PIPE
□	CATCH BASIN ON ROAD (600X600)IL-0.6
□	CATCH BASIN IN PLOT (450X450)IL-0.45
—	CATCH BASIN TO MANHOLE PIPE
○	RAIN WATER HARVESTING PIT SIZE = 3M DIA X5M DEPTH
—	COLD WATER SUPPLY LINE
—	FLUSHING WATER SUPPLY LINE
—	GARDEN HYDRANT LINE
●	GARDEN HYDRANT
⊗	BALL VALVE / BUTTER FLY VALVE
∨	NO-RETURN VALVE
—	EXTERNAL FIRE HYDRANT

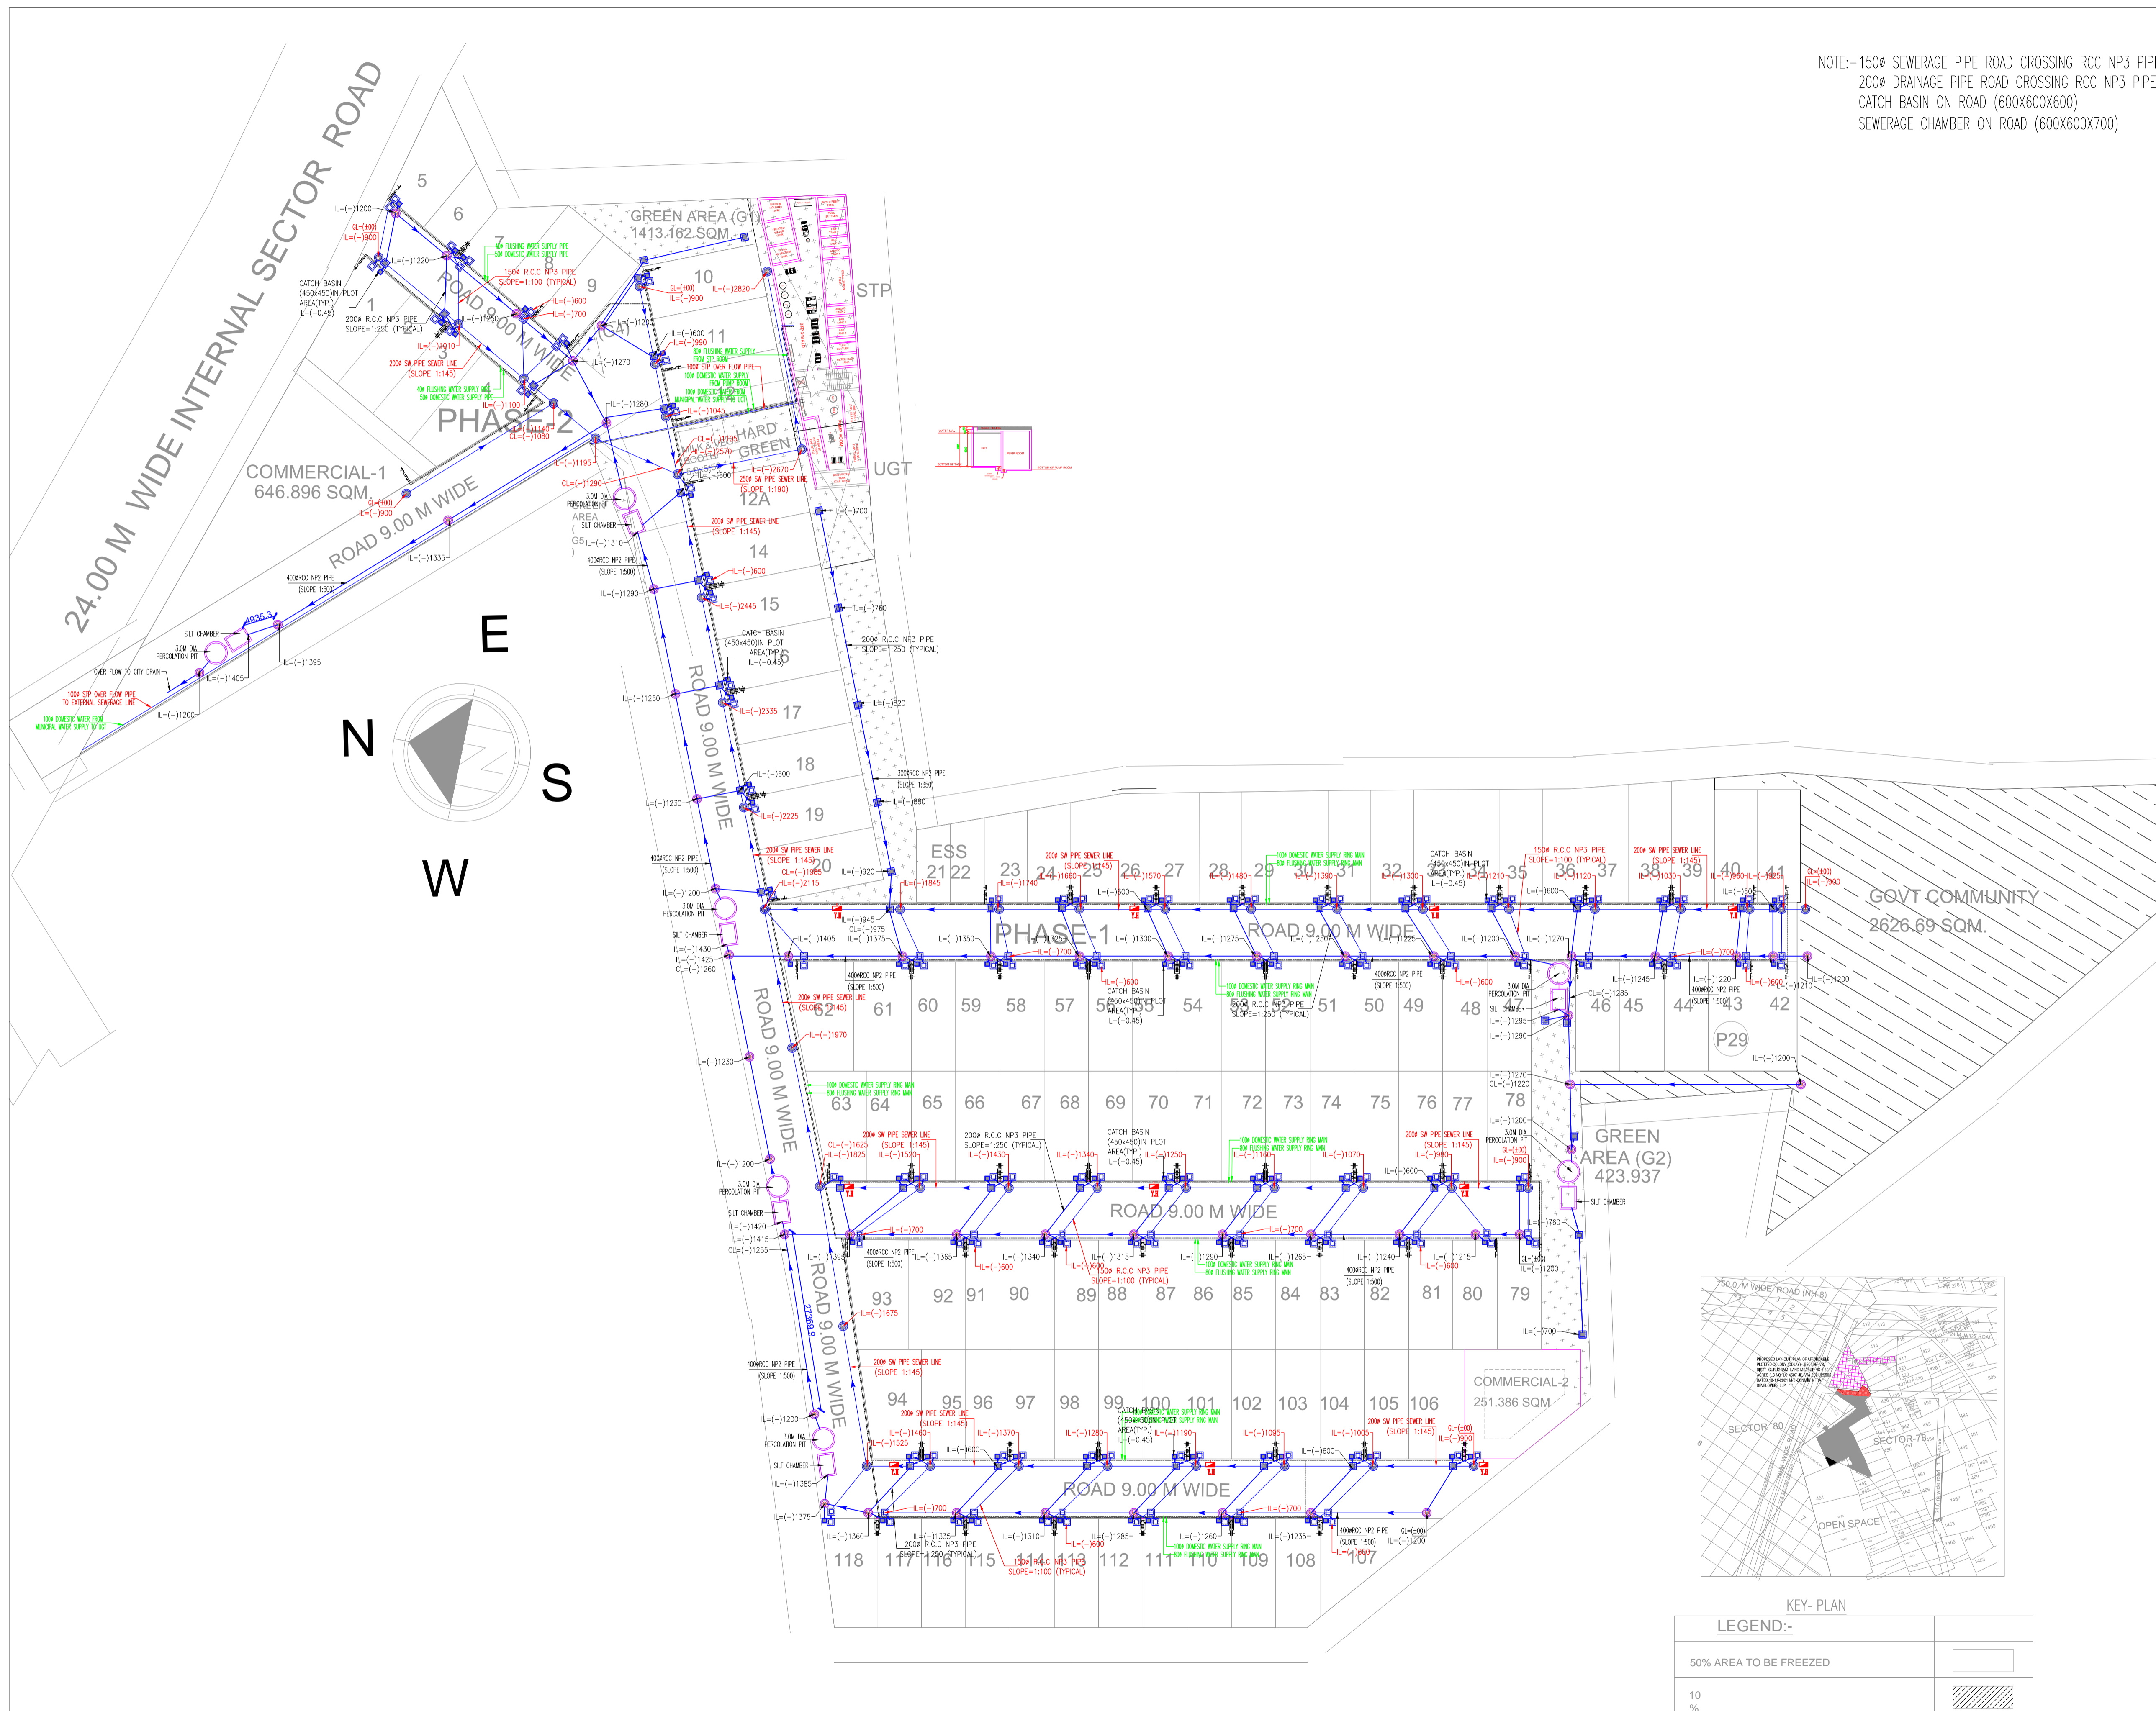

LEGEND:-

50% AREA TO BE FREEZED	
10 %	

DATE	REVISION	DESCRIPTION	BY

	B-50, BASEMENT, SOAMI NAGAR NEW DELHI-110017 TEL No: 011-49848197 & 49849205 EMAIL: INFO@VCONSULTING.CO.IN
	ARCHITECTS <b>RAO AND ASSOCIATE</b>

ARCHITECTS, PLANNERS, ENGINEERS, INTERIORS VALUERS  
 374,UDYOG VIHAR, PHASE-4, SEC-18 GURGAON,HARYANA (INDIA)  
 PH. (0124) - 2347706, 2347707 FAX 0124 - 2347707

PROJECT  
 PROPOSED LAY-OUT PLAN OF AFFORDABLE PLOTTED COLONY (DDJAY) IN REVENUE ESTATE, VILLAGE SIKHOPUR & NAURANGPUR, SECTOR-78, DISTT. GURUGRAM (HR) LAND MEASURING 6.3012 ACRES (LC NO.-LC-4507-JE.(VA)-2021/29505 DATED 18-11-2021 BELONGING TO M/S-CONMIN INFRA DEVELOPERS LLP.

TITLE:  
**SITE PLAN PLUMBING LAYOUT WITH STP**

DATE	06-06-2022
SCALE	1:450(A1)
DRAWN BY	ASIT
CHKD BY	VINOD

DRG.No. :