



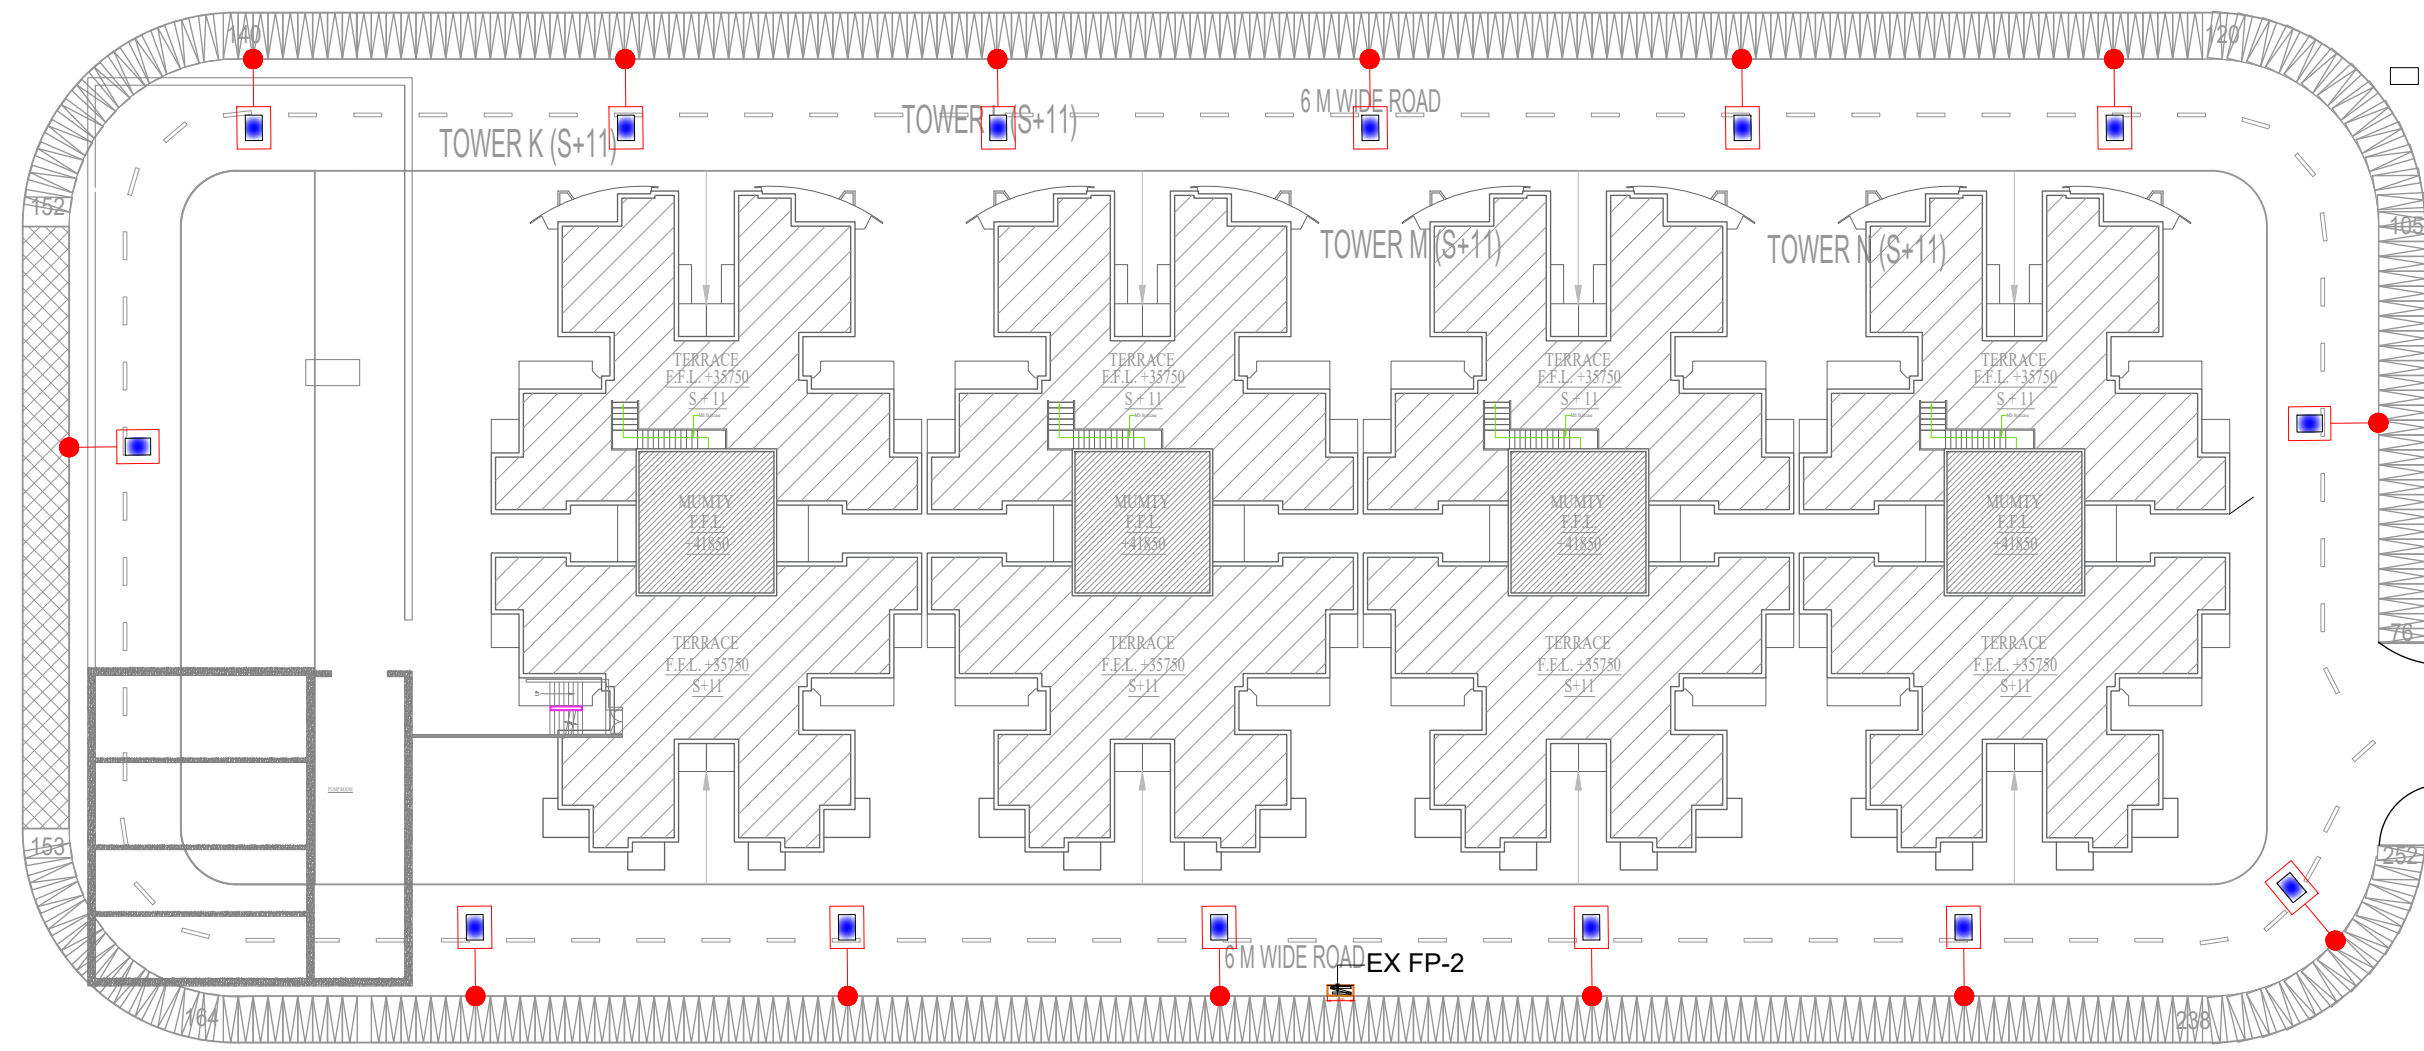


BOUNDARY WALL(230MM THICK)



BOUNDARY WALL (230MM THICK)
GREEN AREA
ZONING LINE

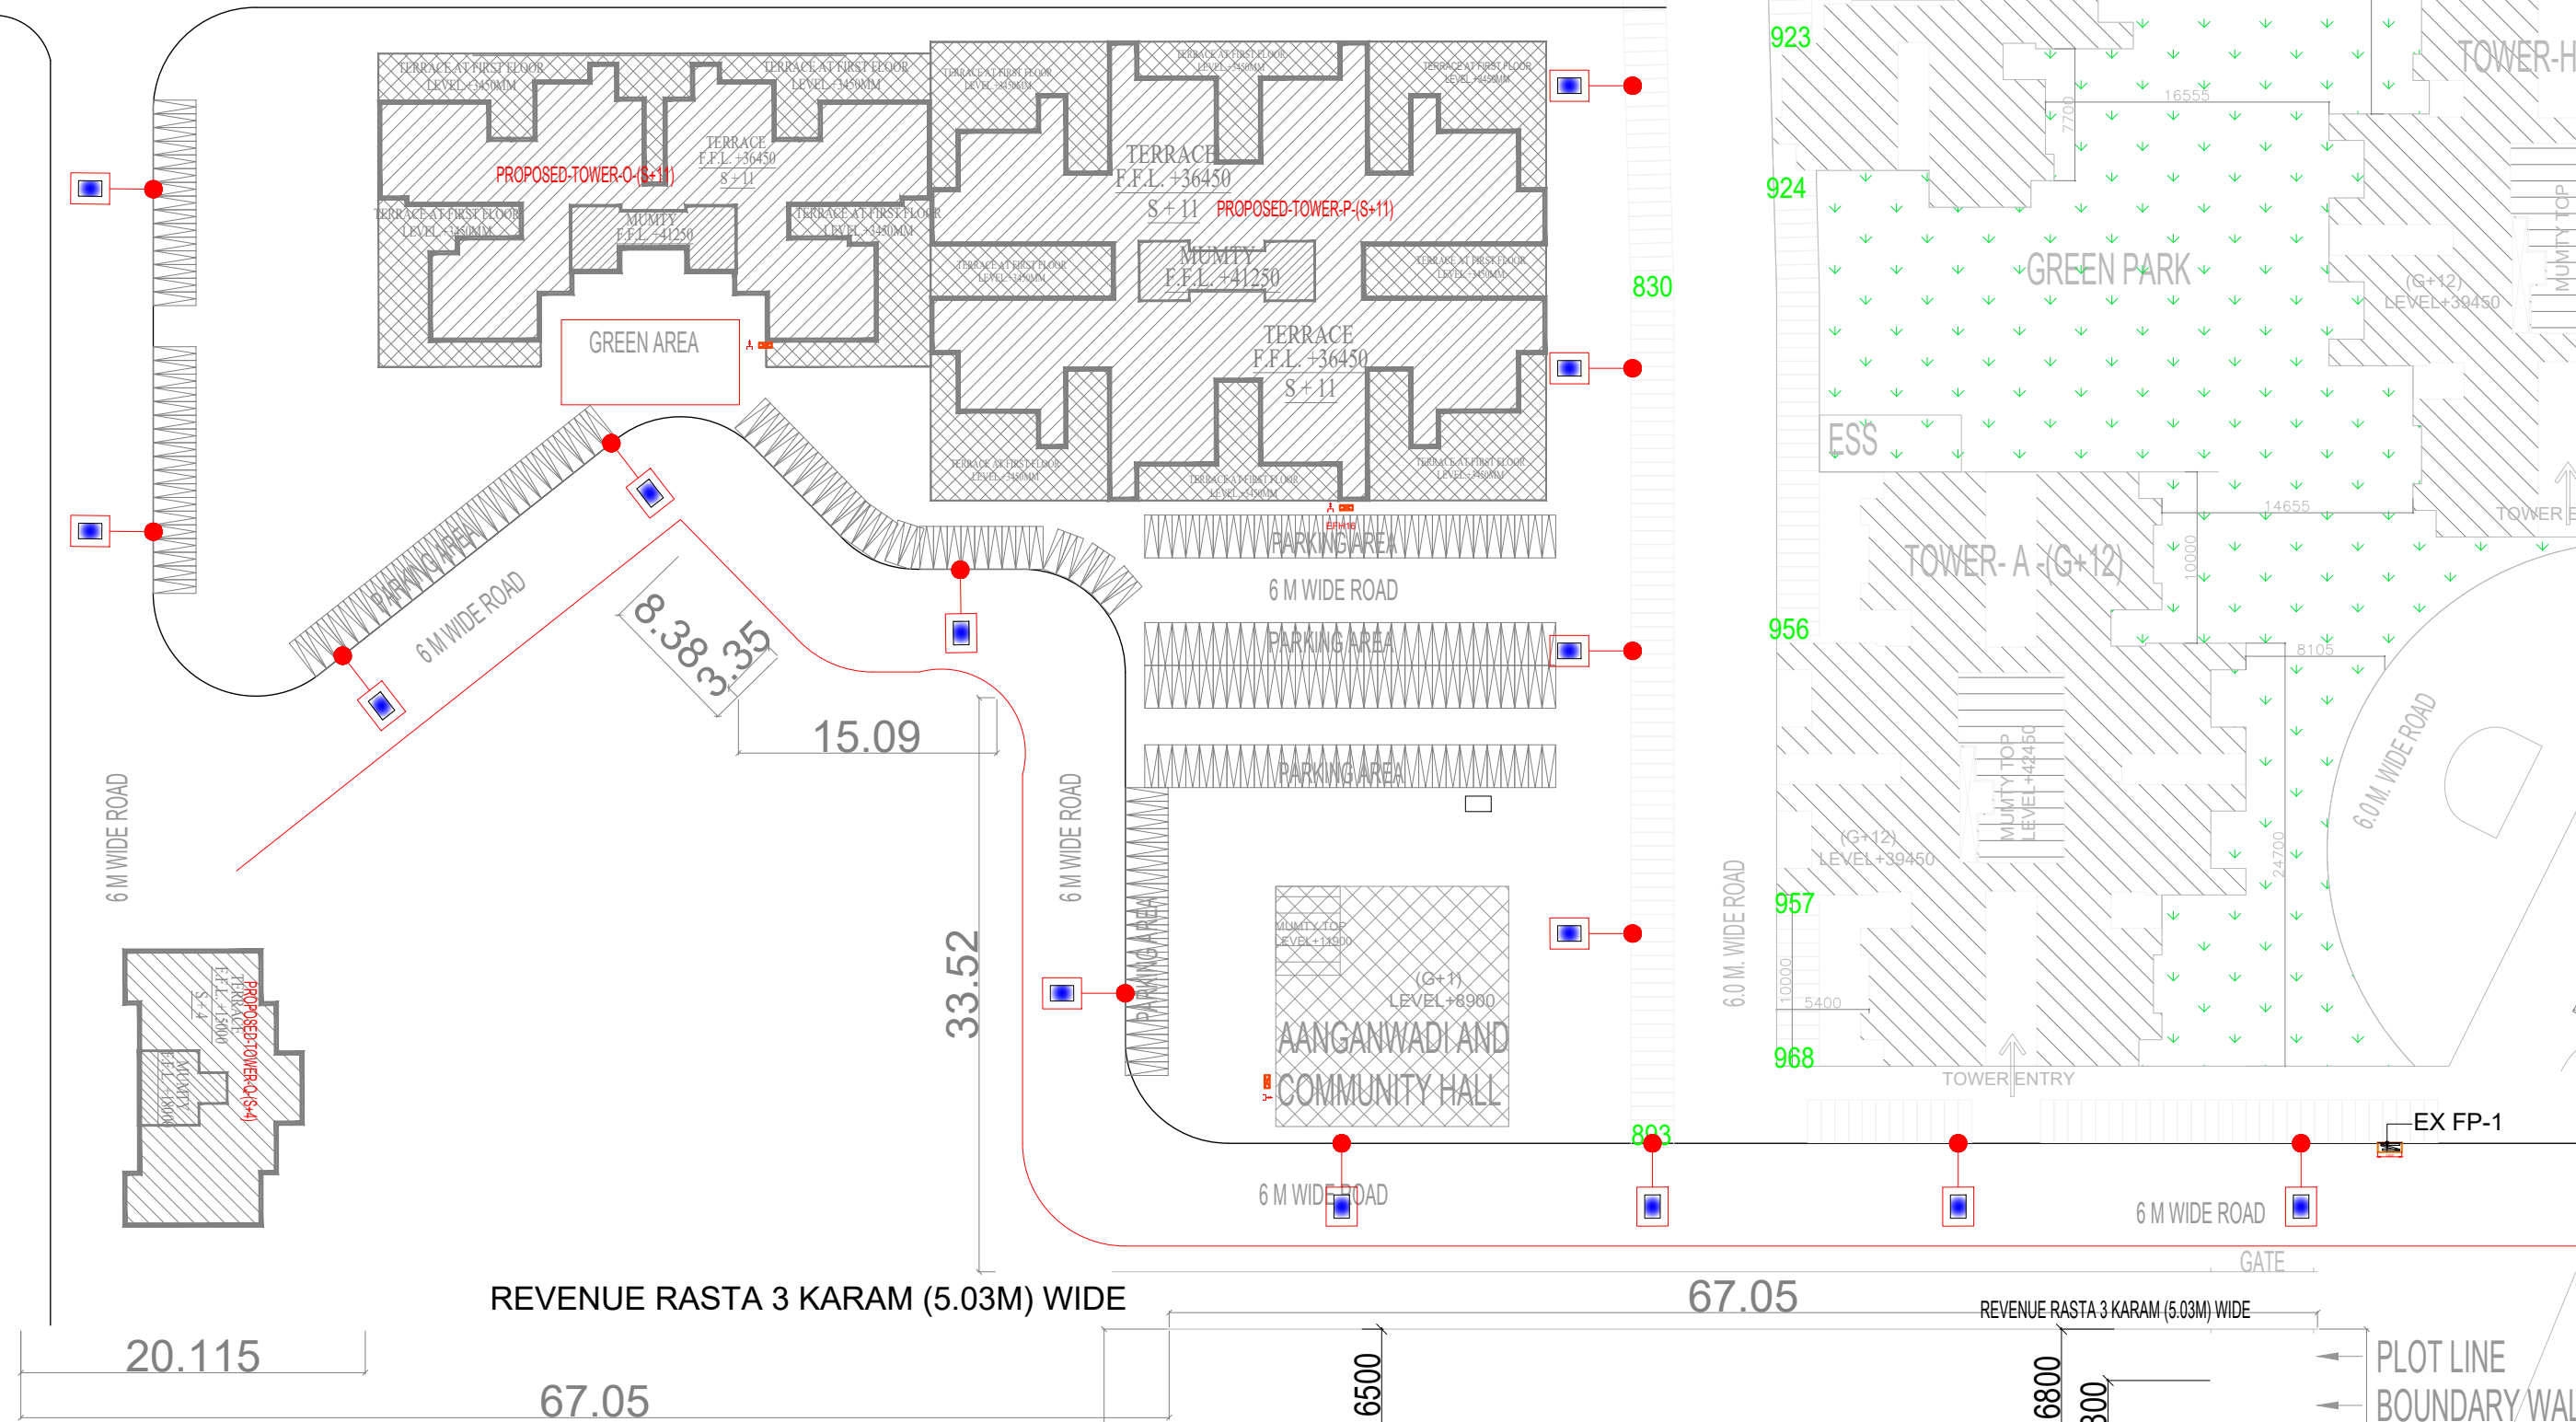

REVENUE RASTA 3 KARAM (5.03M) WIDE

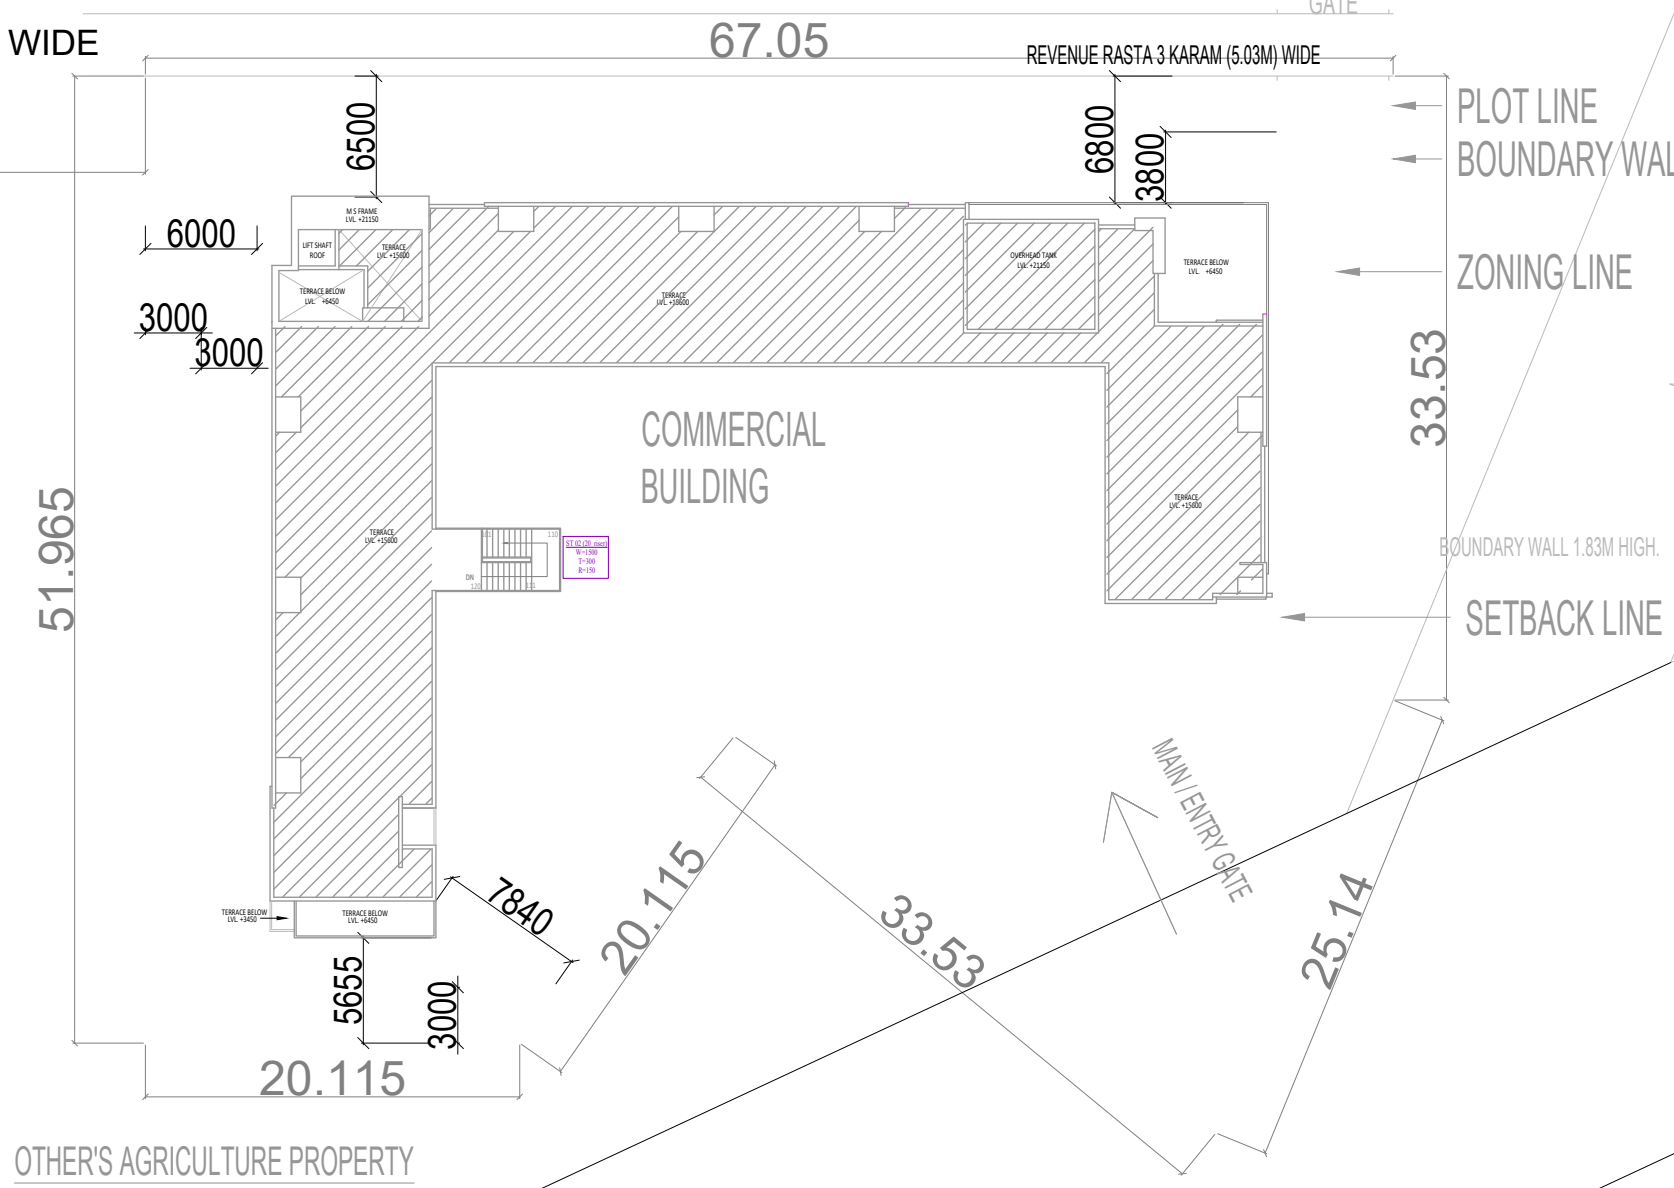

LEGENDS :-		QTY
70 WATT IP-65 LED STREET LIGHT FITTING POLE HEIGHT 6MTR.		31
FEEDER PILLER		02
4C650. MM AL.AR.CABLE		

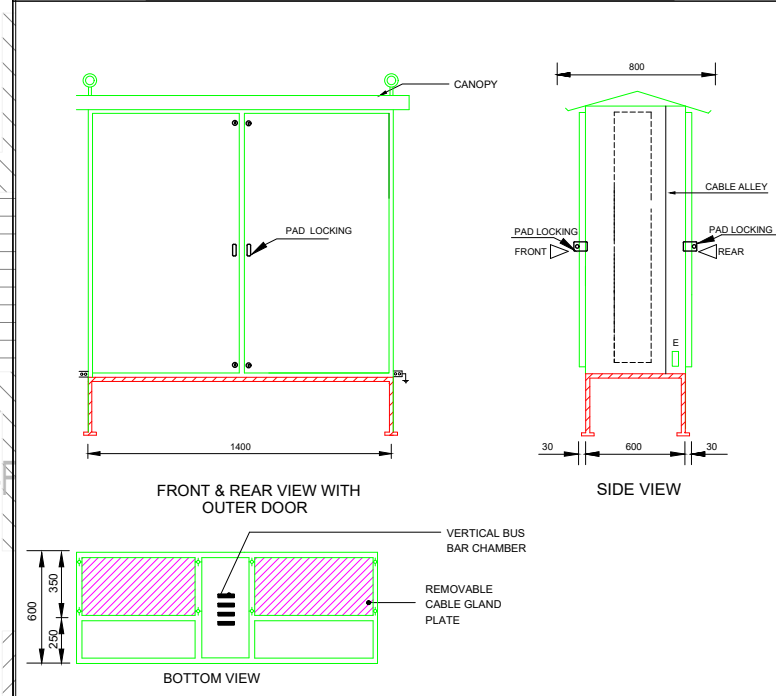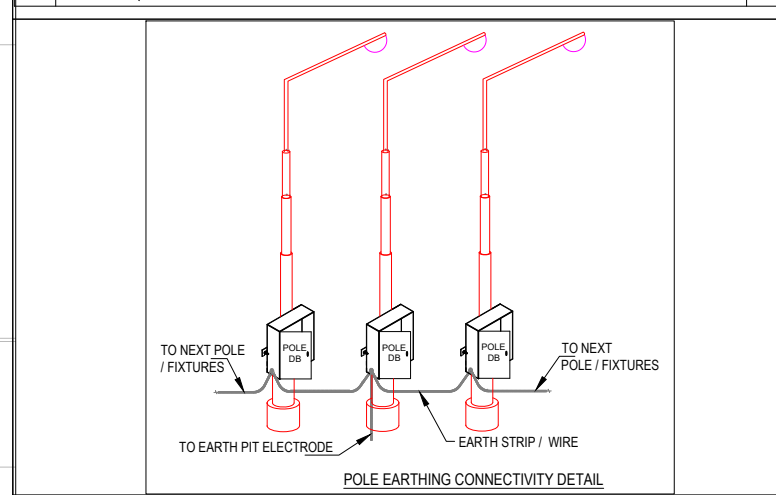

PRINCIPAL ARCHITECT:

OWNER'S SIGNATURE

ARCHITECT'S SIGNATURE

CLIENT:
GLS INFRA PROJETS PVT. LTD.

PROJECT:
REVISED AND PROPOSED BUILDING PLAN OF AFFORDABLE GROUP HOUSING COLONY OF LAND MEASURING 8.76875 ACRES (LICENCE NO.06 OF 2017 DATED 18/02/2017) AND (LICENCE NO.65 OF 2019 DATED 11/06/2019) IN THE REVENUE ESTATE OF VILLAGE WAZIRPUR AT SECTOR 92, DISSTT, GURUGRAM, BEING DEVELOPED BY GLS INFRA PROJETS PVT. LTD.

DRAWING TITLE:
ELECTRICAL EXTERNAL LIGHTING LAYOUT
SITE PLAN

	DRAWN :- RAJESH	
	CHECKED BY:- ARVIND	
	DRG.NO. EX-01	
	SCALE:- NTS	REV. NO.1
DATE:- 21-07-22		R0