


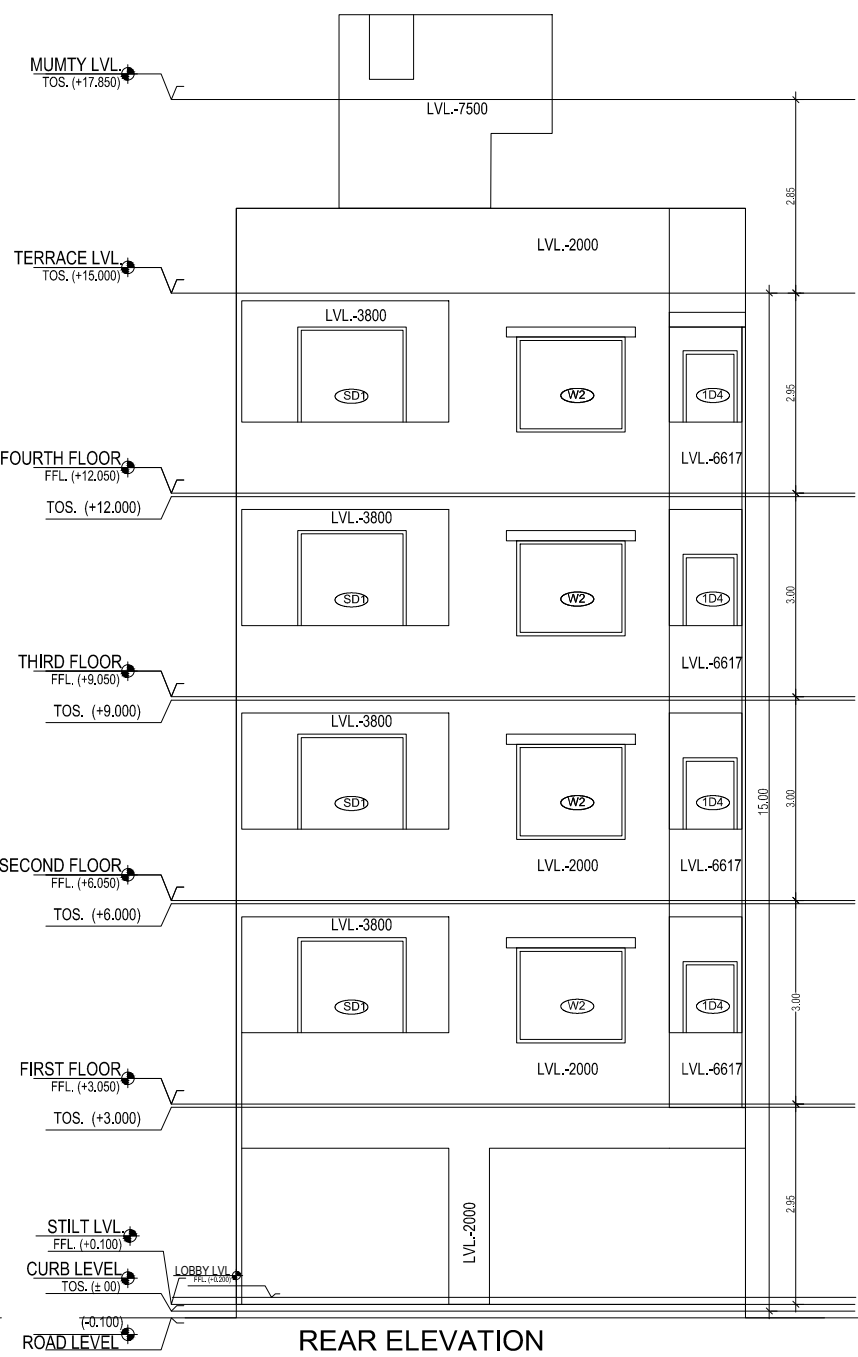
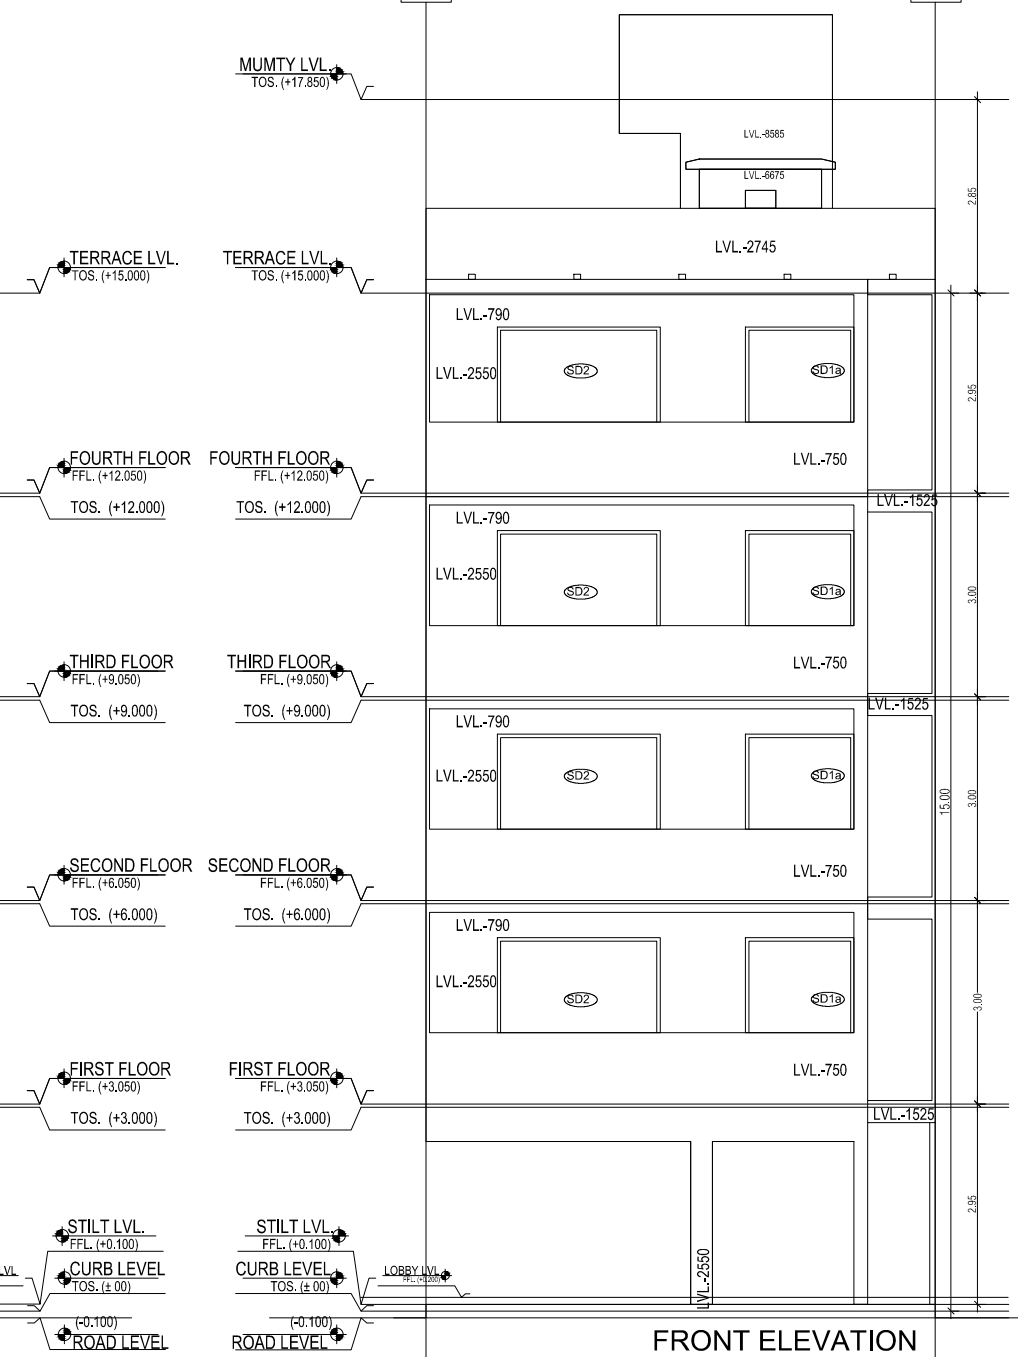
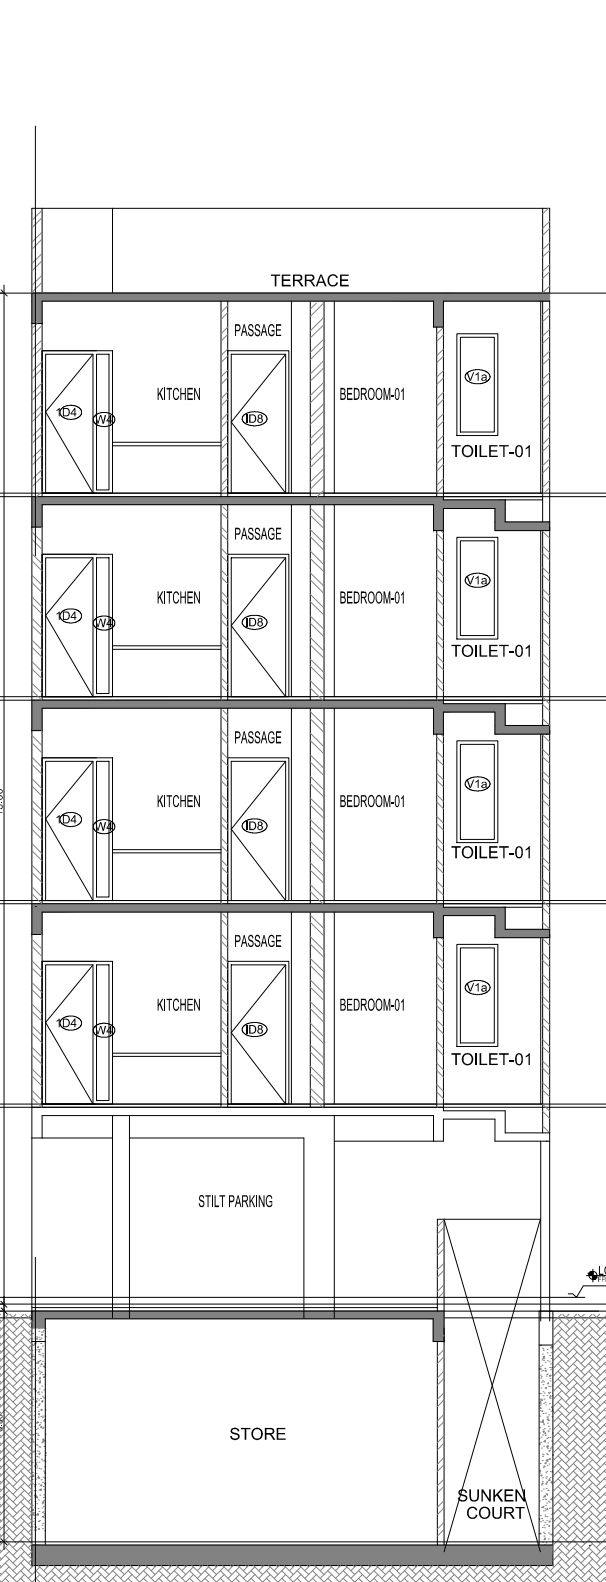
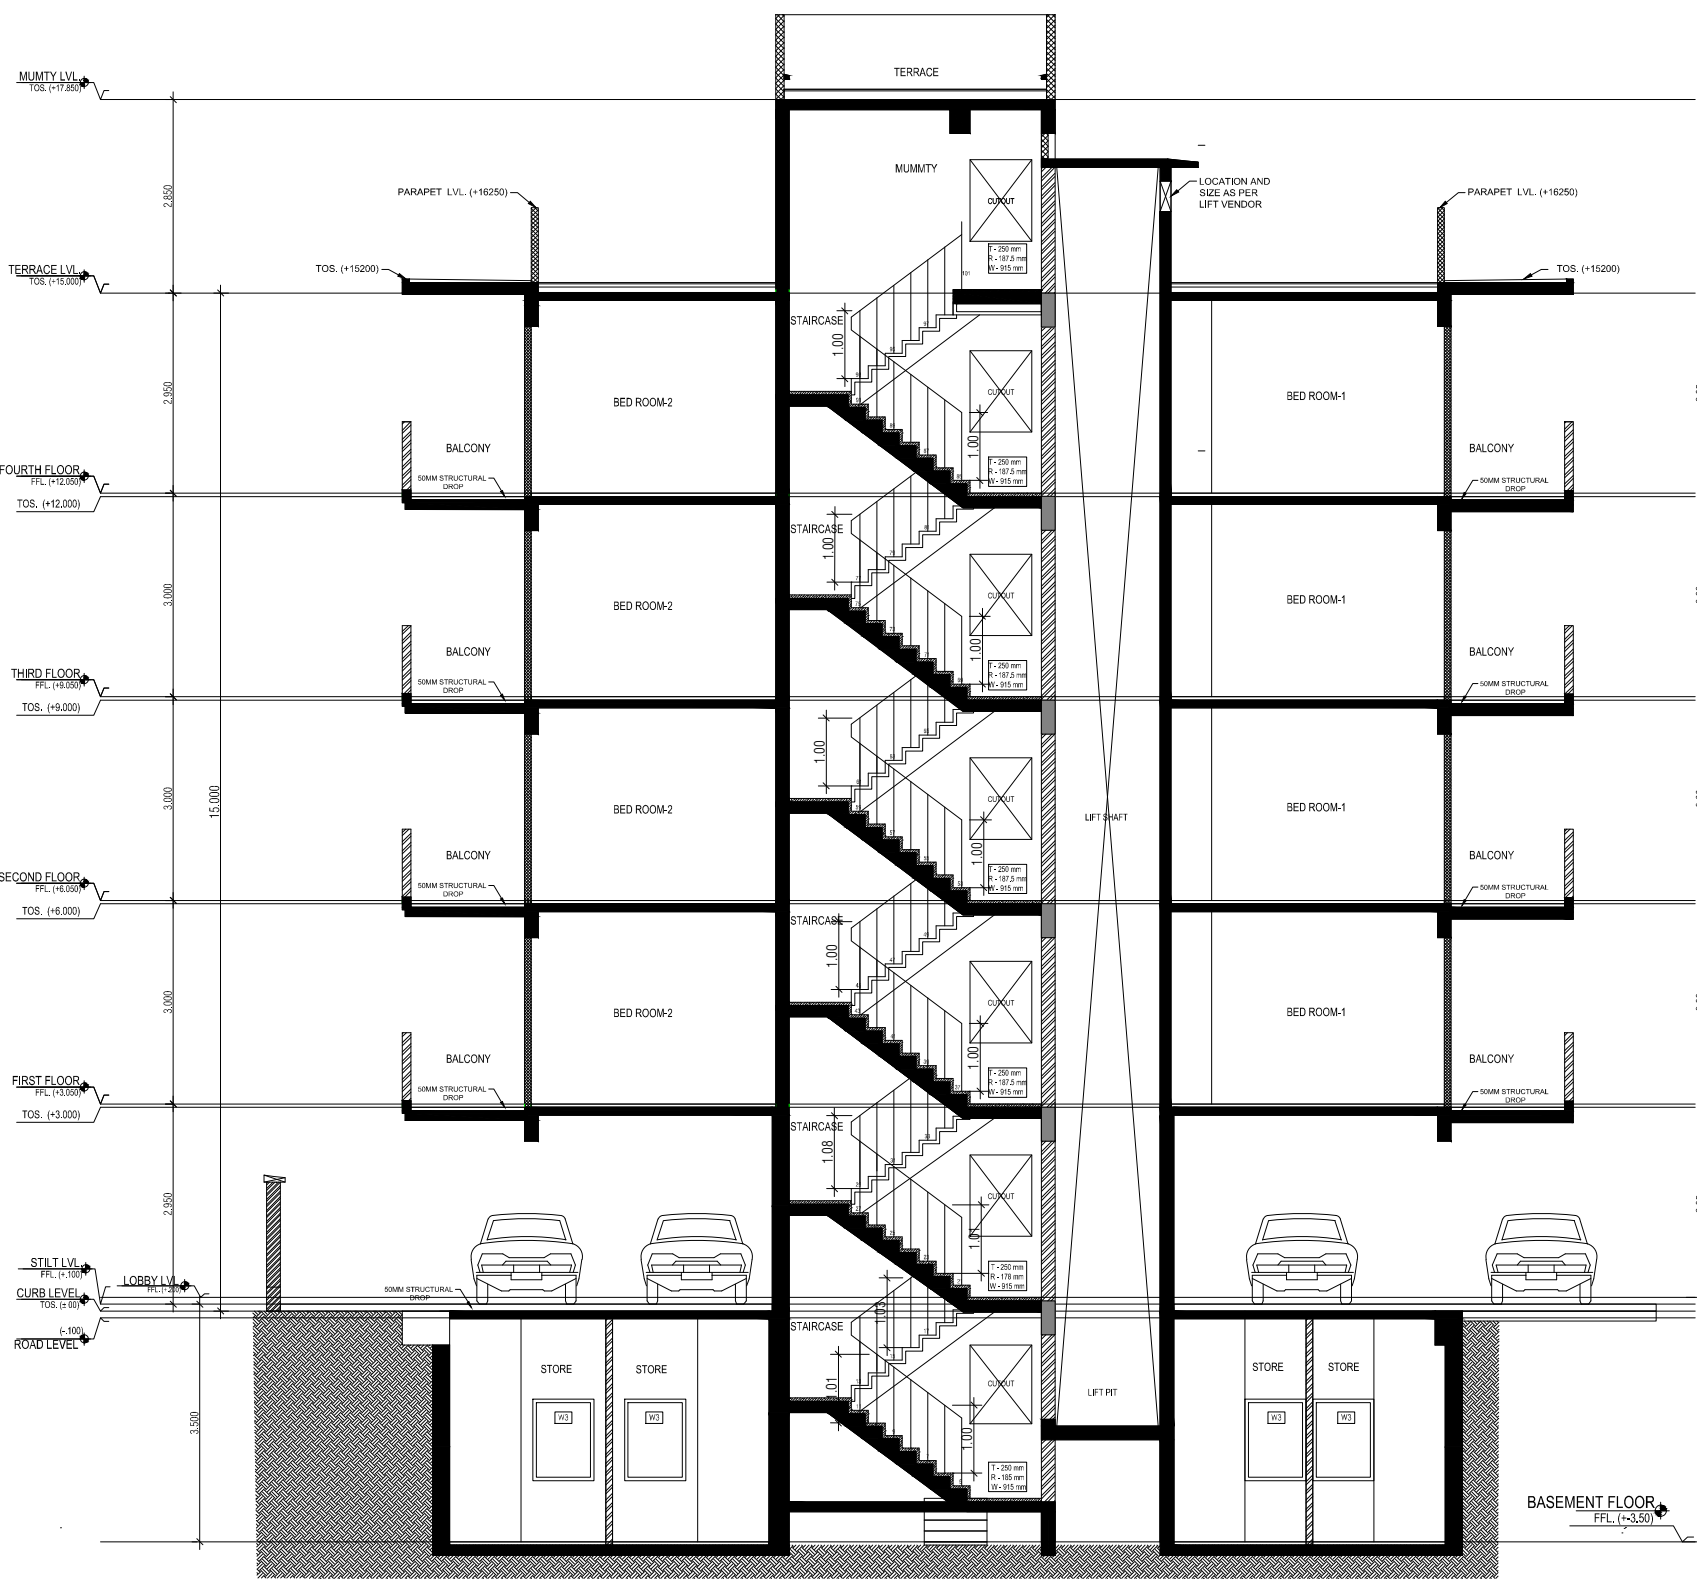
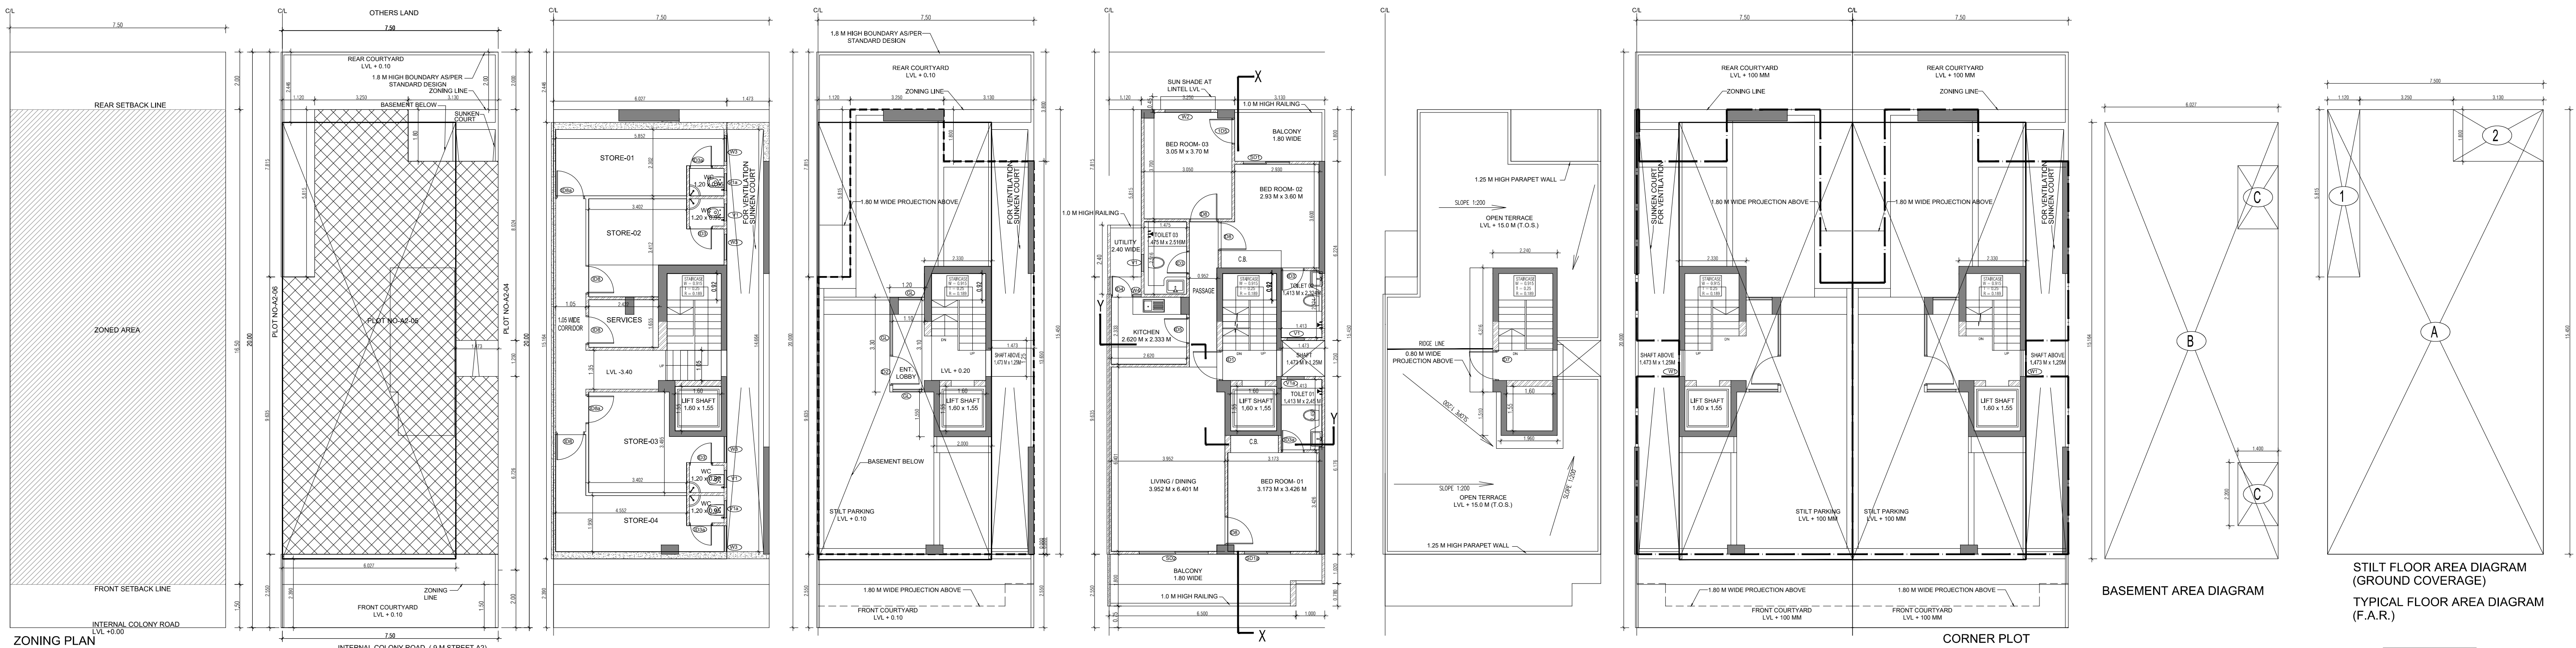
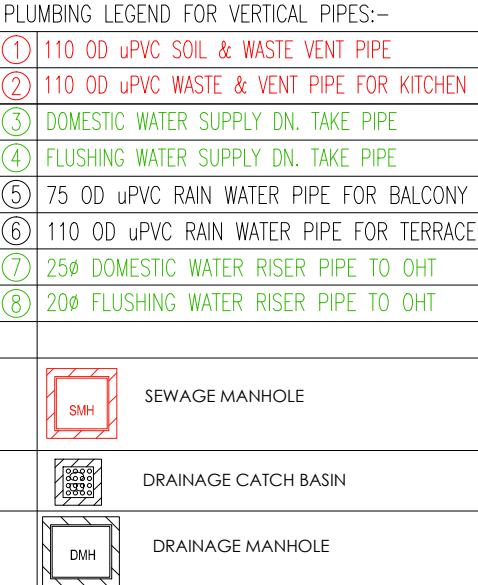


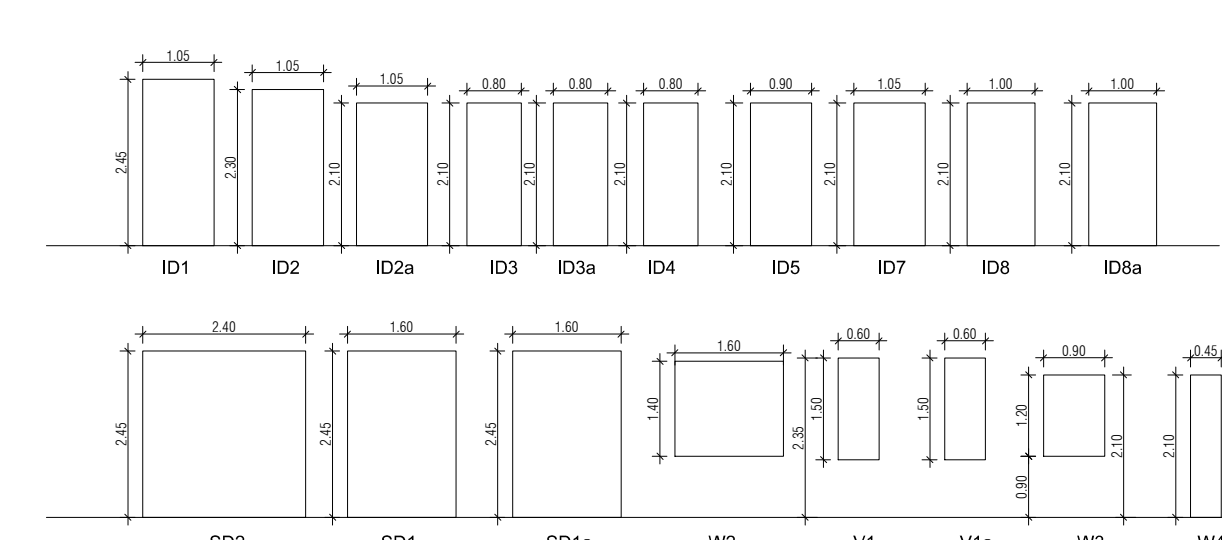

AREA CALCULATION		
	AREA	UNIT
TOTAL PLOT AREA (7.50 M x 20 M)	150	Sqmt
PERMISSIBLE FAR AS PER APPROVED ZONING PLAN @ 2.00	300	Sqmt
PURCHASEABLE FAR @ 0.64	96	Sqmt
TOTAL PERMISSIBLE FAR @ 2.64	296	Sqmt
PROPOSED FAR @ 2.63	394.936	Sqmt
PERMISSIBLE GROUND COVERAGE @ 75%	112.50	Sqmt
PROPOSED GROUND COVERAGE @ 69.15 %	103.728	Sqmt
AREA OF STILT FLOOR (GROUND COVERAGE)		
A	7.5 x 15.450 x 1	115.875 Sqmt
TOTAL		115.875 Sqmt
DEDUCTION (D)		
1	1.12 x 5.815 x 1	6.513 Sqmt
2	3.13 x 1.800 x 1	5.634 Sqmt
TOTAL		12.147 Sqmt
PROPOSED GROUND COVERAGE = A - D		103.728 Sqmt
AREA CALCULATION FOR TYPICAL FLOOR (1st to 4th FLOOR)		
TOTAL AREA ON GROUND COVERAGE (X)		103.728 Sqmt
DEDUCTION		
4 (STAIRCASE)	1.880 x 3.715 x 1	6.984 Sqmt
5	1.600 x 1.550 x 1	2.480 Sqmt
3	1.473 x 1.250 x 1	1.842 Sqmt
TOTAL (Y)		11.305 Sqmt
TOTAL AREA OF TYPICAL FLOOR (X-Y)		92.423 Sqmt
BASEMENT BUILT UP AREA		
B	6.027 x 15.164 x 1	91.393 Sqmt
TOTAL		91.393 Sqmt
BASEMENT F.A.R. AREA		
C	1.400 x 2.200 x 2	6.160 Sqmt
TOTAL		6.160 Sqmt
NET NON F.A.R. AREA OF BASEMENT		
B-C		85.233 Sqmt
TOTAL		85.233 Sqmt
STILT FAR		
E	2.333 x 4.365 x 1	10.184 Sqmt
F	2.000 x 1.550 x 1	3.100 Sqmt
G	1.473 x 1.250 x 1	1.842 Sqmt
J	1.2 x 3.300 x 1	3.960 Sqmt
TOTAL		19.085 Sqmt
MUMTY AREA		
H	1.960 x 1.51 x 1	2.960 Sqmt
I	2.24 x 4.32 x 1	9.660 Sqmt
TOTAL		12.627 Sqmt
PROJECTION AREA		
6.500 x 1.800 x 1		11.700 Sqmt
1.000 x 1.020 x 1		1.020 Sqmt
1.120 x 1.800 x 1		2.016 Sqmt
3.050 x 1.800 x 1		5.490 Sqmt
TOTAL		20.226 Sqmt
GROUND COVERAGE CALCULATION		
STILT FLOOR AREA, STAIRCASE, LIFT SHAFT INCLUDED		103.728 Sqmt
TOTAL GROUND COVERAGE ACHIEVED		103.728 Sqmt
FAR CALCULATION		
TYPICAL FLOOR AREA x 4		369.692 Sqmt
FAR AREA ON BASEMENT		6.160
FAR AREA ON STILT		19.085 Sqmt
TOTAL FAR ACHIEVED		394.936 Sqmt
BUILT UP AREA CALCULATION		
BASEMENT AREA (FAR-NON FAR) + COVERAGE		696.201 Sqmt
AT STILT AREA + FLOOR AREA + STAIR CASE x 4 + MUMTY AREA + PROJECTION AREA x 4		

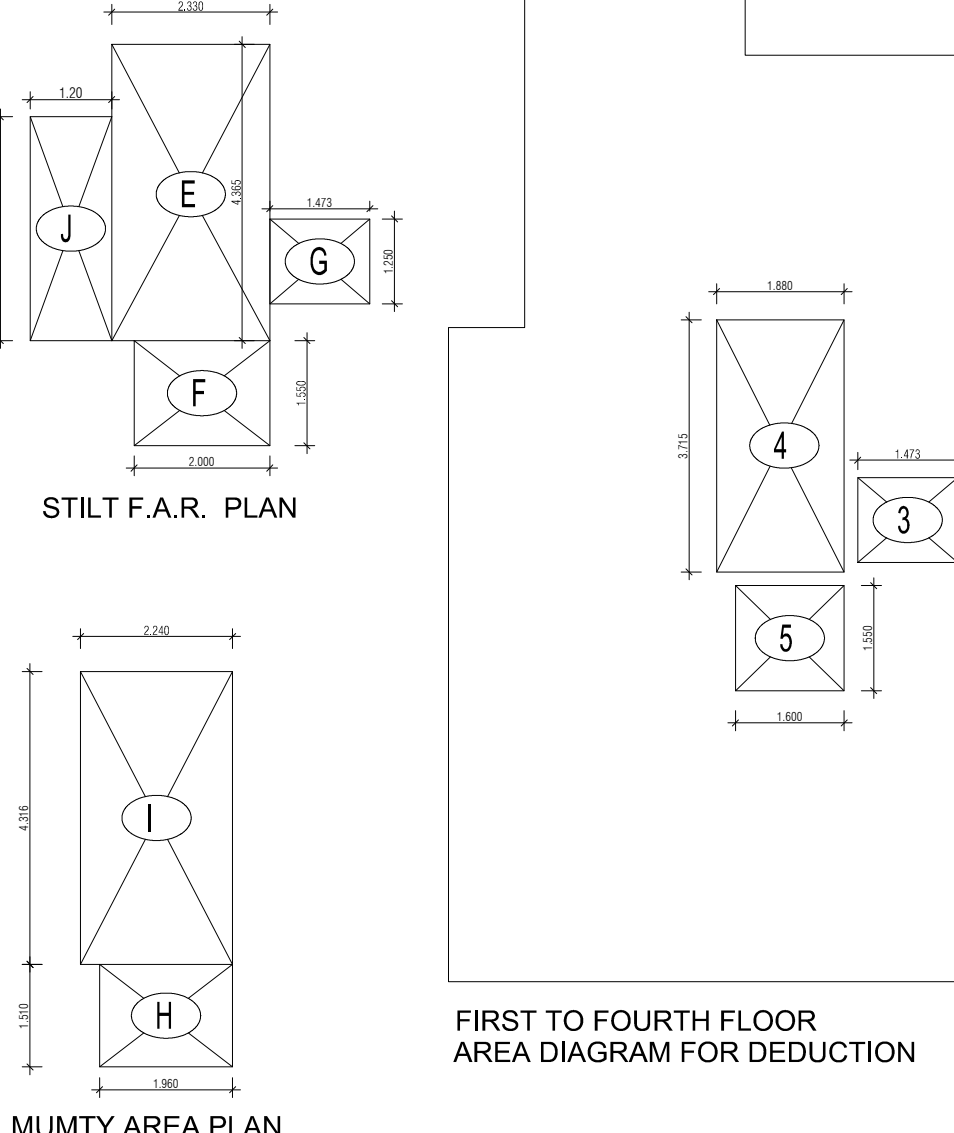

NO	LEADER	WIDTH (MM)	DEPTH (MM)	CALL LVL (FROM FFL)	UNIT LVL (FROM FFL)
1	110 OD uPVC SOIL & WASTE VENT PIPE	110	200	0	2400
2	110 OD uPVC WASTE & VENT PIPE FOR KITCHEN	110	200	0	2300
3	DOMESTIC WATER SUPPLY DN. TAKE PIPE	25	200	0	2100
4	FLUSHING WATER SUPPLY DN. TAKE PIPE	25	200	0	2100
5	75 OD uPVC RAIN WATER PIPE FOR BALCONY	75	200	0	2100
6	110 OD uPVC RAIN WATER PIPE FOR TERRACE	110	200	0	2100
7	25# DOMESTIC WATER RISER PIPE TO OHT	25	200	0	2100
8	20# FLUSHING WATER RISER PIPE TO OHT	20	200	0	2100

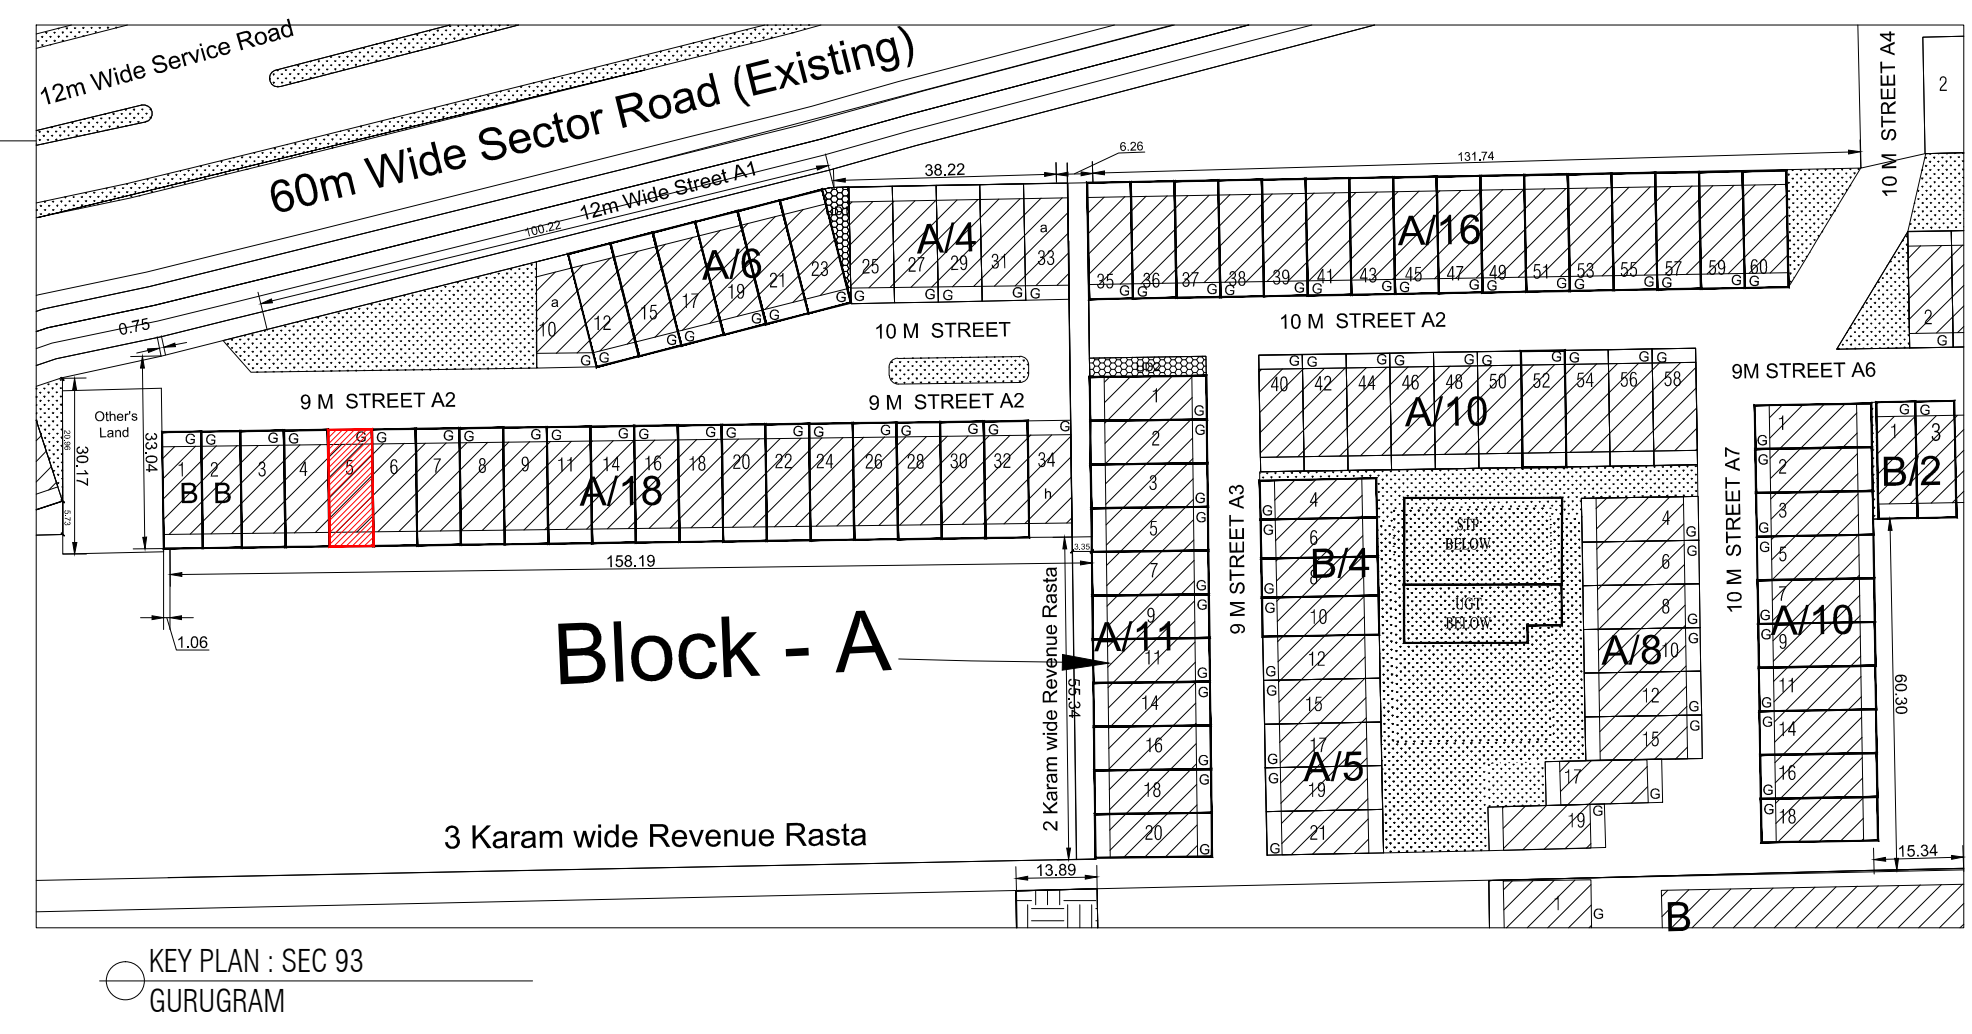

PROJECT - PROPOSED INDEPENDENT RESIDENTIAL FLOORS ON PLOT NO A2 - 05 (STREET A2 - 9 M WIDE) IN AFFORDABLE RESIDENTIAL PLOTTED COLONY UNDER DEEN DAYAL JAN AWAS YOJANA-2016 OVER AN AREA MEASURING 26.91875 (LICESNE NO 94 OF 2021 DT 12.11.2021) IN VILLAGE HAYATPUR, SECTOR 93, GURUGRAM, BEING DEVELOPED BY SAGARDUTT BUILDERS & DEVELOPERS PVT LTD & OTHERS IN COLLABORATION WITH DLF LIMITED.

OWNERS -

DLF LIMITED

ARCHITECTS - Arcop Associates Private Limited Plot- 36b, Sec-32, Gurgaon-122001 Ph.: 26242050, 26242169

DRAWING TITLE - TYPE A (7.5 M x 20 M) FLOORS PLANS WITH AREA CALCULATIONS , ELEVATION & SECTIONS

DRAWING NUMBER - ARCHITECT SIGN - AUTHORISED SIGN -







SCALE = 1:50

DATE -


DRAWN BY -

CHECKED BY -






DRAWING NUMBER -

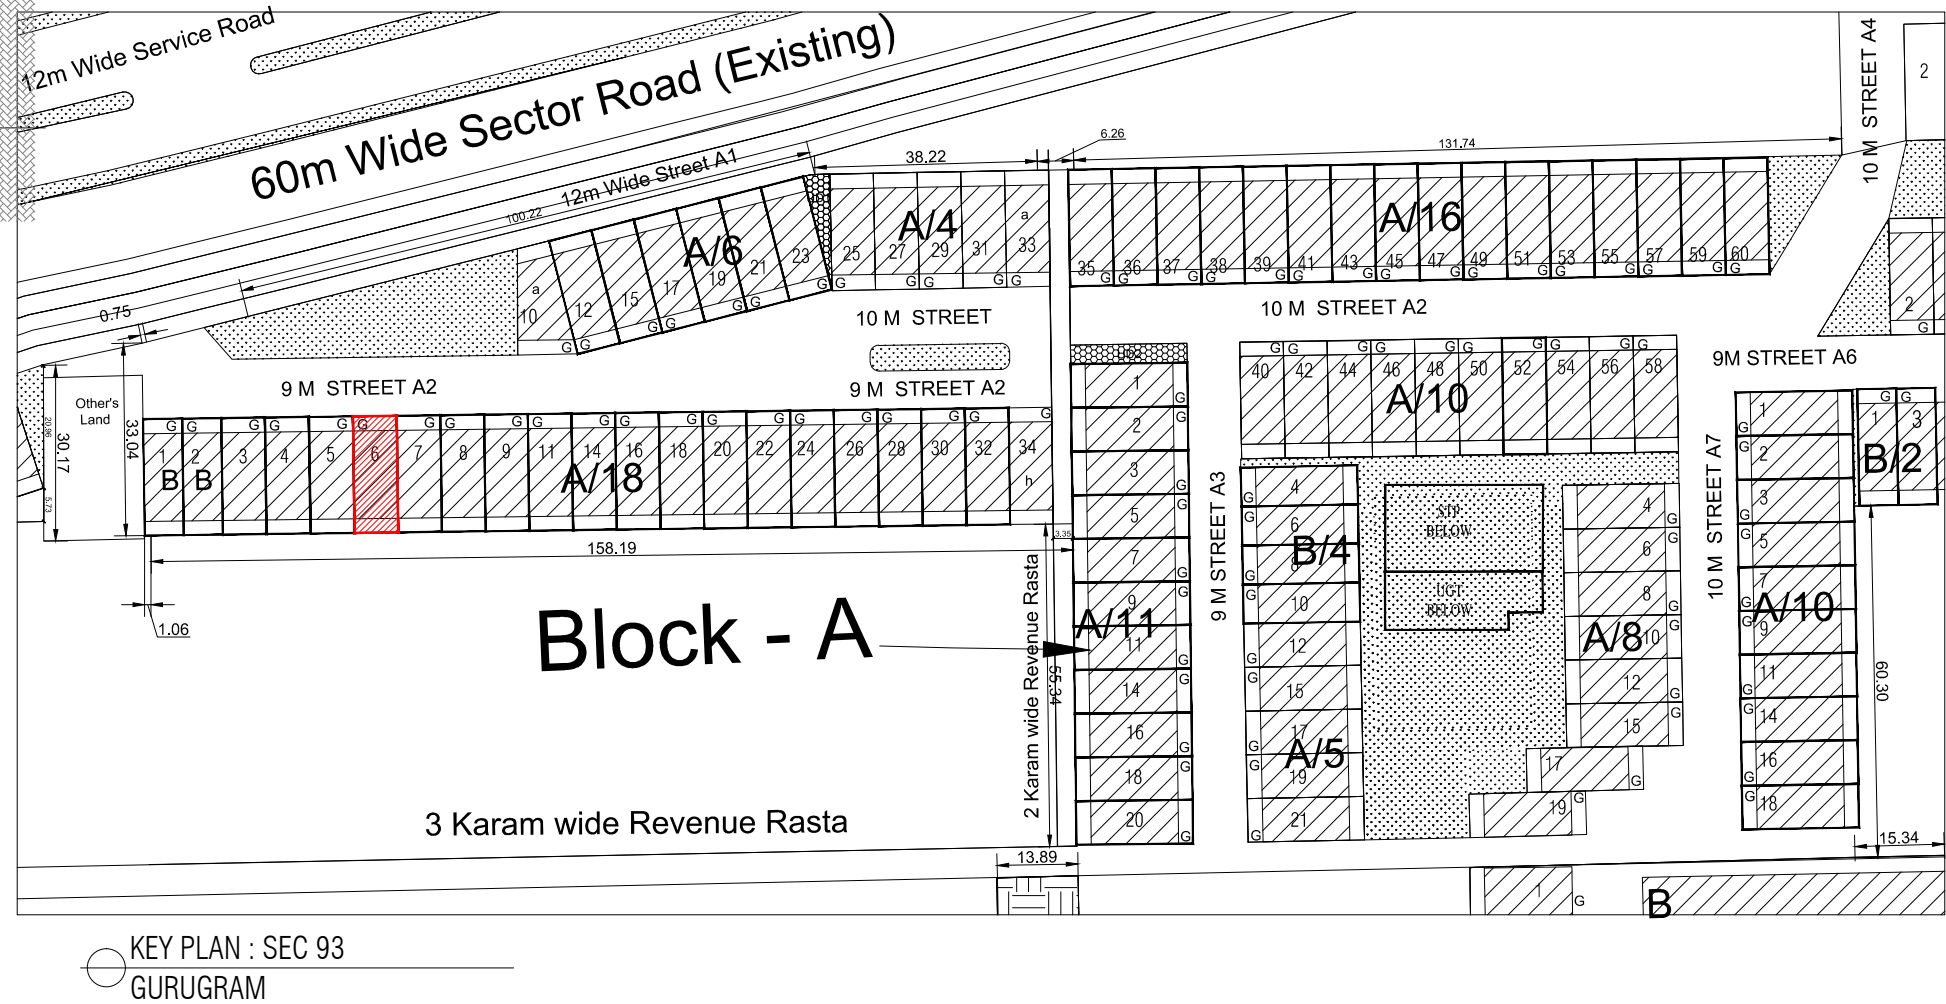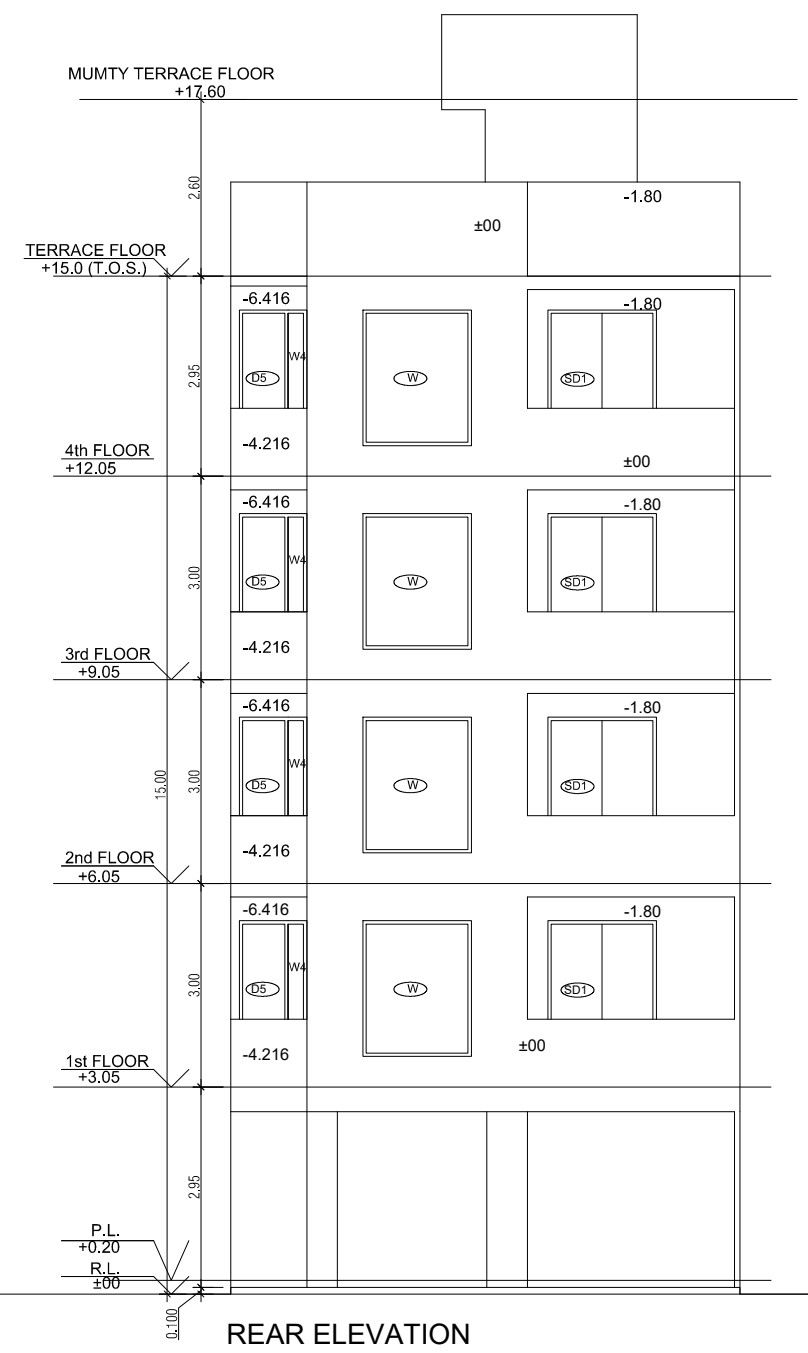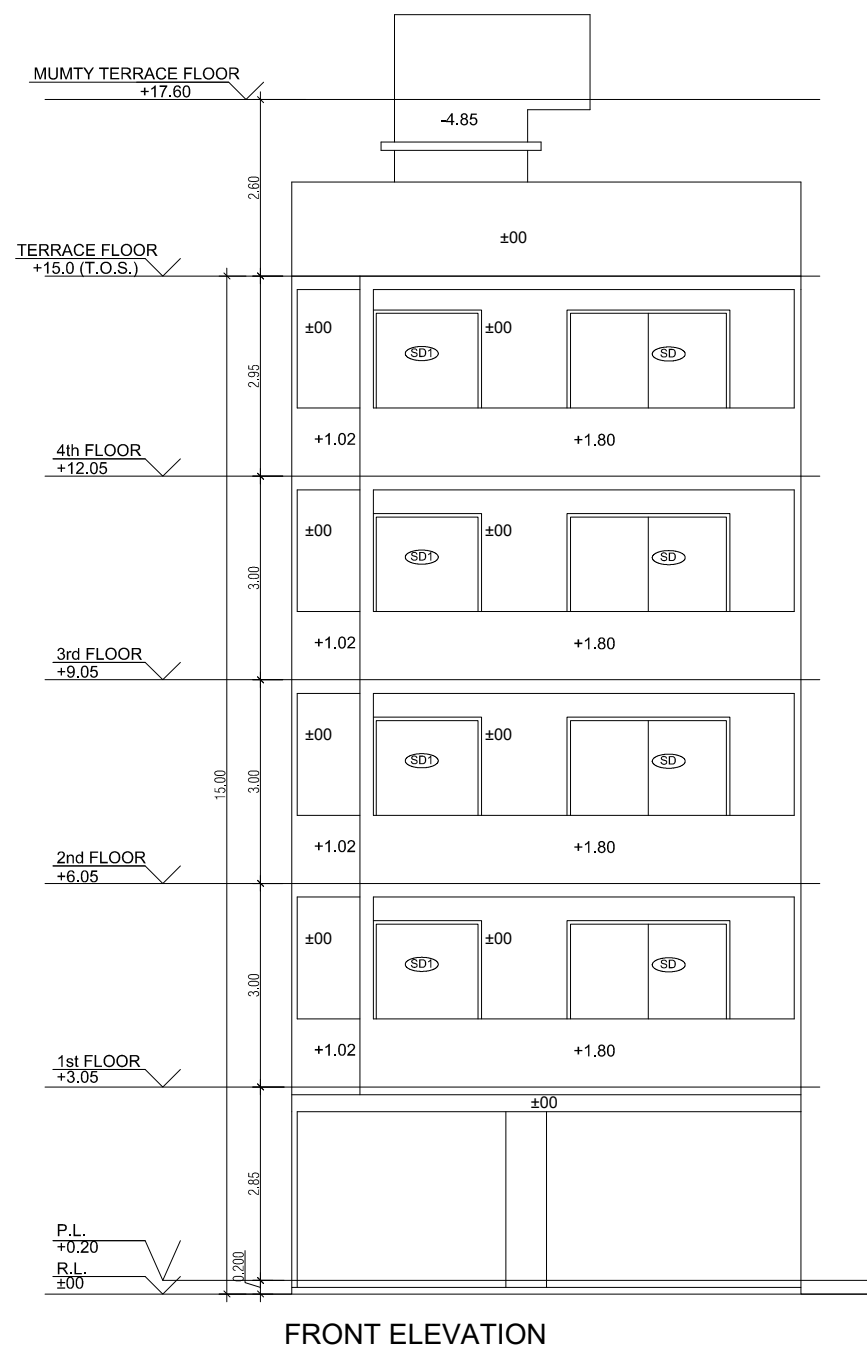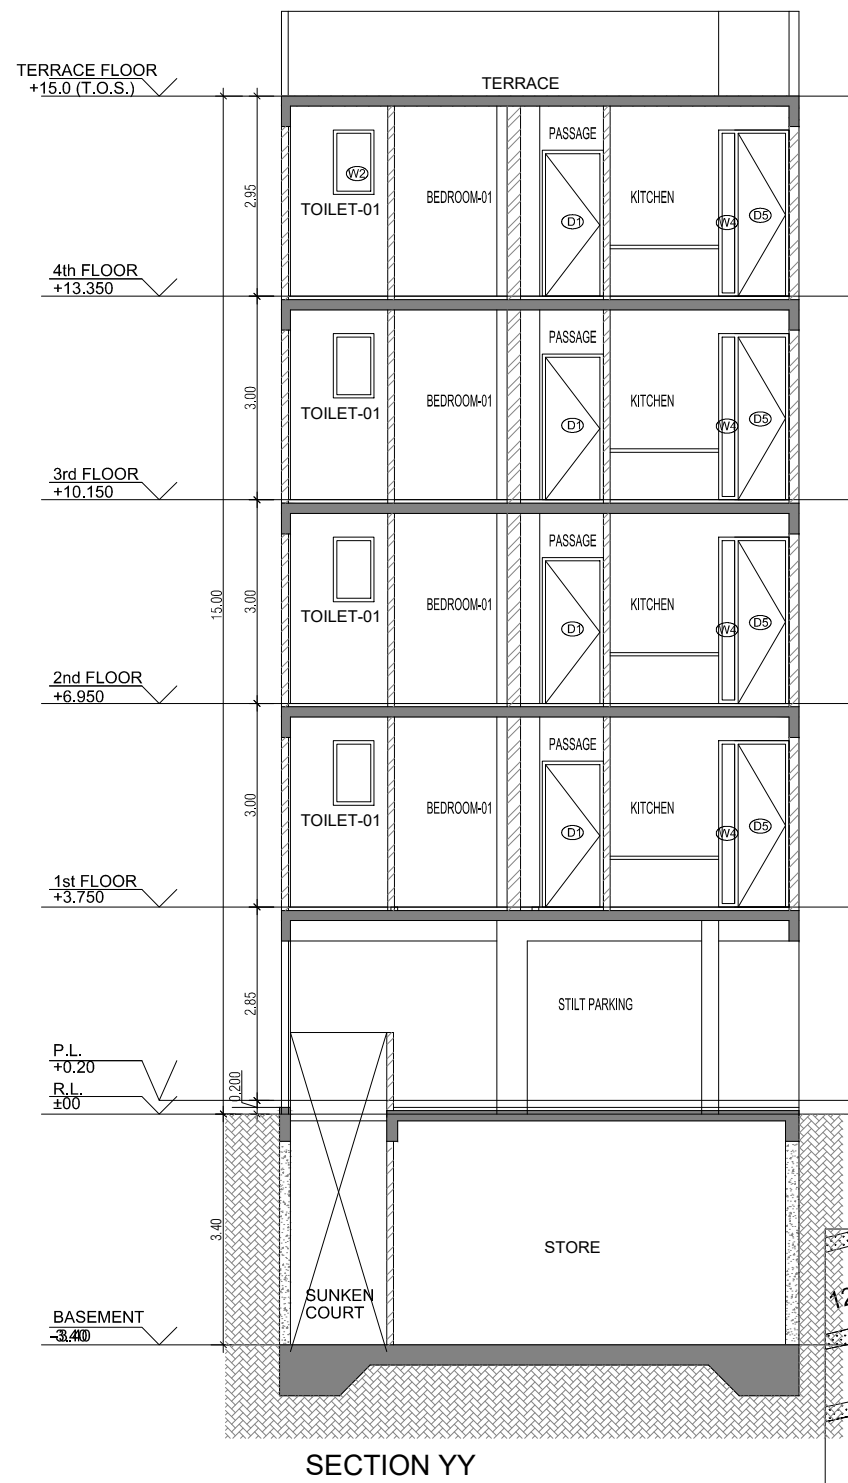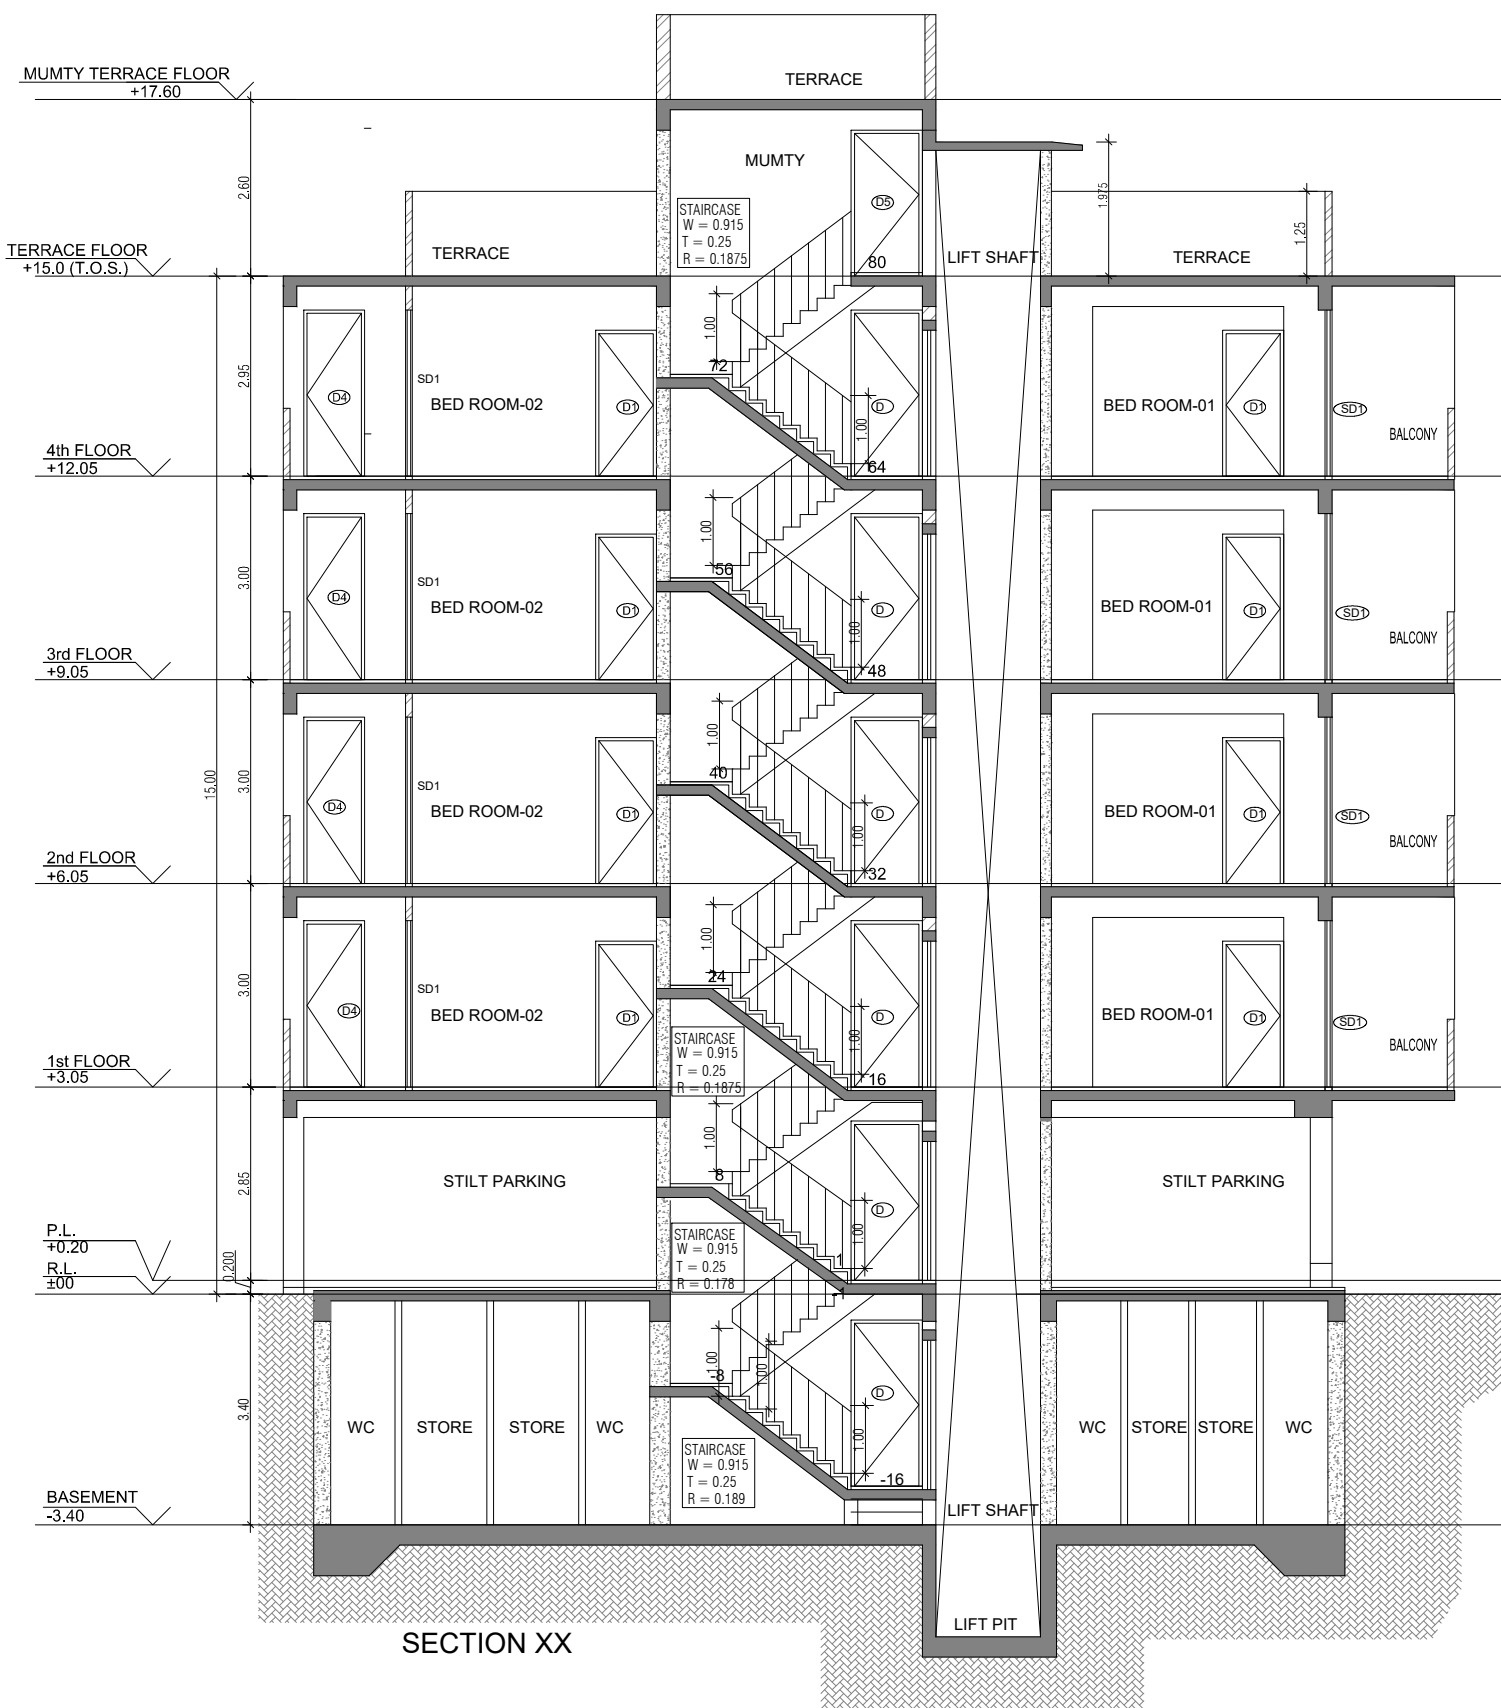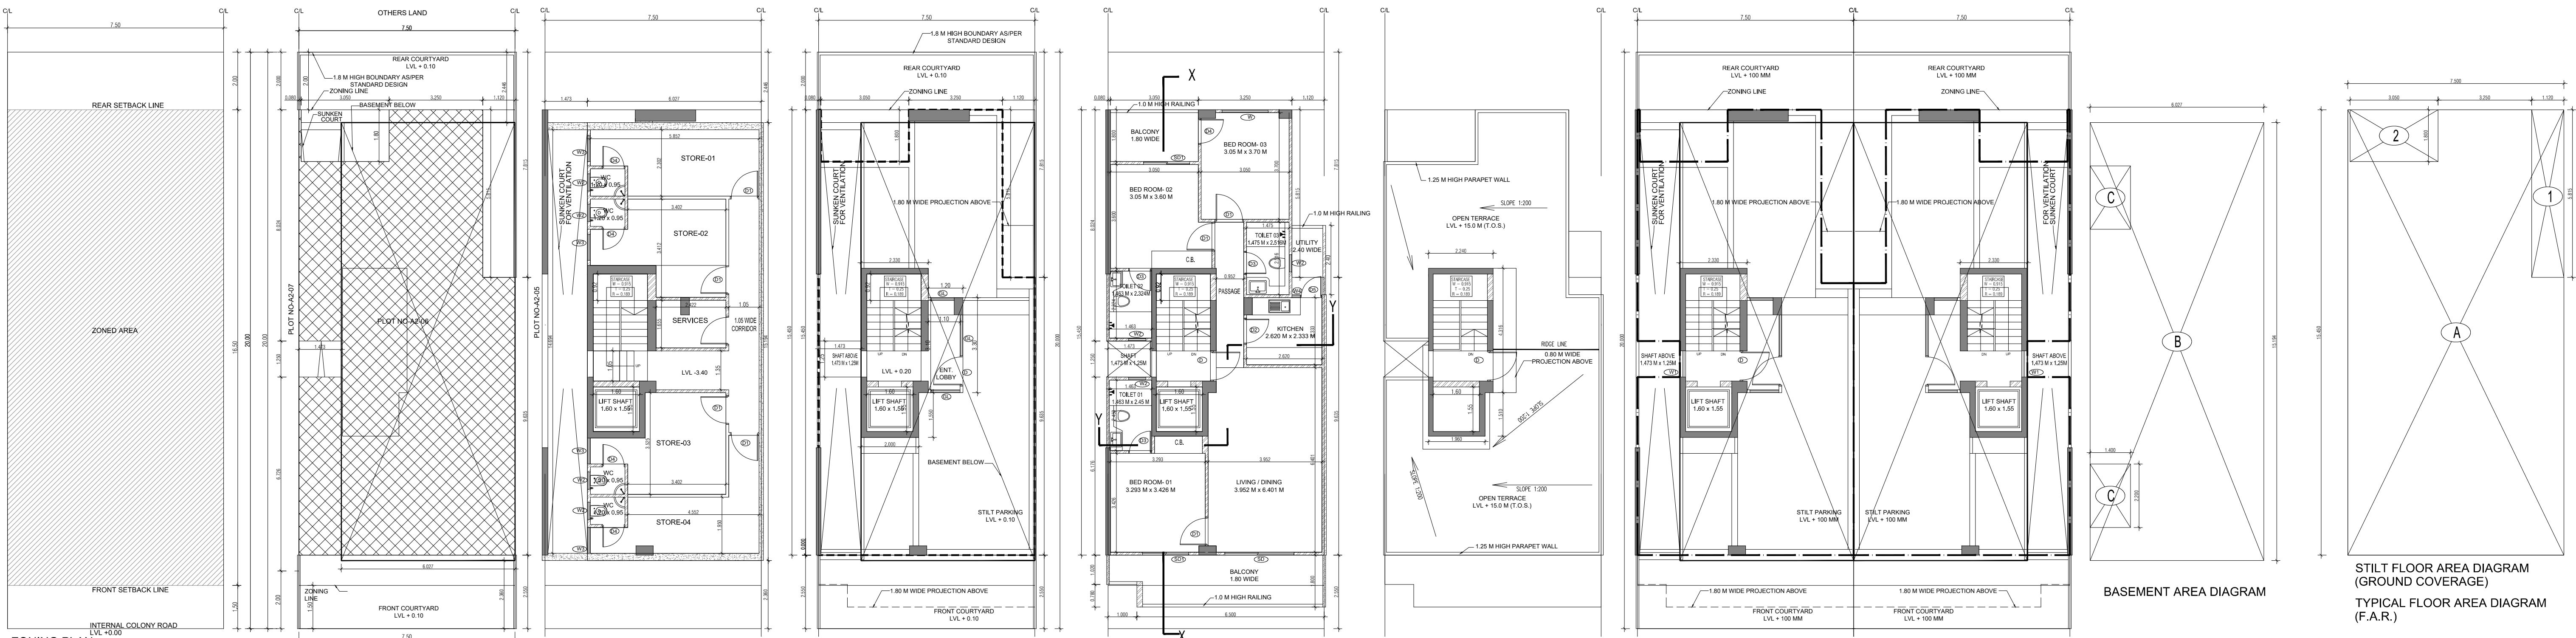


AREA CALCULATION			AREA	UNIT
TOTAL PLOT AREA (7.50 M x 20 M)			150	Sq.mt
PERMISSIBLE FAR AS PER APPROVED ZONING PLAN @ 2.00			300	Sq.mt
PURCHASABLE FAR @ 0.64			96	Sq.mt
TOTAL PERMISSIBLE FAR @ 2.64			396	Sq.mt
PROPOSED FAR @ 2.63			395.395	Sq.mt
PERMISSIBLE GROUND COVERAGE @ 75%			112.50	Sq.mt
PROPOSED GROUND COVERAGE @ 69.24%			103.872	Sq.mt
AREA OF STILT FLOOR (GROUND COVERAGE)				
A			7.5 x 15.45 x 1	115.875 Sq.mt
TOTAL				115.875 Sq.mt
DEDUCTION (D)				
1			1.12 x 5.815 x 1	6.513 Sq.mt
2			3.05 x 1.800 x 1	5.490 Sq.mt
TOTAL				12.003 Sq.mt
PROPOSED GROUND COVERAGE = A-D				103.872 Sq.mt
AREA CALCULATION FOR TYPICAL FLOOR (1st to 4th FLOOR)				
TOTAL AREA ON GROUND COVERAGE (X)				103.872 Sq.mt
DEDUCTION				
1 (STAIRCASE)			1.880 x 3.715 x 1	6.984 Sq.mt
2			1.600 x 1.550 x 1	2.480 Sq.mt
3			1.473 x 1.250 x 1	1.841 Sq.mt
TOTAL (Y)				11.305 Sq.mt
TOTAL AREA OF TYPICAL FLOOR (X-Y)				92.567 Sq.mt
BASEMENT BUILT UP AREA				
B			6.027 x 15.194 x 1	91.574 Sq.mt
TOTAL				91.574 Sq.mt
BASEMENT F.A.R. AREA				
C			1.400 x 2.200 x 2	6.160 Sq.mt
TOTAL				6.160 Sq.mt
NET NON F.A.R. AREA OF BASEMENT				
B-C				85.414 Sq.mt
TOTAL				85.414 Sq.mt
STILT FAR				
E			2.333 x 4.315 x 1	10.067 Sq.mt
F			2.000 x 1.550 x 1	3.100 Sq.mt
G			1.473 x 1.250 x 1	1.841 Sq.mt
J			1.2 x 3.300 x 1	3.960 Sq.mt
TOTAL				18.968 Sq.mt
MUMTY AREA				
H			1.960 x 1.51 x 1	2.960 Sq.mt
I			2.24 x 4.32 x 1	9.660 Sq.mt
TOTAL				12.627 Sq.mt
PROJECTION AREA				
6.500 x 1.800 x 1				11.700 Sq.mt
1.000 x 1.020 x 1				1.020 Sq.mt
1.120 x 1.800 x 1				2.016 Sq.mt
3.050 x 1.800 x 1				5.490 Sq.mt
TOTAL				20.226 Sq.mt
GROUND COVERAGE CALCULATION				
STILT FLOOR AREA, STAIRCASE, LIFT SHAFT INCLUDED				103.872 Sq.mt
TOTAL GROUND COVERAGE ACHIEVED				103.872 Sq.mt
FAR CALCULATION				
TYPICAL FLOOR AREA x 4				370.267 Sq.mt
FAR AREA UN BASEMENT				6.160 Sq.mt
FAR AREA ON STILT				18.968 Sq.mt
TOTAL FAR ACHIEVED				395.395 Sq.mt
BUILT UP AREA CALCULATION				
BASEMENT AREA (FAR-NON FAR) + COVERAGE				697.102 Sq.mt
AT STILT AREA + FLOOR AREA + STAIR CASE x 4 +				
MUMTY AREA + PROJECTION AREA x 4				

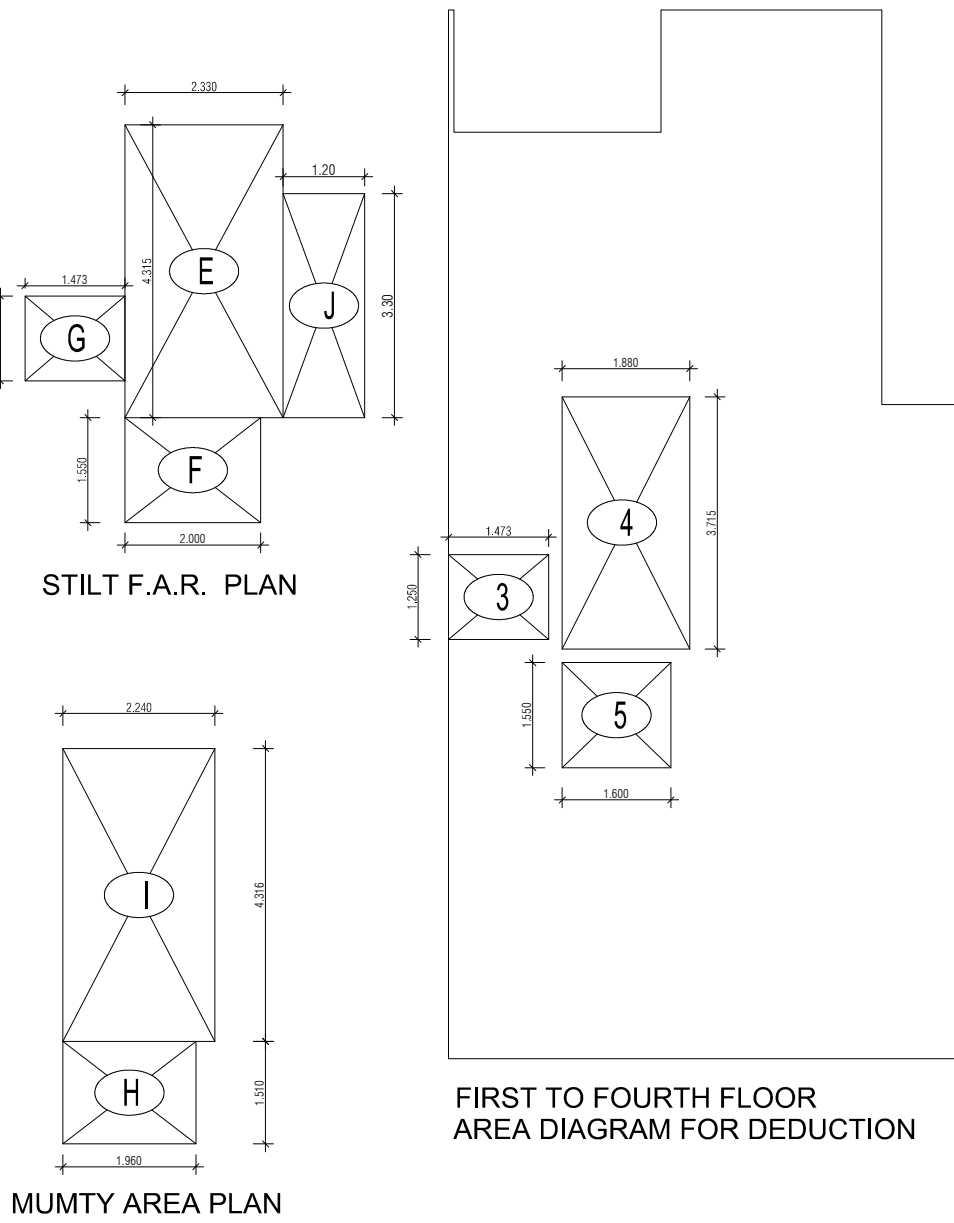







PROJECT -		
PROPOSED INDEPENDENT RESIDENTIAL FLOORS ON PLOT NO A2 - 06 (STREET A2 - 9 M WIDE) IN AFFORDABLE RESIDENTIAL PLOTTED COLONY UNDER DEEN DAYAL JAN AWAS YOJNA-2016 OVER AN AREA MEASURING 26.91875 (LICESNE NO 94 OF 2021 DT 12.11.2021) IN VILLAGE HAYATPUR, SECTOR 93, GURUGRAM, BEING DEVELOPED BY SAGARDUTT BUILDERS & DEVELOPERS PVT LTD & OTHERS IN COLLABORATION WITH DLF LIMITED.		
OWNERS -		
DLF LIMITED		
ARCHITECTS -		
Arcop Associates Private Limited Plot- 36b, Sec-32, Gurgaon-122001 Ph.: 26242050, 26242169		
DRAWING TITLE -		
TYPE A (7.5 M x 20 M) FLOORS PLANS WITH AREA CALCULATIONS , ELEVATION & SECTIONS		
DRAWING NUMBER -		
SCALE = 1:50		
DATE :		
DRAWN BY -		
CHECKED BY -		
DRAWING NUMBER -		
ARCHITECT SIGN		AUTHORISED SIGN
Vandana Arora		Vandana Arora
VANDANA ARORA		VANDANA ARORA

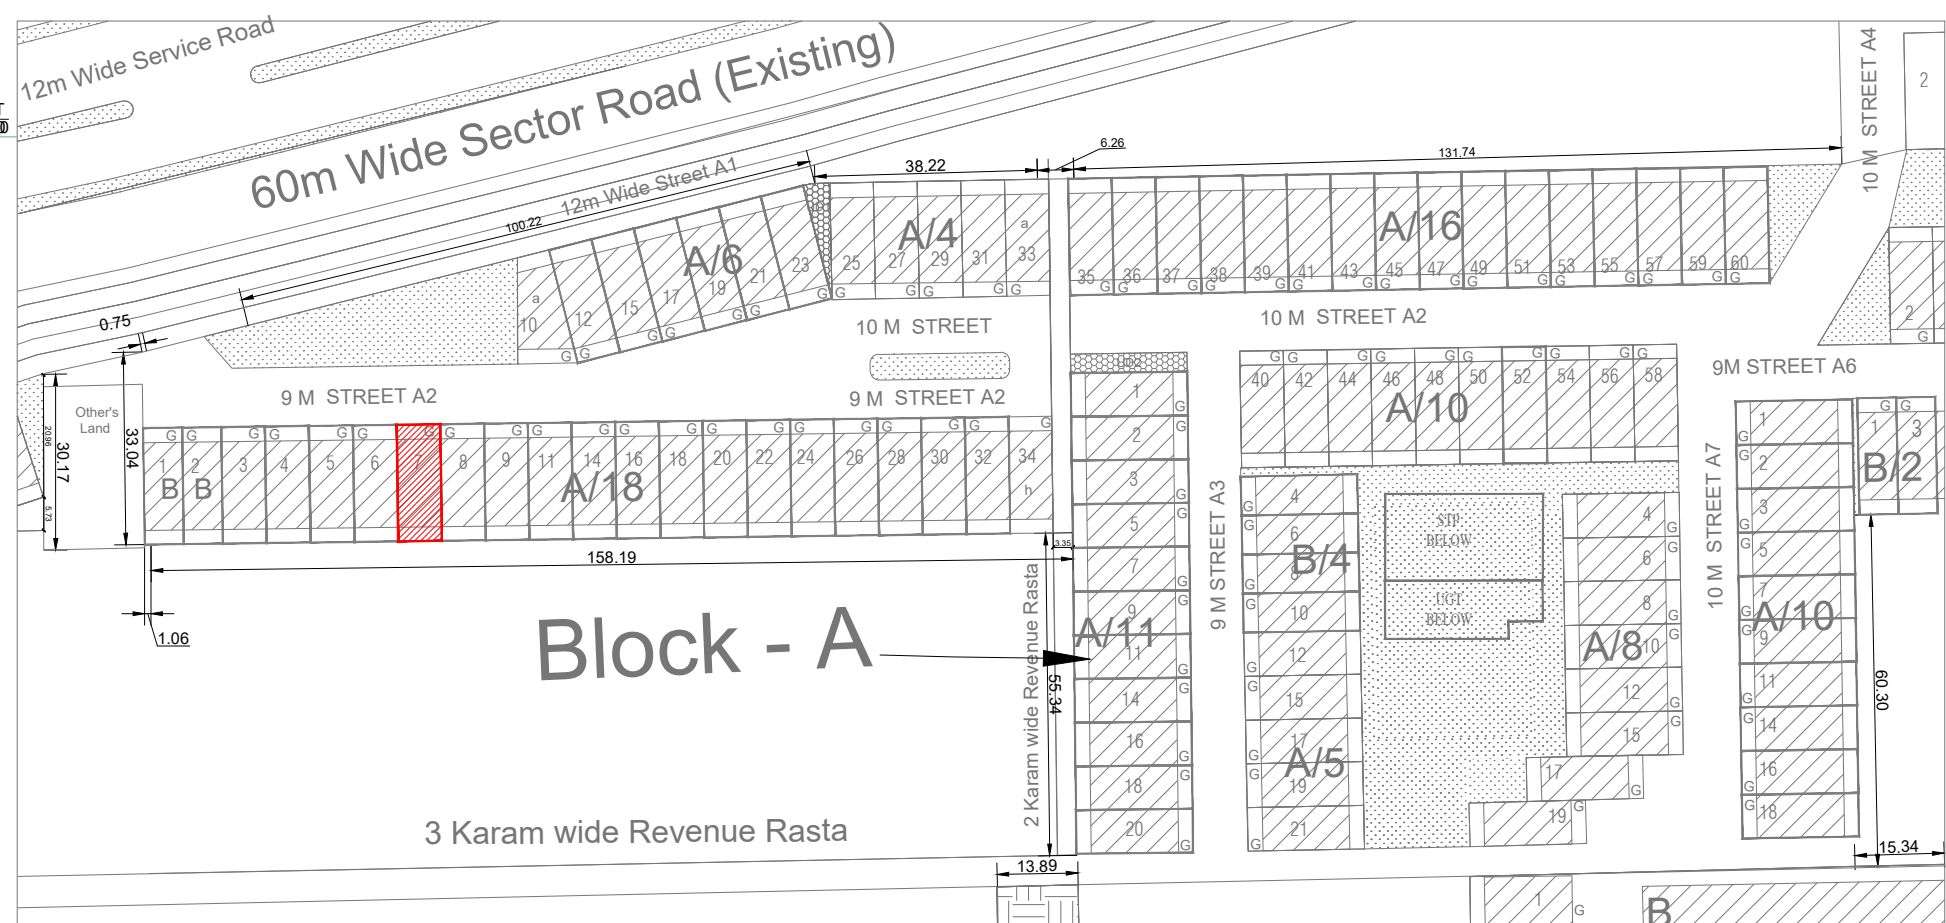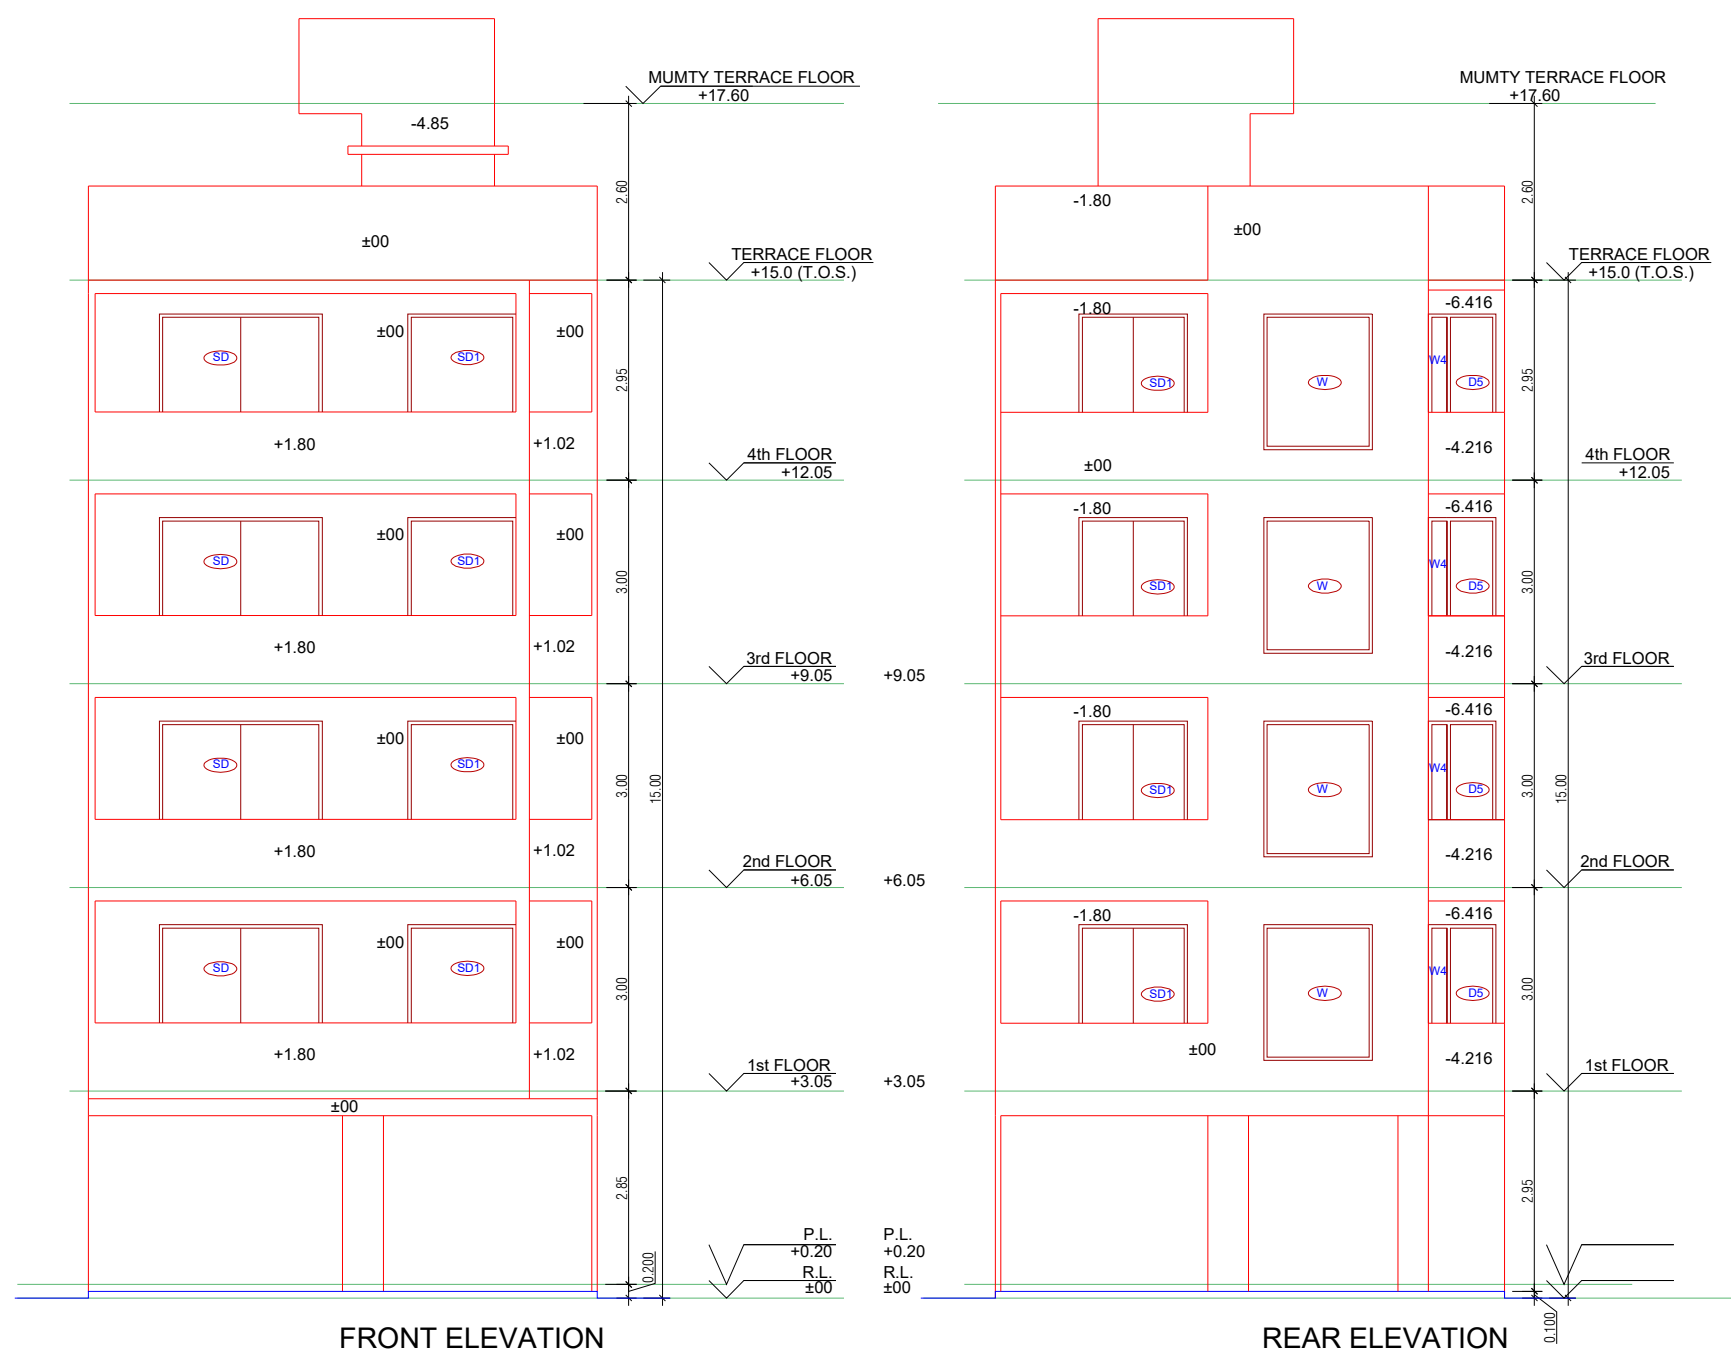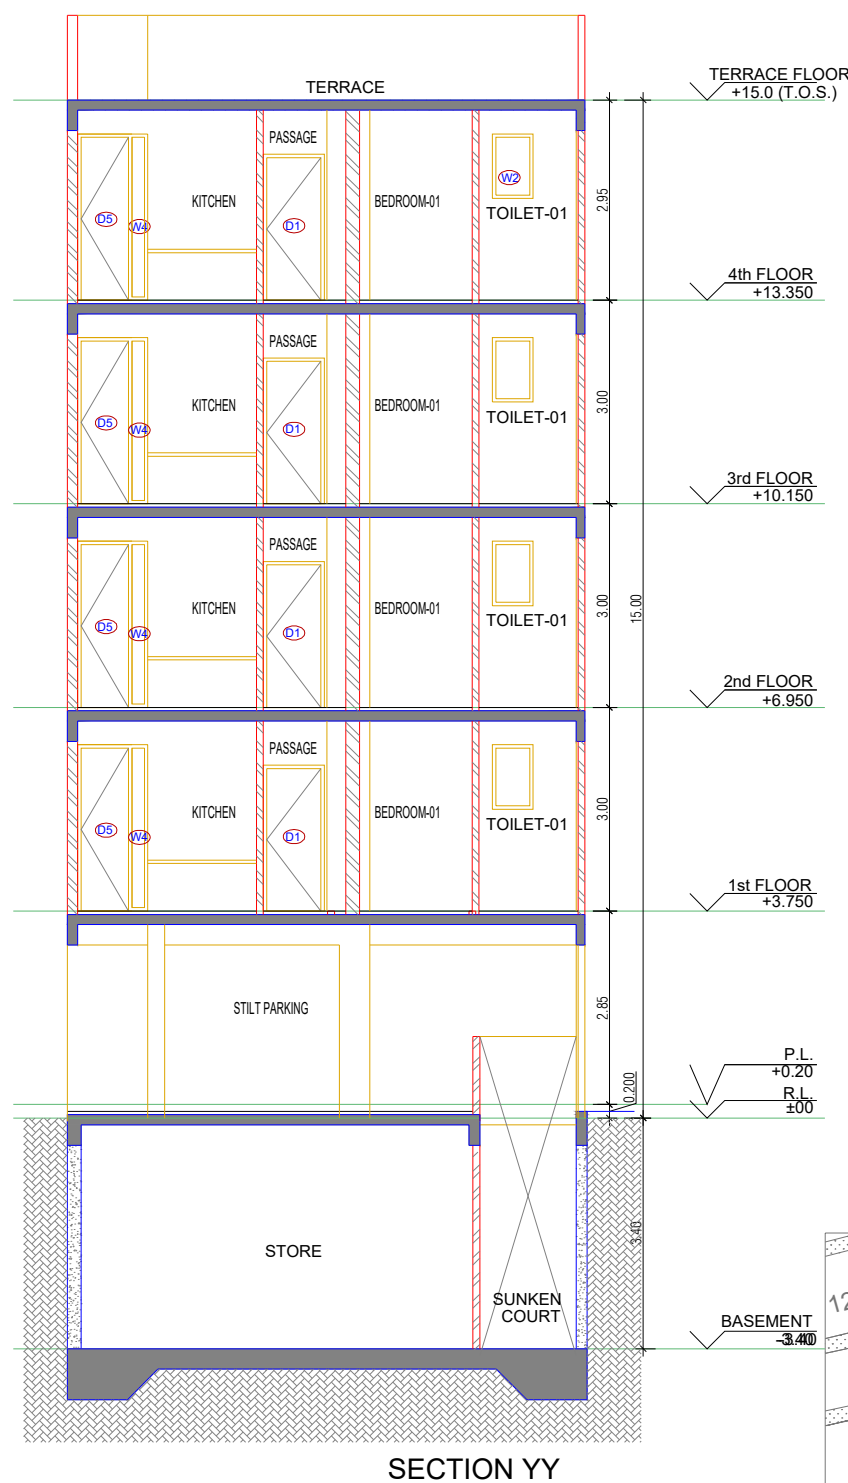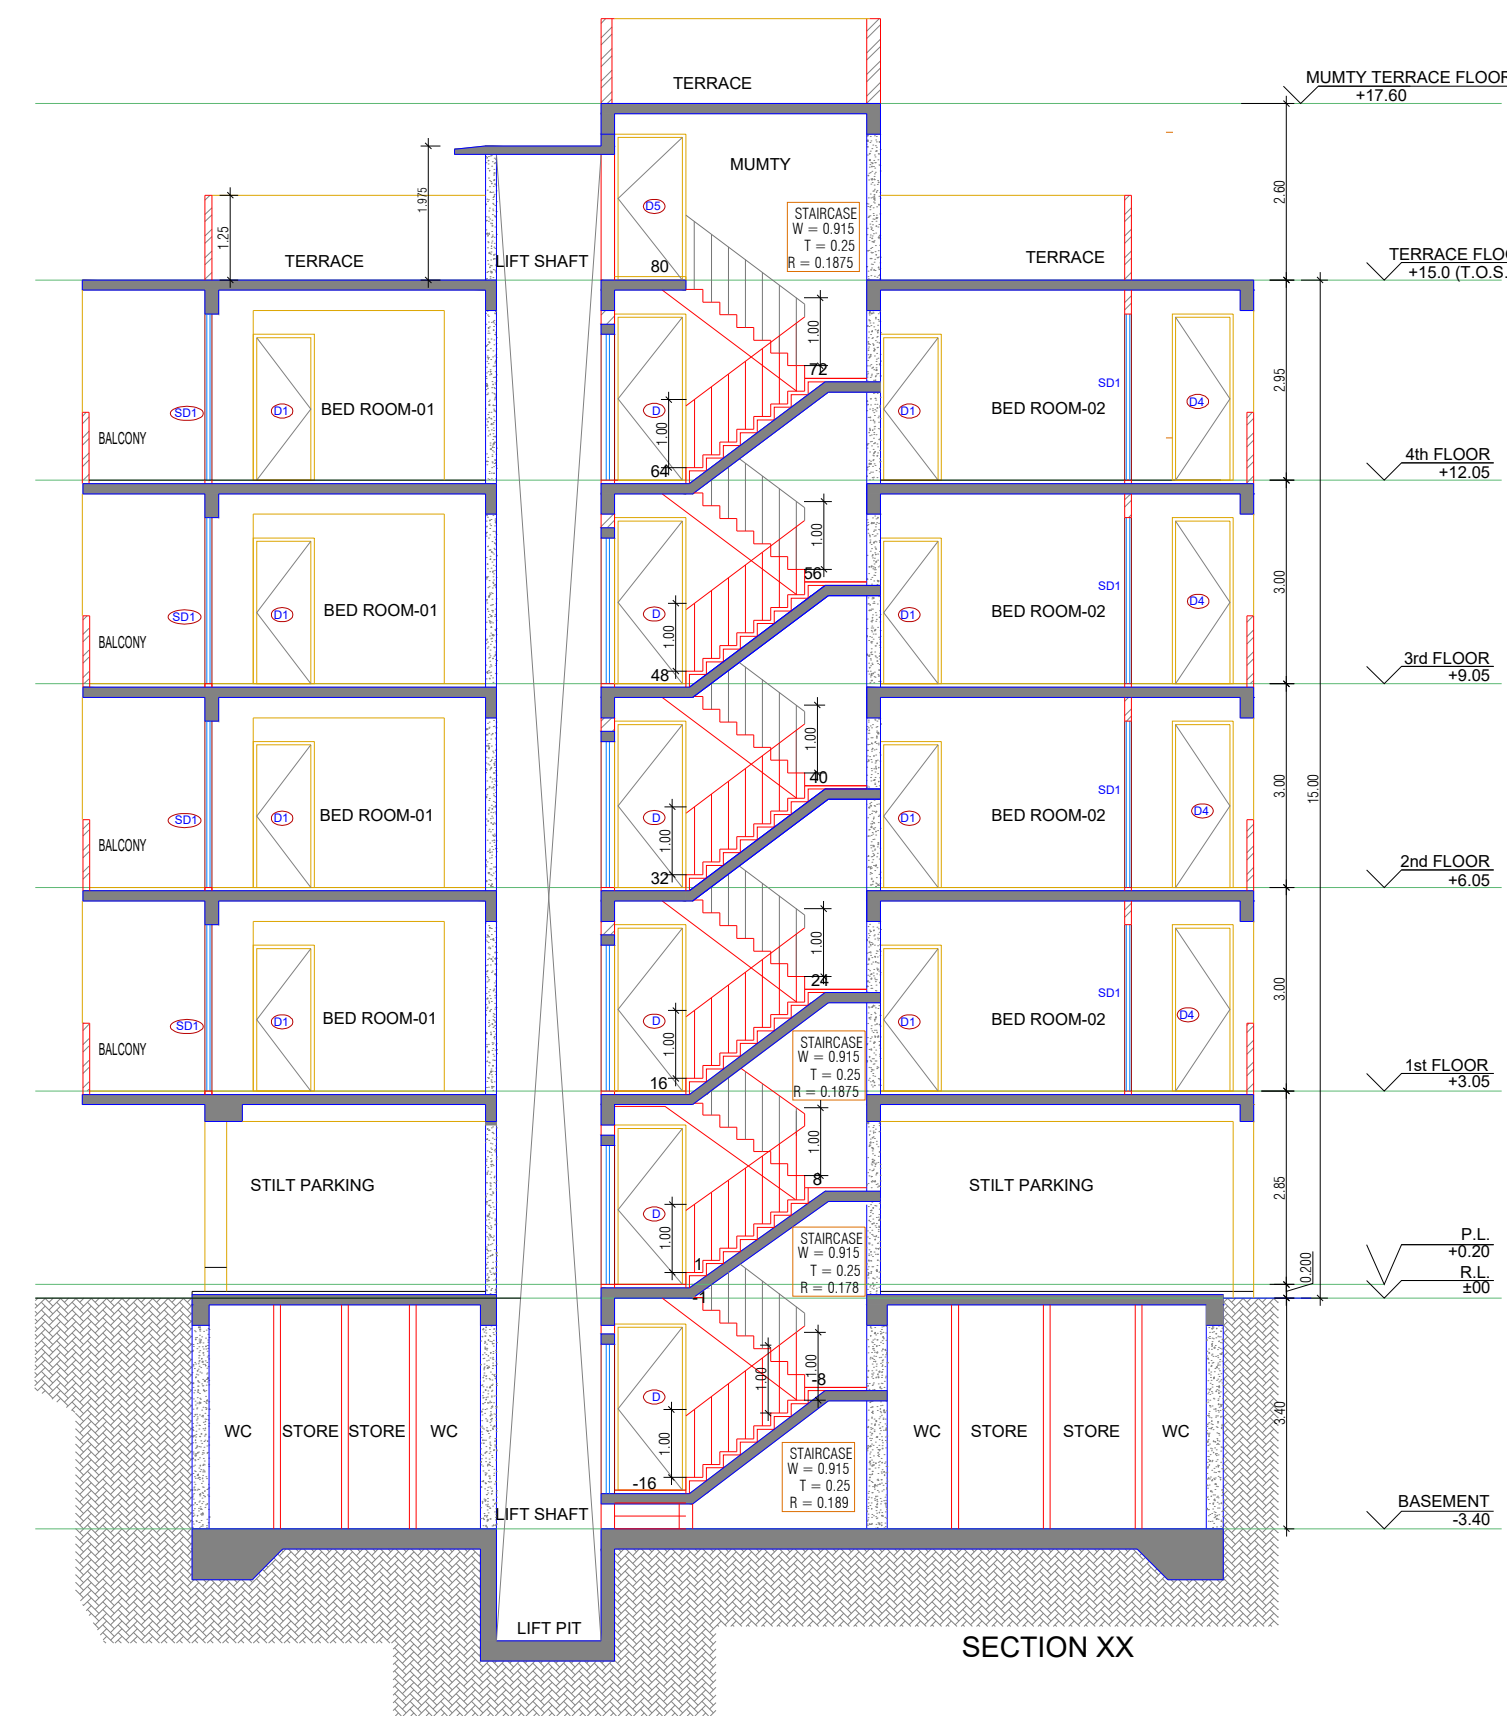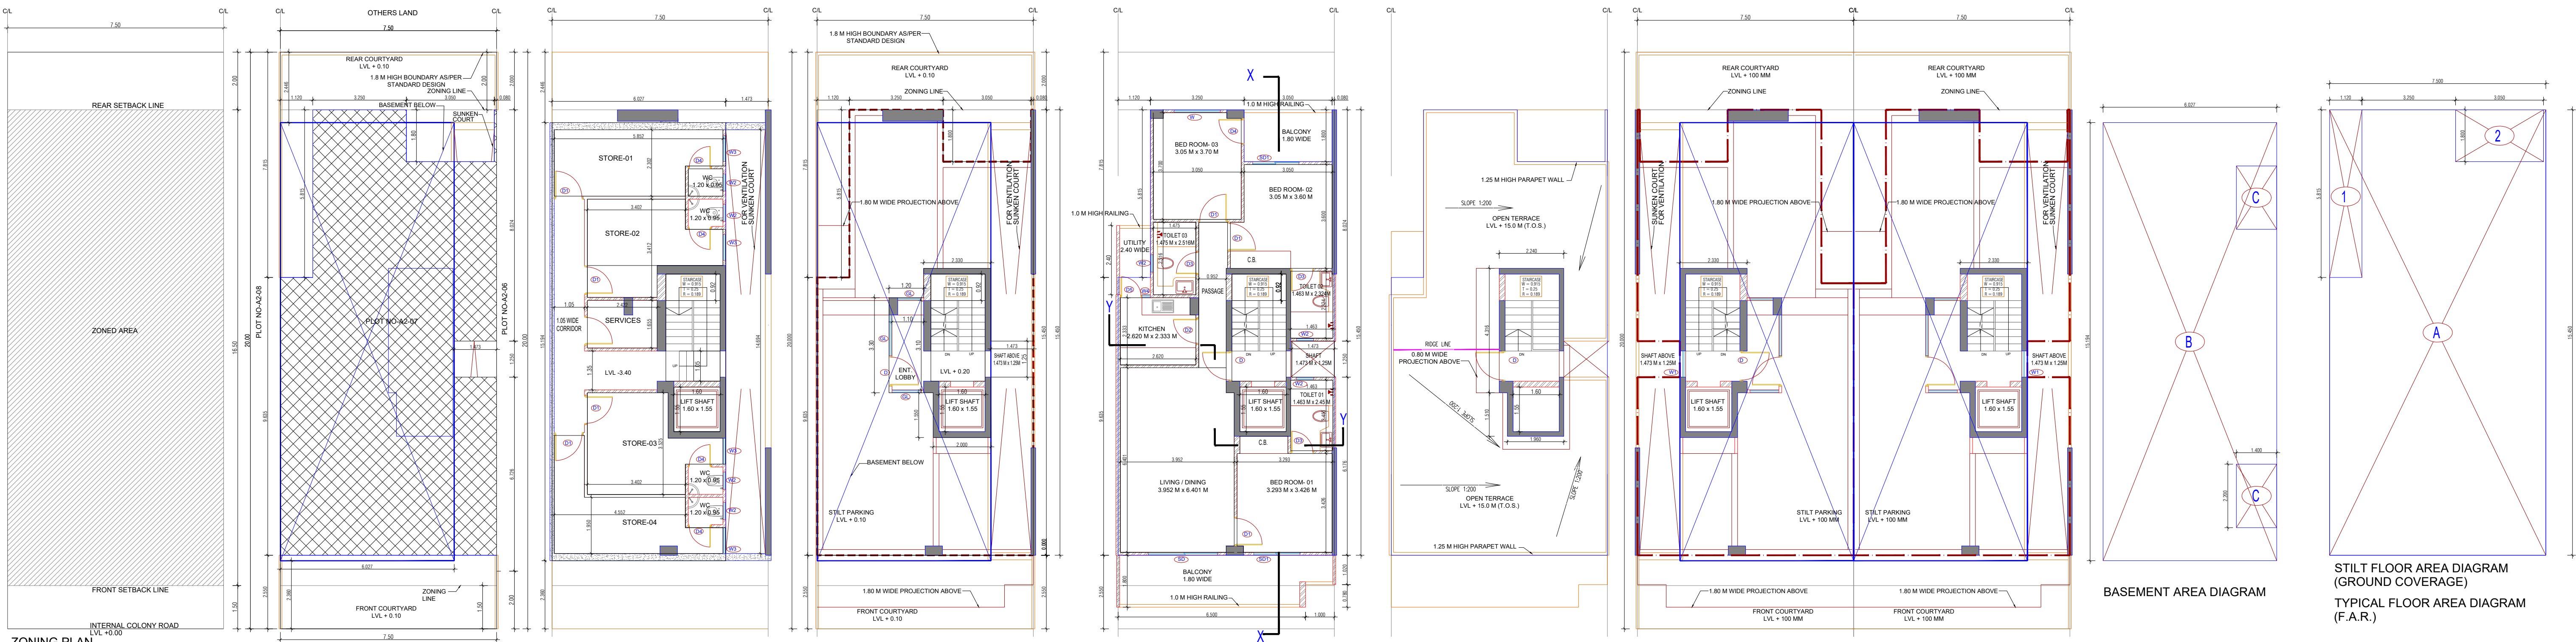

AREA CALCULATION			
	AREA	UNIT	
TOTAL PLOT AREA (7.50 M x 20 M)	150	Sqmt	
PERMISSIBLE FAR AS PER APPROVED ZONING PLAN @ 2.00	300	Sqmt	
PURCHASABLE FAR @ 0.64	96	Sqmt	
TOTAL PERMISSIBLE FAR @ 2.64	396	Sqmt	
PROPOSED FAR @ 2.63	395.395	Sqmt	
PERMISSIBLE GROUND COVERAGE @ 75%	112.50	Sqmt	
PROPOSED GROUND COVERAGE @ 69.24%	103.872	Sqmt	
AREA OF STILT FLOOR (GROUND COVERAGE)			
A	7.5 x 15.450 x 1	115.875	Sqmt
TOTAL			115.875 Sqmt
DEDUCTION (D)			
1	1.12 x 5.815 x 1	6.512	Sqmt
2	3.05 x 1.800 x 1	5.490	Sqmt
TOTAL			12.003 Sqmt
PROPOSED GROUND COVERAGE = A - D			103.872 Sqmt
AREA CALCULATION FOR TYPICAL FLOOR (1st to 4th Floor)			
TOTAL AREA ON GROUND COVERAGE (X)			103.872 Sqmt
DEDUCTION			
1 (STAIRCASE)	3.880 x 3.715 x 1	6.984	Sqmt
2	1.600 x 1.550 x 1	2.480	Sqmt
3	1.473 x 1.250 x 1	1.841	Sqmt
TOTAL (Y)			11.305 Sqmt
TOTAL AREA OF TYPICAL FLOOR (X - Y)			92.567 Sqmt
BASEMENT BUILT UP AREA			
B	6.027 x 15.134 x 1	91.574	Sqmt
TOTAL			91.574 Sqmt
BASEMENT F.A.R. AREA			
C	1.400 x 2.200 x 2	6.160	Sqmt
TOTAL			6.160 Sqmt
NET NON F.A.R. AREA OF BASEMENT			
B-C		85.414	Sqmt
TOTAL			85.414 Sqmt
STILT FAR			
E	2.333 x 4.315 x 1	10.067	Sqmt
F	2.000 x 1.550 x 1	3.100	Sqmt
G	1.473 x 1.250 x 1	1.841	Sqmt
J	1.2 x 3.300 x 1	3.960	Sqmt
TOTAL			18.968 Sqmt
MUMTY AREA			
H	1.960 x 1.51 x 1	2.960	Sqmt
I	2.24 x 4.32 x 1	9.680	Sqmt
TOTAL			12.627 Sqmt
PROJECTION AREA			
	6.300 x 1.800 x 1	11.340	Sqmt
	1.000 x 1.000 x 1	1.000	Sqmt
	1.120 x 1.800 x 1	2.016	Sqmt
	3.050 x 1.800 x 1	5.490	Sqmt
TOTAL			20.226 Sqmt
GROUND COVERAGE CALCULATION			
STILT FLOOR AREA, STAIRCASE, LIFT SHAFT INCLUDED	103.872	Sqmt	
TOTAL GROUND COVERAGE ACHIEVED			103.872 Sqmt
FAR CALCULATION			
TYPICAL FLOOR AREA x 4	370.267	Sqmt	
FAR AREA UN BASEMENT	6.160	Sqmt	
FAR AREA ON STILT	18.968	Sqmt	
TOTAL FAR ACHIEVED			395.395 Sqmt
BUILT UP AREA CALCULATION			
BASEMENT AREA (FAR NON FAR) + COVERAGE	697.102	Sqmt	
AT STILT AREA + FLOOR AREA + STAIR CASE x 4 + MUMTY AREA + PROJECTION AREA x 4			

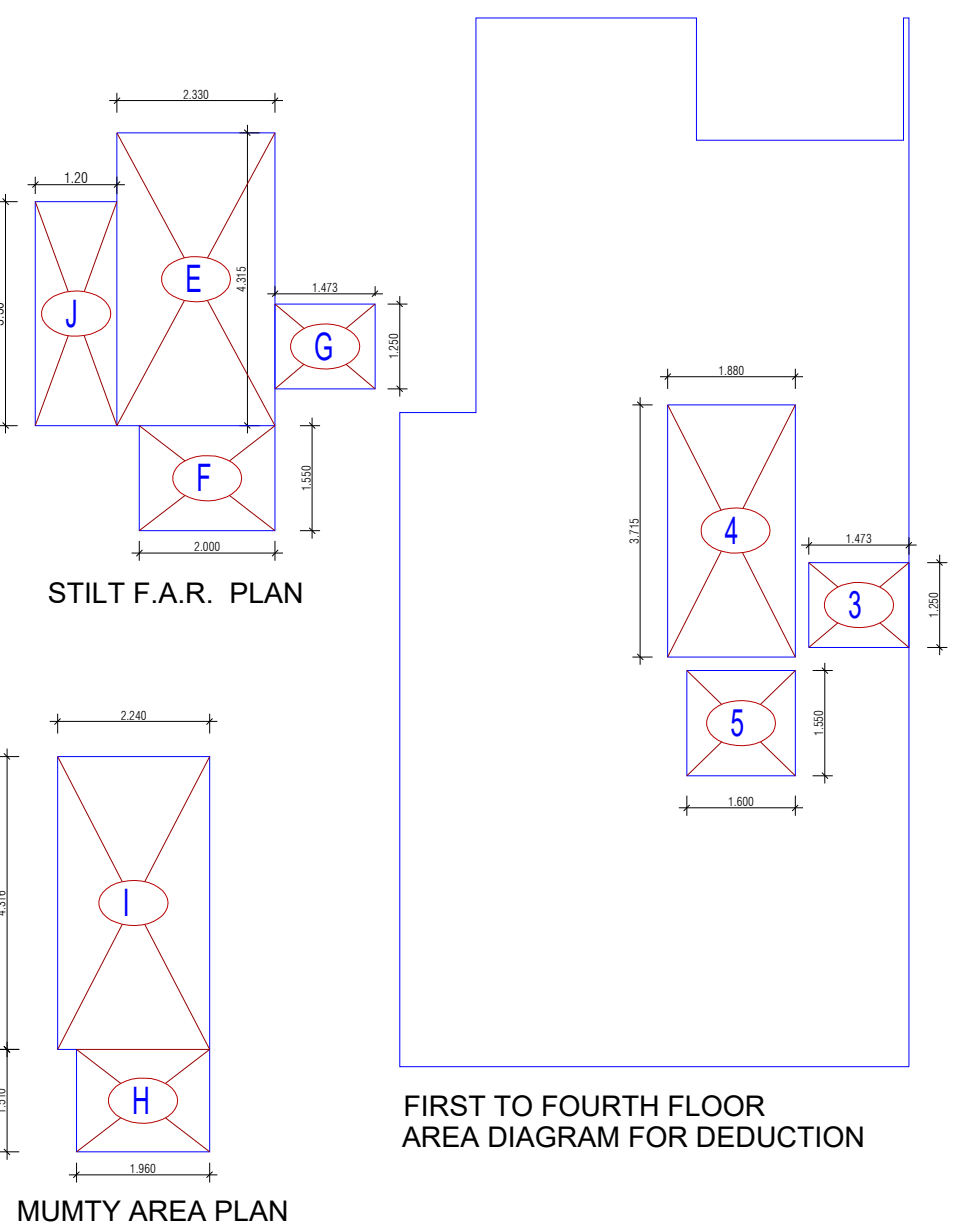

PROJECT -		
PROPOSED INDEPENDENT RESIDENTIAL FLOORS ON PLOT NO A2 - 07 (STREET A2 - 9 M WIDE) IN AFFORDABLE RESIDENTIAL PLOTTED COLONY UNDER DEEN DAYAL JAN AWAS YOJNA-2016 OVER AN AREA MEASURING 26.91875 (LICESNE NO 94 OF 2021 DT 12.11.2021) IN VILLAGE HAYATPUR, SECTOR 93, GURUGRAM, BEING DEVELOPED BY SAGARDUTT BUILDERS & DEVELOPERS PVT LTD & OTHERS IN COLLABORATION WITH DLF LIMITED.		
OWNERS -		
DLF LIMITED		
ARCHITECTS -		
Arcop Associates Private Limited Plot- 36b, Sec-32, Gurgaon-122001 Ph.: 26242050, 26242169		
DRAWING TITLE -		
TYPE A (7.5 M x 20 M) FLOORS' PLANS WITH AREA CALCULATIONS , ELEVATION & SECTIONS		
DRAWING NUMBER -		
SCALE = 1:50		
DATE :		
DRAWN BY -		
CHECKED BY -		
DRAWING NUMBER -		
ARCHITECT SIGN		AUTHORISED SIGN
Abhishek Thakur Chartered CP Architect Registration No. CA2001102742		V Arora VANDANA ARORA AUTHORISED SIGN

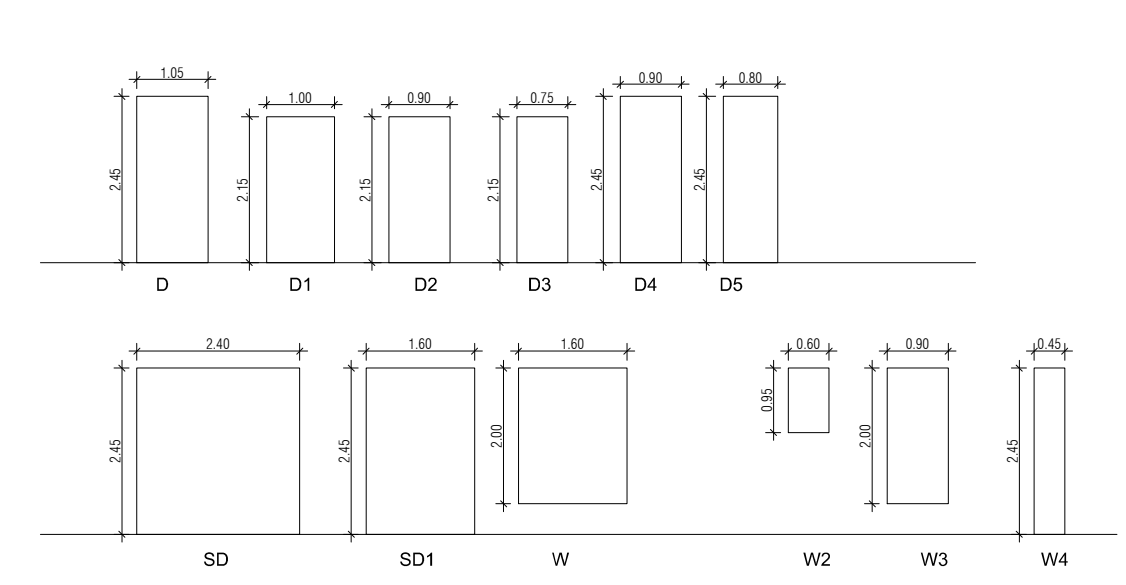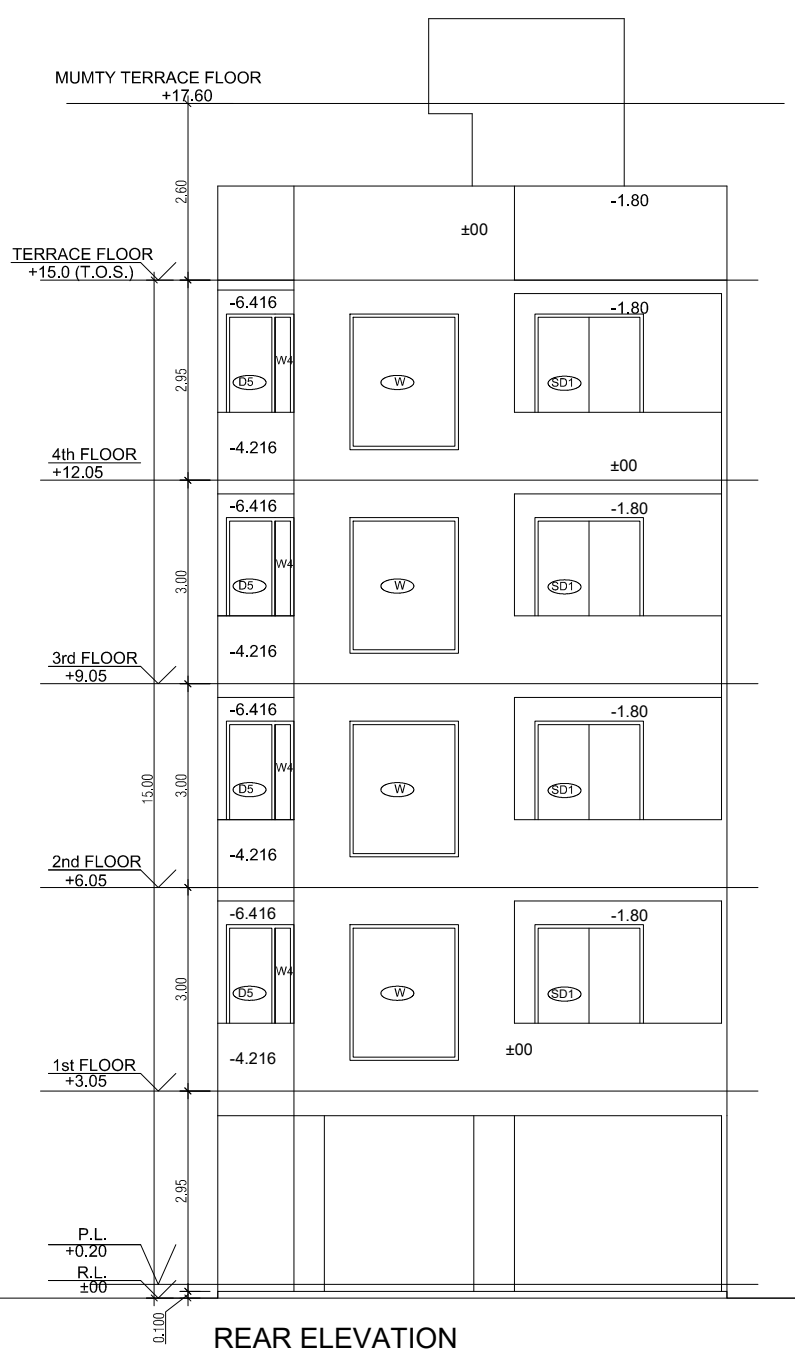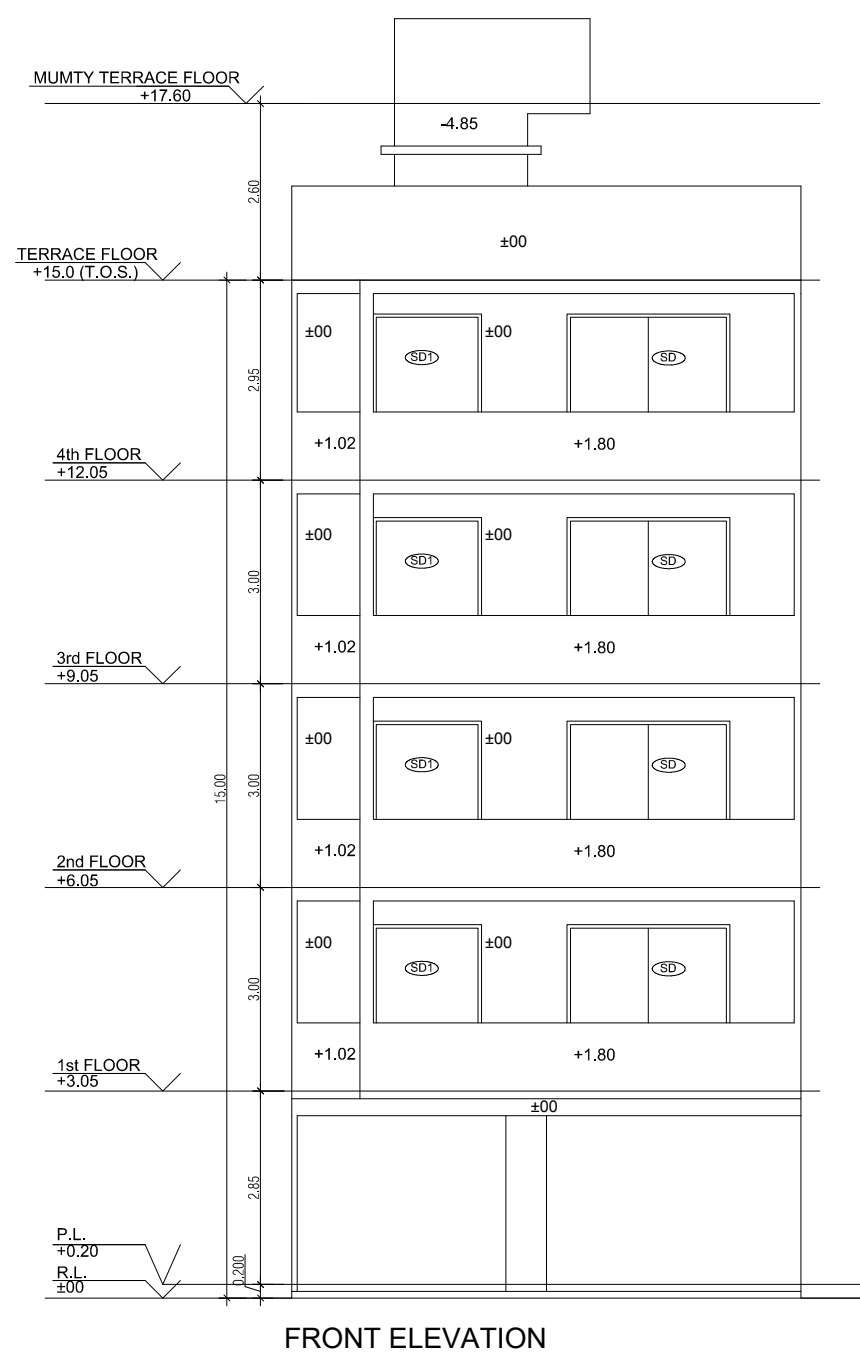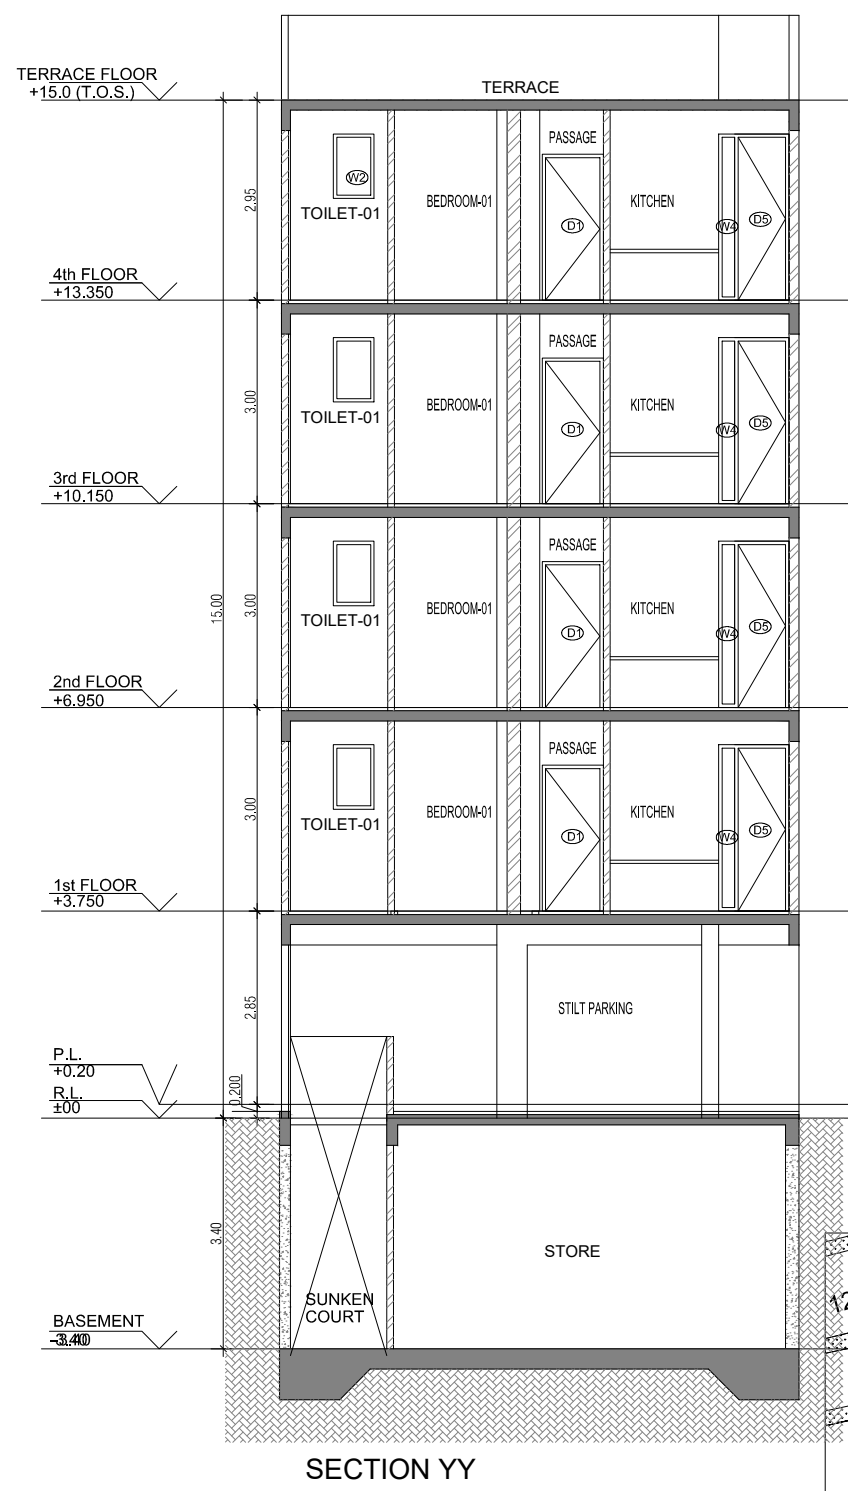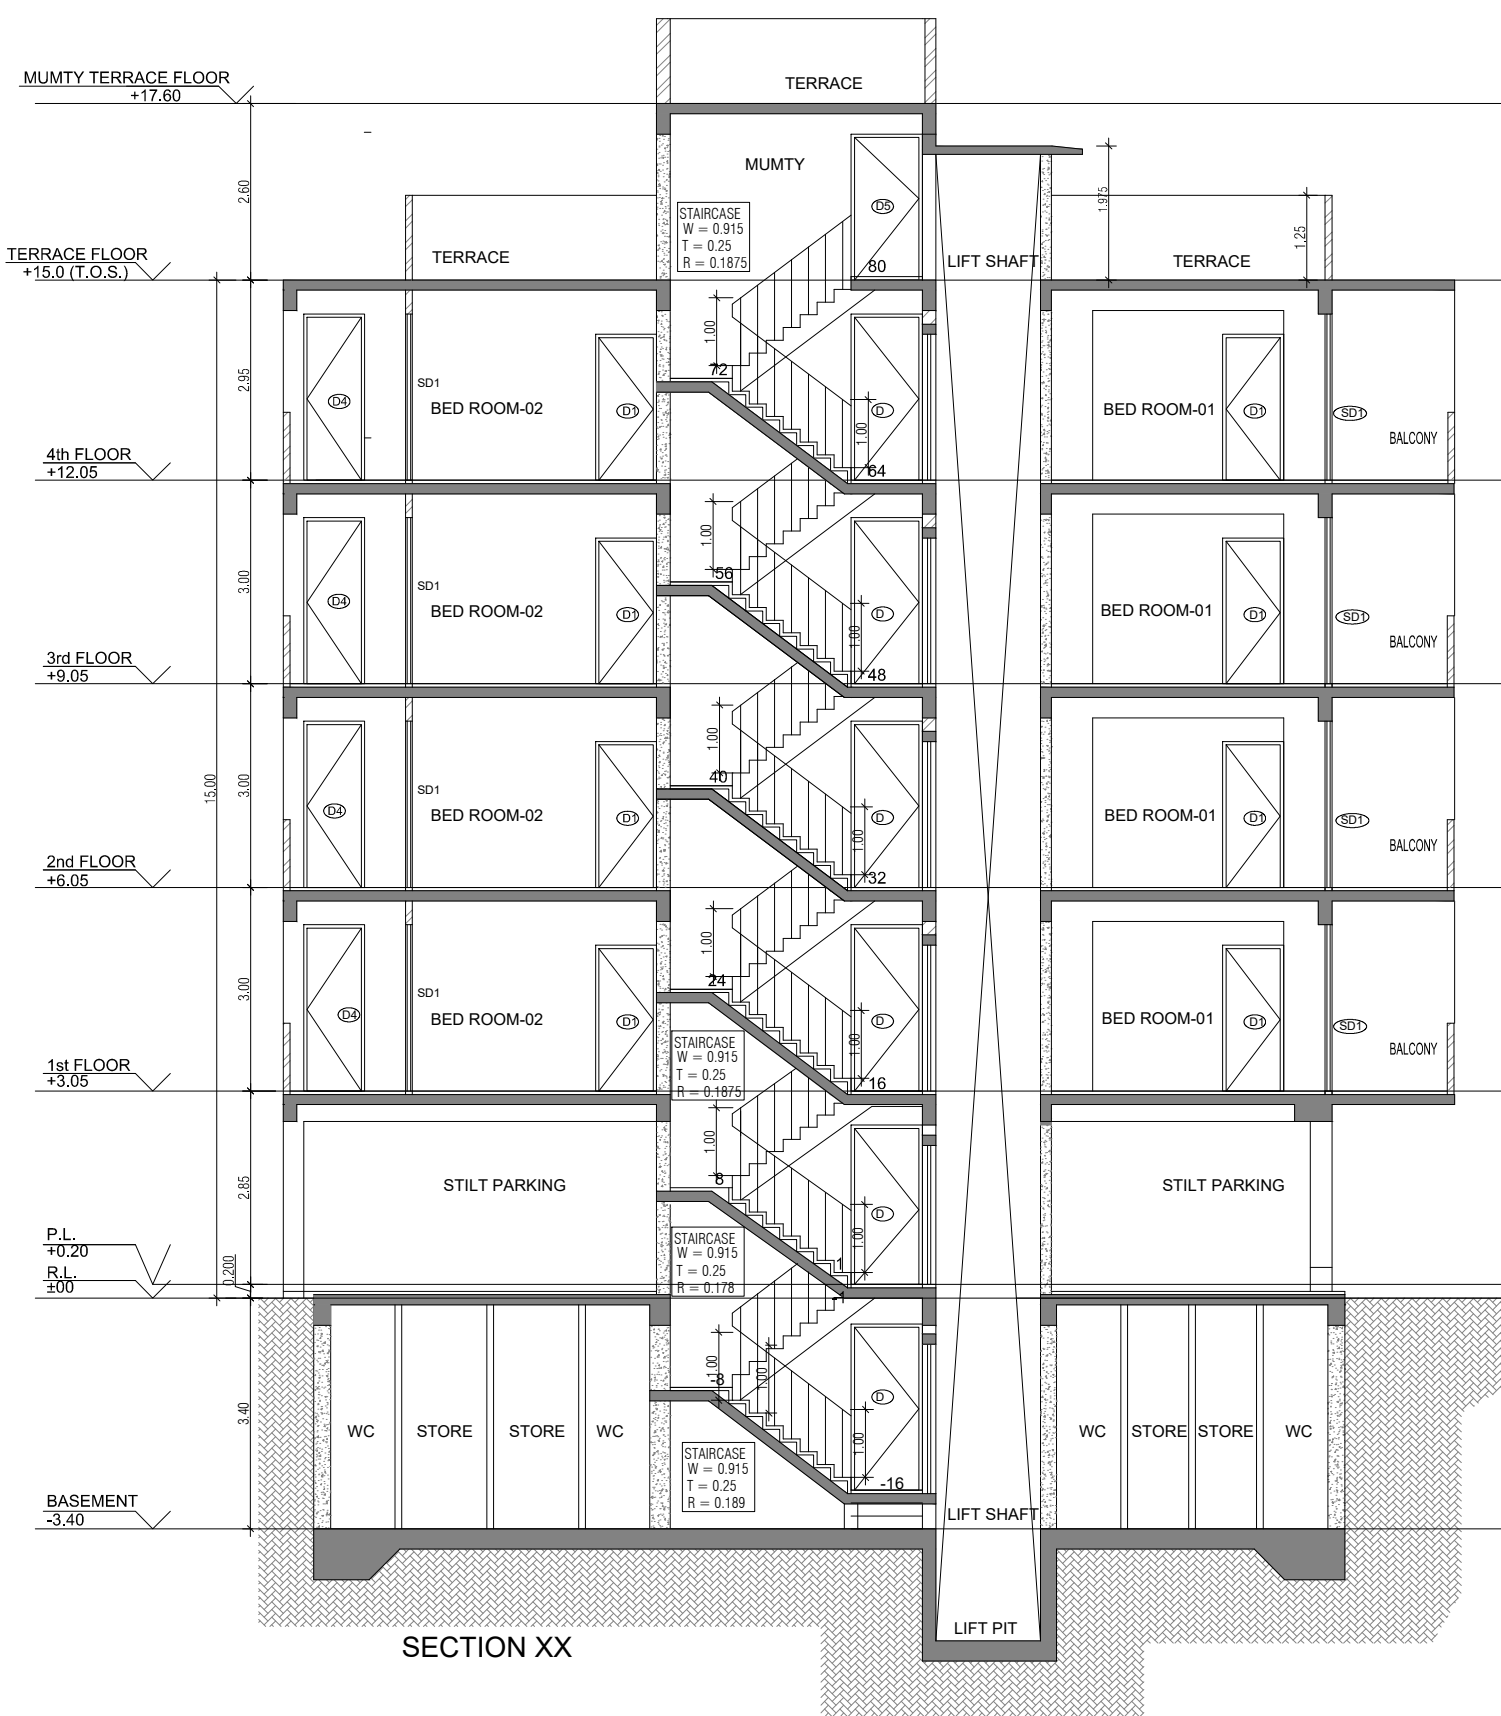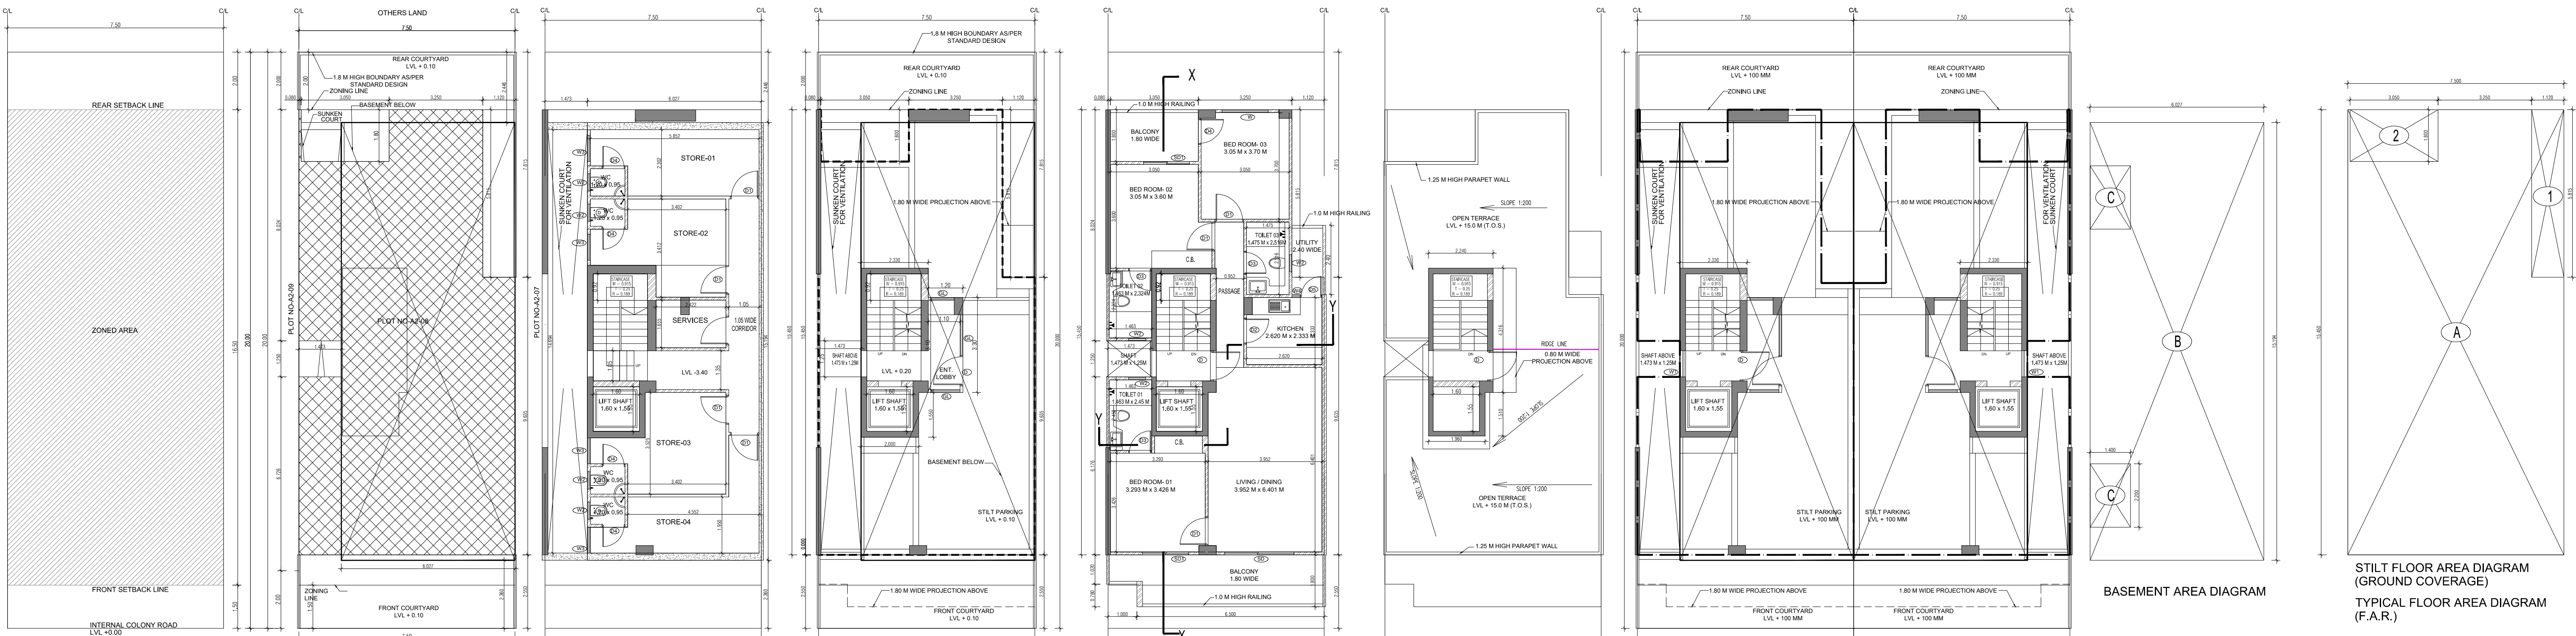

PLUMBING LEGEND FOR VERTICAL PIPES:-	
①	110 OD uPVC SOIL & WASTE VENT PIPE
②	110 OD uPVC WASTE & VENT PIPE FOR KITCHEN
③	DOMESTIC WATER SUPPLY DN. TAKE PIPE
④	FLUSHING WATER SUPPLY DN. TAKE PIPE
⑤	75 OD uPVC RAIN WATER PIPE FOR BALCONY
⑥	110 OD uPVC RAIN WATER PIPE FOR TERRACE
⑦	25# DOMESTIC WATER RISER PIPE TO OHT
⑧	20# FLUSHING WATER RISER PIPE TO OHT

DOOR WINDOW SCHEDULE						
SR NO.	LEGEND	WIDTH (MM)	HEIGHT (MM)	CILL LVL. (FROM FFL)	LINTEL LVL. (FROM FFL)	
1	D1	1.0	2.15	0	2.45	
2	D2	0.9	2.15	0	2.15	
3	D3	0.75	2.45	0	2.15	
4	D4	0.60	2.15	0	2.45	
5	D5	0.90	2.15	0	2.45	
6	D6	0.9	2.45	0	2.45	
7	D7	0.9	1.6	2.45	0	2.45
8	D8	0.9	1.6	2.45	0	2.45
9	D9	0.9	1.6	2.45	0	2.45
200	D200	0.9	1.6	2.45	0	2.45

	SEWAGE MANHOLE
	DRAINAGE CATCH BASIN
	DRAINAGE MANHOLE