







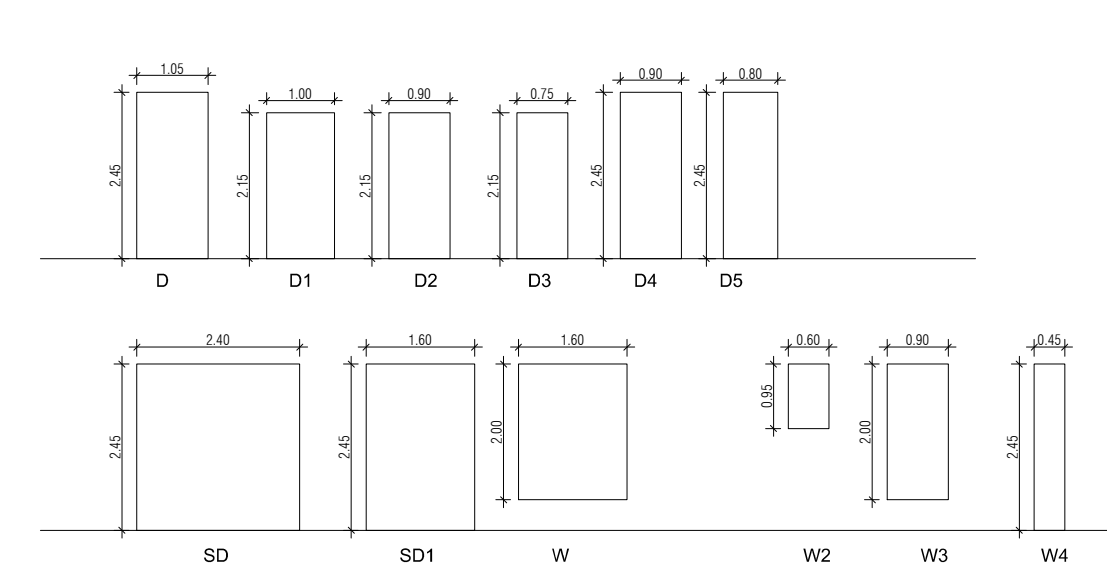


Table with 4 columns: SR NO, LEGEND, WIDTH (MM), HEIGHT (MM), CILL LVL (FROM FFL), and LINTEL LVL (FROM FFL).

SR NO	LEGEND	WIDTH (MM)	HEIGHT (MM)	CILL LVL (FROM FFL)	LINTEL LVL (FROM FFL)
1	110 OD uPVC SOIL & WASTE VENT PIPE	105	245	0	245
2	110 OD uPVC WASTE & VENT PIPE FOR KITCHEN	105	245	0	245
3	DOMESTIC WATER SUPPLY DN. TAKE PIPE	25	245	0	245
4	FLUSHING WATER SUPPLY DN. TAKE PIPE	25	245	0	245
5	75 OD uPVC RAIN WATER PIPE FOR BALCONY	75	245	0	245
6	110 OD uPVC RAIN WATER PIPE FOR TERRACE	110	245	0	245
7	25# DOMESTIC WATER RISER PIPE TO OHT	25	245	0	245
8	20# FLUSHING WATER RISER PIPE TO OHT	20	245	0	245

AREA CALCULATION table showing various area calculations and totals.

AREA CALCULATION		AREA	UNIT
TOTAL PLOT AREA (7.50 M x 20 M)		150	Sqmt
PERMISSIBLE FAR AS PER APPROVED ZONING PLAN @ 2.00		300	Sqmt
PURCHASEABLE FAR @ 0.64		96	Sqmt
TOTAL PERMISSIBLE FAR @ 2.64		396	Sqmt
PROPOSED FAR @ 2.63		395.395	Sqmt
PERMISSIBLE GROUND COVERAGE @ 75%		112.50	Sqmt
PROPOSED GROUND COVERAGE @ 69.24%		103.872	Sqmt
AREA OF STILT FLOOR (GROUND COVERAGE)			
A		7.5 x 15.450 x 1	115.875 Sqmt
TOTAL		115.875	Sqmt
DEDUCTION (D)			
1	1.12 x 5.815 x 1	6.513	Sqmt
2	3.05 x 1.800 x 1	5.490	Sqmt
TOTAL		12.003	Sqmt
PROPOSED GROUND COVERAGE = A-D		103.872	Sqmt
AREA CALCULATION FOR TYPICAL FLOOR (1st to 4th FLOOR)			
TOTAL AREA ON GROUND COVERAGE (X)		103.872	Sqmt
DEDUCTION			
1 (STAIRCASE)	1.880 x 3.715 x 1	6.984	Sqmt
2	1.600 x 1.550 x 1	2.480	Sqmt
3	1.473 x 1.250 x 1	1.841	Sqmt
TOTAL (Y)		11.305	Sqmt
TOTAL AREA OF TYPICAL FLOOR (X-Y)		92.567	Sqmt
BASEMENT BUILT UP AREA			
B		6.027 x 15.134 x 1	91.574 Sqmt
TOTAL		91.574	Sqmt
BASEMENT F.A.R. AREA			
C		1.400 x 2.200 x 2	6.160 Sqmt
TOTAL		6.160	Sqmt
NET NON F.A.R. AREA OF BASEMENT			
B-C		85.414	Sqmt
TOTAL		85.414	Sqmt
STILT FAR			
E	2.333 x 4.315 x 1	10.067	Sqmt
F	2.000 x 1.550 x 1	3.100	Sqmt
G	1.473 x 1.250 x 1	1.841	Sqmt
J	1.2 x 3.300 x 1	3.960	Sqmt
TOTAL		18.968	Sqmt
MUMTY AREA			
H		1.960 x 1.51 x 1	2.960 Sqmt
I		2.24 x 4.32 x 1	9.660 Sqmt
TOTAL		12.627	Sqmt
PROJECTION AREA			
6.500 x 1.800 x 1		11.700	Sqmt
1.000 x 1.020 x 1		1.020	Sqmt
1.120 x 1.800 x 1		2.016	Sqmt
3.050 x 1.800 x 1		5.490	Sqmt
TOTAL		20.226	Sqmt
GROUND COVERAGE CALCULATION			
STILT FLOOR AREA, STAIRCASE, LIFT SHAFT INCLUDED		103.872	Sqmt
TOTAL GROUND COVERAGE ACHIEVED		103.872	Sqmt
FAR CALCULATION			
TYPICAL FLOOR AREA x 4		370.267	Sqmt
FAR AREA UNBASEMENT		6.160	Sqmt
FAR AREA ON STILT		18.968	Sqmt
TOTAL FAR ACHIEVED		395.395	Sqmt
BUILT UP AREA CALCULATION			
BASEMENT AREA (FAR-NON FAR) + COVERAGE		697.102	Sqmt
AT STILT AREA + FLOOR AREA + STAIR CASE x 4 + MUMTY AREA + PROJECTION AREA x 4			

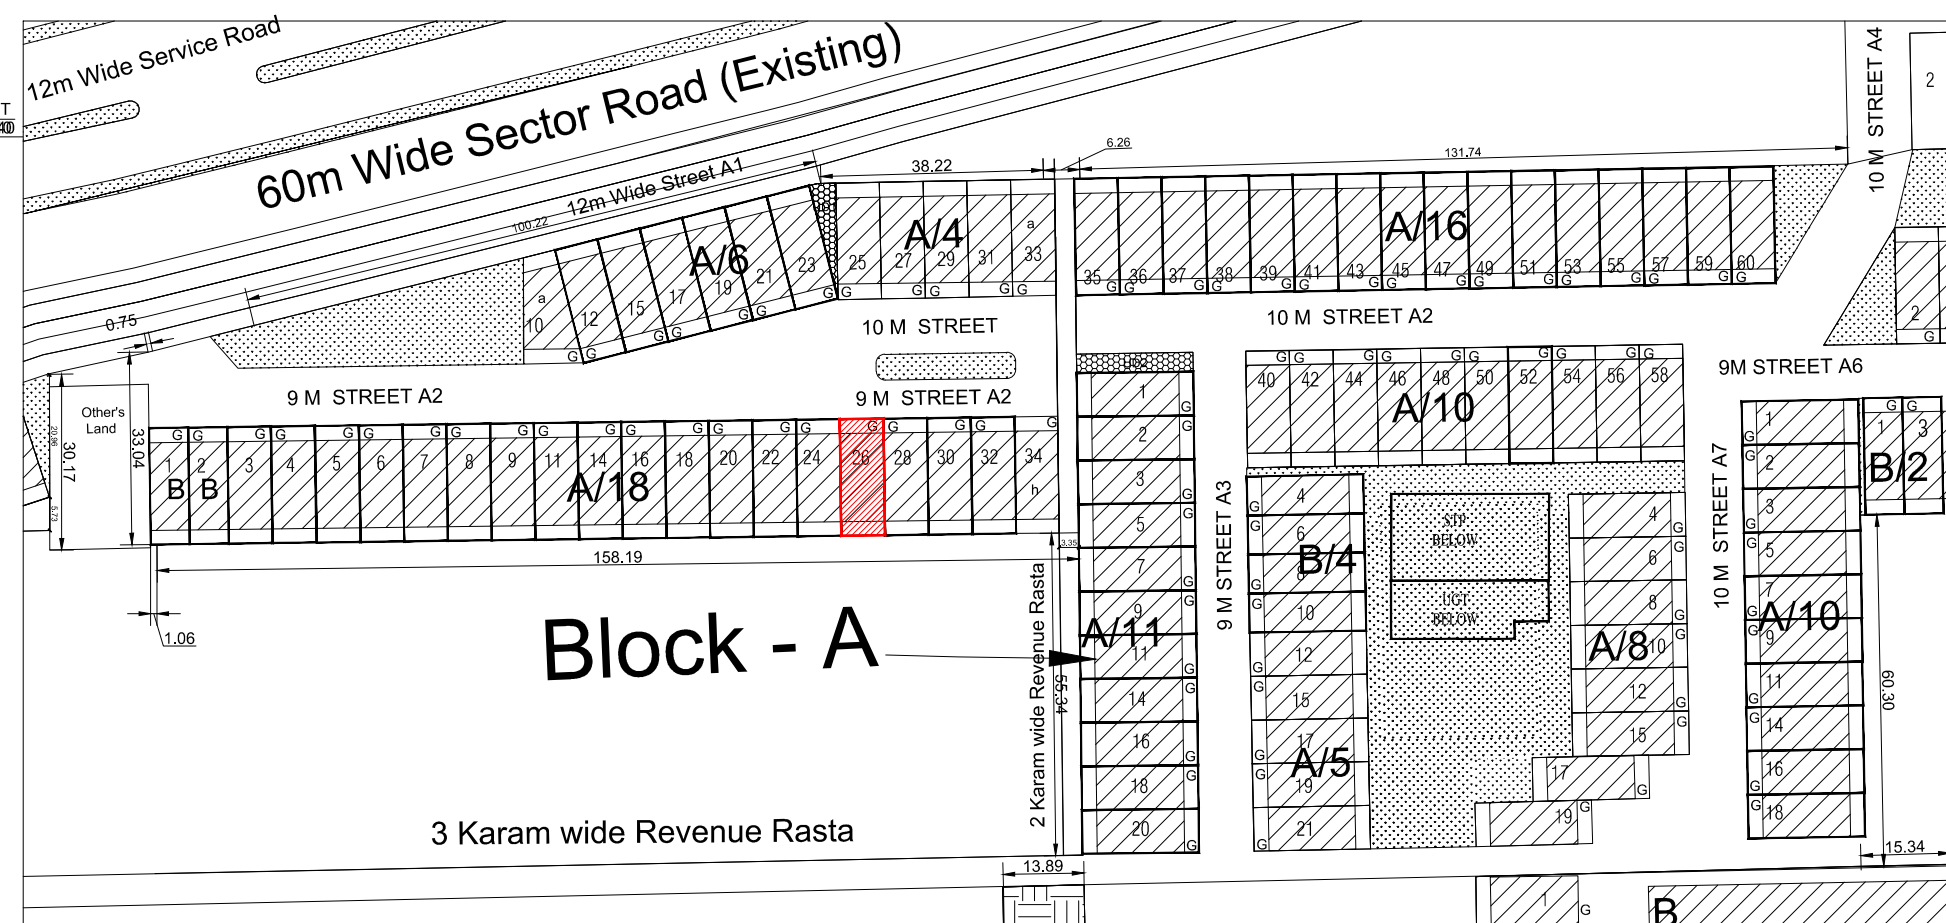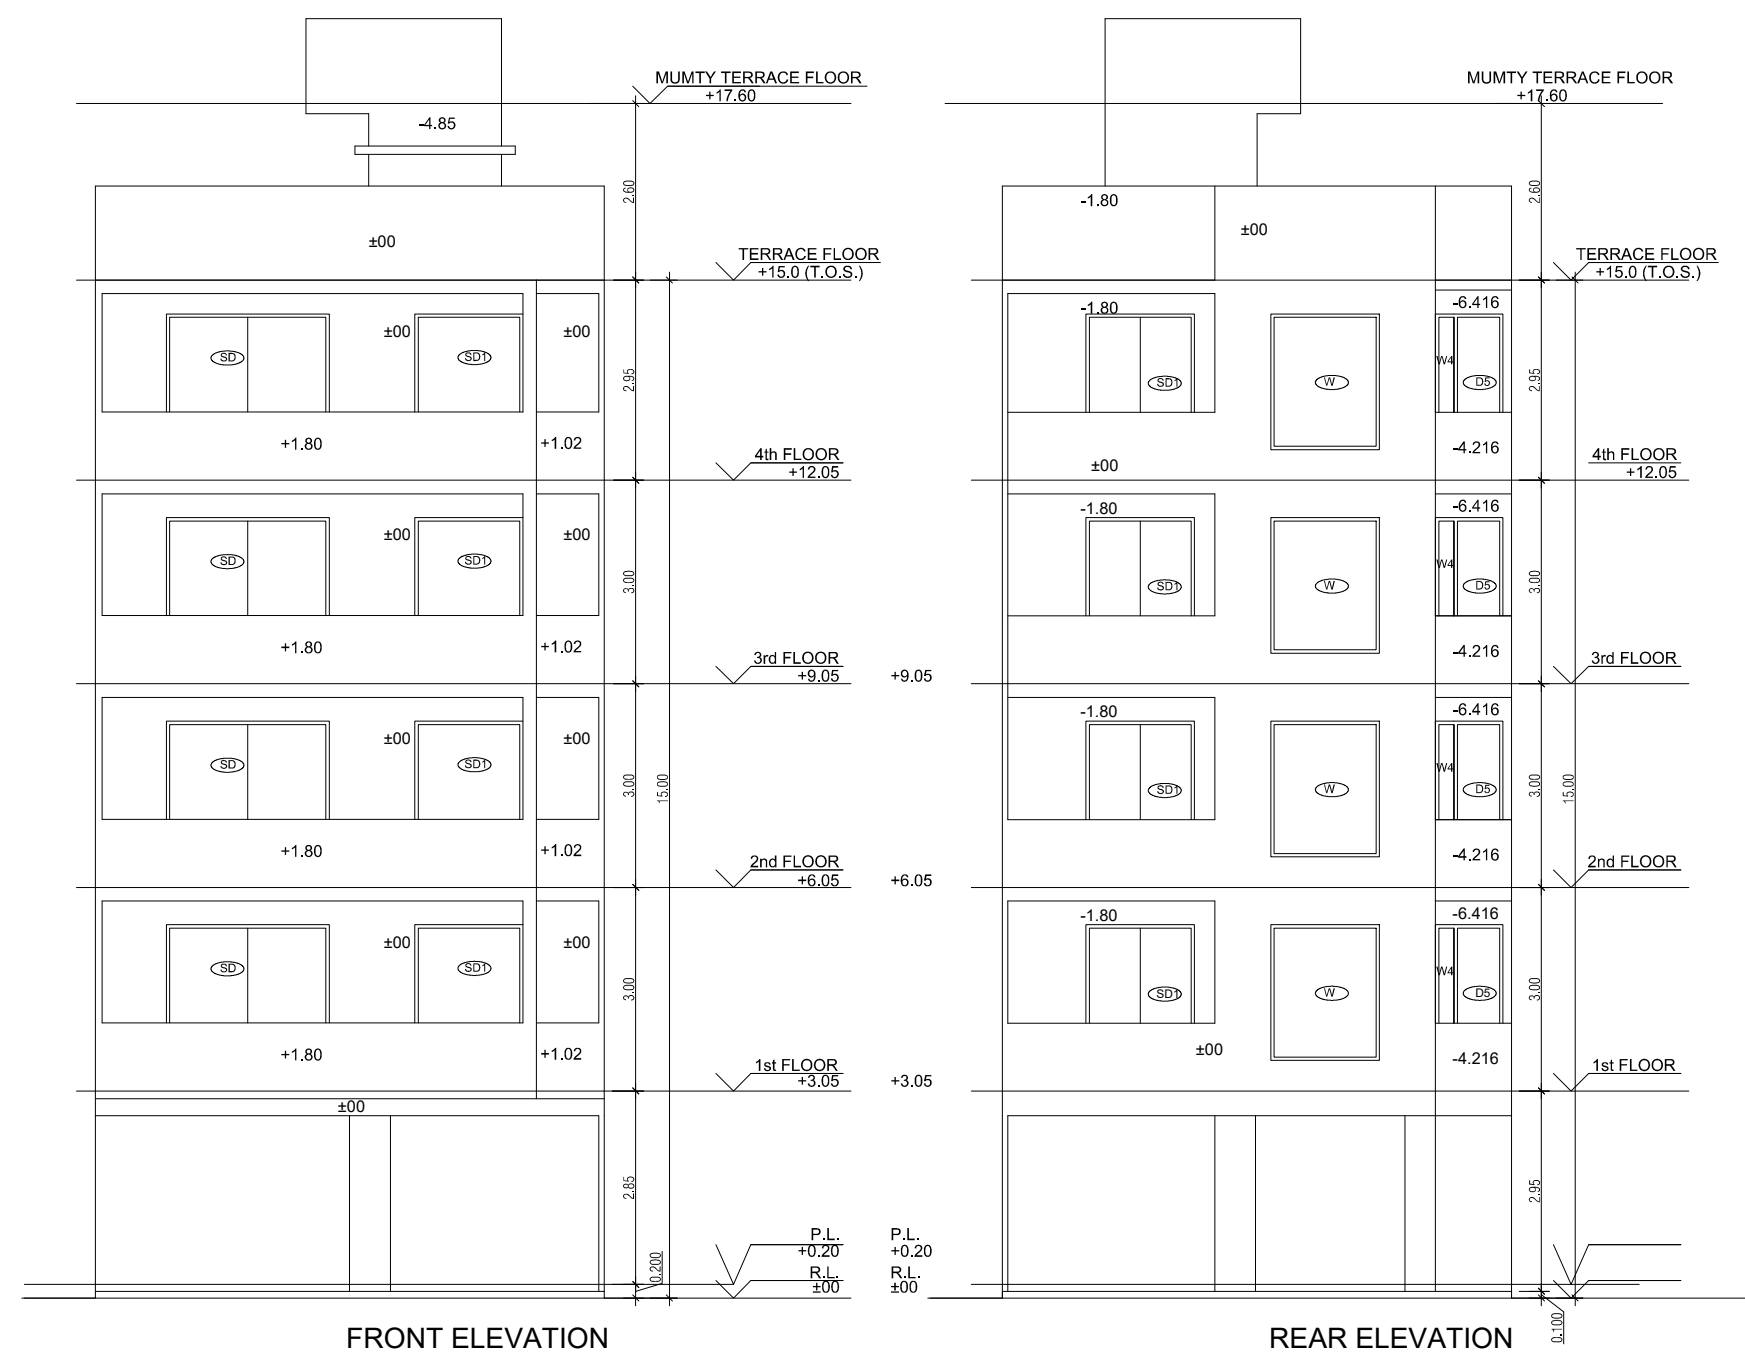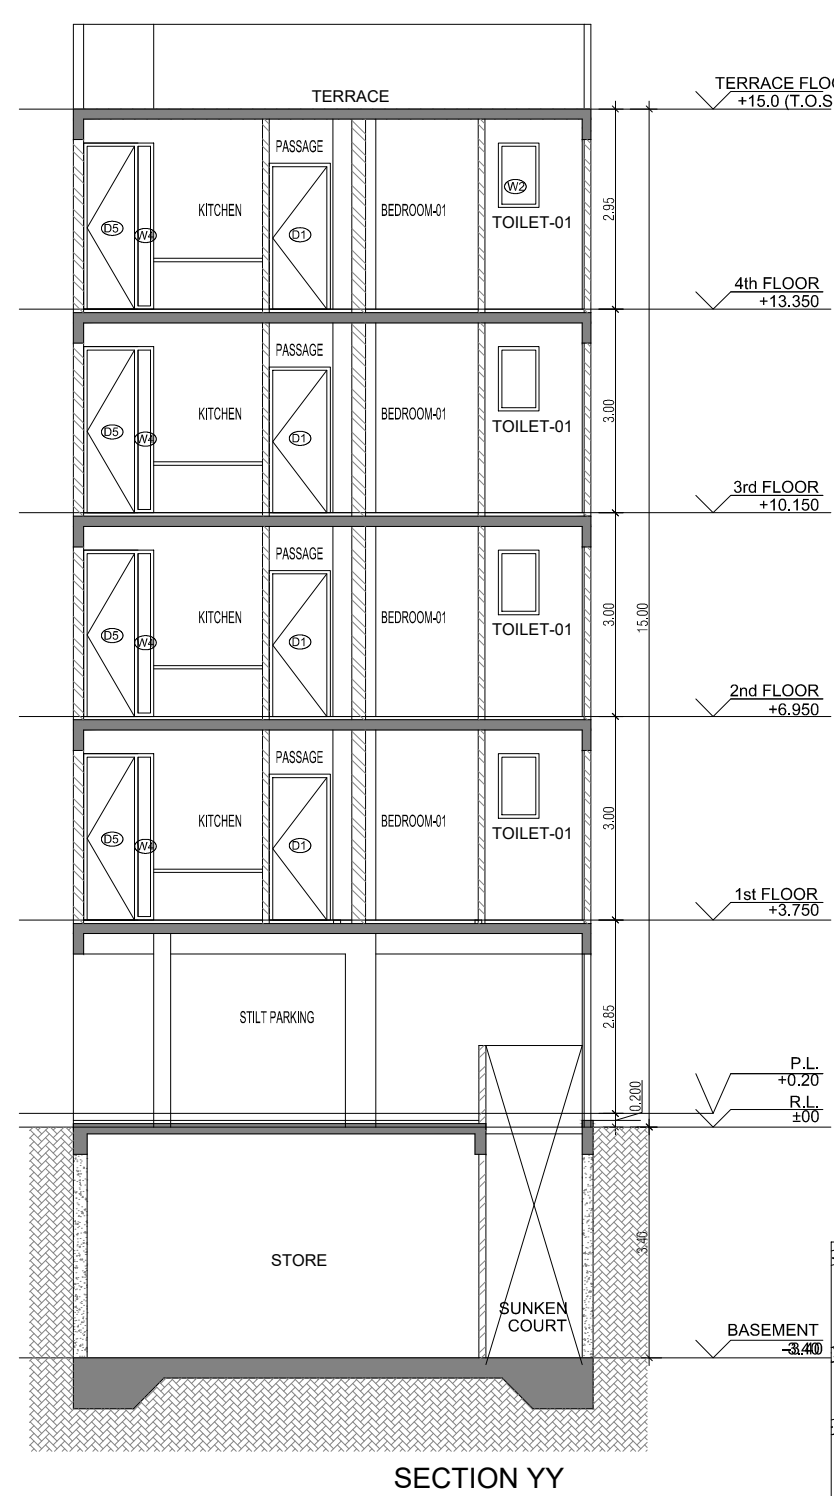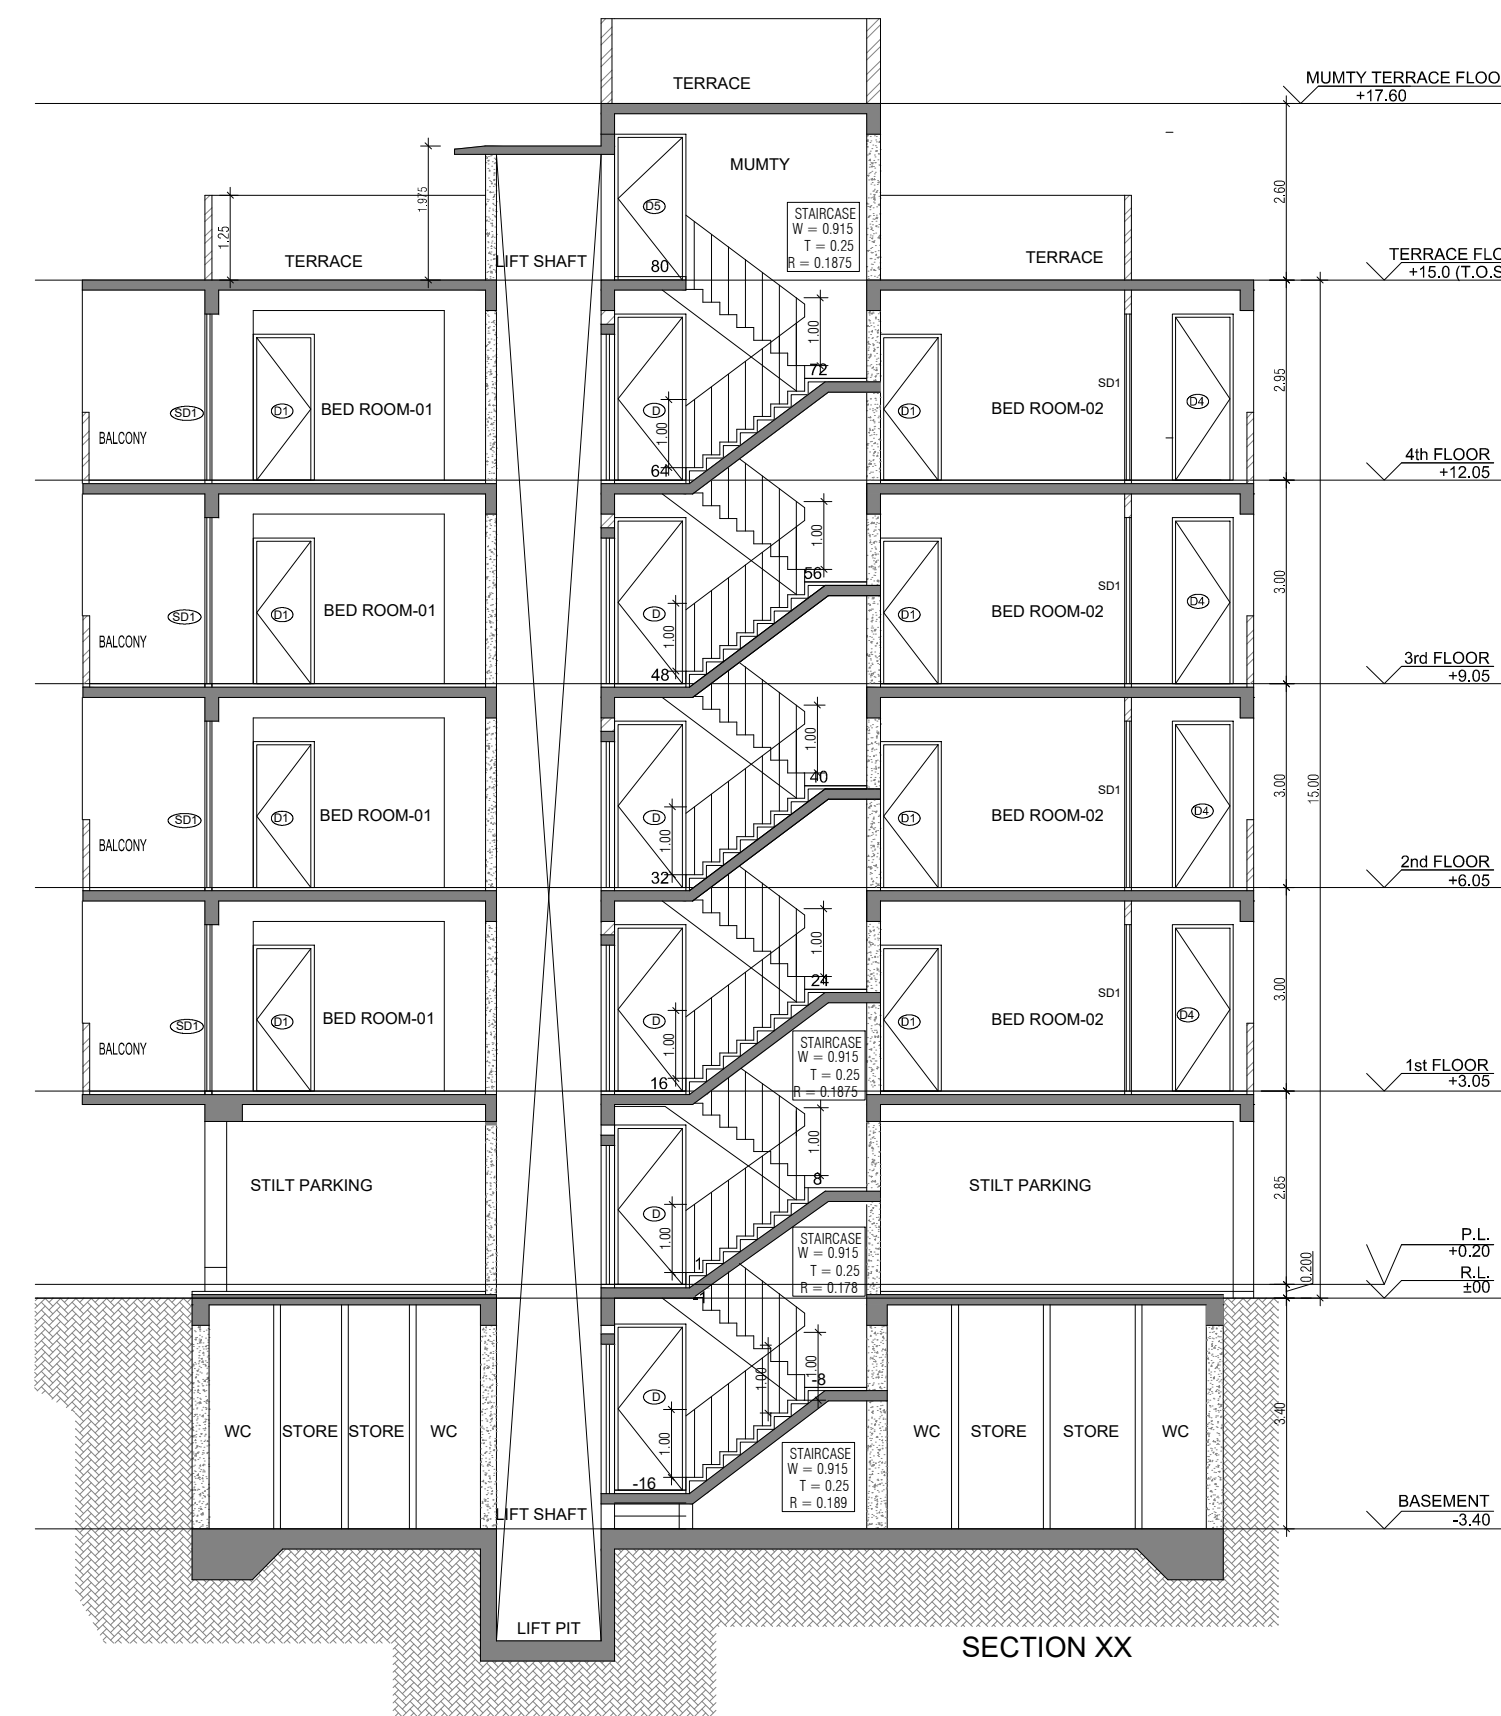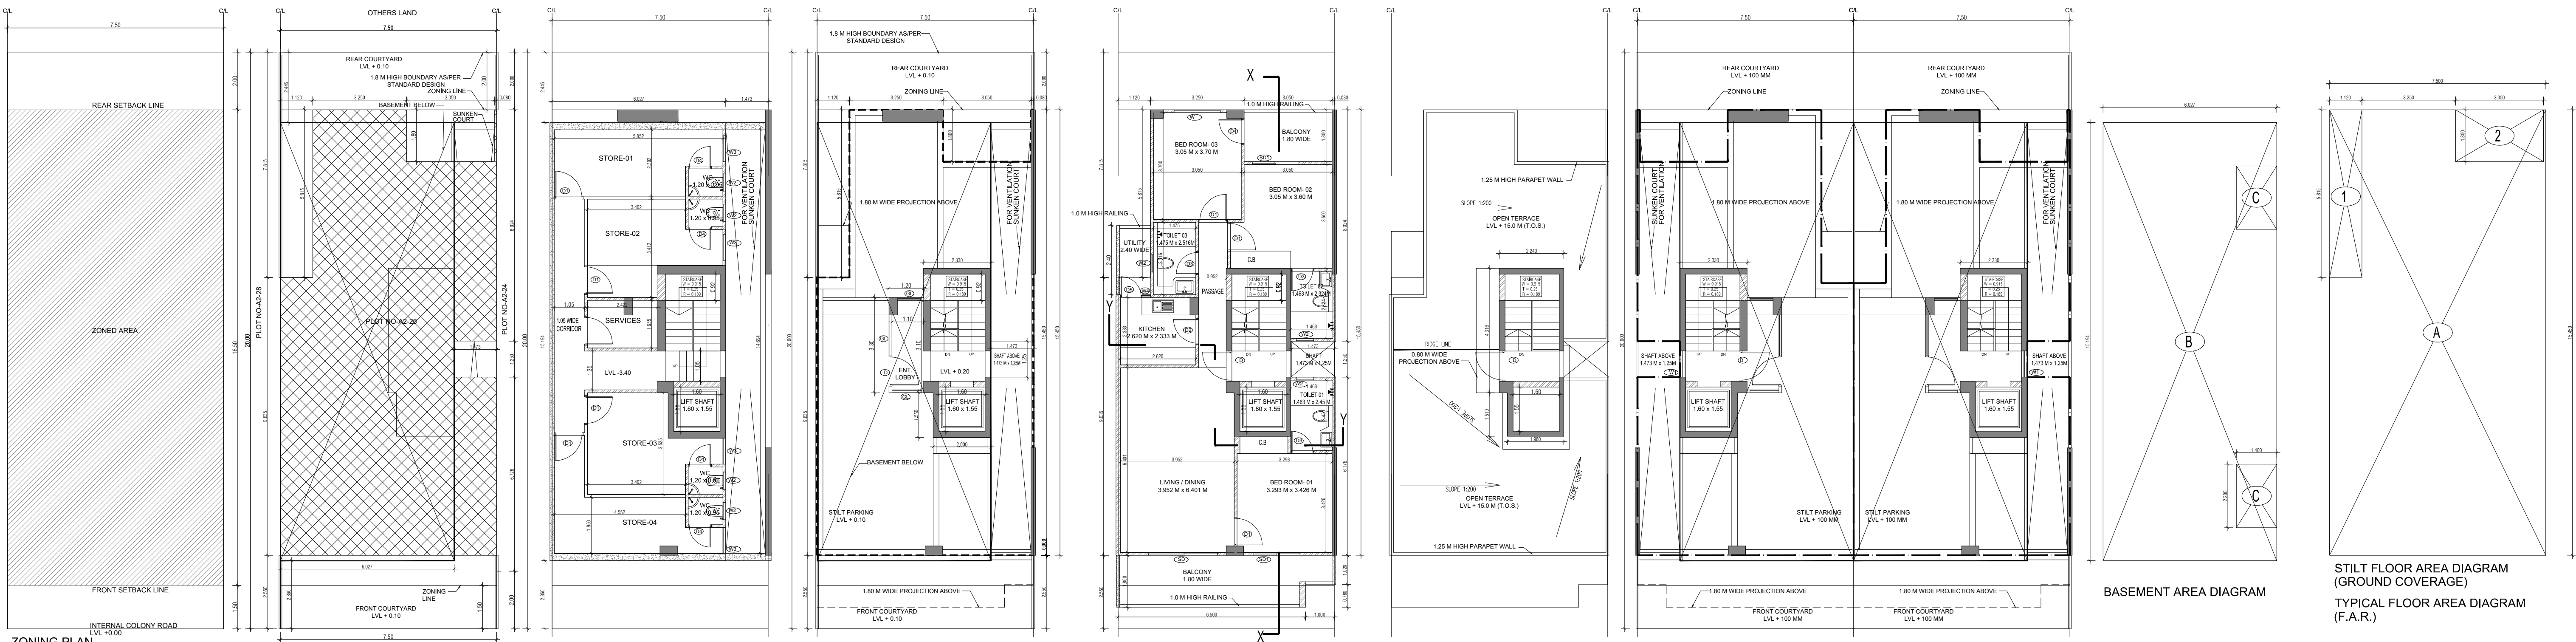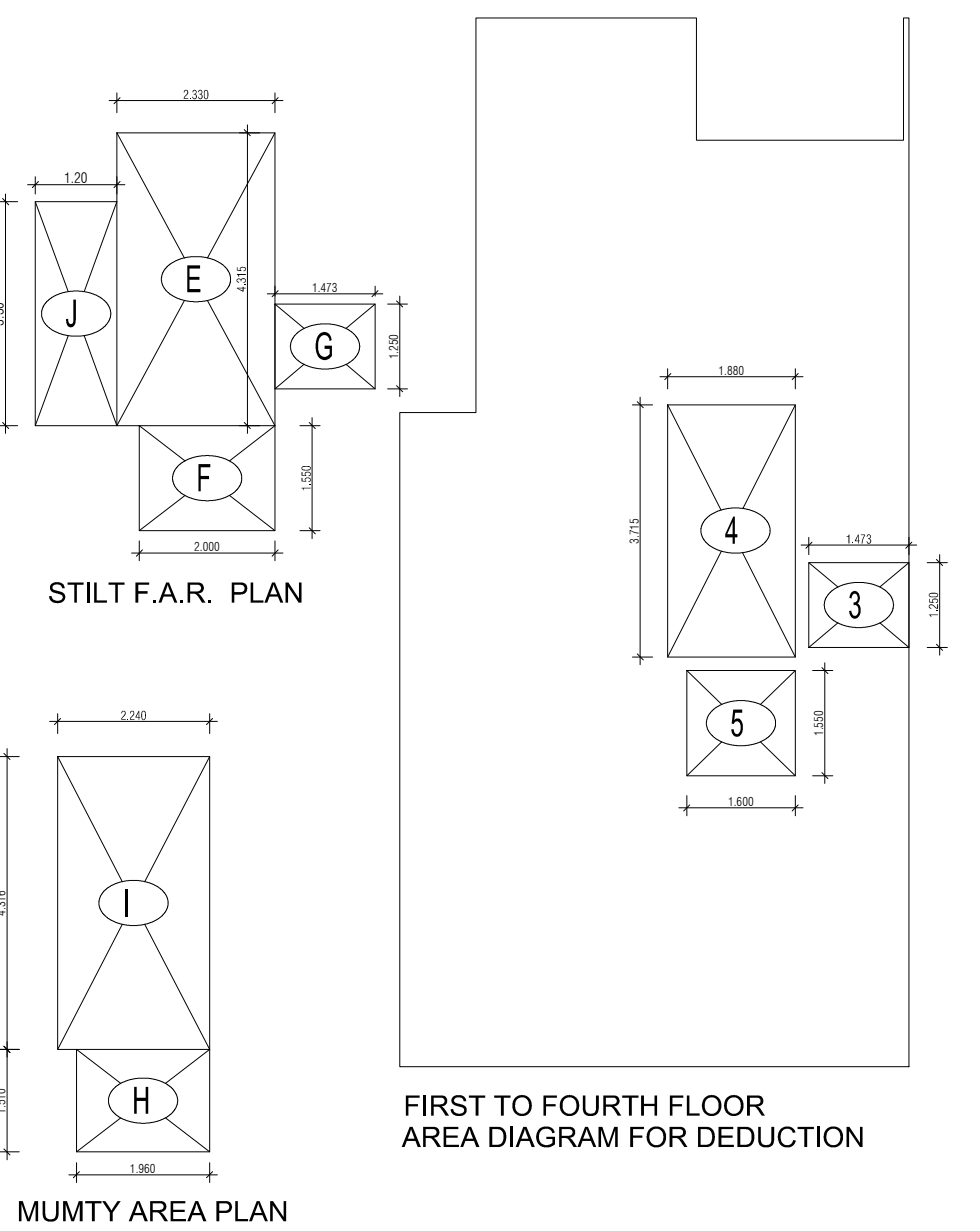

PROJECT - PROPOSED INDEPENDENT RESIDENTIAL FLOORS ON PLOT NO A2 - 26 (STREET A2 - 9 M WIDE) IN AFFORDABLE RESIDENTIAL PLOTTED COLONY UNDER DEEN DAYAL JAN AWAS YOJNA-2016 OVER AN AREA MEASURING 26.91875 (LICESNE NO 94 OF 2021 DT 12.11.2021) IN VILLAGE HAYATPUR, SECTOR 93, GURUGRAM, BEING DEVELOPED BY SAGARDUTT BUILDERS & DEVELOPERS PVT LTD & OTHERS IN COLLABORATION WITH DLF LIMITED.

OWNERS - DLF LIMITED






ARCHITECTS - Arcop Associates Private Limited Plot- 36b, Sec-32, Gurgaon-122001 Ph.: 26242050, 26242169

DRAWING TITLE - TYPE A (7.5 M x 20 M) FLOORS PLANS WITH AREA CALCULATIONS , ELEVATION & SECTIONS


DRAWING NUMBER - ARCHITECT SIGN - AUTHORISED SIGN

SCALE = 1:50

DATE - DRAWN BY - CHECKED BY - DRAWING NUMBER -

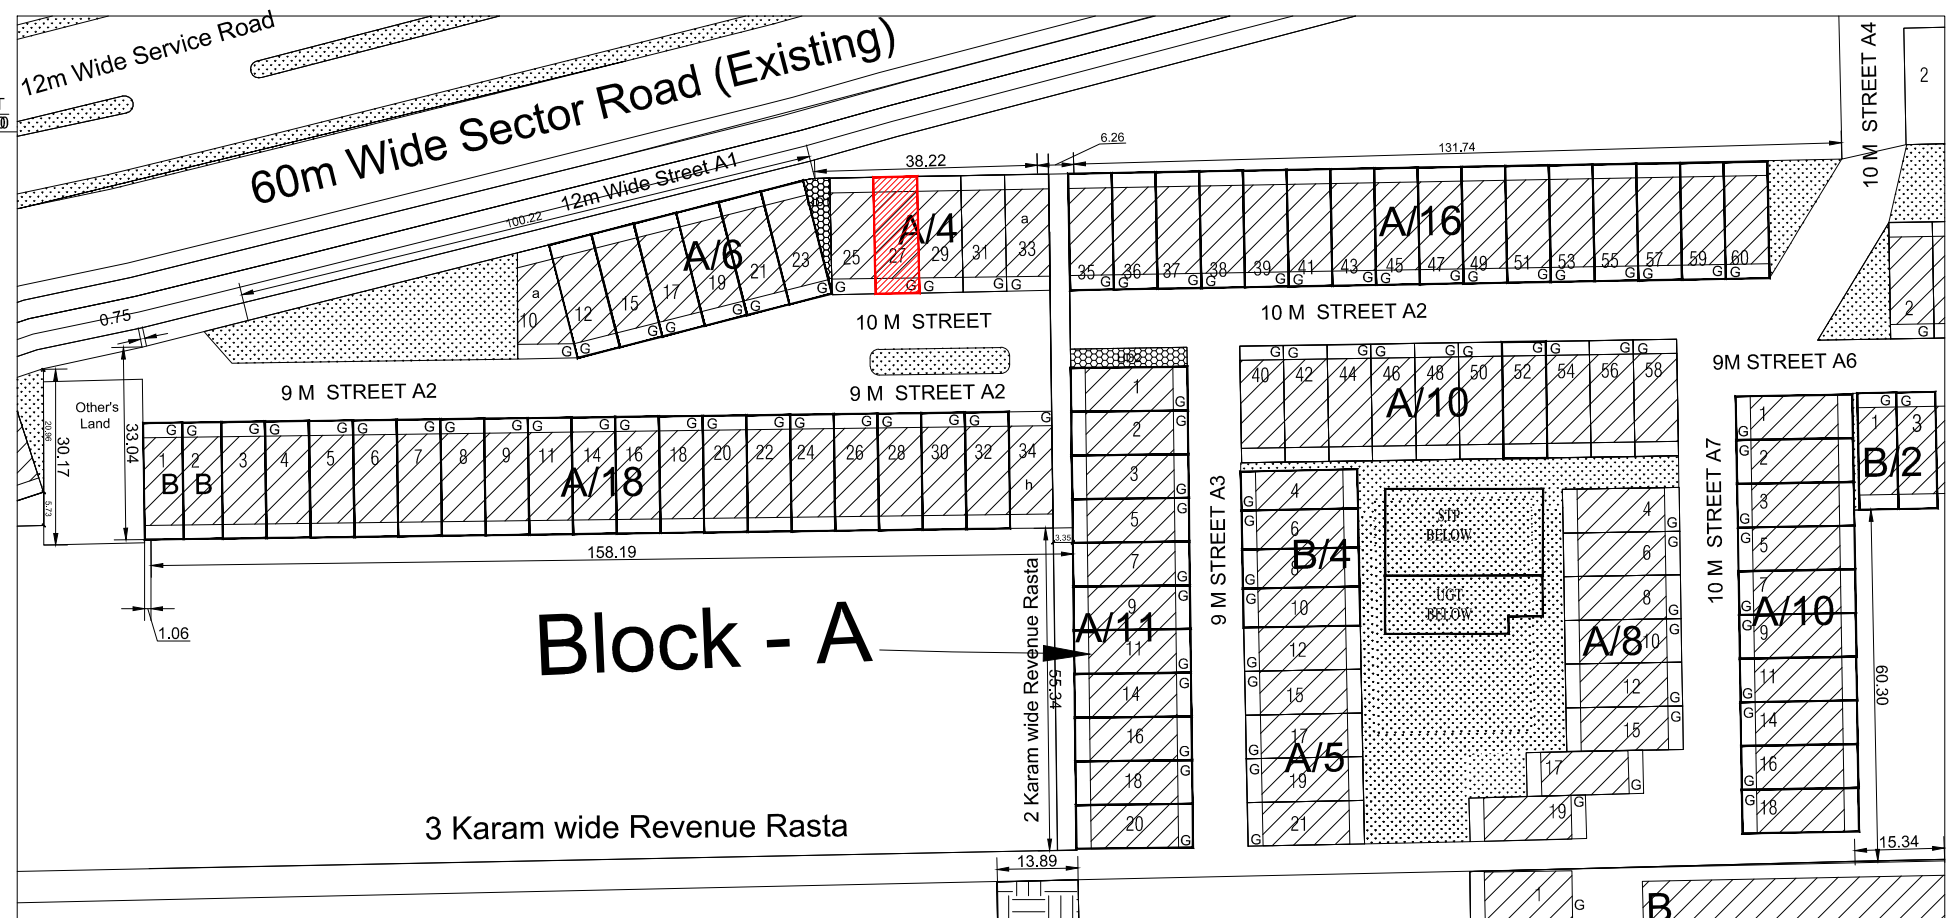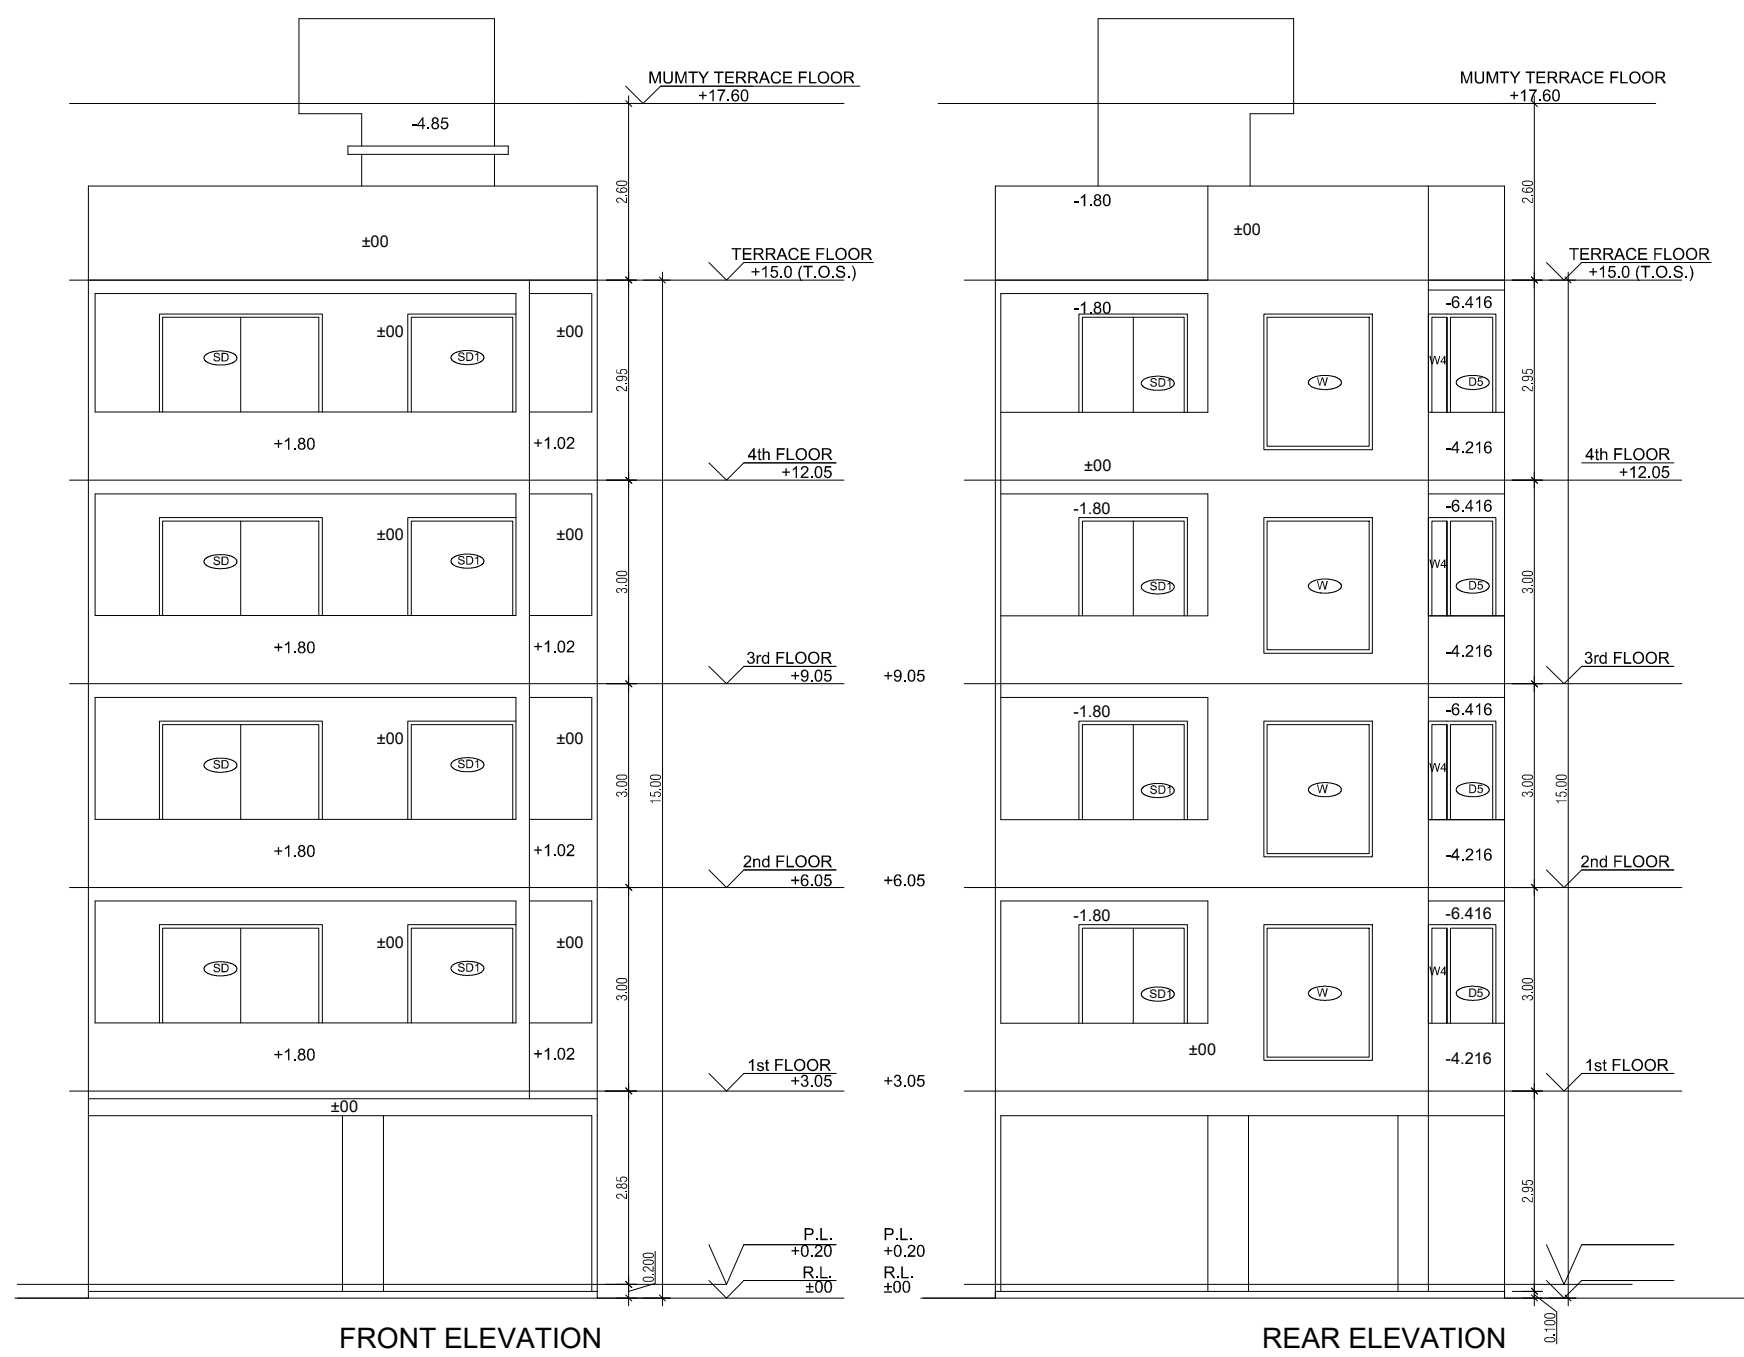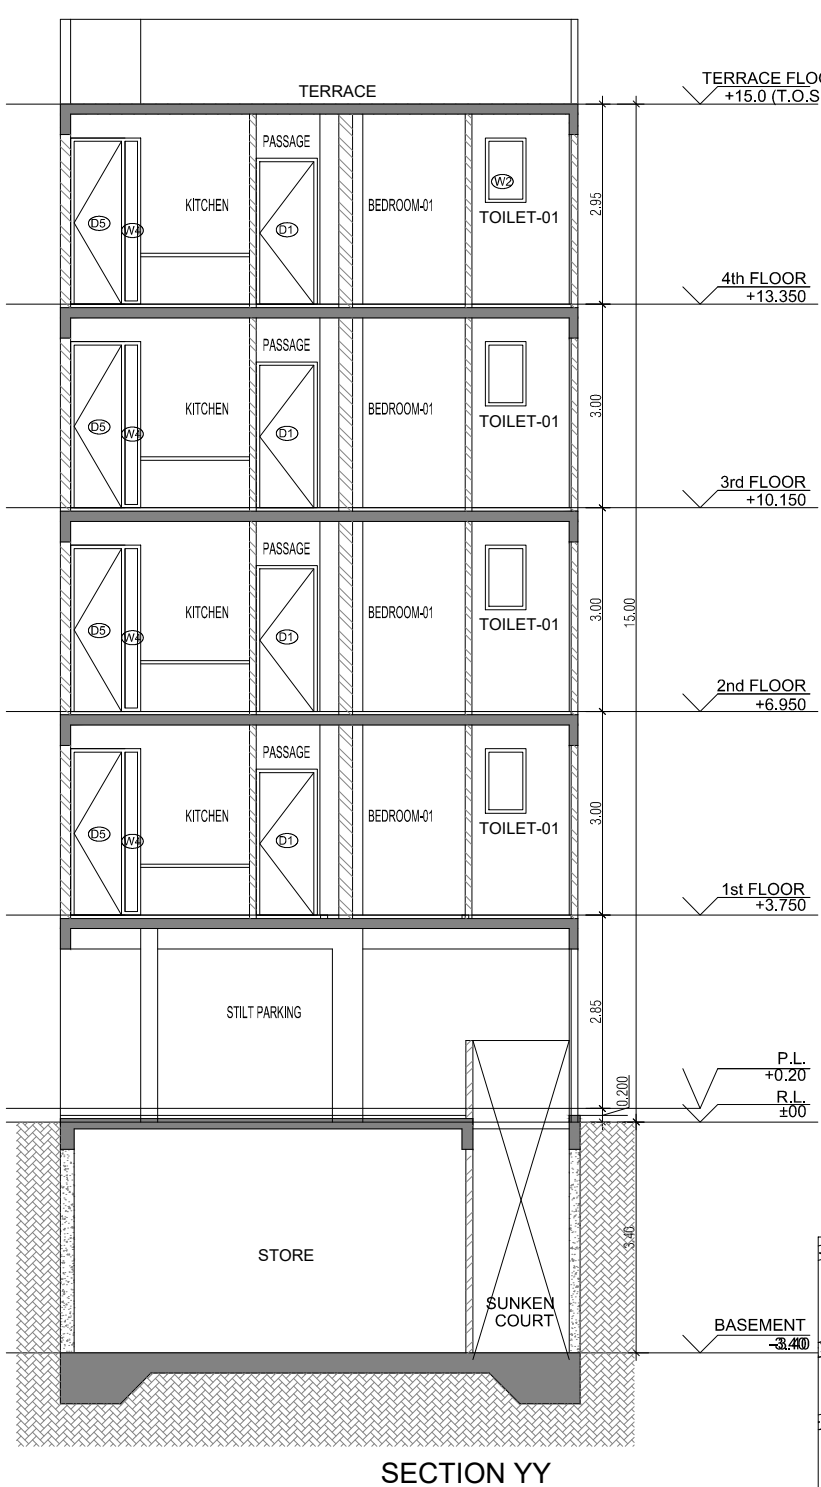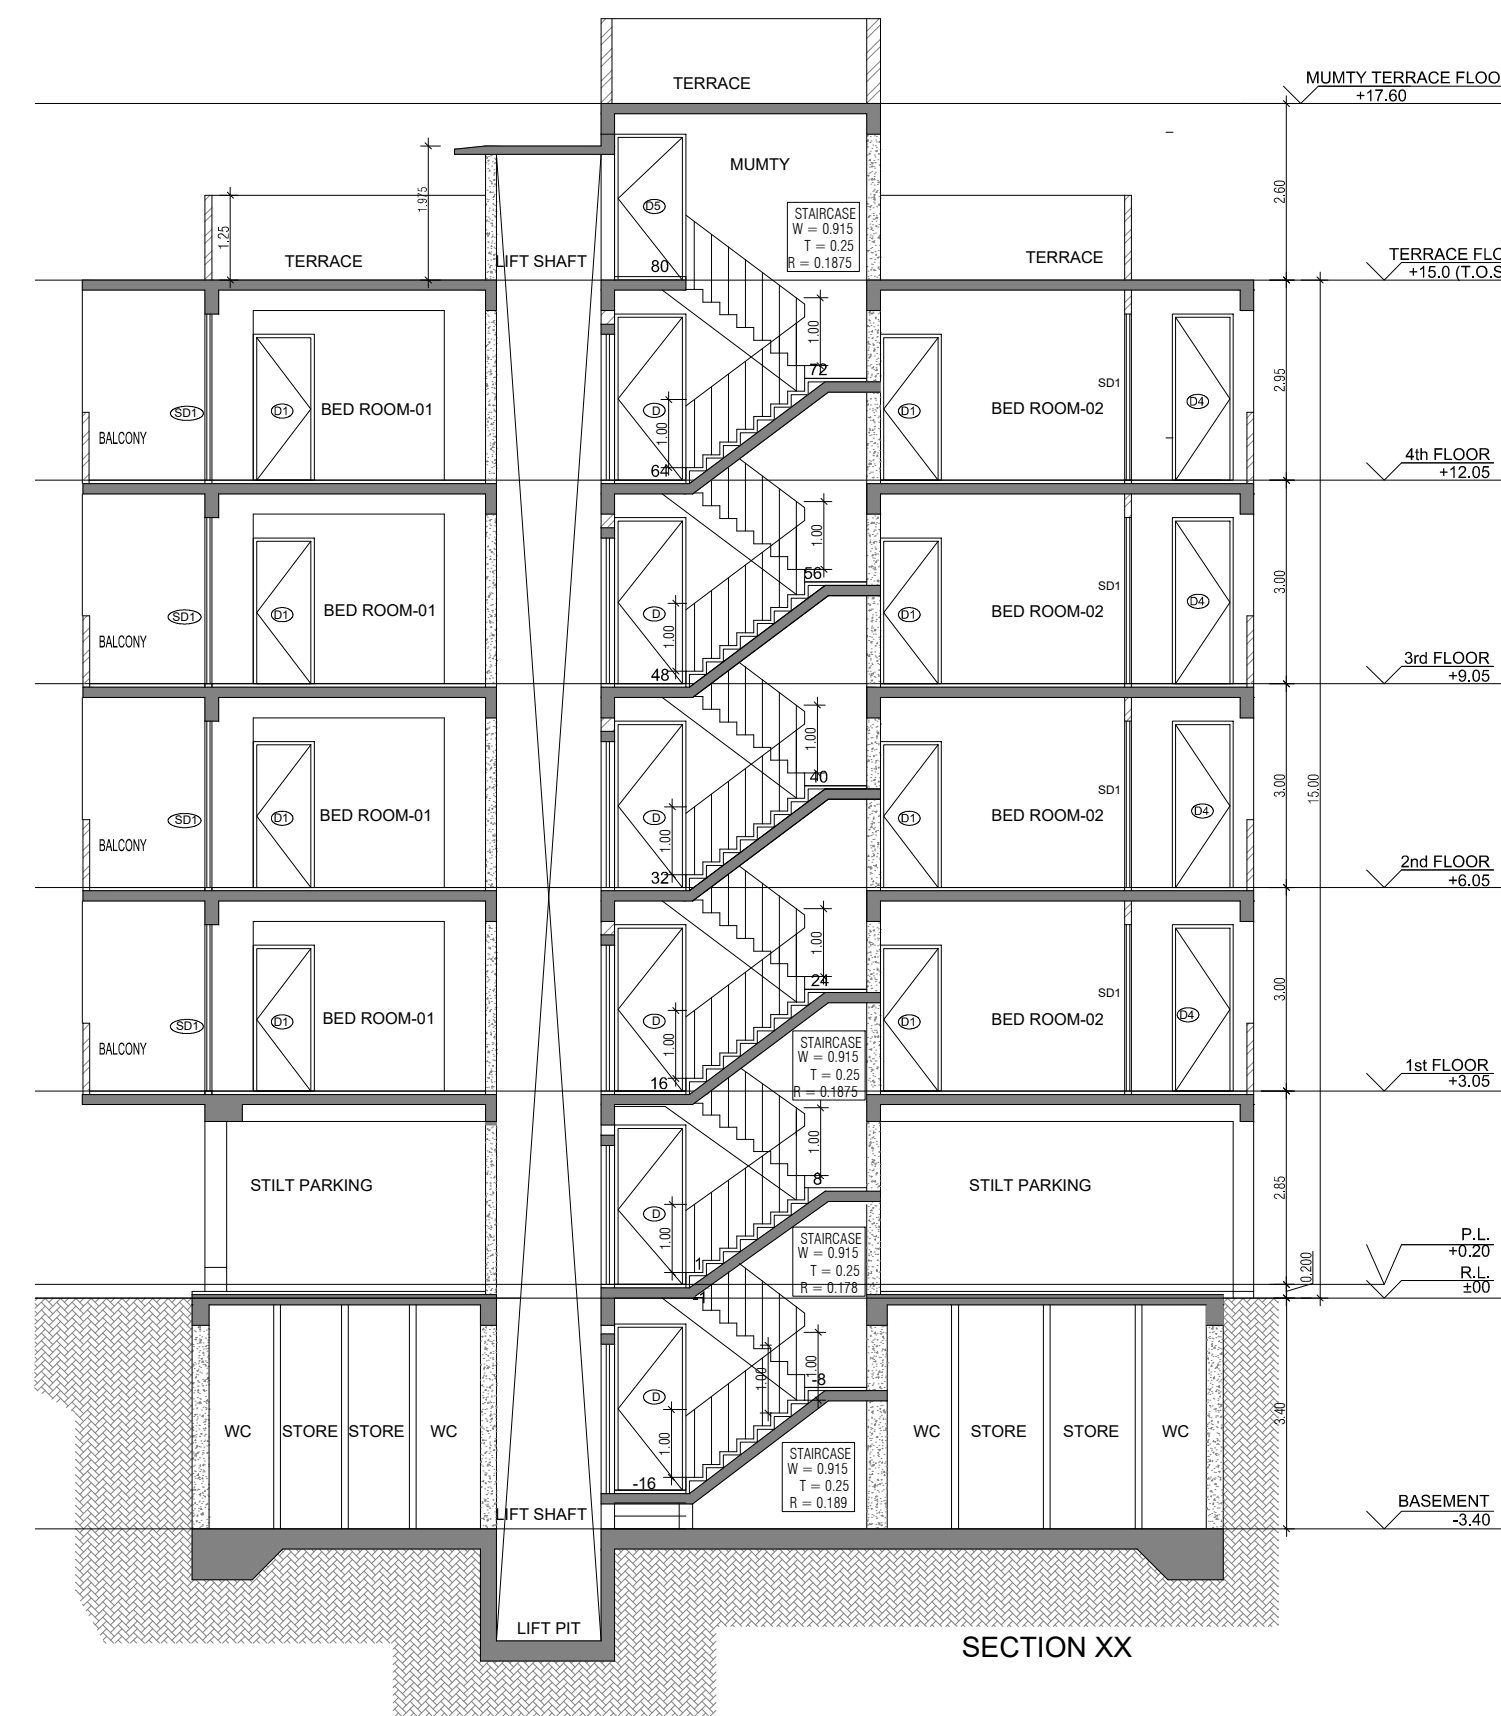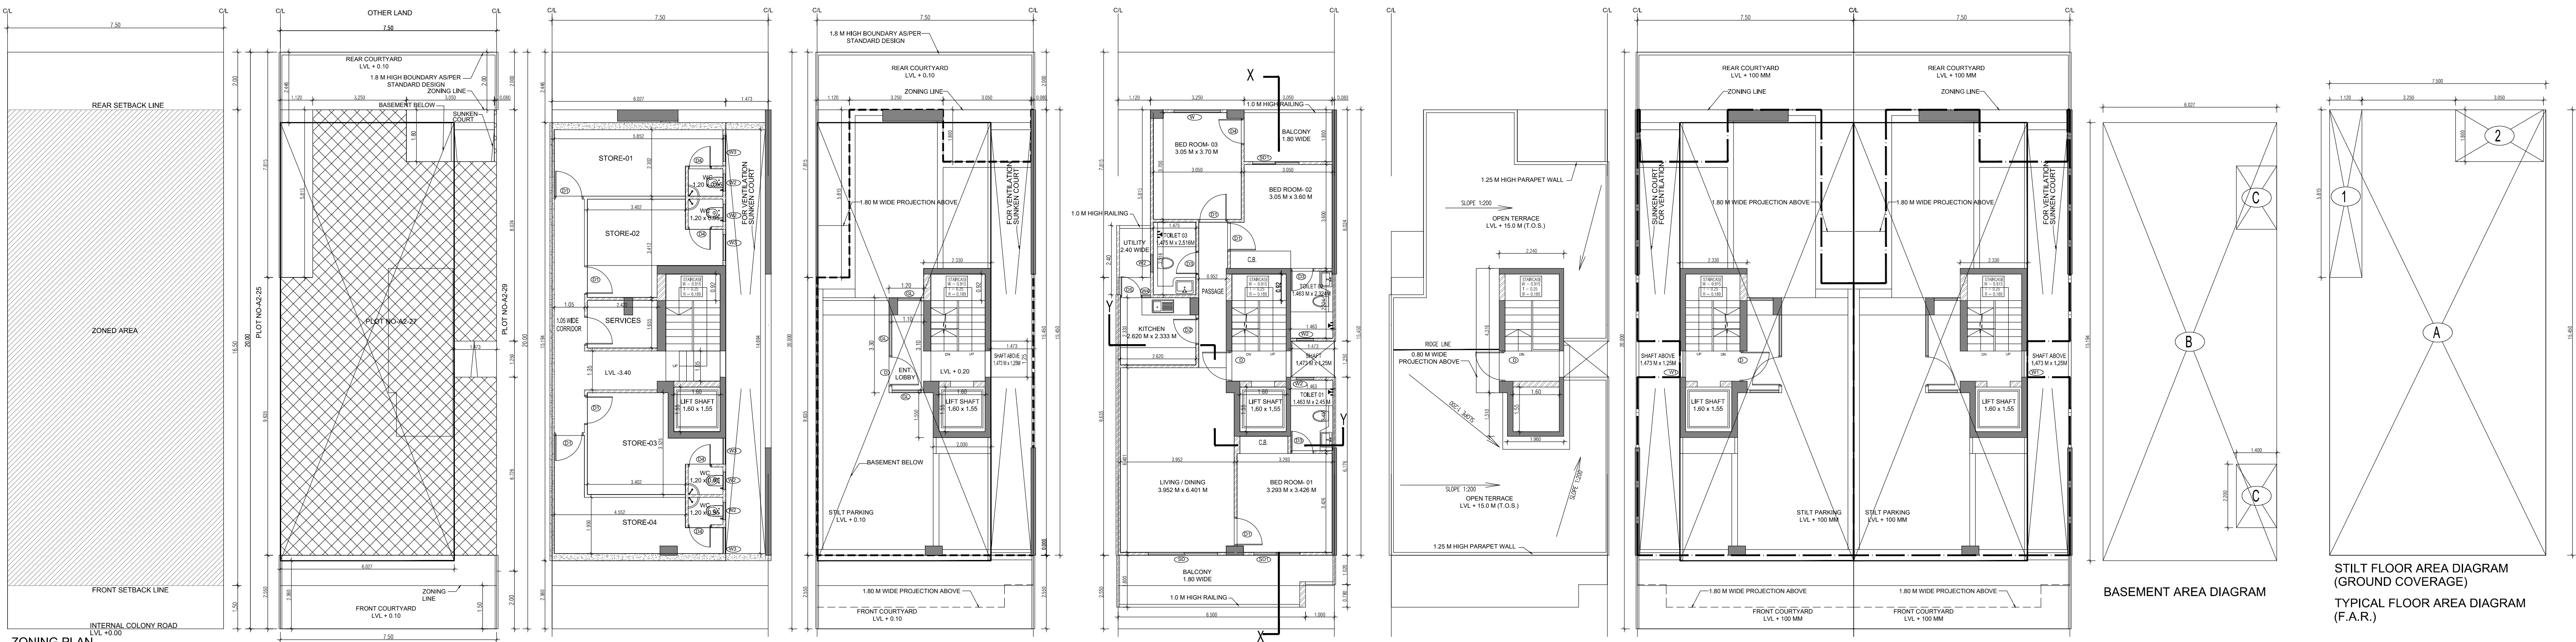

AREA CALCULATION		
	AREA	UNIT
TOTAL PLOT AREA (7.50 M x 20 M)	150	Sqmt
PERMISSIBLE FAR AS PER APPROVED ZONING PLAN @ 2.00	300	Sqmt
PURCHASEABLE FAR @ 0.64	96	Sqmt
TOTAL PERMISSIBLE FAR @ 2.64	396	Sqmt
PROPOSED FAR @ 2.63	395.395	Sqmt
PERMISSIBLE GROUND COVERAGE @ 75%	112.50	Sqmt
PROPOSED GROUND COVERAGE @ 69.24%	103.872	Sqmt
AREA OF STILT FLOOR (GROUND COVERAGE)		
A	7.5 x 15.450 x 1	115.875 Sqmt
TOTAL		115.875 Sqmt
DEDUCTION (D)		
1	1.12 x 5.815 x 1	6.513 Sqmt
2	3.05 x 1.800 x 1	5.490 Sqmt
TOTAL		12.003 Sqmt
PROPOSED GROUND COVERAGE = A-D		103.872 Sqmt
AREA CALCULATION FOR TYPICAL FLOOR (1st to 4th FLOOR)		
TOTAL AREA ON GROUND COVERAGE (X)		103.872 Sqmt
DEDUCTION		
1 (STAIRCASE)	1.880 x 3.715 x 1	6.984 Sqmt
2	1.600 x 1.550 x 1	2.480 Sqmt
3	1.473 x 1.250 x 1	1.841 Sqmt
TOTAL (Y)		11.305 Sqmt
TOTAL AREA OF TYPICAL FLOOR (X-Y)		92.567 Sqmt
BASEMENT BUILT UP AREA		
B	6.027 x 15.194 x 1	91.574 Sqmt
TOTAL		91.574 Sqmt
BASEMENT F.A.R. AREA		
C	1.400 x 2.200 x 2	6.160 Sqmt
TOTAL		6.160 Sqmt
NET NON F.A.R. AREA OF BASEMENT		
B-C		85.414 Sqmt
TOTAL		85.414 Sqmt
STILT FAR		
E	2.333 x 4.315 x 1	10.067 Sqmt
F	2.000 x 1.550 x 1	3.100 Sqmt
G	1.473 x 1.250 x 1	1.841 Sqmt
J	1.2 x 3.300 x 1	3.960 Sqmt
TOTAL		18.968 Sqmt
MUMTY AREA		
H	1.960 x 1.51 x 1	2.960 Sqmt
I	2.24 x 4.32 x 1	9.660 Sqmt
TOTAL		12.627 Sqmt
PROJECTION AREA		
6.500 x 1.800 x 1		11.700 Sqmt
1.000 x 1.020 x 1		1.020 Sqmt
1.120 x 1.800 x 1		2.016 Sqmt
3.050 x 1.800 x 1		5.490 Sqmt
TOTAL		20.226 Sqmt
GROUND COVERAGE CALCULATION		
STILT FLOOR AREA, STAIRCASE, LIFT SHAFT INCLUDED		103.872 Sqmt
TOTAL GROUND COVERAGE ACHIEVED		103.872 Sqmt
FAR CALCULATION		
TYPICAL FLOOR AREA x 4		370.267 Sqmt
FAR AREA UN-BASEMENT		6.160
FAR AREA ON STILT		18.968 Sqmt
TOTAL FAR ACHIEVED		395.395 Sqmt
BUILT UP AREA CALCULATION		
BASEMENT AREA (FAR-NON FAR) + COVERAGE		697.102 Sqmt
AT STILT AREA + FLOOR AREA + STAIR CASE x 4 + MUMTY AREA + PROJECTION AREA x 4		

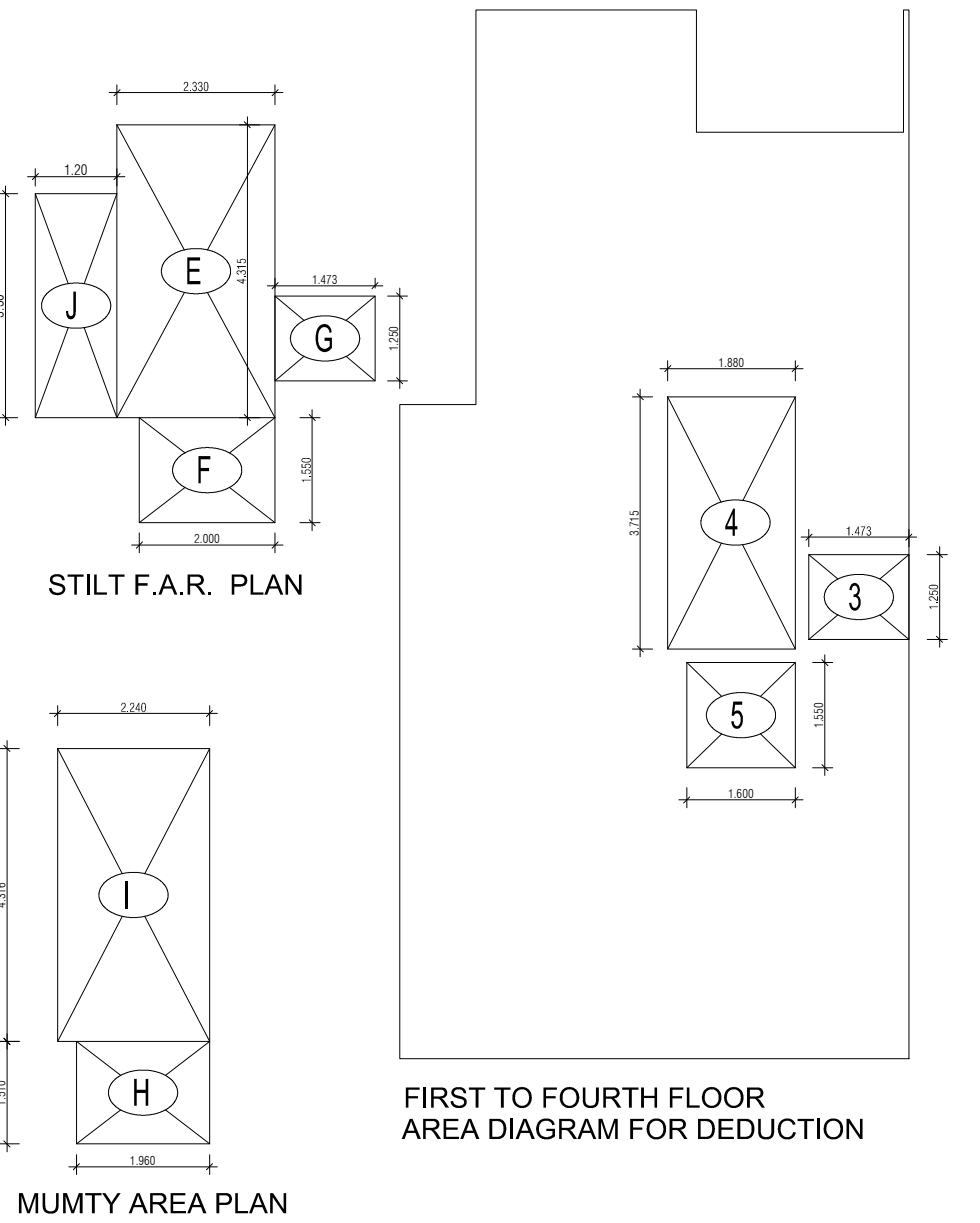

PROJECT -

PROPOSED INDEPENDENT RESIDENTIAL FLOORS ON PLOT NO A2 - 27 (STREET A2 - 10 M WIDE) IN AFFORDABLE RESIDENTIAL PLOTTED COLONY UNDER DEEN DAYAL JAN AWAS YOJNA-2016 OVER AN AREA MEASURING 26.91875 (LICESNE NO 94 OF 2021 DT 12.11.2021) IN VILLAGE HAYATPUR, SECTOR 93, GURUGRAM, BEING DEVELOPED BY SAGARDUTT BUILDERS & DEVELOPERS PVT LTD & OTHERS IN COLLABORATION WITH DLF LIMITED.

OWNERS -

DLF LIMITED

ARCHITECTS -

Arcop Associates Private Limited
Plot- 36b, Sec-32, Gurgaon-122001
Ph.: 26242050, 26242169

DRAWING TITLE -

TYPE A (7.5 M x 20 M) FLOORS PLANS WITH AREA CALCULATIONS , ELEVATION & SECTIONS

DRAWING NUMBER -

SCALE = 1:50

DATE -

DRAWN BY -

CHECKED BY -







DRAWING NUMBER -

ARCHITECT SIGN

AUTHORISED SIGN

Abhishek Tiwari
Chartered CP Architect
Registration No. CA001152702


VArora
VANDANA ARORA
AUTHORISED SIGN

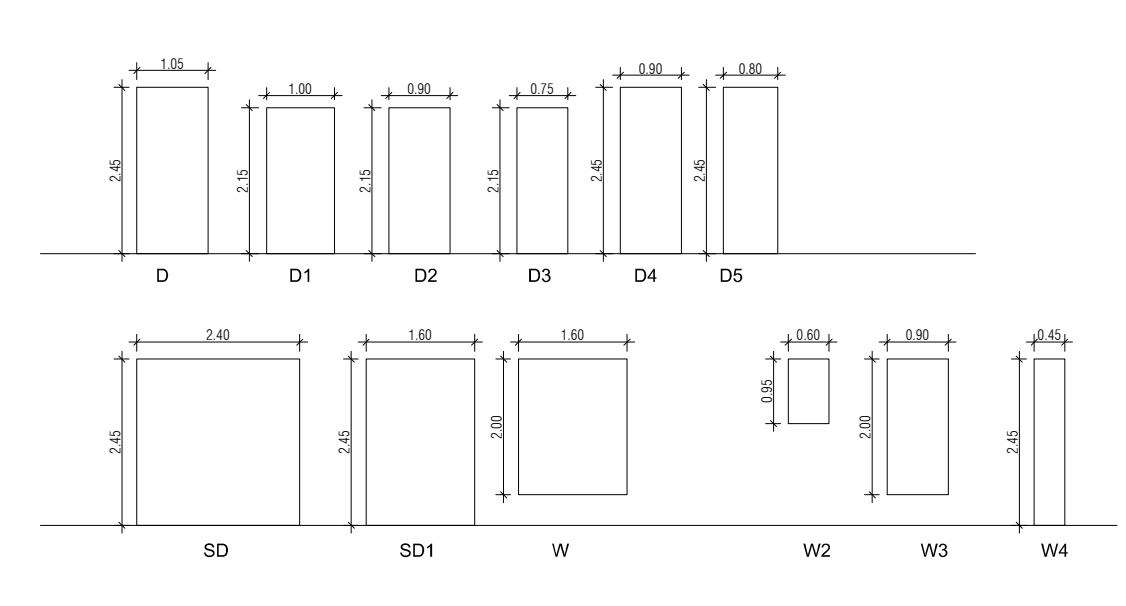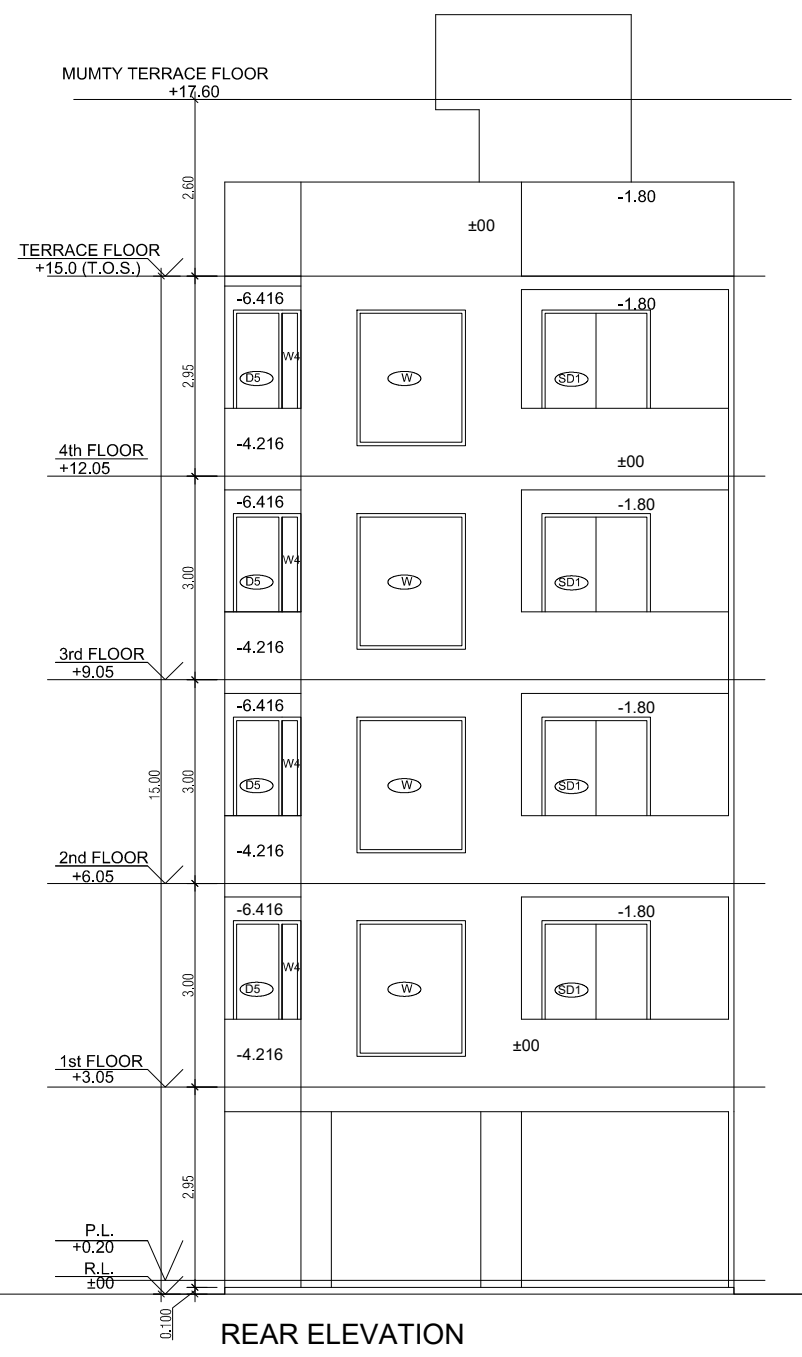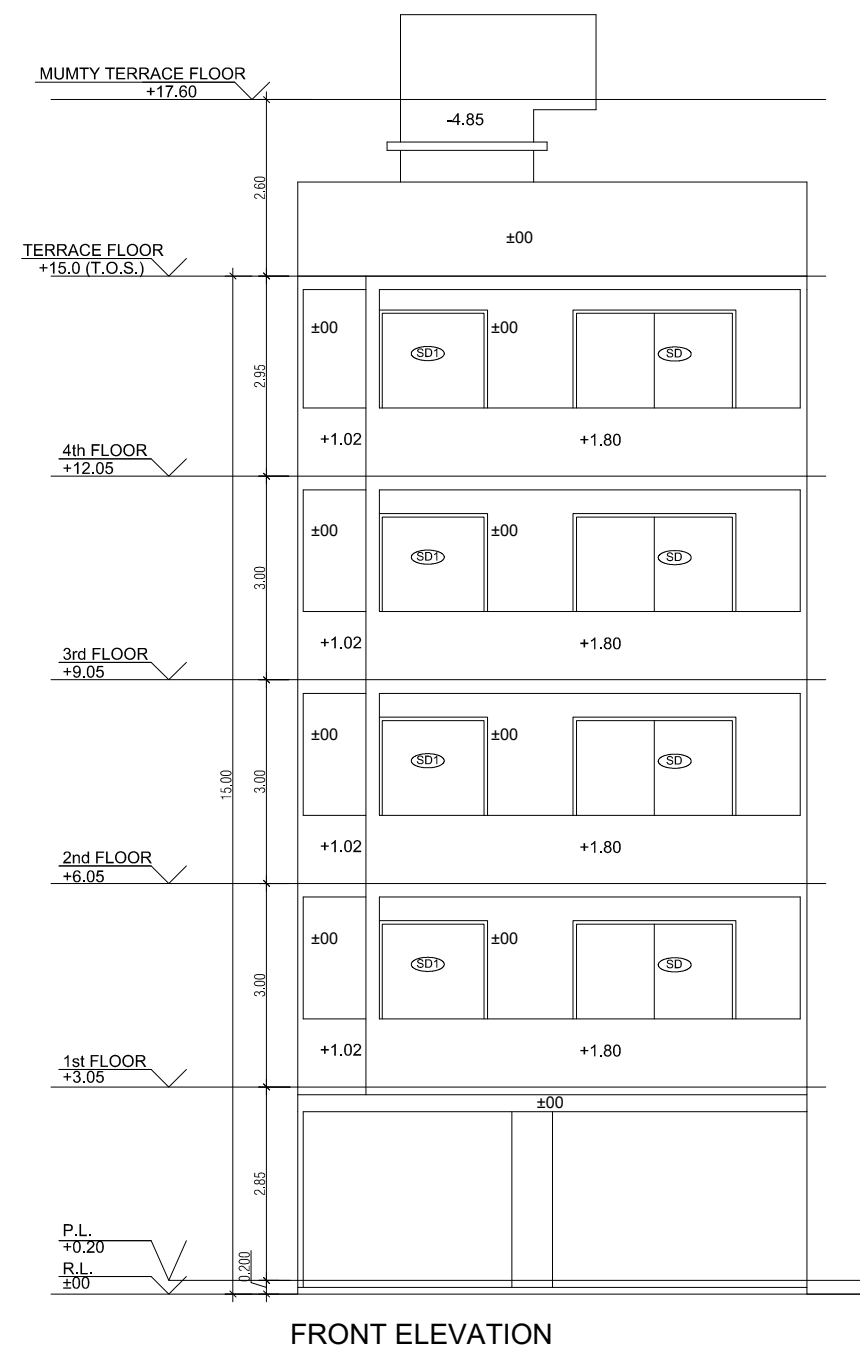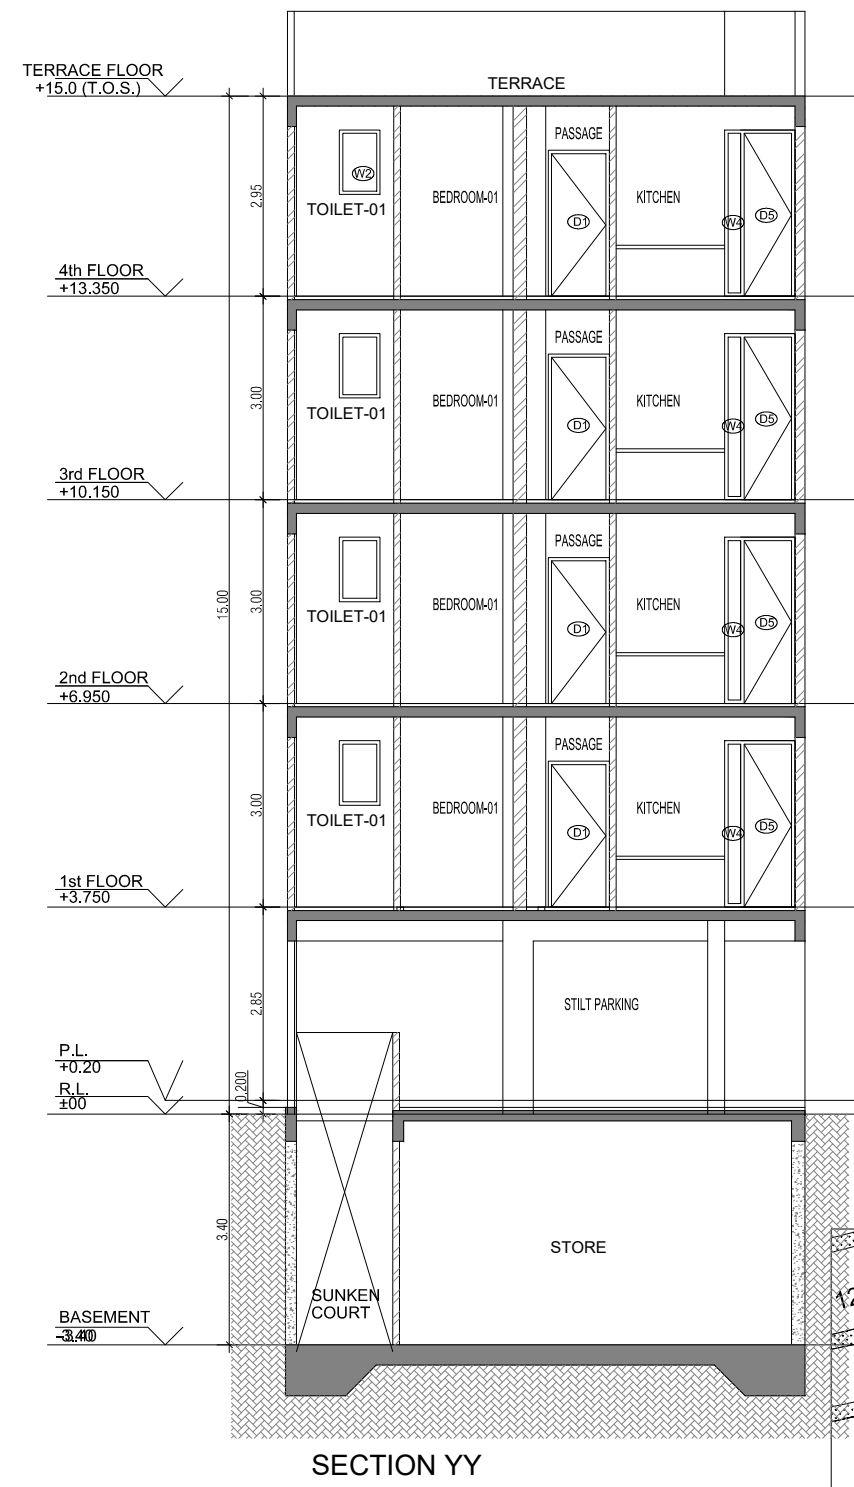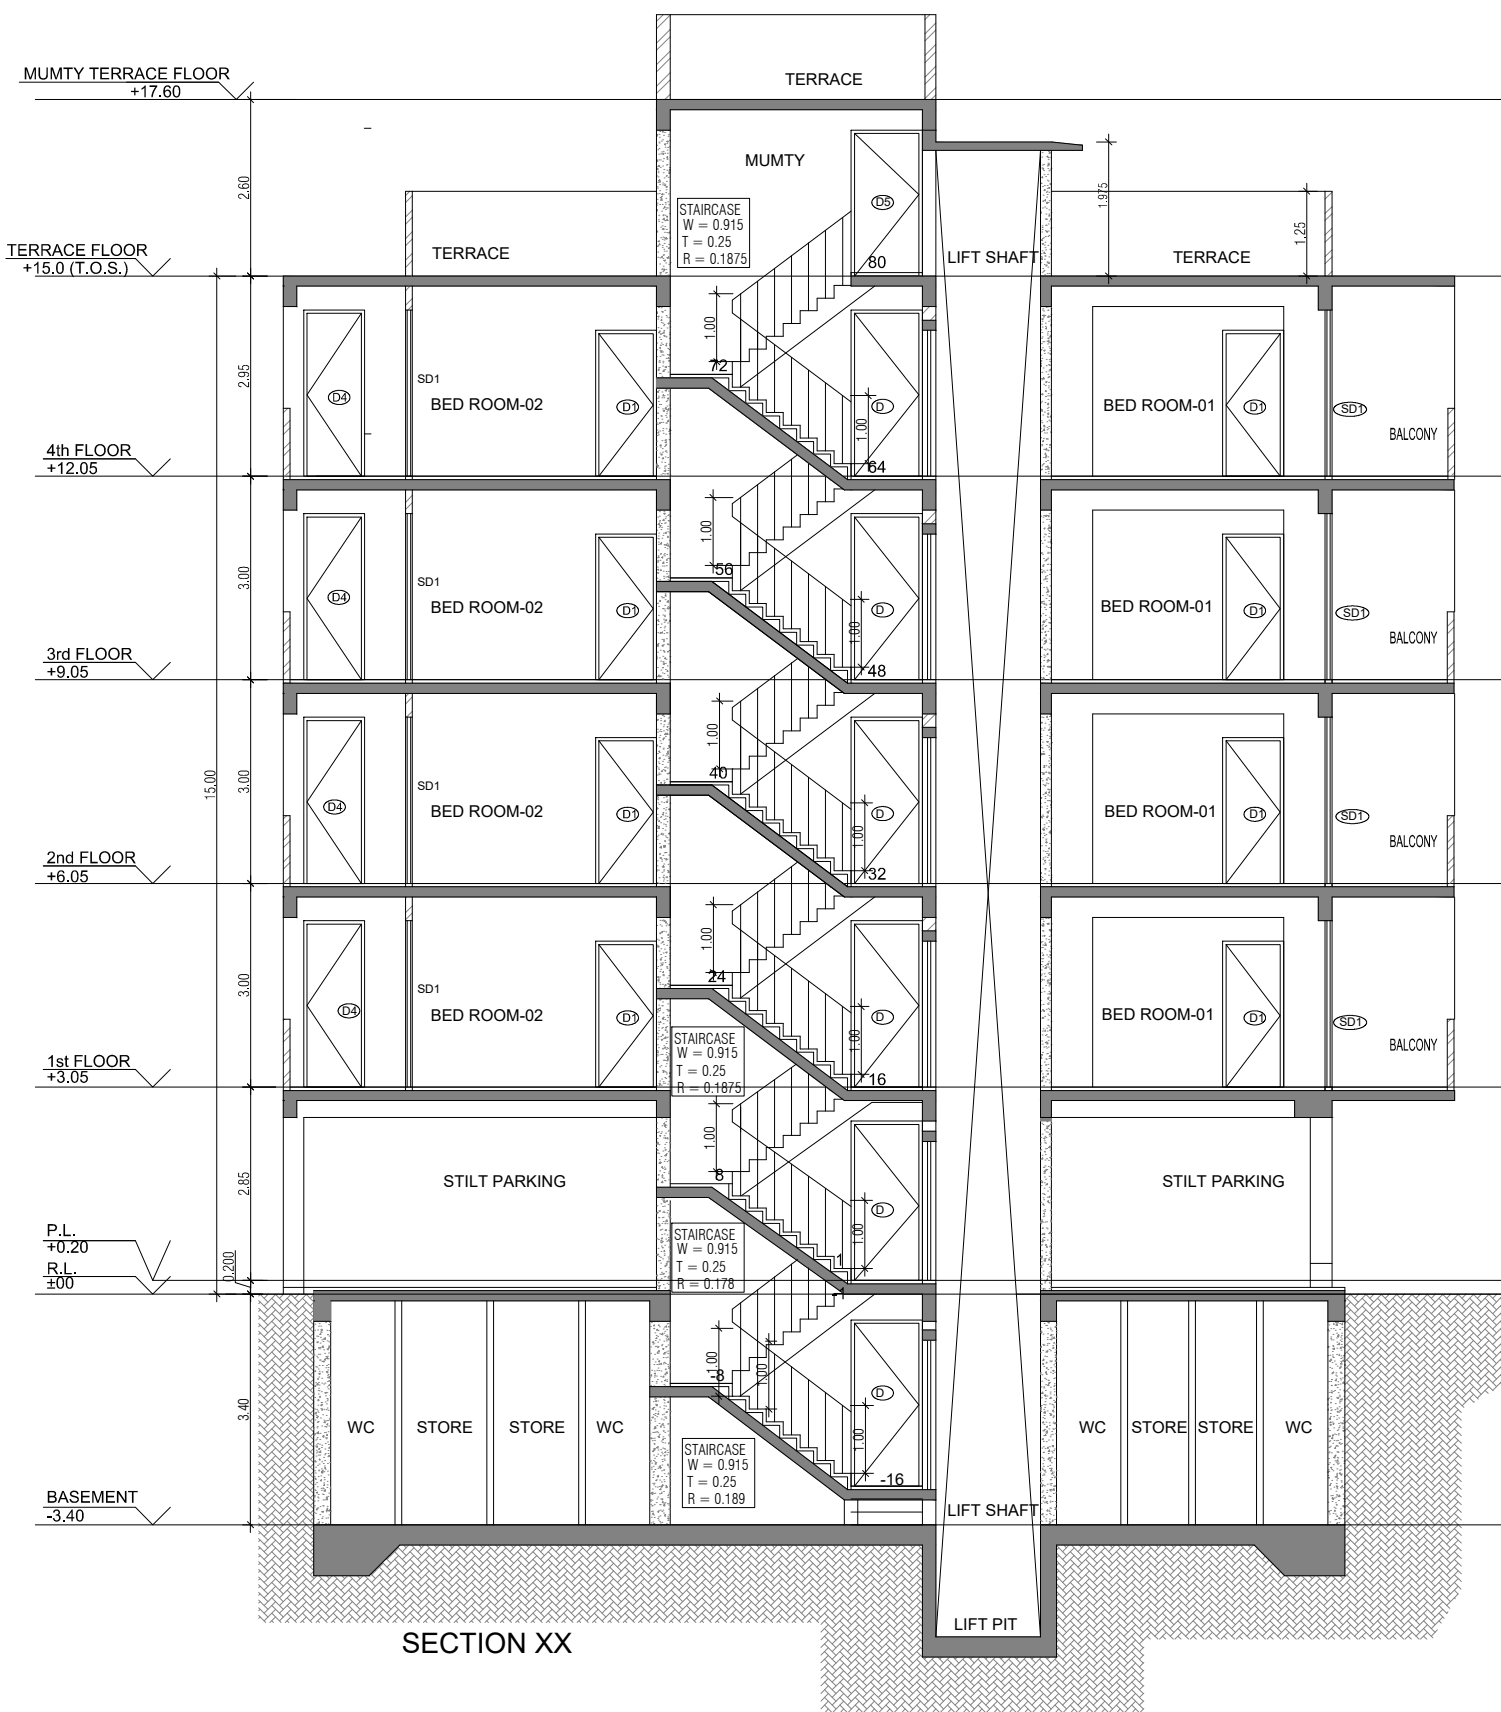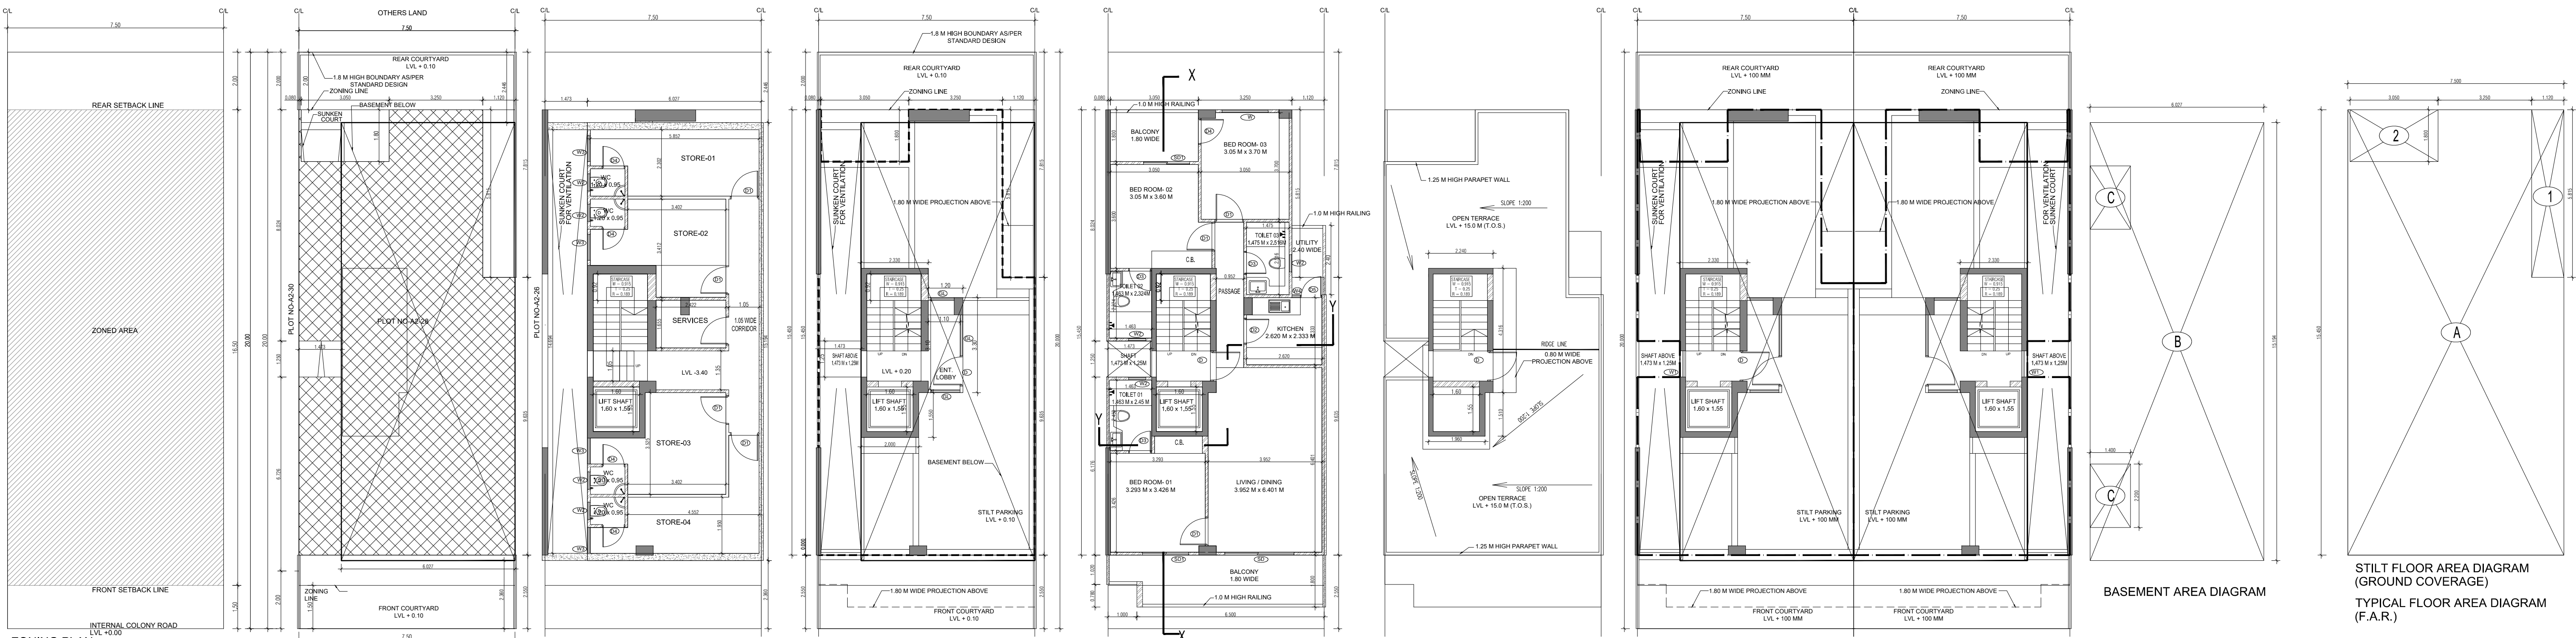

Plumbing legend for vertical pipes and door window schedule.

SP	NO	LEGEND	WIDTH (MM)	HEIGHT (MM)	CILL LVL. (FROM FFL)	LINTEL LVL. (FROM FFL)
1	D	110 OD uPVC SOIL & WASTE VENT PIPE	105	245	0	245
2	D1	110 OD uPVC WASTE & VENT PIPE FOR KITCHEN	105	245	0	245
3	D2	DOMESTIC WATER SUPPLY DN. TAKE PIPE	25	245	0	245
4	D3	FLUSHING WATER SUPPLY DN. TAKE PIPE	25	245	0	245
5	D4	75 OD uPVC RAIN WATER PIPE FOR BALCONY	75	245	0	245
6	D5	110 OD uPVC RAIN WATER PIPE FOR TERRACE	105	245	0	245
7	W	25W DOMESTIC WATER RISER PIPE TO OHT	25	245	0	245
8	W2	20W FLUSHING WATER RISER PIPE TO OHT	20	245	0	245

SP	NO	LEGEND	WIDTH (MM)	HEIGHT (MM)	CILL LVL. (FROM FFL)	LINTEL LVL. (FROM FFL)
1	D	110 OD uPVC SOIL & WASTE VENT PIPE	105	245	0	245
2	D1	110 OD uPVC WASTE & VENT PIPE FOR KITCHEN	105	245	0	245
3	D2	DOMESTIC WATER SUPPLY DN. TAKE PIPE	25	245	0	245
4	D3	FLUSHING WATER SUPPLY DN. TAKE PIPE	25	245	0	245
5	D4	75 OD uPVC RAIN WATER PIPE FOR BALCONY	75	245	0	245
6	D5	110 OD uPVC RAIN WATER PIPE FOR TERRACE	105	245	0	245
7	W	25W DOMESTIC WATER RISER PIPE TO OHT	25	245	0	245
8	W2	20W FLUSHING WATER RISER PIPE TO OHT	20	245	0	245

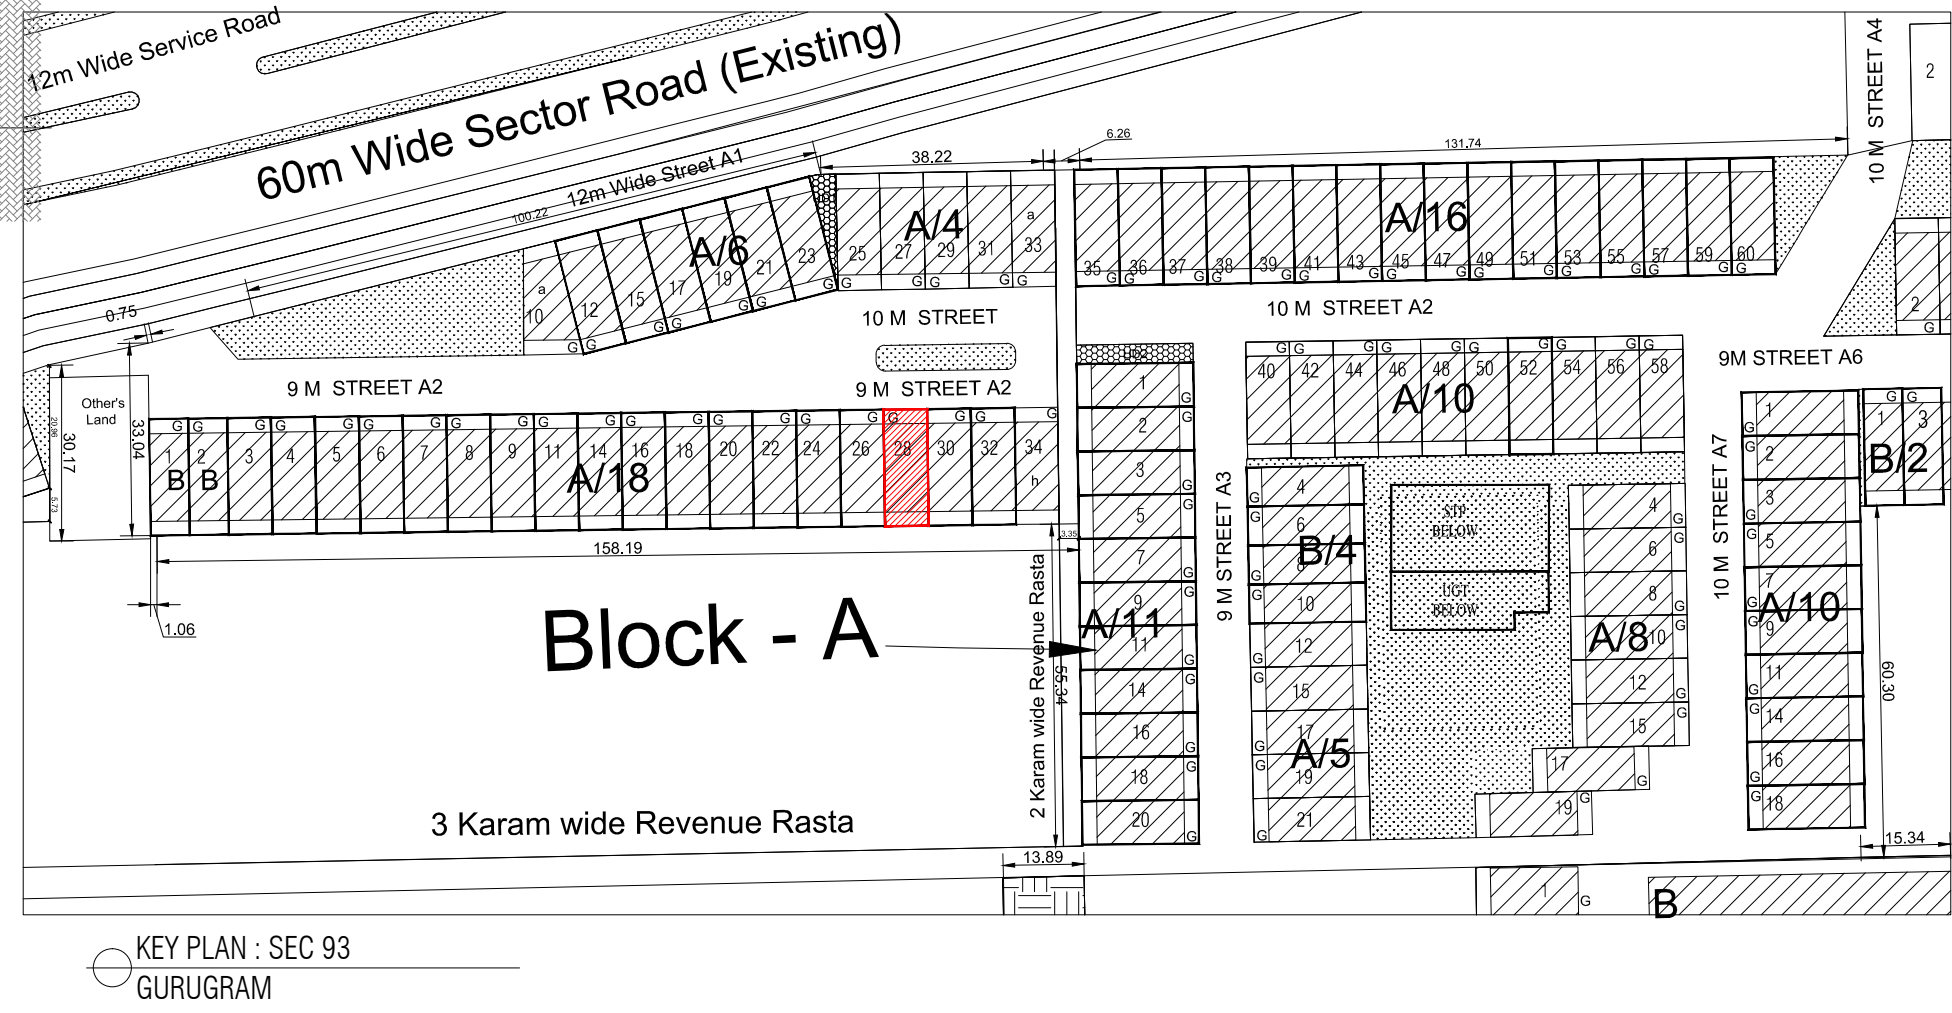

Area calculation table for Block - A, including Total Plot Area, Basement Area, Typical Floor Area, and Stilt Floor Area.

AREA CALCULATION		AREA	UNIT
TOTAL PLOT AREA (7.50 M x 20 M)		150	Sq.mt
PERMISSIBLE FAR AS PER APPROVED ZONING PLAN @ 2.00		300	Sq.mt
PURCHASEABLE FAR @ 0.64		96	Sq.mt
TOTAL PERMISSIBLE FAR @ 2.64		396	Sq.mt
PROPOSED FAR @ 2.63		395.395	Sq.mt
PERMISSIBLE GROUND COVERAGE @ 75%		112.50	Sq.mt
PROPOSED GROUND COVERAGE @ 69.24%		103.872	Sq.mt

AREA OF STILT FLOOR (GROUND COVERAGE)		AREA	UNIT
A	7.5 x 15.04 x 1	115.875	Sq.mt
TOTAL		115.875	Sq.mt

DEDUCTION (D)		AREA	UNIT
1	1.12 x 5.815 x 1	6.513	Sq.mt
2	3.05 x 1.800 x 1	5.490	Sq.mt
TOTAL		12.003	Sq.mt

PROPOSED GROUND COVERAGE = A-D		103.872	Sq.mt
--------------------------------	--	---------	-------

AREA CALCULATION FOR TYPICAL FLOOR (1st to 4th FLOOR)		AREA	UNIT
TOTAL AREA ON GROUND COVERAGE (X)		103.872	Sq.mt
DEDUCTION			
1 (STAIRCASE)	1.880 x 3.715 x 1	6.984	Sq.mt
2	1.600 x 1.550 x 1	2.480	Sq.mt
3	1.473 x 1.250 x 1	1.841	Sq.mt
TOTAL (Y)		11.305	Sq.mt
TOTAL AREA OF TYPICAL FLOOR (X-Y)		92.567	Sq.mt

BASEMENT BUILT UP AREA		AREA	UNIT
B	6.027 x 15.194 x 1	91.574	Sq.mt
TOTAL		91.574	Sq.mt

BASEMENT F.A.R. AREA		AREA	UNIT
C	1.400 x 2.200 x 2	6.160	Sq.mt
TOTAL		6.160	Sq.mt

NET NON F.A.R. AREA OF BASEMENT		AREA	UNIT
B-C		85.414	Sq.mt
TOTAL		85.414	Sq.mt

STILT FAR		AREA	UNIT
E	2.333 x 4.315 x 1	10.067	Sq.mt
F	2.000 x 1.550 x 1	3.100	Sq.mt
G	1.473 x 1.250 x 1	1.841	Sq.mt
J	1.2 x 3.300 x 1	3.960	Sq.mt
TOTAL		18.968	Sq.mt


MUMTY AREA		AREA	UNIT
H	1.960 x 1.51 x 1	2.960	Sq.mt
I	2.24 x 4.32 x 1	9.668	Sq.mt
TOTAL		12.627	Sq.mt

PROJECTION AREA		AREA	UNIT
	6.500 x 1.800 x 1	11.700	Sq.mt
	1.000 x 1.020 x 1	1.020	Sq.mt
	1.120 x 1.800 x 1	2.016	Sq.mt
	3.050 x 1.800 x 1	5.490	Sq.mt
TOTAL		20.226	Sq.mt

GROUND COVERAGE CALCULATION		AREA	UNIT
STILT FLOOR AREA, STAIRCASE, LIFT SHAFT INCLUDED		103.872	Sq.mt
TOTAL GROUND COVERAGE ACHIEVED		103.872	Sq.mt

FAR CALCULATION		AREA	UNIT
TYPICAL FLOOR AREA x 4		370.267	Sq.mt
FAR AREA UN BASEMENT		6.160	Sq.mt
FAR AREA ON STILT		18.968	Sq.mt
TOTAL FAR ACHIEVED		395.395	Sq.mt

BUILT UP AREA CALCULATION		AREA	UNIT
BASEMENT AREA (FAR-NON FAR) + COVERAGE		697.102	Sq.mt
AT STILT AREA + FLOOR AREA + STAIR CASE x 4 + MUMTY AREA + PROJECTION AREA x 4			

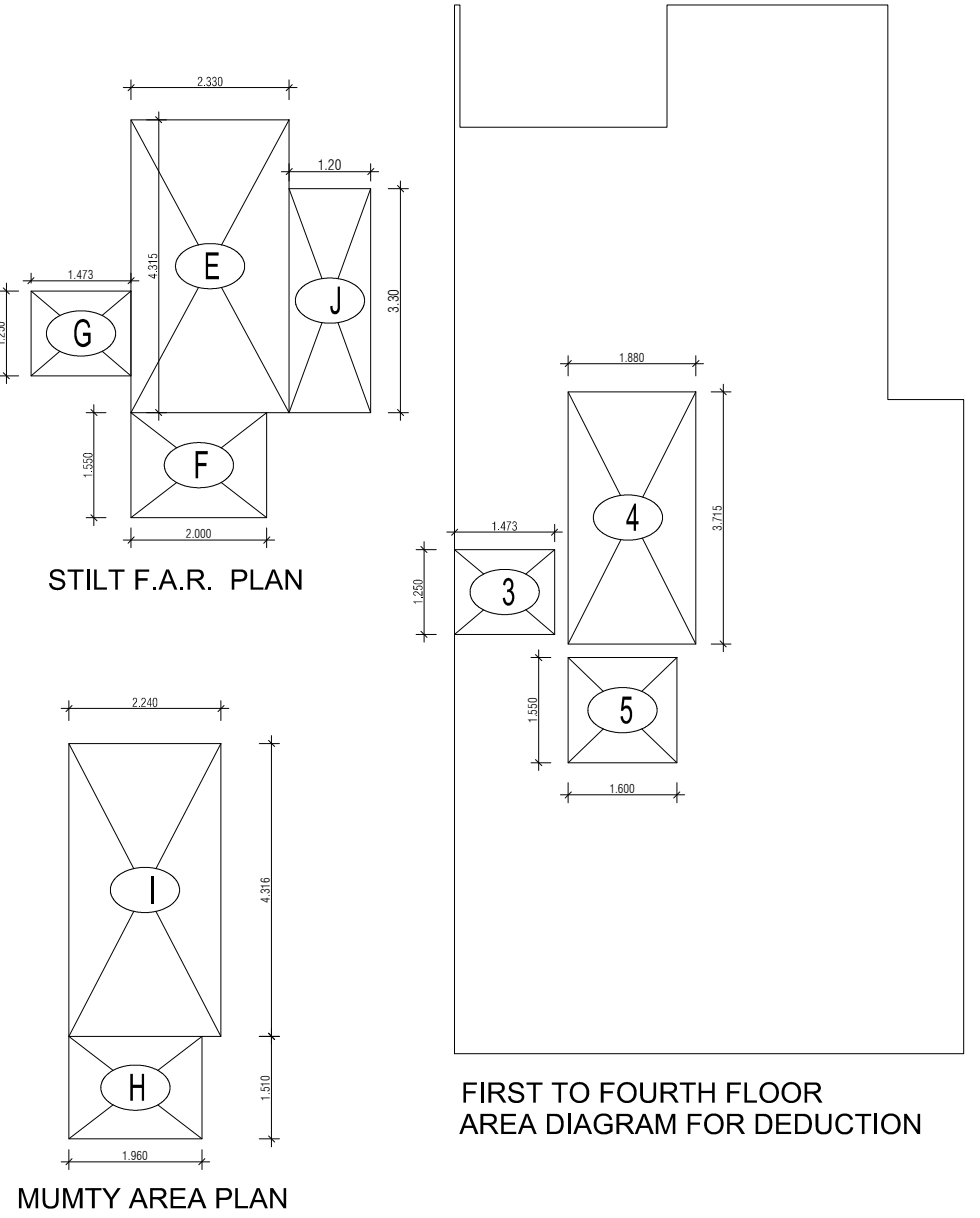

PROJECT - PROPOSED INDEPENDENT RESIDENTIAL FLOORS ON PLOT NO A2 - 28 (STREET A2 - 9 M WIDE) IN AFFORDABLE RESIDENTIAL PLOTTED COLONY UNDER DEEN DAYAL JAN AWAS YOJNA-2016 OVER AN AREA MEASURING 26.91875 (LICESNE NO 94 OF 2021 DT 12.11.2021) IN VILLAGE HAYATPUR, SECTOR 93, GURUGRAM, BEING DEVELOPED BY SAGARDUTT BUILDERS & DEVELOPERS PVT LTD & OTHERS IN COLLABORATION WITH DLF LIMITED.

OWNERS - DLF LIMITED

ARCHITECTS - Arcop Associates Private Limited Plot- 36b, Sec-32, Gurgaon-122001 Ph.: 26242050, 26242169

DRAWING TITLE - TYPE A (7.5 M x 20 M) FLOORS PLANS WITH AREA CALCULATIONS , ELEVATION & SECTIONS

DRAWING NUMBER - ARCHITECT SIGN - AUTHORISED SIGN -






SCALE = 1:50

DATE -


DRAWN BY -

CHECKED BY -



DRAWING NUMBER -

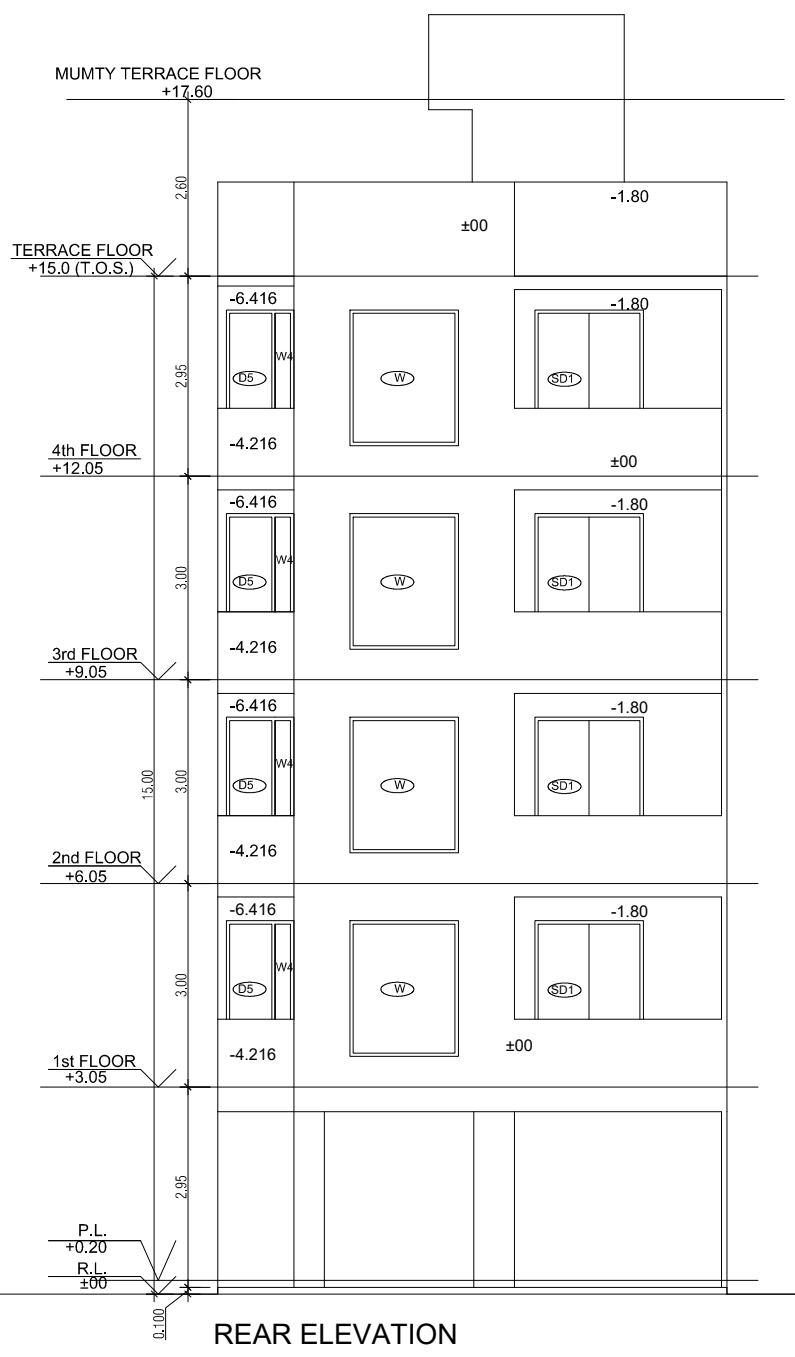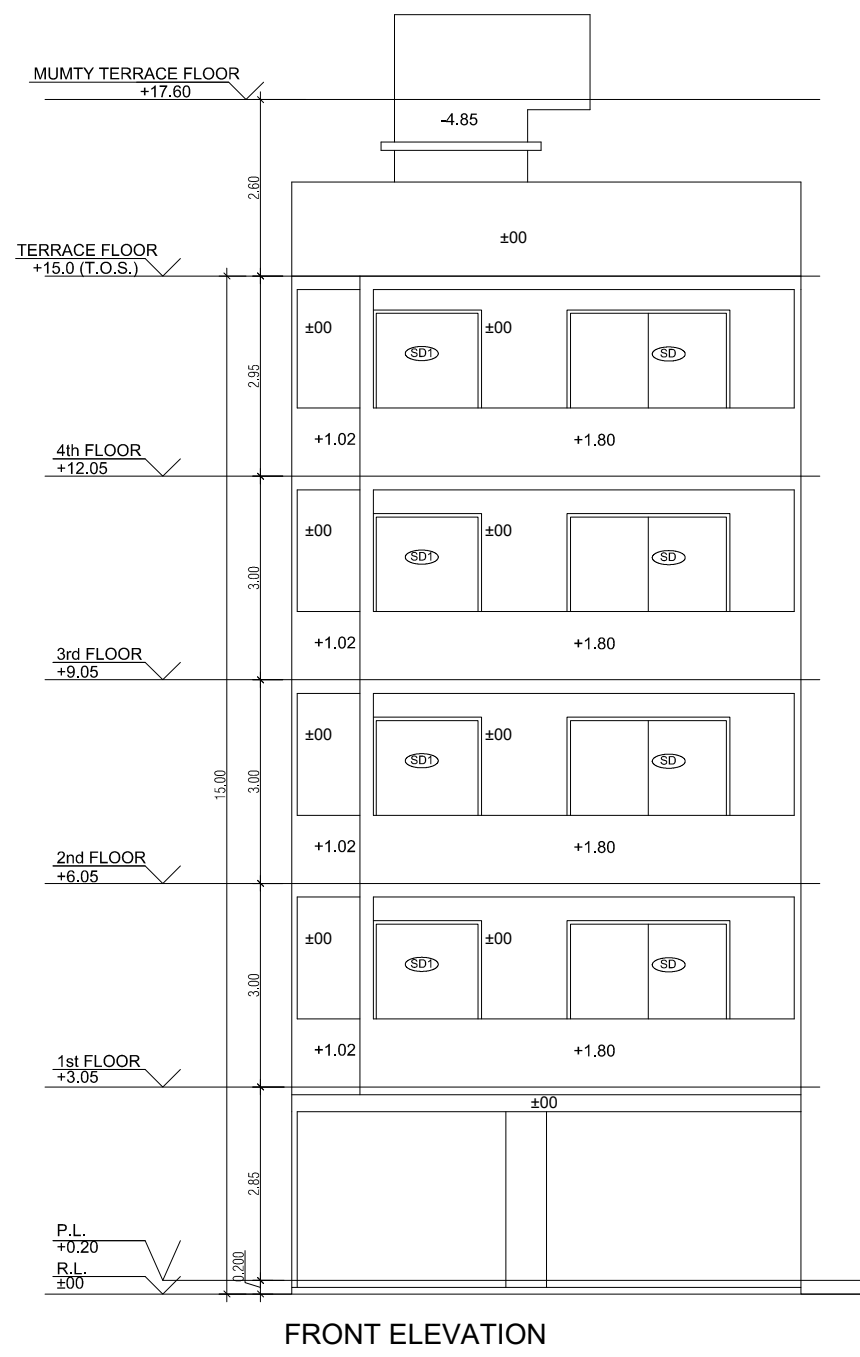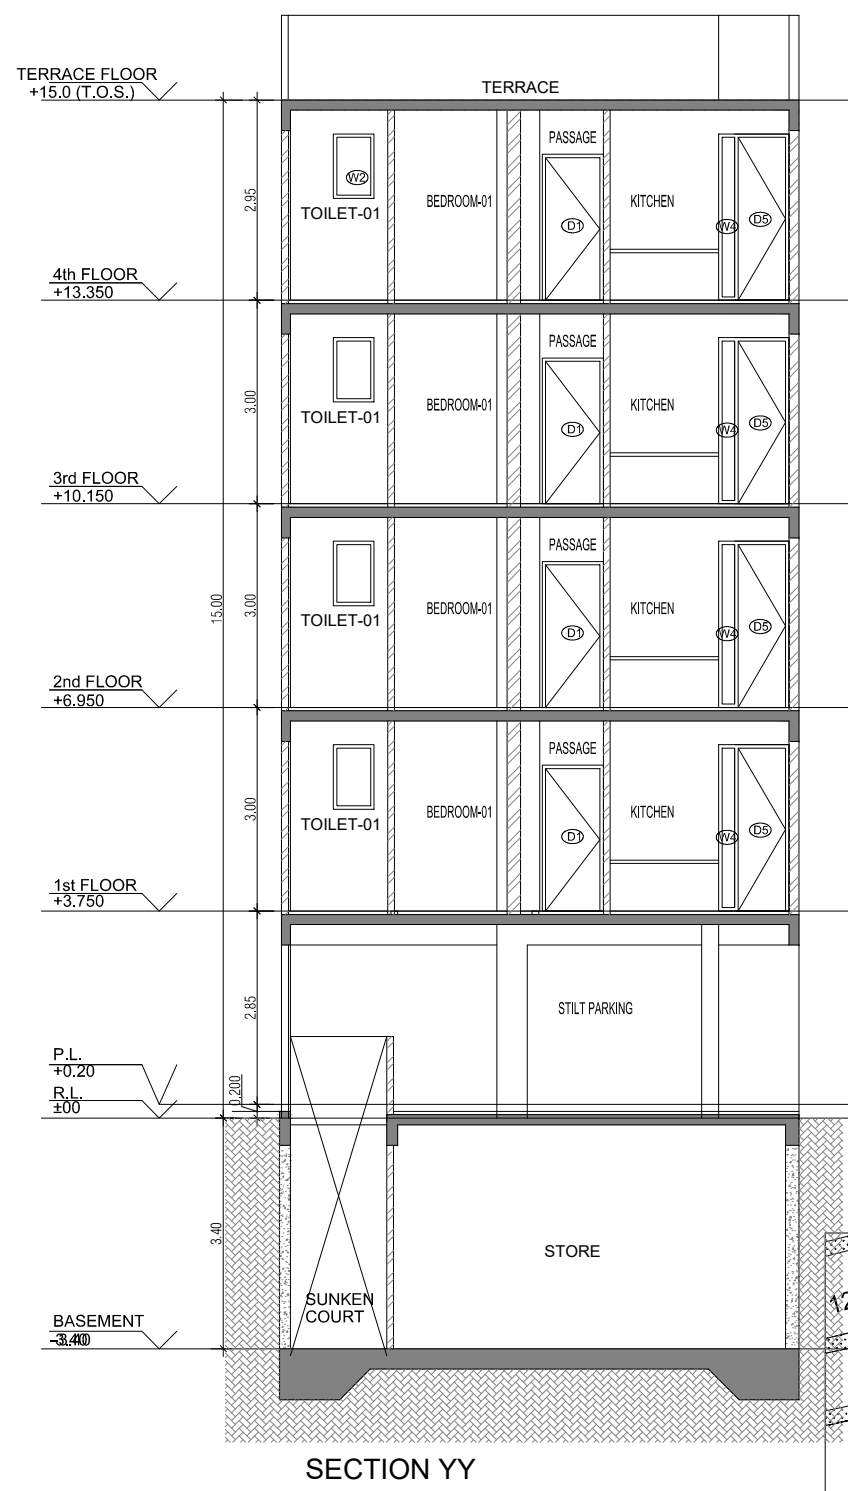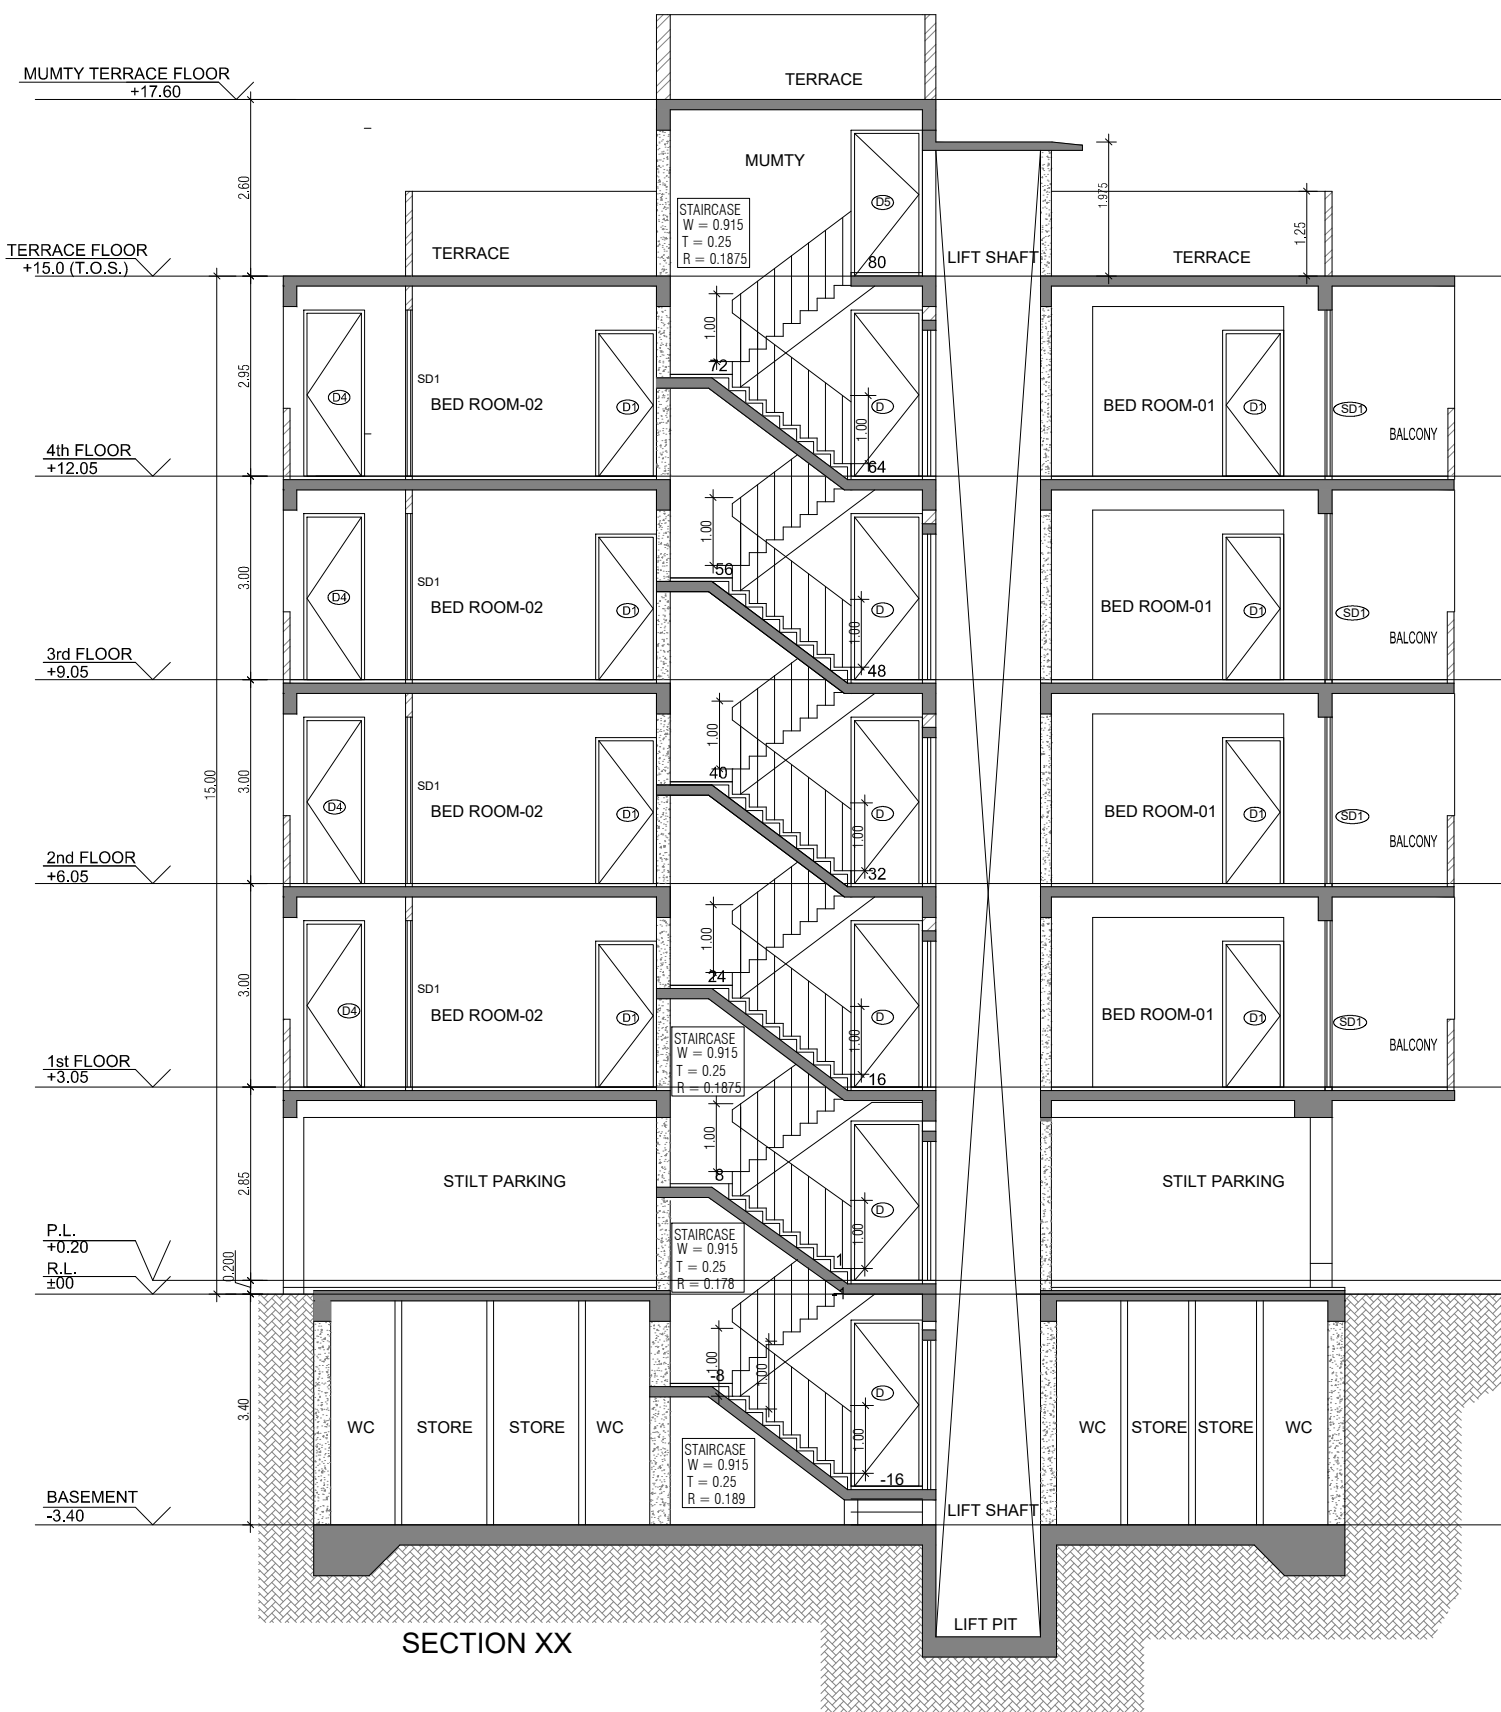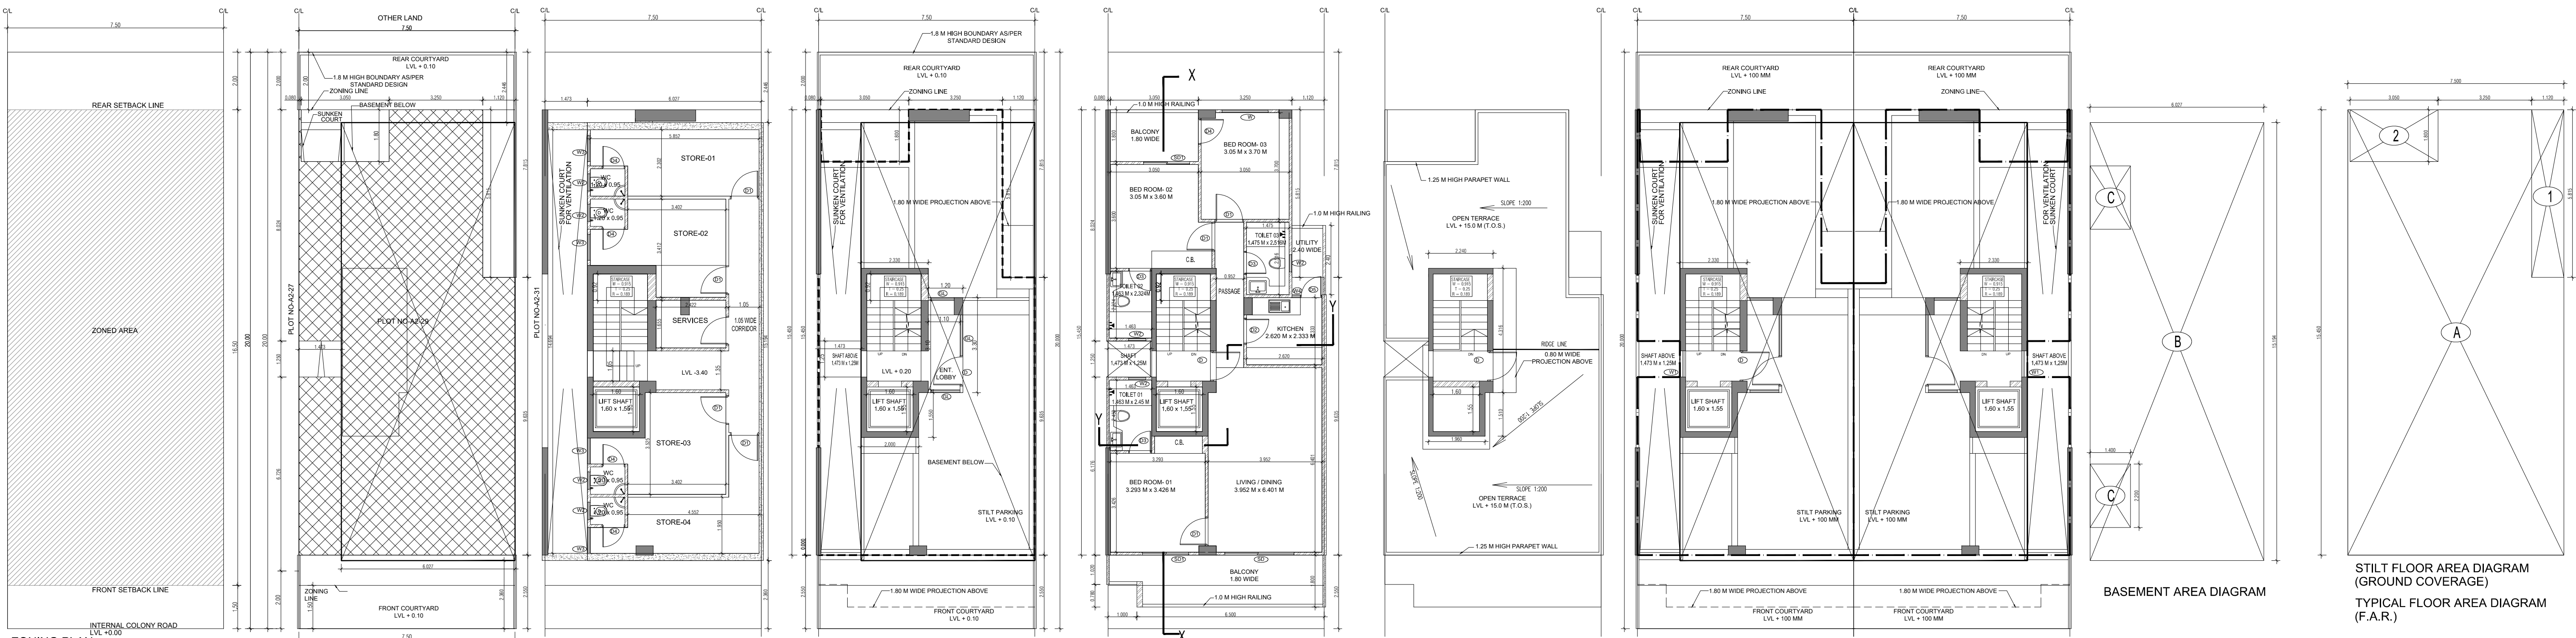

AREA CALCULATION			AREA	UNIT
TOTAL PLOT AREA (7.50 M x 20 M)			150	Sq.mt
PERMISSIBLE FAR AS PER APPROVED ZONING PLAN @ 2.00			300	Sq.mt
PURCHASEABLE FAR @ 0.64			96	Sq.mt
TOTAL PERMISSIBLE FAR @ 2.64			396	Sq.mt
PROPOSED FAR @ 2.63			395.395	Sq.mt
PERMISSIBLE GROUND COVERAGE @ 75%			112.50	Sq.mt
PROPOSED GROUND COVERAGE @ 69.24 %			103.872	Sq.mt
AREA OF STILT FLOOR (GROUND COVERAGE)				
A 7.5 x 15.45 x 1			115.875	Sq.mt
TOTAL			115.875	Sq.mt
DEDUCTION (D)				
1	1.12 x 5.815 x 1		6.513	Sq.mt
2	3.05 x 1.800 x 1		5.490	Sq.mt
TOTAL			12.003	Sq.mt
PROPOSED GROUND COVERAGE = A-D			103.872	Sq.mt
AREA CALCULATION FOR TYPICAL FLOOR (1st to 4th FLOOR)				
TOTAL AREA ON GROUND COVERAGE (X)			103.872	Sq.mt
DEDUCTION				
1 (STAIRCASE)	1.880 x 3.715 x 1		6.984	Sq.mt
2	1.600 x 1.550 x 1		2.480	Sq.mt
3	1.473 x 1.250 x 1		1.841	Sq.mt
TOTAL (Y)			11.305	Sq.mt
TOTAL AREA OF TYPICAL FLOOR (X-Y)			92.567	Sq.mt
BASEMENT BUILT UP AREA				
B 6.027 x 15.194 x 1			91.574	Sq.mt
TOTAL			91.574	Sq.mt
BASEMENT F.A.R. AREA				
C 1.400 x 2.200 x 2			6.160	Sq.mt
TOTAL			6.160	Sq.mt
NET NON F.A.R AREA OF BASEMENT				
B-C			85.414	Sq.mt
TOTAL			85.414	Sq.mt
STILT FAR				
E	2.333 x 4.315 x 1		10.067	Sq.mt
F	2.000 x 1.550 x 1		3.100	Sq.mt
G	1.473 x 1.250 x 1		1.841	Sq.mt
J	1.2 x 3.300 x 1		3.960	Sq.mt
TOTAL			18.968	Sq.mt
MUMTY AREA				
H	1.960 x 1.51 x 1		2.960	Sq.mt
I	2.24 x 4.32 x 1		9.668	Sq.mt
TOTAL			12.627	Sq.mt
PROJECTION AREA				
6.500 x 1.800 x 1			11.700	Sq.mt
1.000 x 1.020 x 1			1.020	Sq.mt
1.120 x 1.800 x 1			2.016	Sq.mt
3.050 x 1.800 x 1			5.490	Sq.mt
TOTAL			20.226	Sq.mt
GROUND COVERAGE CALCULATION				
STILT FLOOR AREA, STAIRCASE, LIFT SHAFT INCLUDED			103.872	Sq.mt
TOTAL GROUND COVERAGE ACHIEVED			103.872	Sq.mt
FAR CALCULATION				
TYPICAL FLOOR AREA x 4			370.267	Sq.mt
FAR AREA UN BASEMENT			6.160	Sq.mt
FAR AREA ON STILT			18.968	Sq.mt
TOTAL FAR ACHIEVED			395.395	Sq.mt
BUILT UP AREA CALCULATION				
BASEMENT AREA (FAR-NON FAR) + COVERAGE			697.102	Sq.mt
AT STILT AREA + FLOOR AREA + STAIR CASE x 4 +				
MUMTY AREA + PROJECTION AREA x 4				

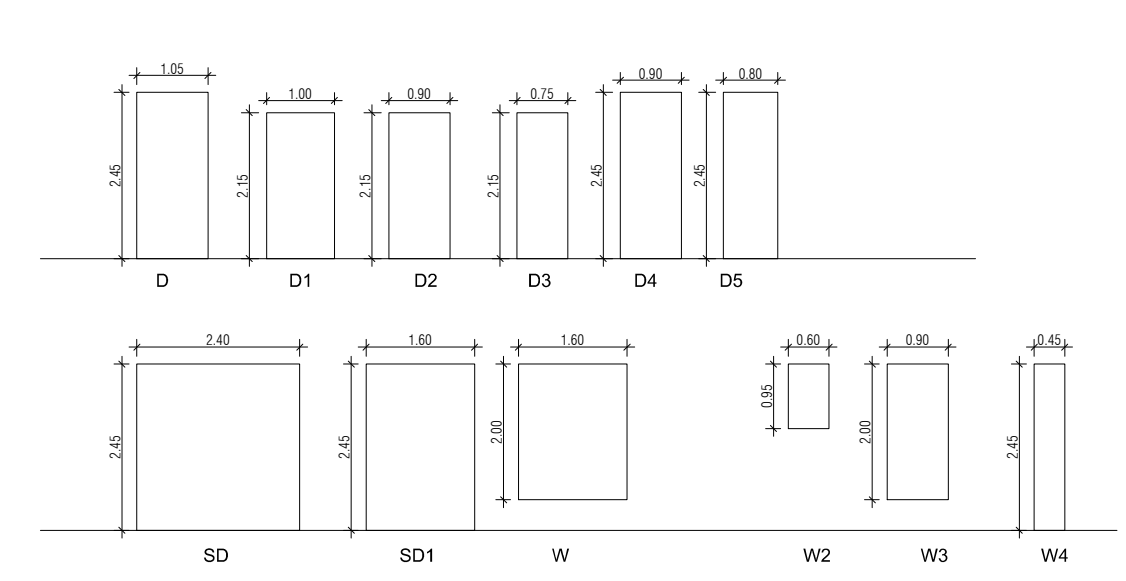

DOOR WINDOW SCHEDULE					
SR	NO	LEGEND	WIDTH (MM)	HEIGHT (MM)	CLL LVL (FROM FFL)
1	D1	110 OD uPVC SOIL & WASTE VENT PIPE	105	245	0
2	D1	110 OD uPVC WASTE & VENT PIPE FOR KITCHEN	105	245	0
3	D2	DOMESTIC WATER SUPPLY DN. TAKE PIPE	0.9	2.15	0
4	D3	FLUSHING WATER SUPPLY DN. TAKE PIPE	0.75	2.45	0
5	D4	75 OD uPVC RAIN WATER PIPE FOR BALCONY	6.90	2.15	0
6	D5	110 OD uPVC RAIN WATER PIPE FOR TERRACE	6.90	2.15	0
7	S1	25W DOMESTIC WATER RISER PIPE TO OHT	2.4	2.45	0
8	S2	20W FLUSHING WATER RISER PIPE TO OHT	1.6	2.45	0
9	W1	1.6 x 2	0.93	1.2	2.13
10	W2	0.6 x 0.95	0.95	1.5	2.45
11	W3	0.9 x 2	0.45	2.45	0
12	W4	0.45 x 2.45	0	2.45	0

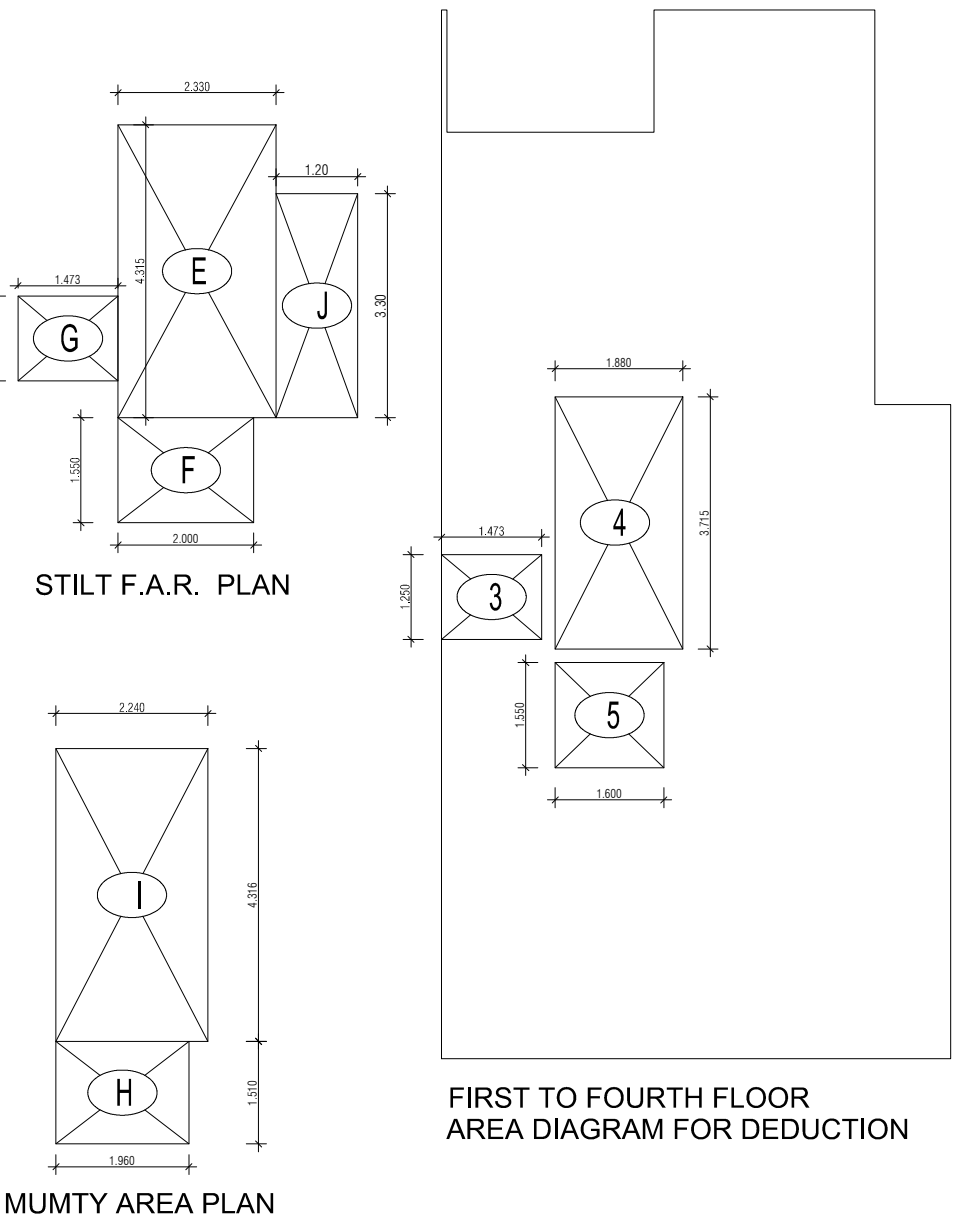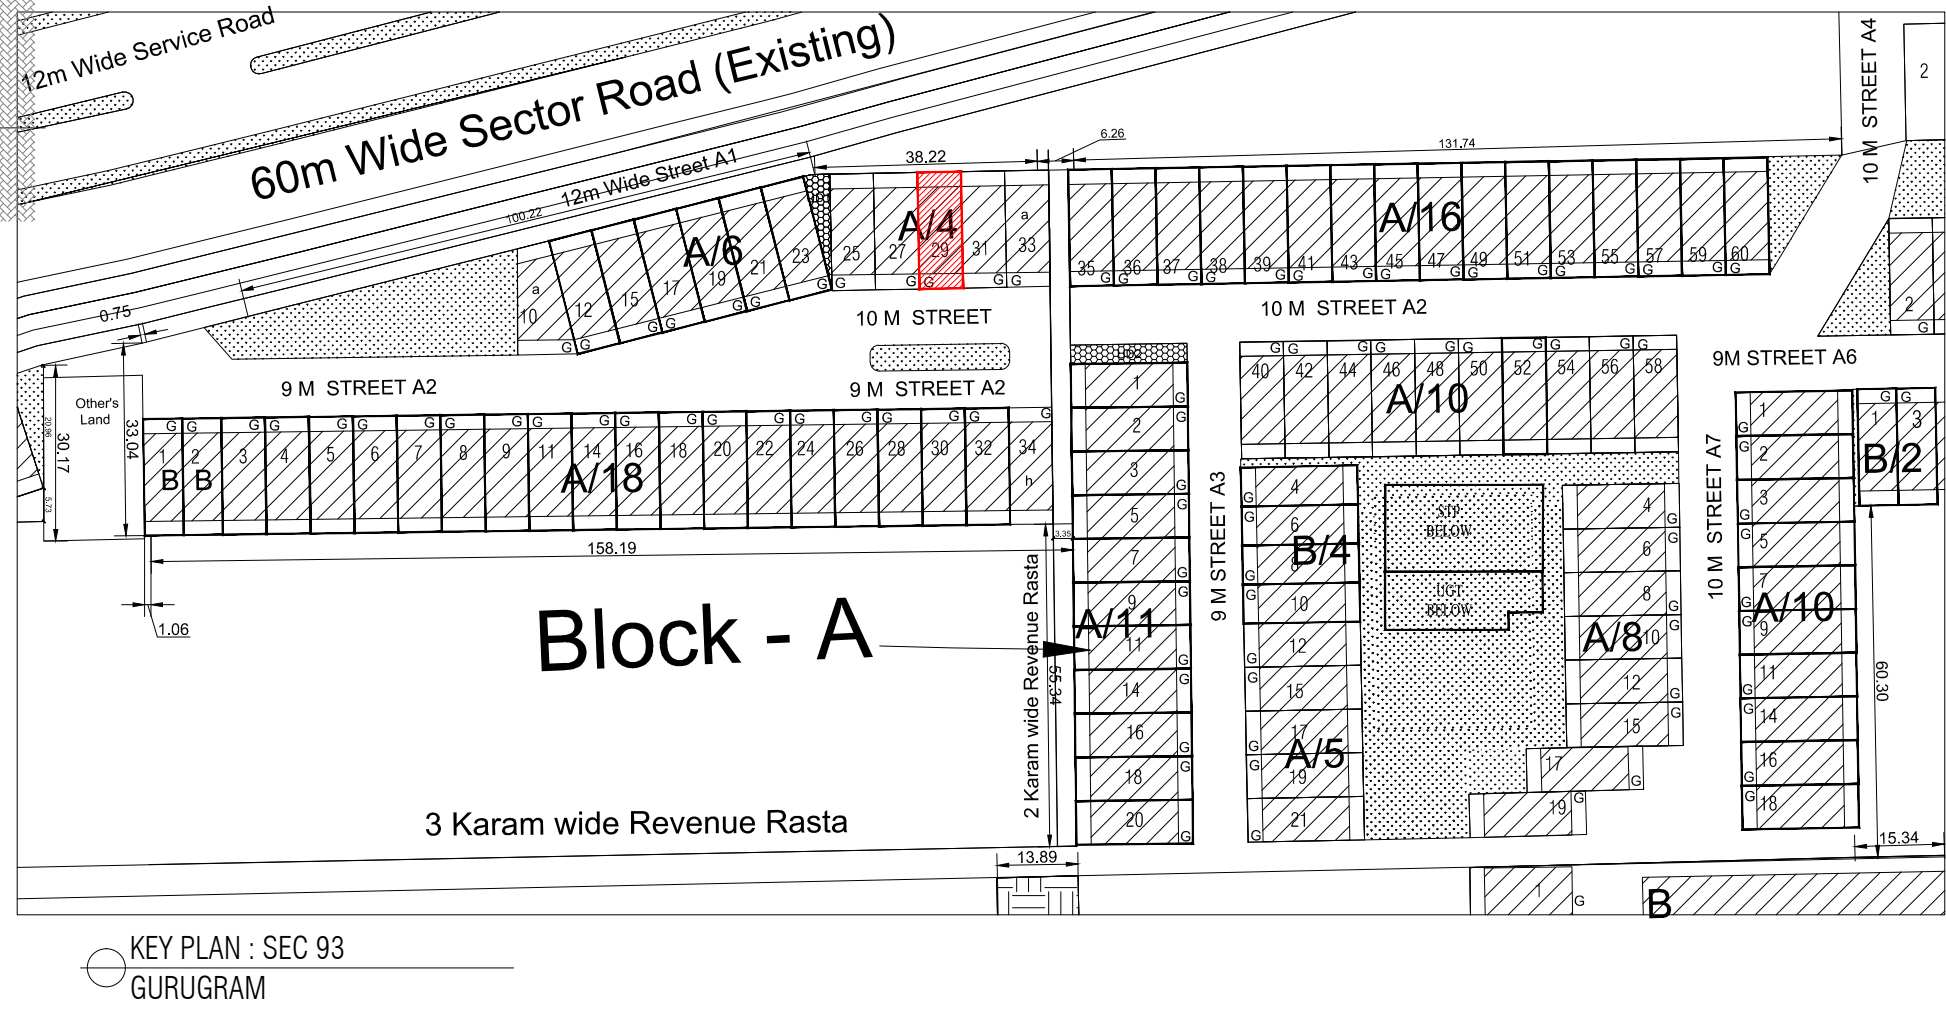

PROJECT -

PROPOSED INDEPENDENT RESIDENTIAL FLOORS ON PLOT NO A2 - 29 (STREET A2 - 10 M WIDE) IN AFFORDABLE RESIDENTIAL PLOTTED COLONY UNDER DEEN DAYAL JAN AWAS YOJNA-2016 OVER AN AREA MEASURING 26.91875 (LICESNE NO 94 OF 2021 DT 12.11.2021) IN VILLAGE HAYATPUR, SECTOR 93, GURUGRAM, BEING DEVELOPED BY SAGARDUTT BUILDERS & DEVELOPERS PVT LTD & OTHERS IN COLLABORATION WITH DLF LIMITED.

OWNERS -

DLF LIMITED

ARCHITECTS -

Arco Associates Private Limited
Plot- 36b, Sec-32, Gurgaon-122001
Ph.: 26242050, 26242169

DRAWING TITLE -

TYPE A (7.5 M x 20 M) FLOORS PLANS WITH AREA CALCULATIONS , ELEVATION & SECTIONS

DRAWING NUMBER -

SCALE = 1:50

DATE :

DRAWN BY -

CHECKED BY -

DRAWING NUMBER -

ARCHITECT SIGN

AUTHORISED SIGN

Vandana Arora

VANDANA ARORA