

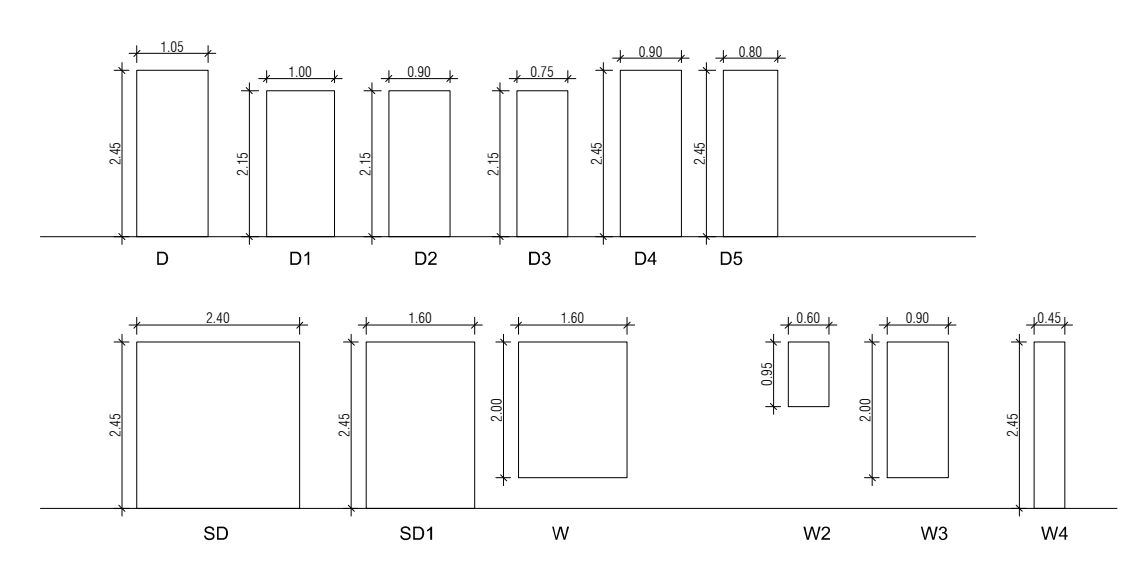
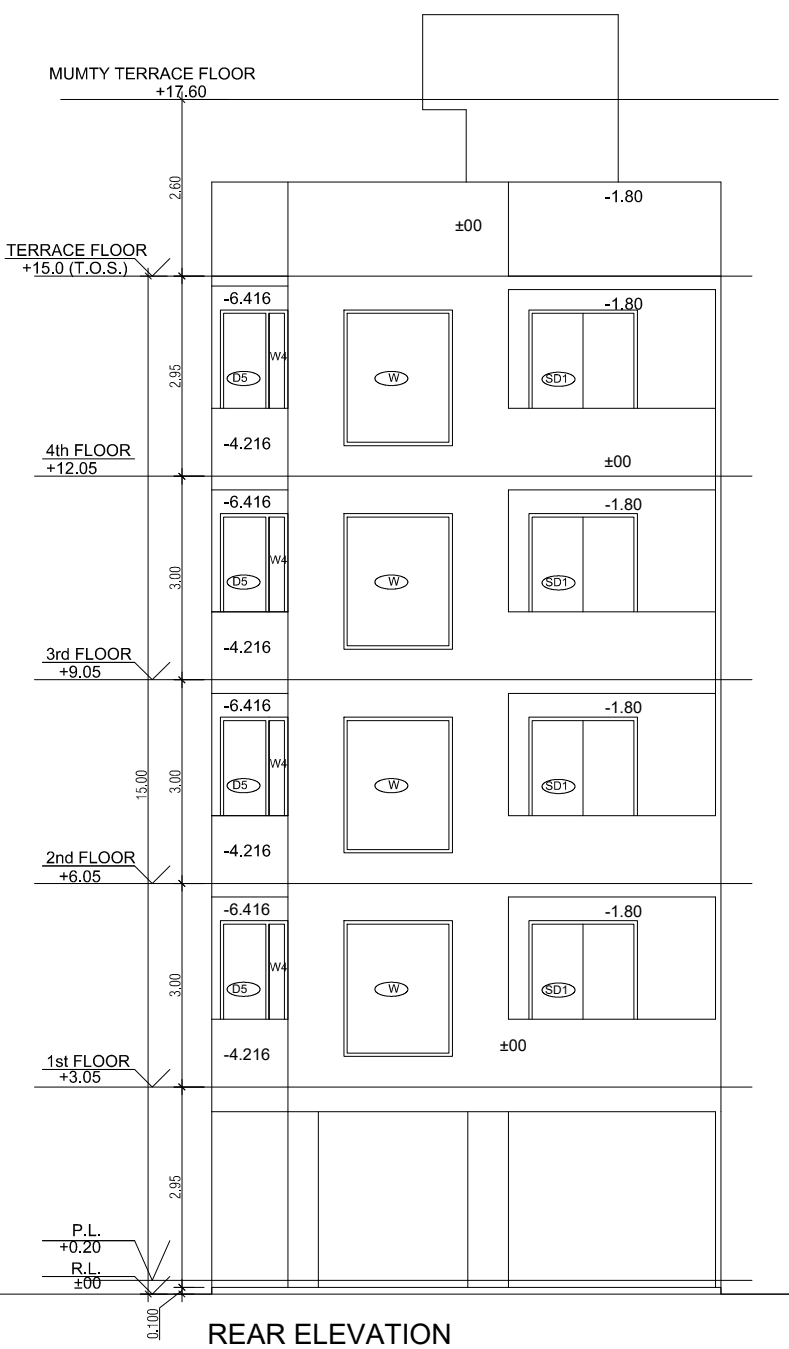
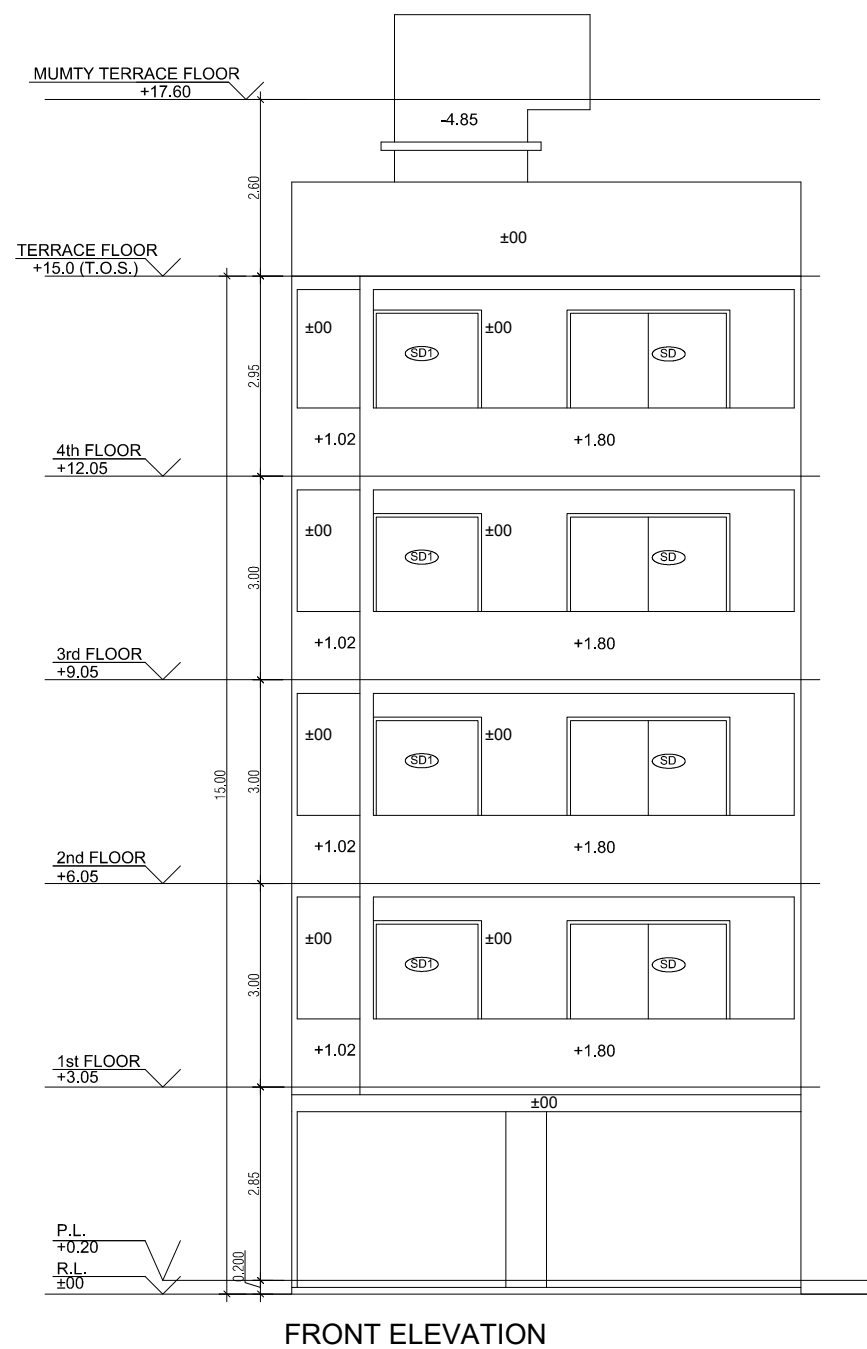
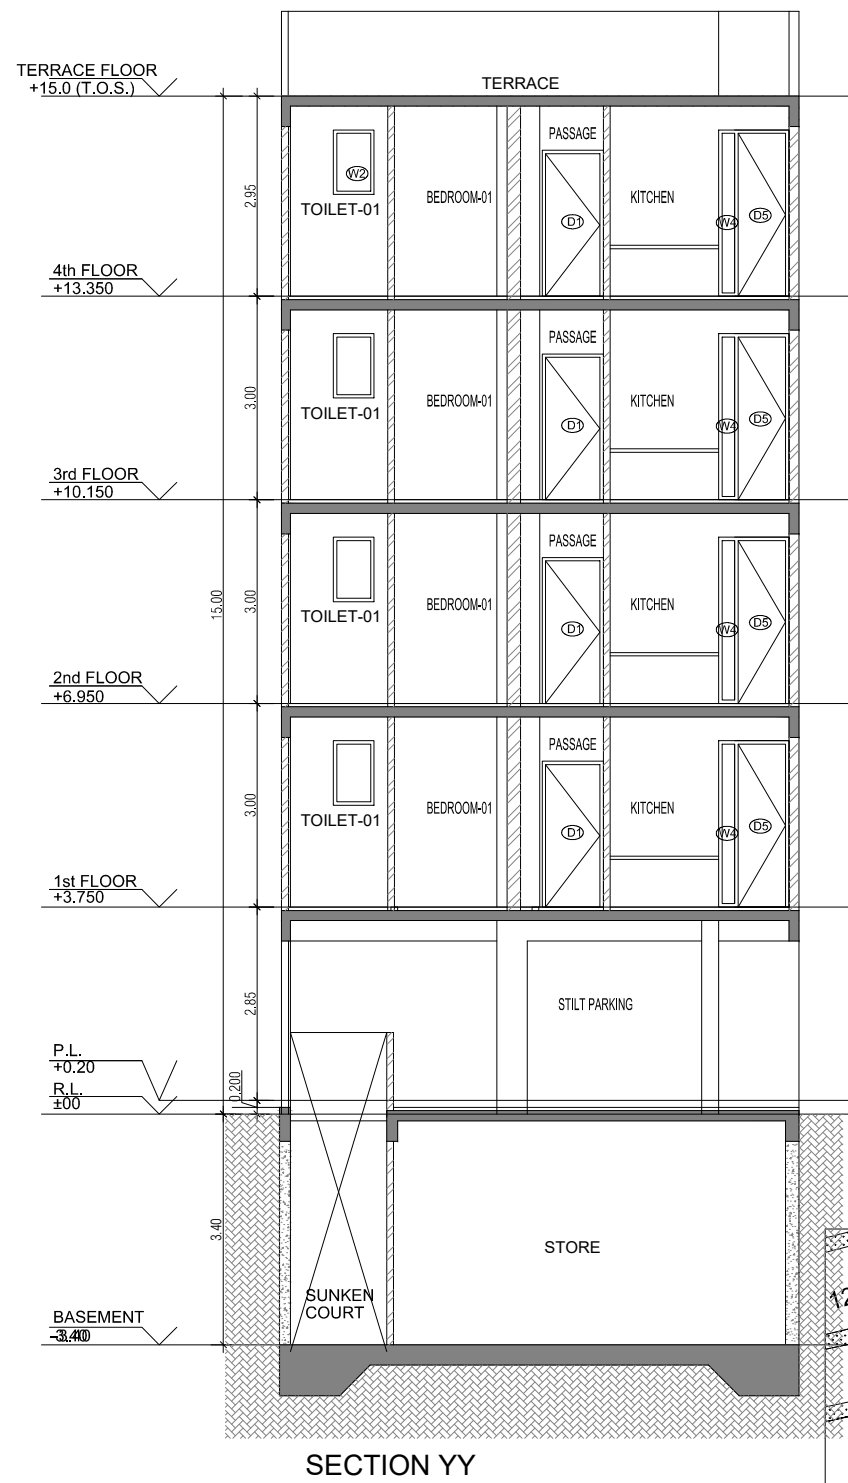
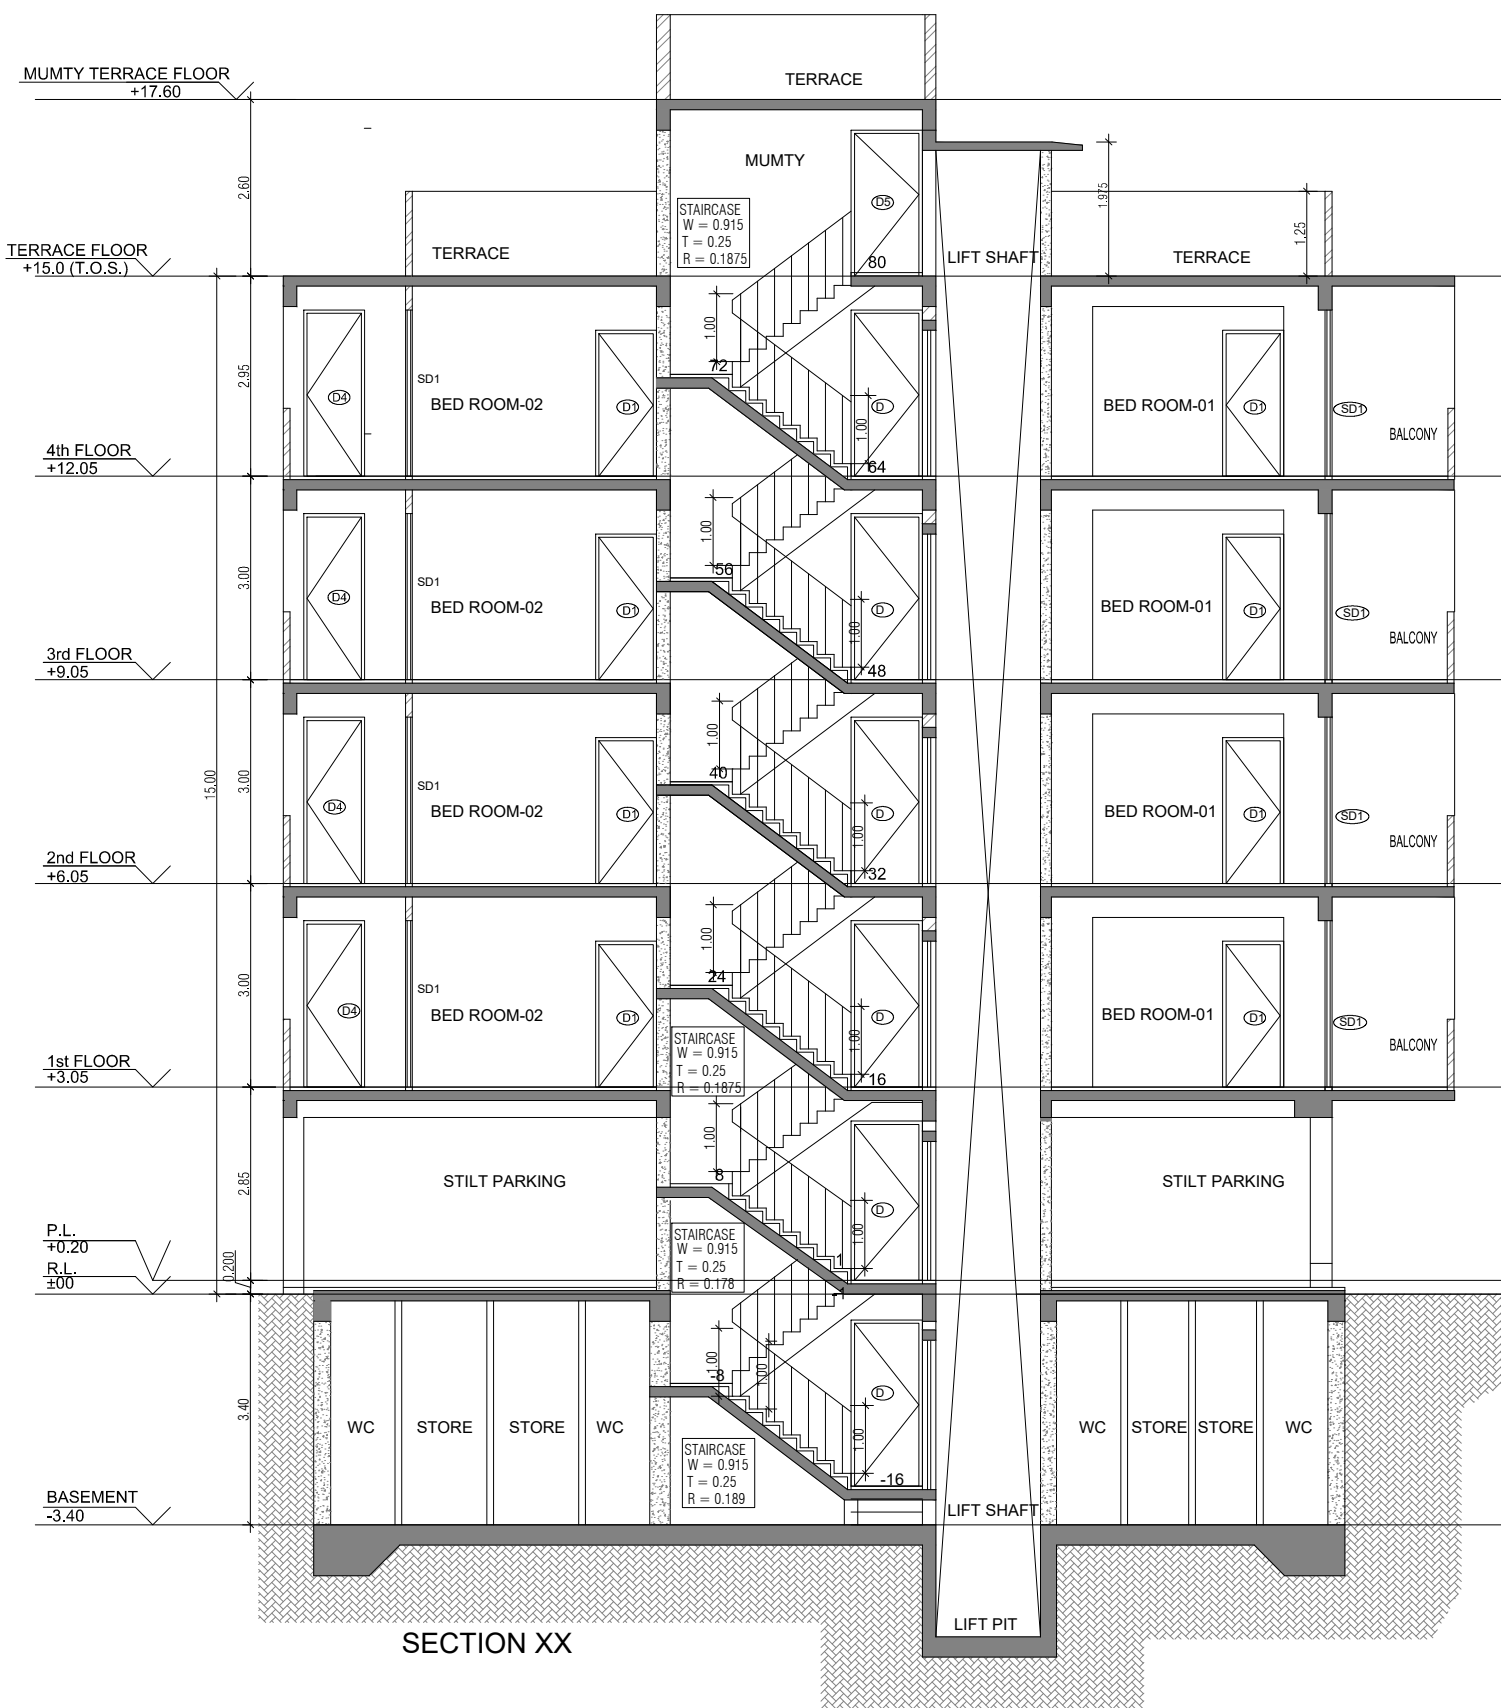


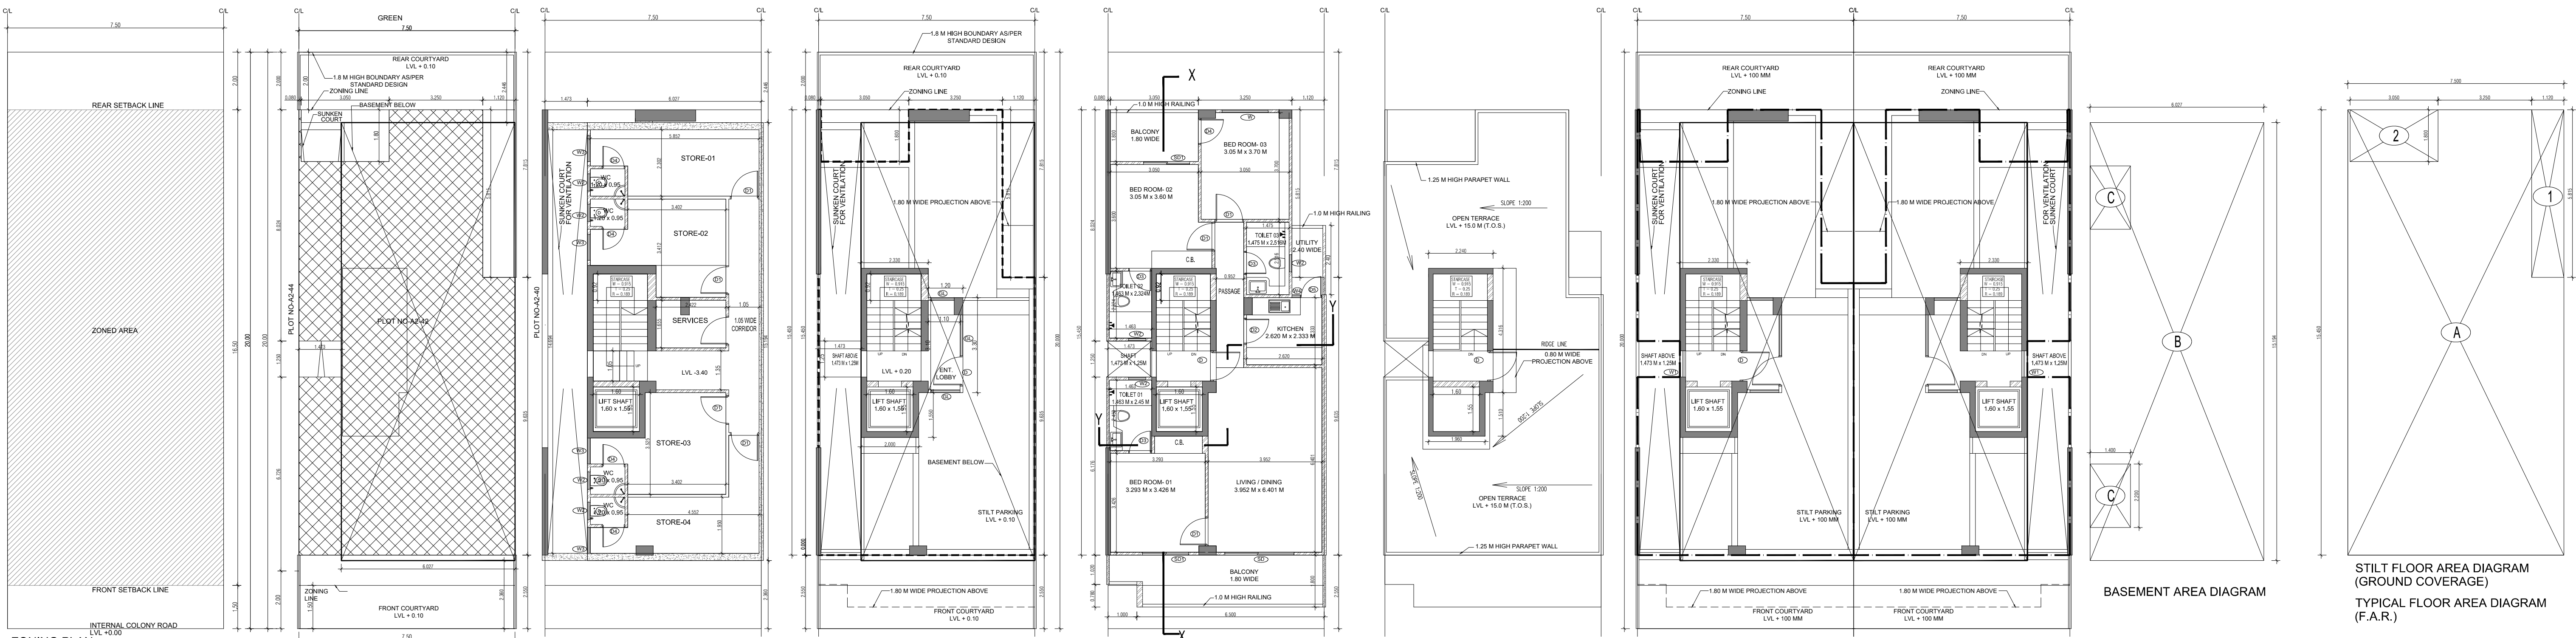


| PLUMBING LEGEND FOR VERTICAL PIPES:- |                                           |  |  |  |  |
|--------------------------------------|-------------------------------------------|--|--|--|--|
| 1                                    | 110 OD uPVC SOIL & WASTE VENT PIPE        |  |  |  |  |
| 2                                    | 110 OD uPVC WASTE & VENT PIPE FOR KITCHEN |  |  |  |  |
| 3                                    | DOMESTIC WATER SUPPLY DN. TAKE PIPE       |  |  |  |  |
| 4                                    | FLUSHING WATER SUPPLY DN. TAKE PIPE       |  |  |  |  |
| 5                                    | 75 OD uPVC RAIN WATER PIPE FOR BALCONY    |  |  |  |  |
| 6                                    | 110 OD uPVC RAIN WATER PIPE FOR TERRACE   |  |  |  |  |
| 7                                    | 25u DOMESTIC WATER RISER PIPE TO OHT      |  |  |  |  |
| 8                                    | 20u FLUSHING WATER RISER PIPE TO OHT      |  |  |  |  |
| SEWAGE MANHOLE                       |                                           |  |  |  |  |
| DRAINAGE CATCH BASIN                 |                                           |  |  |  |  |
| DRAINAGE MANHOLE                     |                                           |  |  |  |  |

| DOOR WINDOW SCHEDULE |        |            |             |                      |                        |
|----------------------|--------|------------|-------------|----------------------|------------------------|
| SR NO                | LEGEND | WIDTH (MM) | HEIGHT (MM) | CILL LVL. (FROM FFL) | LINTEL LVL. (FROM FFL) |
| 1                    | D      | 1.05       | 2.45        | 0                    | 2.45                   |
| 2                    | D1     | 1.0        | 2.15        | 0                    | 2.45                   |
| 3                    | D2     | 0.9        | 2.15        | 0                    | 2.15                   |
| 4                    | D3     | 0.75       | 2.45        | 0                    | 2.15                   |
| 5                    | D4     | 0.90       | 2.15        | 0                    | 2.45                   |
| 6                    | D5     | 0.90       | 2.15        | 0                    | 2.45                   |
| 7                    | S2     | 2.4        | 2.45        | 0                    | 2.45                   |
| 8                    | S2     | 1.6        | 2.45        | 0                    | 2.45                   |
| 9                    | W      | 1.6        | 2           | 0.45                 | 2.45                   |
| 10                   | W1     | 0.9        | 0.93        | 1.2                  | 2.13                   |
| 11                   | W2     | 0.6        | 0.93        | 1.5                  | 2.45                   |
| 12                   | W3     | 0.9        | 2           | 0.45                 | 2.45                   |
| 13                   | W4     | 0.45       | 2.45        | 0                    | 2.45                   |

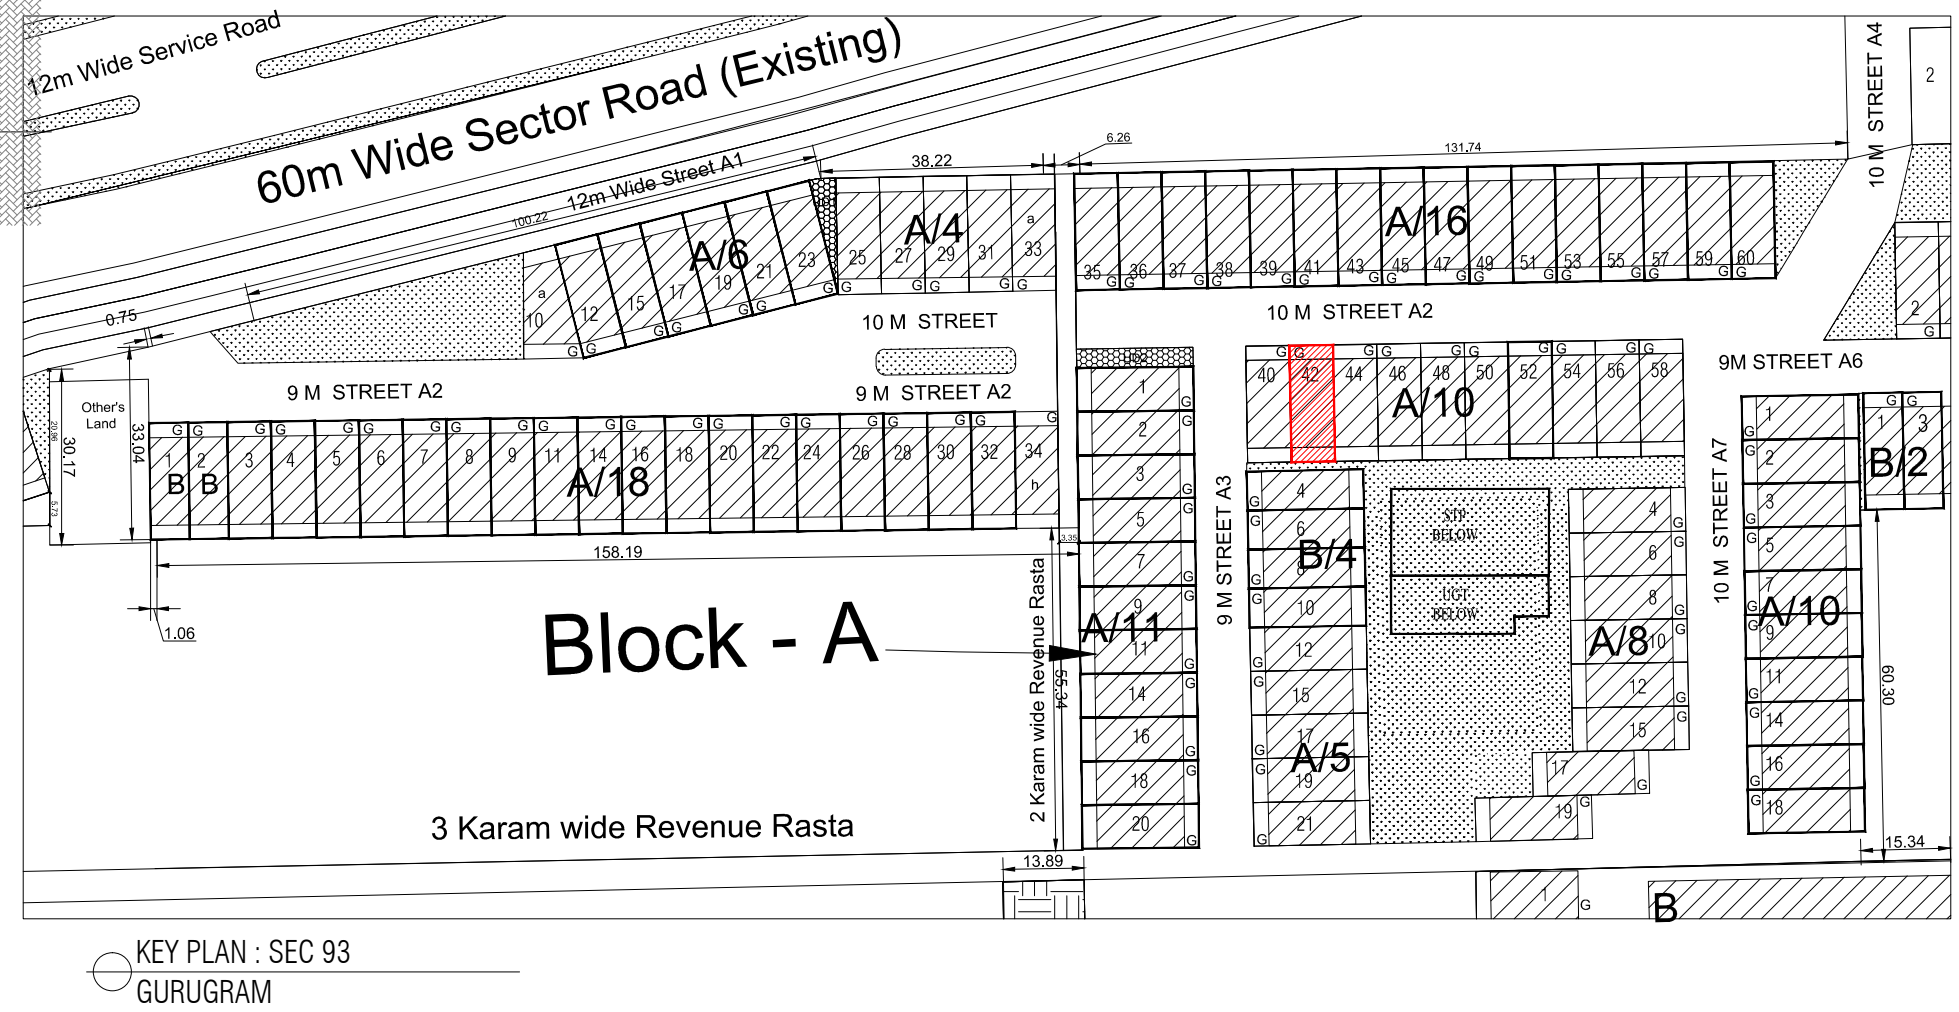

| AREA CALCULATION                                        |  |  | AREA               | UNIT          |
|---------------------------------------------------------|--|--|--------------------|---------------|
| TOTAL PLOT AREA ( 7.50 M x 20 M )                       |  |  | 150                | Sq.mt         |
| PERMISSIBLE FAR AS PER APPROVED ZONING PLAN @ 2.00      |  |  | 300                | Sq.mt         |
| PURCHASABLE FAR @ 0.64                                  |  |  | 96                 | Sq.mt         |
| TOTAL PERMISSIBLE FAR @ 2.64                            |  |  | 396                | Sq.mt         |
| PROPOSED FAR @ 2.63                                     |  |  | 395.395            | Sq.mt         |
| PERMISSIBLE GROUND COVERAGE @ 75%                       |  |  | 112.50             | Sq.mt         |
| PROPOSED GROUND COVERAGE @ 69.24 %                      |  |  | 103.872            | Sq.mt         |
| AREA OF STILT FLOOR ( GROUND COVERAGE )                 |  |  |                    |               |
| A                                                       |  |  | 7.5 x 15.45 x 1    | 115.875 Sq.mt |
| TOTAL                                                   |  |  |                    | 115.875 Sq.mt |
| DEDUCTION (D)                                           |  |  |                    |               |
| 1                                                       |  |  | 1.12 x 5.815 x 1   | 6.513 Sq.mt   |
| 2                                                       |  |  | 3.05 x 1.800 x 1   | 5.490 Sq.mt   |
| TOTAL                                                   |  |  |                    | 12.003 Sq.mt  |
| PROPOSED GROUND COVERAGE = A-D                          |  |  |                    | 103.872 Sq.mt |
| AREA CALCULATION FOR TYPICAL FLOOR ( 1st to 4th FLOOR ) |  |  |                    |               |
| TOTAL AREA ON GROUND COVERAGE (X)                       |  |  |                    | 103.872 Sq.mt |
| DEDUCTION                                               |  |  |                    |               |
| 1 (STAIRCASE)                                           |  |  | 1.880 x 3.715 x 1  | 6.984 Sq.mt   |
| 2                                                       |  |  | 1.600 x 1.550 x 1  | 2.480 Sq.mt   |
| 3                                                       |  |  | 1.473 x 1.250 x 1  | 1.841 Sq.mt   |
| TOTAL (Y)                                               |  |  |                    | 11.305 Sq.mt  |
| TOTAL AREA OF TYPICAL FLOOR ( X-Y )                     |  |  |                    | 92.567 Sq.mt  |
| BASEMENT BUILT UP AREA                                  |  |  |                    |               |
| B                                                       |  |  | 6.027 x 15.194 x 1 | 91.574 Sq.mt  |
| TOTAL                                                   |  |  |                    | 91.574 Sq.mt  |
| BASEMENT F.A.R. AREA                                    |  |  |                    |               |
| C                                                       |  |  | 1.400 x 2.200 x 2  | 6.160 Sq.mt   |
| TOTAL                                                   |  |  |                    | 6.160 Sq.mt   |
| NET NON F.A.R AREA OF BASEMENT                          |  |  |                    |               |
| B-C                                                     |  |  |                    | 85.414 Sq.mt  |
| TOTAL                                                   |  |  |                    | 85.414 Sq.mt  |
| STILT FAR                                               |  |  |                    |               |
| E                                                       |  |  | 2.333 x 4.315 x 1  | 10.067 Sq.mt  |
| F                                                       |  |  | 2.000 x 1.550 x 1  | 3.100 Sq.mt   |
| G                                                       |  |  | 1.473 x 1.250 x 1  | 1.841 Sq.mt   |
| J                                                       |  |  | 1.2 x 3.300 x 1    | 3.960 Sq.mt   |
| TOTAL                                                   |  |  |                    | 18.968 Sq.mt  |
| MUMTY AREA                                              |  |  |                    |               |
| H                                                       |  |  | 1.960 x 1.51 x 1   | 2.960 Sq.mt   |
| I                                                       |  |  | 2.24 x 4.32 x 1    | 9.668 Sq.mt   |
| TOTAL                                                   |  |  |                    | 12.627 Sq.mt  |
| PROJECTION AREA                                         |  |  |                    |               |
| 6.500 x 1.800 x 1                                       |  |  |                    | 11.700 Sq.mt  |
| 1.000 x 1.020 x 1                                       |  |  |                    | 1.020 Sq.mt   |
| 1.120 x 1.800 x 1                                       |  |  |                    | 2.016 Sq.mt   |
| 3.050 x 1.800 x 1                                       |  |  |                    | 5.490 Sq.mt   |
| TOTAL                                                   |  |  |                    | 20.226 Sq.mt  |
| GROUND COVERAGE CALCULATION                             |  |  |                    |               |
| STILT FLOOR AREA, STAIRCASE, LIFT SHAFT INCLUDED        |  |  |                    | 103.872 Sq.mt |
| TOTAL GROUND COVERAGE ACHIEVED                          |  |  |                    | 103.872 Sq.mt |
| FAR CALCULATION                                         |  |  |                    |               |
| TYPICAL FLOOR AREA x 4                                  |  |  |                    | 370.267 Sq.mt |
| FAR AREA UN BASEMENT                                    |  |  |                    | 6.160         |
| FAR AREA ON STILT                                       |  |  |                    | 18.968 Sq.mt  |
| TOTAL FAR ACHIEVED                                      |  |  |                    | 395.395 Sq.mt |
| BUILT UP AREA CALCULATION                               |  |  |                    |               |
| BASEMENT AREA (FAR-NON FAR) + COVERAGE                  |  |  |                    | 697.102 Sq.mt |
| AT STILT AREA + FLOOR AREA + STAIR CASE x 4 +           |  |  |                    |               |
| MUMTY AREA + PROJECTION AREA x 4                        |  |  |                    |               |

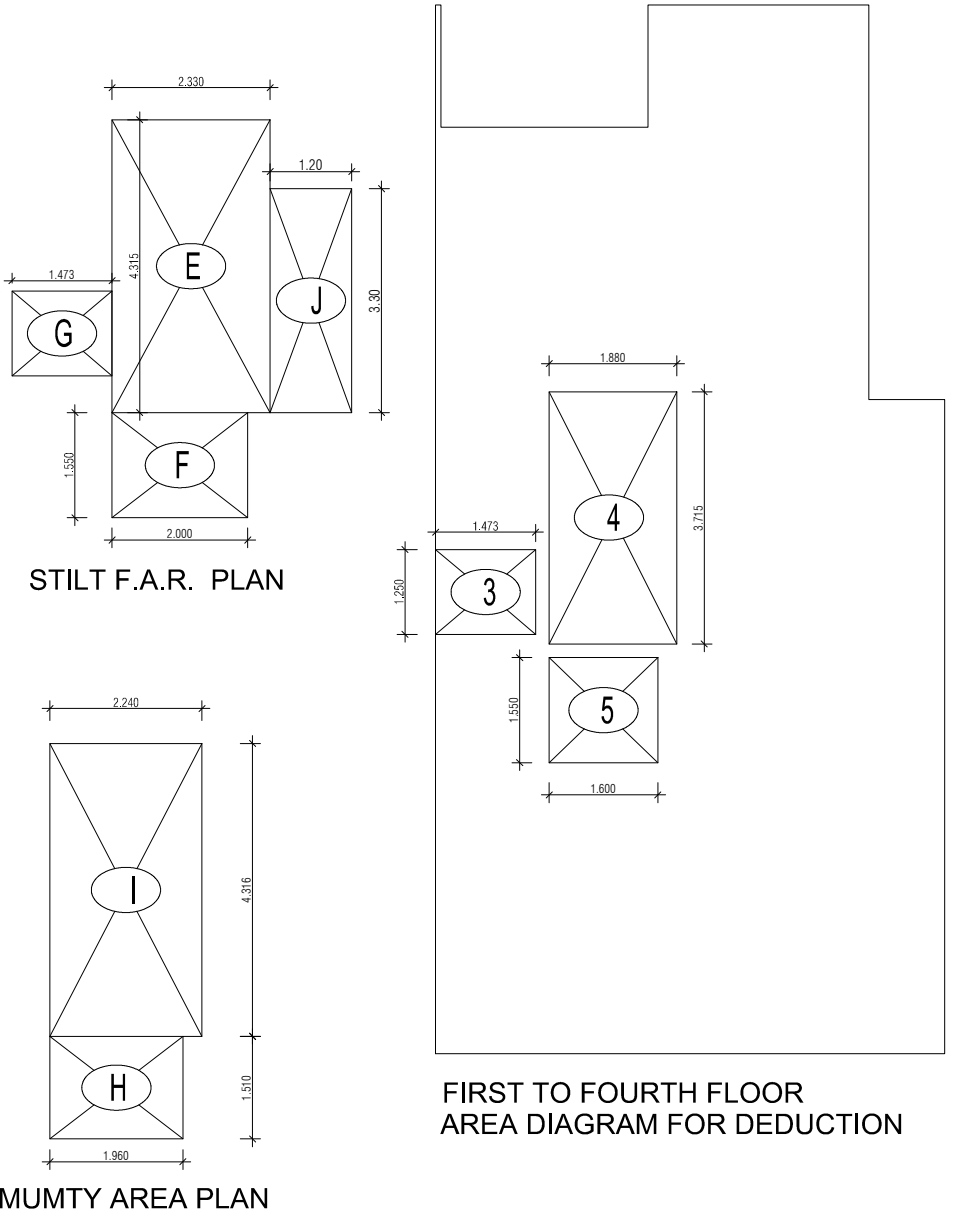

**PROJECT -**

**PROPOSED INDEPENDENT RESIDENTIAL FLOORS ON PLOT NO A2 - 42 (STREET A2 - 10 M WIDE) IN AFFORDABLE RESIDENTIAL PLOTTED COLONY UNDER DEEN DAYAL JAN AWAS YOJNA-2016 OVER AN AREA MEASURING 26.91875 (LICESNE NO 94 OF 2021 DT 12.11.2021) IN VILLAGE HAYATPUR, SECTOR 93, GURUGRAM, BEING DEVELOPED BY SAGARDUTT BUILDERS & DEVELOPERS PVT LTD & OTHERS IN COLLABORATION WITH DLF LIMITED.**

**OWNERS -**

**DLF LIMITED**

**ARCHITECTS -**

Arco Associates Private Limited  
Plot- 36b, Sec-32, Gurgaon-122001  
Ph.: 26242050, 26242169

**DRAWING TITLE -**

TYPE A ( 7.5 M x 20 M ) FLOORS PLANS WITH AREA CALCULATIONS , ELEVATION & SECTIONS

**DRAWING NUMBER -**

**SCALE = 1:50**

**DATE:**

**DRAWN BY -**

**CHECKED BY -**







**DRAWING NUMBER -**

**ARCHITECT SIGN**


**AUTHORISED SIGN**

**Vandana Arora**


**VANDANA ARORA**

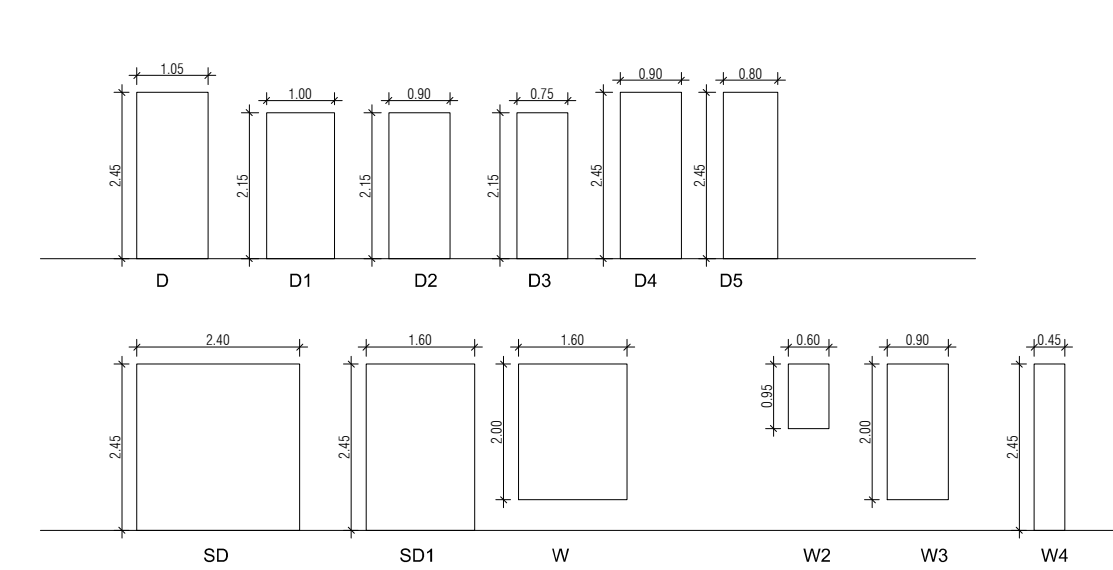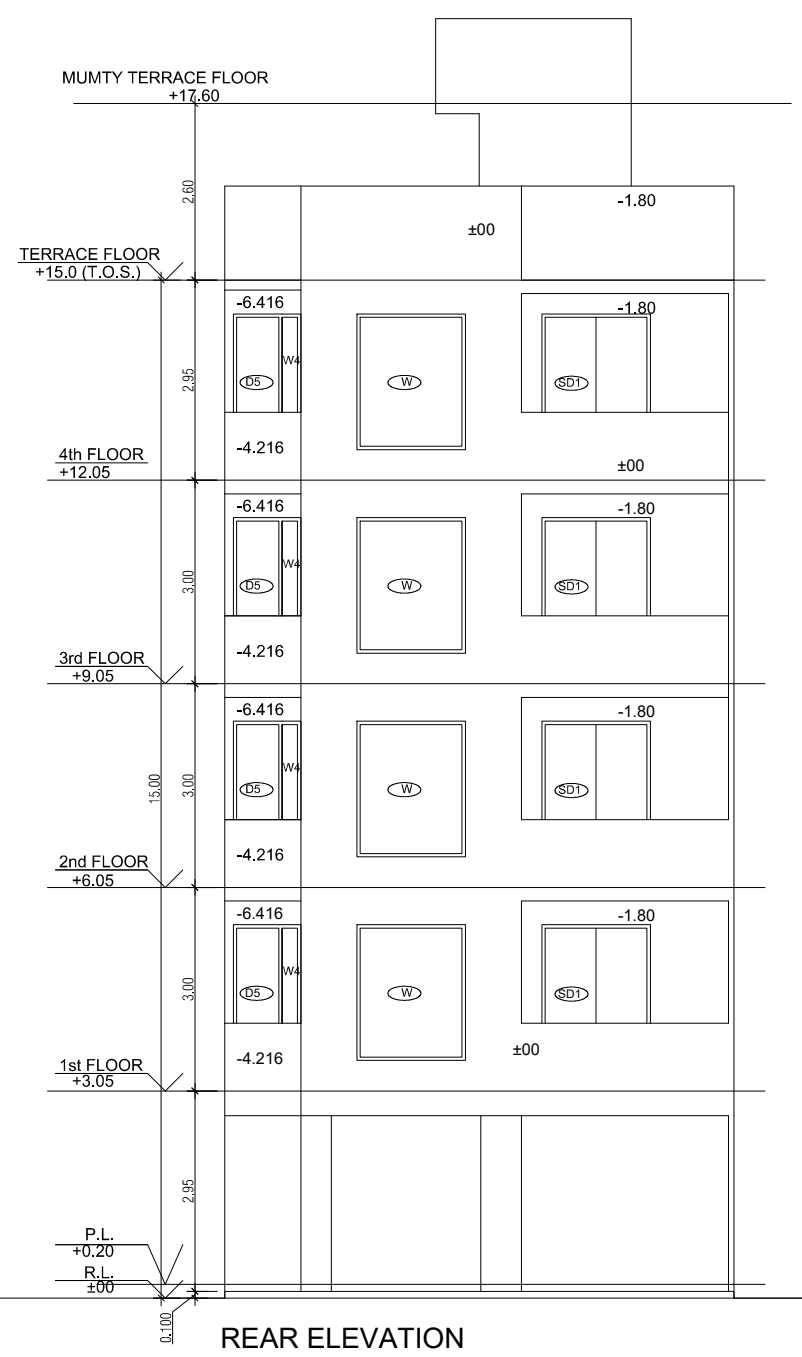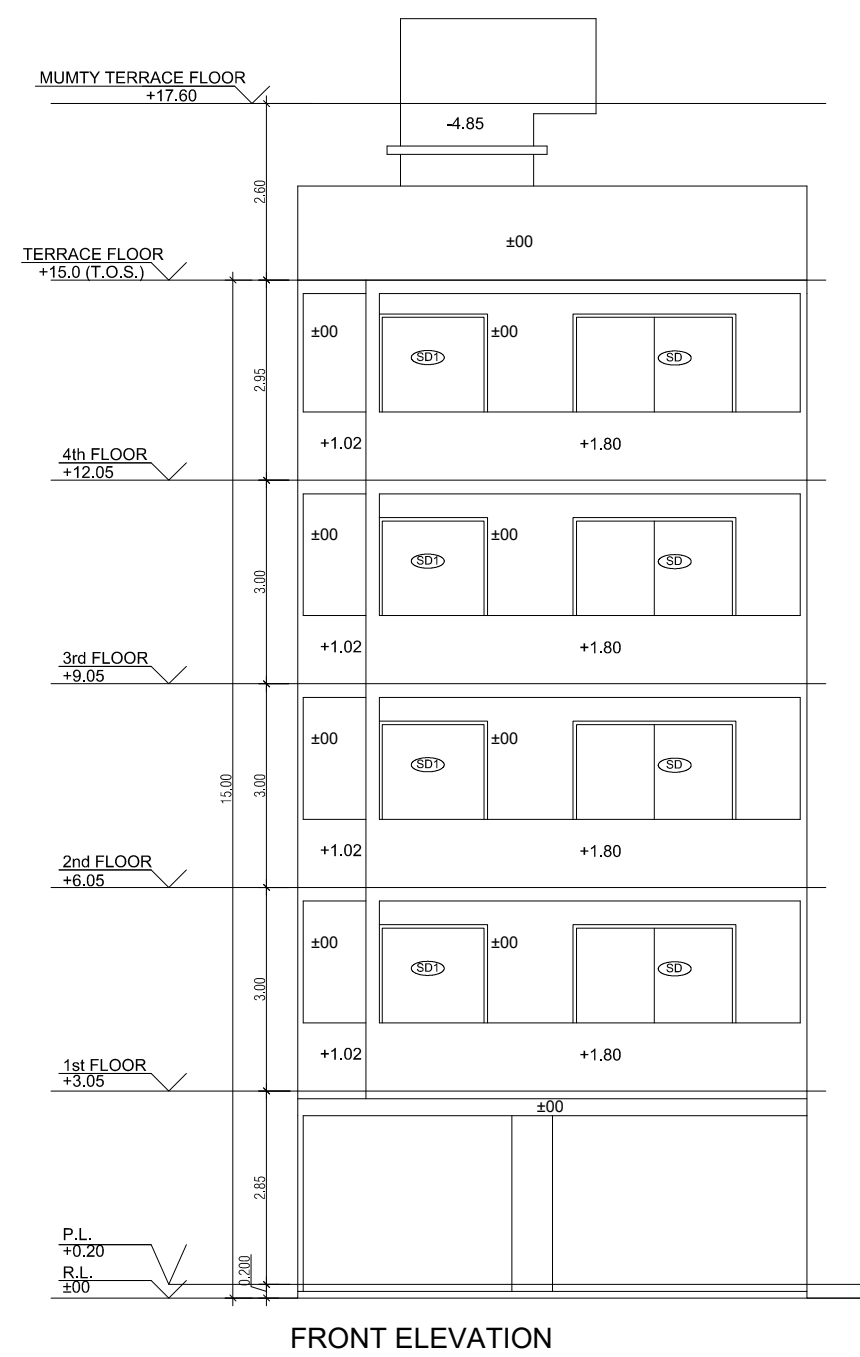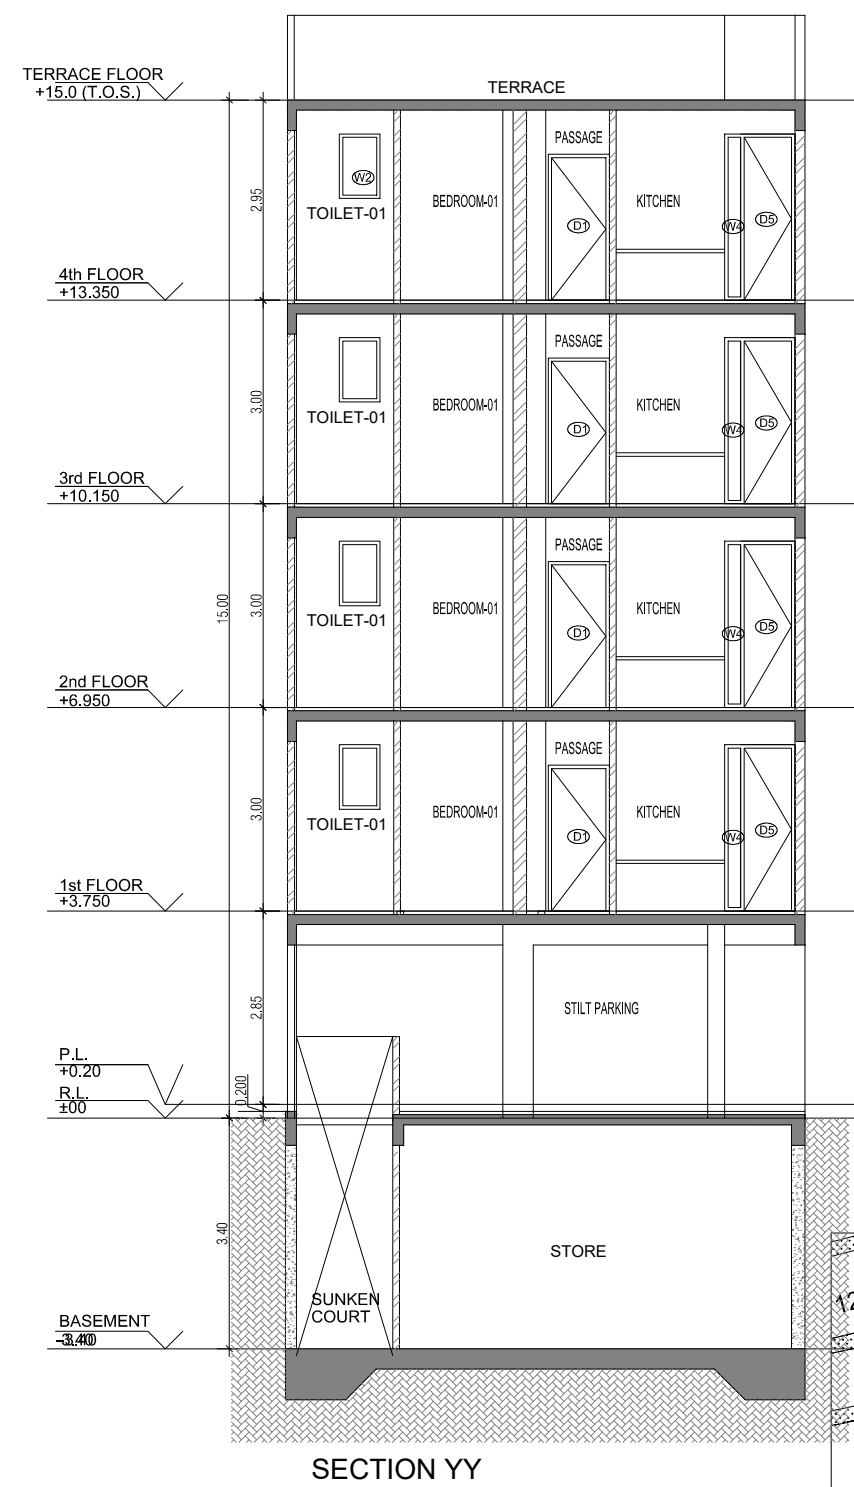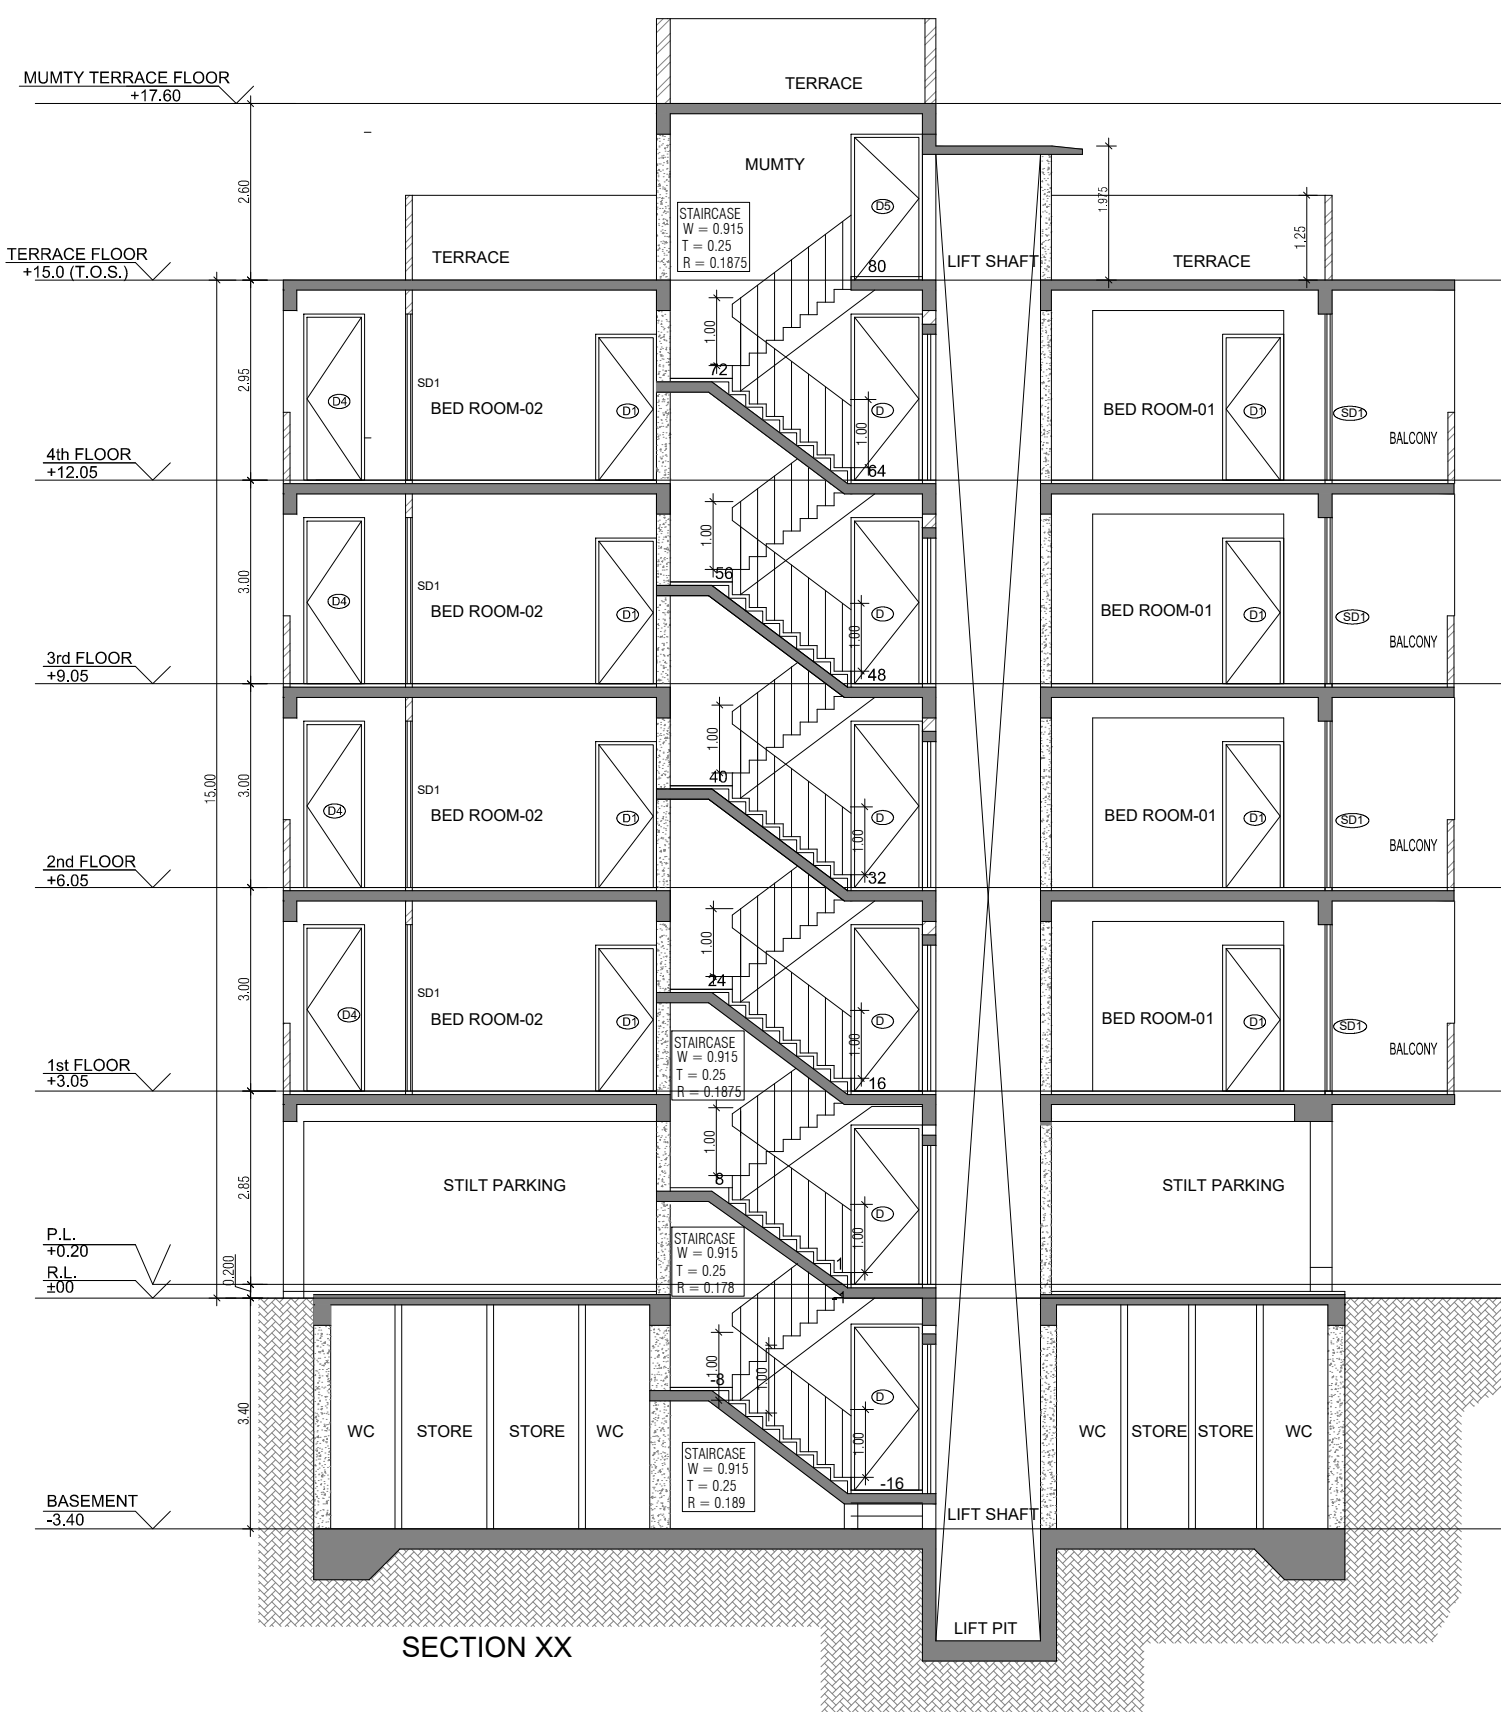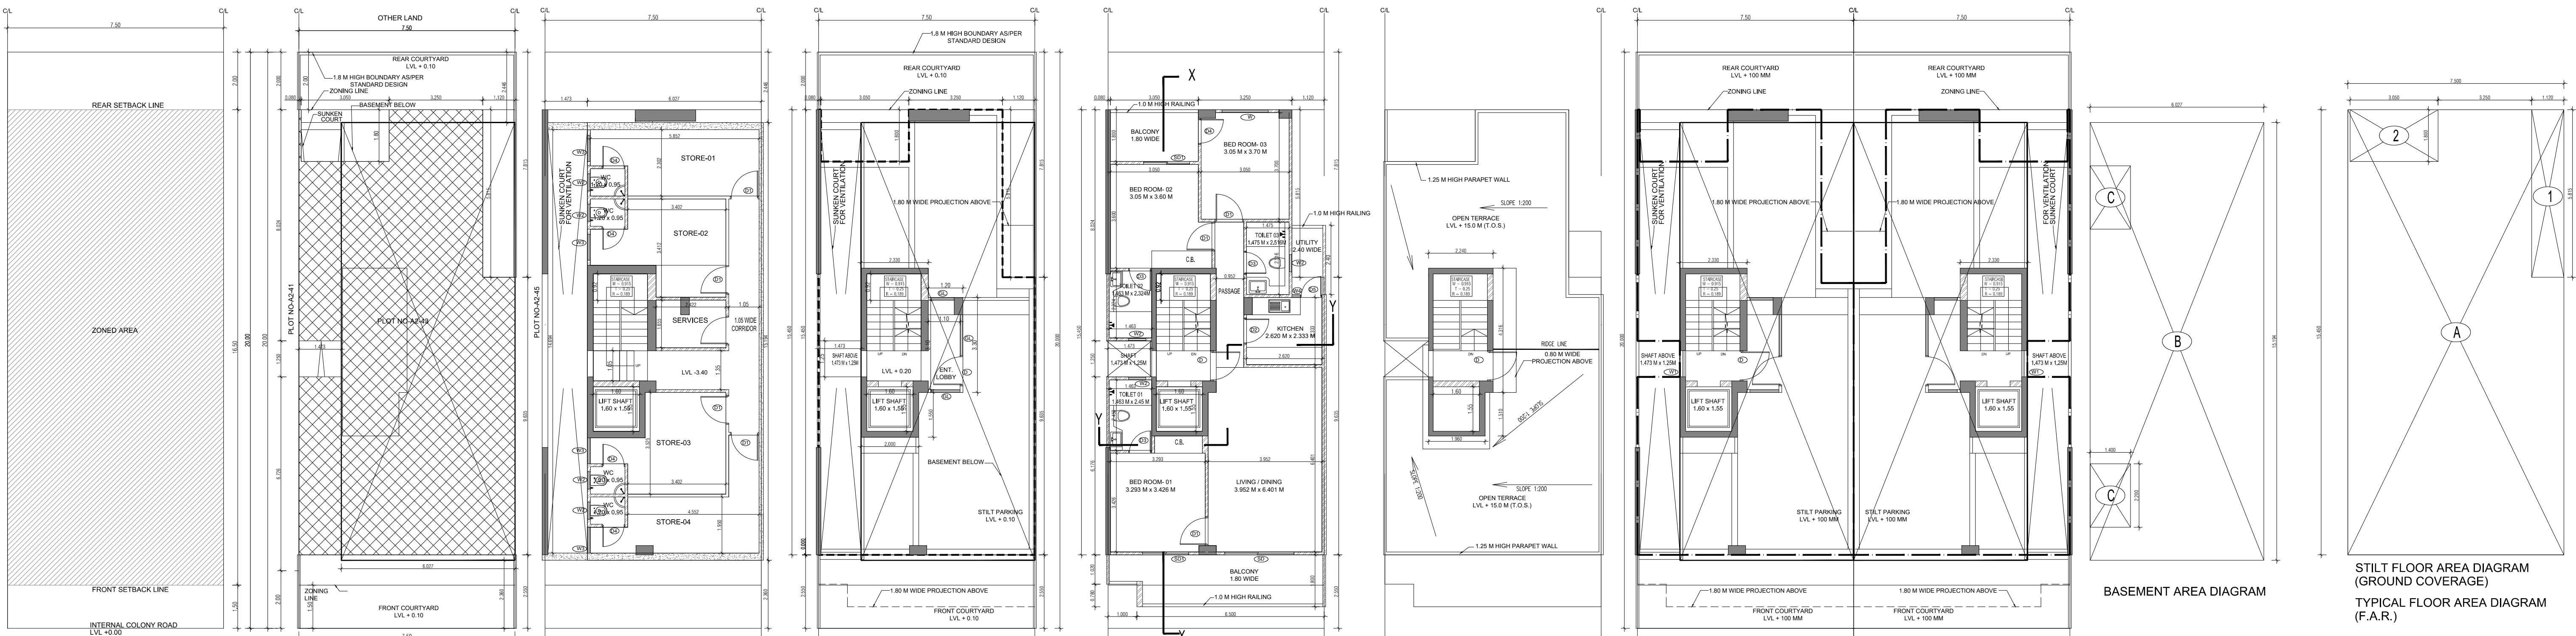

| PLUMBING LEGEND FOR VERTICAL PIPES:- |                                           |        |            |             |                    |
|--------------------------------------|-------------------------------------------|--------|------------|-------------|--------------------|
| ①                                    | 110 OD uPVC SOIL & WASTE VENT PIPE        |        |            |             |                    |
| ②                                    | 110 OD uPVC WASTE & VENT PIPE FOR KITCHEN |        |            |             |                    |
| ③                                    | DOMESTIC WATER SUPPLY DN. TAKE PIPE       |        |            |             |                    |
| ④                                    | FLUSHING WATER SUPPLY DN. TAKE PIPE       |        |            |             |                    |
| ⑤                                    | 75 OD uPVC RAIN WATER PIPE FOR BALCONY    |        |            |             |                    |
| ⑥                                    | 110 OD uPVC RAIN WATER PIPE FOR TERRACE   |        |            |             |                    |
| ⑦                                    | 25# DOMESTIC WATER RISER PIPE TO OHT      |        |            |             |                    |
| ⑧                                    | 20# FLUSHING WATER RISER PIPE TO OHT      |        |            |             |                    |
| DOOR WINDOW SCHEDULE                 |                                           |        |            |             |                    |
| SR                                   | NO                                        | LEGEND | WIDTH (MM) | HEIGHT (MM) | CLL LVL (FROM FFL) |
| 1                                    | D1                                        | 1.05   | 2.45       | 2.45        | 0                  |
| 2                                    | D1                                        | 1.0    | 2.15       | 0           | 2.45               |
| 3                                    | D2                                        | 0.9    | 2.15       | 0           | 2.15               |
| 4                                    | D3                                        | 0.75   | 2.45       | 0           | 2.15               |
| 5                                    | D4                                        | 0.90   | 2.15       | 0           | 2.45               |
| 6                                    | D4                                        | 0.90   | 2.15       | 0           | 2.45               |
| 7                                    | S2                                        | 2.4    | 2.45       | 0           | 2.45               |
| 8                                    | S2                                        | 1.6    | 2.45       | 0           | 2.45               |
| 9                                    | W                                         | 1.6    | 2          | 0.45        | 2.45               |
| 10                                   | W1                                        | 0.9    | 0.93       | 1.2         | 2.13               |
| 11                                   | W2                                        | 0.6    | 0.93       | 1.5         | 2.45               |
| 12                                   | W3                                        | 0.9    | 2          | 0.45        | 2.45               |
| 13                                   | W4                                        | 0.45   | 2.45       | 0           | 2.45               |

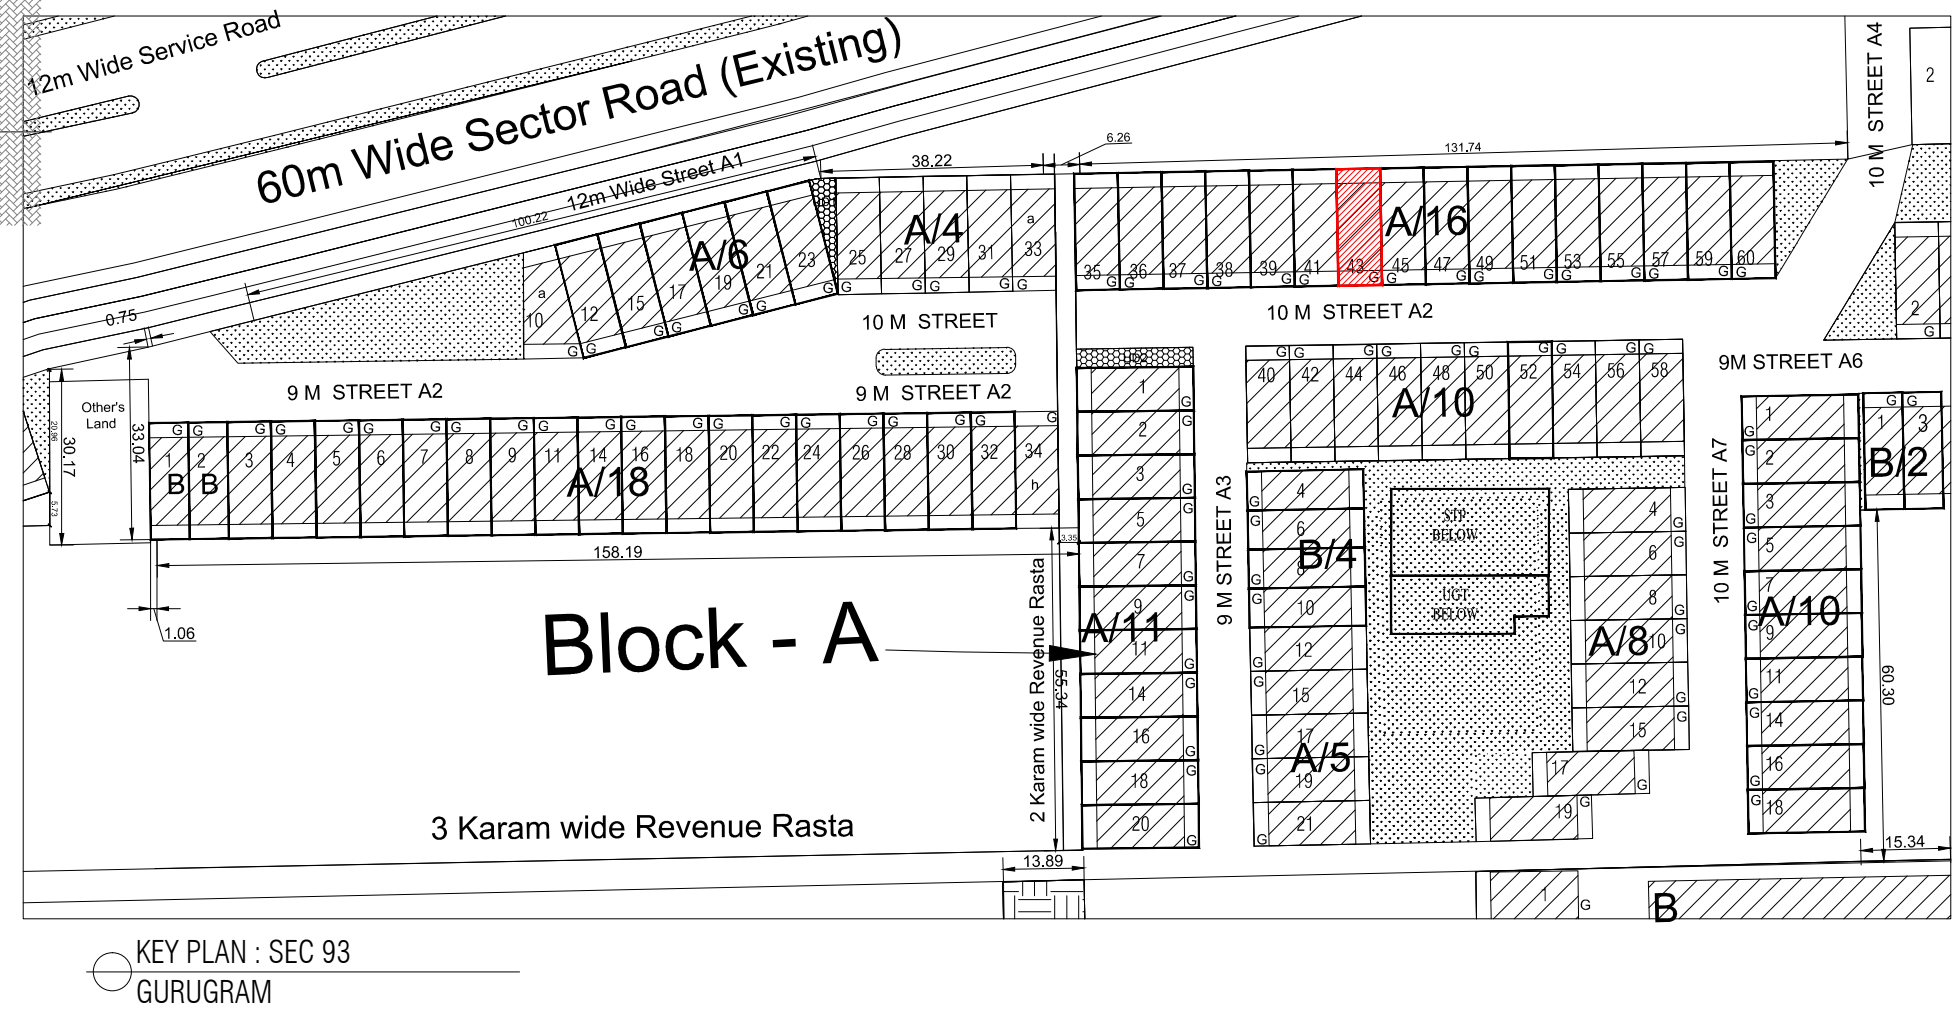

| AREA CALCULATION                                                               |  |  | AREA               | UNIT          |
|--------------------------------------------------------------------------------|--|--|--------------------|---------------|
| TOTAL PLOT AREA (7.50 M x 20 M)                                                |  |  | 150                | Sq.mt         |
| PERMISSIBLE FAR AS PER APPROVED ZONING PLAN @ 2.00                             |  |  | 300                | Sq.mt         |
| PURCHASABLE FAR @ 0.64                                                         |  |  | 96                 | Sq.mt         |
| TOTAL PERMISSIBLE FAR @ 2.64                                                   |  |  | 396                | Sq.mt         |
| PROPOSED FAR @ 2.63                                                            |  |  | 395.395            | Sq.mt         |
| PERMISSIBLE GROUND COVERAGE @ 75%                                              |  |  | 112.50             | Sq.mt         |
| PROPOSED GROUND COVERAGE @ 69.24%                                              |  |  | 103.872            | Sq.mt         |
| AREA OF STILT FLOOR (GROUND COVERAGE)                                          |  |  |                    |               |
| A                                                                              |  |  | 7.5 x 15.45 x 1    | 115.875 Sq.mt |
| TOTAL                                                                          |  |  |                    | 115.875 Sq.mt |
| DEDUCTION (D)                                                                  |  |  |                    |               |
| 1                                                                              |  |  | 1.12 x 5.815 x 1   | 6.513 Sq.mt   |
| 2                                                                              |  |  | 3.05 x 1.800 x 1   | 5.490 Sq.mt   |
| TOTAL                                                                          |  |  |                    | 12.003 Sq.mt  |
| PROPOSED GROUND COVERAGE = A-D                                                 |  |  |                    | 103.872 Sq.mt |
| AREA CALCULATION FOR TYPICAL FLOOR (1st to 4th FLOOR)                          |  |  |                    |               |
| TOTAL AREA ON GROUND COVERAGE (X)                                              |  |  |                    | 103.872 Sq.mt |
| DEDUCTION                                                                      |  |  |                    |               |
| 1 (STAIRCASE)                                                                  |  |  | 1.880 x 3.715 x 1  | 6.984 Sq.mt   |
| 2                                                                              |  |  | 1.600 x 1.550 x 1  | 2.480 Sq.mt   |
| 3                                                                              |  |  | 1.473 x 1.250 x 1  | 1.841 Sq.mt   |
| TOTAL (Y)                                                                      |  |  |                    | 11.305 Sq.mt  |
| TOTAL AREA OF TYPICAL FLOOR (X-Y)                                              |  |  |                    | 92.567 Sq.mt  |
| BASEMENT BUILT UP AREA                                                         |  |  |                    |               |
| B                                                                              |  |  | 6.027 x 15.194 x 1 | 91.574 Sq.mt  |
| TOTAL                                                                          |  |  |                    | 91.574 Sq.mt  |
| BASEMENT F.A.R. AREA                                                           |  |  |                    |               |
| C                                                                              |  |  | 1.400 x 2.200 x 2  | 6.160 Sq.mt   |
| TOTAL                                                                          |  |  |                    | 6.160 Sq.mt   |
| NET NON F.A.R AREA OF BASEMENT                                                 |  |  |                    |               |
| B-C                                                                            |  |  |                    | 85.414 Sq.mt  |
| TOTAL                                                                          |  |  |                    | 85.414 Sq.mt  |
| STILT FAR                                                                      |  |  |                    |               |
| E                                                                              |  |  | 2.333 x 4.315 x 1  | 10.067 Sq.mt  |
| F                                                                              |  |  | 2.000 x 1.550 x 1  | 3.100 Sq.mt   |
| G                                                                              |  |  | 1.473 x 1.250 x 1  | 1.841 Sq.mt   |
| J                                                                              |  |  | 1.2 x 3.300 x 1    | 3.960 Sq.mt   |
| TOTAL                                                                          |  |  |                    | 18.968 Sq.mt  |
| MUMTY AREA                                                                     |  |  |                    |               |
| H                                                                              |  |  | 1.960 x 1.51 x 1   | 2.960 Sq.mt   |
| I                                                                              |  |  | 2.24 x 4.32 x 1    | 9.660 Sq.mt   |
| TOTAL                                                                          |  |  |                    | 12.627 Sq.mt  |
| PROJECTION AREA                                                                |  |  |                    |               |
| 6.500 x 1.800 x 1                                                              |  |  |                    | 11.700 Sq.mt  |
| 1.000 x 1.020 x 1                                                              |  |  |                    | 1.020 Sq.mt   |
| 1.120 x 1.800 x 1                                                              |  |  |                    | 2.016 Sq.mt   |
| 3.050 x 1.800 x 1                                                              |  |  |                    | 5.490 Sq.mt   |
| TOTAL                                                                          |  |  |                    | 20.226 Sq.mt  |
| GROUND COVERAGE CALCULATION                                                    |  |  |                    |               |
| STILT FLOOR AREA, STAIRCASE, LIFT SHAFT INCLUDED                               |  |  |                    | 103.872 Sq.mt |
| TOTAL GROUND COVERAGE ACHIEVED                                                 |  |  |                    | 103.872 Sq.mt |
| FAR CALCULATION                                                                |  |  |                    |               |
| TYPICAL FLOOR AREA x 4                                                         |  |  |                    | 370.267 Sq.mt |
| FAR AREA UN BASEMENT                                                           |  |  |                    | 6.160         |
| FAR AREA ON STILT                                                              |  |  |                    | 18.968 Sq.mt  |
| TOTAL FAR ACHIEVED                                                             |  |  |                    | 395.395 Sq.mt |
| BUILT UP AREA CALCULATION                                                      |  |  |                    |               |
| BASEMENT AREA (FAR-NON FAR) + COVERAGE                                         |  |  |                    | 697.102 Sq.mt |
| AT STILT AREA + FLOOR AREA + STAIR CASE x 4 + MUMTY AREA + PROJECTION AREA x 4 |  |  |                    |               |

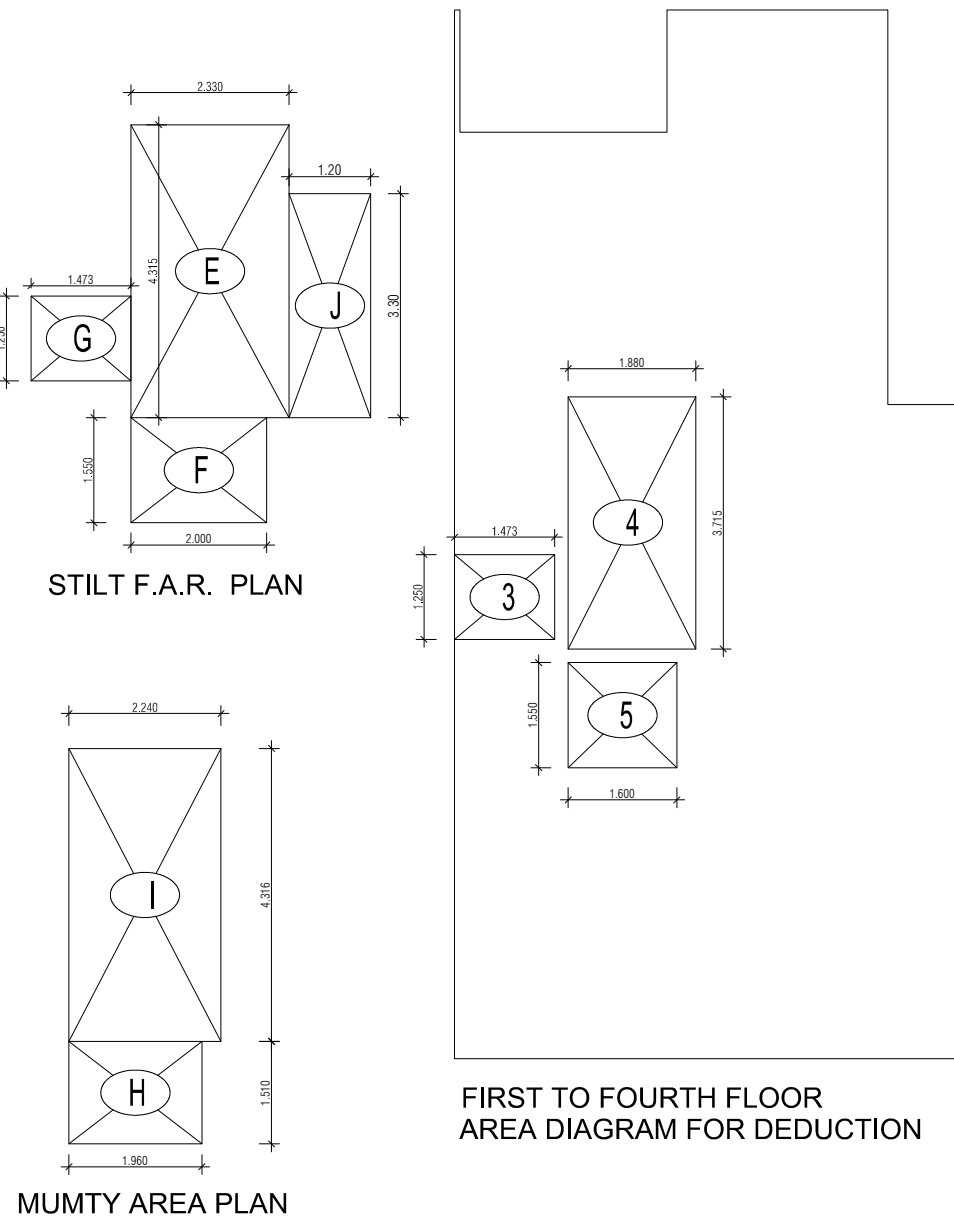

PROJECT -

PROPOSED INDEPENDENT RESIDENTIAL FLOORS ON PLOT NO A2 - 43 (STREET A2 - 10 M WIDE) IN AFFORDABLE RESIDENTIAL PLOTTED COLONY UNDER DEEN DAYAL JAN AWAS YOJNA-2016 OVER AN AREA MEASURING 26.91875 (LICESNE NO 94 OF 2021 DT 12.11.2021) IN VILLAGE HAYATPUR, SECTOR 93, GURUGRAM, BEING DEVELOPED BY SAGARDUTT BUILDERS & DEVELOPERS PVT LTD & OTHERS IN COLLABORATION WITH DLF LIMITED.

OWNERS -

DLF LIMITED

ARCHITECTS -

Arco Associates Private Limited  
Plot- 36b, Sec-32, Gurgaon-122001  
Ph.: 26242050, 26242169

DRAWING TITLE -

TYPE A ( 7.5 M x 20 M ) FLOORS PLANS WITH AREA CALCULATIONS , ELEVATION & SECTIONS

DRAWING NUMBER -

SCALE = 1:50

DATE :

DRAWN BY -

CHECKED BY -

DRAWING NUMBER -








ARCHITECT SIGN

AUTHORISED SIGN

Abhishek Tiwari  
Chartered CP Architect  
Registration No CA00115274


VArora  
VANDANA ARORA  
AUTHORISED SIGN



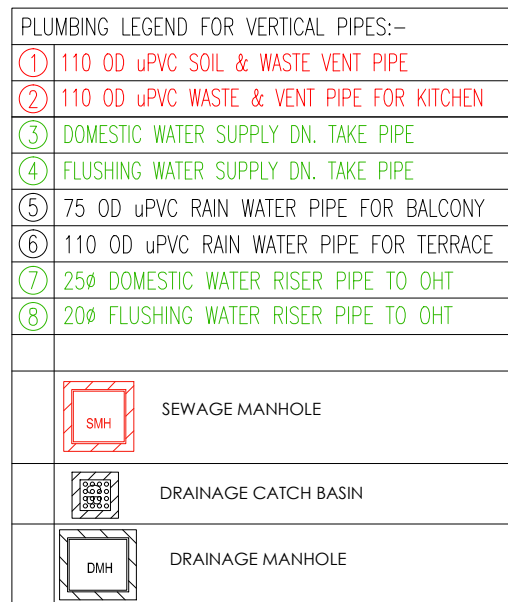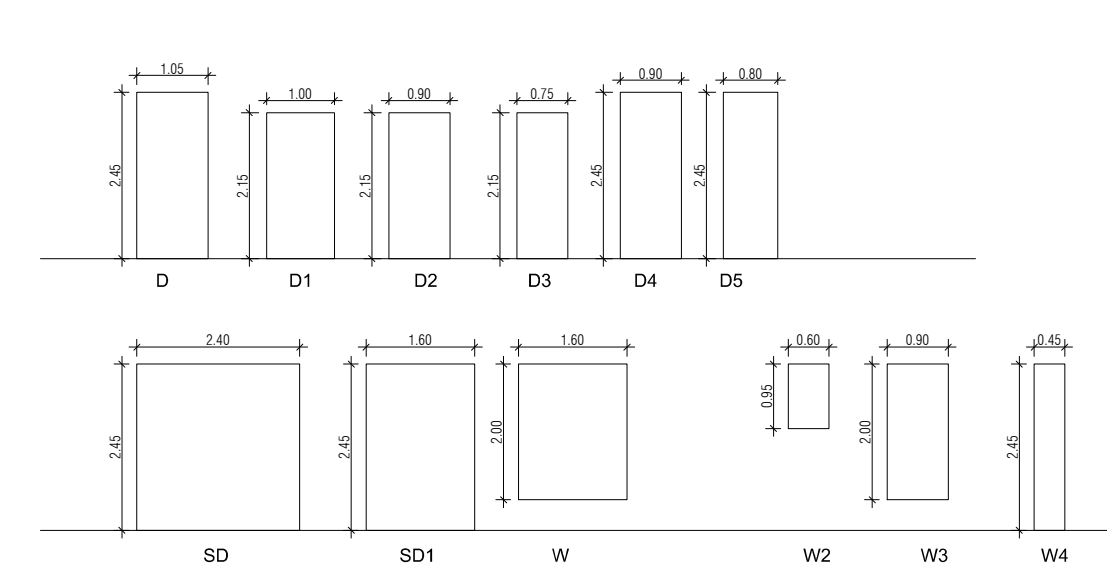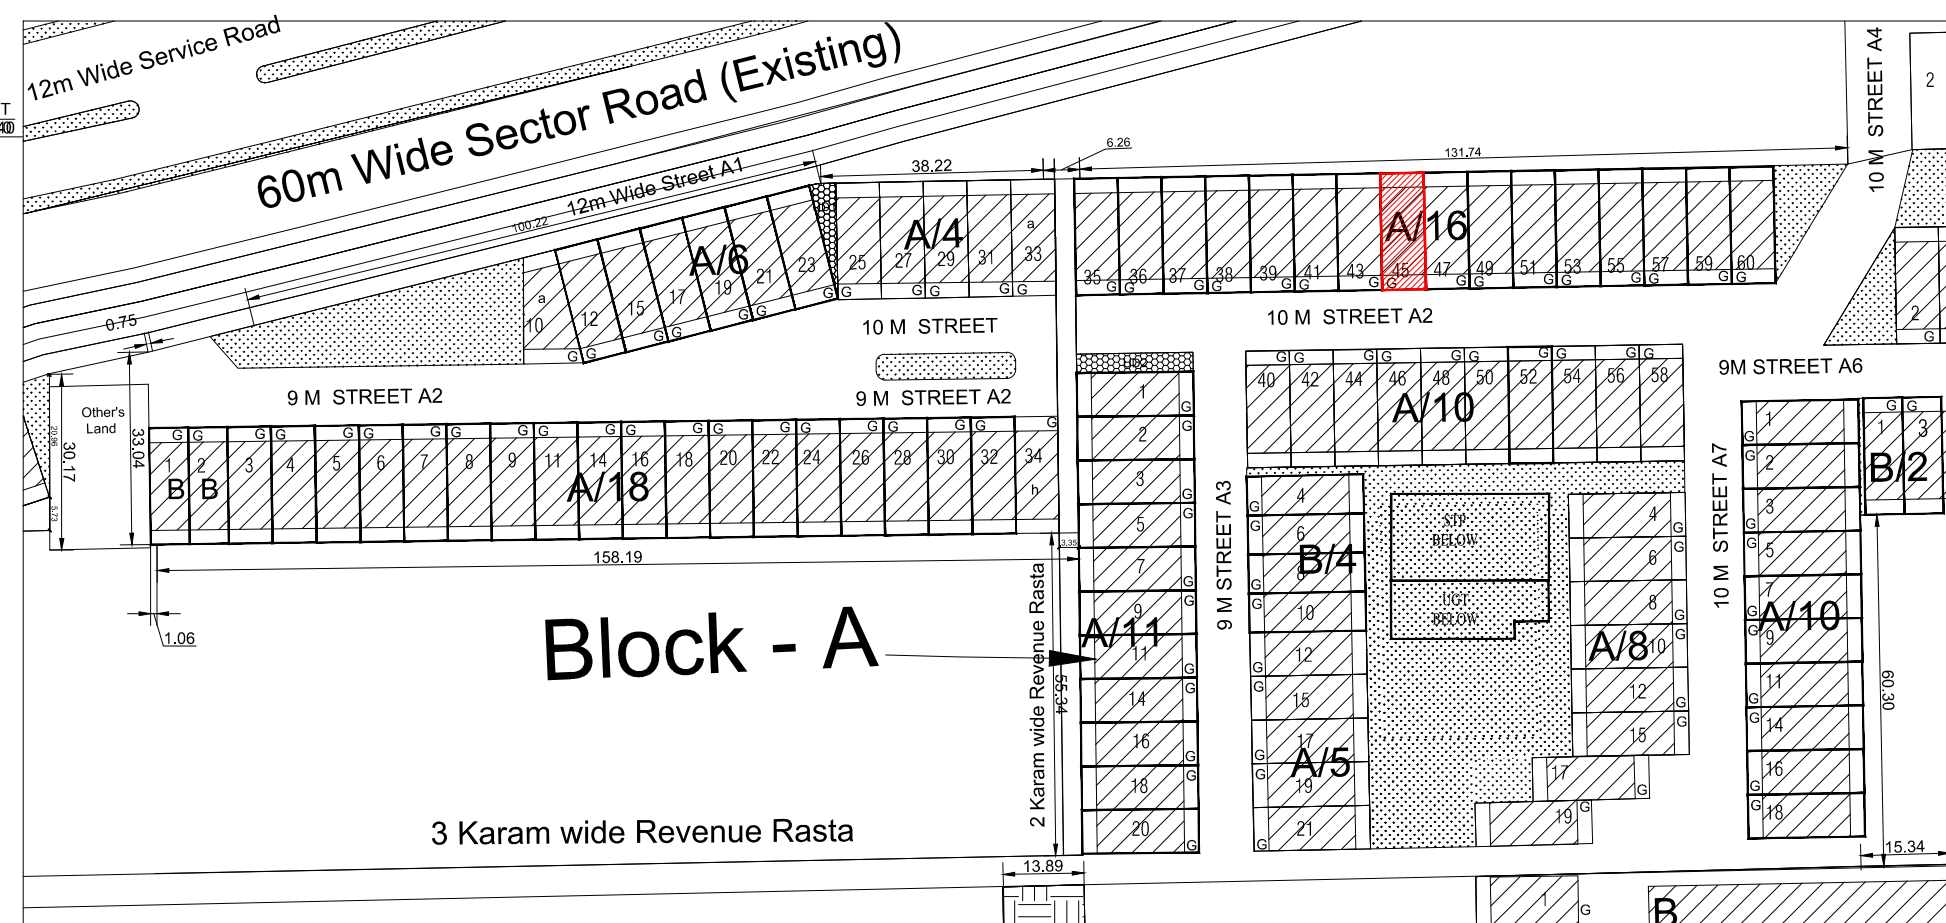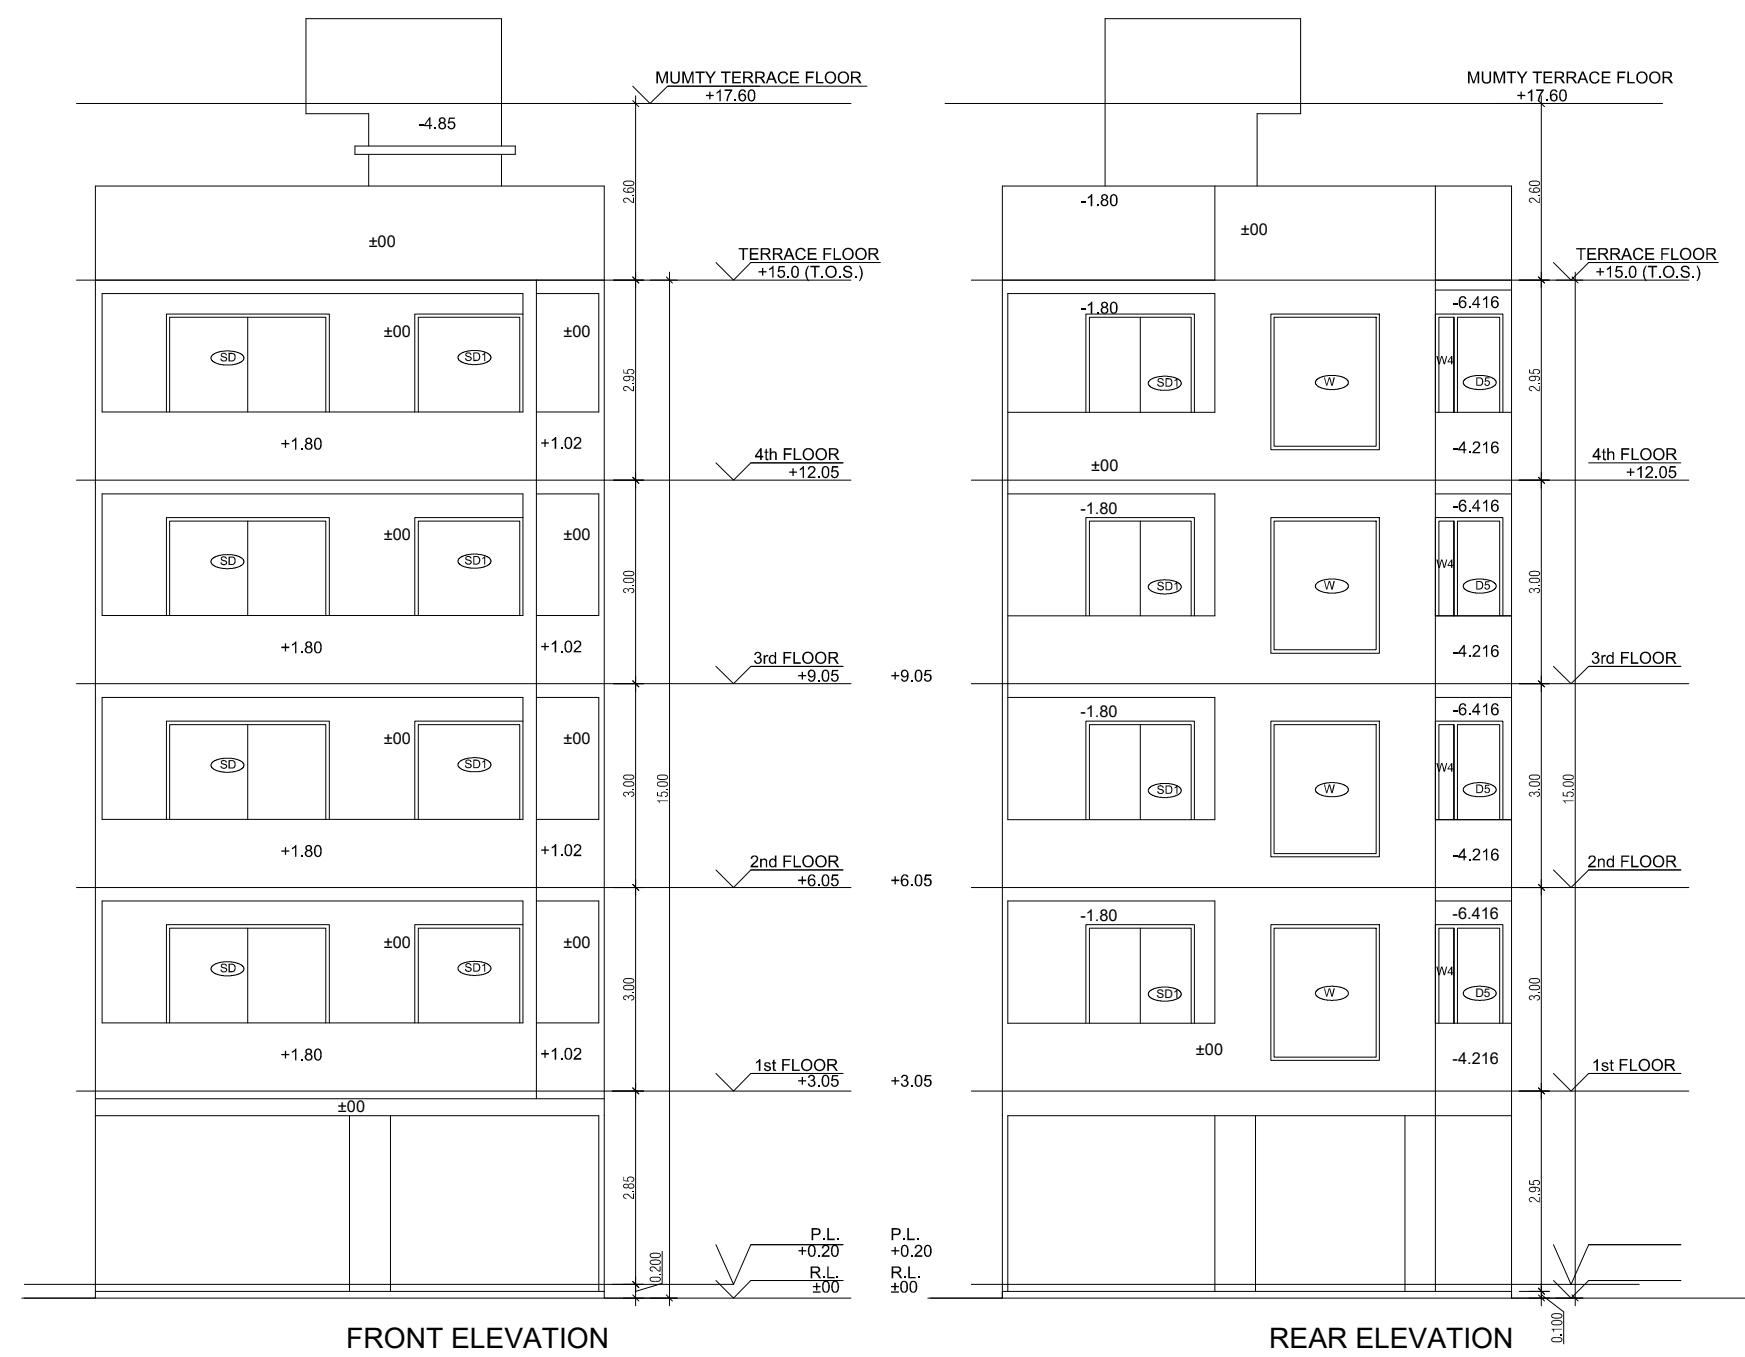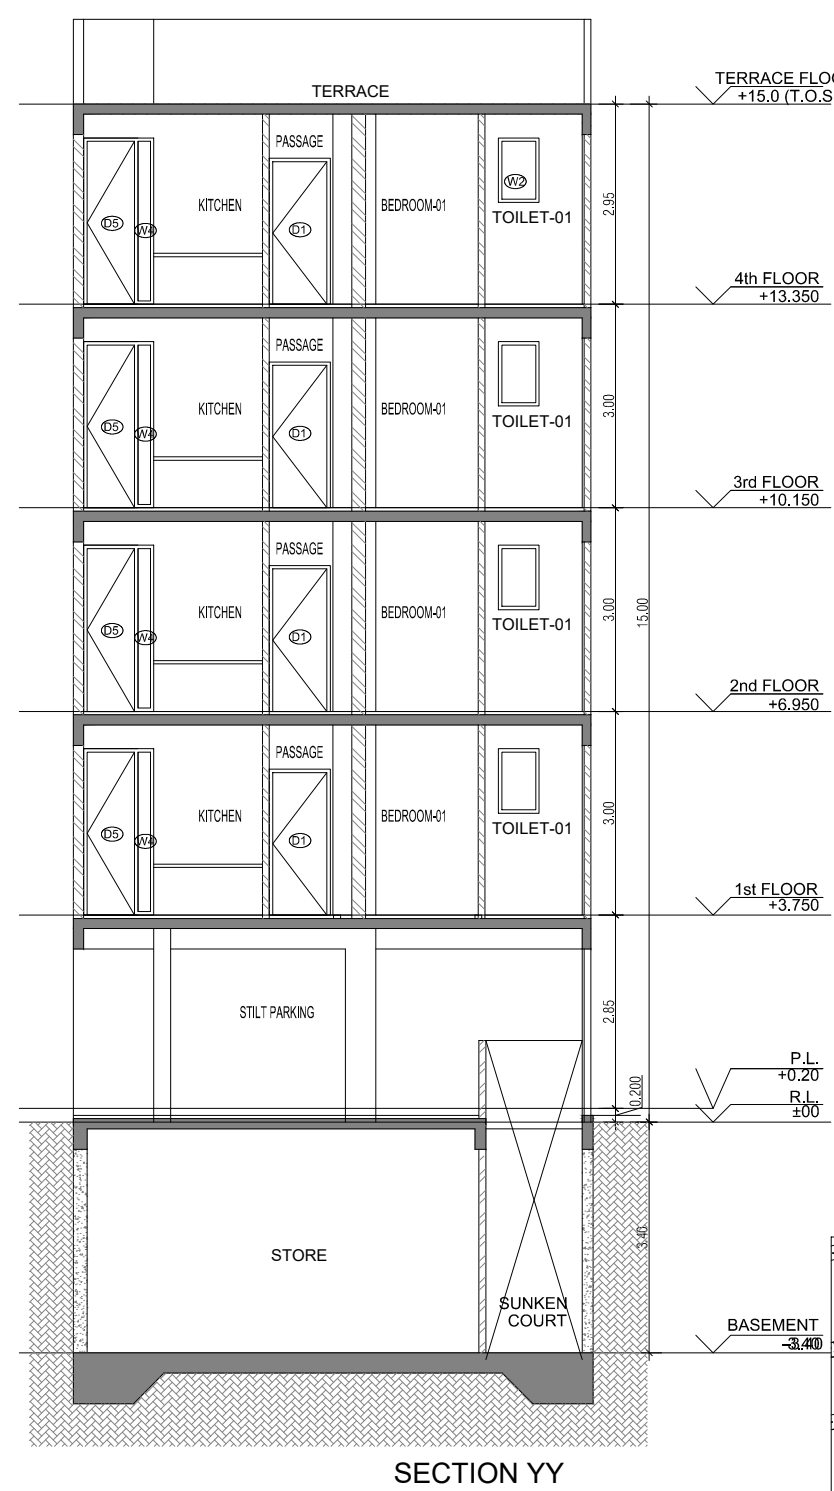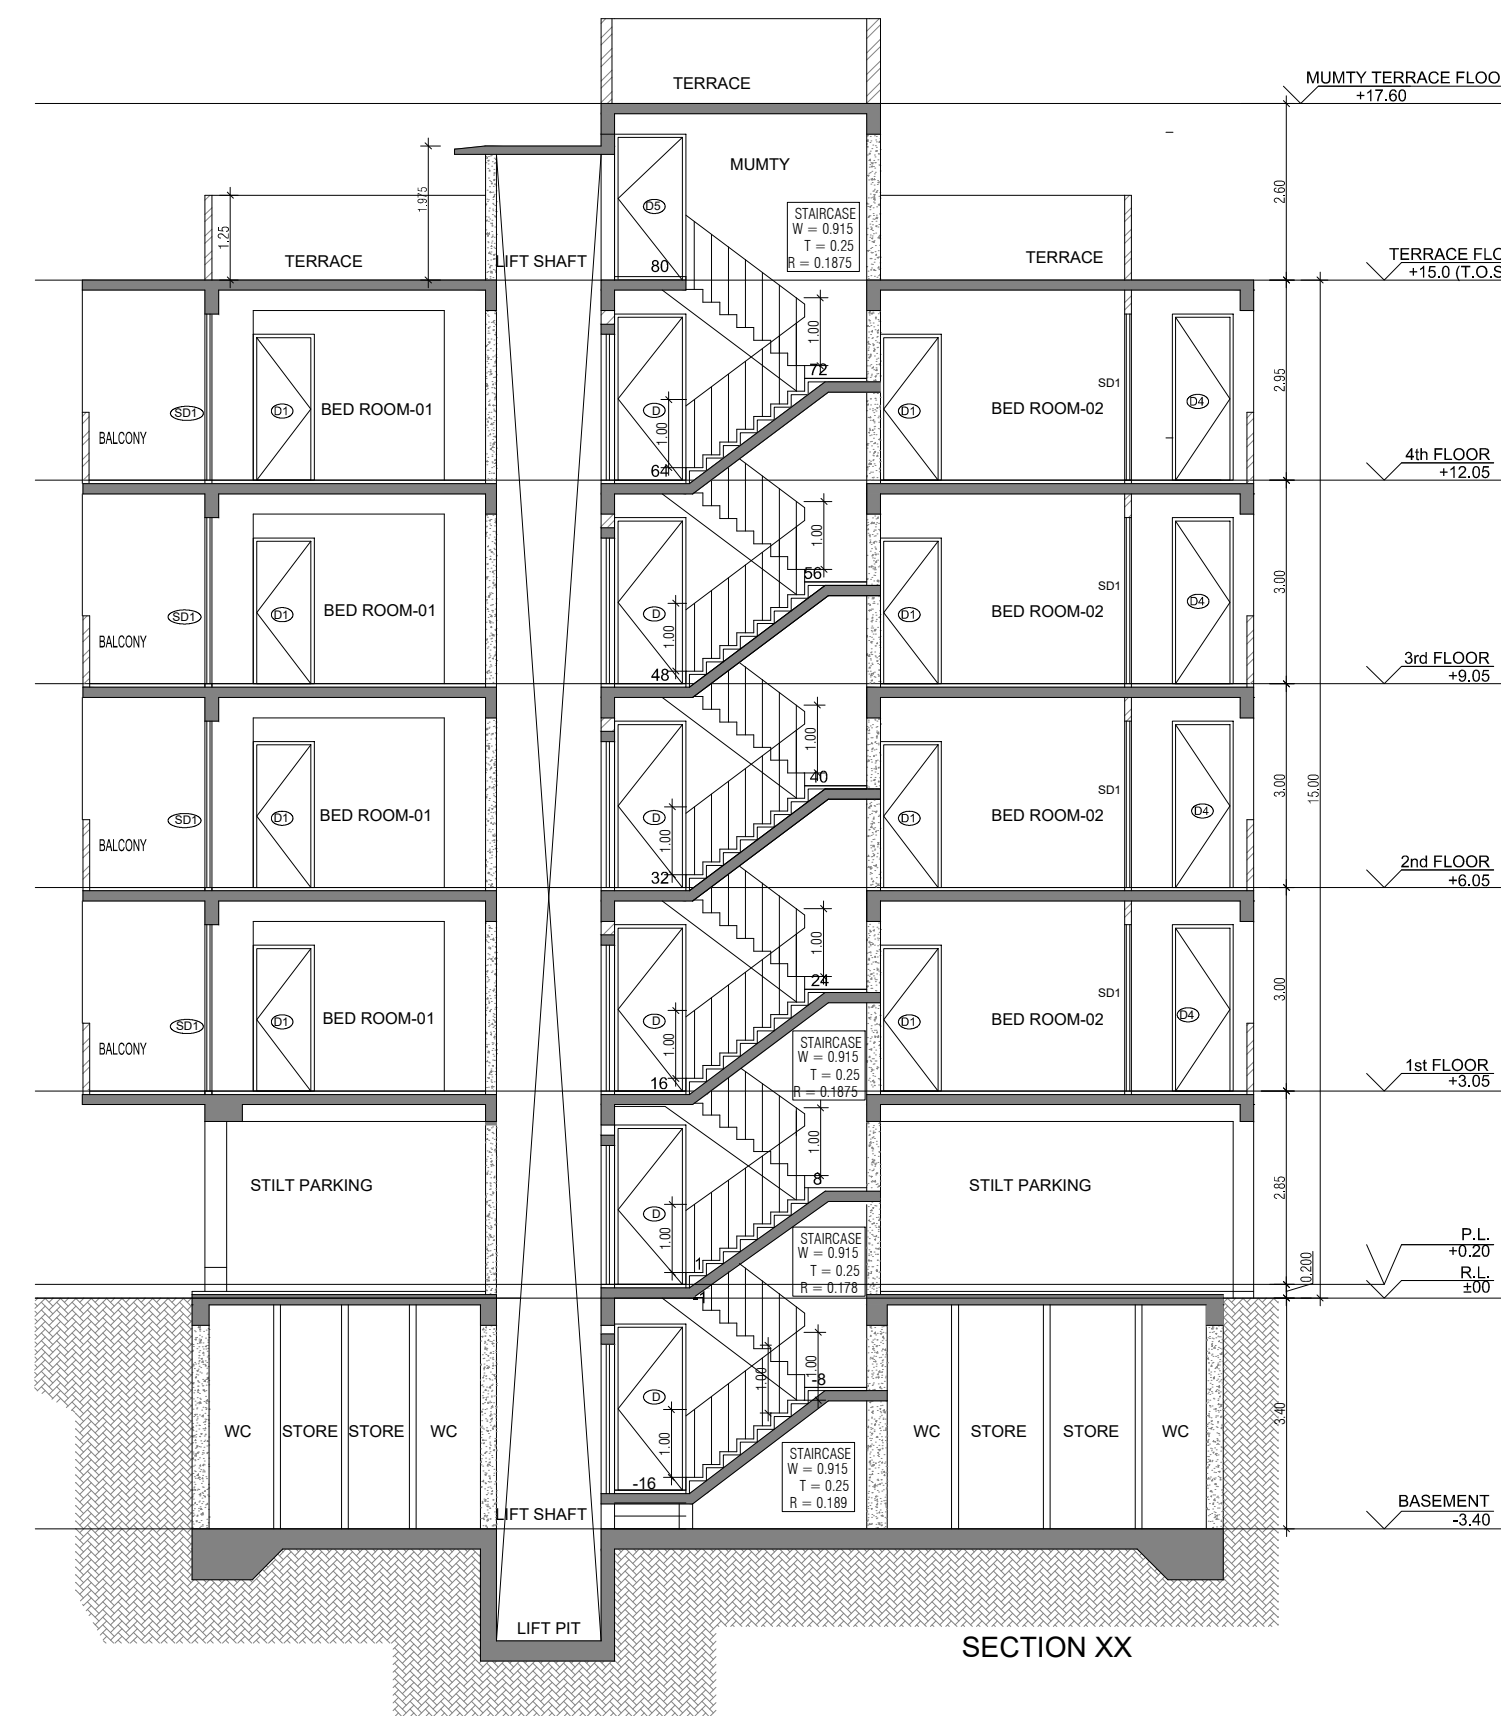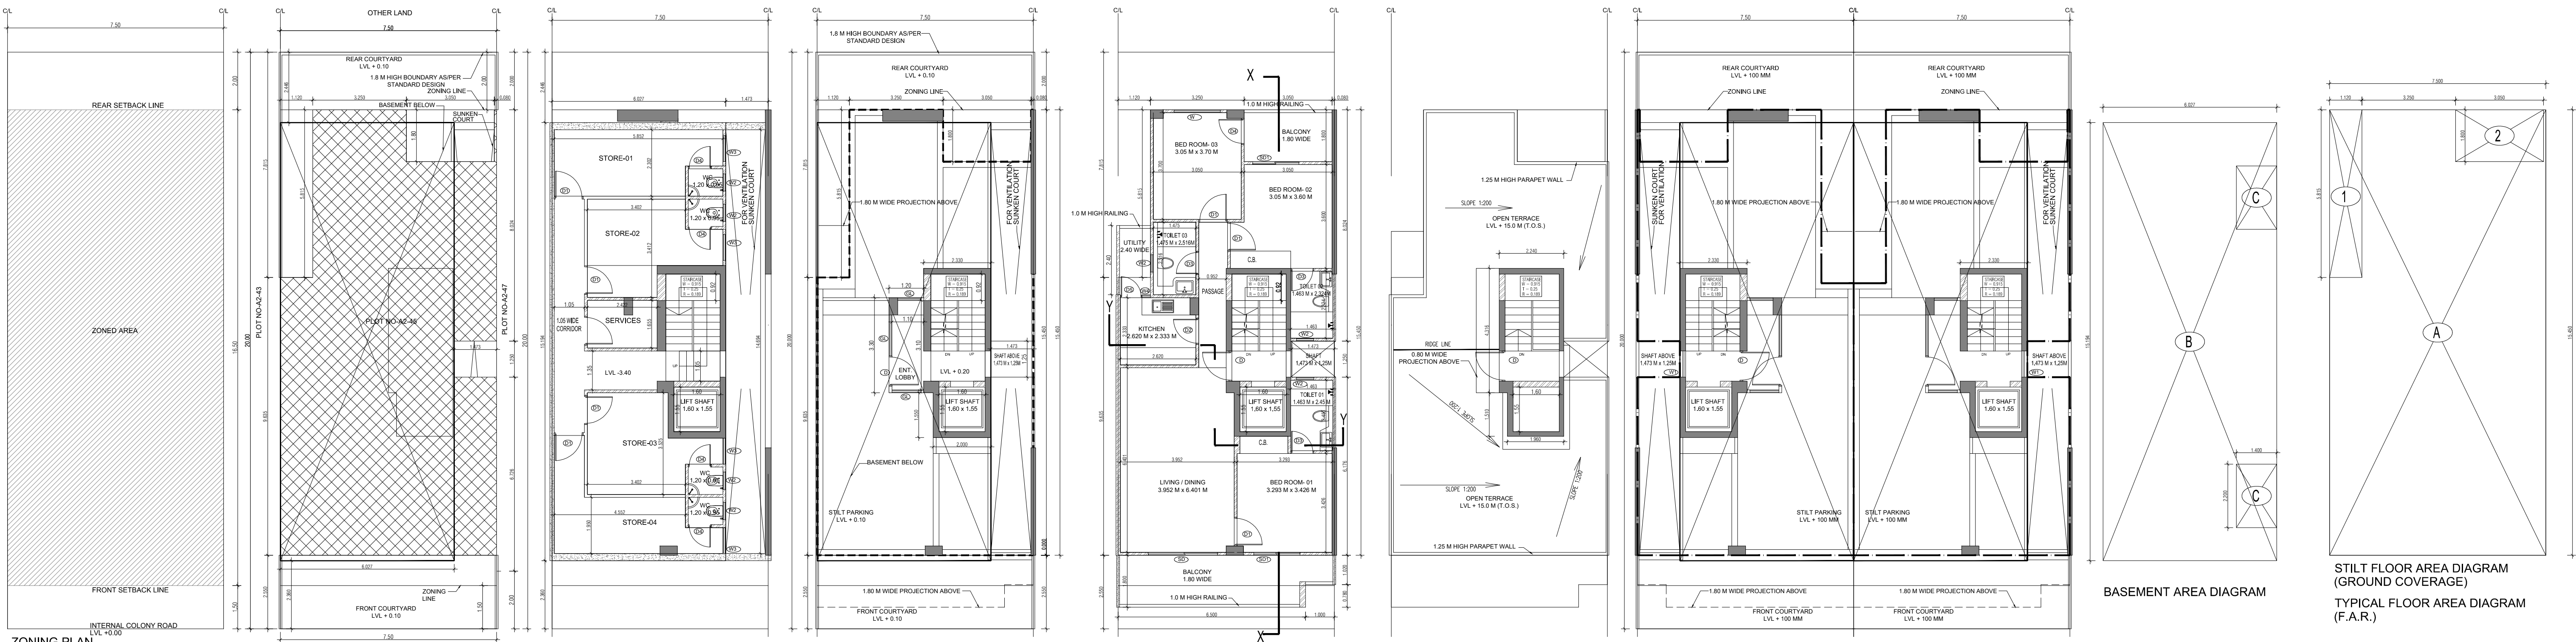

| DOOR WINDOW SCHEDULE |        |            |             |                                            |
|----------------------|--------|------------|-------------|--------------------------------------------|
| SR NO                | LEGEND | WIDTH (MM) | HEIGHT (MM) | CLL LVL (FROM FFL) / UINTEL LVL (FROM FFL) |
| 1                    | D1     | 1.05       | 2.45        | 0                                          |
| 2                    | D1     | 1.0        | 2.15        | 0                                          |
| 3                    | D2     | 0.9        | 2.15        | 0                                          |
| 4                    | D3     | 0.75       | 2.45        | 0                                          |
| 5                    | D4     | 0.9        | 2.15        | 0                                          |
| 6                    | D5     | 0.9        | 2.15        | 0                                          |
| 7                    | D6     | 2.4        | 2.45        | 0                                          |
| 8                    | D7     | 1.6        | 2.45        | 0                                          |
| 9                    | D8     | 1.6        | 2.45        | 0                                          |
| 10                   | D9     | 0.9        | 0.93        | 1.2                                        |
| 11                   | D10    | 0.6        | 0.93        | 1.5                                        |
| 12                   | D11    | 0.9        | 2.45        | 0                                          |
| 13                   | D12    | 0.45       | 2.45        | 0                                          |

| AREA CALCULATION                                                               |                    |              |
|--------------------------------------------------------------------------------|--------------------|--------------|
|                                                                                | AREA               | UNIT         |
| TOTAL PLOT AREA (7.50 M x 20 M)                                                | 150                | Sqmt         |
| PERMISSIBLE FAR AS PER APPROVED ZONING PLAN @ 2.00                             | 300                | Sqmt         |
| PURCHASEABLE FAR @ 0.64                                                        | 96                 | Sqmt         |
| TOTAL PERMISSIBLE FAR @ 2.64                                                   | 396                | Sqmt         |
| PROPOSED FAR @ 2.63                                                            | 395.395            | Sqmt         |
| PERMISSIBLE GROUND COVERAGE @ 75%                                              | 112.50             | Sqmt         |
| PROPOSED GROUND COVERAGE @ 69.24%                                              | 103.872            | Sqmt         |
| AREA OF STILT FLOOR (GROUND COVERAGE)                                          |                    |              |
| A                                                                              | 7.5 x 15.450 x 1   | 115.875 Sqmt |
| TOTAL                                                                          |                    | 115.875 Sqmt |
| DEDUCTION (D)                                                                  |                    |              |
| 1                                                                              | 1.12 x 5.815 x 1   | 6.513 Sqmt   |
| 2                                                                              | 3.05 x 1.800 x 1   | 5.490 Sqmt   |
| TOTAL                                                                          |                    | 12.003 Sqmt  |
| PROPOSED GROUND COVERAGE = A-D                                                 |                    | 103.872 Sqmt |
| AREA CALCULATION FOR TYPICAL FLOOR (1st to 4th FLOOR)                          |                    |              |
| TOTAL AREA ON GROUND COVERAGE (X)                                              |                    |              |
| DEDUCTION                                                                      |                    |              |
| 1 (STAIRCASE)                                                                  | 1.880 x 3.715 x 1  | 6.984 Sqmt   |
| 2                                                                              | 1.600 x 1.550 x 1  | 2.480 Sqmt   |
| 3                                                                              | 1.473 x 1.250 x 1  | 1.841 Sqmt   |
| TOTAL (Y)                                                                      |                    | 11.305 Sqmt  |
| TOTAL AREA OF TYPICAL FLOOR (X-Y)                                              |                    | 92.567 Sqmt  |
| BASEMENT BUILT UP AREA                                                         |                    |              |
| B                                                                              | 6.027 x 15.194 x 1 | 91.574 Sqmt  |
| TOTAL                                                                          |                    | 91.574 Sqmt  |
| BASEMENT F.A.R. AREA                                                           |                    |              |
| C                                                                              | 1.400 x 2.200 x 2  | 6.160 Sqmt   |
| TOTAL                                                                          |                    | 6.160 Sqmt   |
| NET NON F.A.R. AREA OF BASEMENT                                                |                    |              |
| B-C                                                                            |                    | 85.414 Sqmt  |
| TOTAL                                                                          |                    | 85.414 Sqmt  |
| STILT FAR                                                                      |                    |              |
| E                                                                              | 2.333 x 4.315 x 1  | 10.067 Sqmt  |
| F                                                                              | 2.000 x 1.550 x 1  | 3.100 Sqmt   |
| G                                                                              | 1.473 x 1.250 x 1  | 1.841 Sqmt   |
| J                                                                              | 1.2 x 3.300 x 1    | 3.960 Sqmt   |
| TOTAL                                                                          |                    | 18.968 Sqmt  |
| MUMTY AREA                                                                     |                    |              |
| H                                                                              | 1.960 x 1.51 x 1   | 2.960 Sqmt   |
| I                                                                              | 2.24 x 4.32 x 1    | 9.660 Sqmt   |
| TOTAL                                                                          |                    | 12.627 Sqmt  |
| PROJECTION AREA                                                                |                    |              |
| 6.500 x 1.800 x 1                                                              |                    | 11.700 Sqmt  |
| 1.000 x 1.020 x 1                                                              |                    | 1.020 Sqmt   |
| 1.120 x 1.800 x 1                                                              |                    | 2.016 Sqmt   |
| 3.050 x 1.800 x 1                                                              |                    | 5.490 Sqmt   |
| TOTAL                                                                          |                    | 20.226 Sqmt  |
| GROUND COVERAGE CALCULATION                                                    |                    |              |
| STILT FLOOR AREA, STAIRCASE, LIFT SHAFT INCLUDED                               | 103.872            | Sqmt         |
| TOTAL GROUND COVERAGE ACHIEVED                                                 | 103.872            | Sqmt         |
| FAR CALCULATION                                                                |                    |              |
| TYPICAL FLOOR AREA x 4                                                         | 370.267            | Sqmt         |
| FAR AREA IN BASEMENT                                                           | 6.160              | Sqmt         |
| FAR AREA ON STILT                                                              | 18.968             | Sqmt         |
| TOTAL FAR ACHIEVED                                                             | 395.395            | Sqmt         |
| BUILT UP AREA CALCULATION                                                      |                    |              |
| BASEMENT AREA (FAR-NON FAR) + COVERAGE                                         | 697.102            | Sqmt         |
| AT STILT AREA + FLOOR AREA + STAIR CASE x 4 + MUMTY AREA + PROJECTION AREA x 4 |                    |              |

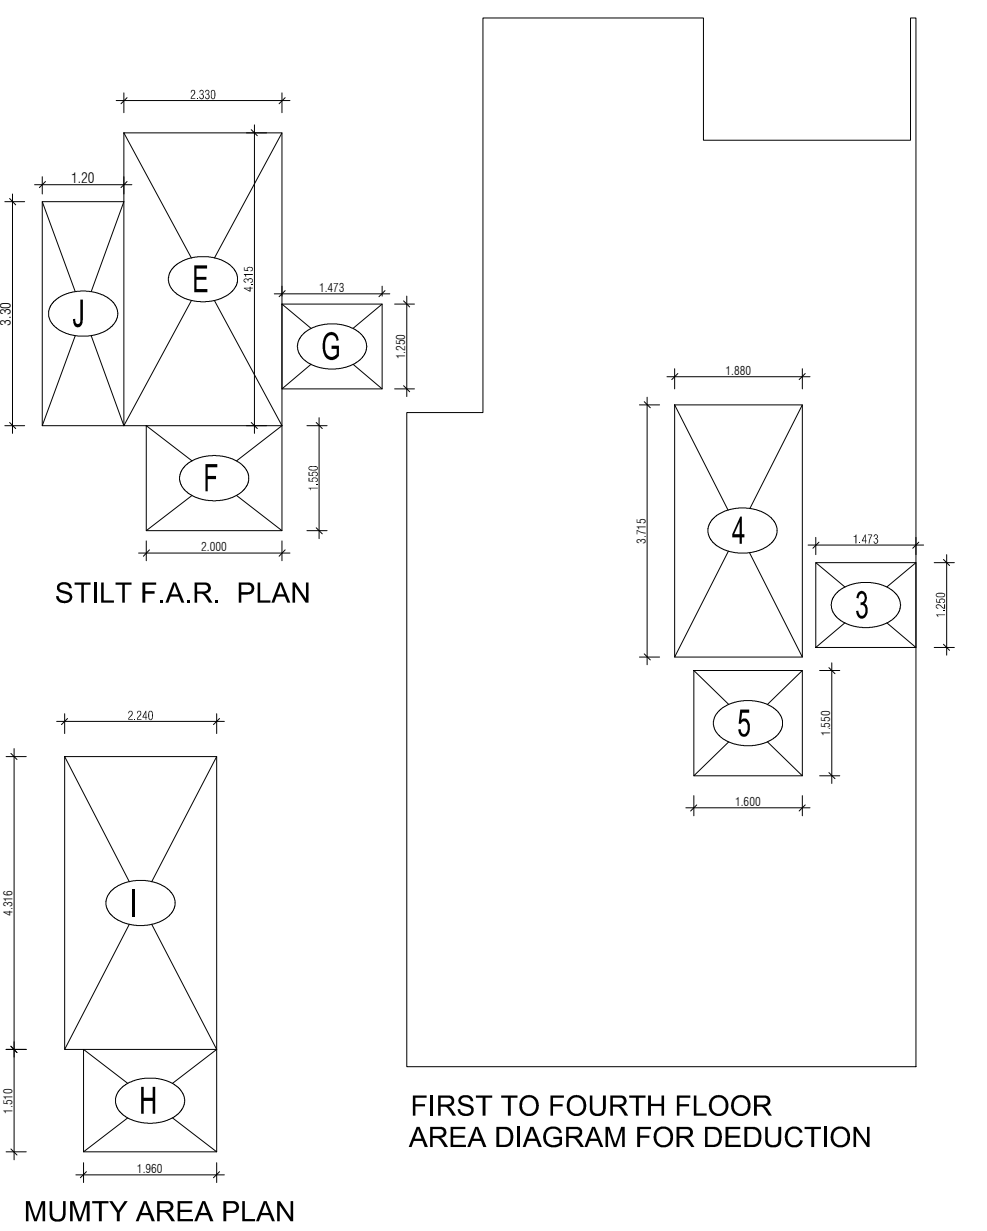

PROJECT - PROPOSED INDEPENDENT RESIDENTIAL FLOORS ON PLOT NO A2 - 45 (STREET A2 - 10 M WIDE) IN AFFORDABLE RESIDENTIAL PLOTTED COLONY UNDER DEEN DAYAL JAN AWAS YOJNA-2016 OVER AN AREA MEASURING 26.91875 (LICESNE NO 94 OF 2021 DT 12.11.2021) IN VILLAGE HAYATPUR, SECTOR 93, GURUGRAM, BEING DEVELOPED BY SAGARDUTT BUILDERS & DEVELOPERS PVT LTD & OTHERS IN COLLABORATION WITH DLF LIMITED.

OWNERS - DLF LIMITED

ARCHITECTS - Arcop Associates Private Limited Plot- 36b, Sec-32, Gurgaon-122001 Ph.: 26242050, 26242169

DRAWING TITLE - TYPE A ( 7.5 M x 20 M ) FLOORS PLANS WITH AREA CALCULATIONS , ELEVATION & SECTIONS

DRAWING NUMBER - ARCHITECT SIGN - AUTHORISED SIGN

SCALE = 1:50

DATE - DRAWN BY - CHECKED BY - DRAWING NUMBER -