




10

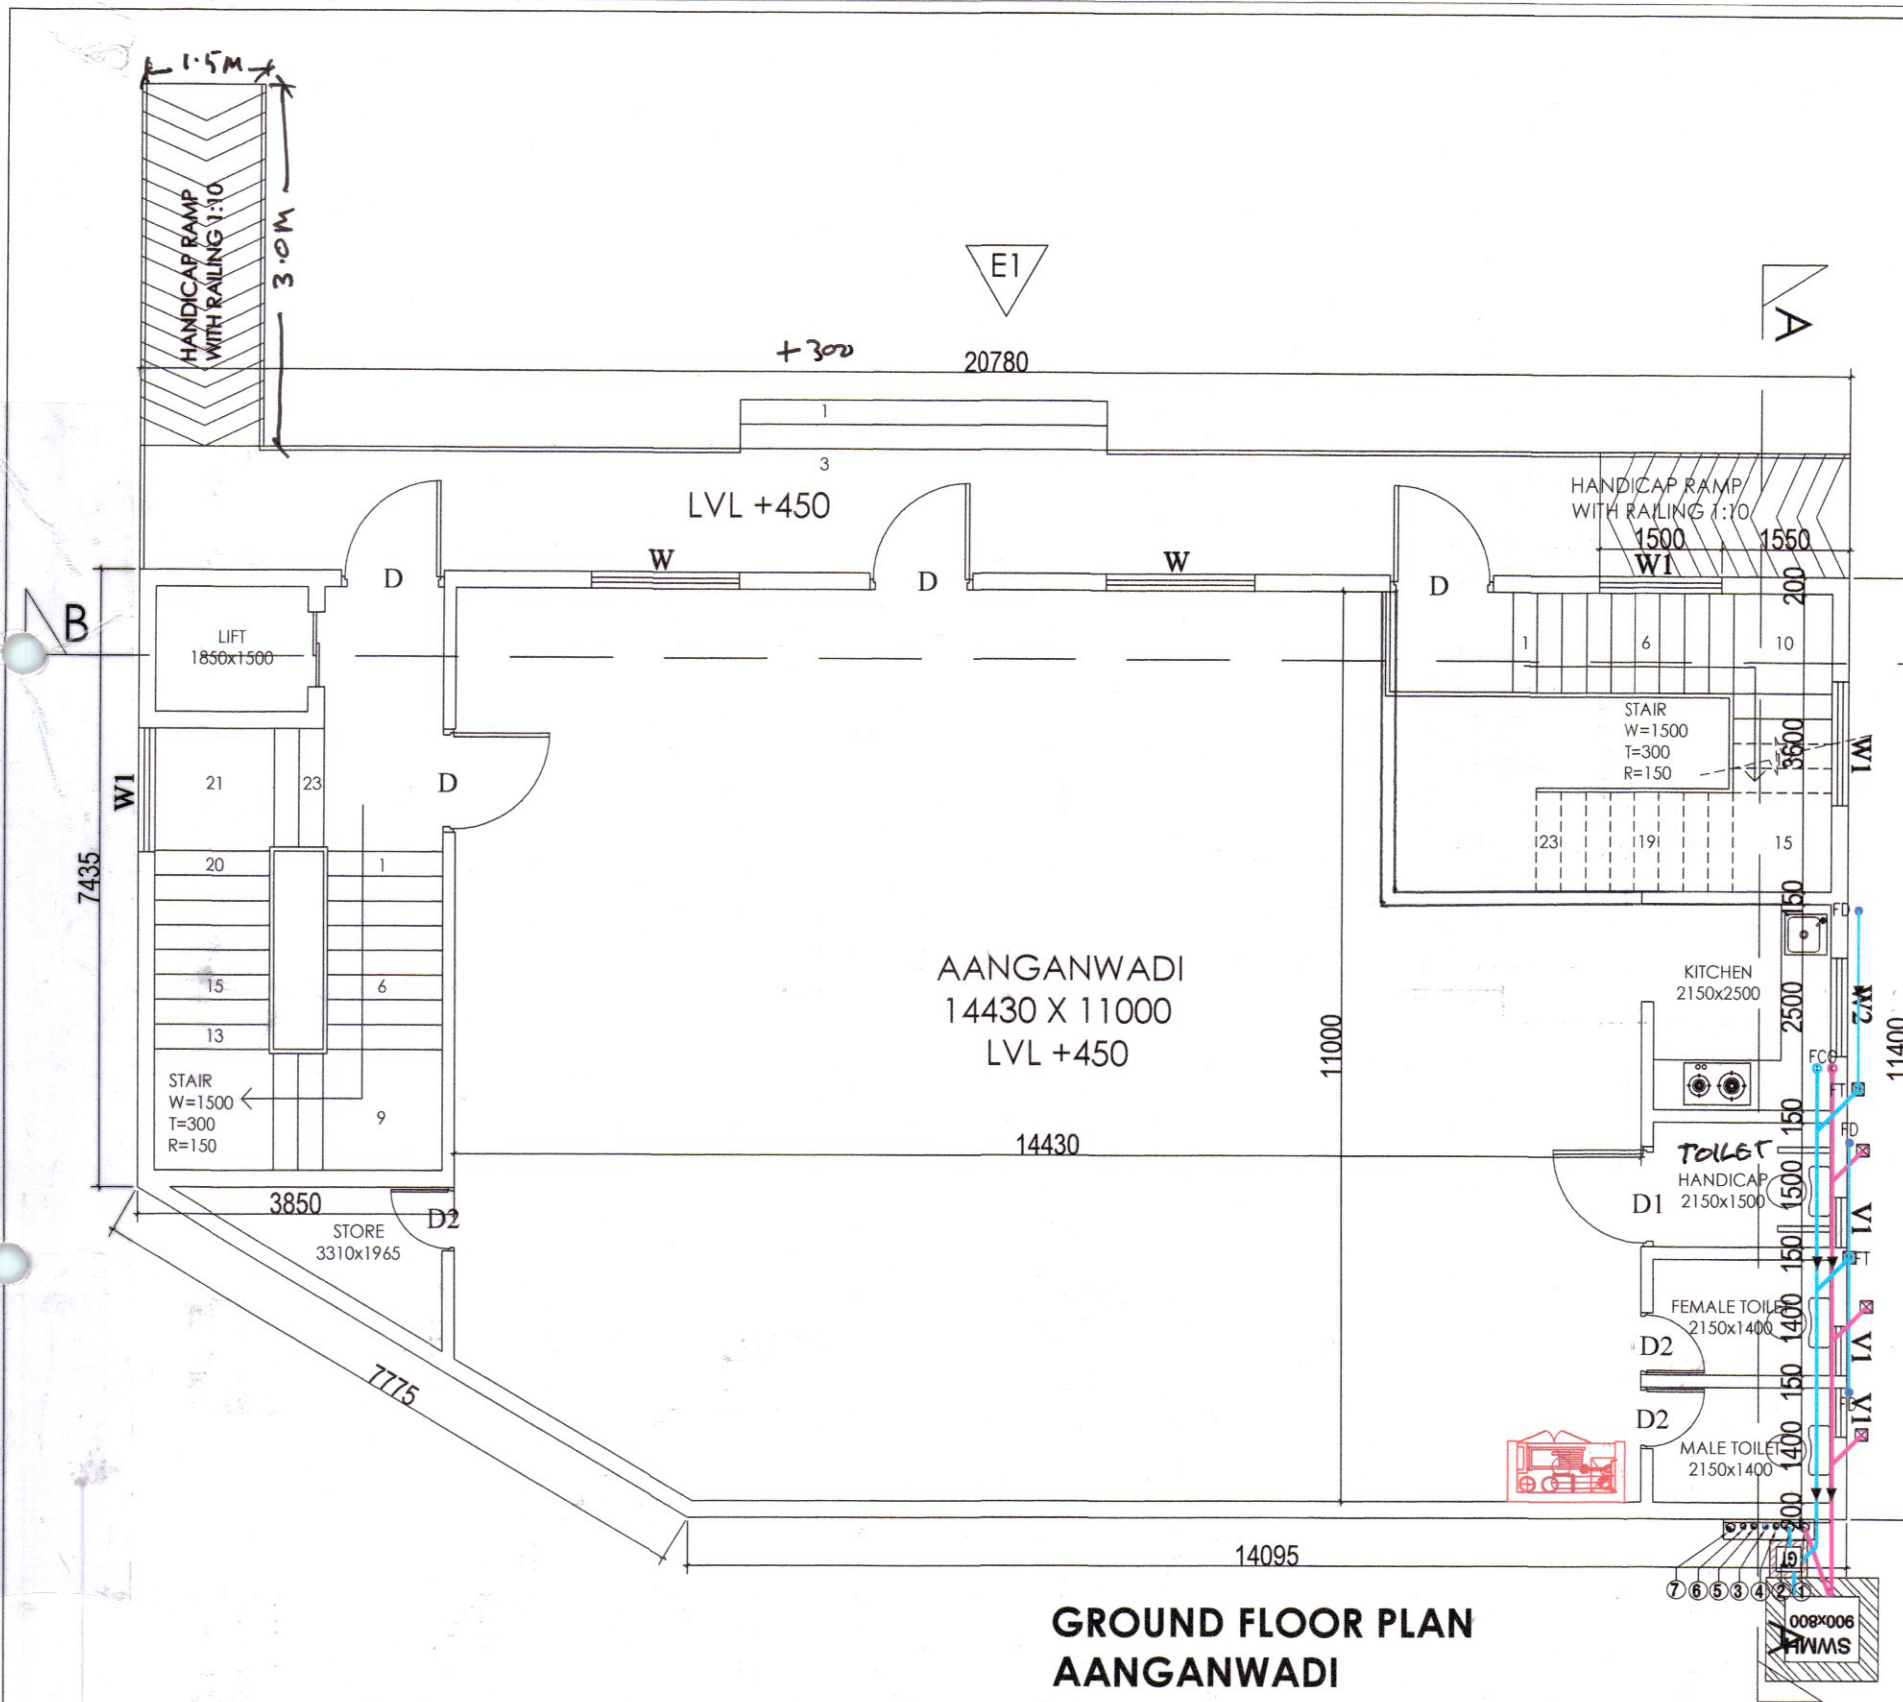


GROUND FLOOR PLAN
AANGANWADI

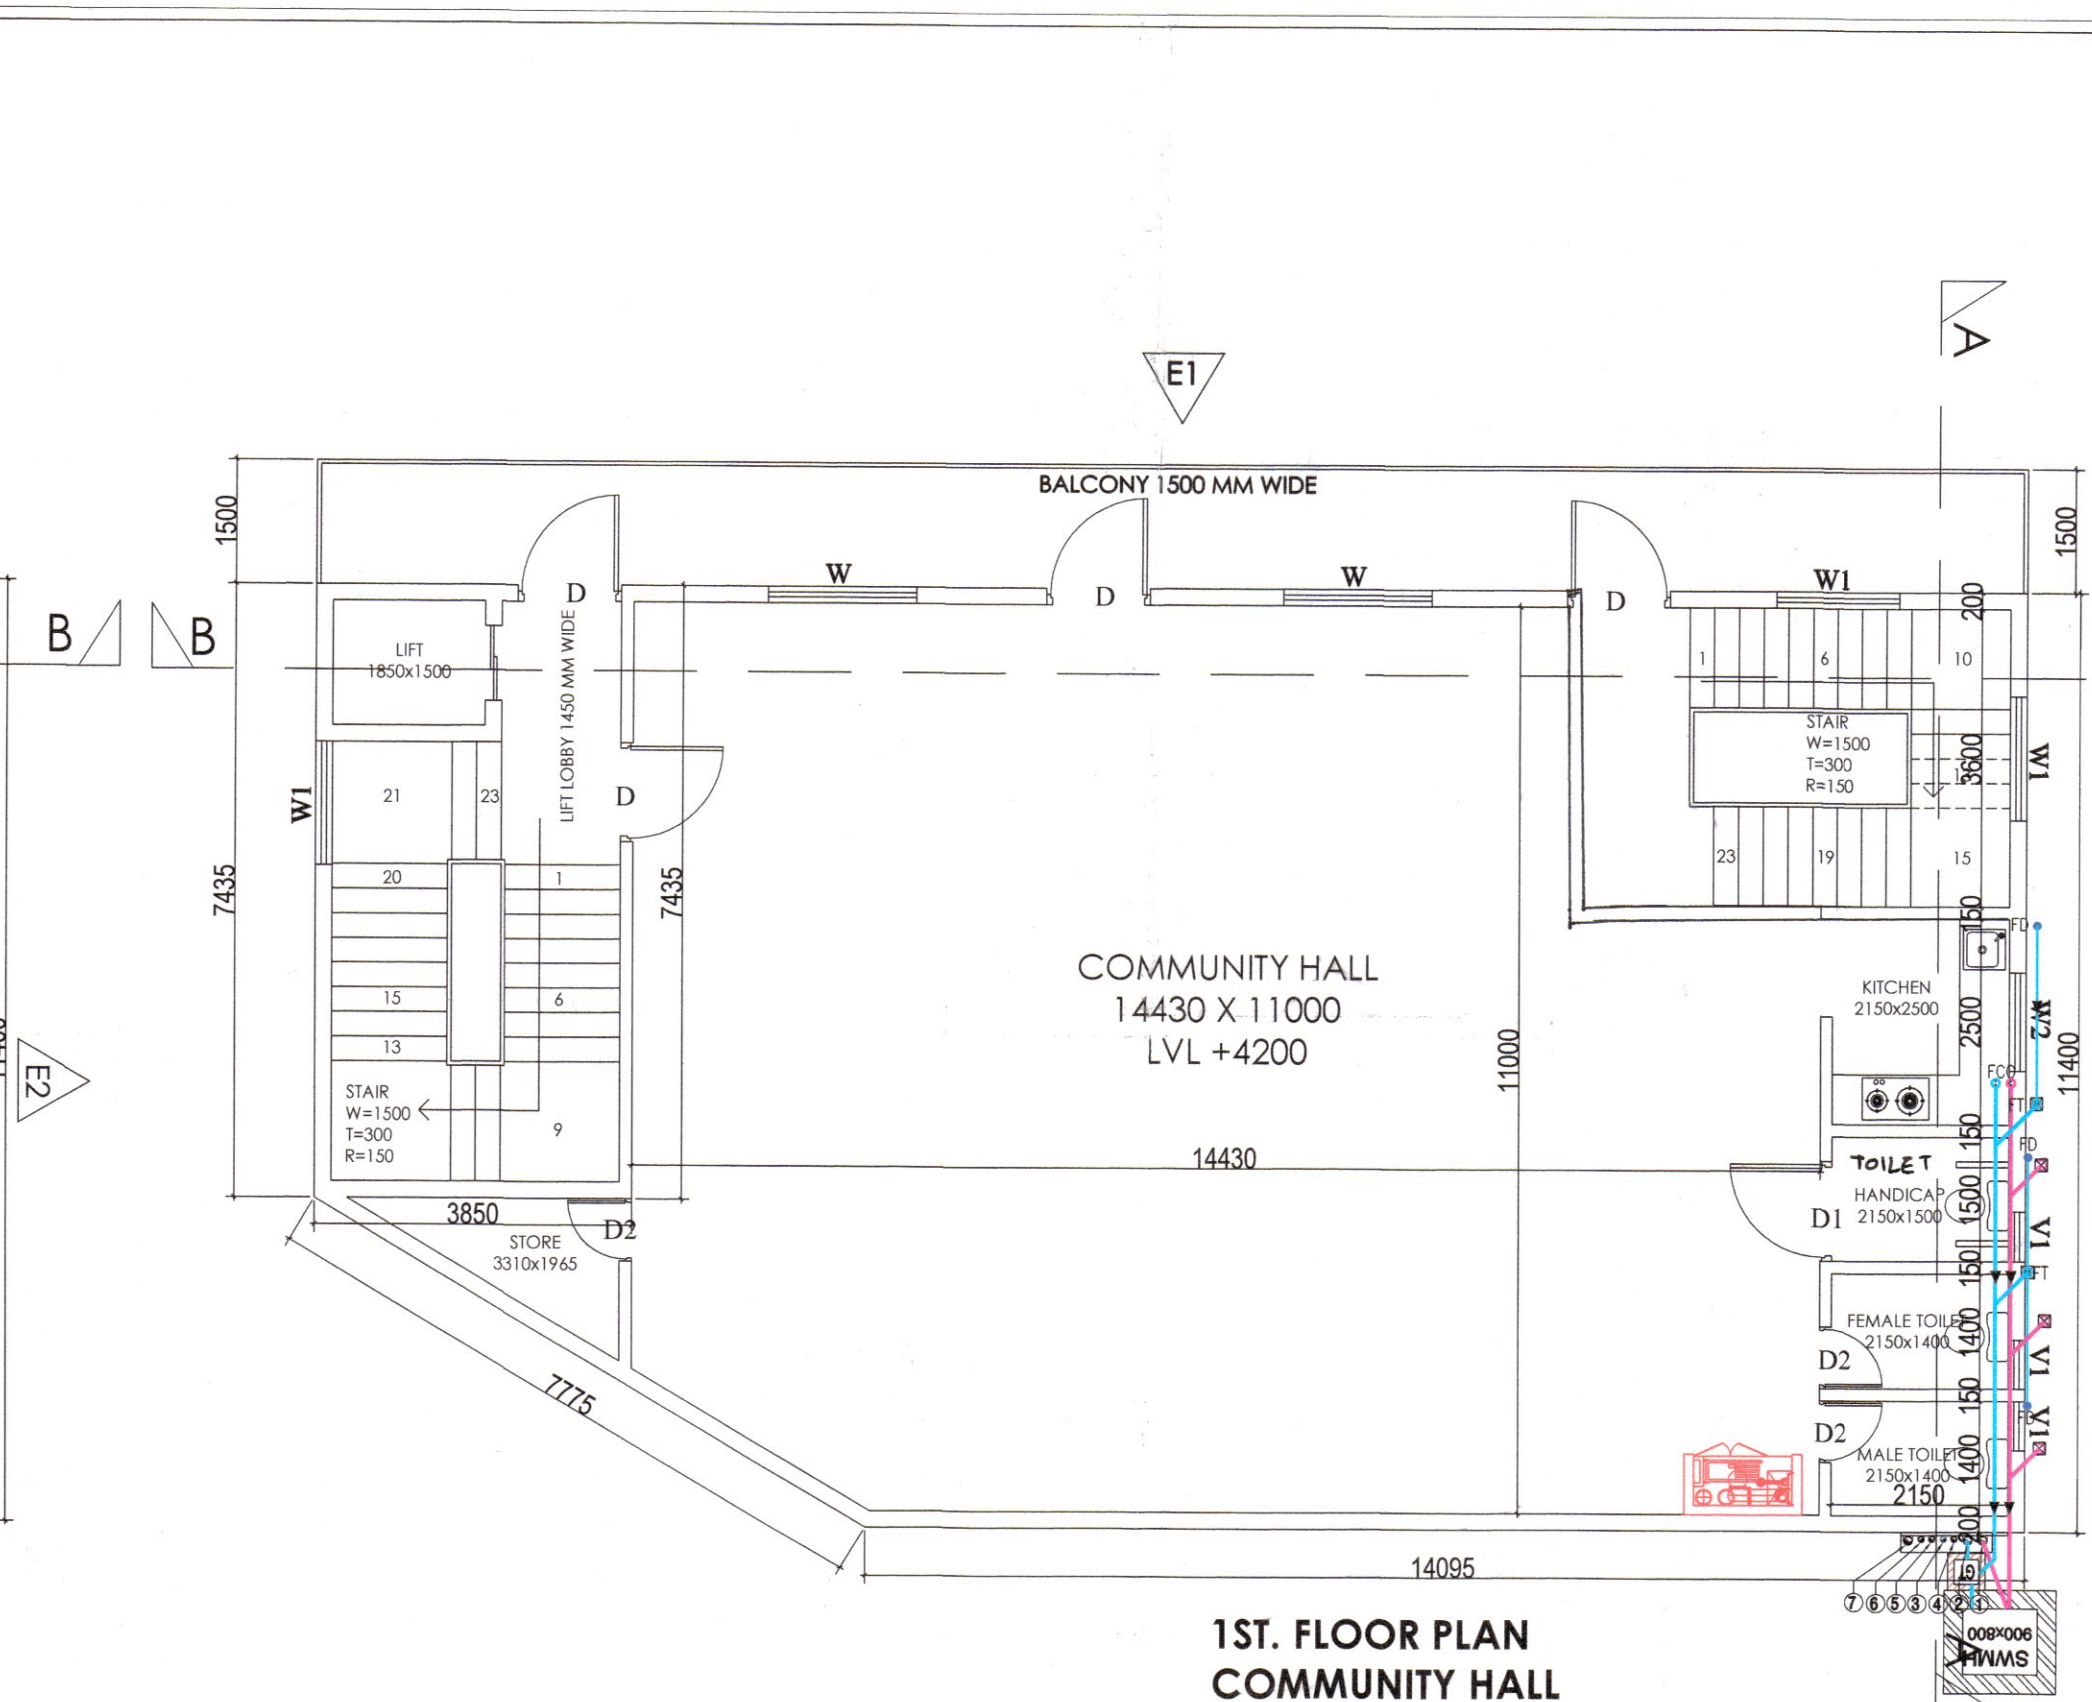

1ST. FLOOR PLAN
COMMUNITY HALL

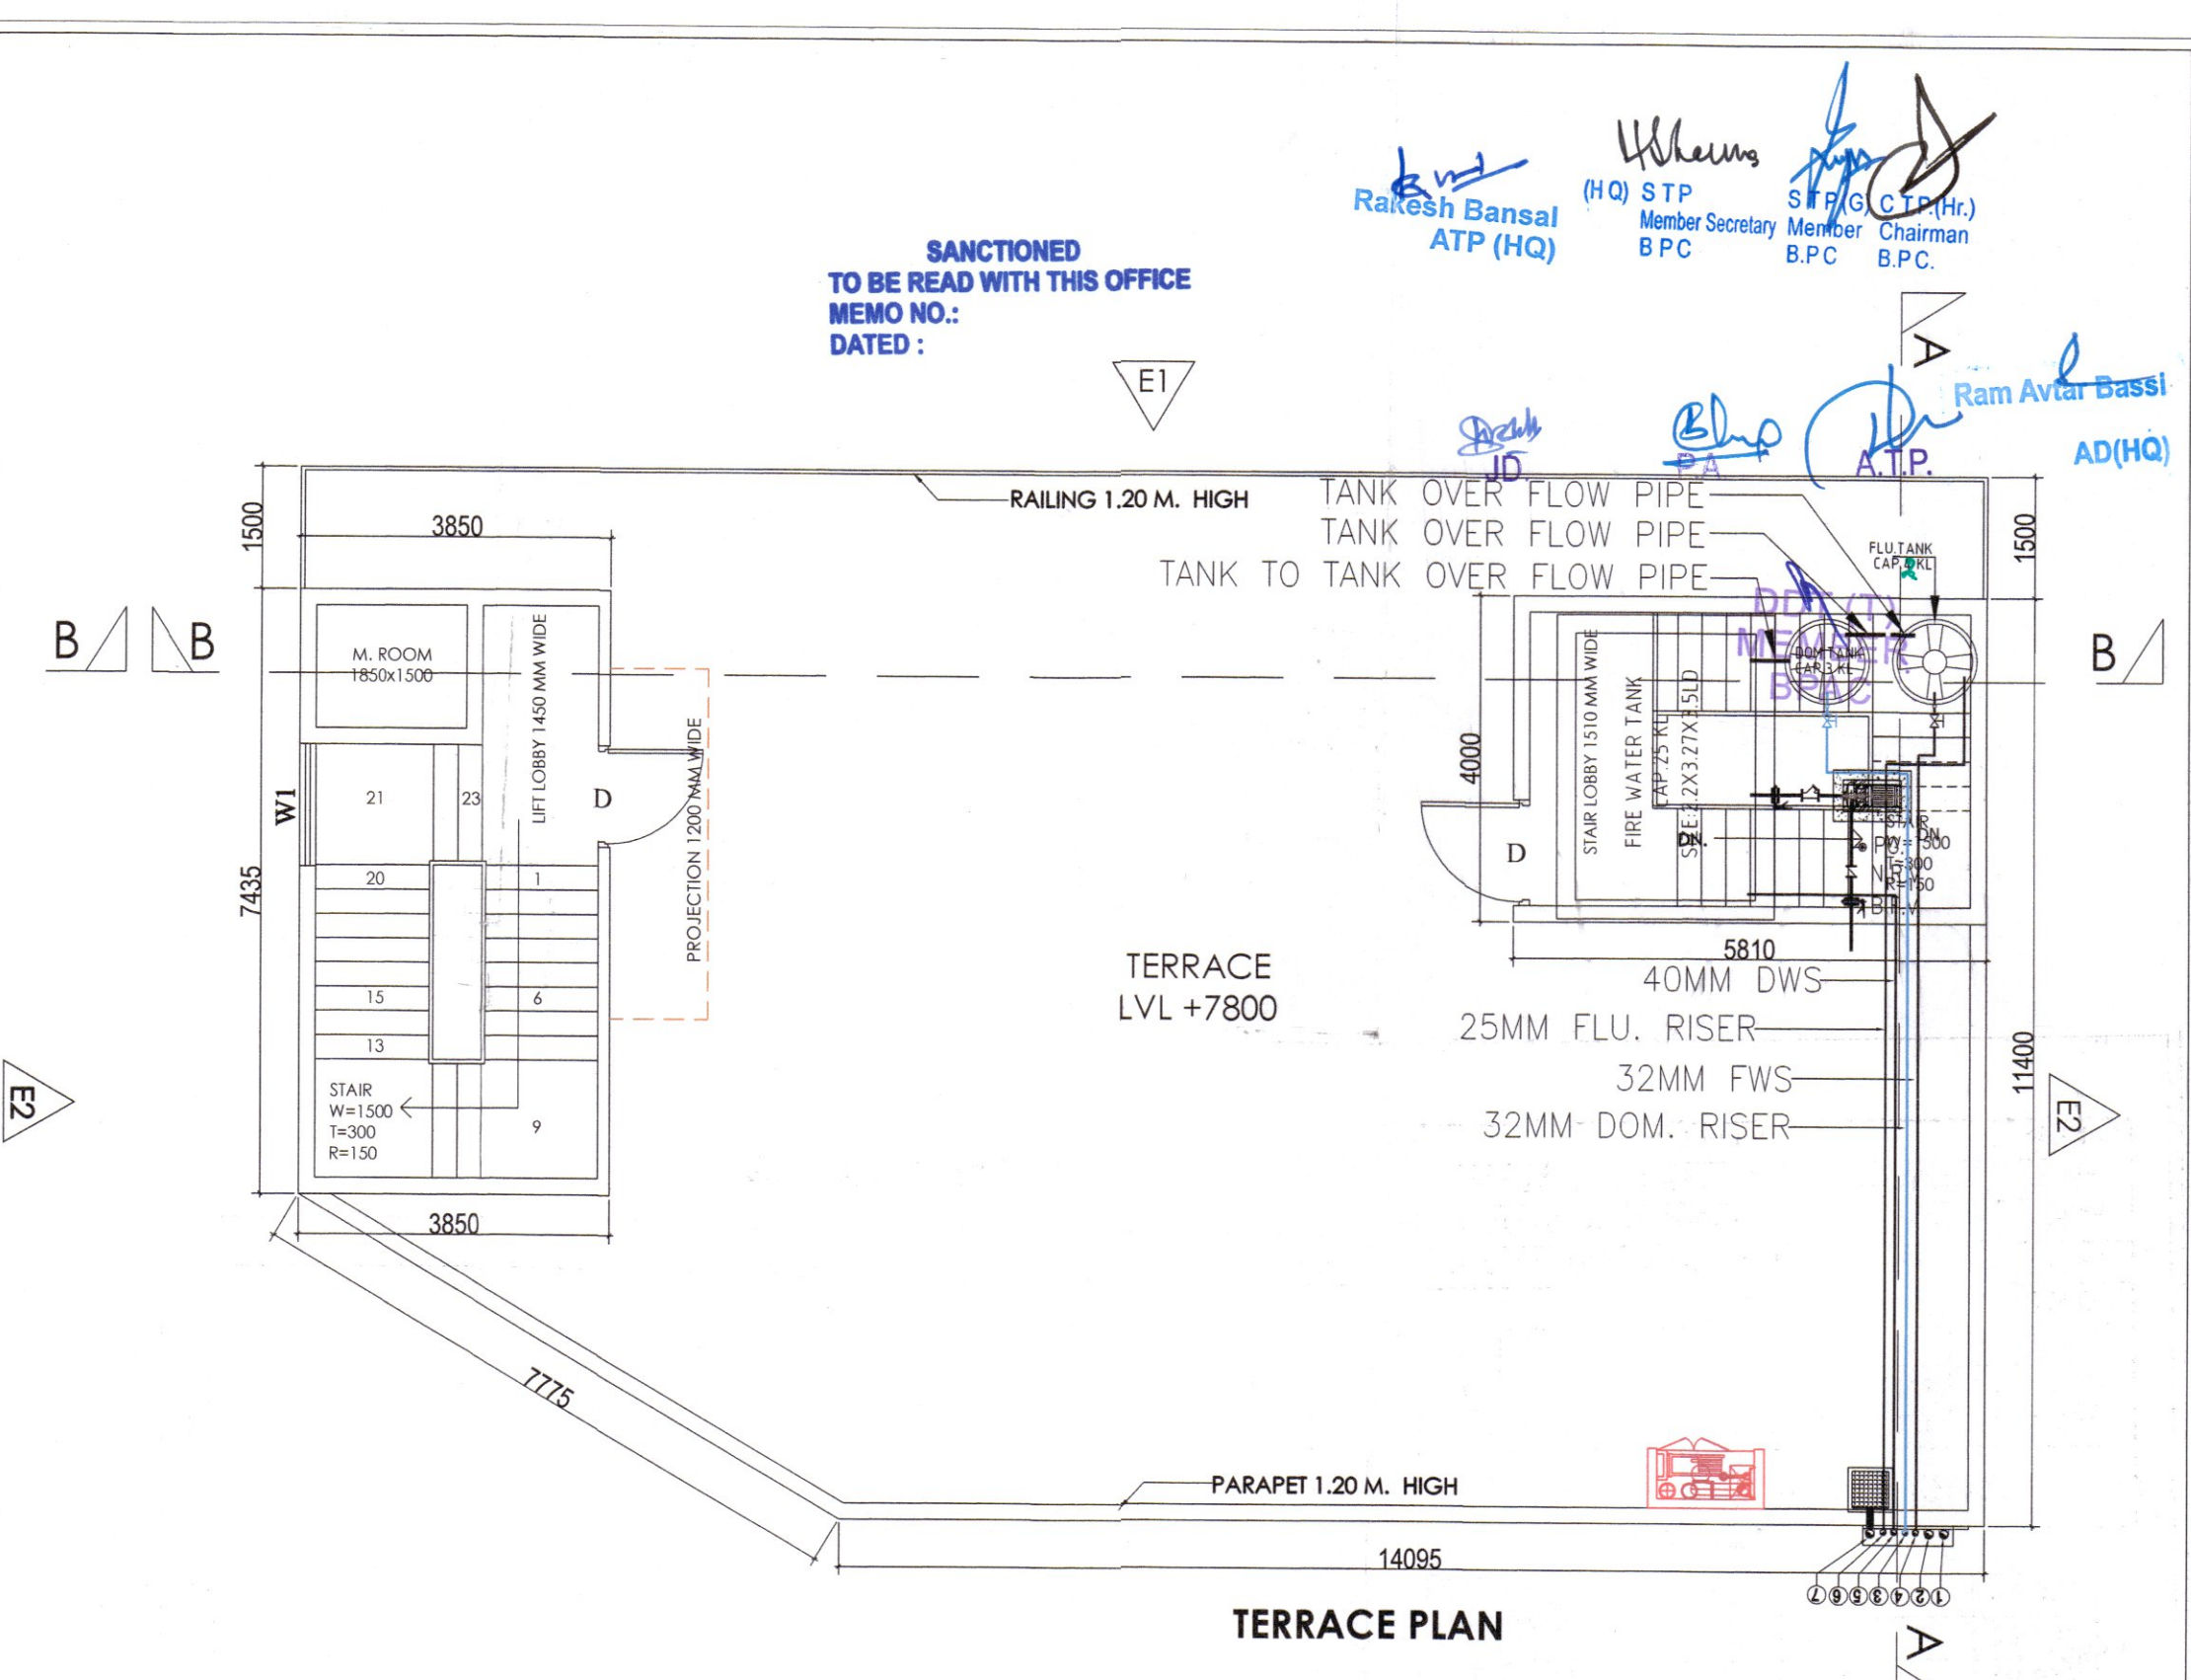


TERRACE PLAN

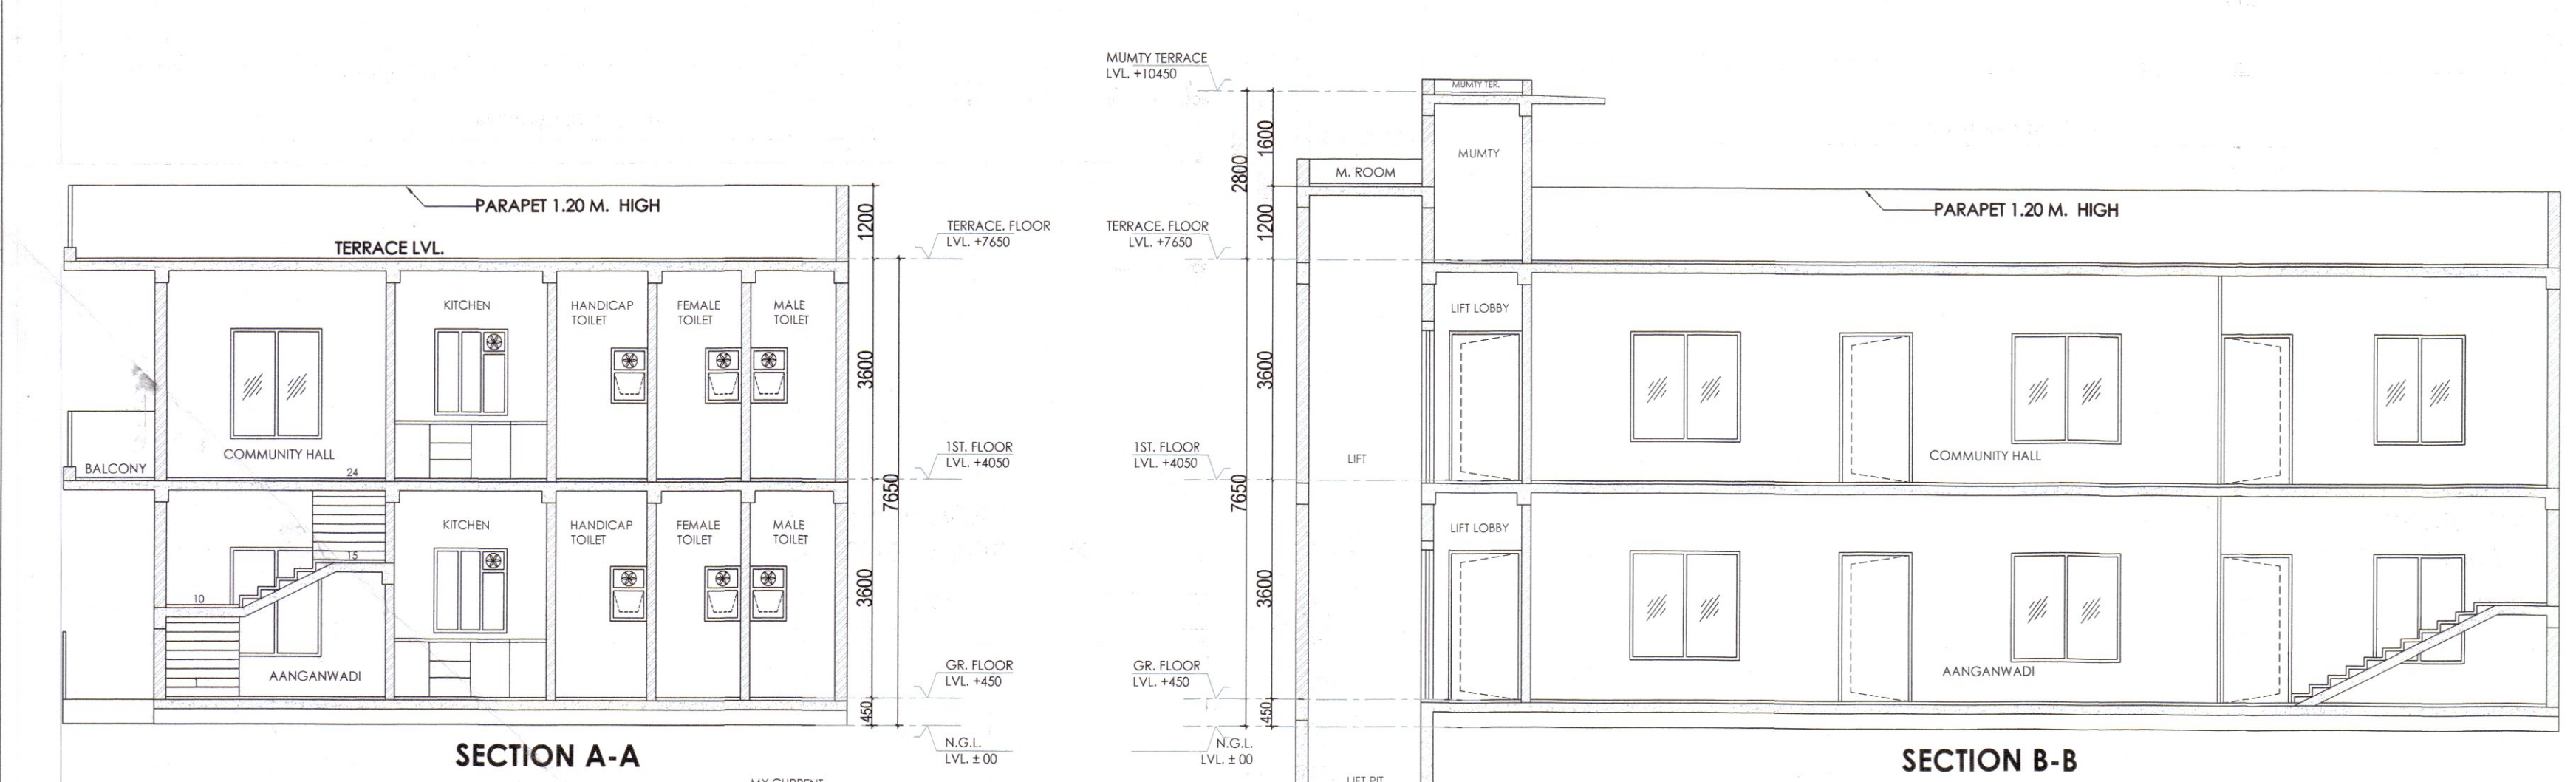

SECTION A-A

SECTION B-B

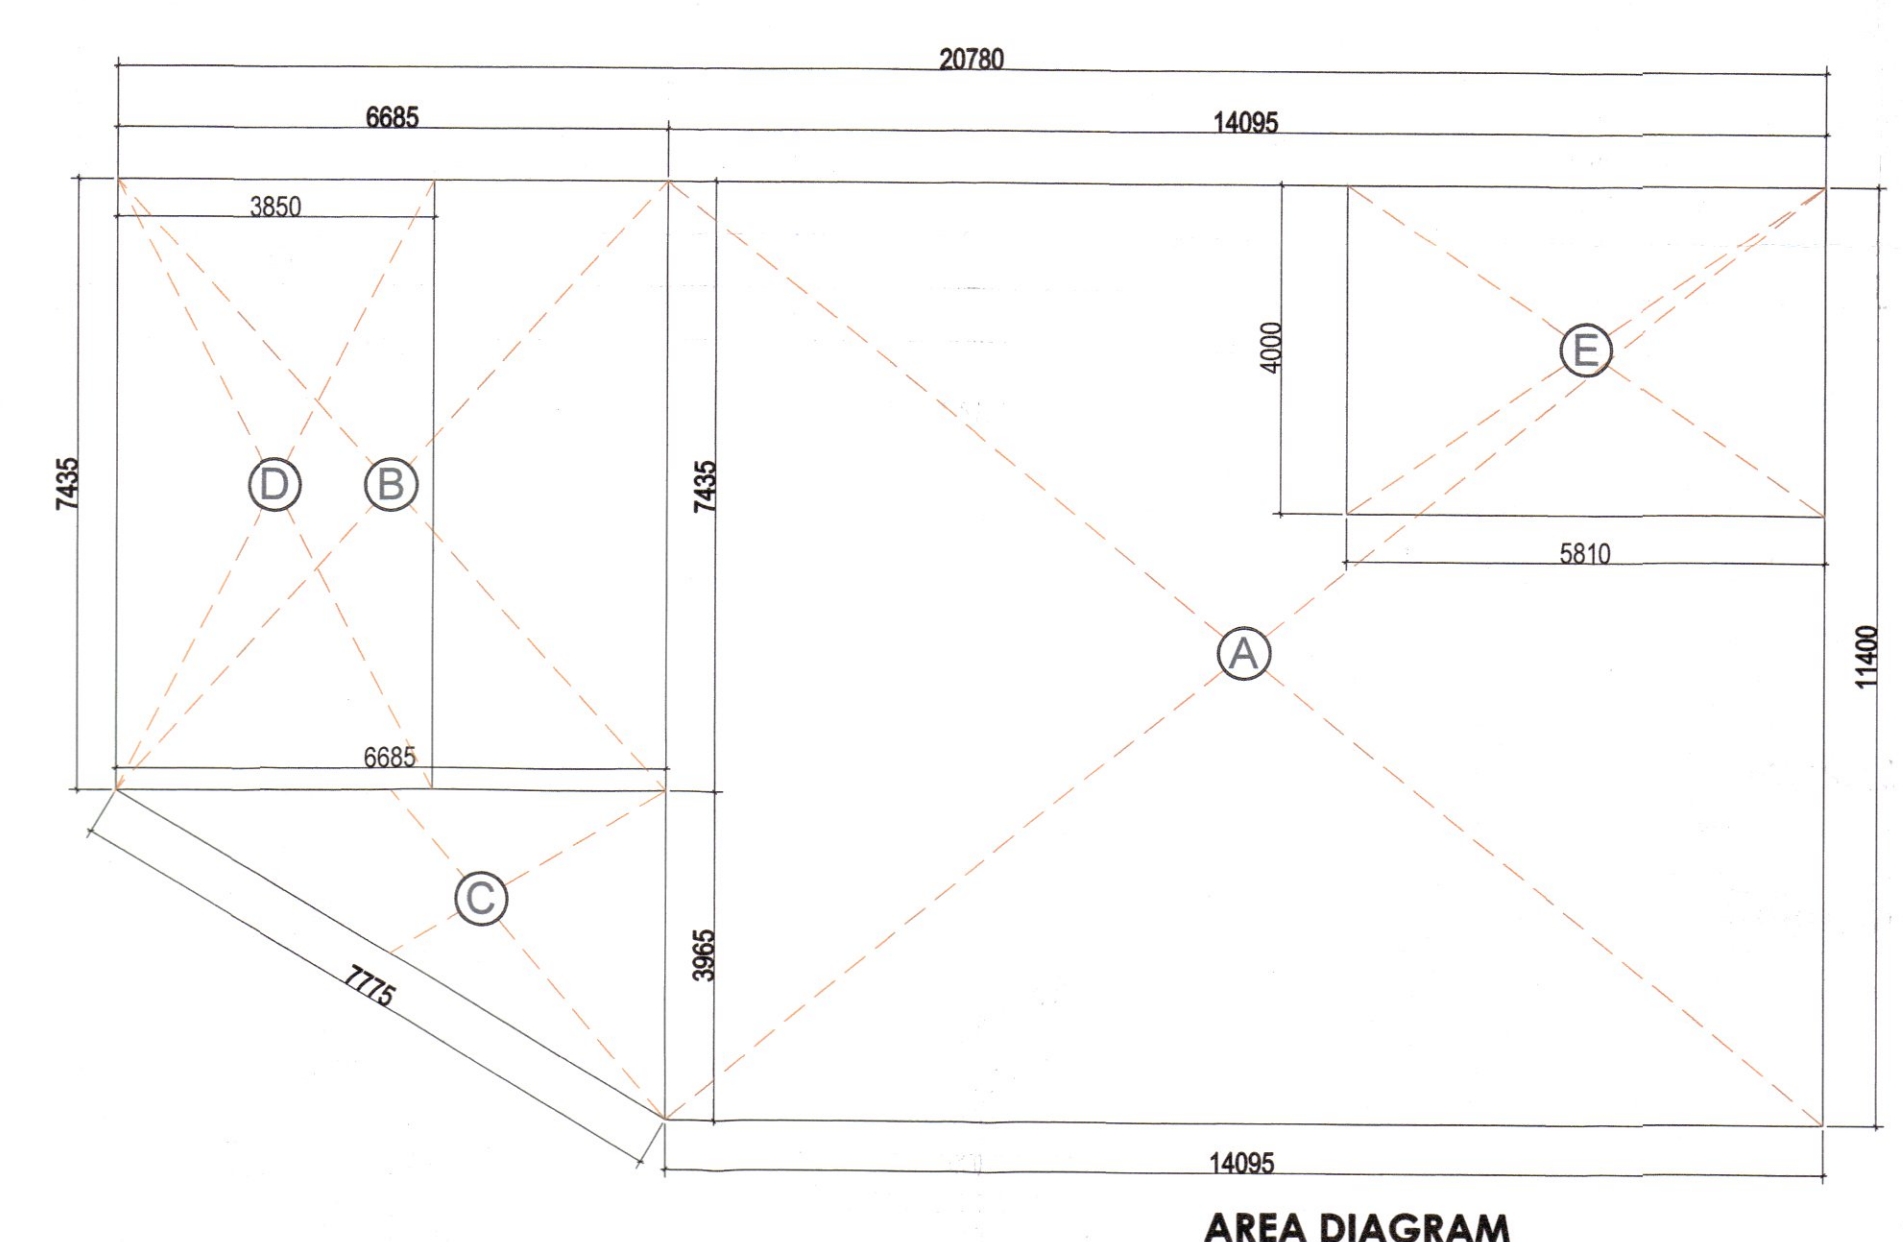


AREA DIAGRAM

TYPICAL FLOOR AREA CHART										STAIR AREA	NET BUILTUP AREA	
A	1	X	14.095	X	11.400	1.0	=	160.68				
B	1	X	6.685	X	7.435	1.0	=	49.703				
C	1	X	6.685	X	3.965	0.5	=	13.253				
GROSS PLATE AREA										223.64		
GROUND FLOOR AANGANWADI NON FAR										223.64	51.865	171.77
FIRST FLOOR COMMUNITY NON FAR AREA										223.64	51.865	171.77
NET AREA										447.28		

STAIRCASE AND LIFT AREA					TOTAL
D	3.850	X	7.435	=	28.625
E	5.810	X	4.000	=	23.240
TOTAL					51.865

MUMTY & MACHINE ROOM NON FAR AREA					TOTAL
D	3.850	X	7.435	=	28.625
E	5.810	X	4.000	=	23.240
TOTAL					51.865

TOTAL BUILTUP AREA CHART							
A	1	X	14.095	X	11.400	1.0	= 160.68
B	1	X	6.685	X	7.435	1.0	= 49.703
C	1	X	6.685	X	3.965	0.5	= 13.253
GROSS PLATE AREA							223.64
GROUND FLOOR AANGANWADI NON FAR							223.64
FIRST FLOOR COMMUNITY NON FAR AREA							223.64
MUMTY MACHINE ROOM NON FAR AREA							51.87
NET AREA							499.14

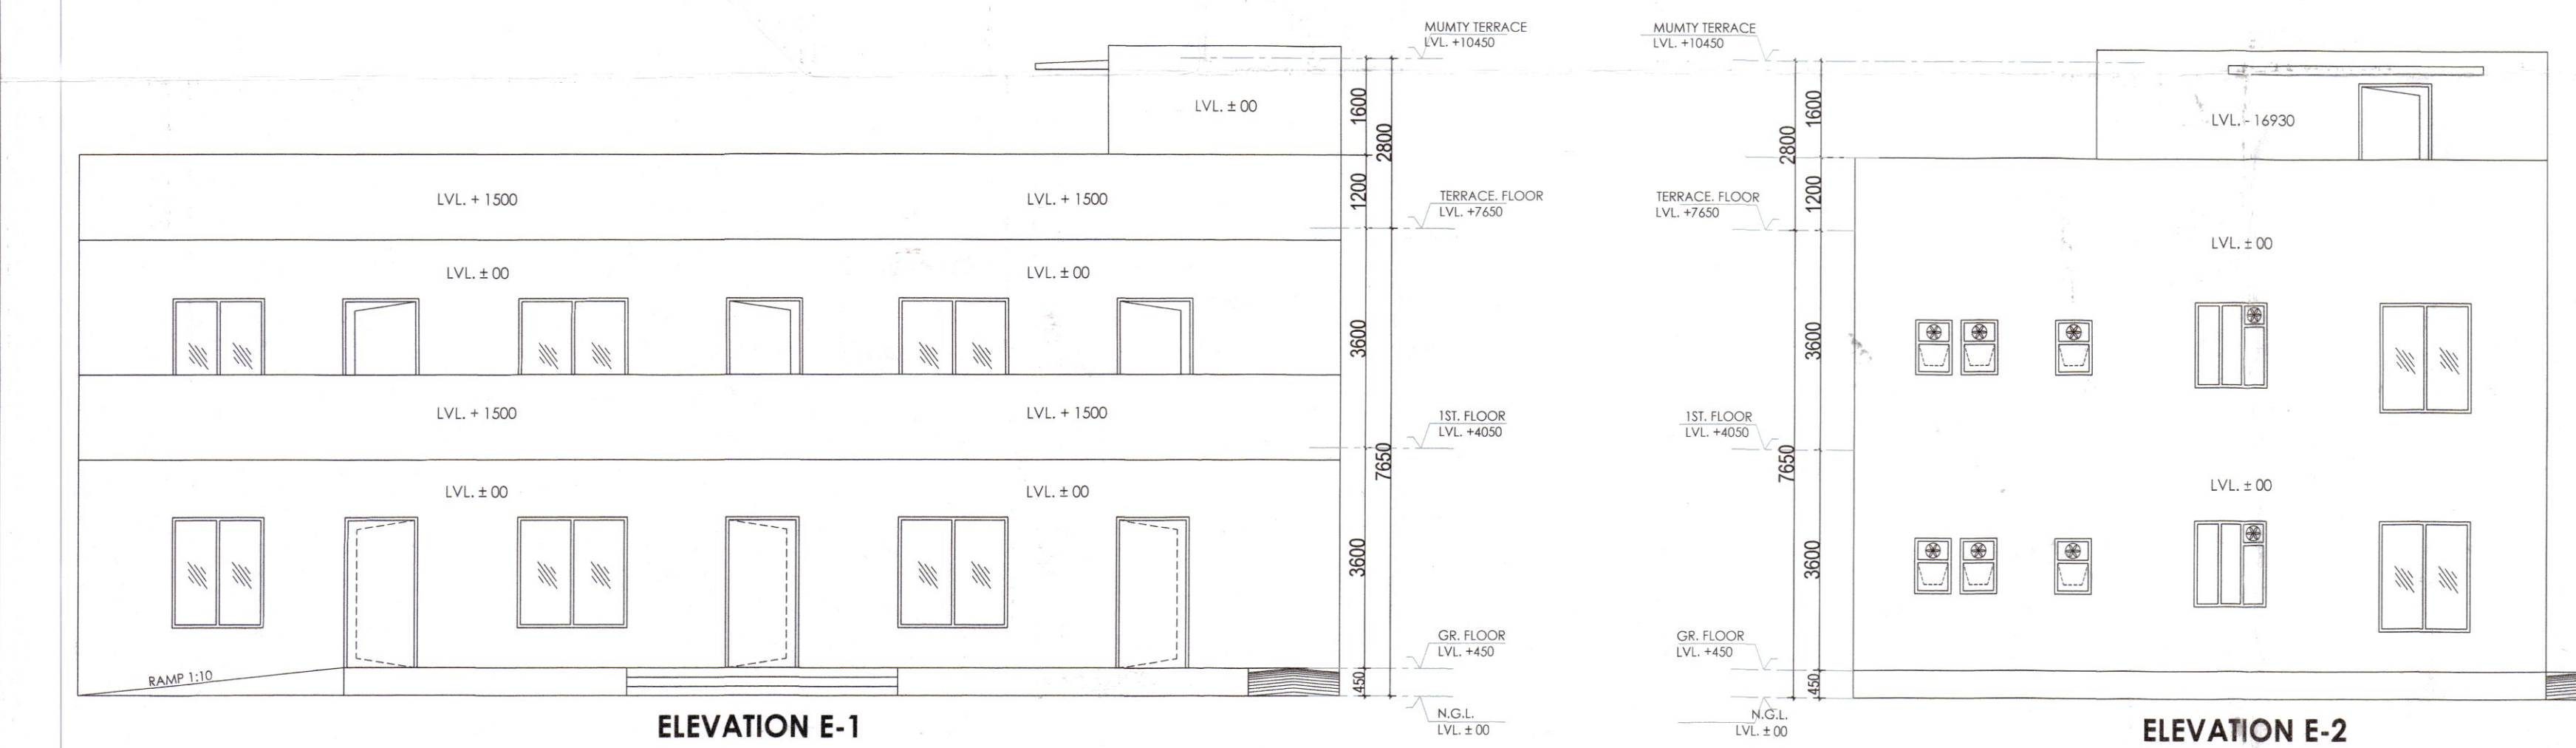

ELEVATION E-1

ELEVATION E-2

PLUMBING LEGEND	
1	1000 SOL. PIPE
2	1000 WASTE PIPE
3	1000 RAIN WATER PIPE
4	1000 SOL. PIPE
5	1000 WASTE PIPE
6	1000 RAIN WATER PIPE
7	1000 SOL. PIPE
8	1000 WASTE PIPE
9	1000 RAIN WATER PIPE
10	1000 SOL. PIPE
11	1000 WASTE PIPE
12	1000 RAIN WATER PIPE
13	1000 SOL. PIPE
14	1000 WASTE PIPE
15	1000 RAIN WATER PIPE
16	1000 SOL. PIPE
17	1000 WASTE PIPE
18	1000 RAIN WATER PIPE
19	1000 SOL. PIPE
20	1000 WASTE PIPE
21	1000 RAIN WATER PIPE
22	1000 SOL. PIPE
23	1000 WASTE PIPE
24	1000 RAIN WATER PIPE
25	1000 SOL. PIPE
26	1000 WASTE PIPE
27	1000 RAIN WATER PIPE
28	1000 SOL. PIPE
29	1000 WASTE PIPE
30	1000 RAIN WATER PIPE
31	1000 SOL. PIPE
32	1000 WASTE PIPE
33	1000 RAIN WATER PIPE
34	1000 SOL. PIPE
35	1000 WASTE PIPE
36	1000 RAIN WATER PIPE
37	1000 SOL. PIPE
38	1000 WASTE PIPE
39	1000 RAIN WATER PIPE
40	1000 SOL. PIPE
41	1000 WASTE PIPE
42	1000 RAIN WATER PIPE
43	1000 SOL. PIPE
44	1000 WASTE PIPE
45	1000 RAIN WATER PIPE
46	1000 SOL. PIPE
47	1000 WASTE PIPE
48	1000 RAIN WATER PIPE
49	1000 SOL. PIPE
50	1000 WASTE PIPE
51	1000 RAIN WATER PIPE
52	1000 SOL. PIPE
53	1000 WASTE PIPE
54	1000 RAIN WATER PIPE
55	1000 SOL. PIPE
56	1000 WASTE PIPE
57	1000 RAIN WATER PIPE
58	1000 SOL. PIPE
59	1000 WASTE PIPE
60	1000 RAIN WATER PIPE
61	1000 SOL. PIPE
62	1000 WASTE PIPE
63	1000 RAIN WATER PIPE
64	1000 SOL. PIPE
65	1000 WASTE PIPE
66	1000 RAIN WATER PIPE
67	1000 SOL. PIPE
68	1000 WASTE PIPE
69	1000 RAIN WATER PIPE
70	1000 SOL. PIPE
71	1000 WASTE PIPE
72	1000 RAIN WATER PIPE
73	1000 SOL. PIPE
74	1000 WASTE PIPE
75	1000 RAIN WATER PIPE
76	1000 SOL. PIPE
77	1000 WASTE PIPE
78	1000 RAIN WATER PIPE
79	1000 SOL. PIPE
80	1000 WASTE PIPE
81	1000 RAIN WATER PIPE
82	1000 SOL. PIPE
83	1000 WASTE PIPE
84	1000 RAIN WATER PIPE
85	1000 SOL. PIPE
86	1000 WASTE PIPE
87	1000 RAIN WATER PIPE
88	1000 SOL. PIPE
89	1000 WASTE PIPE
90	1000 RAIN WATER PIPE
91	1000 SOL. PIPE
92	1000 WASTE PIPE
93	1000 RAIN WATER PIPE
94	1000 SOL. PIPE
95	1000 WASTE PIPE
96	1000 RAIN WATER PIPE
97	1000 SOL. PIPE
98	1000 WASTE PIPE
99	1000 RAIN WATER PIPE
100	1000 SOL. PIPE

DOOR WINDOW SCHEDULE						
Sr. No.	TYPE	WIDTH	HEIGHT	SIZE	CILL	LINTEL
1	D	1250	2450	1250X2450		2450
2	D1	1200	2150	1200X2150		2150
3	D2	750	2150	750X2150		2150
4	W	1800	1800	1800X1800	650	2450
5	W1	1500	1800	1500X1800	650	2450
6	W2	1200	1400	1200X1400	1050	2450
7	V1	600	900	600 X 900	1250	2150

CLIENT:-
SMT.AKSHY NATH W/O JITENDRA NATH & OTHERS IN COLLABORATION PEGASUS LAND AND HOUSING PVT. LTD.

PROJECT :-
PROPOSED BUILDING PLAN OF AFFORDABLE GROUP HOUSING COLONY FOR AN AREA MEASURING 5.375 ACRE(LICENCE NO.58 DATED.13/05/2022.) IN SECTOR-78 GURUGRAM MANESAR URBAN COMPLEX BEING DEVELOPED BY SMT.AKSHY NATH W/O JITENDRA NATH & OTHERS IN COLLABORATION PEGASUS LAND AND HOUSING PVT. LTD.

ARCHITECTS
Pinnacle Architects Pvt.Ltd.
938, SECTOR-14, GURGAON
HARYANA

SCALE : 1:90

DRAWING NAME
AANGANWADI AND
COMMUNITY HALL

DRAWING NO.20

APPLICANT'S SIGN.
VIMAL BAJAJ
Architect CA/96/19791
938, Sector-14, Gurgaon

ARCHITECT'S SIGN